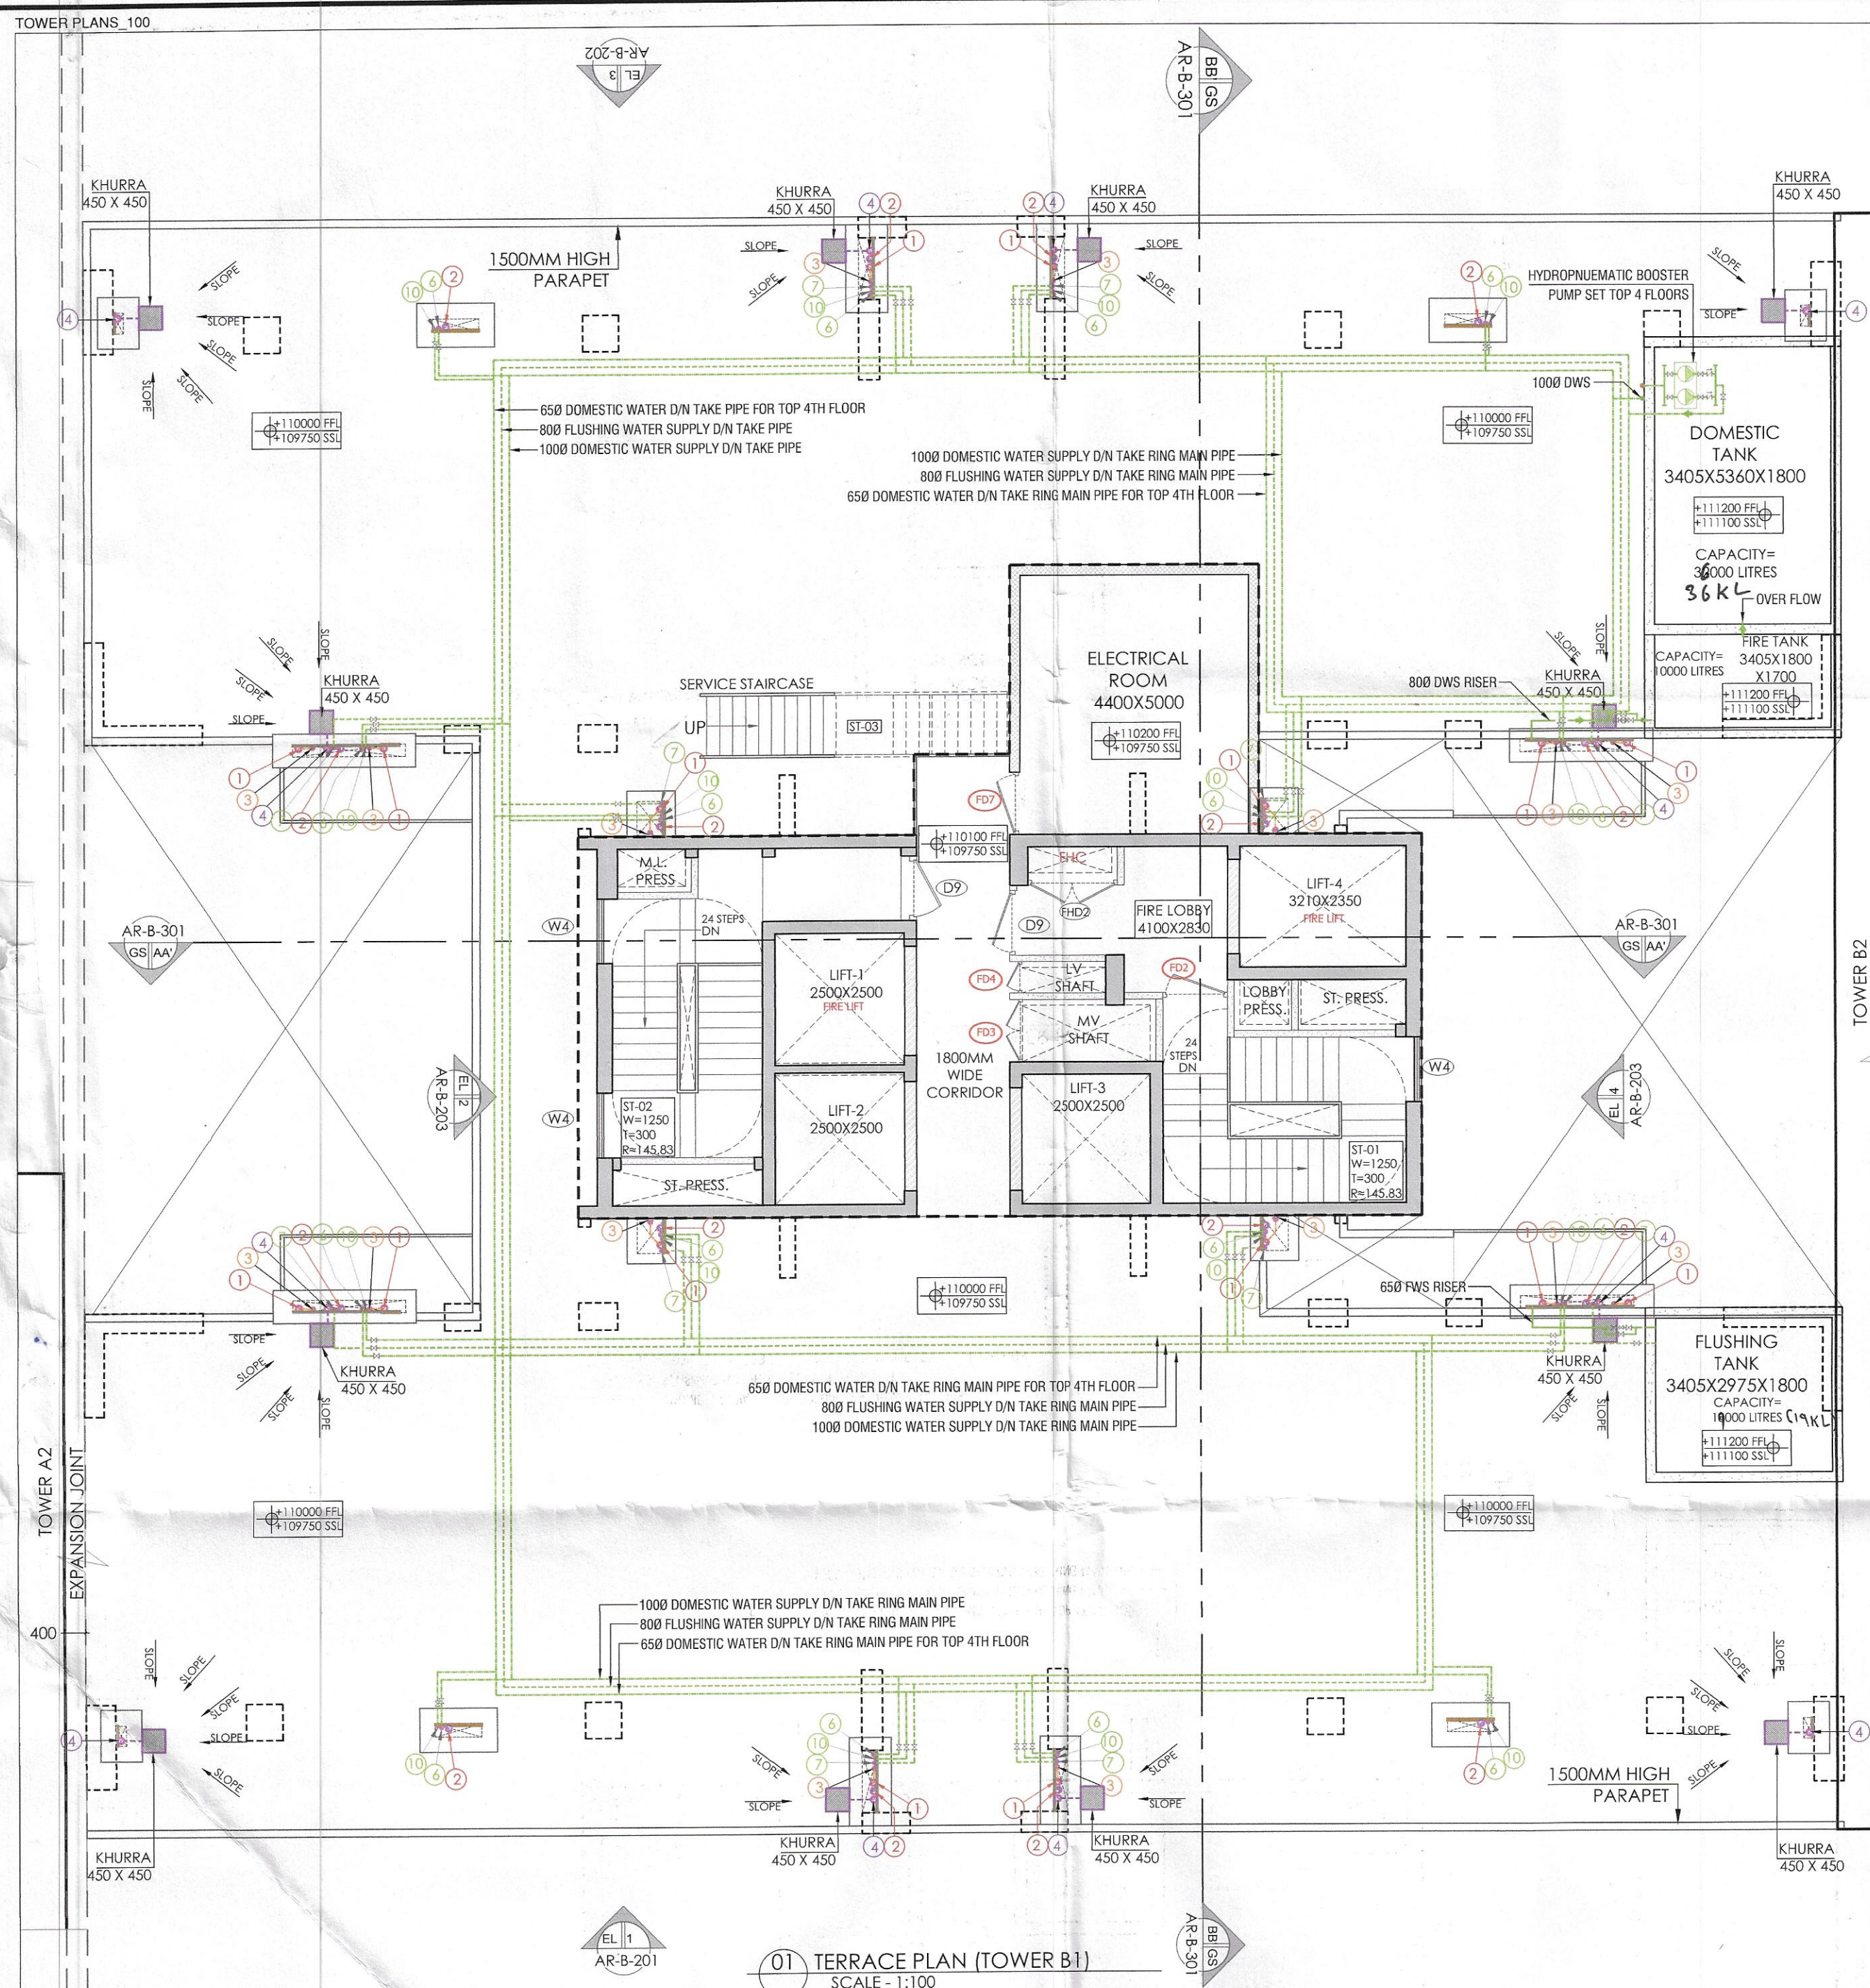
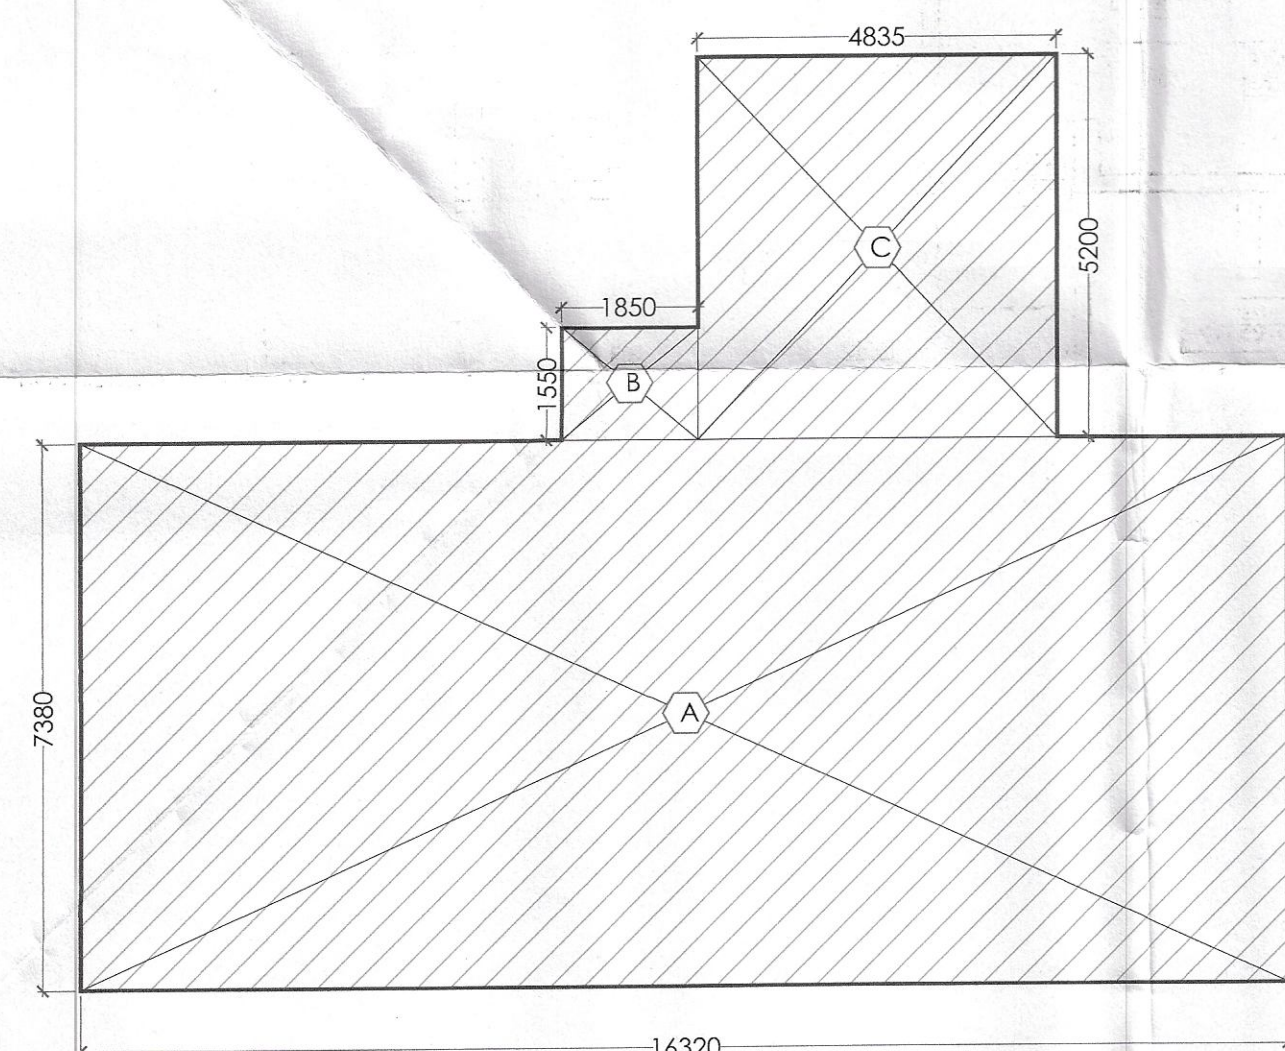
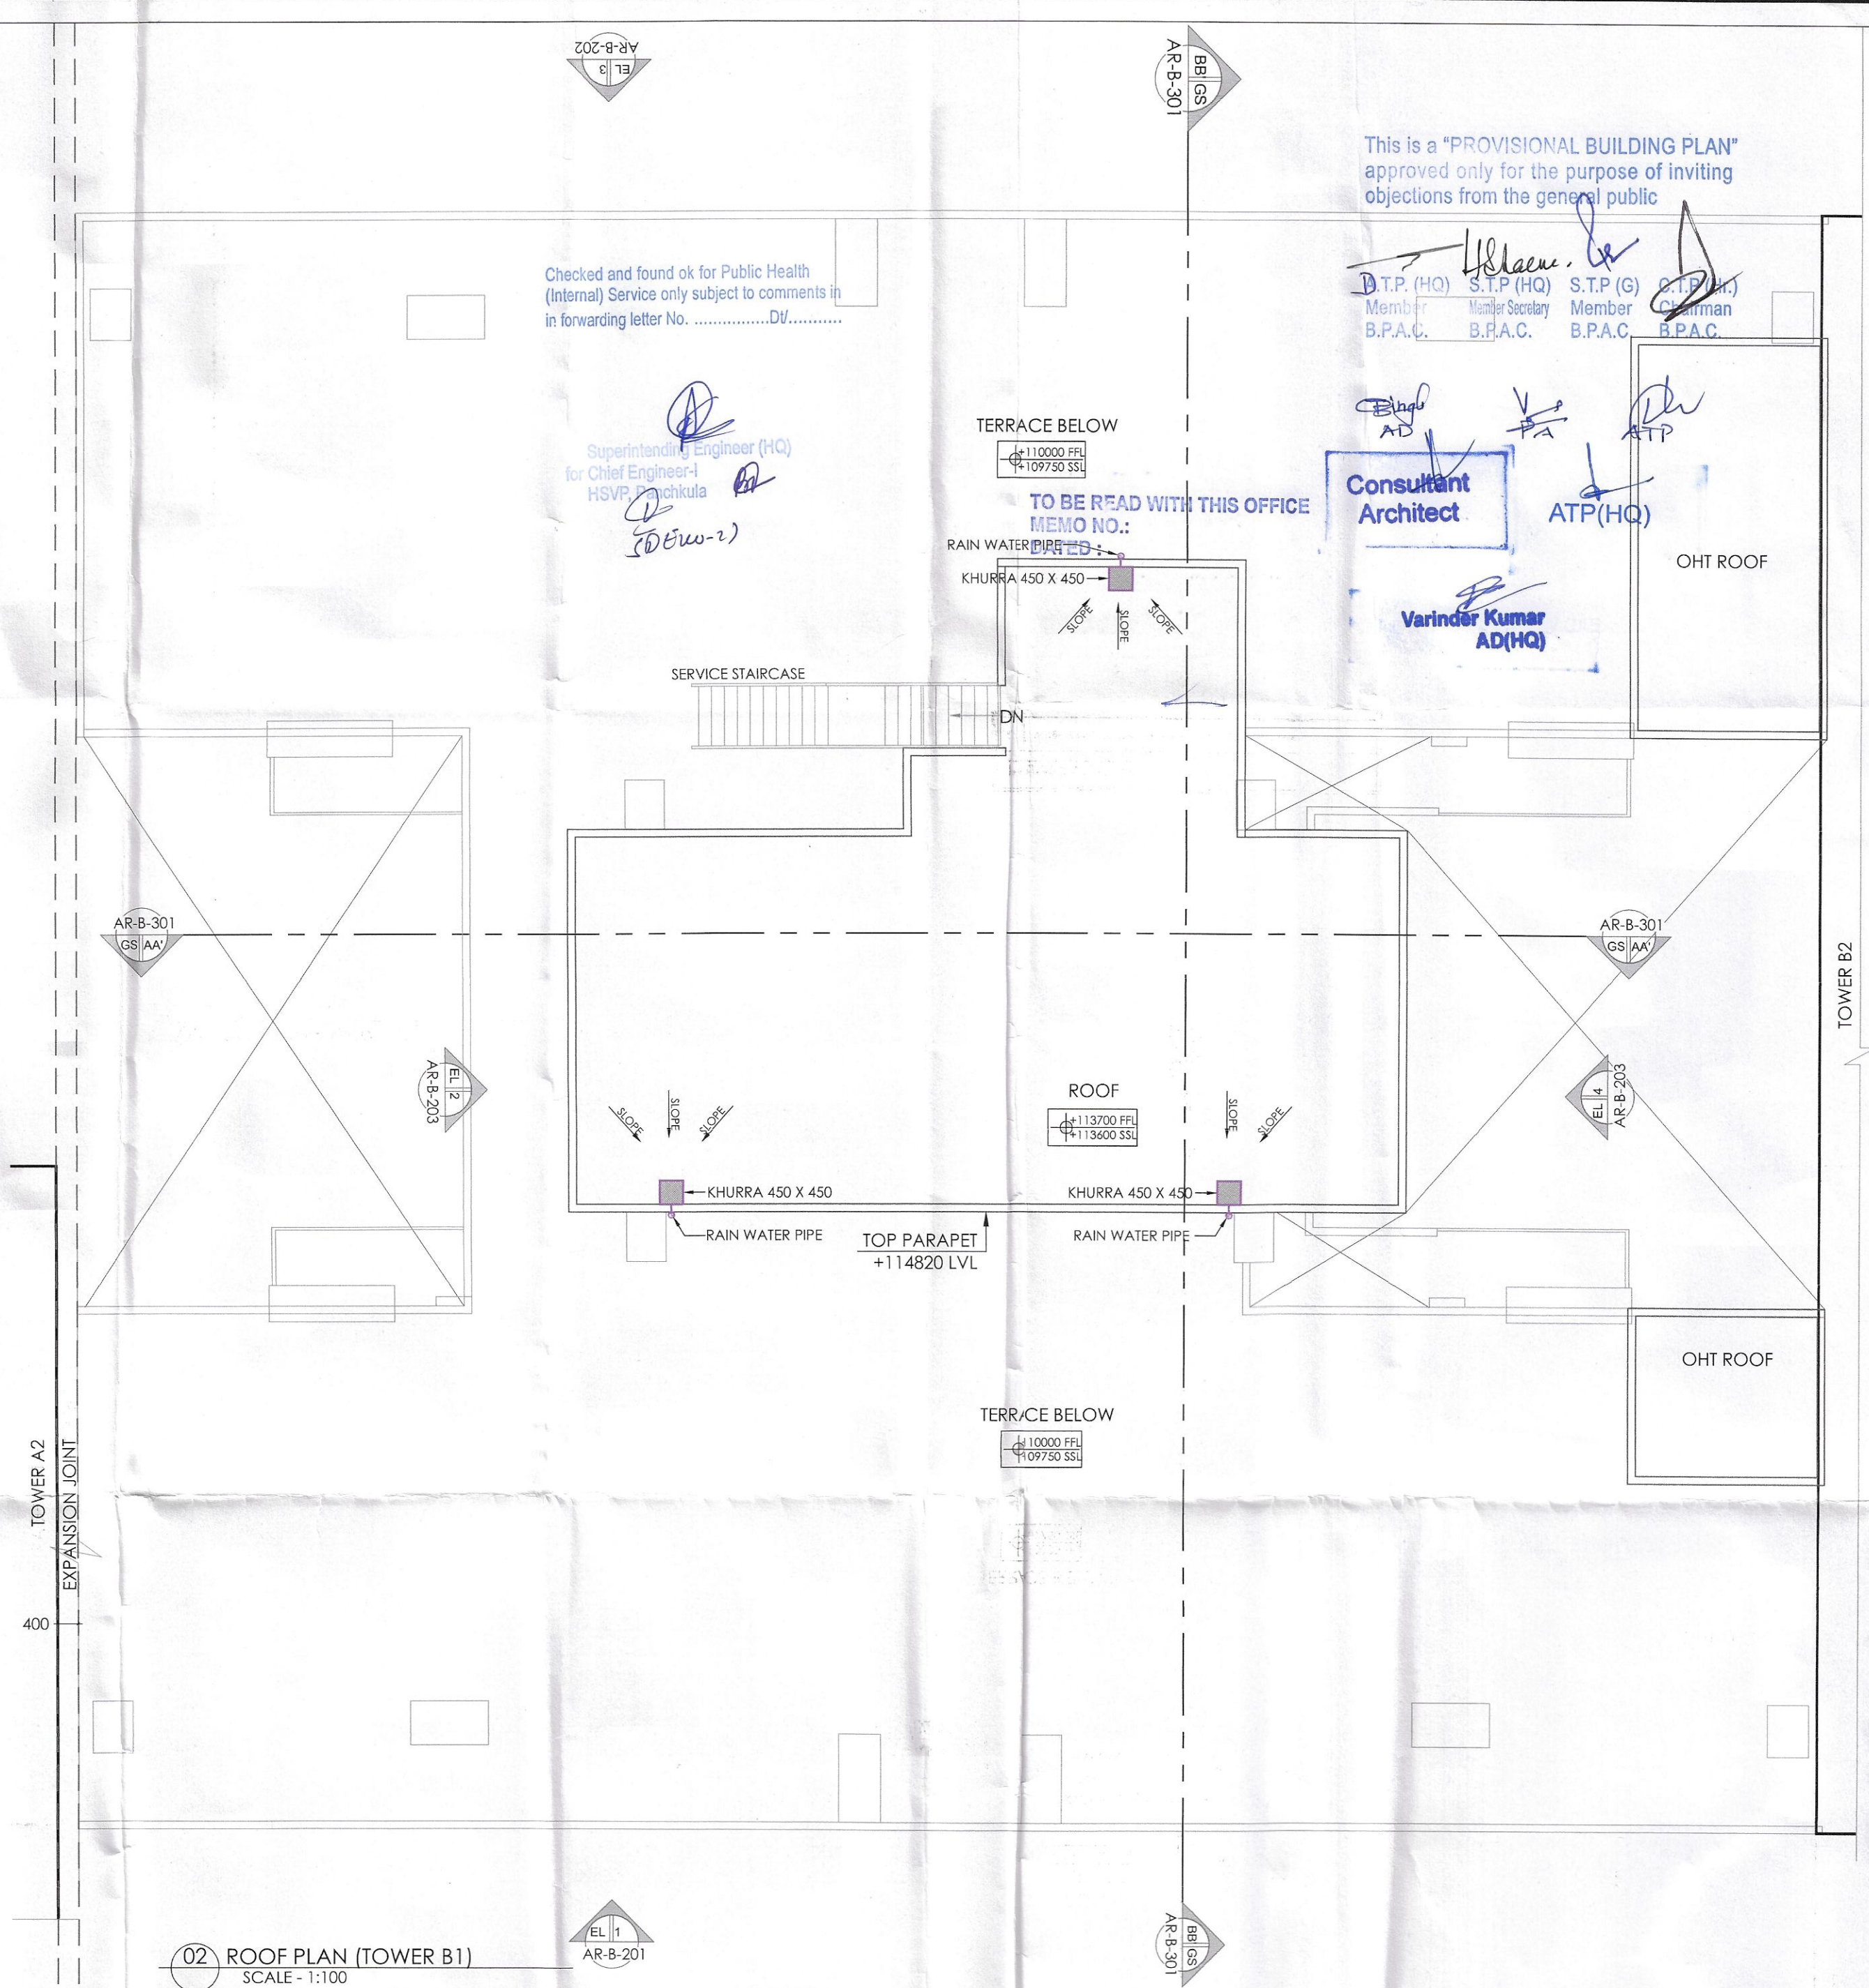



TERRACE PLAN (TOWER B1)
SCALE - 1:100MUMTY (NON-FAR) DIAGRAM
SCALE - 1:100ROOF PLAN (TOWER B1)
SCALE - 1:100

PUMPING NOTES:-

1. WASH BASIN TO FLOOR TRAP (FT) 40 OD UPVC PIPE.
2. KITCHEN SINK TO FLOOR DRAIN (FD) 63 OD UPVC WASTE PIPE.
3. FLOOR DRAIN (FD) TO FLOOR TRAP (FT) 63 OD UPVC WASTE PIPE.
4. 110 OD UPVC PIPE USED FOR SOIL & WASTE.
5. 110 OD UPVC PIPE USED FOR TERRACE RAIN WATER.
6. 110 OD UPVC PIPE USED FOR BALCONY.

SCHEDULE OF PIPES :-

USING	DESCRIPTION
①	110 OD UPVC SOIL PIPE & VENT PIPE
②	110 OD UPVC WASTE PIPE & VENT PIPE
③	110 OD UPVC WASTE PIPE FOR KITCHEN & UTILITY BALCONY
④	75 OD UPVC ANTI-SIPHONAGE PIPE
⑤	110 OD UPVC TERRACE RAIN WATER PIPE
⑥	110 OD UPVC BALCONY RAIN WATER PIPE
⑦	DOMESTIC WATER SUPPLY D/N TAKE PIPE *
⑧	FLUSHING WATER SUPPLY D/N TAKE PIPE *
⑨	DOMESTIC WATER SUPPLY RISER *
⑩	FLUSHING WATER SUPPLY RISER *
⑪	DOMESTIC WATER SUPPLY D/N TAKE PIPE FOR TOP 4TH FLOOR
⑫	CUTOUT IN SLAB +150 x 150 MM FOR WC
⑬	FLOOR TRAP (110 x 110 MM) CUTOUT IN SLAB +150 x 150 MM
⑭	FLOOR DRAIN (110 x 63) MM
⑮	BALCONY DRAIN (110 x 63) MM

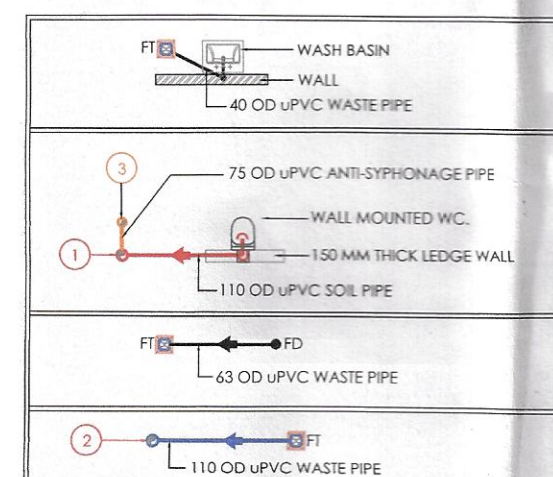

NOTES:
REFER DRAWING NO. AR-B-201.202 & 203 FOR ELEVATIONS
REFER DRAWING NO. AR-B-301 FOR SECTIONS
ALL TOILETS TO BE MECHANICALLY VENTILATED


S.NO.	WIDTH (M)	LENGTH (M)	NOS.	AREA (SqM)
A	16.320	7.380	1	120.442
B	1.850	1.550	1	2.868
C	4.835	5.200	1	25.142
TOTAL AREA				148.451

This is a "PROVISIONAL BUILDING PLAN"
approved only for the purpose of inviting
objections from the general public

B.T.P. (H.O.) S.T.P. (H.O.) S.T.P. (G) S.T.P. (M)
Member Secretary Member Chairman
B.P.A.C. B.P.A.C. B.P.A.C. B.P.A.C.

Consultant Architect
Varinder Kumar AD(HQ)

KEY PLAN

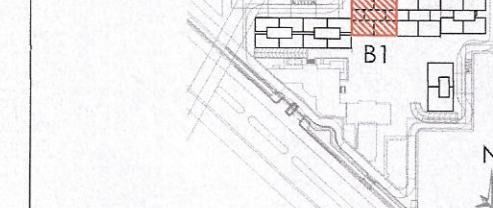

NOTES

DOOR NO.	DOOR TAGS	WIDTH	UNTEL	CILL	LOCATION	FIRE RATINGS
1	D2	1050	2400	0	Bedroom	
2	D3	900	2400	0	Kitchen/Study	
3	D4	800	2400	0	Toilet	
4	D4	1200	2400	0	GF - Toilet	
5	D8	750	2400	0	S. Toilet	
6	D9	1250	2400	0	GF & Terrace	
7	GD1	1800	2400	0	GF Lobby entry from lift	
8	SD1	2250	2400	0	M. Bedroom	
9	SD2	2150	2400	0	Bedroom 2	
10	SD3	1450	2400	0	Bedroom 1	
11	SD4	1500	2400	0	Bedroom 1	
12	SD4	2750	2400	0	Living/Dining	
13	SD5	2250	2400	0	Living/Dining	
14	SD6	1900	2400	0	Study	
15	SD7	4740	2400	0	Living/Dining	
16	D5	750	2400	0	Servant's Room	
17	D7	900	2400	0	Kitchen's Room	
18	DW1	900/50	2400	Q/1200	S. Room/Study	
19	DW2	900/510	2400	Q/1200	S. Room/Study	
20	DW3	1200/1390	2400	Q/1200	Machine Room	
21	V1	700	2400	1200	Toilet	
22	V2	600	2400	1200	Toilet	
23	W4	1250	2400	1200	Staircase	
24	W5	600	2200	1200	Staircase	
25	W6	900	2400	1200	M. Bedroom	
26	GL1	2140/1635	2400	0	Study	
27	GL2	1190/1740/1190	2400	0	GF Lobby	
28	GL3	6215	2400	0	GF Lobby	
29	GL4	6215	2400	0	GF Lobby	
30	GL5	1090/1156/2565	2100	0	Podium Lobby	
31	GL6	4680/2000/2000	2400	0	GF Lobby	
32	GL7	7210	2400	0	GF Lobby	
33	GL8	7210	2400	0	GF Lobby	
34	GL9	1050/1210	2400	0	GF Lobby	
35	GL10	1000/710/410	2400	0	Podium Lobby	
36	GL11	2375/1100/1155	2400	0	Podium Lobby	
37	GL12	5275	2400	0	GF Lobby	
38	GL13	1450/1850/3840	2400	0	GF Lobby	
39	GL14	1440	2400	0	GF Lobby	
40	GL15	2500	2400	0	GF Lobby	
41	GL16	1500	2400	0	Podium Lobby	
42	GL17	2400	2400	0	Podium Lobby	
43	GL18	6190	2400	0	Podium Lobby	
44	GL19	5345	2400	0	GF Lobby	
45	GL20	1590	2400	0	GF Lobby	
46	GL21	3440/1450	2400	0	Study's Room	
47	GL22	3850/1910	2400	0	Study's Room	
48	GL23	1090/1156/2565	2400	0	GF Lobby	
49	GL24	3240	2400	0	GF Lobby	
50	GL25	1755/2670/1755	2400	0	Podium Lobby	
51	GL26	1755/2670	2400	0	GF Lobby	
52	GL27	900	2400	0	GF Lobby	
53	GL28	1800	2400	0	GF Lobby	
54	FD1	1250	2400	0	Entrance Door	1hr
55	FD2	1250	2400	0	Staircase/Fire Lobby	2hrs
56	FD3	1200	2400	100	MV Shaft	2hrs
57	FD4	600	2400	100	UV Shaft	2hrs
58	FD5	900	2400	0	Utility	1hr
59	FD6	900	2400	100	MV Shaft	2hrs
60	FD7	1250	2400	0	Terrace-Electrical room	2hrs
61	FD8	1250	2300	0	Staircase/Fire Lobby	2hrs
62	FD9	1200	2400	0	Fire Control Room	2hrs
63	FV1	700	2400	1200	Toilet	2hrs
64	PHD1	900	2400	100	PHC Shaft	2hrs
65	PHD2	1750	2400	100	PHC Shaft	2hrs

CLIENTS

PURI CONSTRUCTION PVT. LTD.
4-7B, GROUND FLOOR,
TOLSTOY HOUSE
TOLSTOY MARG,
NEW DELHI-110001

STRUCTURES

TPC

Technical Projects Consultants Pvt. Ltd.
B-74 | Sector 57 | Noida 201301 | Uttar Pradesh | India
T: +91-120-4306800 | D: +91-120-4306806 |
M: +91-9910285917
www.tpcconsultants.co.in

ARCHITECTS

Arcop Associates Pvt. Ltd.
Plot-36B, Sec-32, Gurgaon-122001
Ph: 26242050, 26242169
Montreal, Toronto, New-Delhi, Boston

PROJECT

Building plan of Phase-B, Under (TOD and TDR) policy area measuring 5.56175 Acres License no 87 of 2012 dated 29-08-2012 (4.268 Acres) & License no 33 of 2013 dated 25-05-2013 (1.29375 Acres) part of 21.01875 Acres License No. 55 of 2010 dated 25-07-2010 (15.457 Acres), License no 87 of 2012 dated 29-08-2012 (4.268 Acres) & License no 33 of 2013 dated 25-05-2013 (1.29375 Acres) in Sector-110A & 111, Gurugram being developed by M/s Puri Construction Pvt. Ltd.

ARCHITECT

OWNER'S SIGNATURE
For PURI CONSTRUCTION PVT. LTD.

DRAWING TITLE
GROUP HOUSING COLONY
[TOWER-B1]

TERRACE & ROOF PLAN
AR-B1-106