



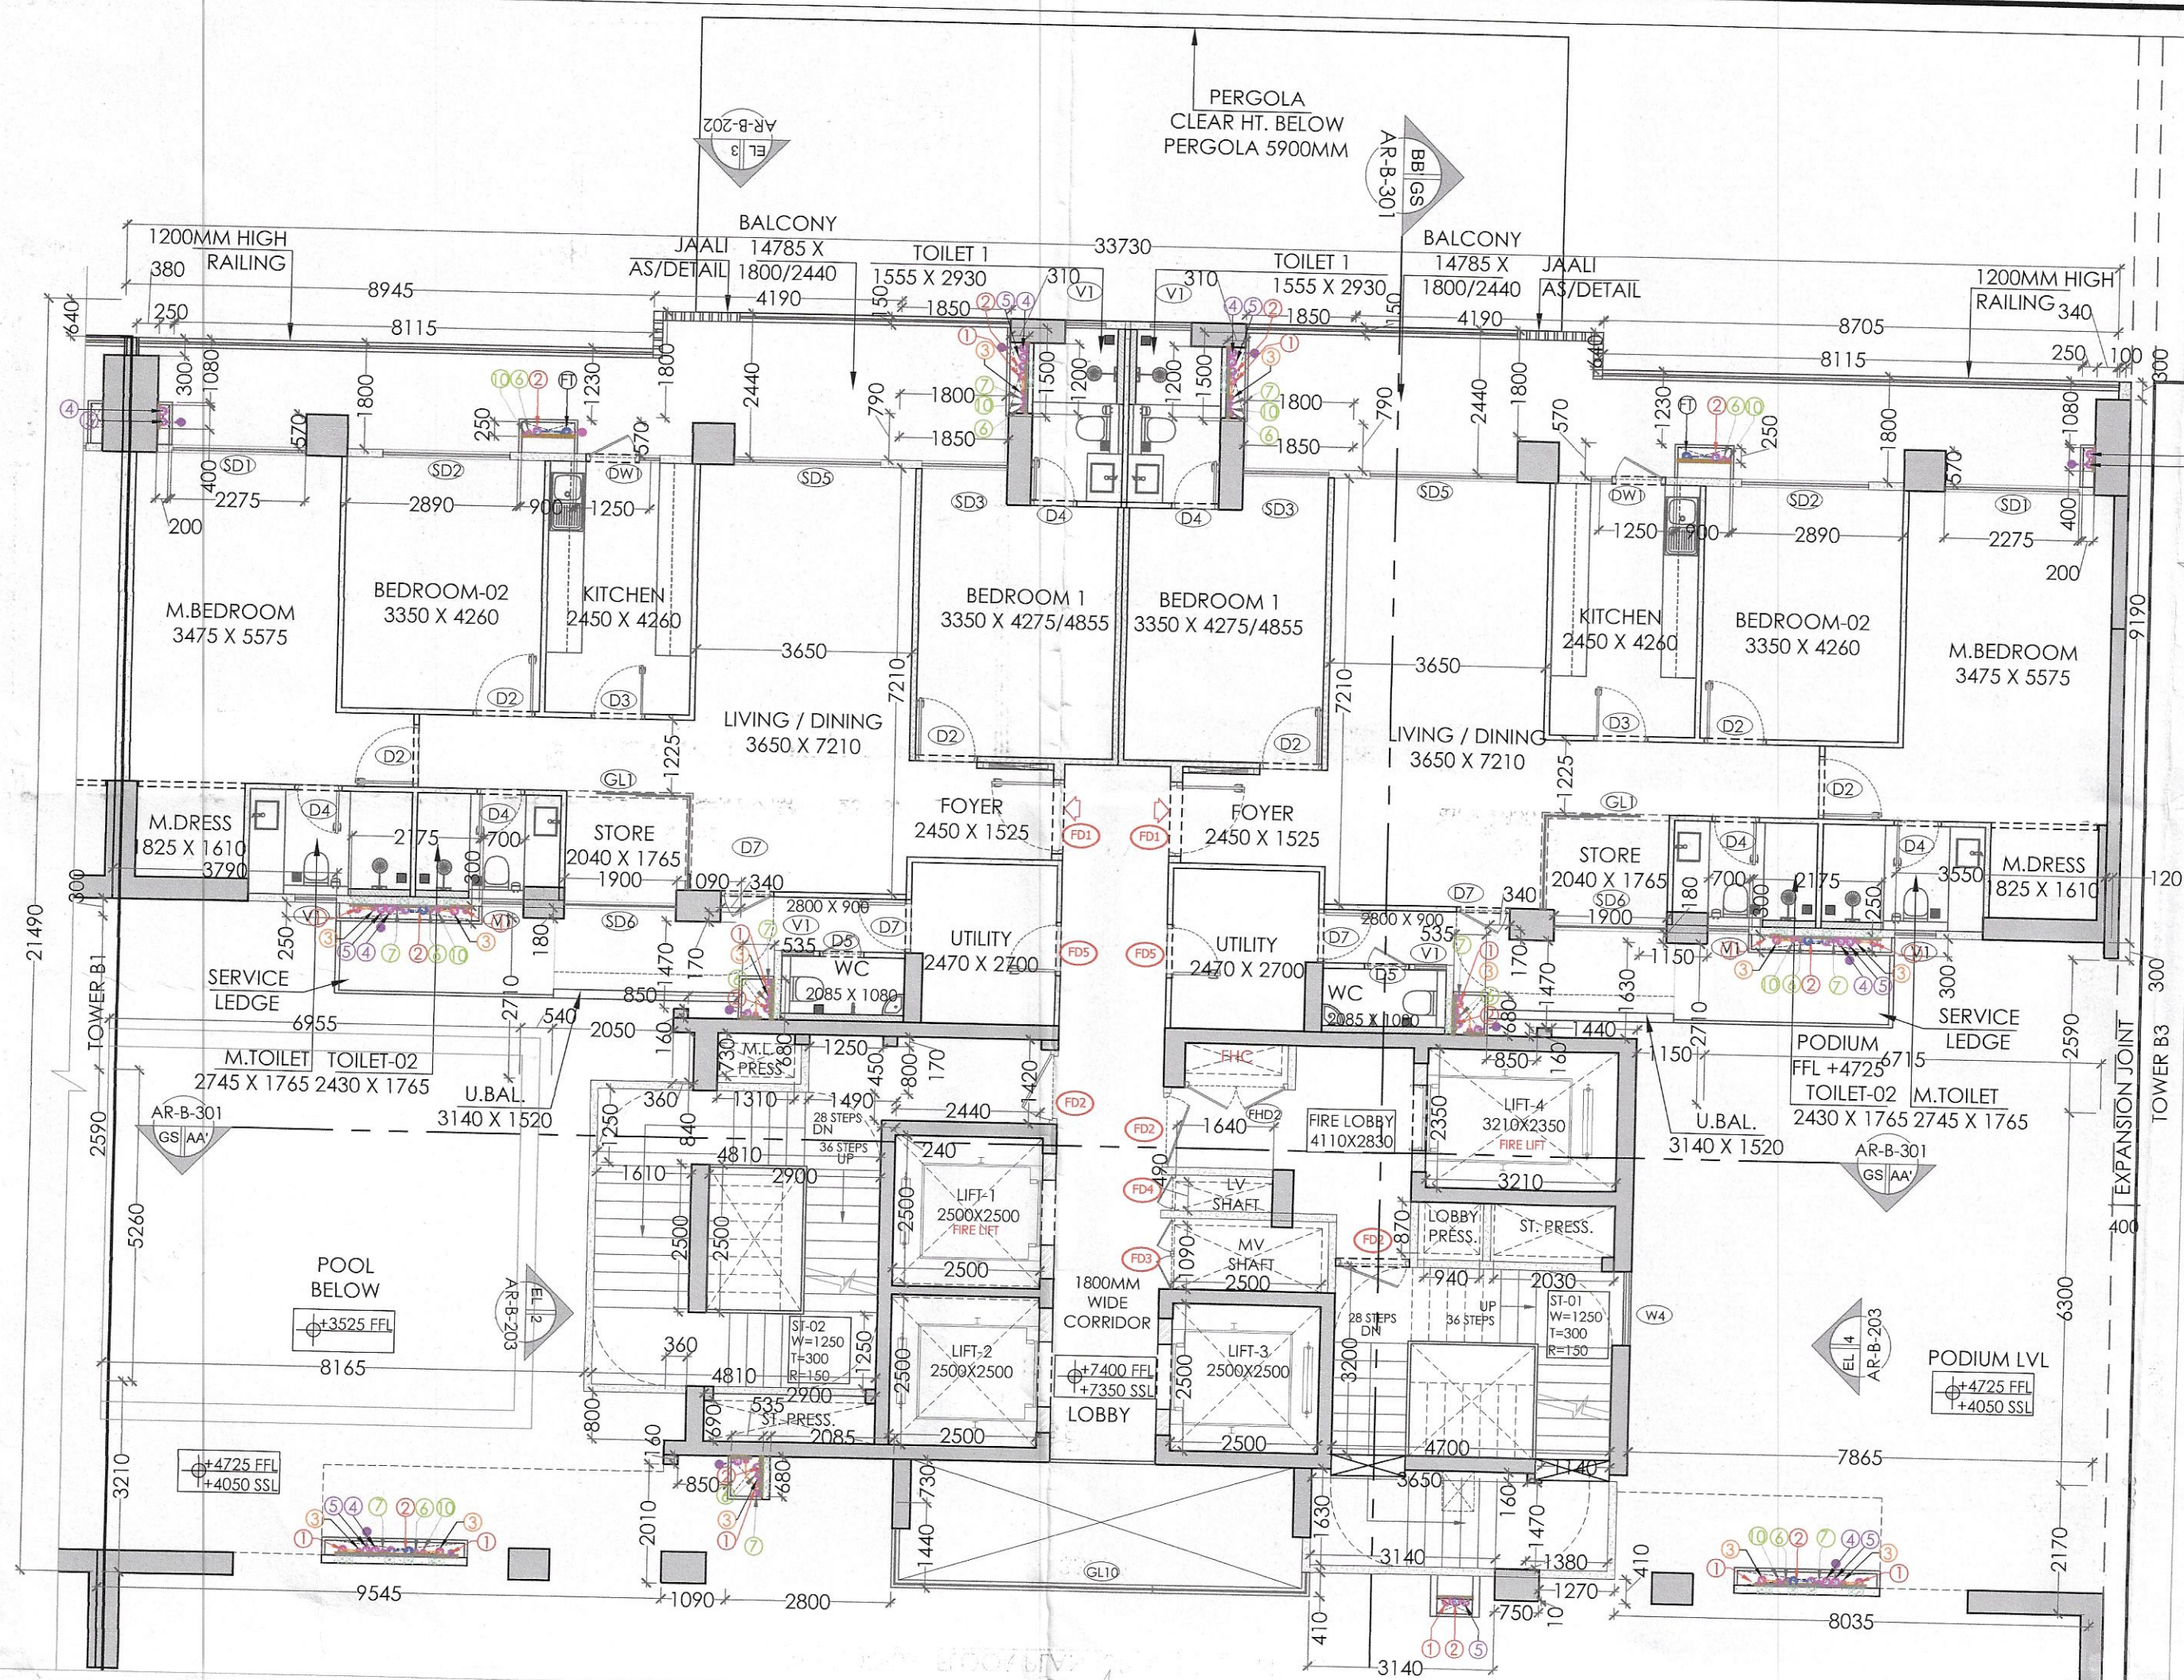

01) PODIUM FLOOR PLAN (UPPER) (TOWER B2)

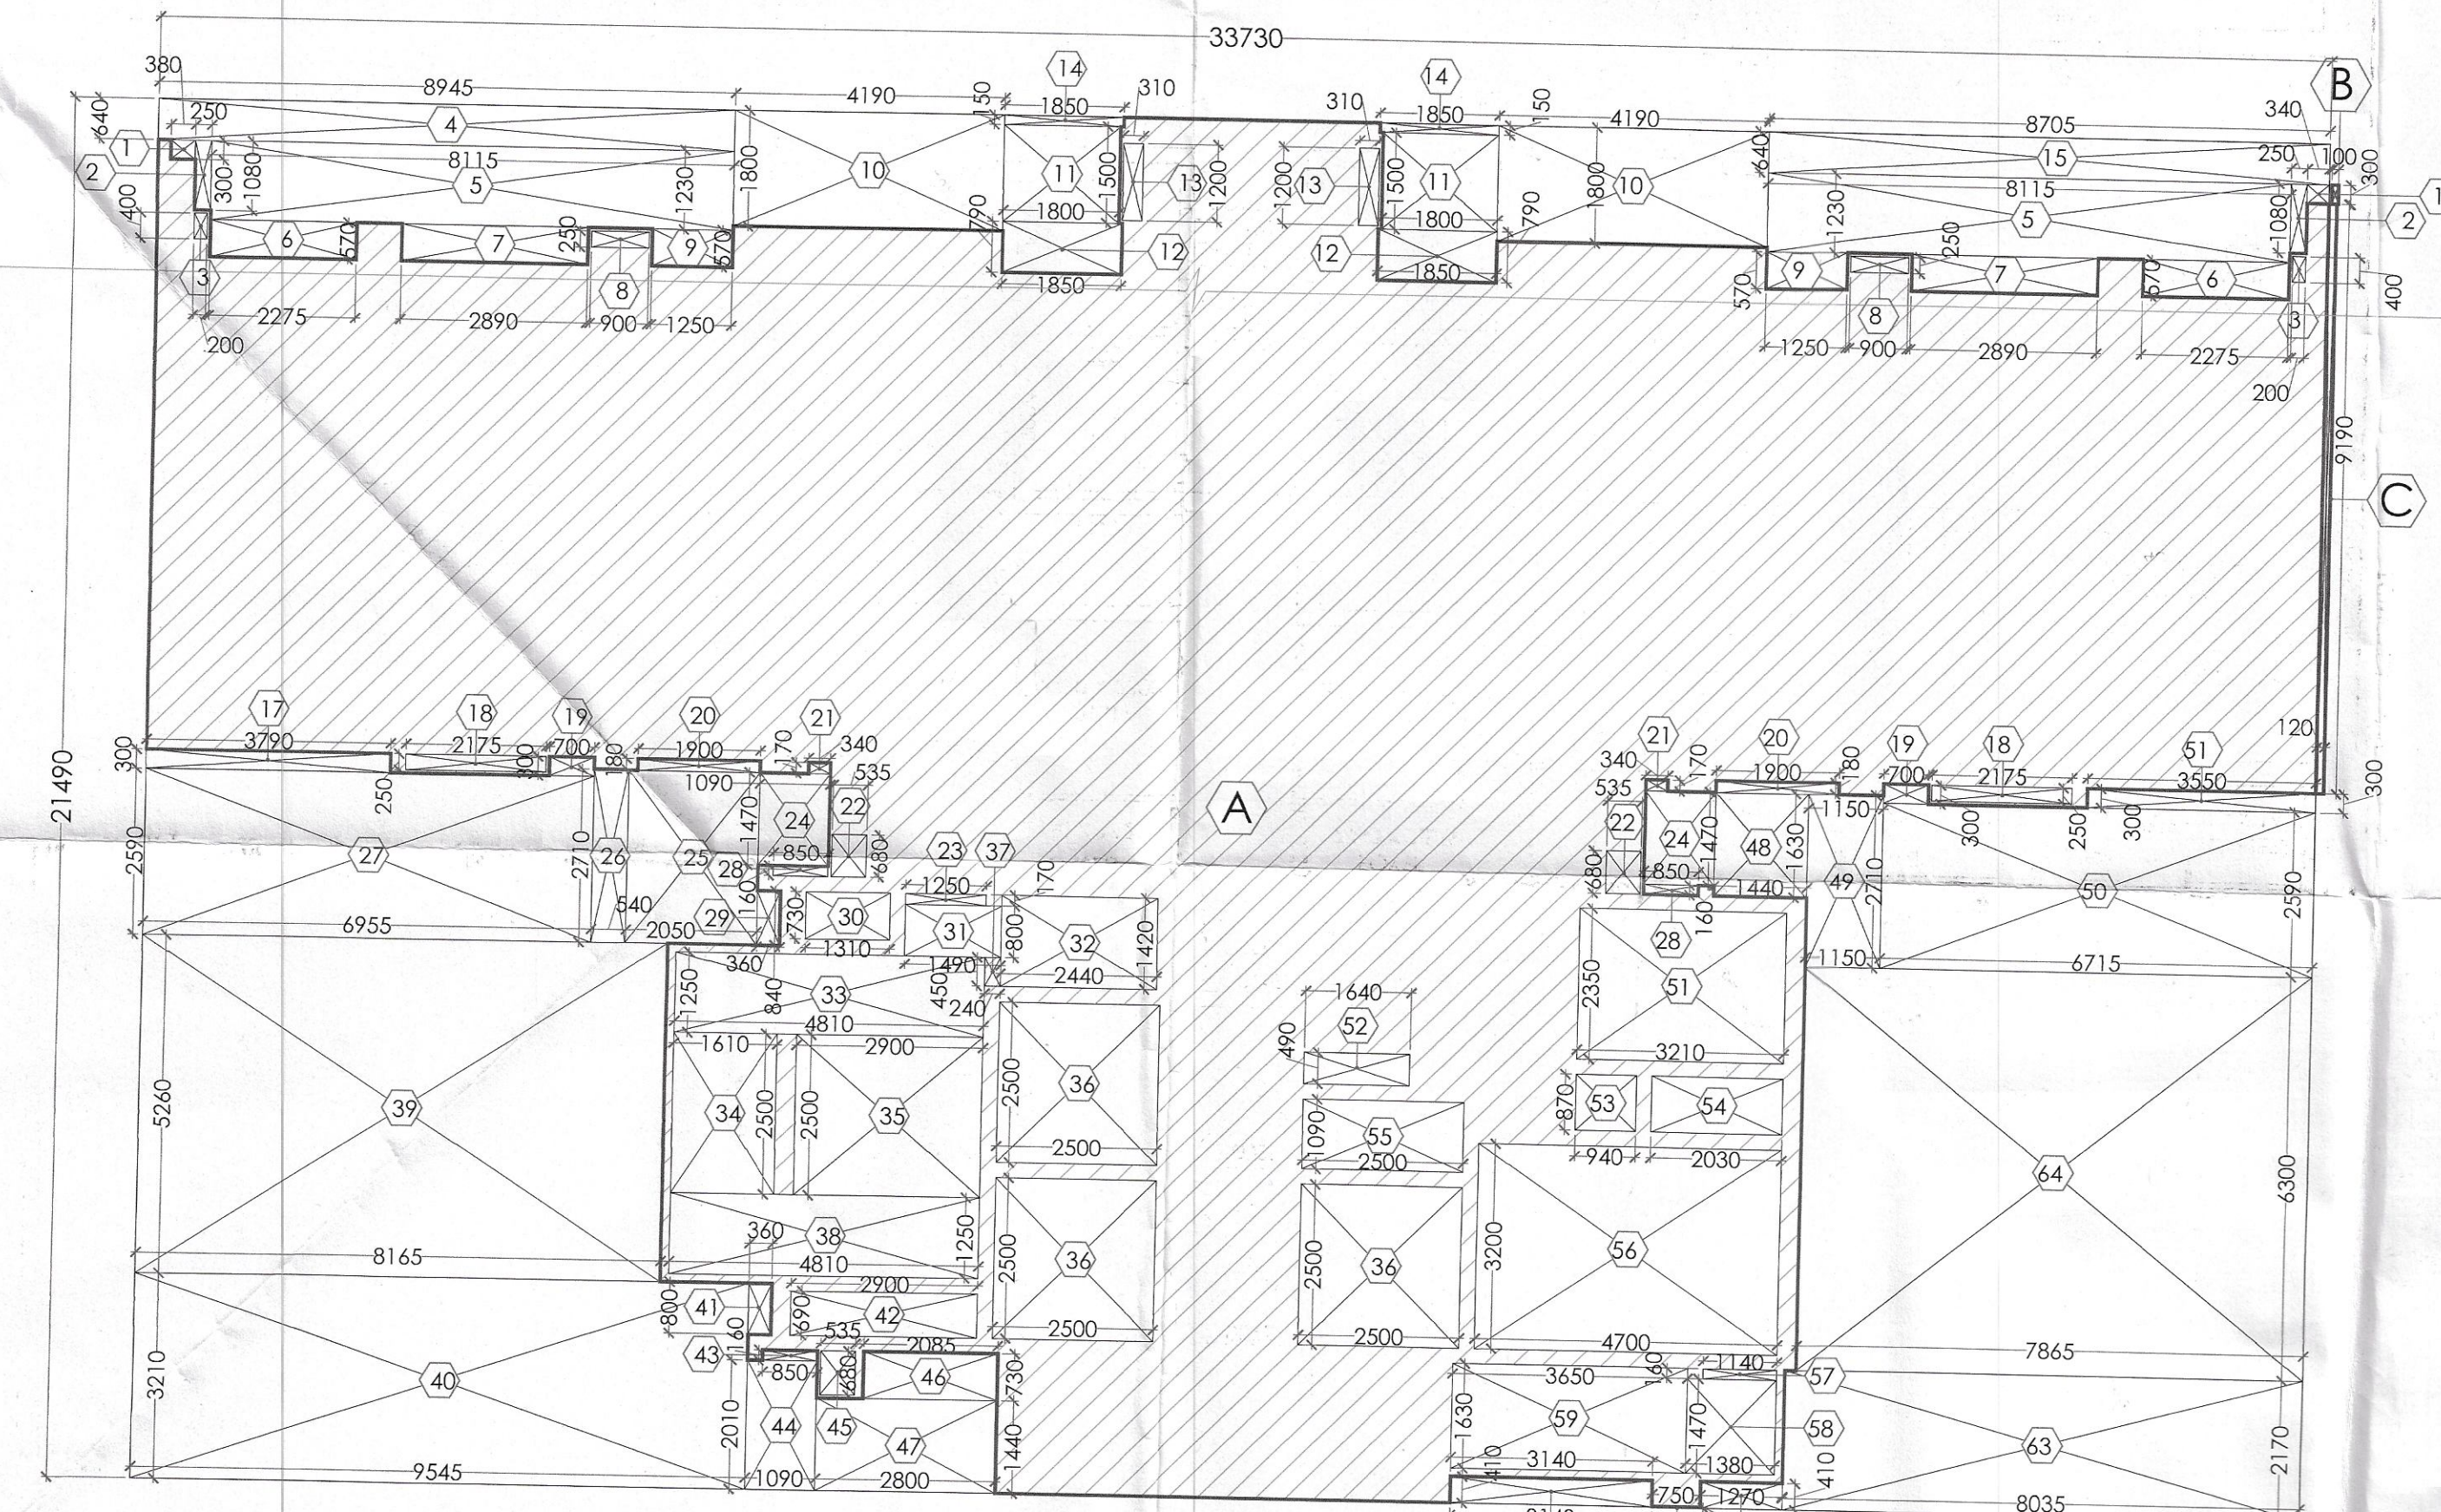

02) PODIUM FLOOR (UPPER) F.A.R. AREA DIAGRAM (TOWER B2)

Checked and found ok for Public Health
(Internal) Service only subject to comments in
in forwarding letter No.

Superintending Engineer (H.Q.)
for Chief Engineer-1
HSVP, Bhopal
10/05/2021

DD (H.Q.)
Member
BPAC

This is a "PROVISIONAL BUILDING PLAN"
approved only for the purpose of inviting
objections from the general public


D.T.P. (H.Q.) S.T.P. (H.Q.) S.T.P. (H.Q.)
Member Secretary Member Secretary
B.P.A.C. B.P.A.C. B.P.A.C. B.P.A.C.

Consultant
Architect

ATP(HQ)

Varinder Kumar
AD(HQ)

TO BE READ WITH THIS OFFICE
MEMO NO.:
DATED :

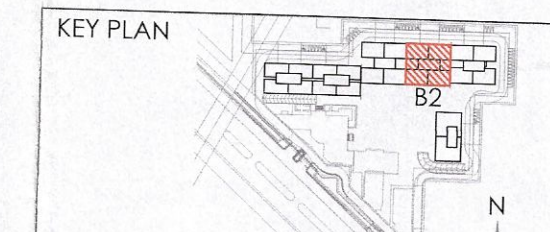

NOTES

DOOR/WINDOW SCHEDULE (TOWERS)					
S. NO.	DOOR TAGS	WIDTH	LINTEL	CILL	LOCATION
1	D2	1050			Bedroom
2	D3	900			Kitchen/Study
3	D4	800			Room
4	D4	1200			GF. H. Toilet
5	D8	750			St. Toilet
6	D9	1250			GF & Terrace
7	GD1	1800			GF Lobby

EXTERNAL DOORS

8	S01	2250			M. Bedroom
9	S02	2150			Bedroom-2
10	S03	1450			Bedroom-1
11	S04	1500			Bedroom-1
12	S04	2750			Living/Dining
13	S05	2500			Living/Dining
14	S06	1900			Study
15	S07	4740			Living/Dining
16	D5	750			Servant's Room
17	D7	900			Kitchen/Room
18	DW1	900/350			Q/1200 Kitchen
19	DW2	900/310			Q/1200's Room/Study
20	DW3	1200/1300			Machine Room

WINDOWS

21	V1	700			Toilet
22	V2	600			Toilet
23	W4	1200			Staircase
24	W5	600			Staircase
25	W6	900			2000 M. Bedroom
26	GL1	1740/1635			Study
27	GL2	1190/1740/1190			GF Lobby
28	GL3	6215			GF Lobby
29	GL4	6215			GF Lobby
30	GL5	1000/1155/555			GF Lobby
31	GL6	4680/2000/2000			Podium Lobby
32	GL7	7210			GF Lobby
33	GL8	7210			GF Lobby
34	GL9	1000/1210			Podium Lobby
35	GL10	1000/1100/410			Podium Lobby
36	GL11	2375/7100/1155			Podium Lobby
37	GL12	3075			GF Lobby
38	GL13	1450/1855/2600			GF Lobby
39	GL14	1440			GF Lobby
40	GL15	2500			GF Lobby
41	GL16	1550			Podium Lobby
42	GL17	2600			Podium Lobby
43	GL18	6190			Podium Lobby
44	GL19	5345			GF Lobby
45	GL20	1590			GF Lobby
46	GL21	3640/1620			Study's Room
47	GL22	3685/1910			Study's Room
48	GL23	1090/1155/2565			GF Lobby
49	GL24	3340			GF Lobby
50	GL25	1755/9685/1735			Podium Lobby
51	GL26	1725/2670			GF Lobby
52	GL27	900			GF Lobby
53	GL28	1600			GF Lobby

FIRE DOORS AND VENTILATOR

54	FD1	1250			Entrance Door
55	FD2	1250			Staircase/Fire Lobby
56	FD3	1800			100 MV Shaft
57	FD4	700			100 LV Shaft
58	FD5	900			Utility
59	FD6	900			100 MV Shaft
60	FD7	1250			Terrace/Balcony room
61	FD8	1250			Staircase/Fire Lobby
62	FD9	1200			Fire Control Room
63	FD10	700			100 MV Shaft
64	FD11	900			100 MV Shaft
65	FD12	1750			100 MV Shaft

CLIENTS

PURI CONSTRUCTION PVT. LTD.
4-7B, GROUND FLOOR,
TOLSTOY HOUSE
TOLSTOY MARG,
NEW DELHI-110001

STRUCTURES

TFC

Technical Projects Consultants Pvt. Ltd.
B-74 | Sector 57 | Noida 201301 | Uttar Pradesh | India
T: +91-120-4306800 | D: +91-120-4306806 |
M: +91-9910285917
www.tpcconsultants.co.in

ARCHITECTS

Arco Associates Pvt. Ltd.
Plot- 36B, Sec-32, Gurgaon-122001
Ph: 26742959/26542959
Montreal, Toronto, New-Delhi, Boston

PROJECT

Building plan of Phase-B, Under (TOD and TDR)
policy area measuring 5.56175 Acres License
no 87 of 2012 dated 29-08-2012 (4.268 Acres) &
License no 33 of 2013 dated 25-05-2013
(1.29375 Acres) part of 21.01875 Acres License
No. 55 of 2010 dated 25-07-2010 (15.457 Acres).
License no 87 of 2012 dated 29-08-2012 (4.268
Acres) & License no 33 of 2013 dated
25-05-2013 (1.29375 Acres) in Sector-110A &
111, Gurugram being developed by M/s Puri
Construction Pvt. Ltd.


ARCHITECTS SIGNATURE

OWNER'S SIGNATURE
PURI CONSTRUCTION PVT. LTD.
Authorised Signatory

DRAWING TITLE
GROUP HOUSING COLONY
(TOWER-B2)
PODIUM FLOOR (UPPER) PLAN &
AREA CALCULATIONS

DRAWING NO.
AR-B2-103

PLUMBING NOTES:-			
1.	WASH BASIN TO FLOOR TRAP (FT) 40 OD UPVC PIPE.		
2.	KITCHEN SINK TO FLOOR DRAIN (FD) 43 OD UPVC WASTE PIPE.		
3.	FLOOR DRAIN (FD) TO FLOOR TRAP (FT) 43 OD UPVC WASTE PIPE.		
4.	110 OD UPVC PIPE USED FOR SOIL & WASTE.		
5.	110 OD UPVC PIPE USED FOR TERRACE RAIN WATER.		
6.	110 OD UPVC PIPE USED FOR BALCONY.		
SCHEDULE OF PIPES :-			
LEGEND	DESCRIPTION		
1	110 OD UPVC SOIL PIPE & VENT PIPE		
2	110 OD UPVC WASTE PIPE & VENT PIPE		
3	75 OD UPVC ANTI-SIPHONAGE PIPE		
4	75 OD UPVC WASTE PIPE FOR KITCHEN & UTILITY BALCONY		
5	75 OD UPVC ANTI-SIPHONAGE PIPE		
6	110 OD UPVC TERRACE RAIN WATER PIPE		
7	110 OD UPVC BALCONY RAIN WATER PIPE		
8	DOMESTIC WATER SUPPLY D/N TAKE PIPE *		
9	FLUSHING WATER SUPPLY D/N TAKE PIPE *		
10	DOMESTIC WATER SUPPLY RISER *		
11	FLUSHING WATER SUPPLY RISER *		
12	DOMESTIC WATER SUPPLY D/N TAKE PIPE FOR TOP 4TH FLOOR		
13	CUTOUT IN SLAB +150 X 150 MM FOR WC		
14	FLOOR TRAP (FT) 110 X 110 MM, OUTPUT IN SLAB +150 X 150 MM		
15	FLOOR DRAIN (FD) 110 X 62 MM		
16	BALCONY DRAIN (BD) 110 X 62 MM		

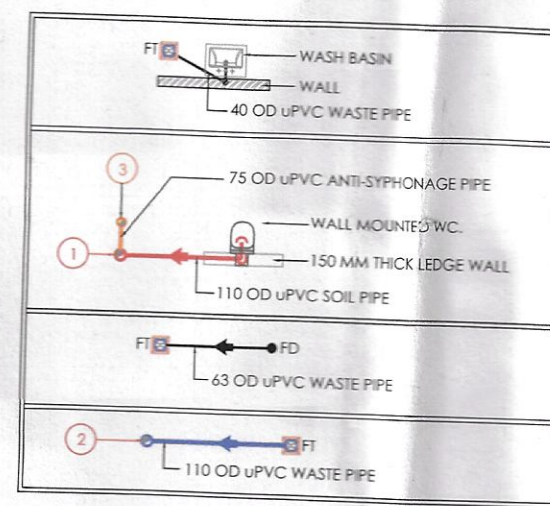

NOTES:
REFER DRAWING NO. AR-B-201.202 & 203 FOR ELEVATIONS
REFER DRAWING NO. AR-B-301 FOR SECTIONS
ALL TOILETS TO BE MECHANICALLY VENTILATED

