


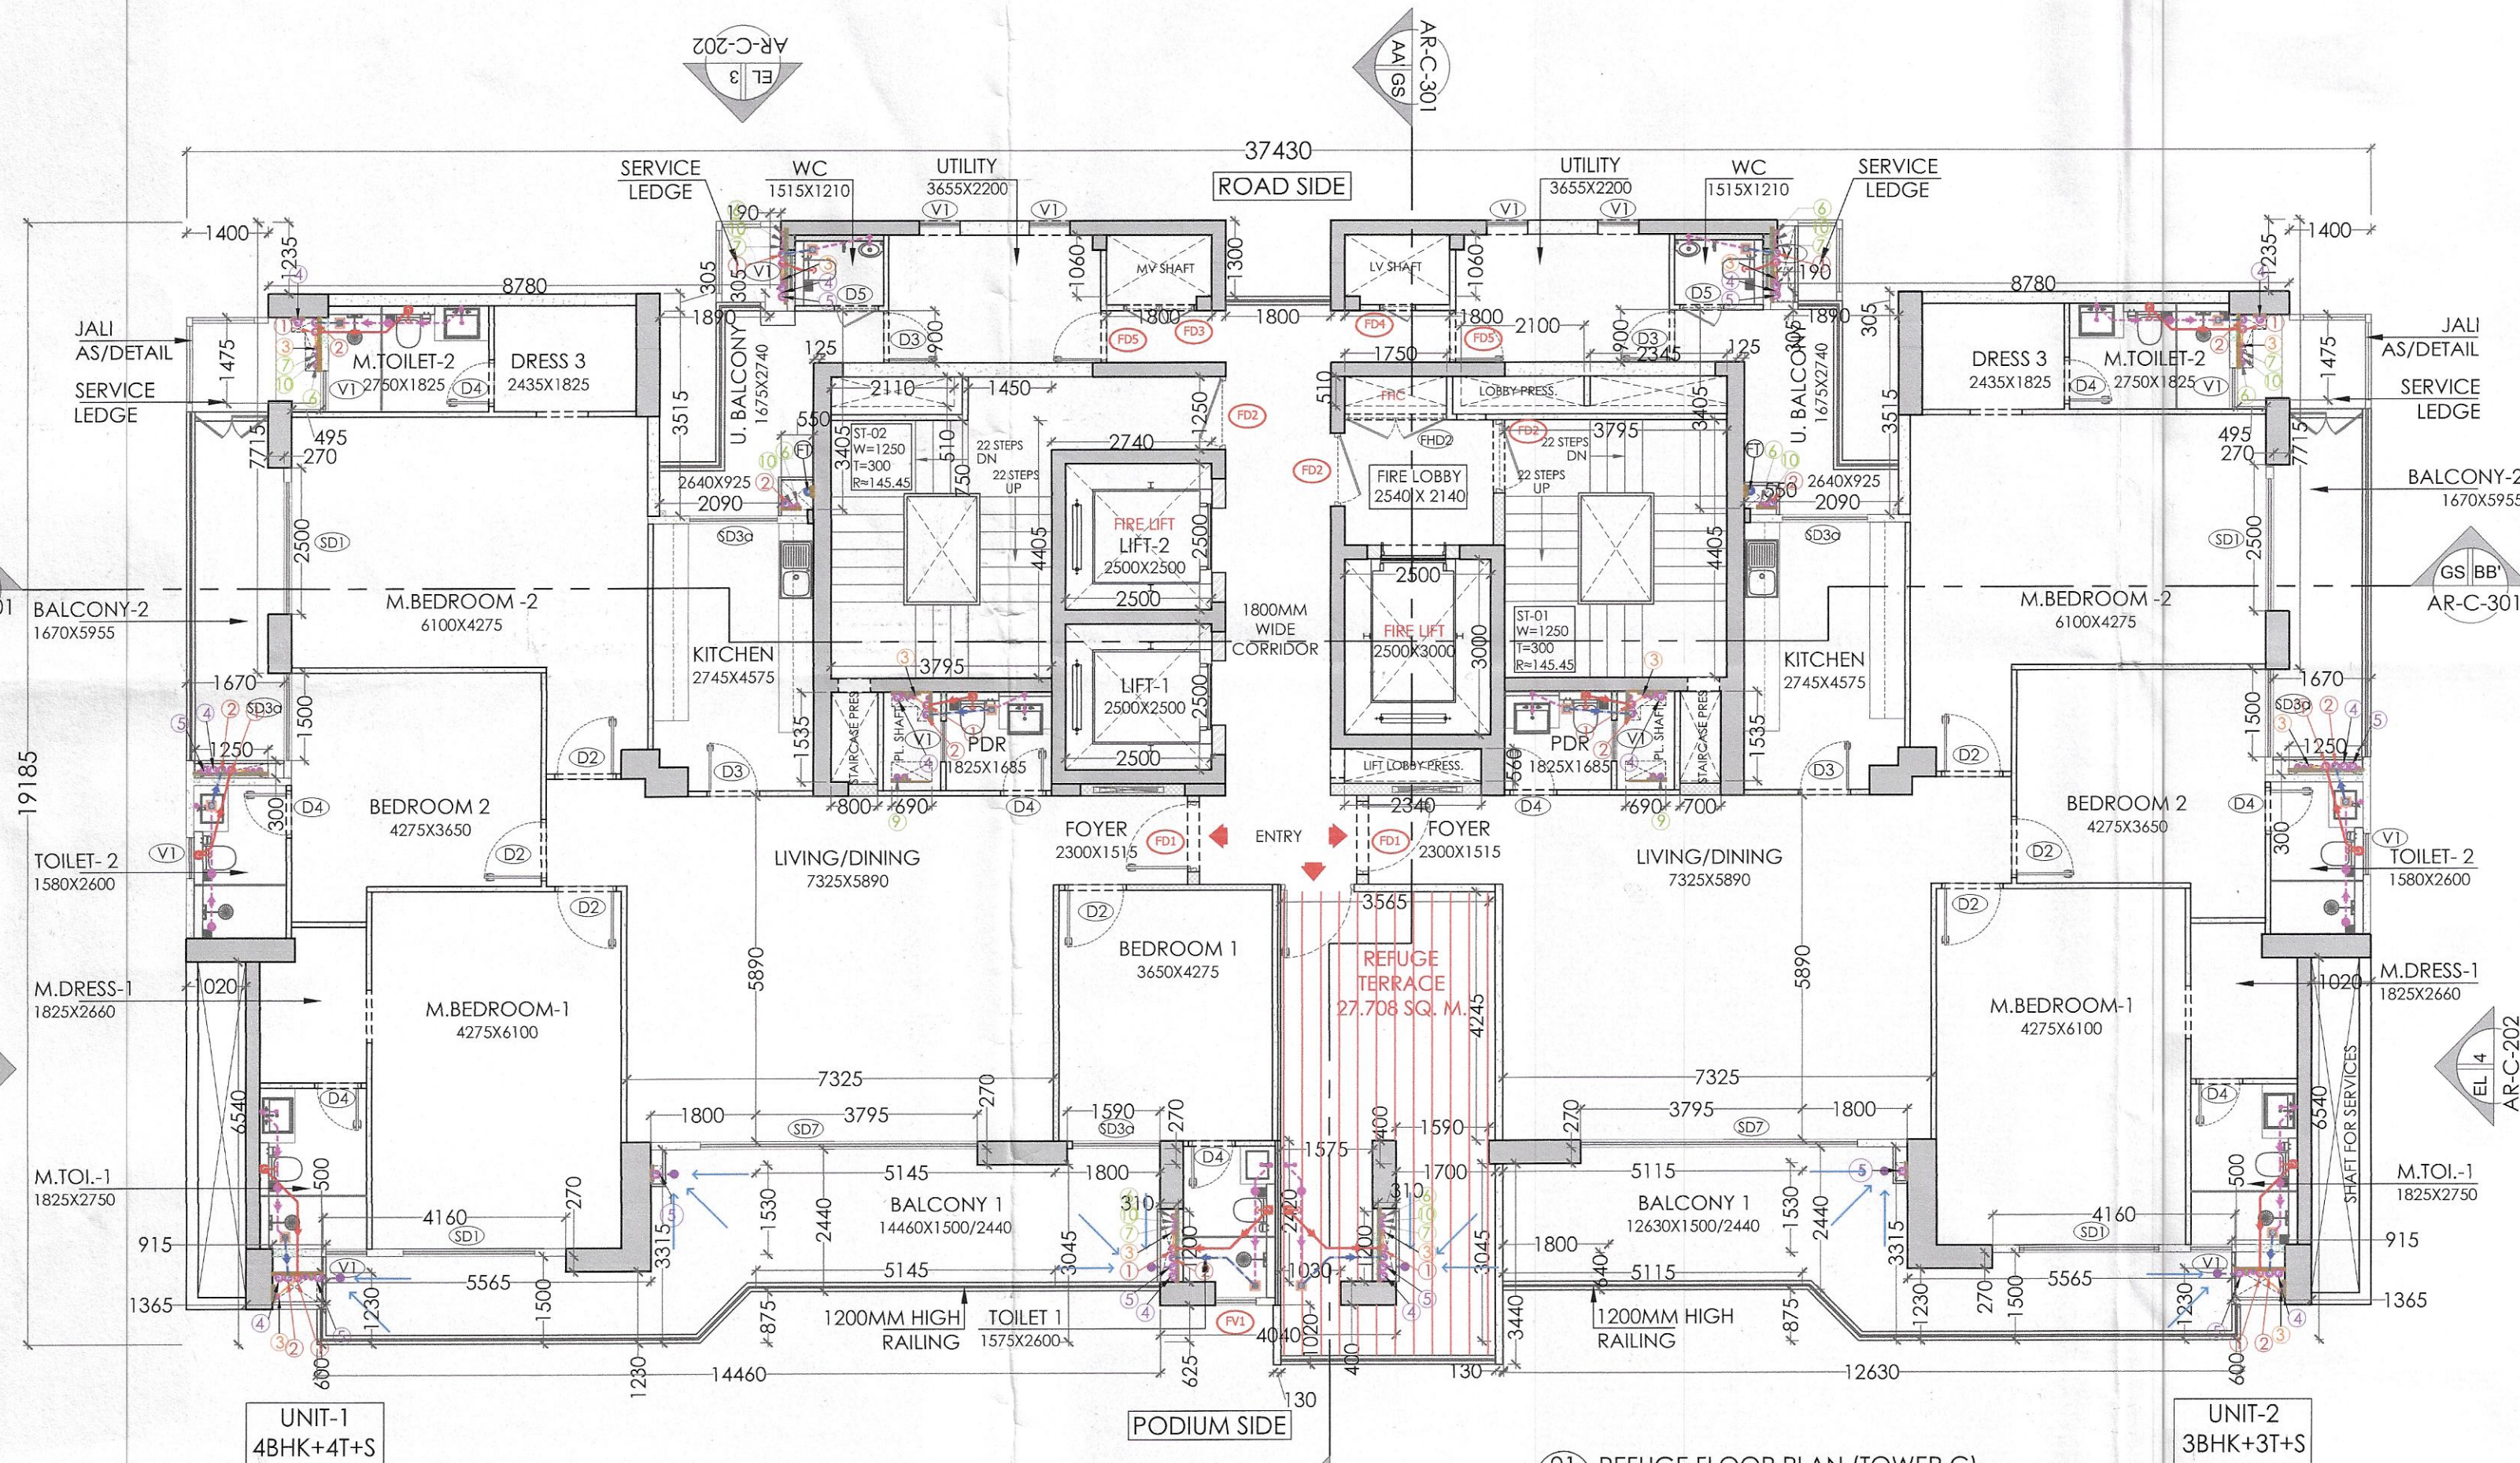

03 REFUGE FLOOR CARPET AREA F.A.R. AREA DIAGRAM (TOWER C)
SCALE: 1:100

Checked and found ok for Public Health (Internal) Service only subject to comments in forwarding letter No.DV.....

This is a "PROVISIONAL BUILDING PLAN" approved only for the purpose of inviting objections from the general public


Supervising Engineer (HQ)
for Civil Engineer
HSVP, Pandharpur

D.T.P. (HQ) S.T.P. (HQ) S.T.P. (HQ)
Member Member Member
B.P.A.C. B.P.A.C. B.P.A.C.

Consultant Architect

Varinder Kumar AD(HQ)

KEY PLAN

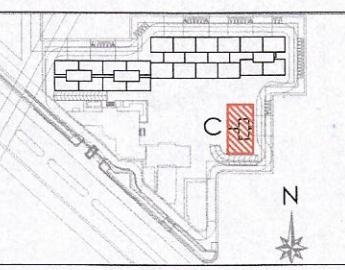

NOTES

S. NO.	DOOR TAGS	WIDTH	LINTEL	CILL	LOCATION	FIRE RATINGS
1	D2	1550			Bedroom	
2	D3	900			Kitchen/Study	
3	D4	800			Toilet	
4	D4	1200			GF Lobby	
5	D8	750			Toilet	
6	D9	1250			GF & Terrace	
7	GD1	1800			entry from lift	

EXTERNAL DOORS

8	SD1	2250			M. Bedroom	
9	SD2	2150			Bedroom 2	
10	SD3	1450			Bedroom 1	
11	SD3a	1500			Bedroom 1	
12	SD4	2750			Living/Dining	
13	SD5	2590			Living/Dining	
14	SD4	1900			Study	
15	SD7	4740			Living/Dining	
16	SD5	750			Servant Toilet	
17	D7	900			Room	
18	DW1	900/350			Q/1200 Kitchen	
19	DW2	900/310			Q/1200 S. Room/Study	
20	DW3	1200/1380			Q/1200 Machine Room	

WINDOWS

21	V1	700			Toilet	
22	V2	600			Toilet	
23	W4	1250			Staircase	
24	W5	600			Staircase	
25	W6	900			M. Bedroom	
26	GL1	2140/1435			Study	
27	GL2	1190/1155/2565			Podium Lobby	
28	GL3	6215			GF Lobby	
29	GL4	6215			GF Lobby	
30	GL5	1090/1155/2565			Podium Lobby	
31	GL6	4680/2020/2030			GF Lobby	
32	GL7	7210			GF Lobby	
33	GL8	7210			GF Lobby	
34	GL9	1059/1210			GF Lobby	
35	GL10	1000/1004/410			Podium Lobby	
36	GL11	2375/1007/1155			Podium Lobby	
37	GL12	5275			GF Lobby	
38	GL13	1450/1950/3840			GF Lobby	
39	GL14	1440			GF Lobby	
40	GL15	2500			GF Lobby	
41	GL16	1500			Podium Lobby	
42	GL17	2400			Podium Lobby	
43	GL18	6190			Podium Lobby	
44	GL19	5345			GF Lobby	
45	GL20	1590			GF Lobby	
46	GL21	3440/1630			Study/Room	
47	GL22	3885/1910			Study/Room	
48	GL23	1090/1155/2565			GF Lobby	
49	GL24	5240			GF Lobby	
50	GL25	1755/665/1735			Podium Lobby	
51	GL26	1225/2670			GF Lobby	
52	GL27	900			GF Lobby	
53	GL28	1800			GF Lobby	

FIRE DOORS AND VENTILATOR

54	FD1	1250			Entrance Door	
55	FD2	1250			Staircase/Fire Lobby	
56	FD3	1200			MV Shaft	
57	FD4	600			LV Shaft	
58	FD5	900			Utility	
59	FD6	900			MV Shaft	
60	FD7	1250			Staircase/Fire Lobby	
61	FD8	1250			Staircase/Fire Lobby	
62	FD9	1200			Fire Control Room	
63	FV1	700			Toilet	
64	RHD1	900			RHC Shaft	
65	RHD2	1750			RHC Shaft	

SUBTRACTIONS

1	7.715	1.400	2	21.602
2	8.780	1.235	2	21.687
3	0.190	0.305	2	0.116
4	1.890	0.435	2	1.552
5	2.090	0.515	2	14.093
6	0.550	3.405	2	3.746
7	0.270	2.500	2	1.350
8	1.670	1.500	2	5.010
9	1.250	0.300	2	0.750
10	6.540	1.020	2	13.342
11	1.365	0.405	2	1.638
12	0.915	0.500	2	0.915
13	4.160	0.270	2	2.246
14	5.565	1.230	2	13.690
15	1.800	3.315	2	11.934
16	3.795	0.270	2	2.049
17	5.145	1.530	1	7.872
18	5.145	0.875	1	4.562
19	1.800	0.045	1	5.481
20	1.590	0.270	1	0.429
21	0.310	1.200	2	0.744
22	4.040	0.625	1	2.525
23	2.110	0.510	1	1.076
24	3.795	4.405	1	16.717
25	0.800	1.535	1	1.228
26	0.690	1.535	2	2.118
27	2.500	2.500	2	12.500
28	1.450	0.750	1	1.088
29	2.740	1.250	1	3.425
30	2.500	3.000	1	7.500
31	2.340	0.560	1	1.310
32	3.790	0.530	1	0.899
33	1.000	1.071	1	1.071
34	2.345	0.510	1	1.196
35	1.800	1.060	2	3.816
36	1.800	1.300	1	2.340
37	3.795	4.405	1	16.717
38	1.800	0.640	1	1.152
39	1.080	0.400	1	0.432
40	1.975	2.420	1	3.812
41	3.565	4.245	1	15.133
42	0.700	1.535	1	1.075
43	5.115	1.530	1	7.826
44	5.115	0.875	1	4.476
45	1.700	3.045	1	5.177
46	1.590	0.400	1	0.636
47	0.495	1.475	2	1.460
48	0.125	0.900	2	0.225
TOTAL SUBTRACTIONS				251.850
TOTAL F.A.R.				466.824


PLUMBING NOTES:

- WASH BASIN TO FLOOR TRAP (FT) 40 OD UPVC PIPE
- KITCHEN SINK TO FLOOR DRAIN (FD) 63 OD UPVC WASTE PIPE
- FLOOR DRAIN (FD) TO FLOOR TRAP (FT) 63 OD UPVC WASTE PIPE
- 110 OD UPVC PIPE USED FOR SOIL & WASTE
- 110 OD UPVC PIPE USED FOR TERRACE RAIN WATER
- 110 OD UPVC PIPE USED FOR BALCONY

SCHEDULE OF PIPES:

LEGEND	DESCRIPTION
1	110 OD UPVC SOIL PIPE & VENT PIPE
2	110 OD UPVC WASTE PIPE & VENT PIPE
3	75 OD UPVC WASTE PIPE FOR KITCHEN & SHIP BALCONY
4	75 OD UPVC ANTI-SIPHONAGE PIPE
5	110 OD UPVC TERRACE RAIN WATER PIPE
6	110 OD UPVC BALCONY RAIN WATER PIPE
7	DOMESTIC WATER SUPPLY DRAIN TAKE PIPE
8	FLUSHING WATER SUPPLY DRAIN TAKE PIPE
9	DOMESTIC WATER SUPPLY RISER
10	FLUSHING WATER SUPPLY RISER
11	DOMESTIC WATER SUPPLY DRAIN TAKE PIPE FOR TOP 4TH FLOOR
12	CUTOUT IN SLAB 150 x 150 MM FOR WC
13	FLOOR TRAP (110 x 110 MM, OUTLET IN SLAB 150 x 150 MM)
14	FLOOR DRAIN (110 x 63 MM)
15	BALCONY DRAIN (110 x 63 MM)

NOTES:
REFER DRAWING NO. AR-C-201 & 202 FOR ELEVATIONS
REFER DRAWING NO. AR-C-301 FOR SECTIONS
ALL TOILETS TO BE MECHANICALLY VENTILATED

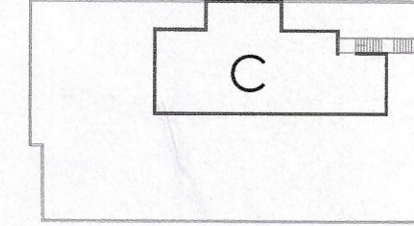

OWNER'S SIGNATURE

For PURI CONSTRUCTION PVT. LTD.

DRAWING TITLE

GROUP HOUSING COLONY

REFUGE FLOOR PLAN & AREA CALCULATIONS

AR-C-104