




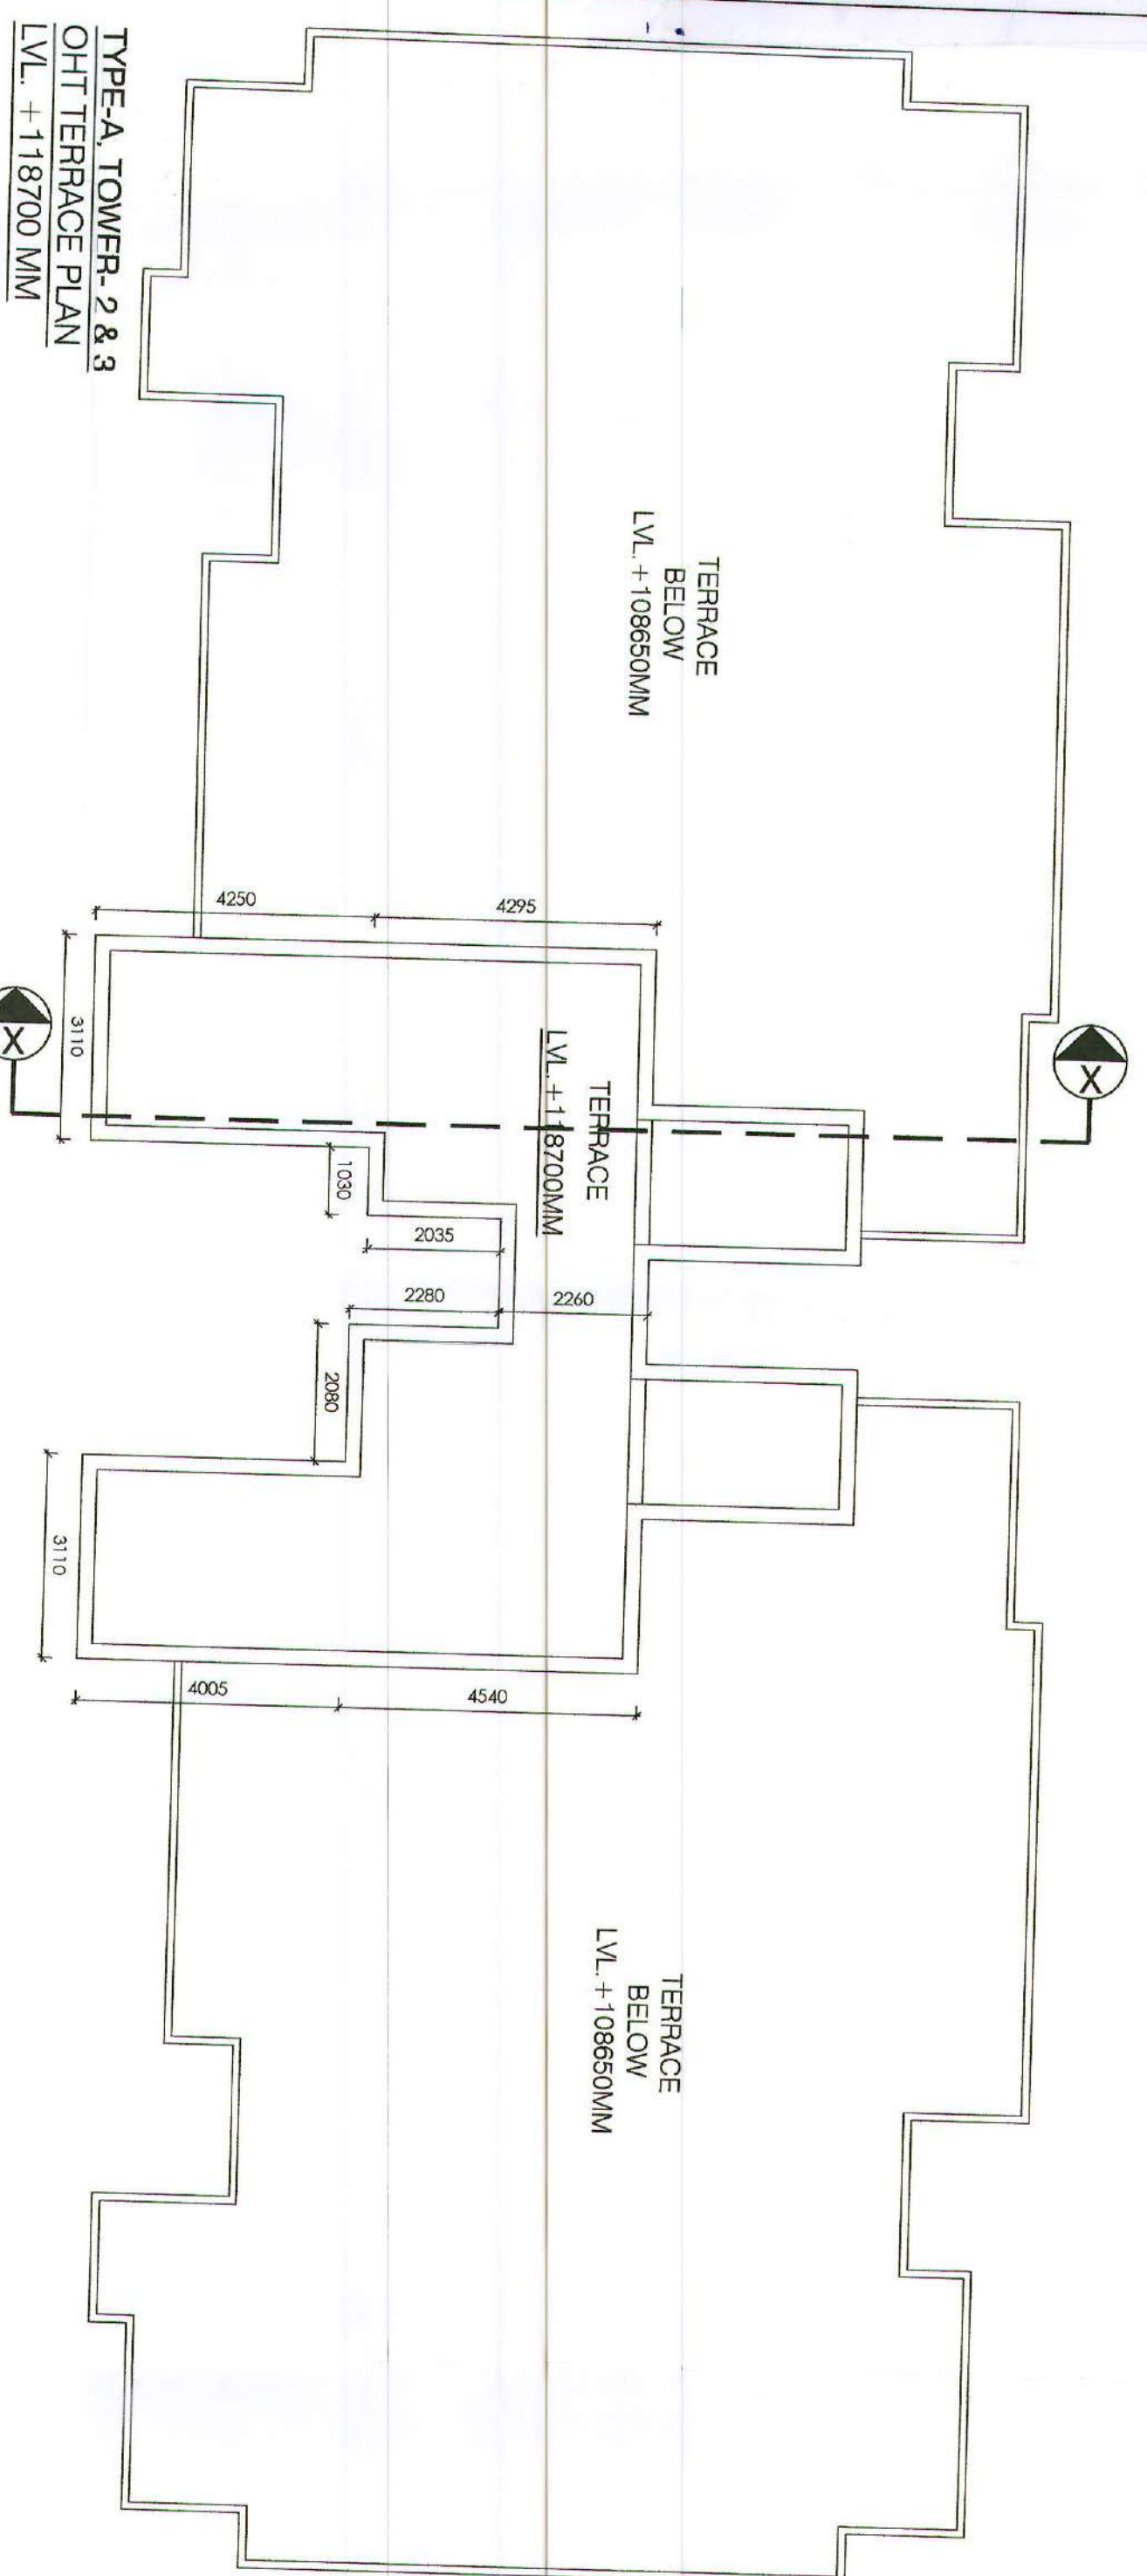


TYPE-A, TOWER-2 & 3
OHT TERRACE PLAN
LVL. +118700 MM

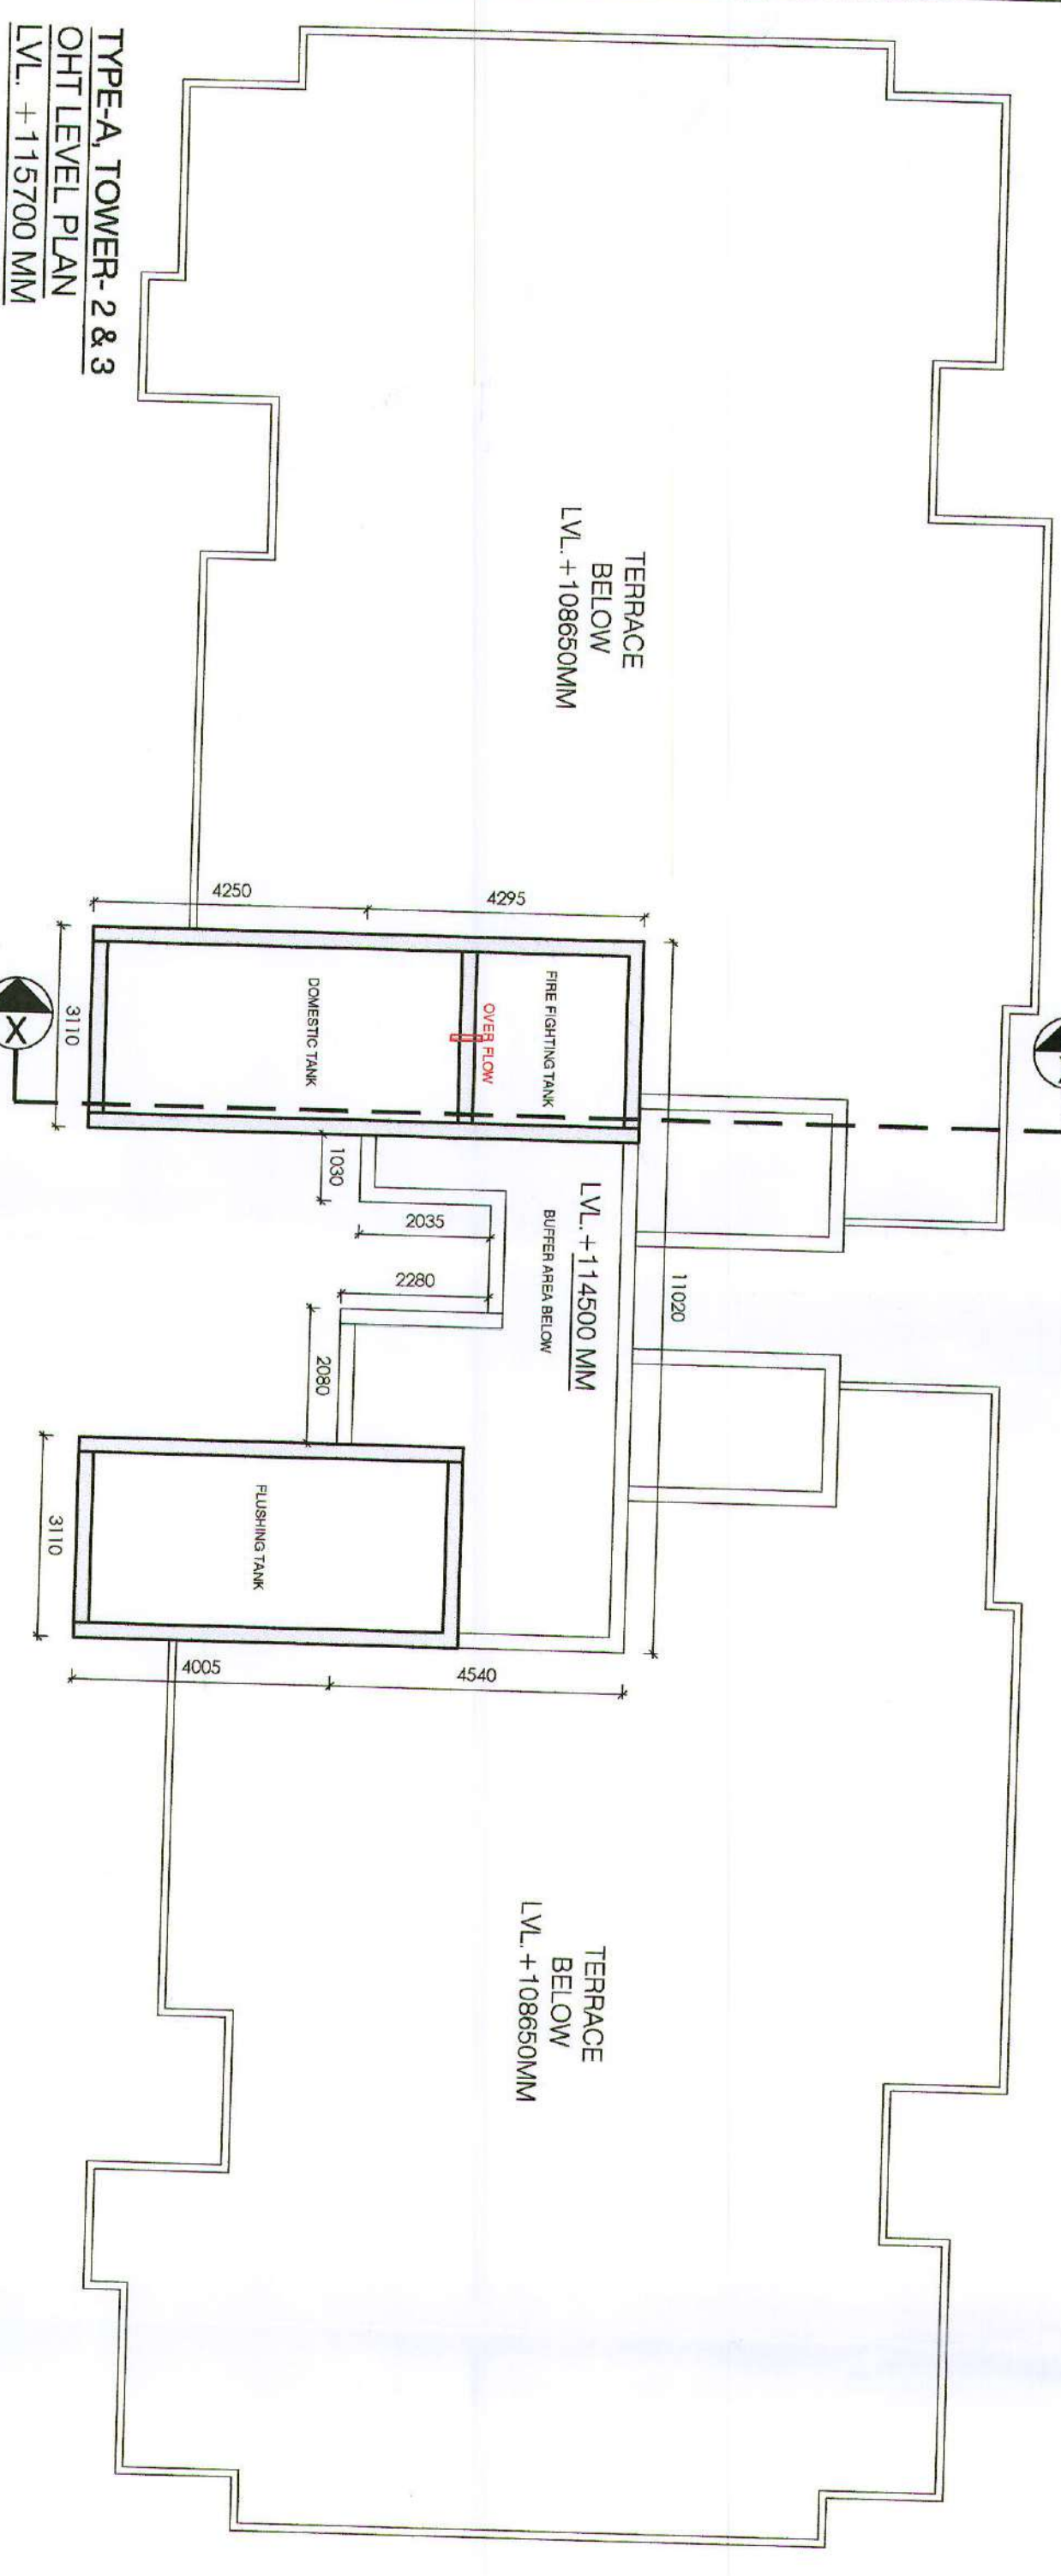


TYPE-A, TOWER-2 & 3
OHT LEVEL PLAN
LVL. +115700 MM

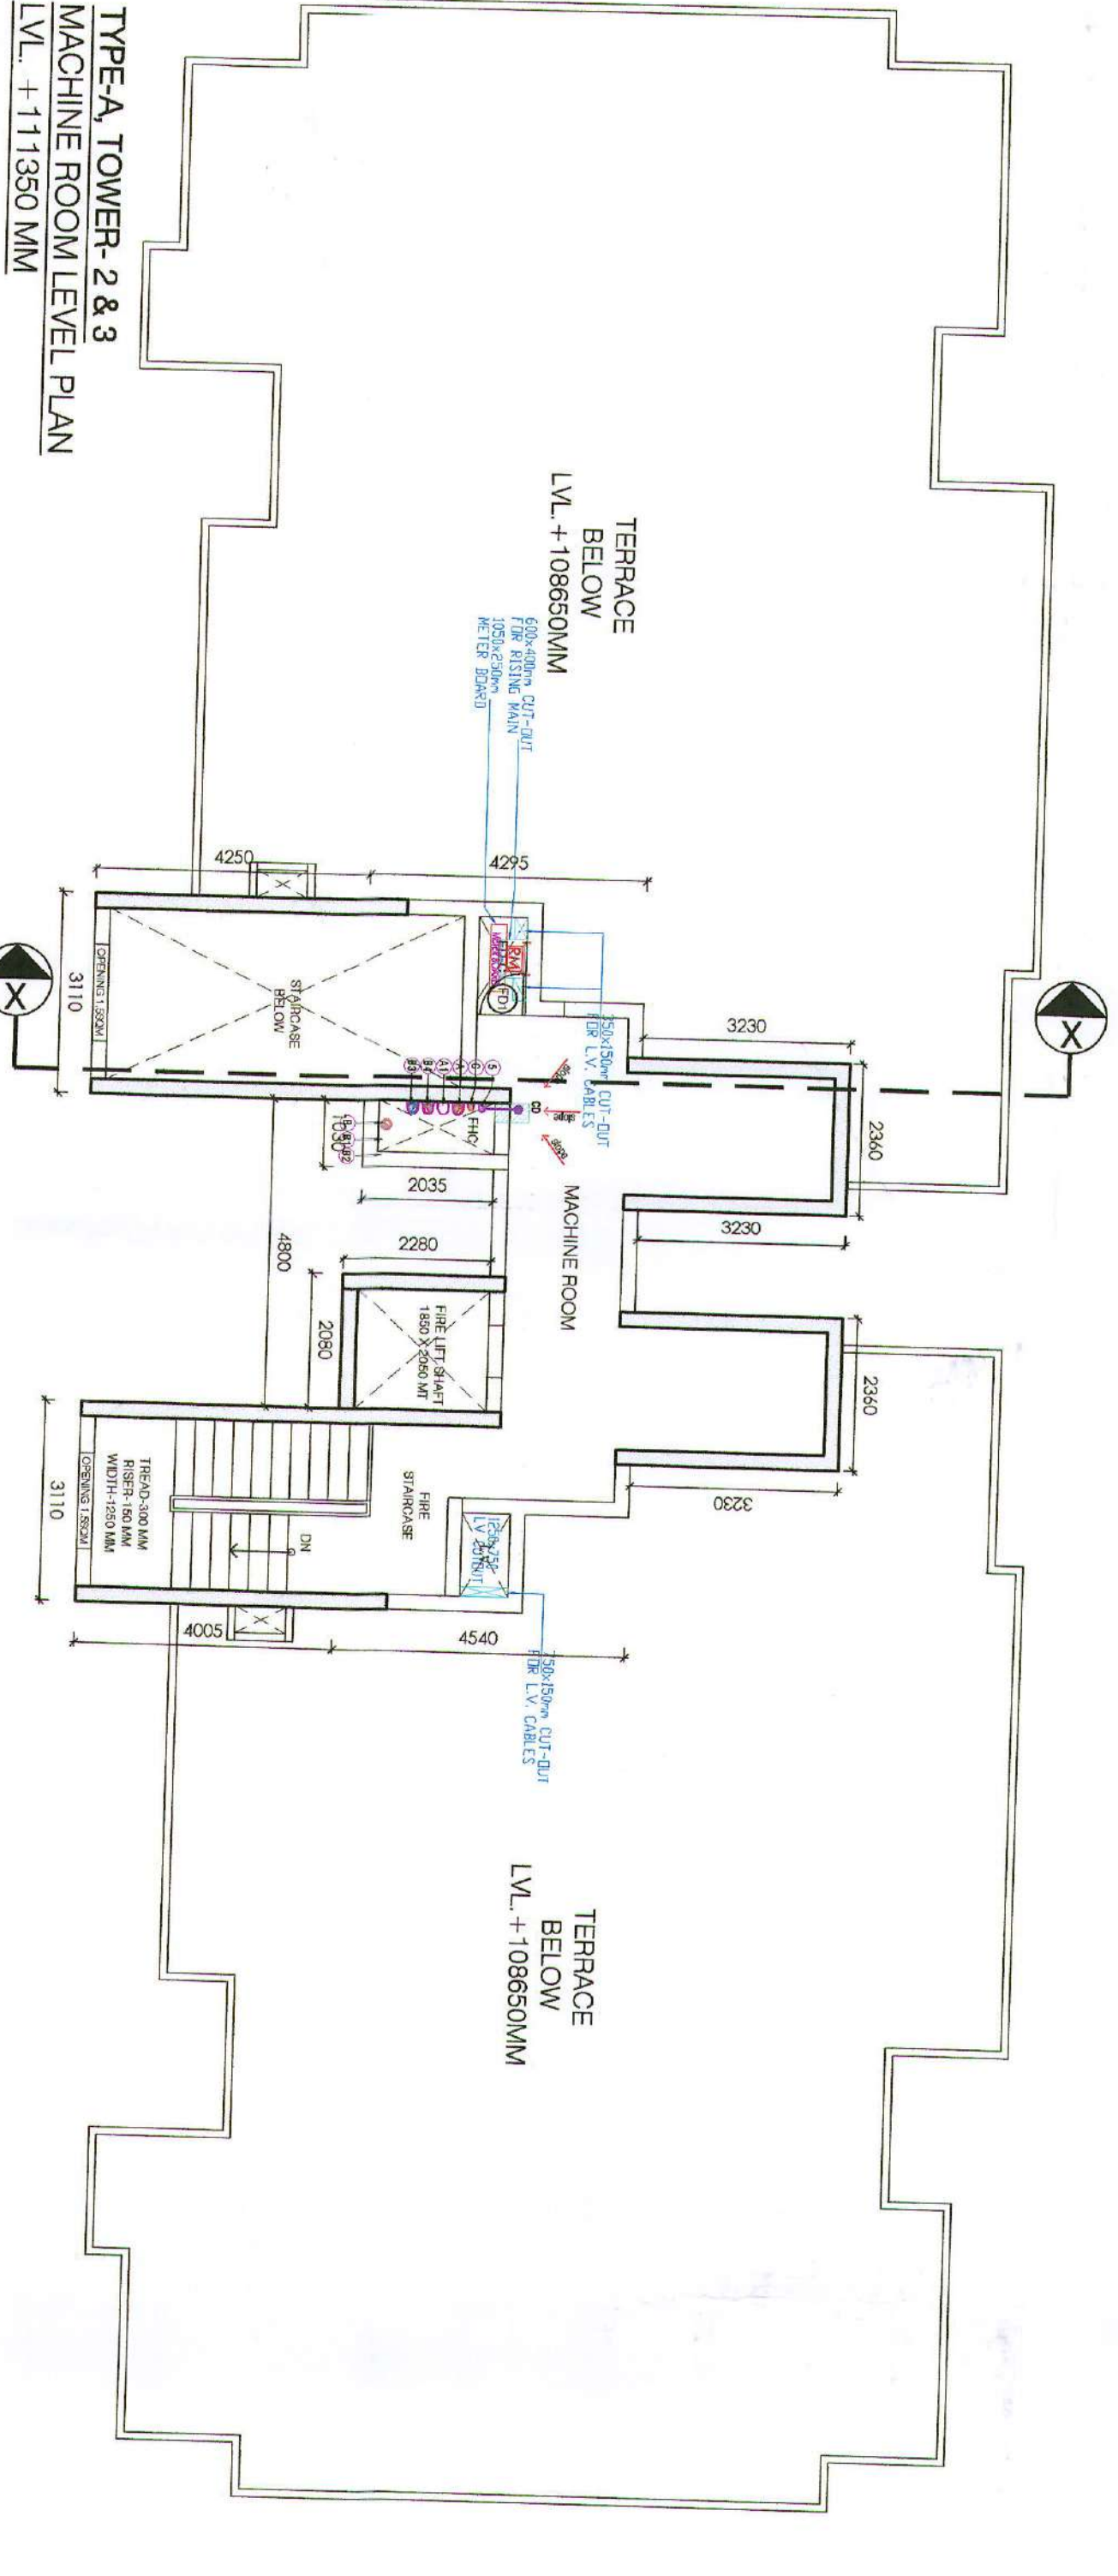


TYPE-A, TOWER-2 & 3
MACHINE ROOM LEVEL PLAN
LVL. +111350 MM

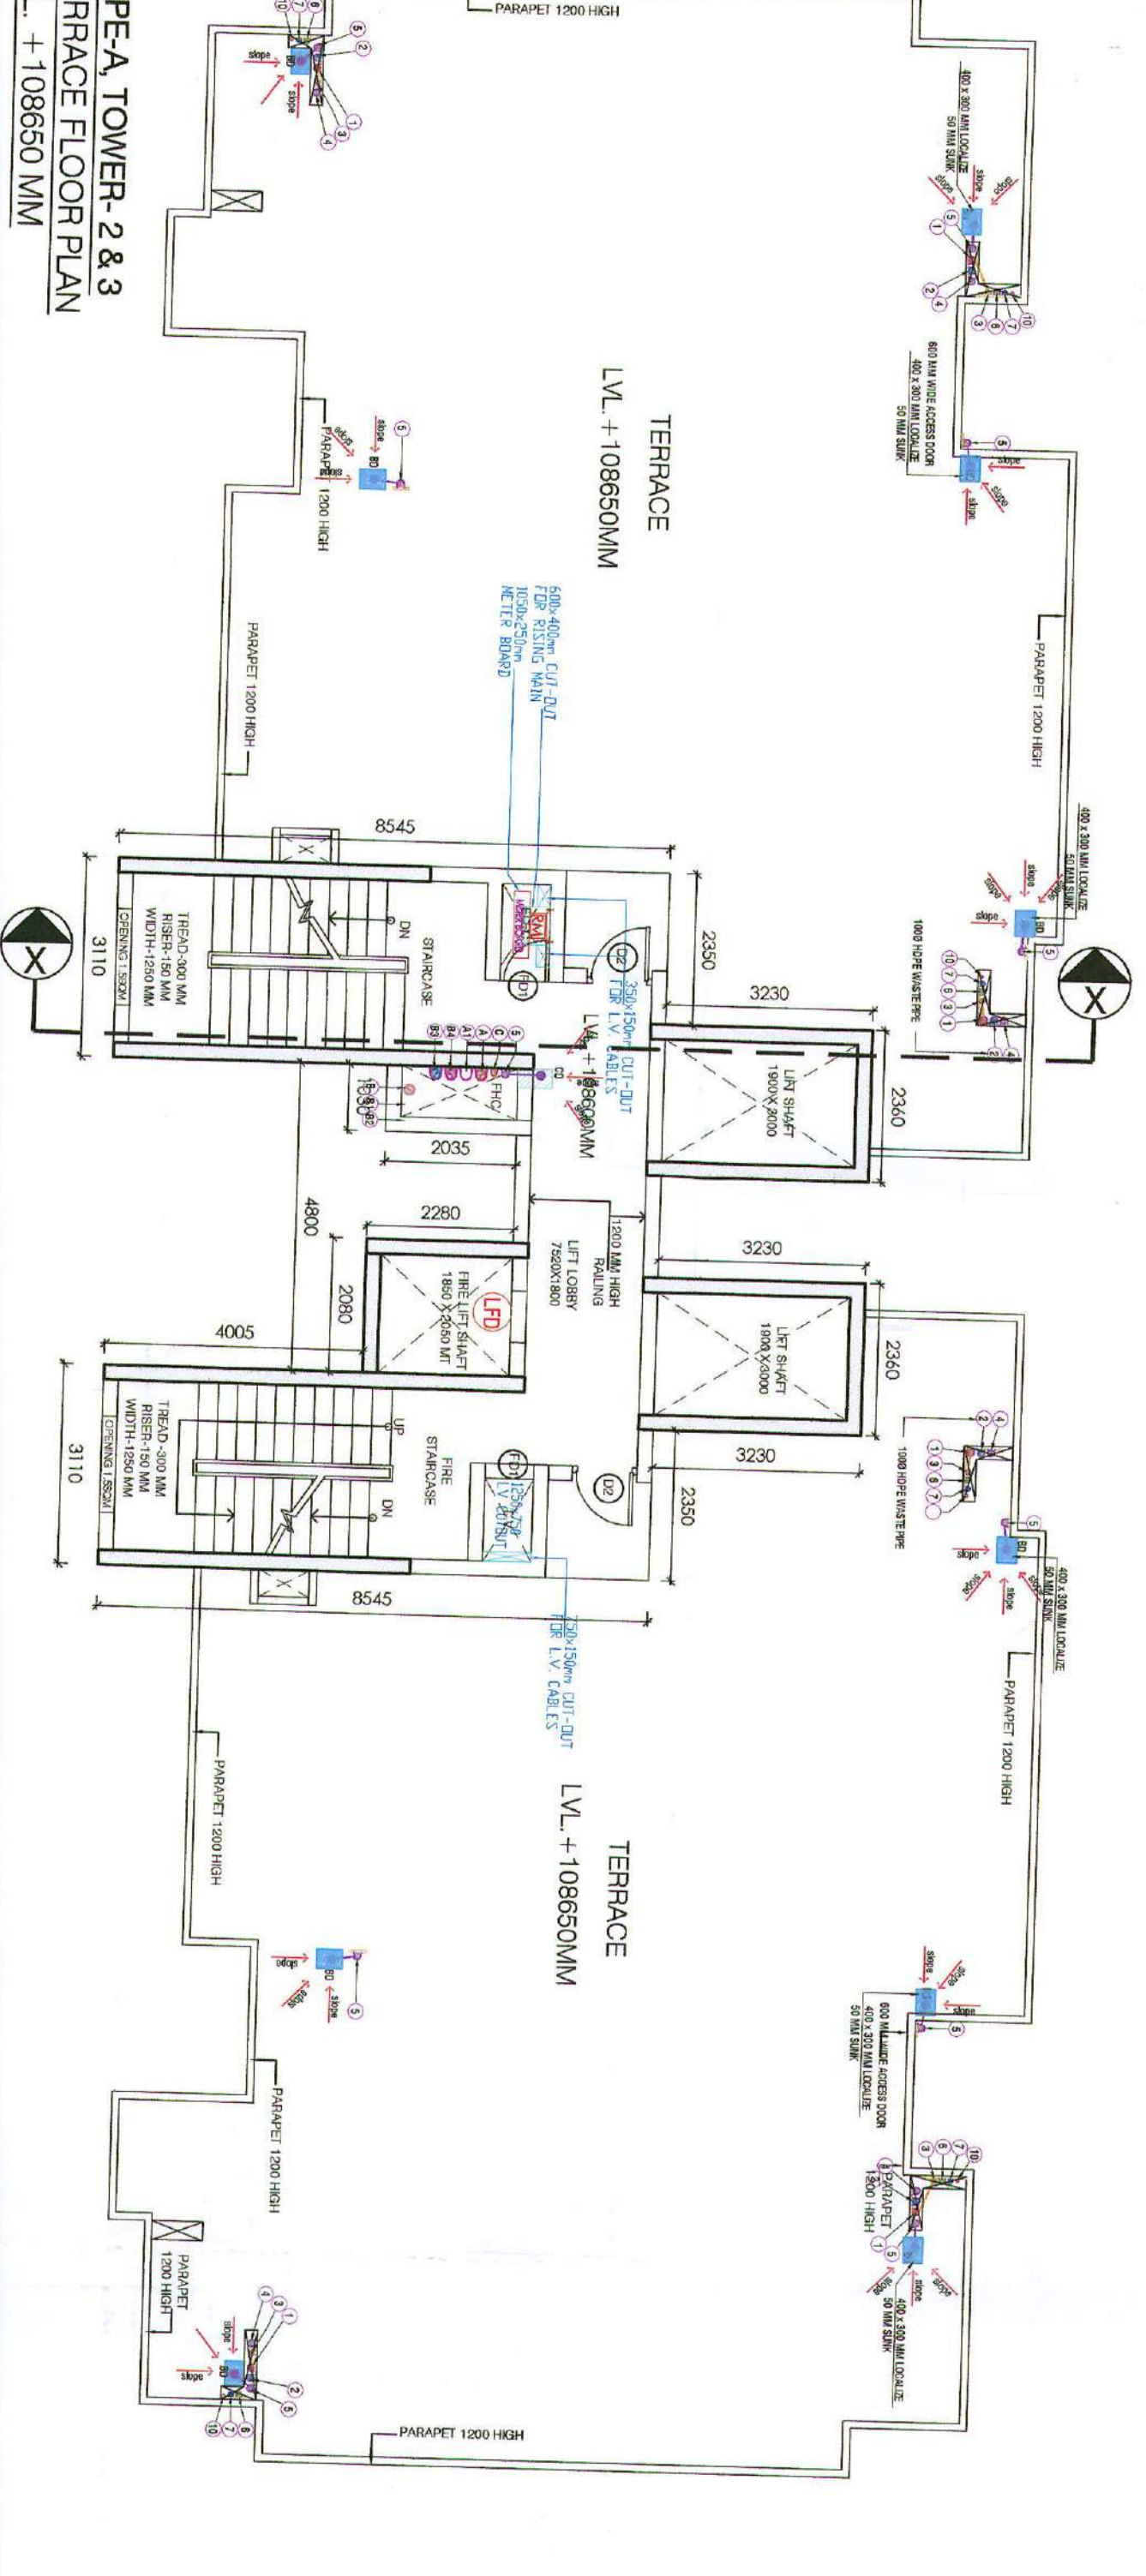

PE-A, TOWER-2 & 3
RACE FLOOR PLAN
- +108650 MM

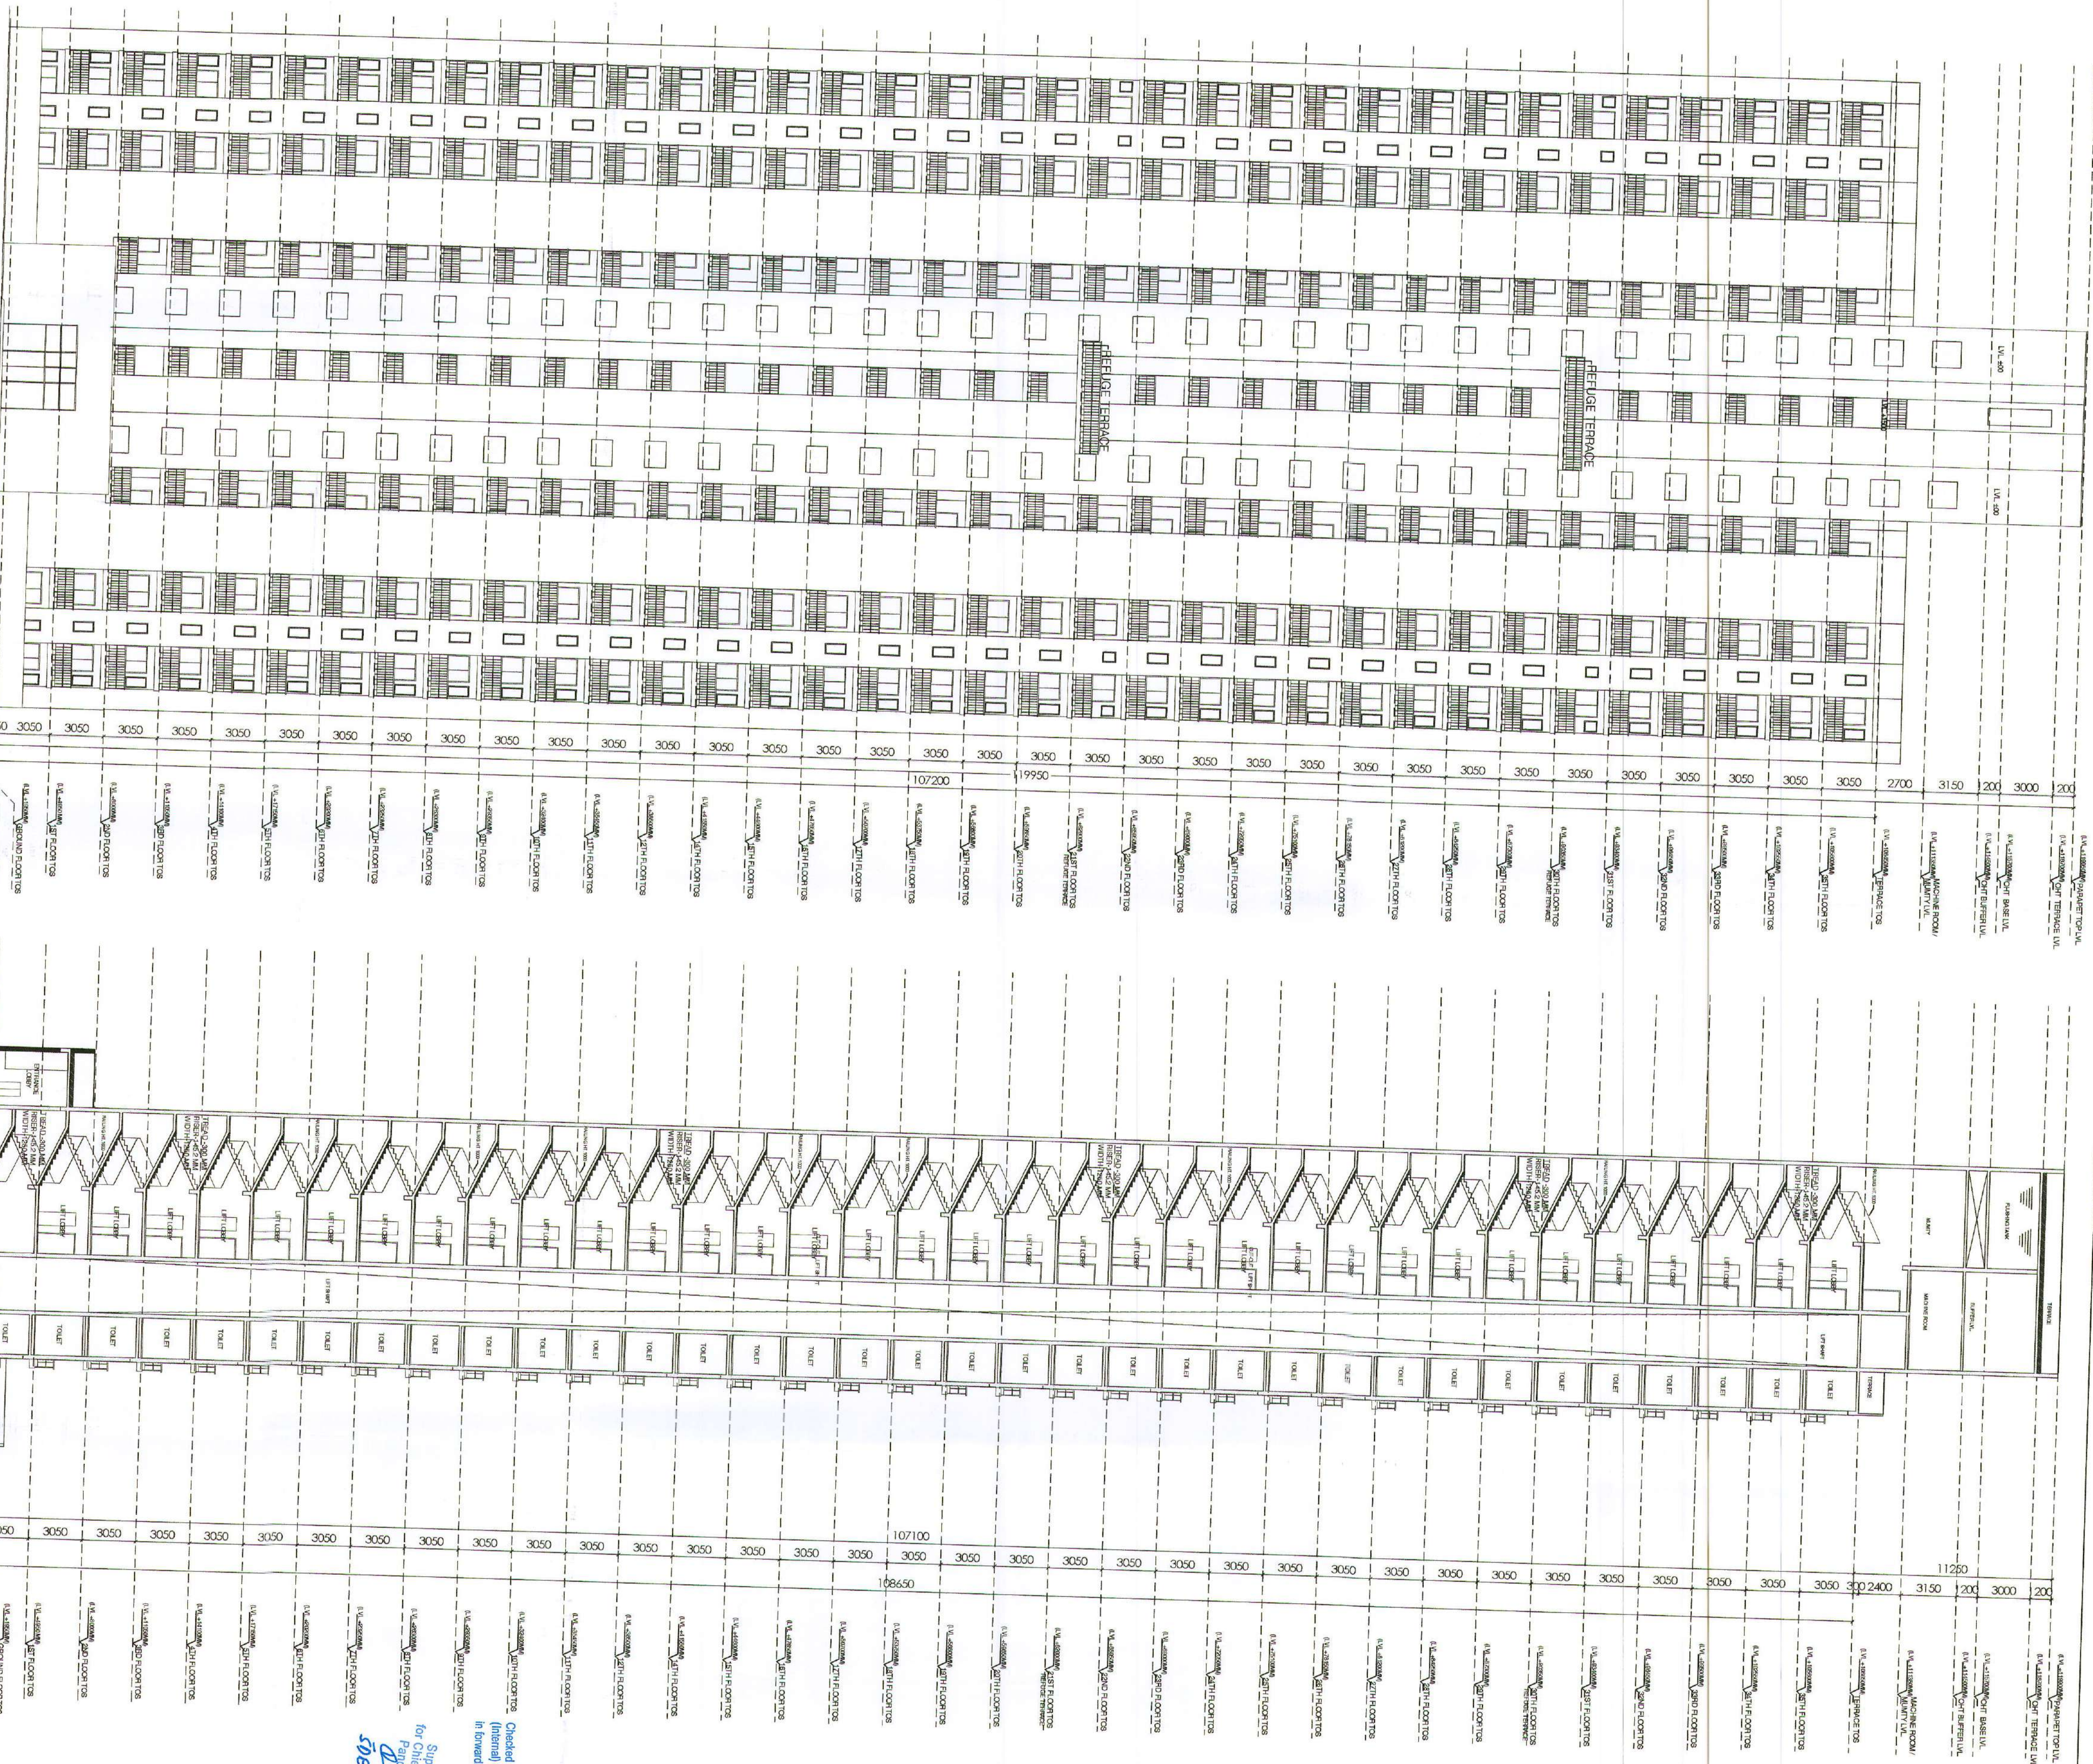


FRONT ELEVATION (SCALE-1:200)

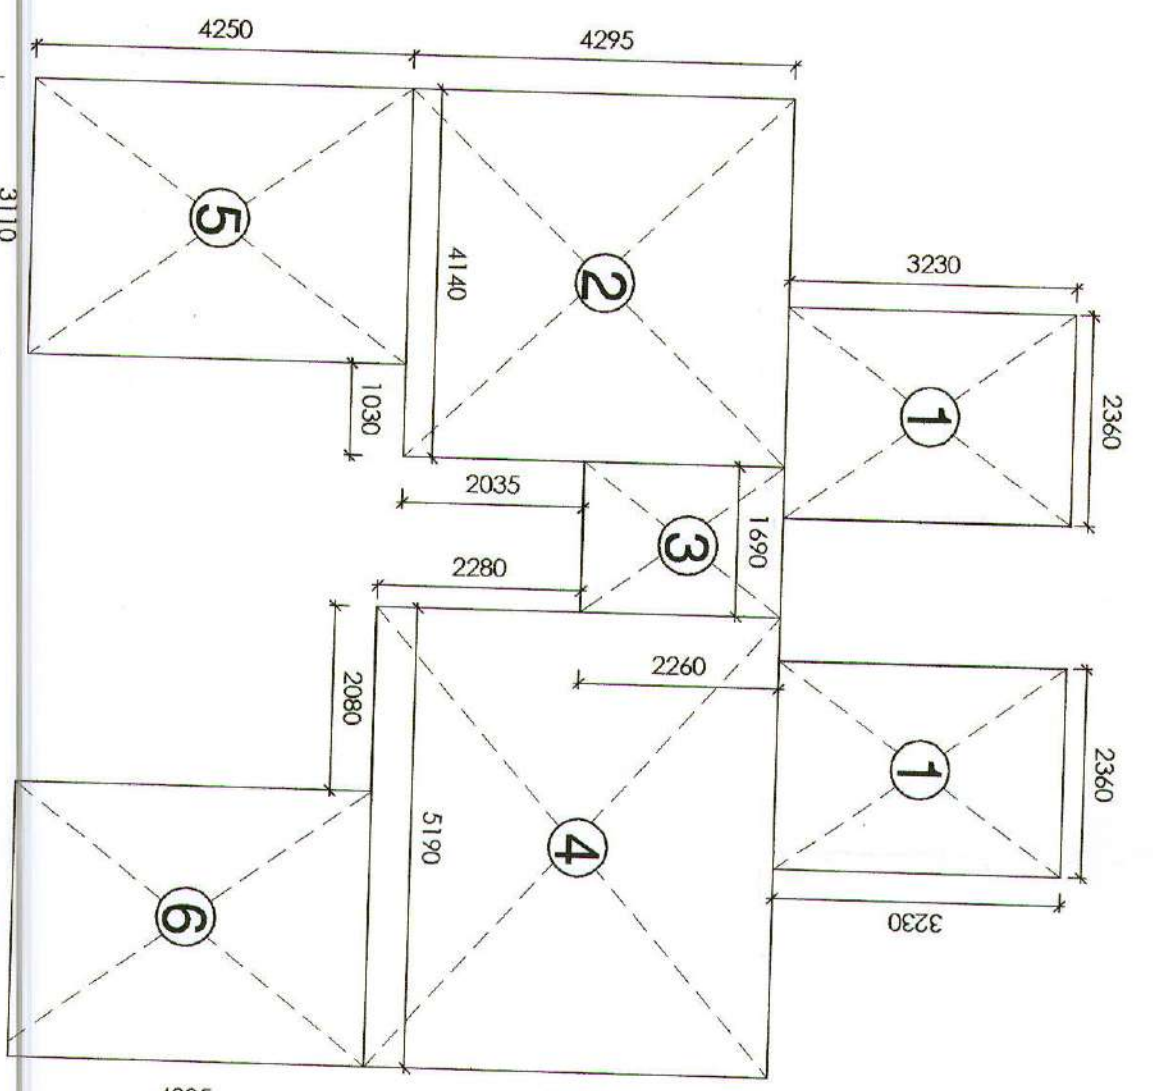


AREA DIAGRAM - MUMTY & MACHINE ROOM

MUMFORD & MACHINE ROOM				
AREA CALCULATION				
S. NO.	LENGTH	BREADTH	NO	TOTAL
1	2.860	X	3.320	2
2	4.140	X	4.295	1
3	1.690	X	2.260	1
4	5.190	X	4.540	1
5	3.110	X	4.250	1
6	3.110	X	4.005	1
				98.08

AREA CALCULATION				OFF
S. NO.	LENGTH	BREATH	NO	TOT
1	3.110	4.250	1	13.2
2	4.140	4.265	1	17.7
3	1.690	2.260	1	3.82
4	5.190	4.540	1	23.5
5	3.110	4.005	1	12.4
SUB				

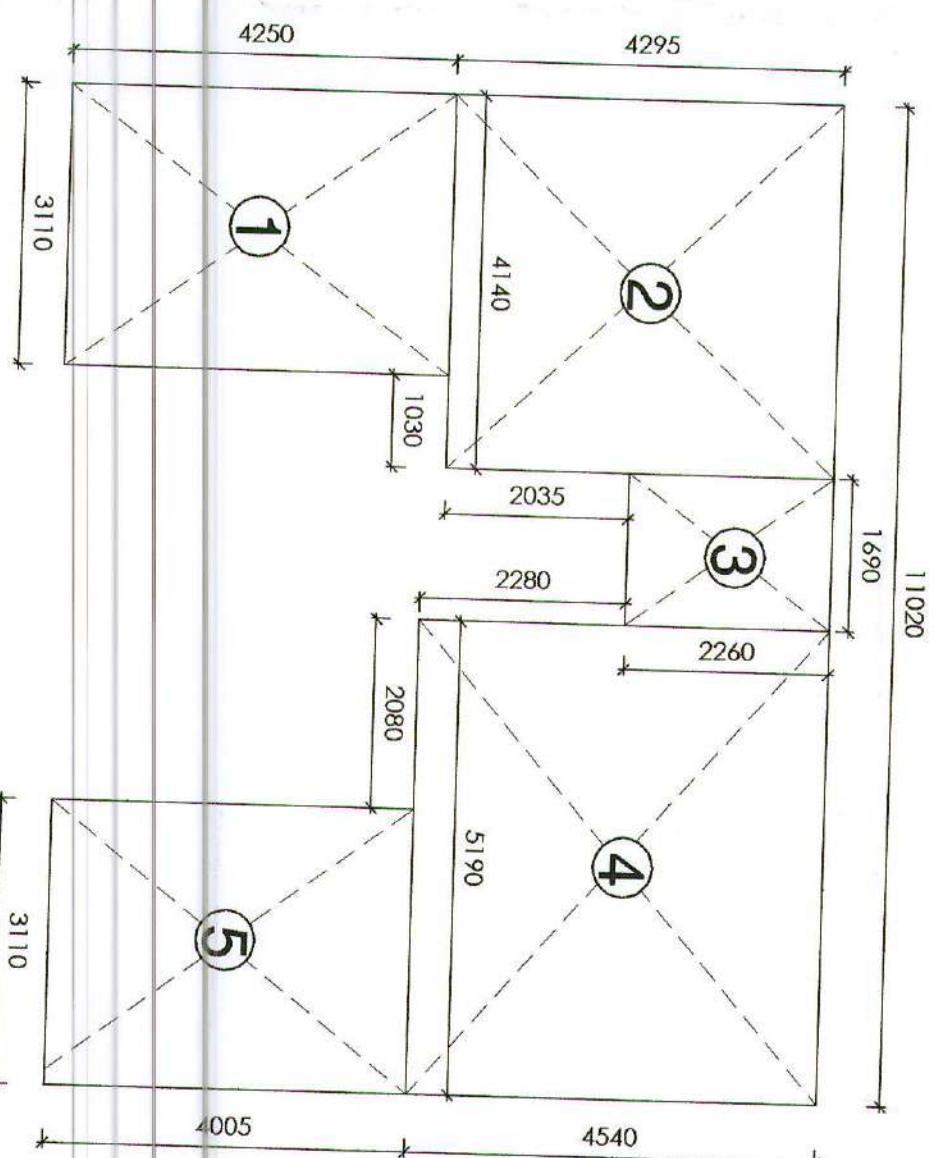

SECTION - XX (SCALE-1:200)

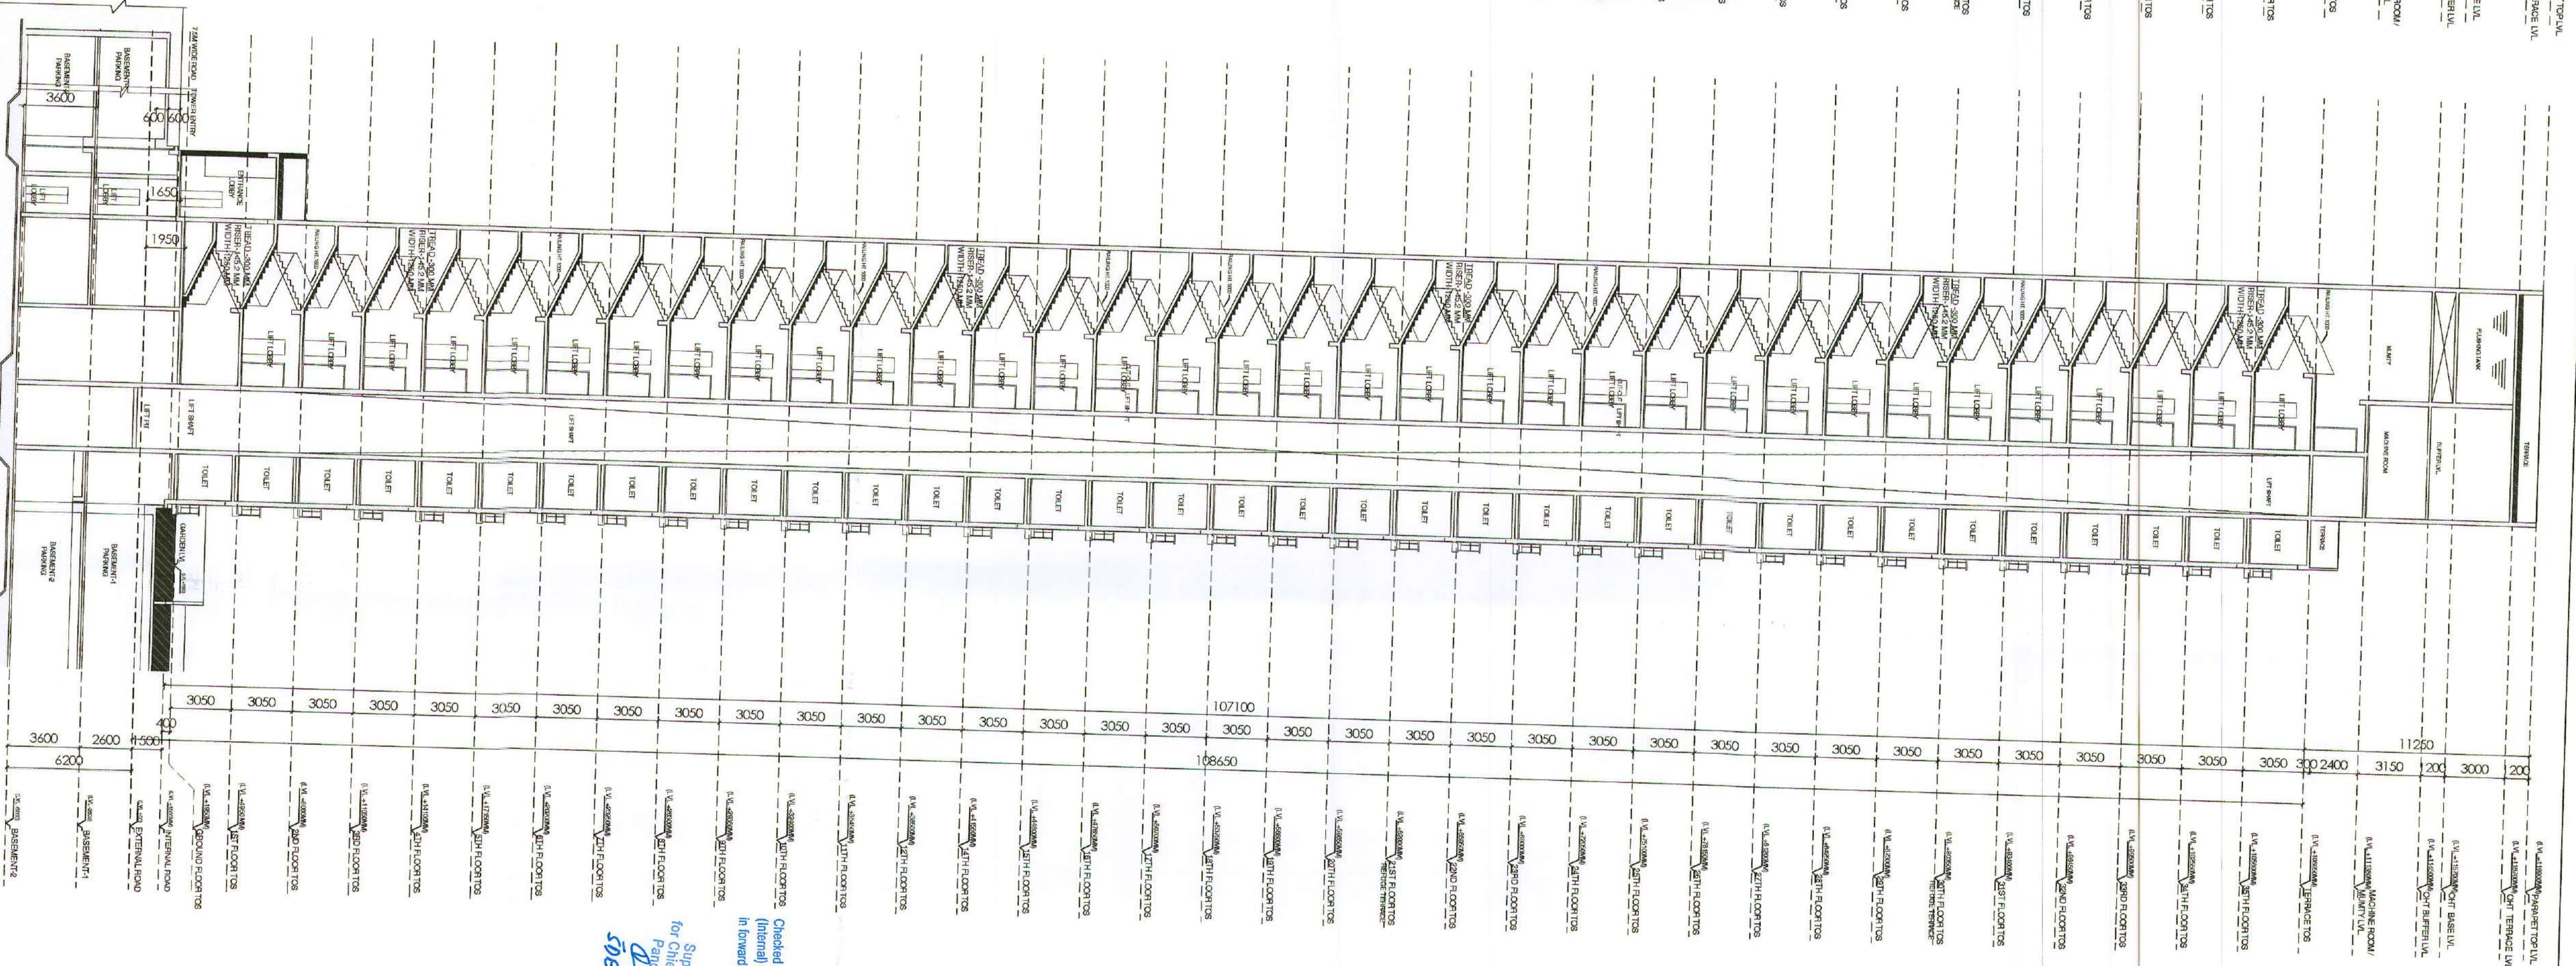[illegible]

OPENING SCHEDULE OF DOORS & WINDOWS

[illegible]

- | | |
|----|--|
| 1. | MADAM BAKER TO LOCATE TRUCK AT 10:20 AM THIS PM. |
| 2. | INTERCOMBUSTOR TO LOCATE TRUCK IF NOT AVAILABLE FIRE |
| 3. | REPORT ON DAMAGE TO LOCATOR TRUCK AT 10:20 AM THIS PM. |
| 4. | 1000 PPM PER SEC. TEST FOR GAS AND NOXIDE. |
| 5. | IF 10:20 PPM PER SEC. OR THEREABOUTS CONTINUE WITH WORK |
| 6. | IF 10:20 PPM PER SEC. STOP AND INVESTIGATE CAUSE OF LEAKAGE. |
-
- | SERIAL | TYPE | SIZE | SILL | LINTEL | REMARKS |
|--------|------|----------|------|--------|-----------|
| 1 | D1 | 800 X - | - | 2100 | - |
| 2 | D2 | 900 X - | - | 2100 | - |
| 3 | D3 | 1200 X - | - | 2700 | 1 HR FIRE |

PLUMBING NOTES

- | SERIAL | TYPE | SIZE | SILL | UNIT/L | REMARKS |
|--------|------|----------|------|--------|-----------|
| 1 | D1 | 800 X - | - | 2100 | |
| 2 | D2 | 900 X - | - | 2100 | |
| 3 | D3 | 1200 X - | - | 2700 | 1 HR FIRE |

NOTES

1. DIMENSIONS ARE NOT TO BE SCALED.
2. ALL DIMENSIONS ARE IN MM.
3. ALL ELECTRICAL INSTALLATIONS SHALL BE AS PER PROVISIONS OF NBC.
4. FIRE FIGHTING SAFETY PROVISIONS WILL BE AS PER RELEVANT NBC PROVISIONS.
5. BOUNDARY WALL AND GATE AS PER STANDARDS.
6. ALL WALLS ARE 230/200/115 MM THK. BRICK WALL.
7. RAIN WATER HARVESTING SYSTEM SHALL BE PROVIDED AS PER CENTRAL GROUND WATER AUTHORITY NORMS/HARYANA GOVT.
8. ALL WINDOWS & VENTILATORS ARE OPERABLE.
9. ALL MECHANICALLY VENTILATED & ARTIFICIAL LIT TOILET PROVIDED WITH 24hr POWER BACKUP.

REVISÉD SUBMISSION DRAWING

REVISED BUILDING PLAN OF MIX LAND USE COLONY (8% RESIDENTIAL COMPONENT & 12% COMMERCIAL COMPONENT) UNDER TRANSIT ORIENTED DEVELOPMENT (TOD) POLICY FOR THE AREA MEASURING 7.0553 ACRES (FALLING WITHIN TRANSITION ZONE) PART OF GROUP HOUSING COLONY MEASURING 13.078 ACRES (LICENSE NO. 127 OF 2012 DATED 27.12.2012) IN SECTOR - 105, GURUGRAM MANESAR URBAN COMPLEX BEING DEVELOPED BY SH. KANWAR SINGH & OTHERS IN COLLABORATION WITH 1000 TREES HOUSING PRIVATE LIMITED (A 100% WHOLLY OWNED PRIVATE LIMITED)

DRAWING TITLE:

111 E-24, 10 MEN-2 & 3 (G+34)
TERRACE PLAN, MACHINE ROOM LEVEL PLAN, OHT LEVEL, PLAN, OHT

TYPE-A

DEAL BY	DATE	DESCRIPTION & SECTION

CHECKED BY	DATE	SHEET NO
		AR-A-2.2

THROUGH : AUTHORISED SIGNATORY

APR 11 1961

00 Treco Housing Pvt Ltd
Authorized Signatory
CA2009/46567

OWNER'S SIGN	ARCHITECT'S SIGN.
--------------	-------------------