



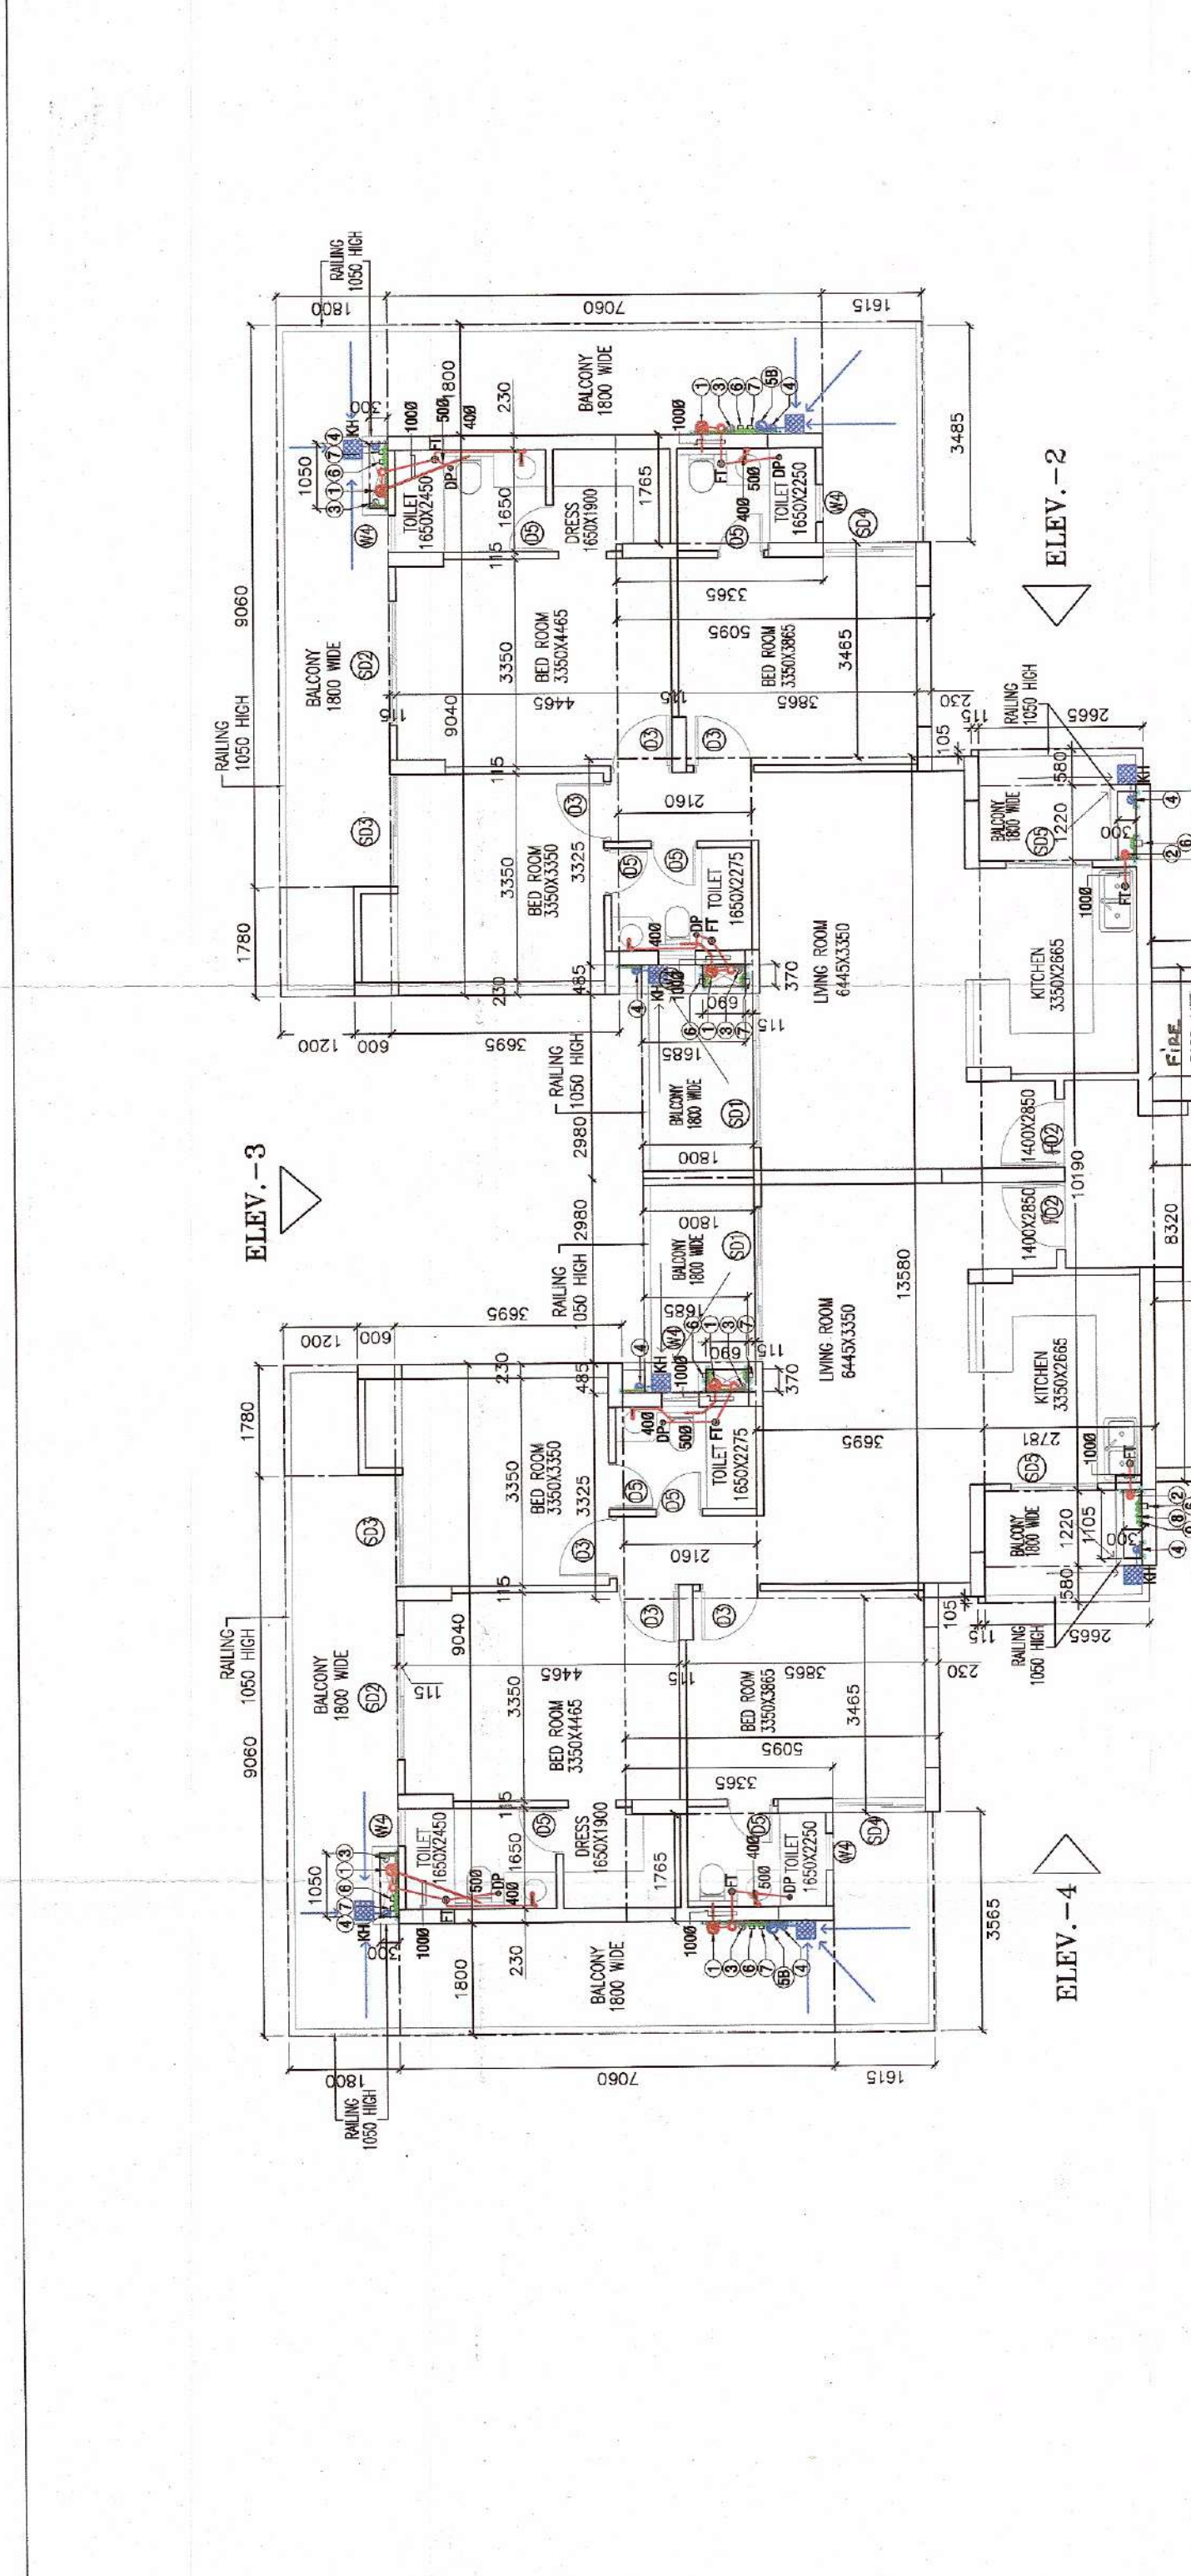


Architectural drawing of the rear elevation of a building, labeled "ELEV. -2" and "ELEV. -4". The drawing shows a complex structure with multiple levels, including a main floor and a lower level. Key features include a large central window, a smaller window to the left, and a series of steps or a ramp leading up to the entrance. The drawing is oriented vertically, with the building's front facing the viewer. Dimensions are provided for various sections, and the drawing is signed "J. J. J." in the bottom right corner.

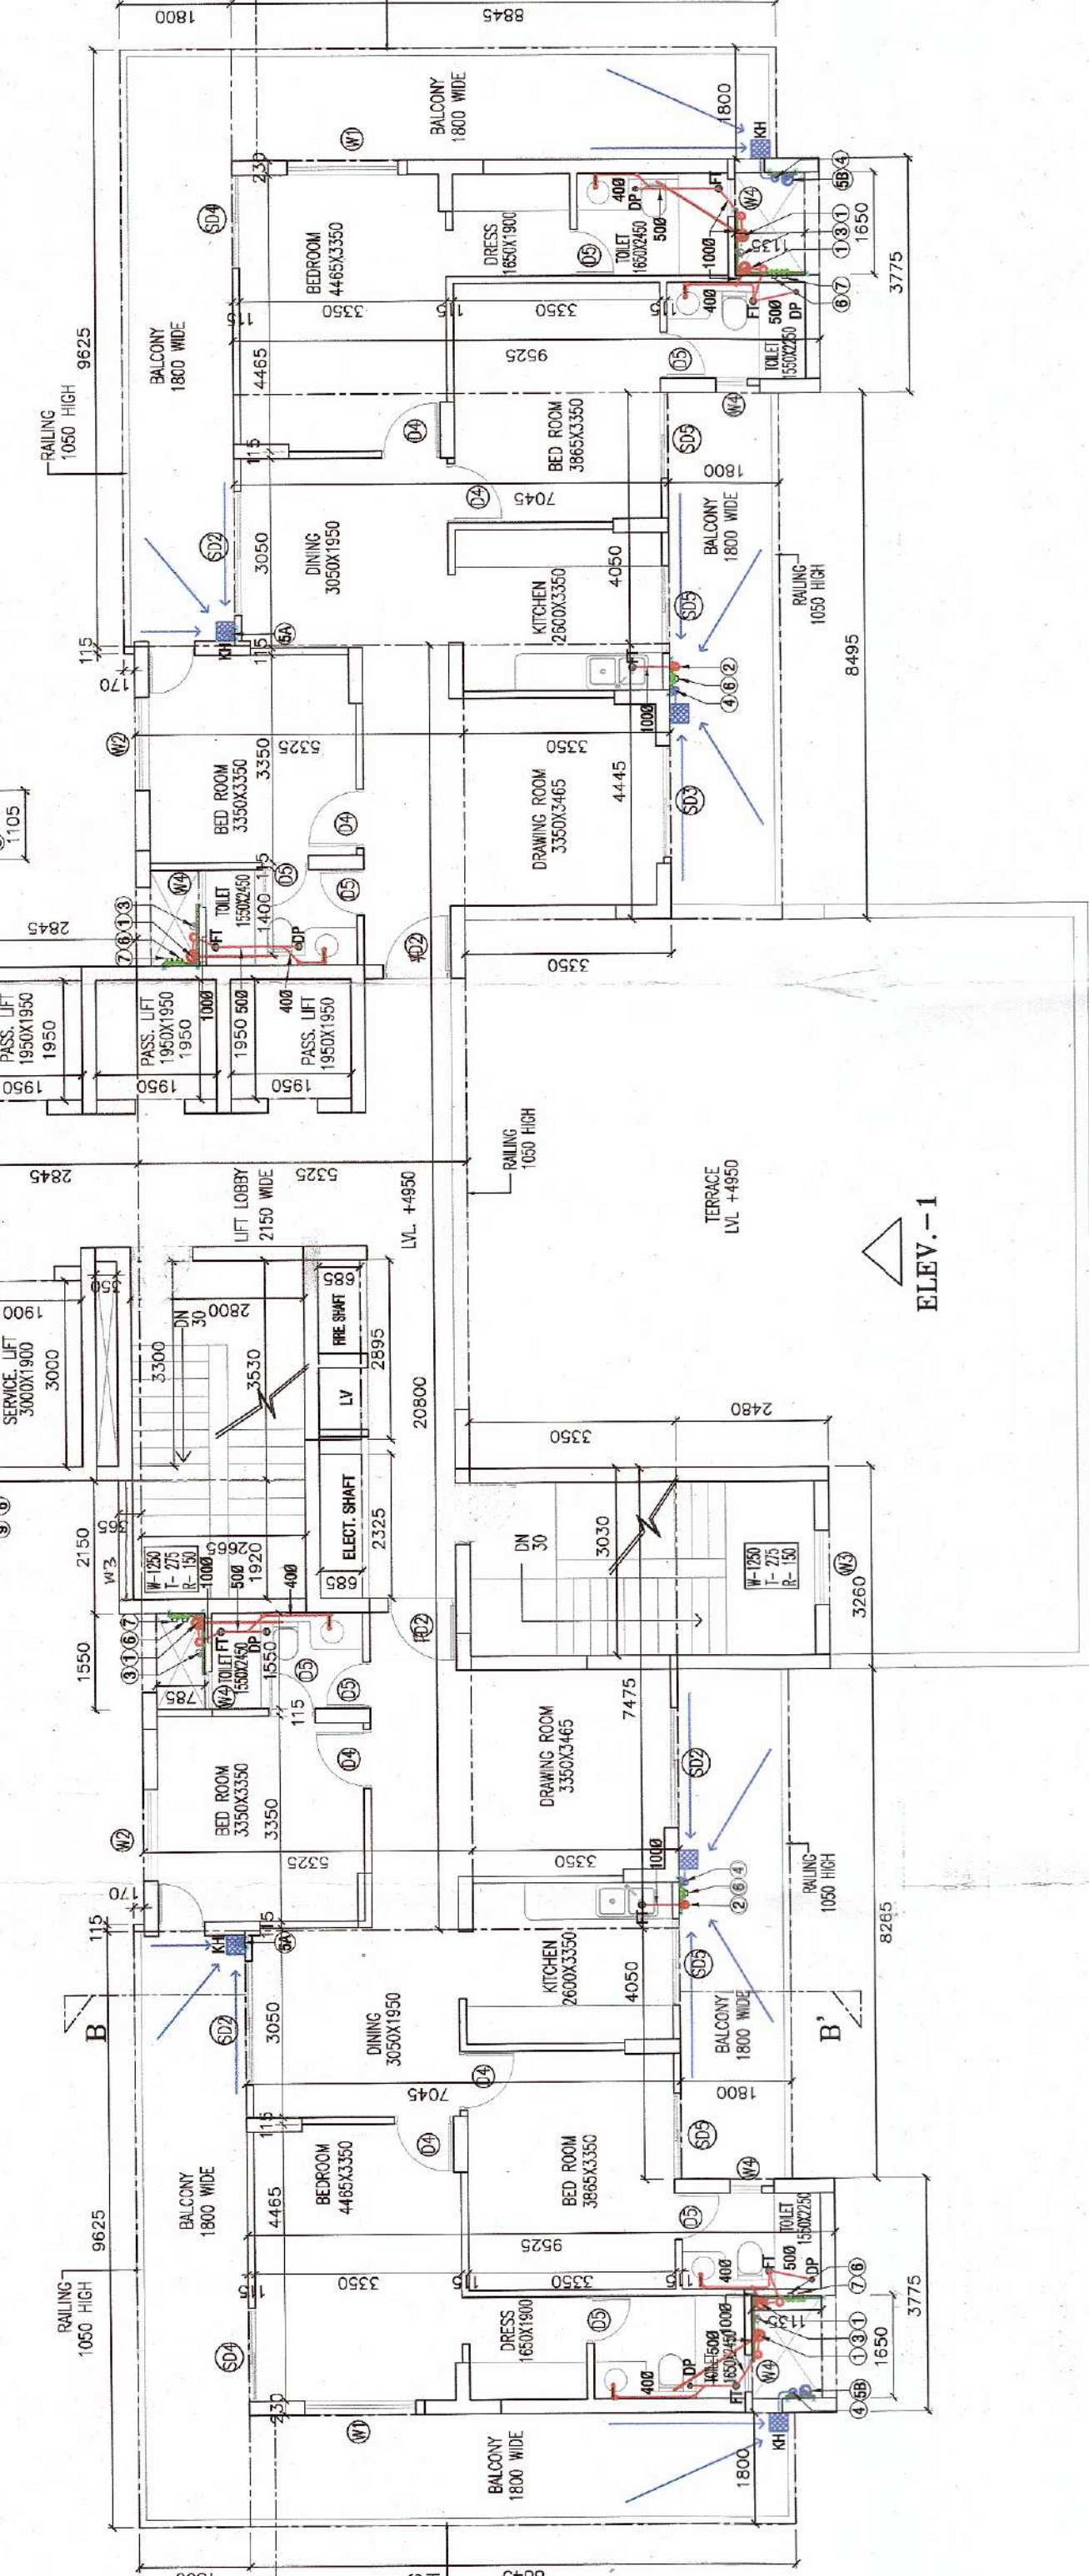


SCHEDULE OF OPENING

TYPE	SIZE	CILL	UNTEL
DW	4200x2425	-	2700
S01	2500x2450	75	2700
S02	2000x2450	75	2700
S03	1800x2450	75	2700
S04	1600x2450	75	2700
S05	1400x2450	75	2700
D1	1200x2100	-	2100
D2	1100x2100	-	2100
S3	1000x2100	-	2100
D4	900x2100	-	2100
D5	750x2100	-	2100
W1	1800x1050	1200	2700
W2	1500x1050	1200	2700
W3	1200x1050	1200	2700
W4	600x1200	1200	2400
W5	1000x1200	-	2400

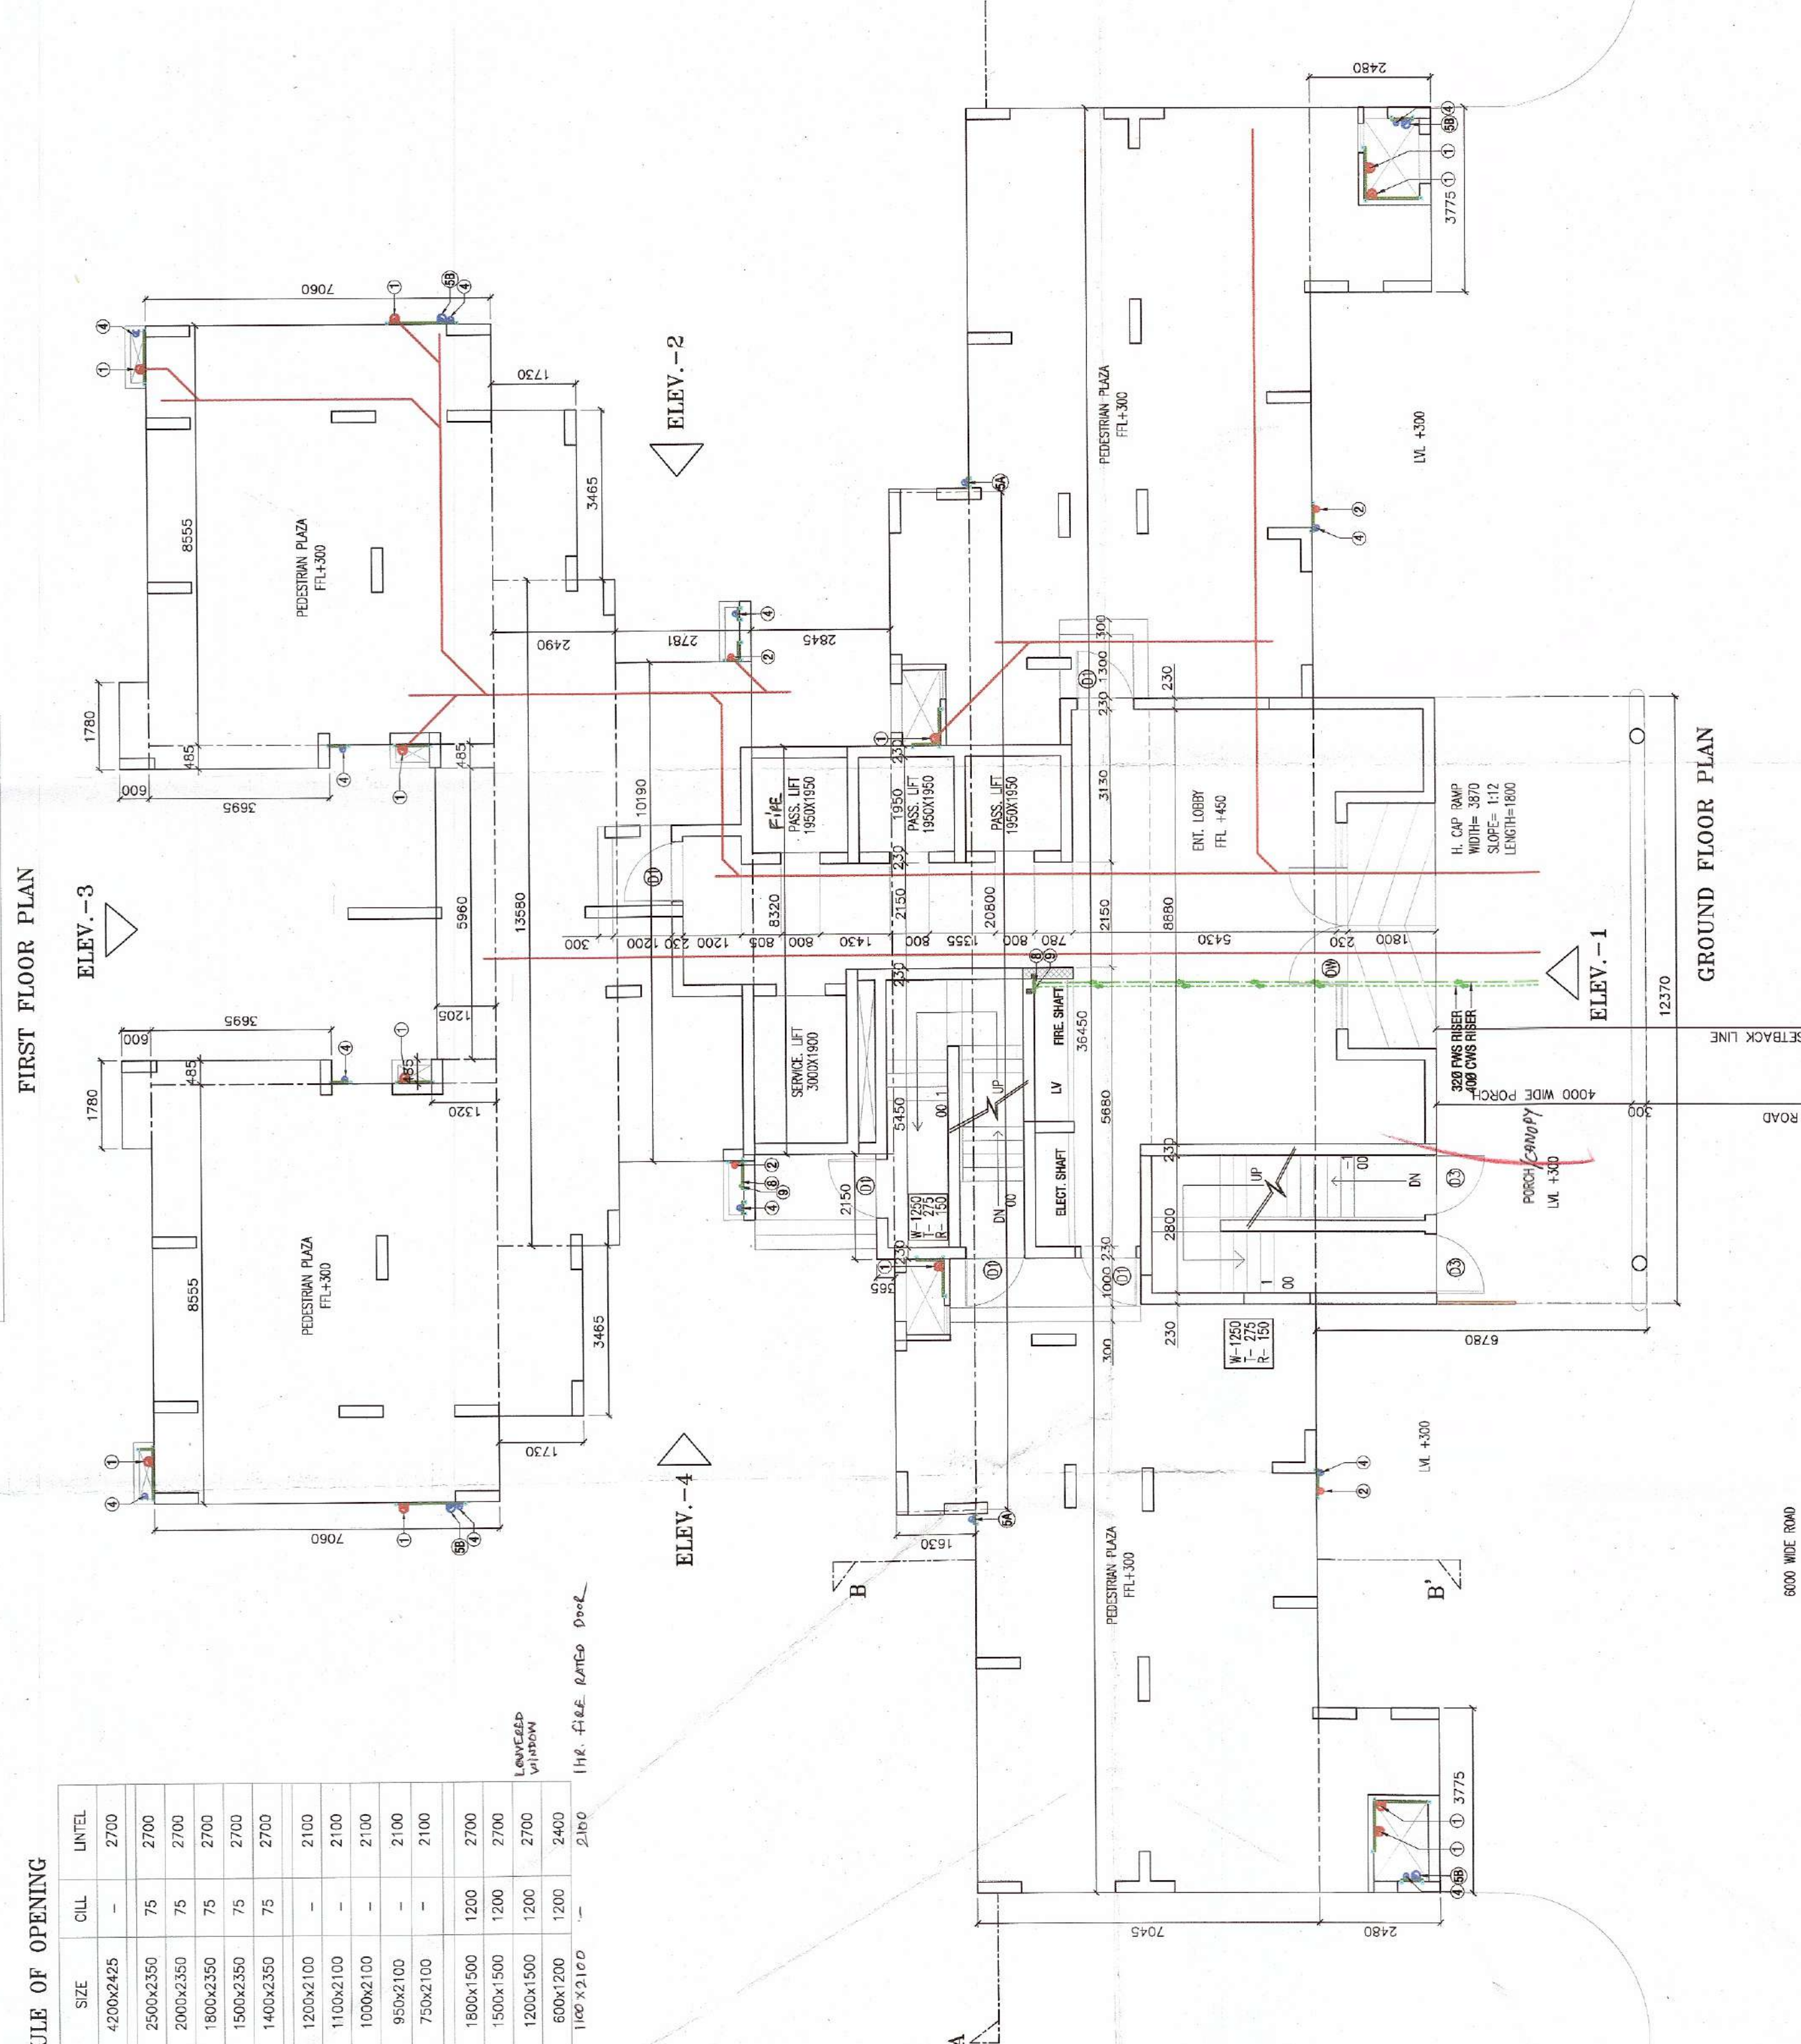

GROUND COVER AREA CALCULATION					REMARK
OWNER, T1 & T2	Sr. No.	LENGTH	WIDTH		
G/C1	1	1.80	0.00		2.136
G/C2	2	8.55	7.00		120.15
G/C3	3	1.80	0.00		2.136
G/C4	4	8.45	1.30		1.260
G/C5	5	3.45	1.70		11.685
G/C6	6	5.90	1.20		7.162
G/C7	7	13.90	2.40		33.816
G/C8	8	10.18	2.65		26.979
G/C9	9	2.15	0.35		0.753
G/C10	1	21.50	0.35		7.525
G/C11	1	20.80	1.50		33.940
G/C12	1	38.45	7.45		265.769
G/C13	2	3.75	2.85		18.720
G/C14	1	72.30	6.70		60.505
TOTAL					626.882

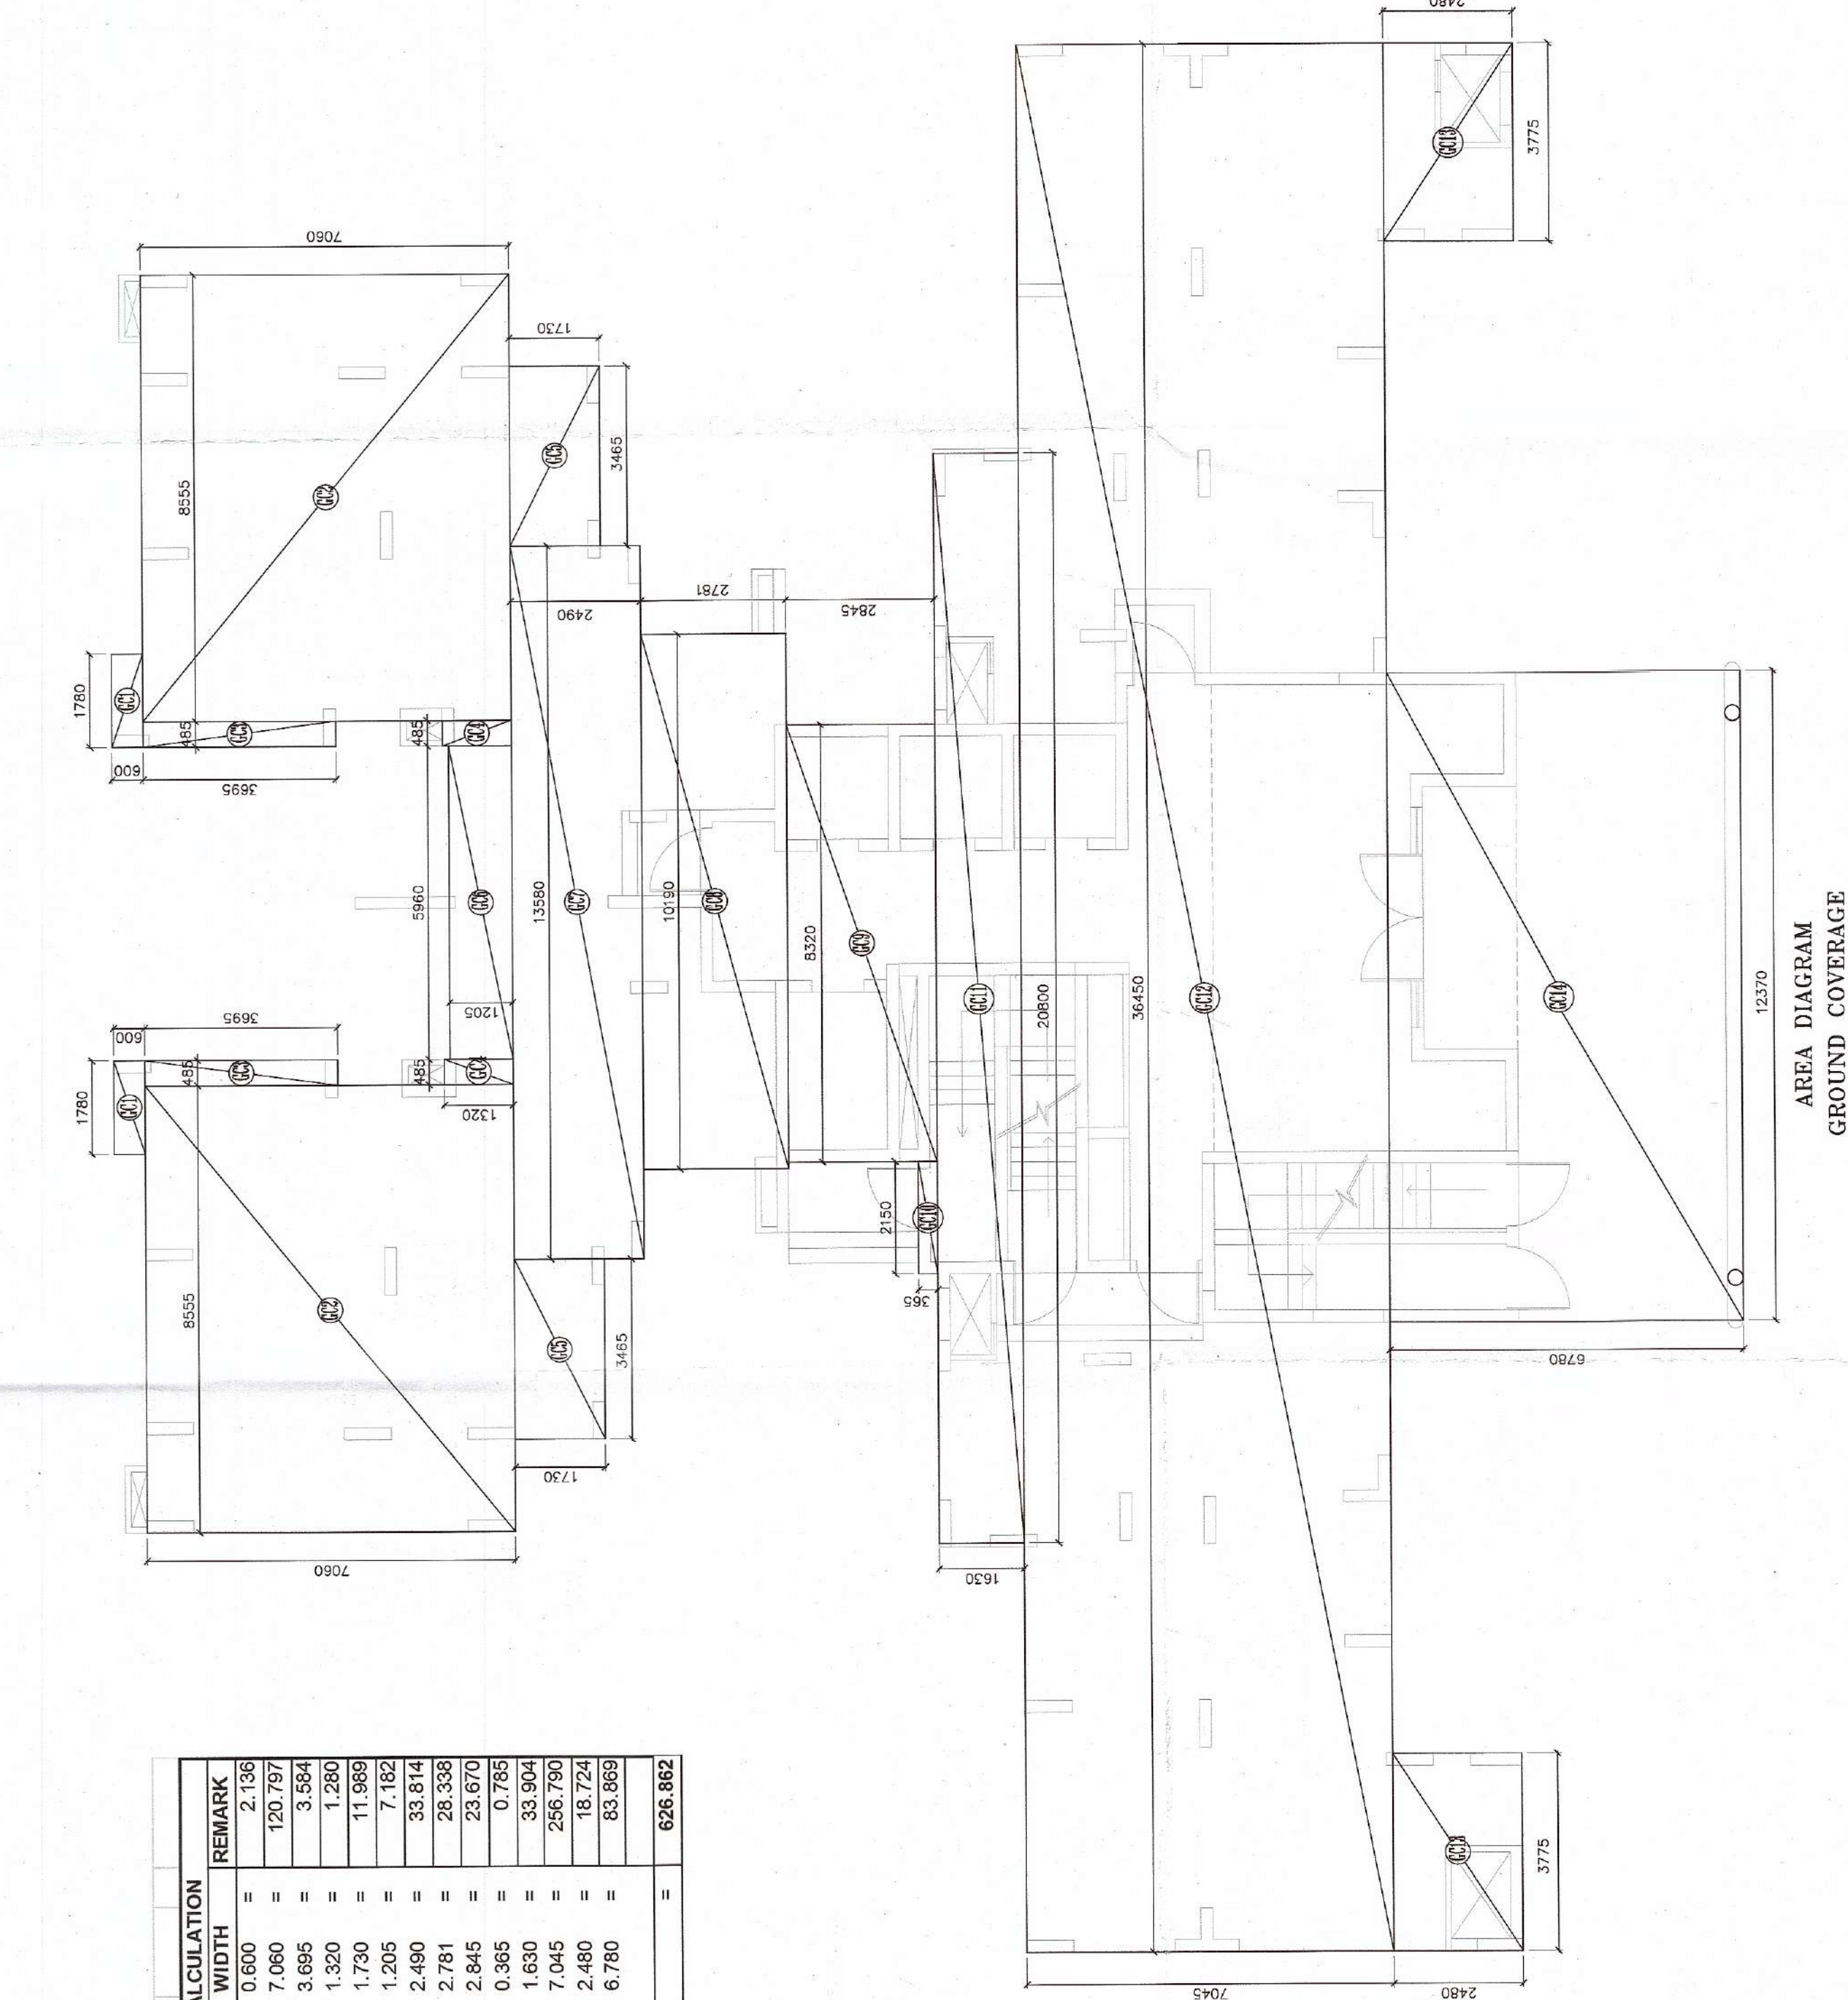

RAIN WATER PIPES DETAILS -TOWER-T1 & T2

TOWER NOS.	NOS. OF TOTAL NOS. OF STOREY	TERRACE AREA TOWER ONE TOWER	REQUIRED NO. OF PIPES @ 45 SQ.M FOR 100D PIPE	PROVIDED TOTAL NOS. OF RAIN WATER PIPE (100MM DIA)	SIZE OF RAIN WATER PIPE (MM DIA)	REQUIRED NO. OF PIPES @ 15 SQ.M FOR 100D PIPE	PROVIDED TOTAL NOS. OF RAIN WATER PIPE (150MM DIA)	SIZE OF RAIN WATER PIPE (MM DIA)
BLOCK-1	S+26	2	457 ONE TOWER	2 ONE TOWER	100 ONE LOWER	4 ONE LOWER	4 ONE LOWER	150 ONE LOWER

LEGEND	DESCRIPTION	LEGEND
6-10	SOIL, WASTE AND VENT PIPE	6-10
6-2	WASTE AND VENT PIPE	6-2
6-3	NON WATER PIPE FOR RAINWATER	6-3
6-4	NON WATER PIPE	6-4
6-5	NON WATER PIPE FOR RAINWATER	6-5
6-6	COLD WATER SUPPLY PIPE FROM O.H.T.	6-6
6-7	FLUSHING WATER SUPPLY, 2000 FROM O.H.T.	6-7
6-8	COLD WATER SUPPLY, 1000 TO O.H.T.	6-8
6-9	FLUSHING WATER SUPPLY, 1000 TO O.H.T.	6-9
6T	FLOOR TRAP	6T
6P	DRAIN POINT	6P
6PH	KUBERKA (000000MM)	6PH
6P+	SOIL PIPE	6P+
6P+	WASTE PIPE	6P+
6P+	COLD WATER SUPPLY	6P+
6P+	HOT WATER SUPPLY	6P+
6P+	FLUSHING WATER SUPPLY	6P+
6P+	WASTEWATER SUPPLY	6P+
6P+	WASTEWATER VALVE	6P+
6P+	MANHOLE (000000MM)	6P+
6P+	RAIN WATER COLLECTION CHAMBER	6P+

SCHEDULE OF PIPES		
TAG NO.	DESCRIPTION	DIA (mm)
1	SOIL WASTE & VENT PIPE	150
2	WASTE & VENT PIPE	100
3	VENT PIPE	100

	A	B
4	RAIN WATER PIPE FOR BALCONY	100
5	RAIN WATER PIPE FOR TERRACE	100 150
6	CWS DROP FROM OHT	*
7	FWS DROP FROM OHT	*
8	COLD WATER RISER TO OHT	*

9	FLUSHING WATER KISER TO OHT	*
---	-----------------------------	---

*AS PER WATER SUPPLY DISTRIBUTION DIAGRAM

City of Public Health
only subject to comments in
No. 25817 Dtd 13/02/2024

Dr. S.T.R. (G)
S.T.R. (AG)
Member Secretary
B.P.A.C.

 Consulting Engineer (Hq)  Designer (Hq)  Architect  ATP

OFFICE	CLIENT'S SIGN	For ADORE PROPRIETARY
--------	---------------	-----------------------

DUL (City)
 Member
 BPAC

APPROVAL OF BUILDING PLANS OF GROUP HOUSE
 AREA MEASURING 9.2453 ACRES (LICENSE NO.
 DATED 19-12-2023) IN SECTOR-77, GURGA
 DEVELOPED BY ADORE PROPART LLP.

	BUILDING NO.	TOWER T1 & T2	SHEET TITLE
--	--------------	---------------	-------------

DEALT S.K.	SCALE 1:100	DATE	ARCHITECT SAHA & ASSOCIATES
CHECKED B.K.			

CALL & ASSOCIATES
ARCHITECTS, PLANNERS & INT. DESIGN
D-22, PAMPOSH ENCLAVE, (I.G.F.)
NEW DELHI-110048
TEL. 26285532, 26461121. FAX. 011 91 26
email:- bhupsaha@gmail.com