


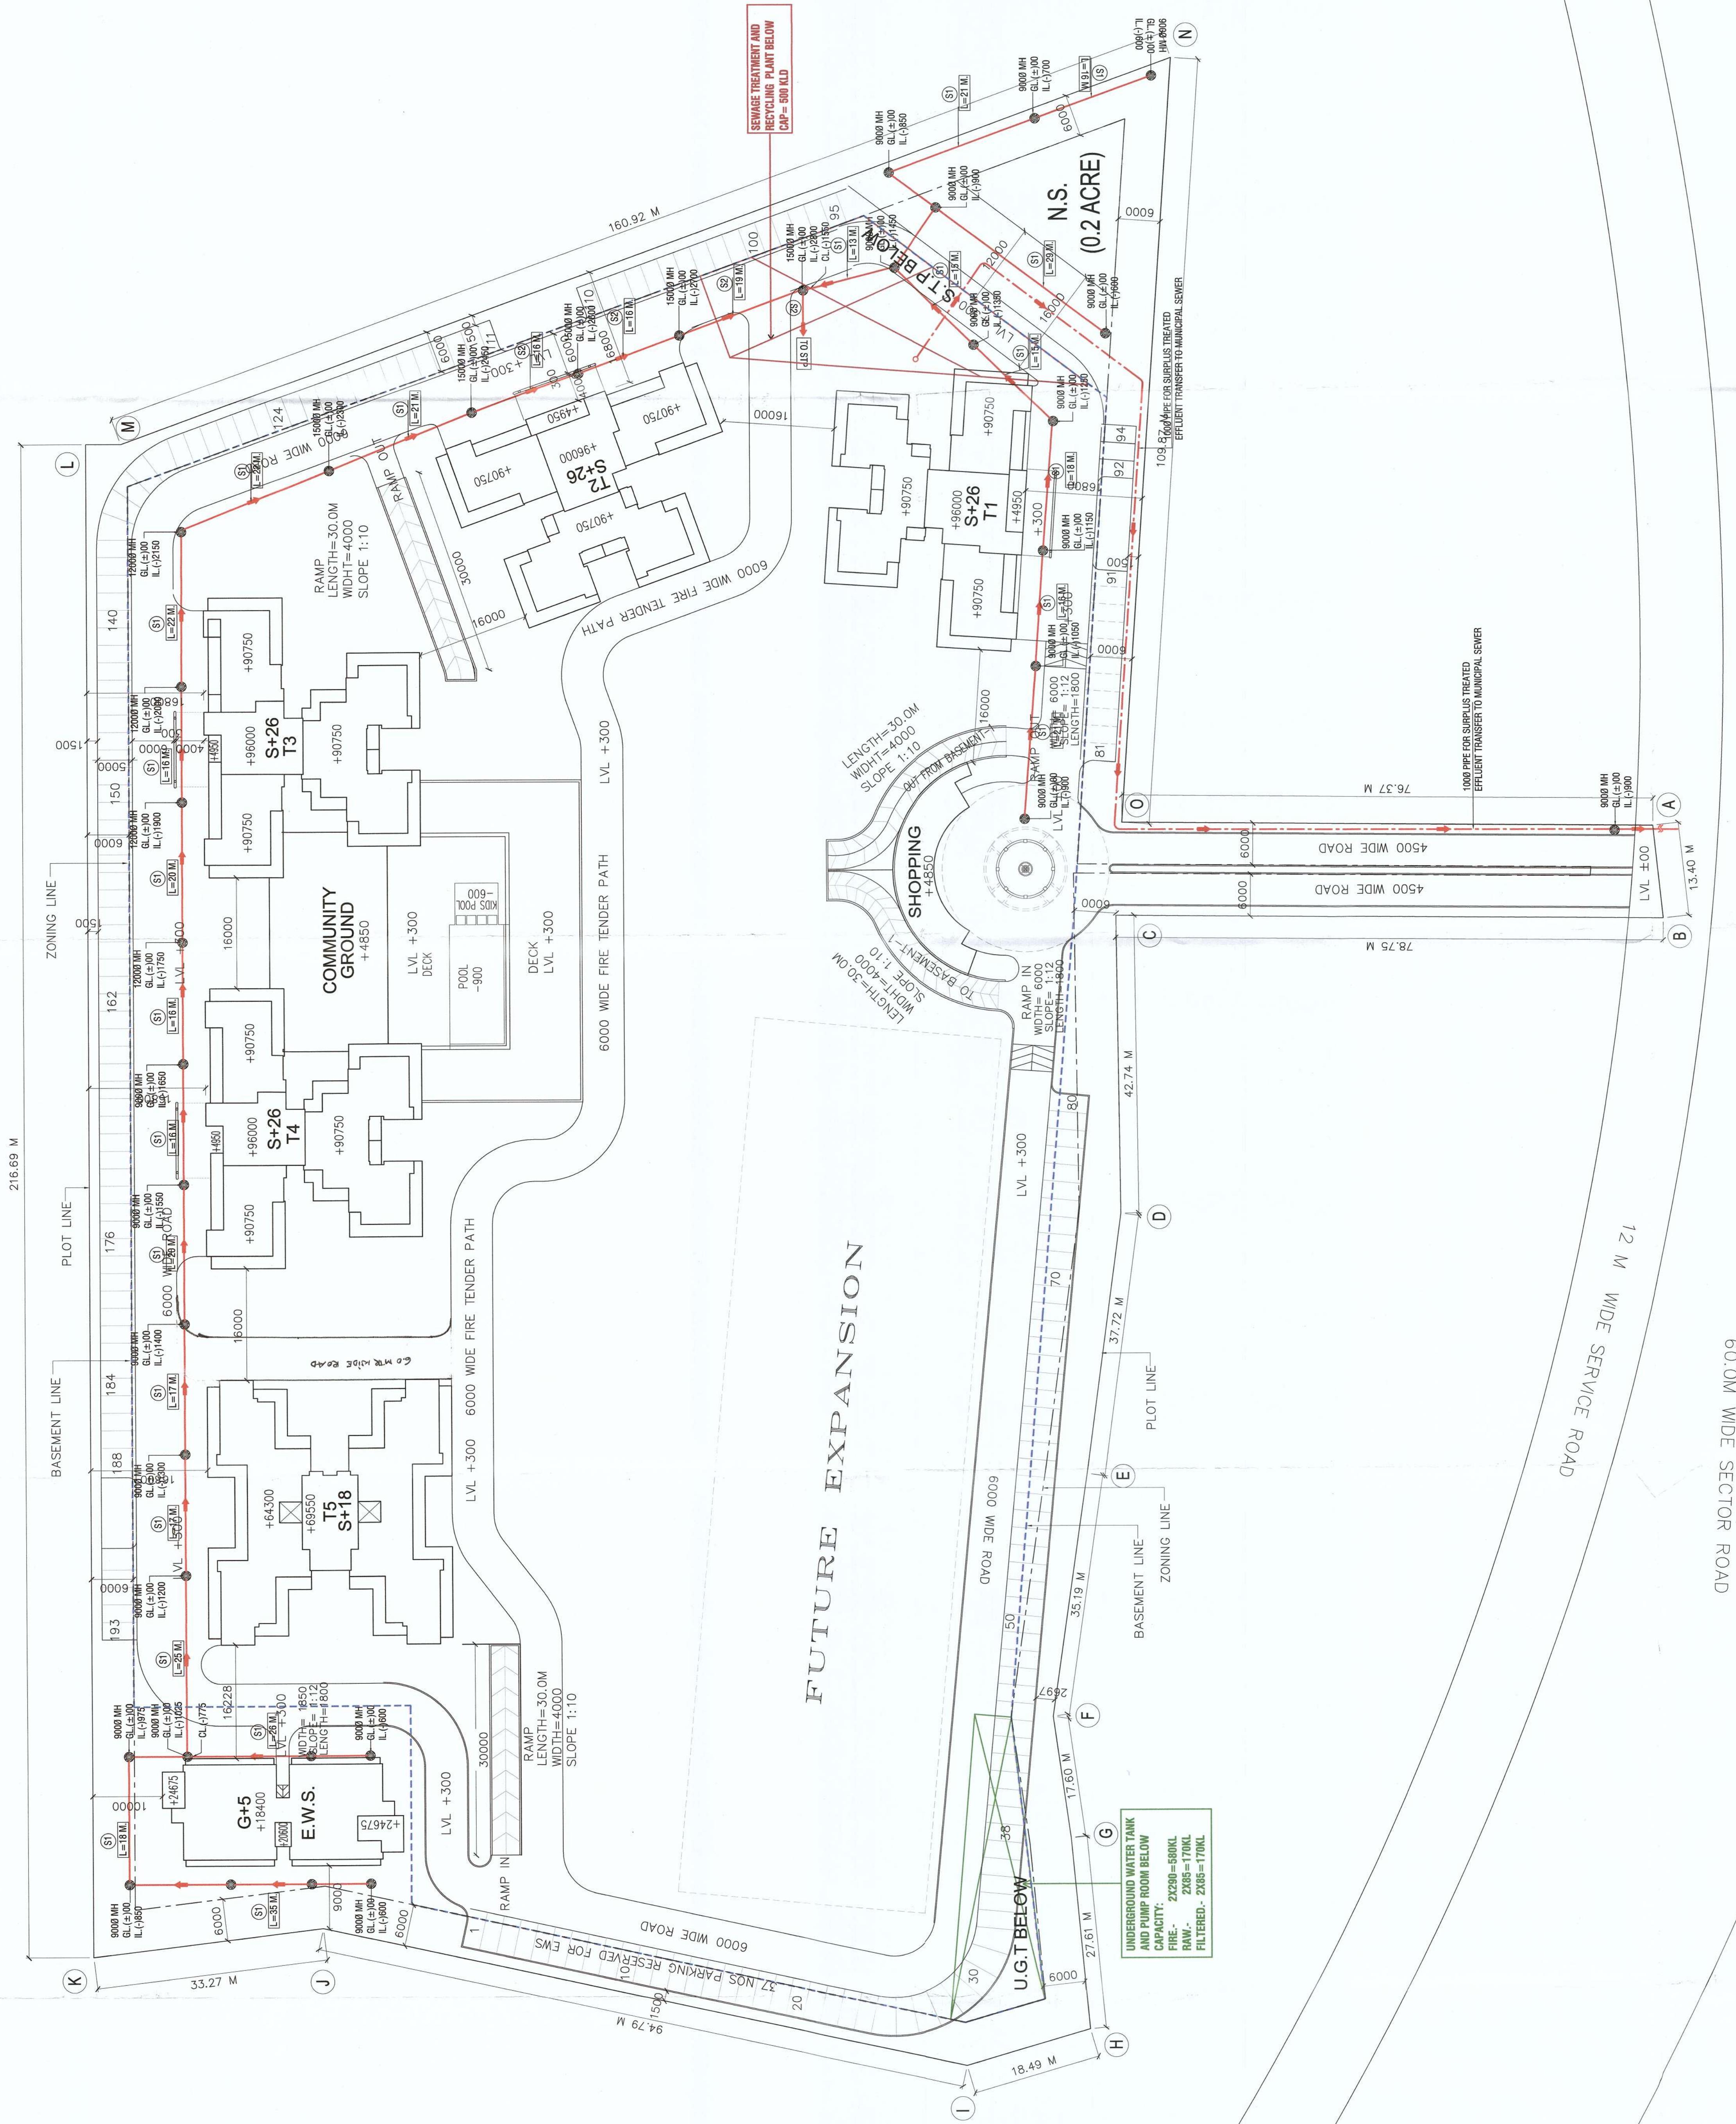

SEWER LINE - EXTERNAL		
MANHOLE (CIRCULAR)		MH
GROUND LEVEL		GL
INVERT LEVEL		IL
CONNECTION LEVEL		CL

IMPORTANT NOTES

- 1- THIS DRAWING SHALL BE COORDINATED WITH ARCHITECTURAL AND LANDSCAPE DRAWINGS.
- 2- THE FEASIBILITY OF MAKING CONNECTION OF THE SEWERAGE AND STORM DRAIN LINE AT OUTFALL SHALL BE ASCERTAINED BEFORE STARTING THE WORK.

1. ALL PIPE DIAMETERS ARE IN MM.
2. ALL WORKS ARE TO BE CARRIED OUT AS PER SPECIFICATIONS.
3. GROUND LEVELS AS PER MENTIONED ARE TENTATIVE. THESE SHALL MATCH WITH FORMATION LEVELS AS GIVEN BY ARCHITECTS.
4. FIGURE SHOWN **THIS 18M**, ARE DISTANCES BETWEEN MANHOLES (CENTRE TO CENTRE). THESE DISTANCES ARE INDICATIVE AND SHALL BE ADJUSTED AS PER ACTUAL SITE CONDITION.
5. MANHOLES SHALL THICKEN DEEPEN SUPPORT AND ROAD GULLY SHALL BE CONSTRUCTED AS PER STANDARD DETAILS.
6. STORM WATER DRAINAGE SYSTEMS SHALL BE CONSTRUCTED AS PER STANDARD DETAILS.
7. WHEREVER DRAIN CROSSES A ROAD OR SECTION, IT SHALL BE COVERED WITH PRECAST SLAB, DESIGNED TO TAKE VEHICULAR LOAD AT THAT POINT.

ARCHITECT, S SIGN

**BHUPENDRA KUMAR
ARCHITECT
CA/2004/33978**

CLIENT'S SIGN

PROPMART LLP
Authorized Signatory

PROPOSED GROUP HOUSING COLONY FOR AN AREA MEASURING 9.2453 ACRES (LICENSE NO. 264 OF 2023 DATED 19-12-2023) IN SECTOR-77, GURUGRAM MANESAR URBAN COMPLEX BEING DEVELOPED BY SH. RAM AVTAR S/O SH. DHARMO AND OTHERS IN COLLABORATION WITH ADORE PROPWART LLP.

BUILDING NO.

DEL (HQ)
Member
BPAC

SEWERAGE LAYOUT SITE PLAN

SHEET TITLE

SEWERAGE I AVOIT

DEBIT

SCALE

S.K.

CHECKED

B.K.

ARCHITECT

SAHA

ARCHITECTS

D-22, PAN

NEW DELHI-
TELE 0000505

TEL: 202039.
email:- bhur