


| LEGEND FOR PLUMBING                                                               |                                |
|-----------------------------------------------------------------------------------|--------------------------------|
|  | 100Ø SOIL & VENT PIPE          |
|  | 100Ø WASTE & VENT PIPE         |
|  | 100Ø KITCHEN WASTE & VENT PIPE |
|  | 90 OD VENT PIPE                |
|  | 160 OD uPVC RAIN WATER PIPE    |
|  | 110 OD uPVC RAIN WATER PIPE    |
|  | 80Ø SUMP DRAIN PIPE            |

| LEGEND                                                                                 |                                   |
|----------------------------------------------------------------------------------------|-----------------------------------|
| SYMBOL                                                                                 | DESECRATION                       |
|  M    | MUNICIPAL SUPPLY LINE             |
|  TF   | TANKER FILLING LINE               |
|  FWR  | FLU. WATER RISER FOR TERRACE TANK |
|  DWVR | DOM. WATER RISER FOR TERRACE TANK |
|  FWS  | FLU. WATER SUPPLY LINE            |
|  DWS  | DOM. WATER SUPPLY LINE            |
|       | CONTROL VALVE                     |
|       | NON RETURN VALVE                  |
|       | STRAINER                          |
| WM                                                                                     | WATER METER                       |
| MV                                                                                     | MOTORIZED VALVE                   |
| PV                                                                                     | PRESSURE VESSEL                   |
| WM    | WATER METER                       |
| OF    | OVER FLOW PIPE                    |

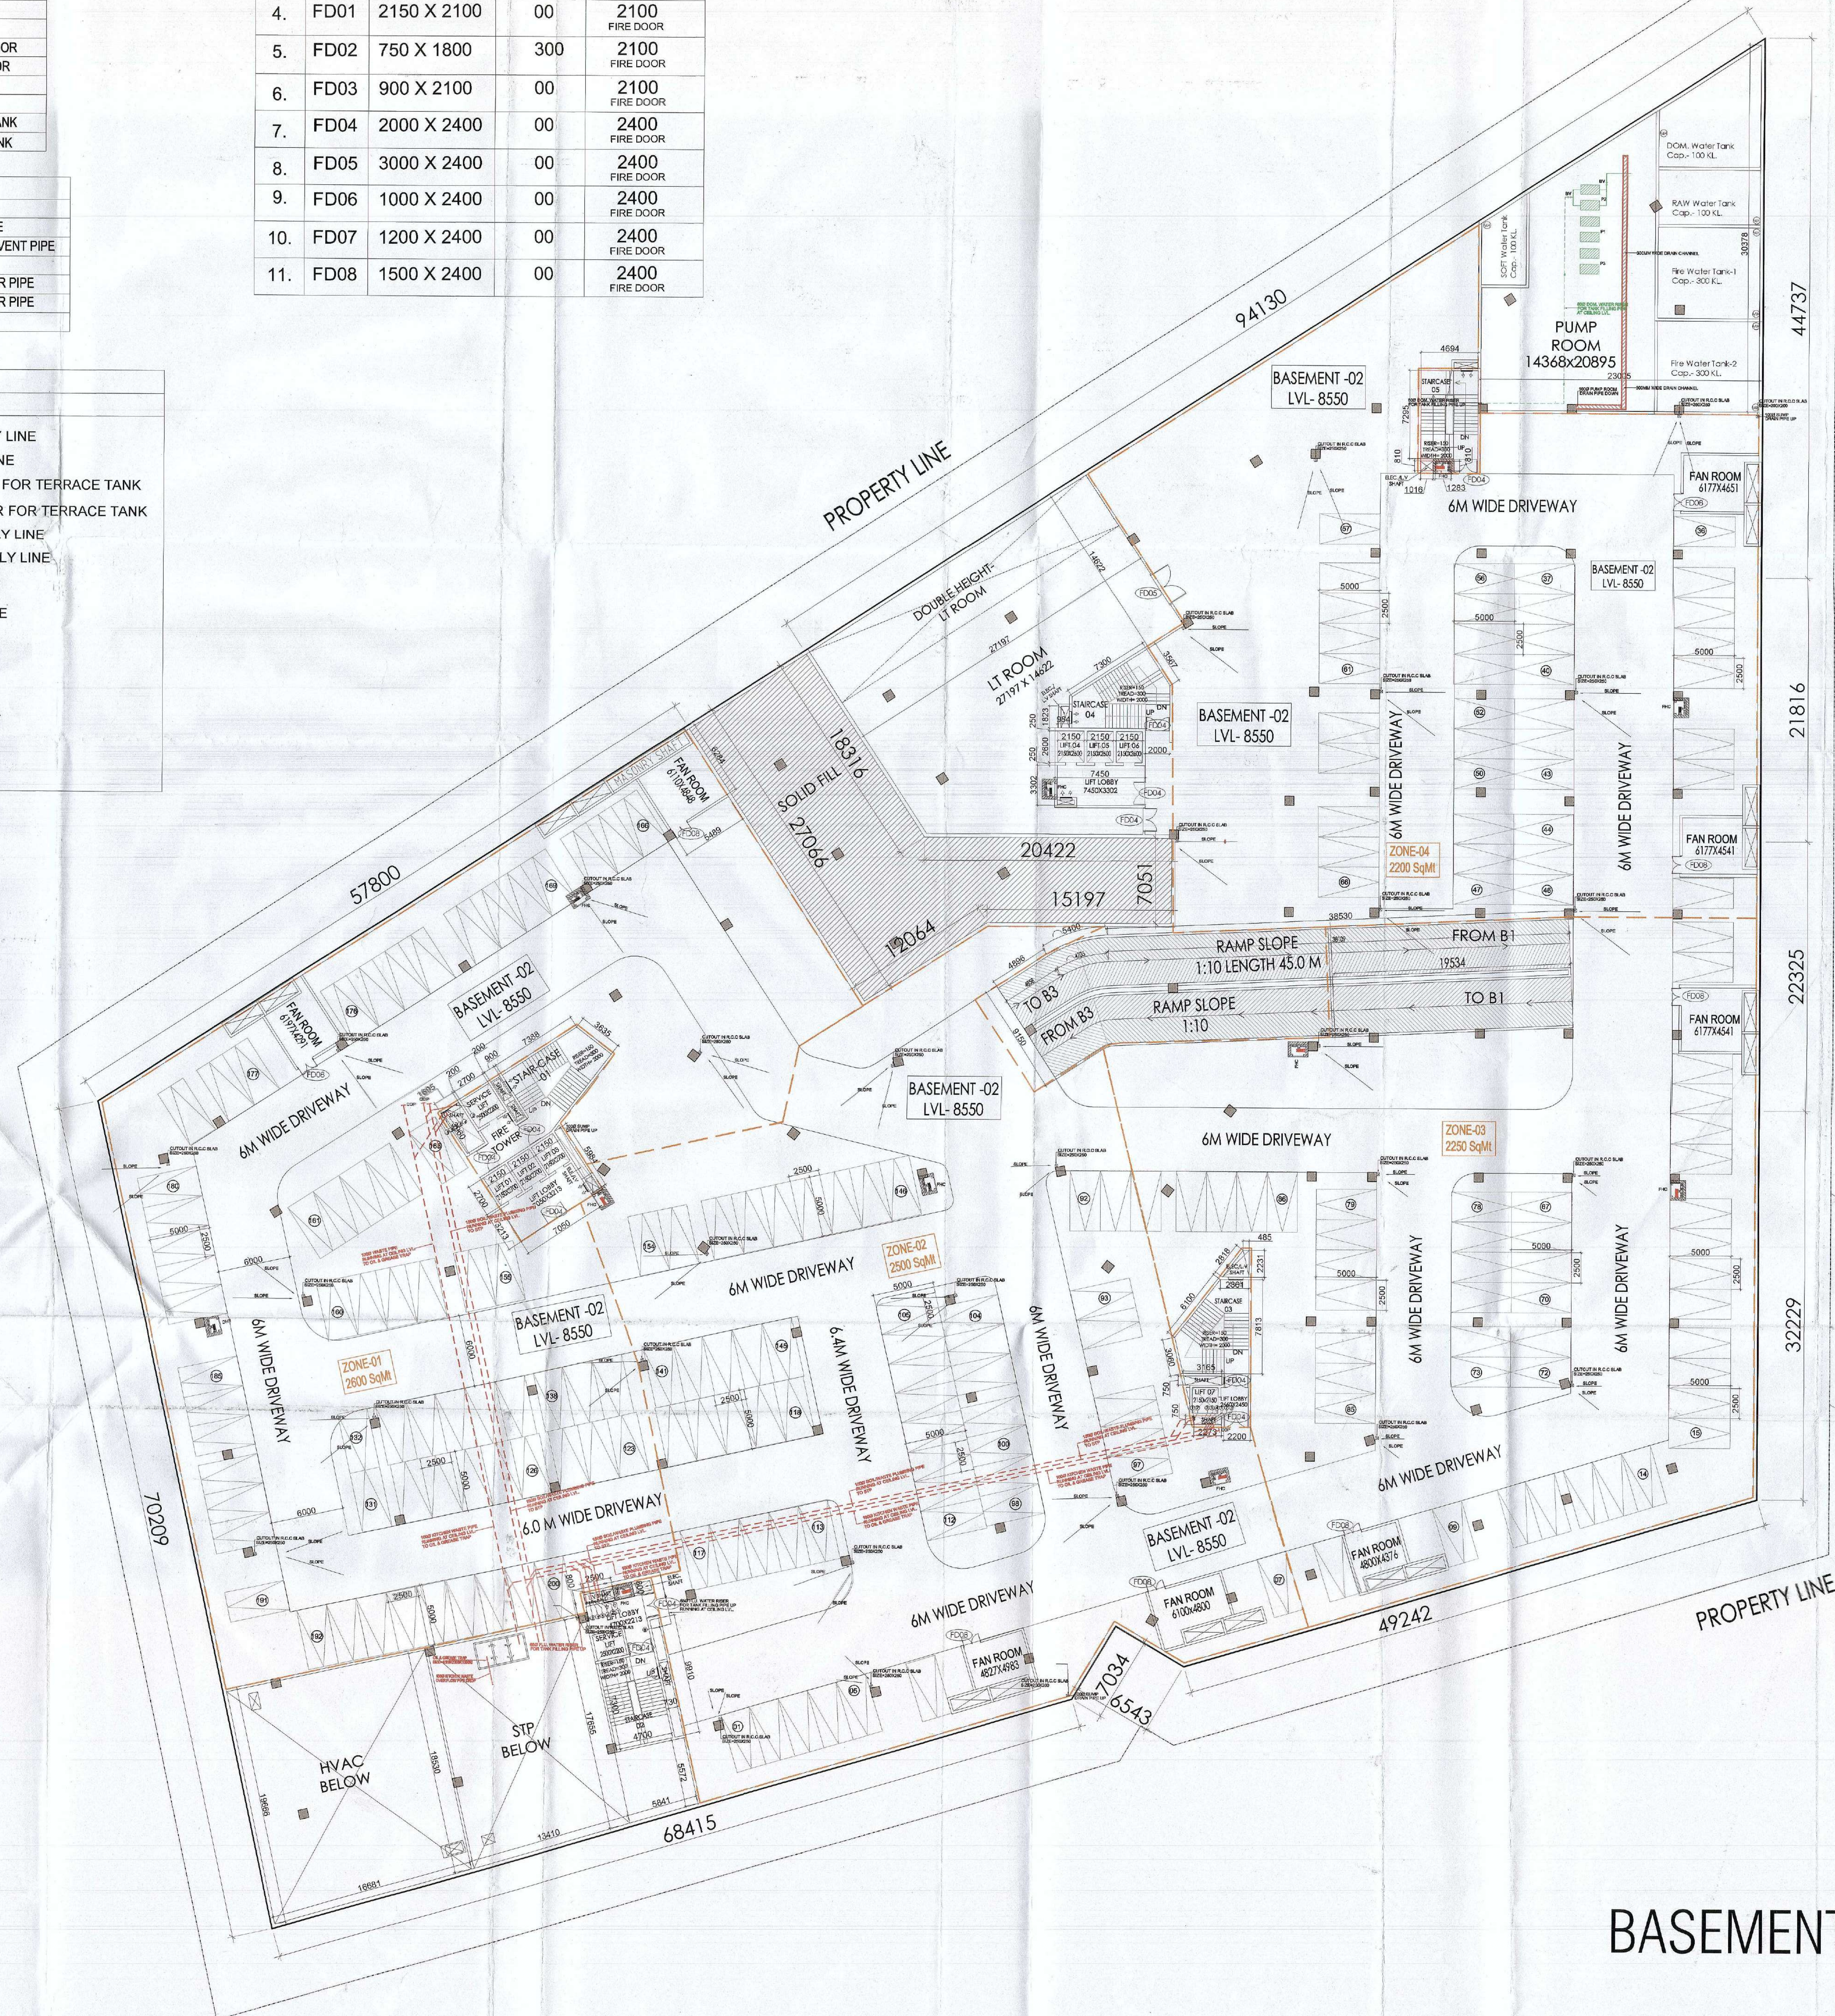

BASEMENT 02

AD ~~Y/PA~~ ATP

**SANCTIONED**  
**TO BE READ WITH THIS OFFICE**  
**MEMO NO.:**  
**DATED:**

DDT (H)  
Member  
R

Checked and found ok for Public Health  
(Internal) Service only subject to comments in  
in forwarding letter No. ....DV.....

  
Superintending Engineer (HQ)  
for Chief Engineer-I  
HSVP, Panchkula



**NOTES:**

1. ALL DIMENSIONS ARE IN MM
2. GATE AND BOUNDARY WALL SHALL BE AS PER STANDARD DESIGN.
3. SPRINKLERS WILL BE PROVIDED IN ENTIRE BUILDING INCLUDING BASEMENTS AS PER N.B.C.
4. RAIN WATER HARVESTING SYSTEM WILL BE PROVIDED AS PER APPLICABLE NORMS.
5. 100% POWER BACK UP WILL BE PROVIDED FOR LIFTS & ESSENTIAL SERVICE AREAS.
6. DISABLED RAMP @ 1:12 SLOPE WITH 900MM HIGH RAILING.
7. ALL BUILDINGS ARE MECHANICALLY VENTILATED
8. BUILDINGS WILL BE DESIGNED (STRUCTURES) AS PER RELEVANT IS CODES FOR EARTHQUAKE RESISTANCE
9. FIRE TRAVEL DISTANCE NOT MORE THAN 45 METER

**PROJECT**

**PROPOSED BUILDING PLAN OF  
COMMERCIAL COLONY AREA  
MEASURING 3.99 ACRES (LICENCE NO  
119 DATED 05-06-2023) FALLING IN  
SECTOR-90, GURUGRAM BEING  
DEVELOPED BY NORTH STAR TOWERS  
PVT. LTD., MATRIX BUILDWELL PVT. LTD.,  
IN COLLABORATION WITH NORTH STAR  
APARTMENTS PVT. LTD. (NOW KNOWN  
AS SS GROUP PVT. LTD.)**

**ACPL**

ISO 9001:2015

**Architecture  
Management  
Planning**

**ACPL Design Ltd**

Unit 5, South Devon Way, St  
Bridges, Dorset DT1 1QD, UK

 
T: +44 (0) 1302 564444  
F: +44 (0) 1302 564444

|                           |       |                                                                                       |             |
|---------------------------|-------|---------------------------------------------------------------------------------------|-------------|
| DRAWING TITLE             | SCALE | NORTH-                                                                                | DRAWING NO. |
| BASEMENT-02<br>FLOOR PLAN | 1:200 |  | 03          |

For SS Group Pvt. Ltd.

  
Authorised Signatory





  
ARCHITECT'S SIGNATURE