


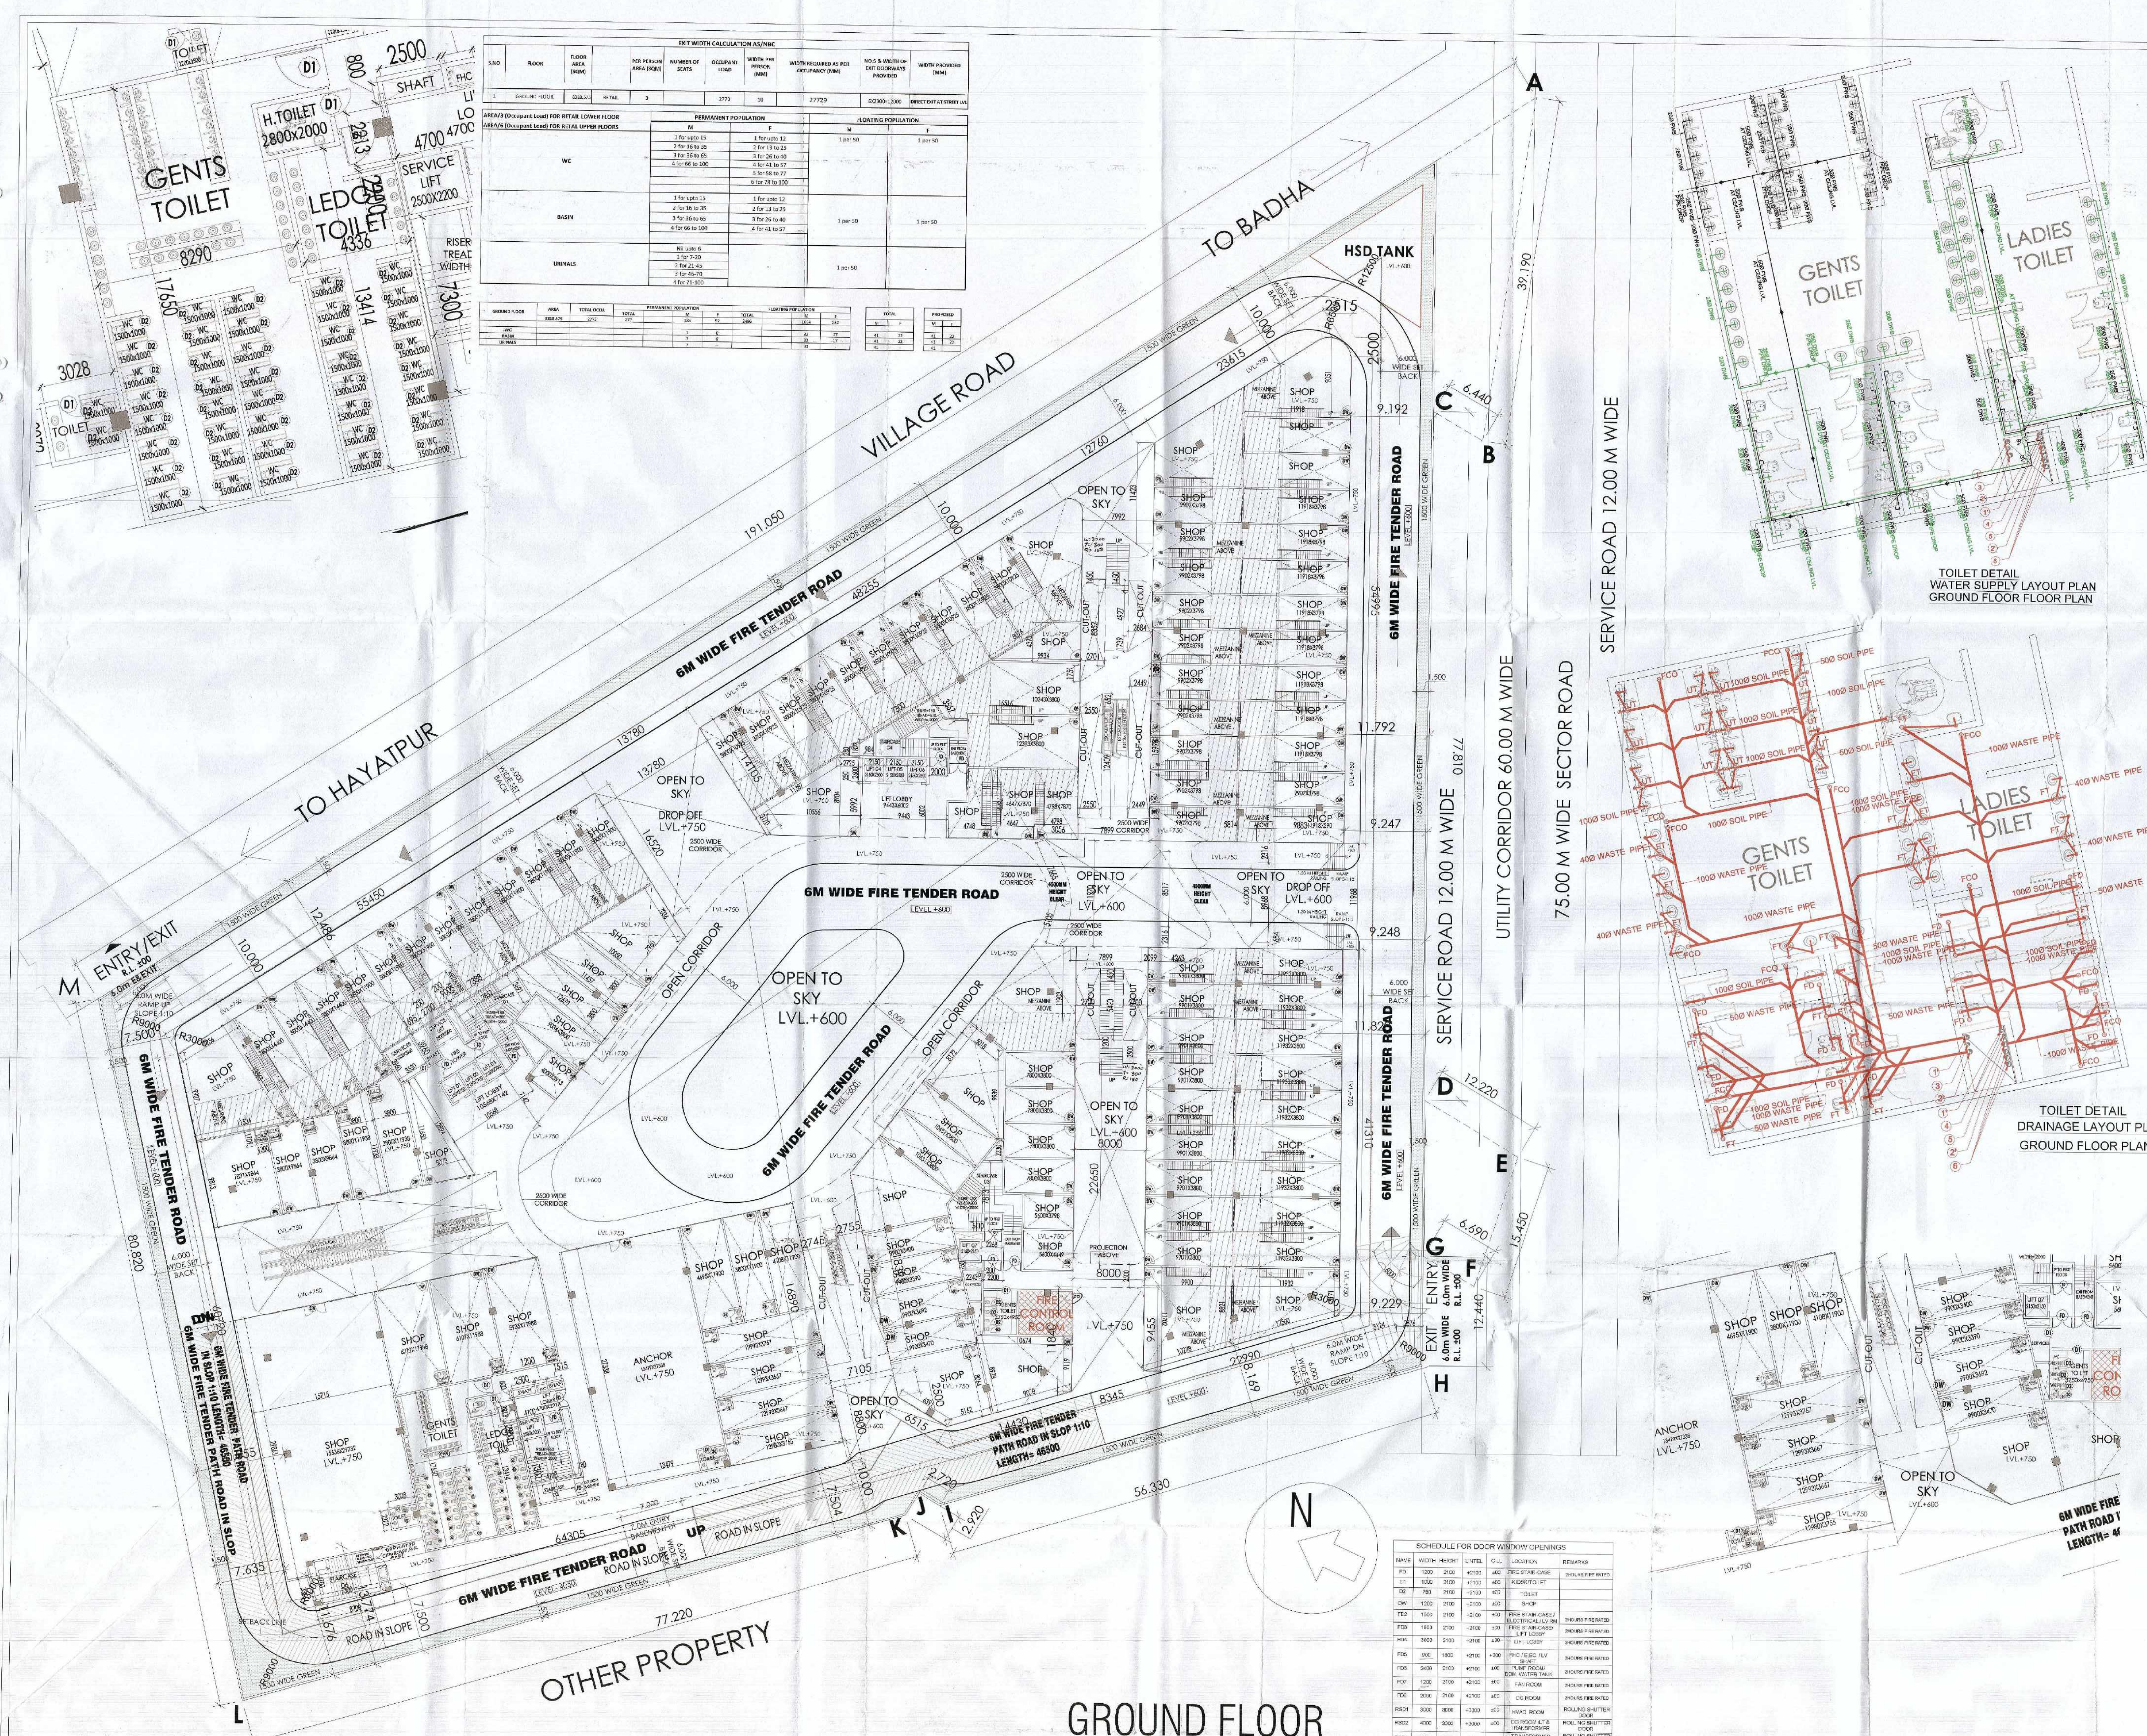

EXIT WIDTH CALCULATION AS PER NBC									
FLOOR	FLOOR AREA (SQM)	FLOOR AREA (SQT)	NUMBER OF PERSONS	NUMBER OF PERSONS	NUMBER OF PERSONS	NUMBER OF PERSONS	NUMBER OF PERSONS	NUMBER OF PERSONS	NUMBER OF PERSONS
1	10000	10764	1000	1000	1000	1000	1000	1000	1000
2	10000	10764	1000	1000	1000	1000	1000	1000	1000
3	10000	10764	1000	1000	1000	1000	1000	1000	1000
4	10000	10764	1000	1000	1000	1000	1000	1000	1000
5	10000	10764	1000	1000	1000	1000	1000	1000	1000
6	10000	10764	1000	1000	1000	1000	1000	1000	1000
7	10000	10764	1000	1000	1000	1000	1000	1000	1000
8	10000	10764	1000	1000	1000	1000	1000	1000	1000
9	10000	10764	1000	1000	1000	1000	1000	1000	1000
10	10000	10764	1000	1000	1000	1000	1000	1000	1000

LEGEND FOR PLUMBING	
1	1500 SOIL & VENT PIPE
2	1500 WASTE & VENT PIPE
3	1000 SOIL & VENT PIPE
4	1000 WASTE & VENT PIPE
5	800 SOIL & VENT PIPE
6	800 WASTE & VENT PIPE
7	1000 KITCHEN WASTE & VENT PIPE
8	DOM. WATER LINE TERRACE ALL FLOOR
9	FLU. WATER LINE TERRACE ALL FLOOR
10	180 OD UPVC RAIN WATER PIPE
11	110 OD UPVC RAIN WATER PIPE
12	DOM. WATER RISER FOR TERRACE TANK
13	FLU. WATER RISER FOR TERRACE TANK

LEGEND FOR PLUMBING	
1	1000 SOIL & VENT PIPE
2	1000 WASTE & VENT PIPE
3	1000 KITCHEN WASTE & VENT PIPE
4	800 SOIL & VENT PIPE
5	800 WASTE & VENT PIPE
6	180 OD UPVC RAIN WATER PIPE
7	110 OD UPVC RAIN WATER PIPE
8	800 SUMP DRAIN PIPE

LEGEND	
SYMBOL	DESCRIPTION
M	MUNICIPAL SUPPLY LINE
TF	TANKER FILLING LINE
FWR	FLU. WATER RISER FOR TERRACE TANK
DWR	DOM. WATER RISER FOR TERRACE TANK
FWS	FLU. WATER SUPPLY LINE
DWS	DOM. WATER SUPPLY LINE
CV	CONTROL VALVE
NRV	NON RETURN VALVE
STR	STRAINER
WM	WATER METER
MV	MOTORIZED VALVE
PV	PRESSURE VESSEL
WM	WATER METER
OF	OVER FLOW PIPE

- NOTES:
1. ALL DIMENSIONS ARE IN MM.
 2. GATE AND BOUNDARY WALL SHALL BE AS PER STANDARD DESIGN.
 3. SPRINKLERS WILL BE PROVIDED IN ENTIRE BUILDING INCLUDING BASEMENT'S AS PER NBC.
 4. RAIN WATER HARVESTING SYSTEM WILL BE PROVIDED AS PER APPLICABLE NOTICES.
 5. 100% POWER BACK UP WILL BE PROVIDED FOR LIFTS & ESSENTIAL SERVICE AREAS.
 6. DISABLED RAMP @ 1:12 SLOPE WITH 900MM HIGH RAILING.
 7. ALL BUILDINGS ARE MECHANICALLY VENTILATED.
 8. BUILDING WILL BE DESIGNED (STRUCTURES) AS PER RELEVANT IS CODES FOR EARTHQUAKE RESISTANCE.
 9. FIRE TRAVEL DISTANCE NOT MORE THAN 45 METER.

PROJECT

PROPOSED BUILDING PLAN OF COMMERCIAL COLONY AREA MEASURING 3.99 ACRES (LICENCE NO. 119 DATED 05-06-2023) FALLING IN SECTOR-90, GURUGRAM BEING DEVELOPED BY NORTH STAR TOWERS PVT. LTD., MATRIX BUILDWELL PVT. LTD., IN COLLABORATION WITH NORTH STAR APARTMENTS PVT. LTD. (NOW KNOWN AS SS GROUP PVT. LTD.)

ACPL Design Ltd

OWNER'S SIGNATURE

ARCHITECT'S SIGNATURE

PROJECT TITLE

SCALE

DRAWING NO.

GROUND FLOOR PLAN

1:200

05

FOR SS Group Pvt. Ltd.

Authorised Signatory

KULDEEP SHANGARI

ARCHITECT

C/97/21741

SCHEDULE FOR DOOR WINDOW OPENINGS									
NO.	WIDTH	HEIGHT	UNIT	CLL	LOCATION	REMARKS	NO.	WIDTH	HEIGHT
01	1200	2100	4000	400	DOOR TO STAIR CASE	2 DOORS PER FLOOR	01	1200	2100
02	1200	2100	4000	400	DOOR TO STAIR CASE	2 DOORS PER FLOOR	02	1200	2100
03	1200	2100	4000	400	DOOR TO STAIR CASE	2 DOORS PER FLOOR	03	1200	2100
04	1200	2100	4000	400	DOOR TO STAIR CASE	2 DOORS PER FLOOR	04	1200	2100
05	1200	2100	4000	400	DOOR TO STAIR CASE	2 DOORS PER FLOOR	05	1200	2100
06	1200	2100	4000	400	DOOR TO STAIR CASE	2 DOORS PER FLOOR	06	1200	2100
07	1200	2100	4000	400	DOOR TO STAIR CASE	2 DOORS PER FLOOR	07	1200	2100
08	1200	2100	4000	400	DOOR TO STAIR CASE	2 DOORS PER FLOOR	08	1200	2100
09	1200	2100	4000	400	DOOR TO STAIR CASE	2 DOORS PER FLOOR	09	1200	2100
10	1200	2100	4000	400	DOOR TO STAIR CASE	2 DOORS PER FLOOR	10	1200	2100