
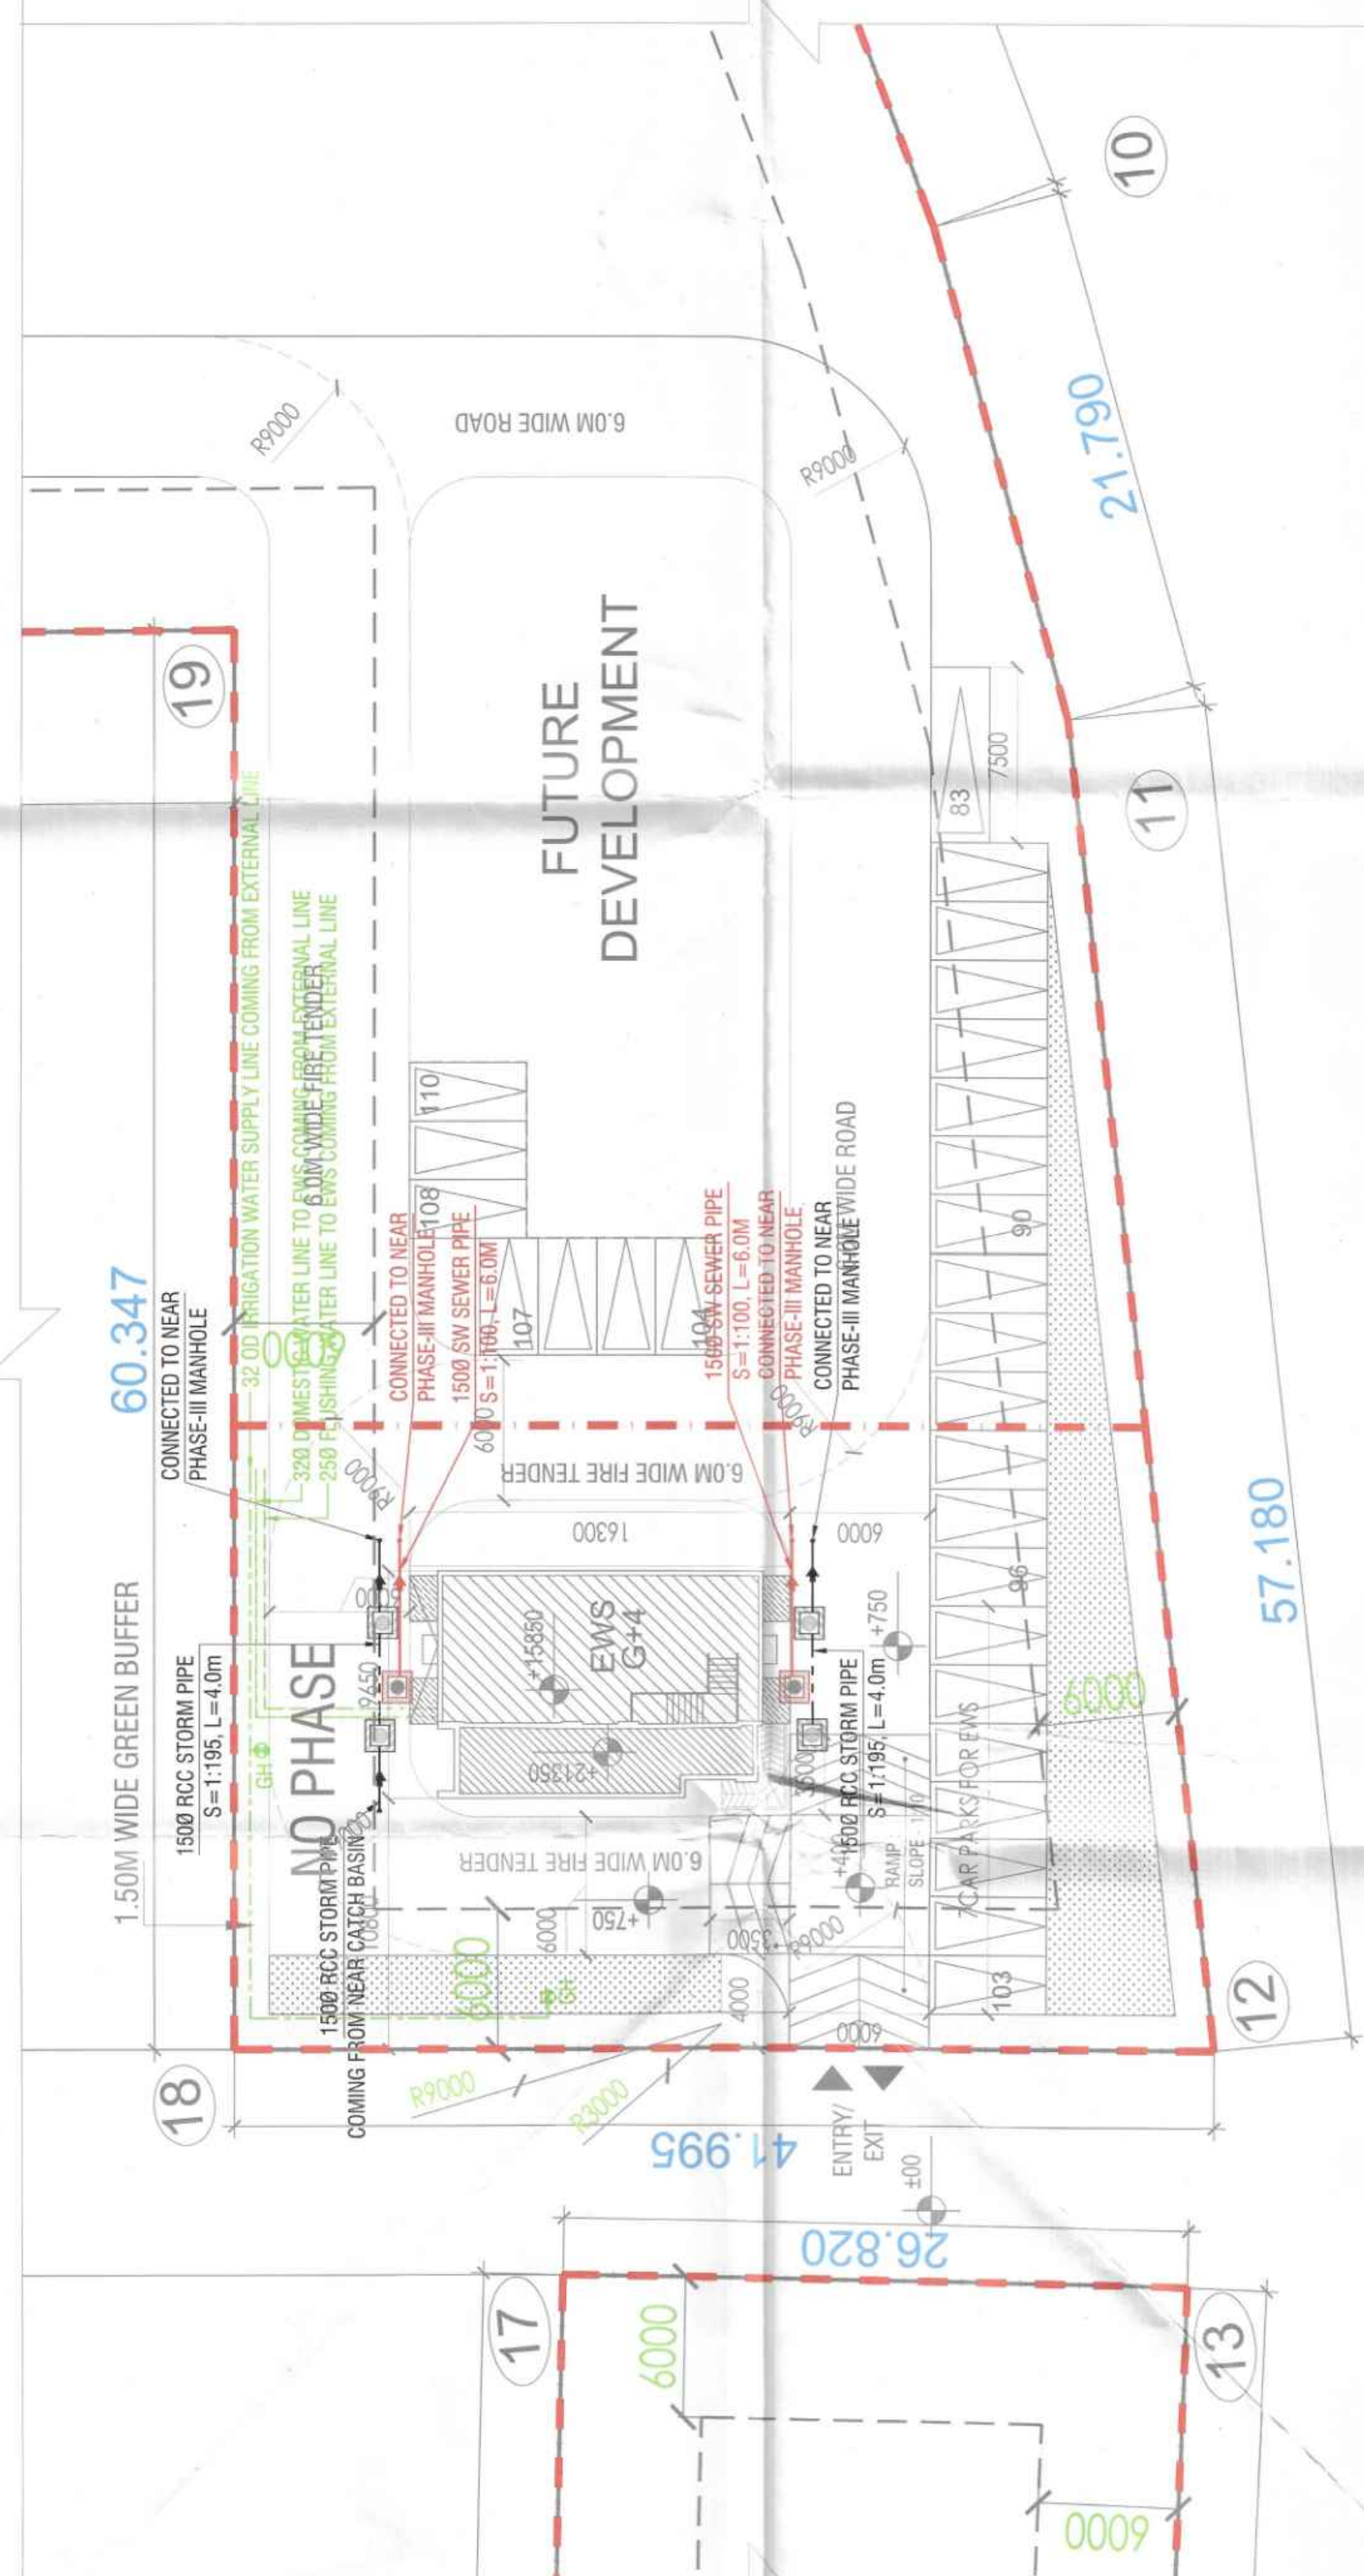


OTHER'S LAND

PART 1

PART 2

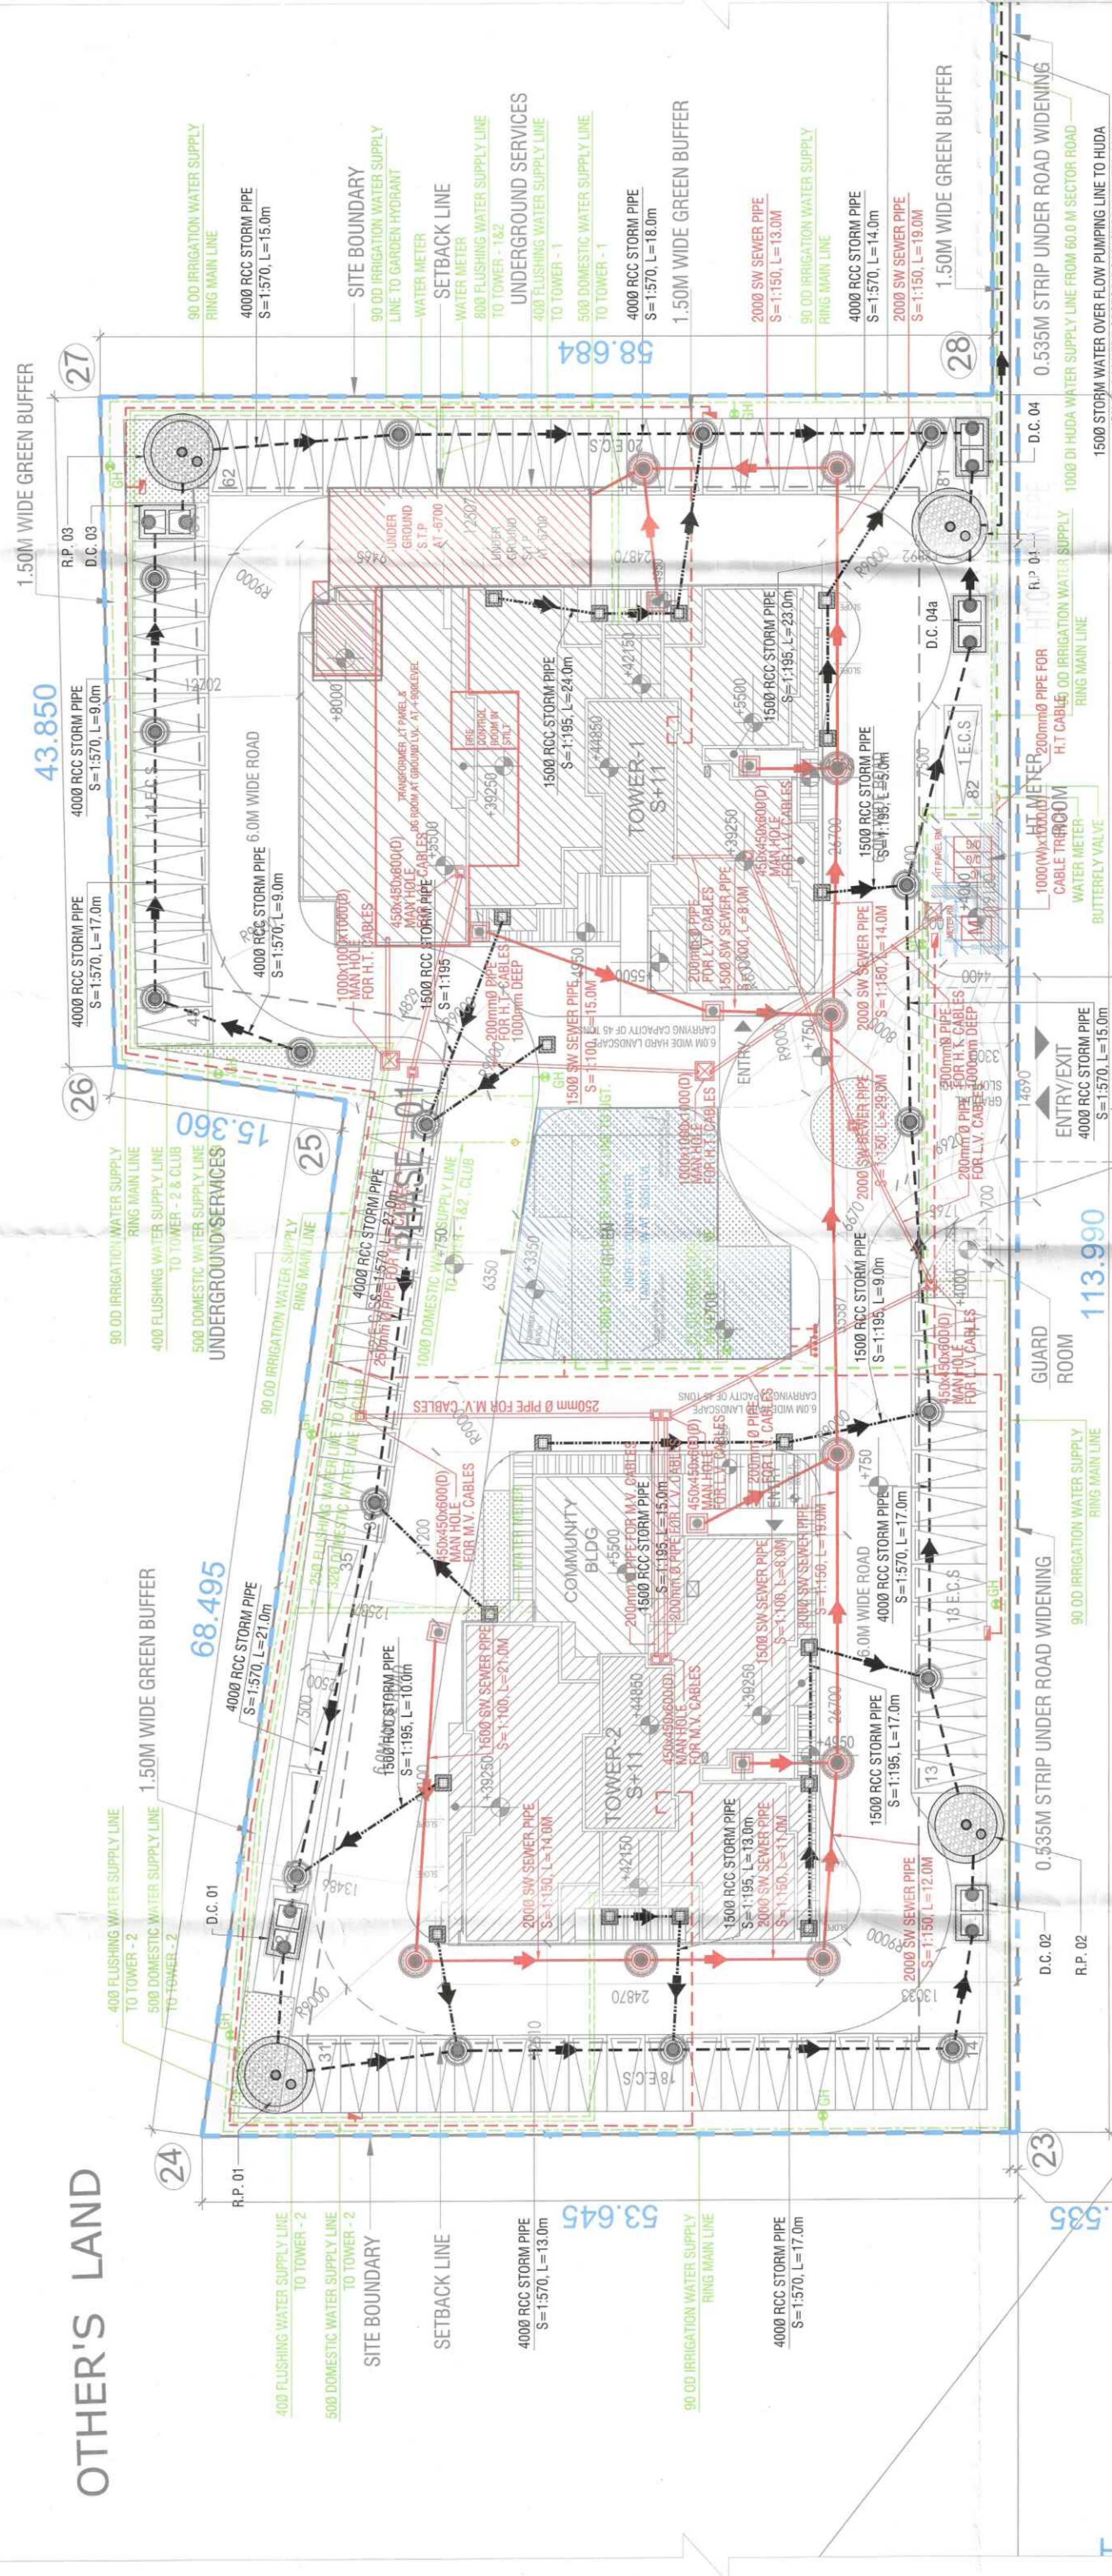

NOTES

1. ALL DIMENSIONS IN MILLIMETERS UNLESS OTHERWISE SPECIFIED.

2. ALL BASIN AREAS SHALL BE MECHANICALLY LIFT AND VENTILATED WITH 100% POWER EXHAUST.

3. ALL WASTE WATER SHALL BE AS PER STANDARD DESIGN.

4. THE PROVISION OF SOLAR WATER HEATING SYSTEM TO BE AS PER NORMS SPECIFIED BY HAREDA, AND MADE AVAILABLE BEFORE APPLYING FOR OCCUPANCY CERTIFICATE.

5. RAIN WATER HARVESTING SYSTEM SHALL BE AS PER HAREDA GOVT. AND HAREDA AUTHORITY NORMS.

6. ALL DIMENSIONS INCLUDING FIRE SPRINKLERS SHALL BE AS PER NBC GUIDELINES.

SPECIAL NOTES:

1. ALL DIMENSIONS ON THIS DRAWING ARE IN METERS.

2. ONLY WRITTEN DIMENSIONS ARE TO BE FOLLOWED. DRAWINGS SHOULD NOT BE SCALED UNDER ANY CIRCUMSTANCES.

3. ALL MEASUREMENTS MUST BE CHECKED AND VERIFIED BY THE CONTRACTORS PRIOR TO EXECUTION OF WORK AT THE SITE.

4. THIS DRAWING IS TO BE READ IN CONJUNCTION WITH ALL RELEVANT STRUCTURAL, SERVICES & FACILITY PLANNING DRAWINGS.

5. ARCHITECTURAL DRAWINGS ARE TO BE FOLLOWED FOR THE LOCATION OF ALL STRUCTURAL MEMBERS & MASONRY WALLS. FOR SIZES & REINFORCEMENT DETAILS OF STRUCTURAL MEMBERS RELEVANT STRUCTURAL DRAWINGS ARE TO BE REFERRED.

6. ANY DISCREPANCIES BETWEEN ARCHITECTURAL, STRUCTURAL AND SERVICES DRAWINGS MUST BE BROUGHT TO THE NOTICE OF THE ARCHITECTS IMMEDIATELY & PRIOR TO EXECUTION AT SITE.

7. CO-ORDINATION WITH THE SERVICES SUCH AS PLUMBING & ELECTRICAL ETC. IS THE RESPONSIBILITY OF THE CONTRACTORS.

PLUMBING SERVICES LEGEND:

EXTERNAL SEWER MANHOLE

EXTERNAL STORM WATER MANHOLE

BRANCH STORM WATER MANHOLE (600 x 600) MM

BRANCH STORM WATER MANHOLE (800 x 800) MM

BRANCH STORM WATER MANHOLE (900 x 800) MM

SN EXTERNAL SEWER LINE

RCC EXTERNAL STORM WATER LINE

DOMESTIC WATER SUPPLY LINE

FLUSHING WATER SUPPLY LINE

1500 SW SEWER BRANCH LINE SLOPE = 1:100

1500 RCC STORM WATER BRANCH LINE SLOPE = 1:150

GARDEN IRRIGATION LINE

EXTERNAL NS FIRE HYDRANT LINE (DIA MENTION IN LAYOUT)

EXTERNAL FIRE HYDRANT (750 x 600 x 250) MM

GARDEN HYDRANT POINT

D.C. DESLTING CHAMBER (1.5 x 3.0) M

R.P. RECHARGE PIT (4.1 M DIA)

HUDA SUBMISSION DRAWING

Client: Sh. Atul Singh And Other in Collaboration With BMA&S MGF LAND LTD.

Job Title: Proposed Building Plans for Housing Group Colony Measuring 10.744 acres land (Licence no. 4 of 2013 dated 18-02-2013 in sector 112, Gurgaon, Haryana, India). The project is located in Sector 112, Gurgaon, Haryana, India. The project is a housing colony with a total area of 10.744 acres. The project is a housing colony with a total area of 10.744 acres. The project is a housing colony with a total area of 10.744 acres.

Architects: Arcop Associates Pvt. Ltd. Plot 365, Sec-32, Gurgaon-122001 Ph: 91-98688-11541 Fax: 91-98688-11542

Structure: IPC Technical Projects Consultants Pvt. Ltd. 3/41 Sector 87, Gurgaon-122001 Ph: 91-98688-11541 Fax: 91-98688-11542

MEP: Paradise Consultants 3/41 Sector 87, Gurgaon-122001 Ph: 91-98688-11541 Fax: 91-98688-11542

Owner's Signature: [Signature]

Architect's Signature: [Signature]

Drawing Title: PART SITE PLAN(PHASE-1) MEP COORDINATED LAYOUT

Date: 01-11-2023 Scale: 1:200 Drawing No.: A-008