


PLUMBING LEGEND:
1. DOMESTIC WATER SUPPLY LINE
2. DOMESTIC WATER SUPPLY LINE
3. DOMESTIC WATER SUPPLY LINE
4. DOMESTIC WATER SUPPLY LINE
5. DOMESTIC WATER SUPPLY LINE
6. DOMESTIC WATER SUPPLY LINE
7. DOMESTIC WATER SUPPLY LINE
8. DOMESTIC WATER SUPPLY LINE
9. DOMESTIC WATER SUPPLY LINE
10. DOMESTIC WATER SUPPLY LINE

Only For Submission Estimate
Superintending Engineer,
HSVP Division No. 4, Gurgaon

NOTES:
1. ALL DIMENSIONS IN METERS UNLESS OTHERWISE SPECIFIED.
2. ANY AREA SHALL BE KEPT UNOCCUPIED BY THE DEVELOPER.
3. GATE AND BOUNDARY WALL SHALL BE AS PER STANDARD DESIGN.
4. AS PER NORMS SPECIFIED BY HUDA AND MAHARASHTRA GOVT.
5. LAND WATER HARVESTING SYSTEM SHALL BE AS PER CENTRAL GOVT. WATER AUTHORITY NORMS.
6. SPRINKLER SHALL BE AS PER NBC GUIDELINES.
7. ALL DIMENSIONS IN METERS UNLESS OTHERWISE SPECIFIED.
8. ANY AREA SHALL BE KEPT UNOCCUPIED BY THE DEVELOPER.
9. GATE AND BOUNDARY WALL SHALL BE AS PER STANDARD DESIGN.
10. AS PER NORMS SPECIFIED BY HUDA AND MAHARASHTRA GOVT.
11. LAND WATER HARVESTING SYSTEM SHALL BE AS PER CENTRAL GOVT. WATER AUTHORITY NORMS.
12. SPRINKLER SHALL BE AS PER NBC GUIDELINES.

Table with 10 columns: S.No., Building Type, Typology, Far Area, Non Far Area, Ground Coverage, Building Heights, No. of Main Units, No. of Service Personnel Units, Population Breakup, Total Population. Rows include Tower 1, Tower 2, and various community facilities like Gym, Club, etc.

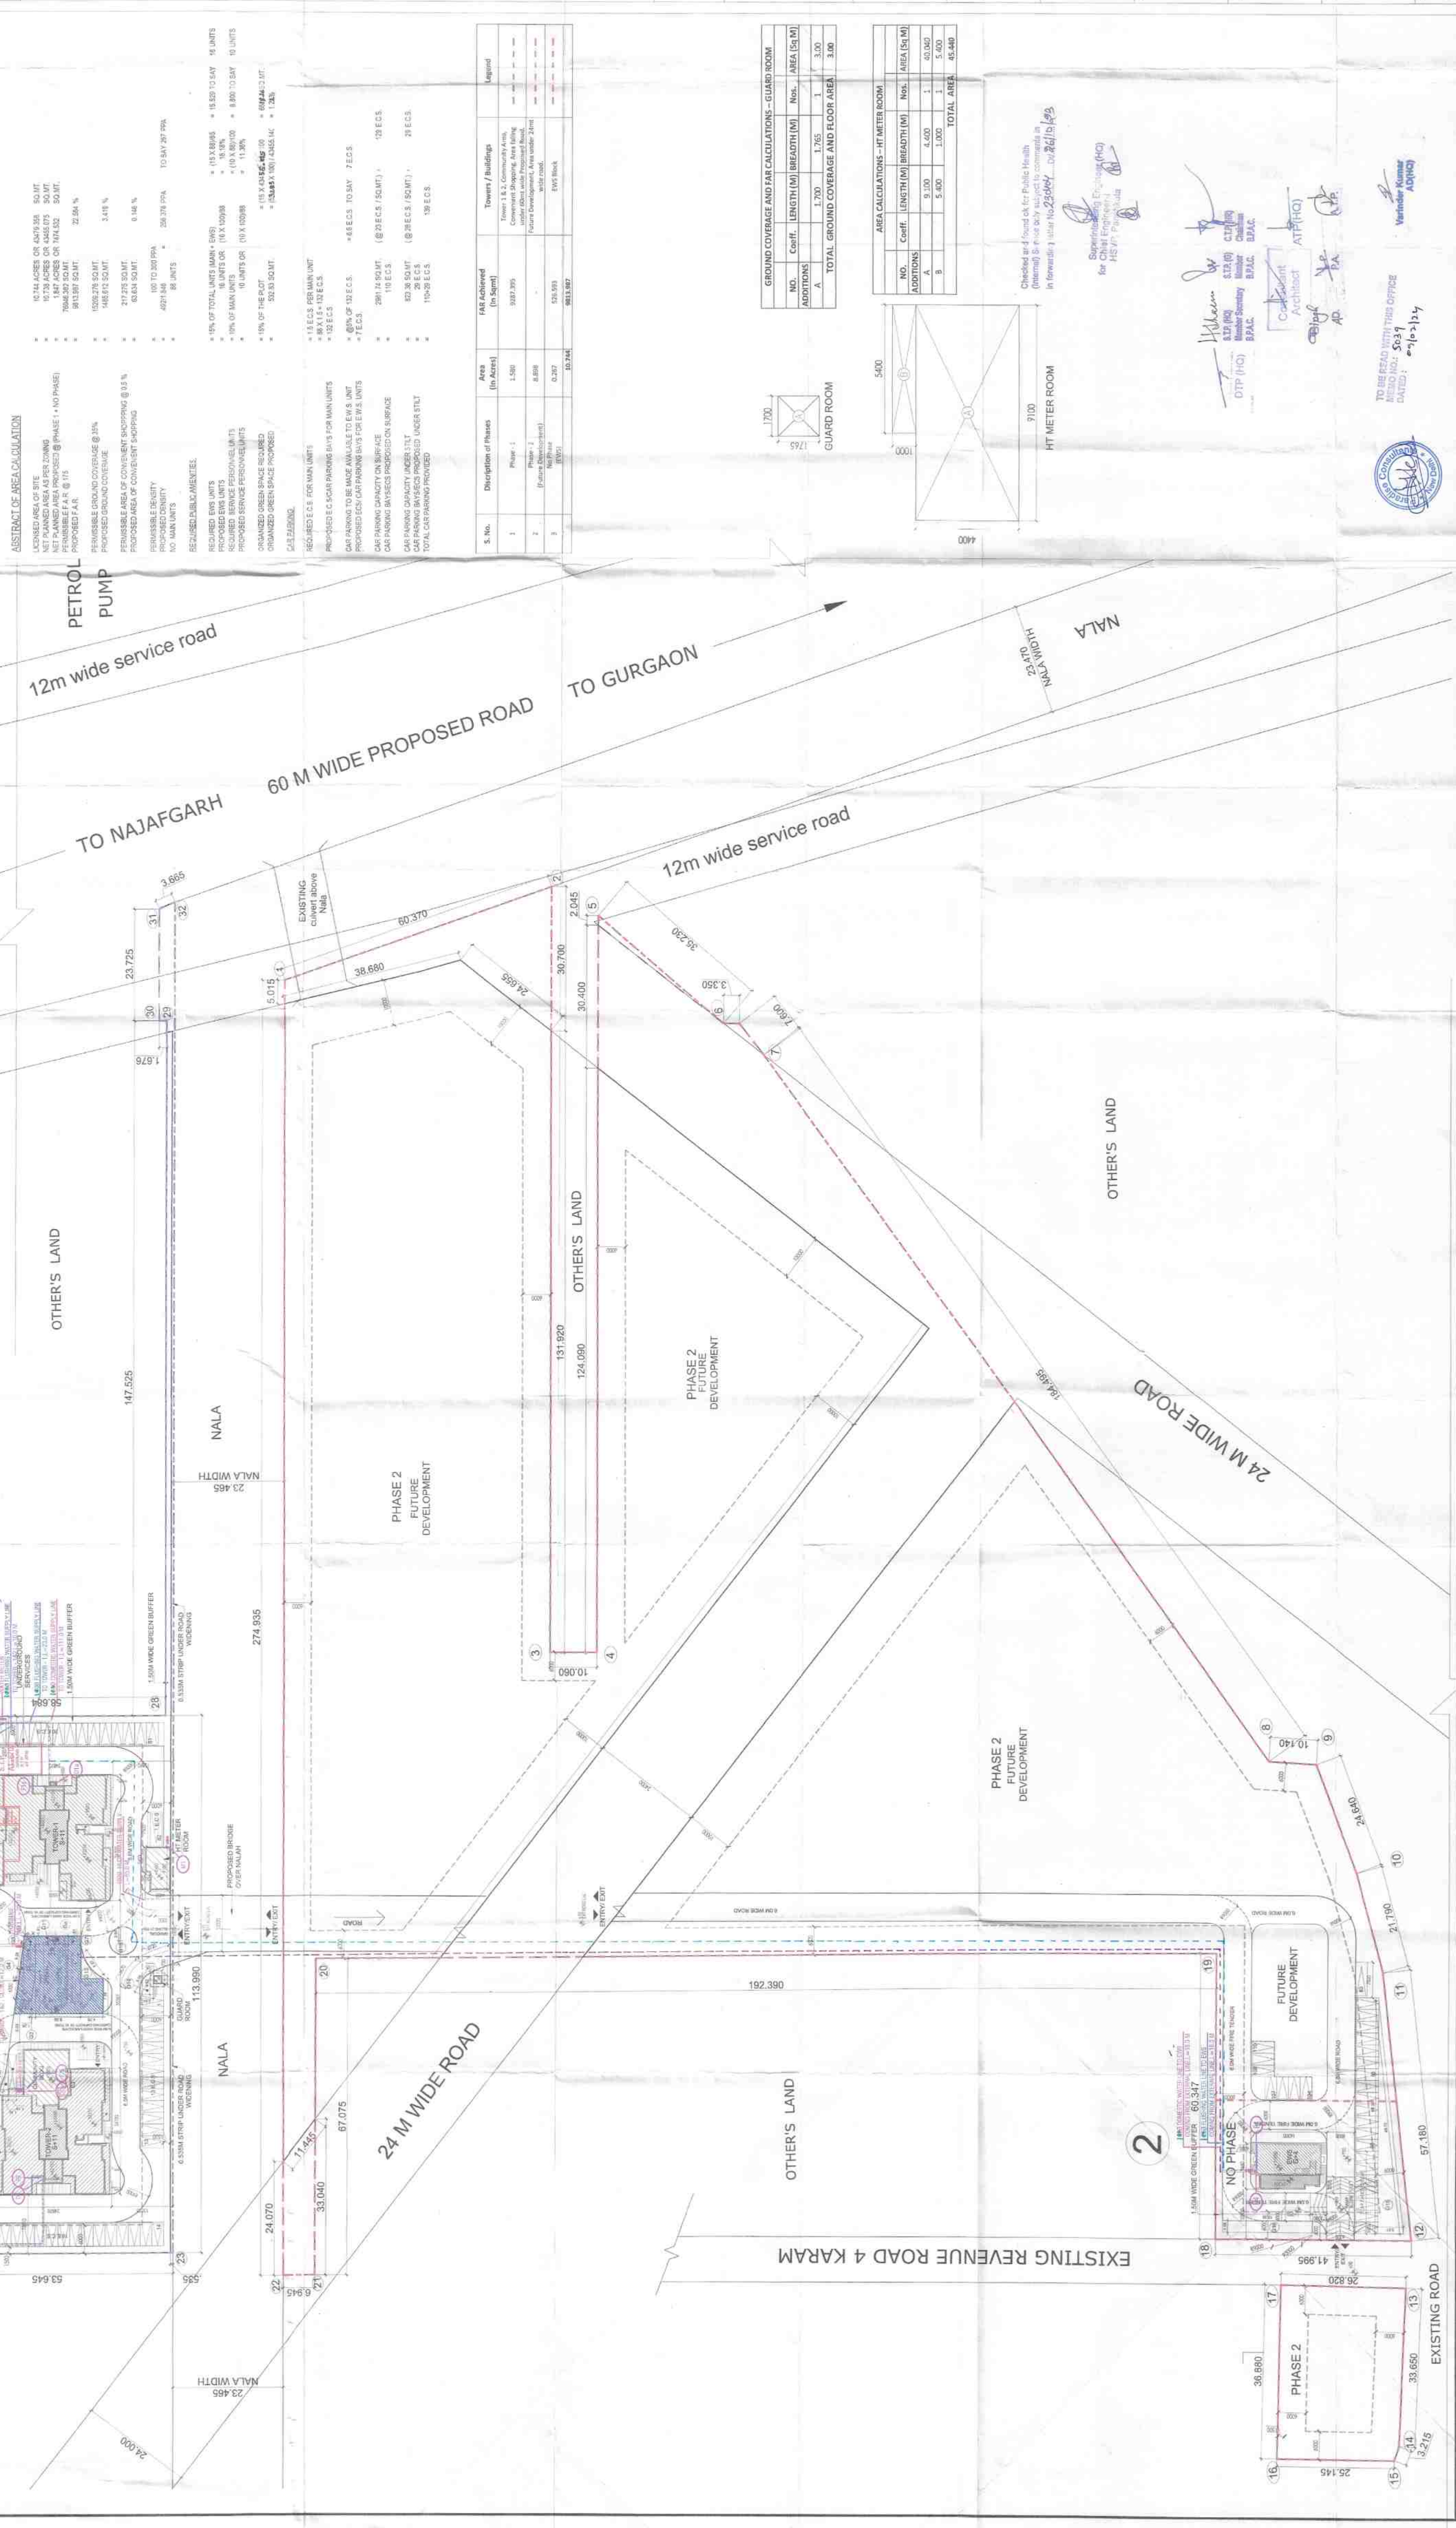

SUBMISSION DRAWING
Client: Sh. A.P. Singh And Other In Collaboration With EMAR INDIA LTD.
Architect: Alcoro Associates Pvt. Ltd.
Structural: JPC Technical Projects Consultants Pvt. Ltd.
MEP: Parag Consultants
Owner's Signature: [Signature]
Architect's Signature: [Signature]
Overall Site Plan
Water Supply Layout
Date: 01-12-2023
Scale: 1:500
Drawing No: A-001