

Note :-

1. BUILDING HAS AUTOMATIC SPRINKLER SYSTEM WHEREVER REQUIRED BY NBC.
2. BUILDING WILL BE DESIGNED (STRUCTURES) AS PER RELENT IS CODES FOR EARTH QUAKE RESISTANCE.
3. BUILDING IS ARTIFICIALLY LIGHTED MECHANICALLY VENTILATED/ AIRCONDITIONED & 100% POWER BACKUP

LEGEND :-

PROJECT:
PROPOSED BUILDING PLAN (REVISION-1) OF (SUMMIT PLAZA)
DEVELOPMENT (TPO) POLICY DATED 08.02.2018 ON THE AREA
HOUSING COLONY NAME: TULSA FORBERA X KNOW AS TULSA
CITY PHASE-IV, GURUGRAM BEING DEVELOPED BY GFC LIMITED.

DESIGN ARCHITECTS
ARCOP
ARCOP ASSOCIATES PVT.LTD
Plot No. 36B, Sector-32, Institutional Area,
Gurugram, Haryana, 122001, India
Tel.: 91-124-4595500
Fax: 91-124-4595550


ASSOCIATE ARCHITECTS
RSIMIS ARCHITECTS
RSMS ARCHITECTS PVT. LTD.
69 Noida Noida (Bhronat Kunj)
(Behind D2), Vasant Kunj,
New Delhi-110070
Tel.: 011-26898616, 26898617
WWW.RSMS-INDIA.COM

ARCHITECT'S SEAL & SIGNATURE

OWNER'S SEAL & SIGNATURE

JAN-2024 Scale: 1:100 Drawing No:- R-04

3RD FLOOR PLAN

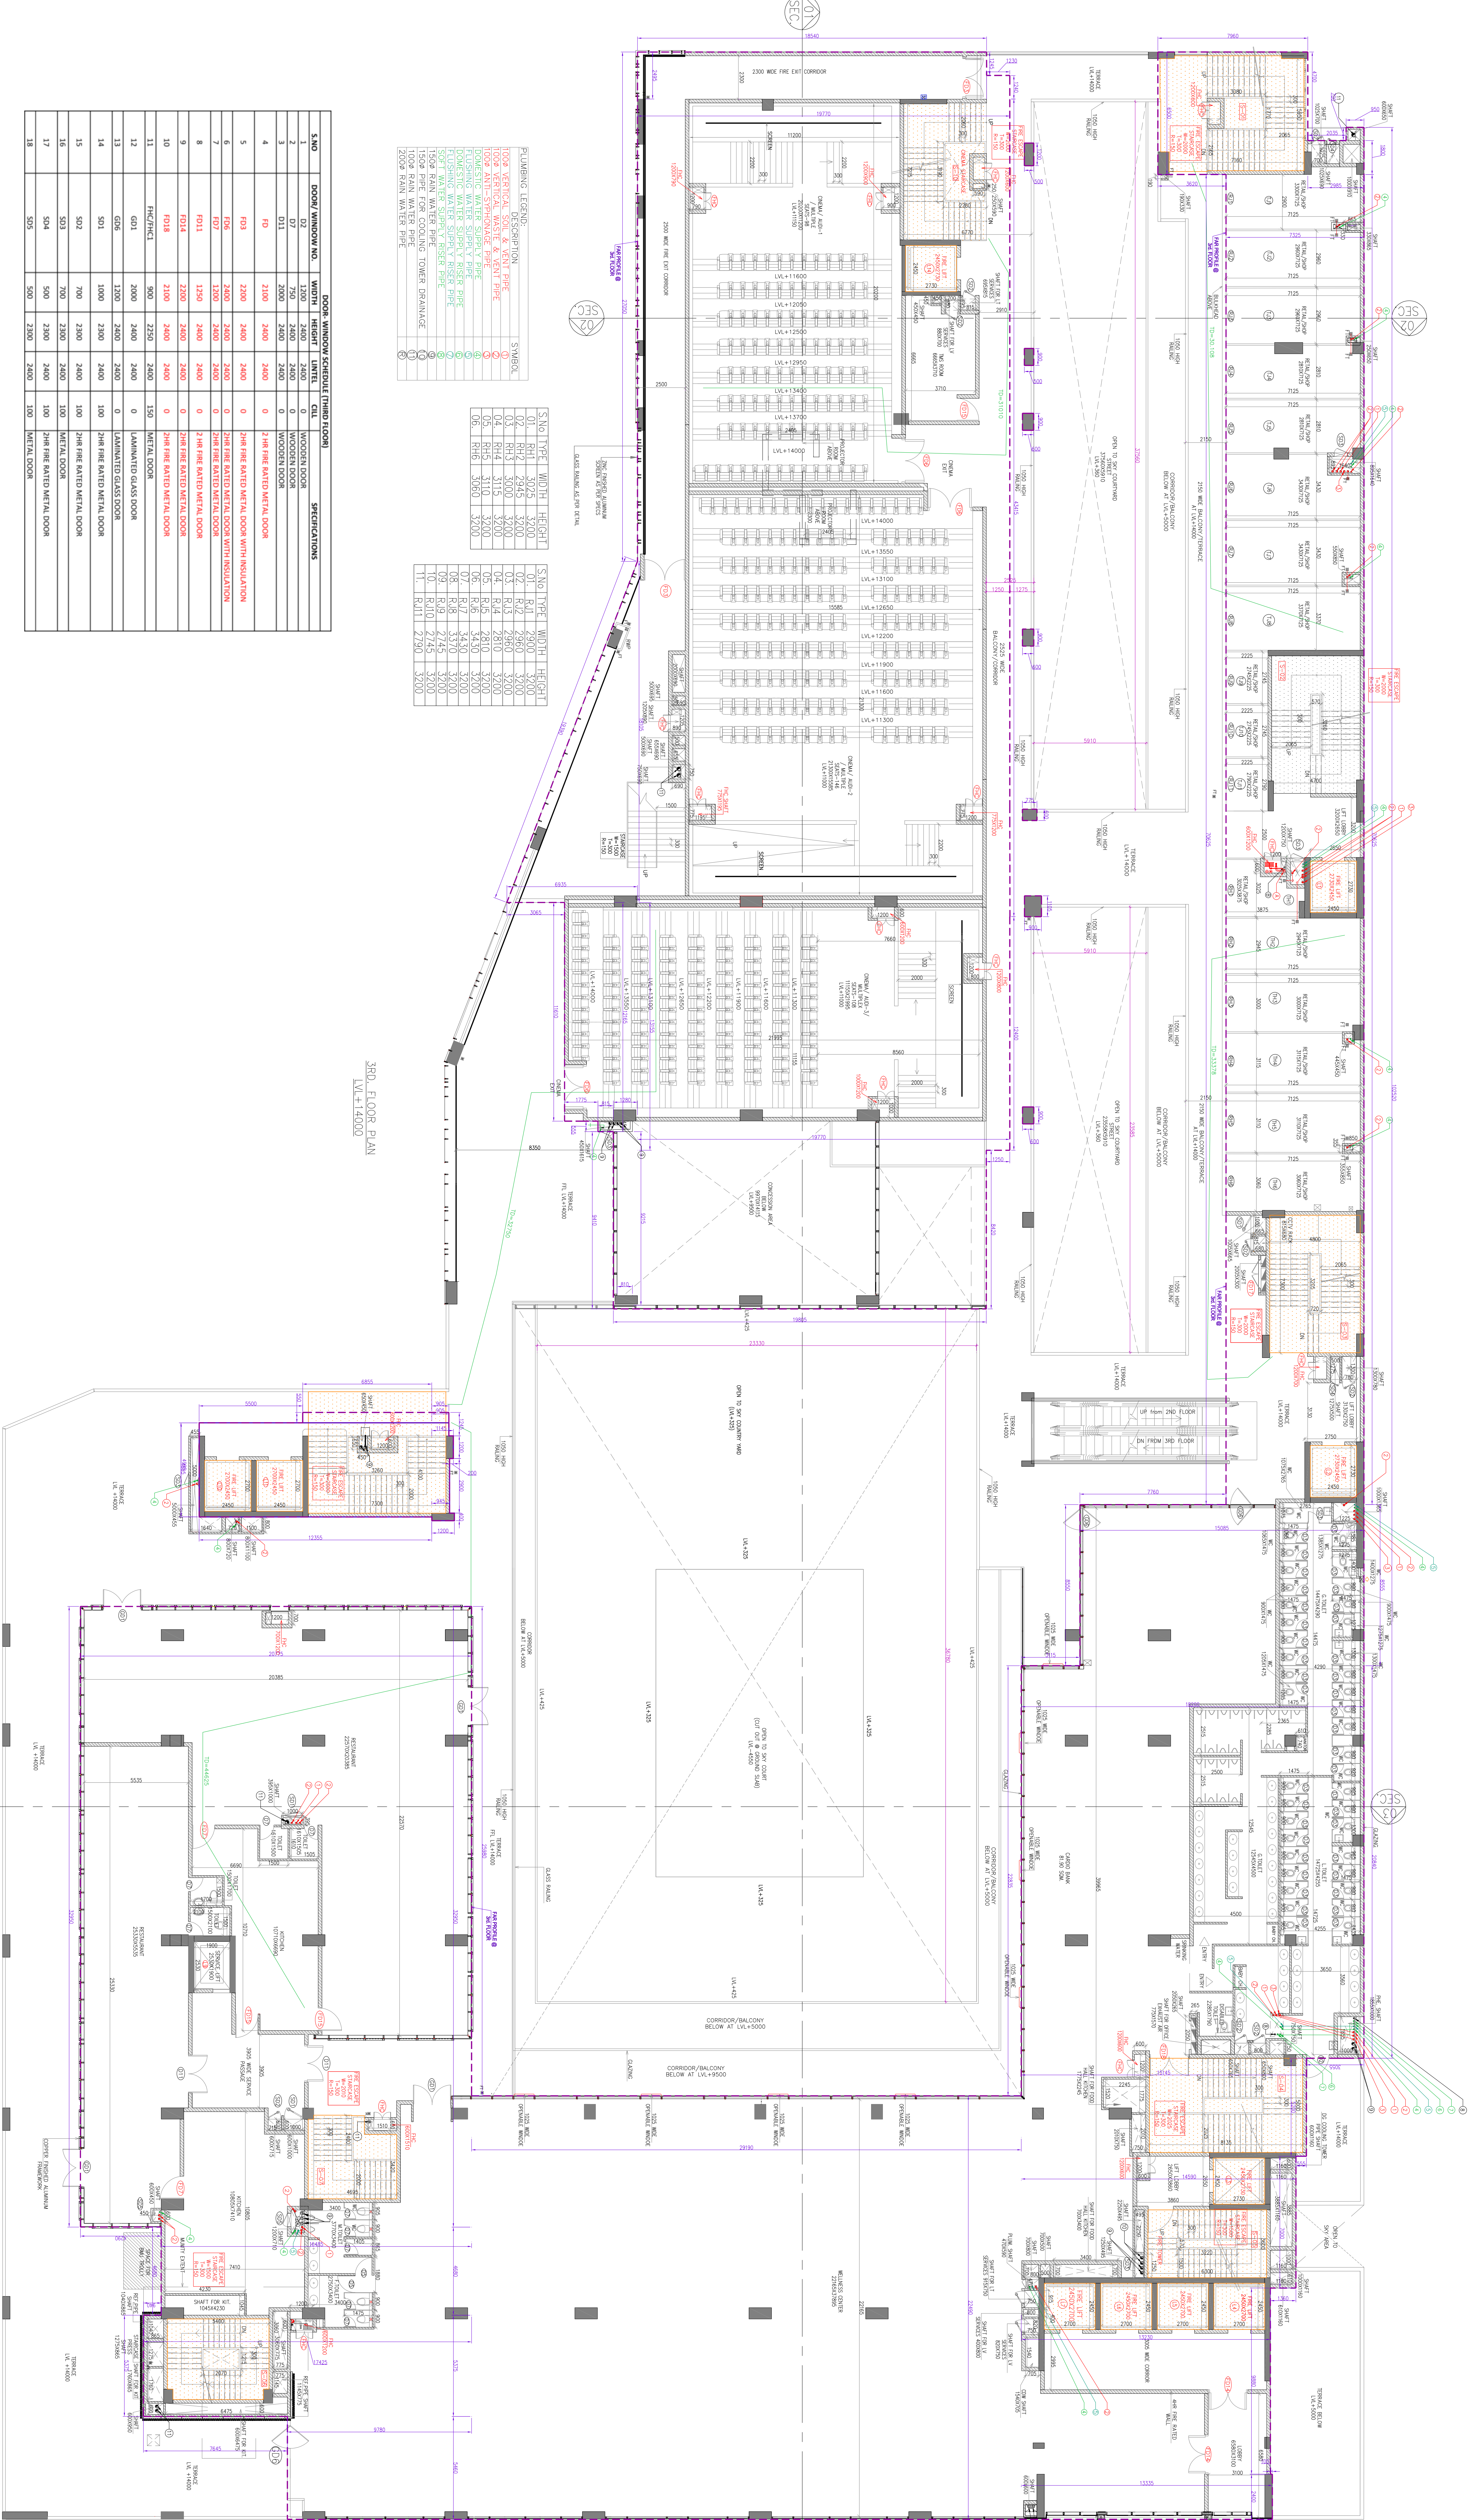

PLUMBING LEGEND	SYMBOL
100% VERTICAL SOIL & RAIN PIPE	100%
100% ANTI-SIPHONING PIPE	100%
100% WATER SUPPLY PIPE	100%
100% WATER SUPPLY RISER PIPE	100%
100% WATER SUPPLY RISER PIPE	100%
100% RAIN WATER PIPE - TOWER DRAINAGE	100%
100% RAIN WATER PIPE	100%
200% RAIN WATER PIPE	200%

S.NO	TYPE	WIDTH	HEIGHT	CL
01	RH	3025	3200	0
02	RH	2945	3200	0
03	RH	3000	3200	0
04	RH	3000	3200	0
05	RH	3110	3200	0
06	RH	3060	3200	0
07	RH	3450	3200	0
08	RH	2745	3200	0
09	RH	2745	3200	0
10	RH	2745	3200	0
11	RH	2745	3200	0
12	RH	2745	3200	0
13	RH	2745	3200	0
14	RH	2745	3200	0
15	RH	2745	3200	0
16	RH	2745	3200	0
17	RH	2745	3200	0
18	RH	2745	3200	0

S.NO	TYPE	WIDTH	HEIGHT	CL
01	RH	3025	3200	0
02	RH	2945	3200	0
03	RH	3000	3200	0
04	RH	3000	3200	0
05	RH	3110	3200	0
06	RH	3060	3200	0
07	RH	3450	3200	0
08	RH	2745	3200	0
09	RH	2745	3200	0
10	RH	2745	3200	0
11	RH	2745	3200	0
12	RH	2745	3200	0
13	RH	2745	3200	0
14	RH	2745	3200	0
15	RH	2745	3200	0
16	RH	2745	3200	0
17	RH	2745	3200	0
18	RH	2745	3200	0

DOOR WINDOW SCHEDULE (FINISH FLOOR)

S.NO	DOOR WINDOW NO.	WIDTH	HEIGHT	LINETS	CL	SPECIFICATIONS
1	D01	2400	2400	0	0	WOODEN DOOR
2	D02	2400	2400	0	0	WOODEN DOOR
3	D03	2400	2400	0	0	WOODEN DOOR
4	D04	2400	2400	0	0	WOODEN DOOR
5	D05	2400	2400	0	0	WOODEN DOOR
6	D06	2400	2400	0	0	WOODEN DOOR
7	D07	2400	2400	0	0	WOODEN DOOR
8	D08	2400	2400	0	0	WOODEN DOOR
9	D09	2400	2400	0	0	WOODEN DOOR
10	D10	2400	2400	0	0	WOODEN DOOR
11	D11	2400	2400	0	0	WOODEN DOOR
12	D12	2400	2400	0	0	WOODEN DOOR
13	D13	2400	2400	0	0	WOODEN DOOR
14	D14	2400	2400	0	0	WOODEN DOOR
15	D15	2400	2400	0	0	WOODEN DOOR
16	D16	2400	2400	0	0	WOODEN DOOR
17	D17	2400	2400	0	0	WOODEN DOOR
18	D18	2400	2400	0	0	WOODEN DOOR

Level	Occupancy Type	Area	Quantity	Material	Remarks
3RD	Office	545	10	10000	
4TH	Office	545	10	10000	
5TH	Office	545	10	10000	
6TH	Office	545	10	10000	
7TH	Office	545	10	10000	
8TH	Office	545	10	10000	
9TH	Office	545	10	10000	
10TH	Office	545	10	10000	
11TH	Office	545	10	10000	
12TH	Office	545	10	10000	
13TH	Office	545	10	10000	
14TH	Office	545	10	10000	
15TH	Office	545	10	10000	
16TH	Office	545	10	10000	
17TH	Office	545	10	10000	
18TH	Office	545	10	10000	