

1. BUILDING HAS AUTOWATC SPRINKLER SYSTEM WHEREVER REQUIRED BY NBC.
2. BUILDING WILL BE DESIGNED (STRUCTURES) AS PER RELEVANT IS CODES FOR EARTH QUAKE RESISTANCE.
3. ALL TOILET & KITCHEN HAVE PERMANENT VENTILATION /EXHAUST
4. POWDER ROOM / WC WILL BE MECHANICALLY VENTILATED(HORIZONTAL)

This is a "PROVISIONAL BUILDING PLAN"
approved only for the purpose of inviting
objections from the general public.

STP(HQ) STP(CS) CDP(H)
Main Office Main Branch
BPAAC BPAAC SPAC

[Signature]

DTP(HQ)

Consultant
Architect

2000
 P.A.
 2000

TO BE READ WITH THIS OFFICE
MEMO NO.:
DATED :

AREA CALCULATION OF MUMTY / MACHINE ROOM AREA (TOWER-N1 & N2)					
GROSS -A					
1	1	X		X	SQM
			20.925	16.375	=
			TOTAL	342.647	=
				342.647	SQM

ARCHITECT

Plot No. 41, Industrial Estate,
Okhla Phase-III,
New Delhi 110020, India
TEL: +91 11 41828070
FAX: 91 11 26490351

R|S|M|S
ARCHITECTS

RSMS ARCHITECTS PVT. LTD.
69, Nora Niwas Bhawani Kunj
(Behind D2), Vasant Kunj,
New Delhi-110070.
Tel.: 011-26898616, 26898617
www.rsms-arch.com


ARCHITECT'S SEAL & SIGNATURE

Name : AVINASH DEV
DA No. CA/2014/66491


OCT. 2023.	Scale : 1:100	Drawing No: -
------------	---------------	---------------

Drawing Title: -
33RD TO ROOF PLAN
AND MUMTY AREA CALCULATION
TOWER N4 & N2


PARAS-GMA PAVARI

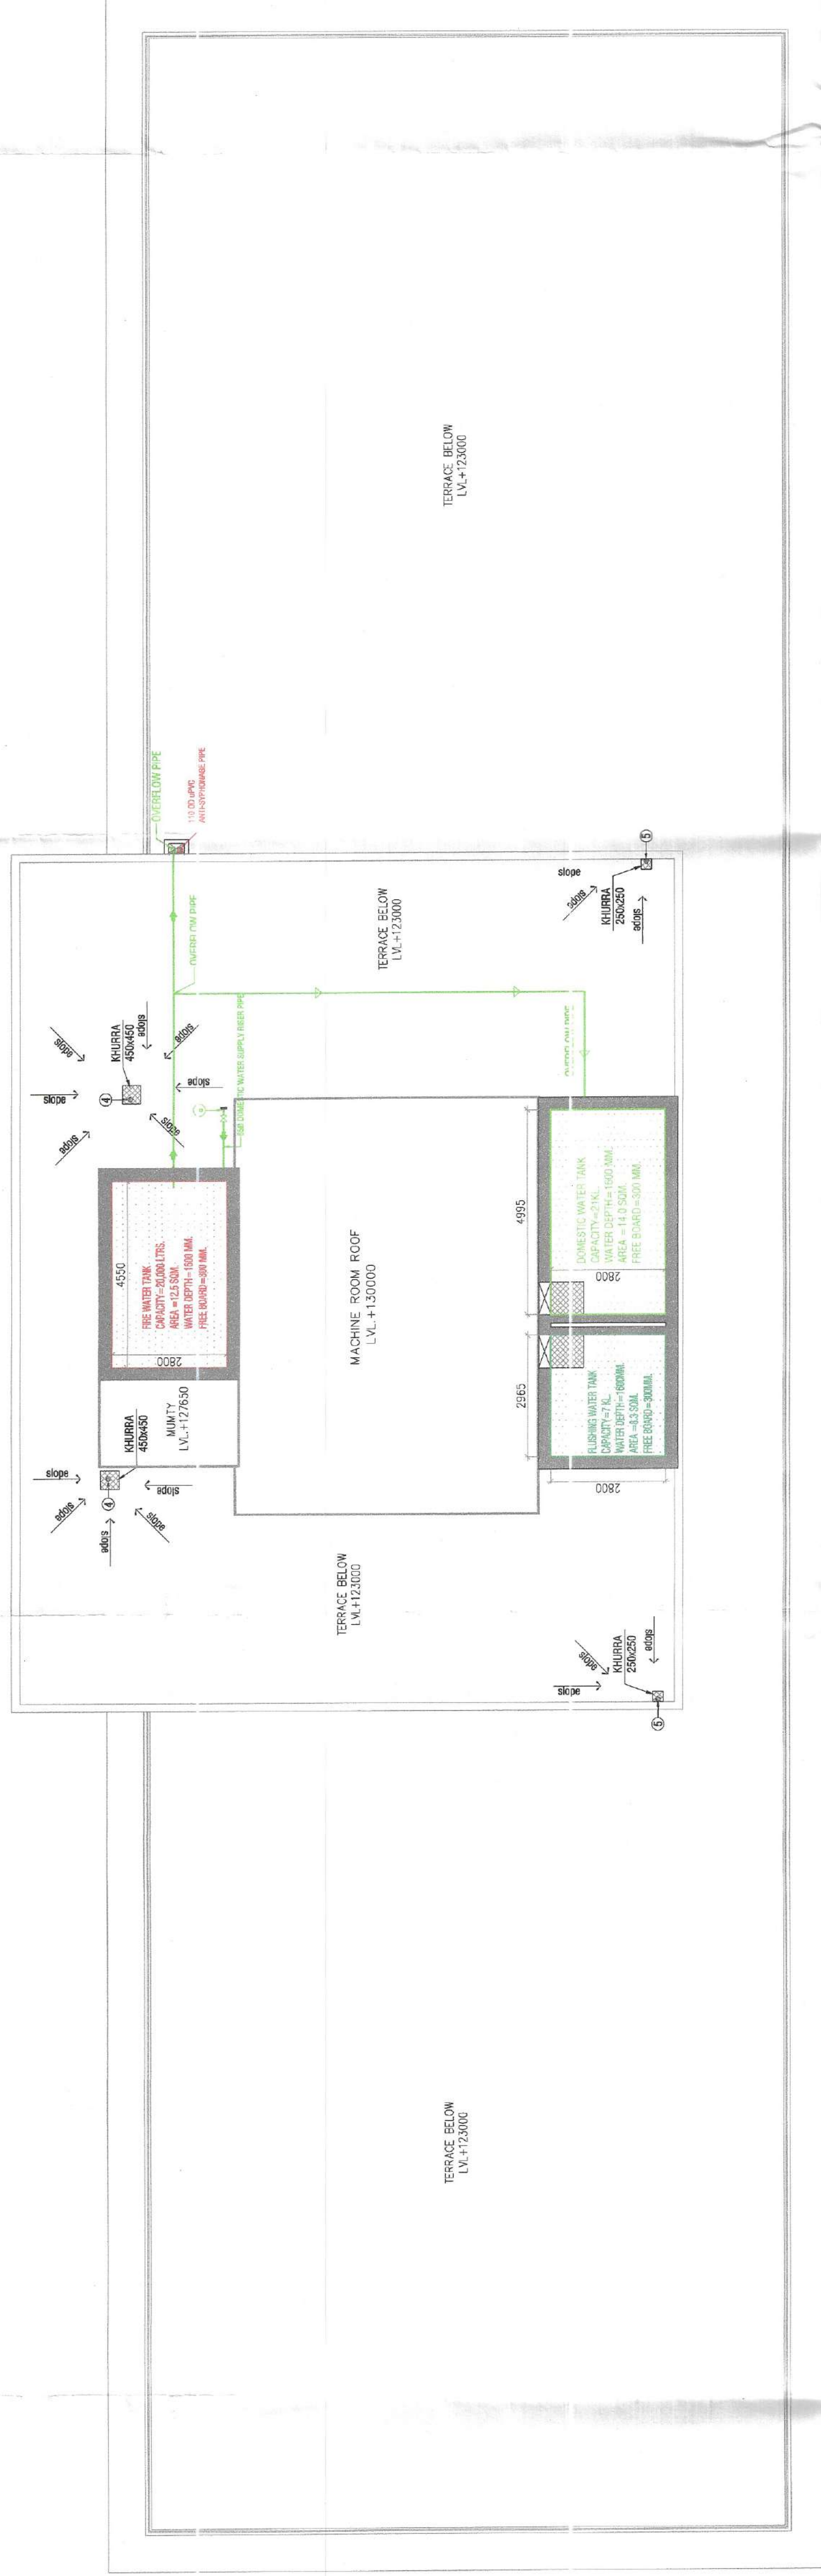

ROOF PLAN

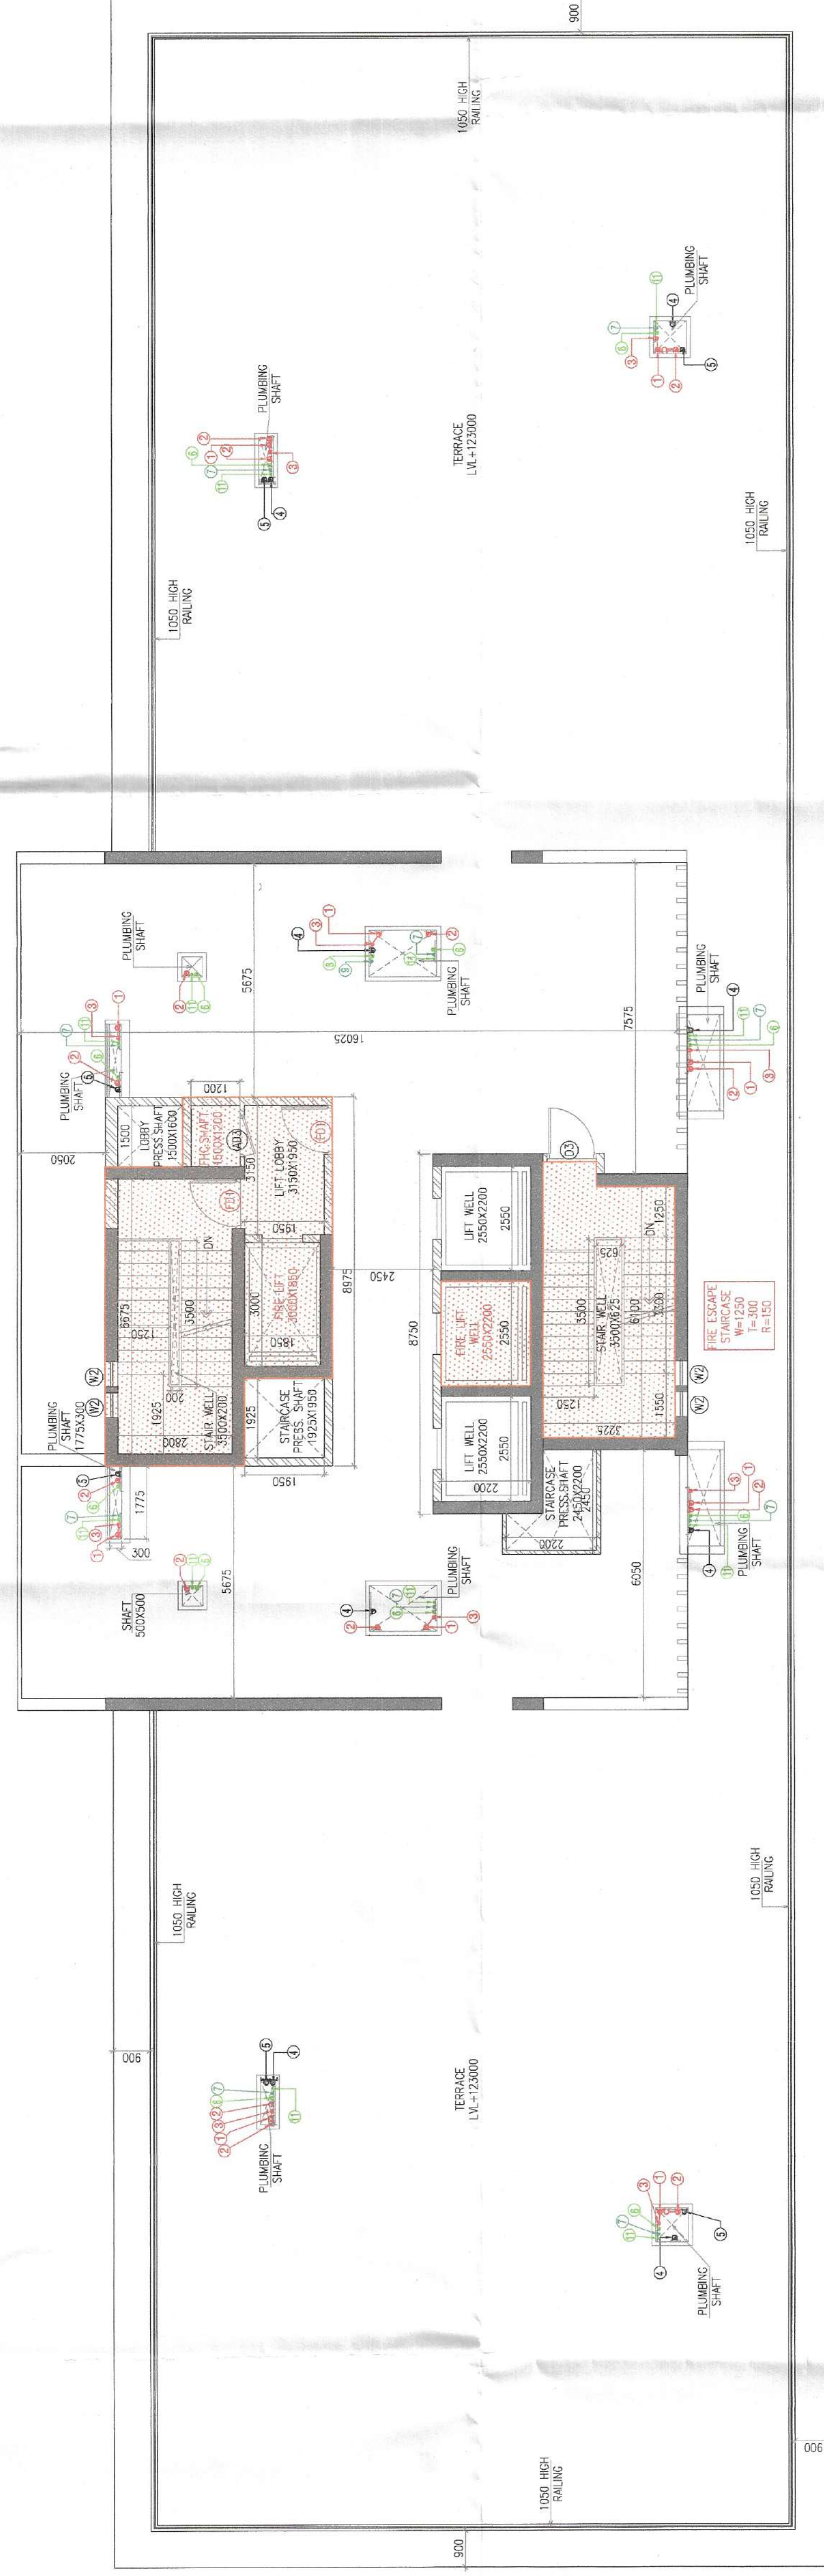

TERRACE FLOOR PLAN
LVL+123000
TOWER-N1&N2

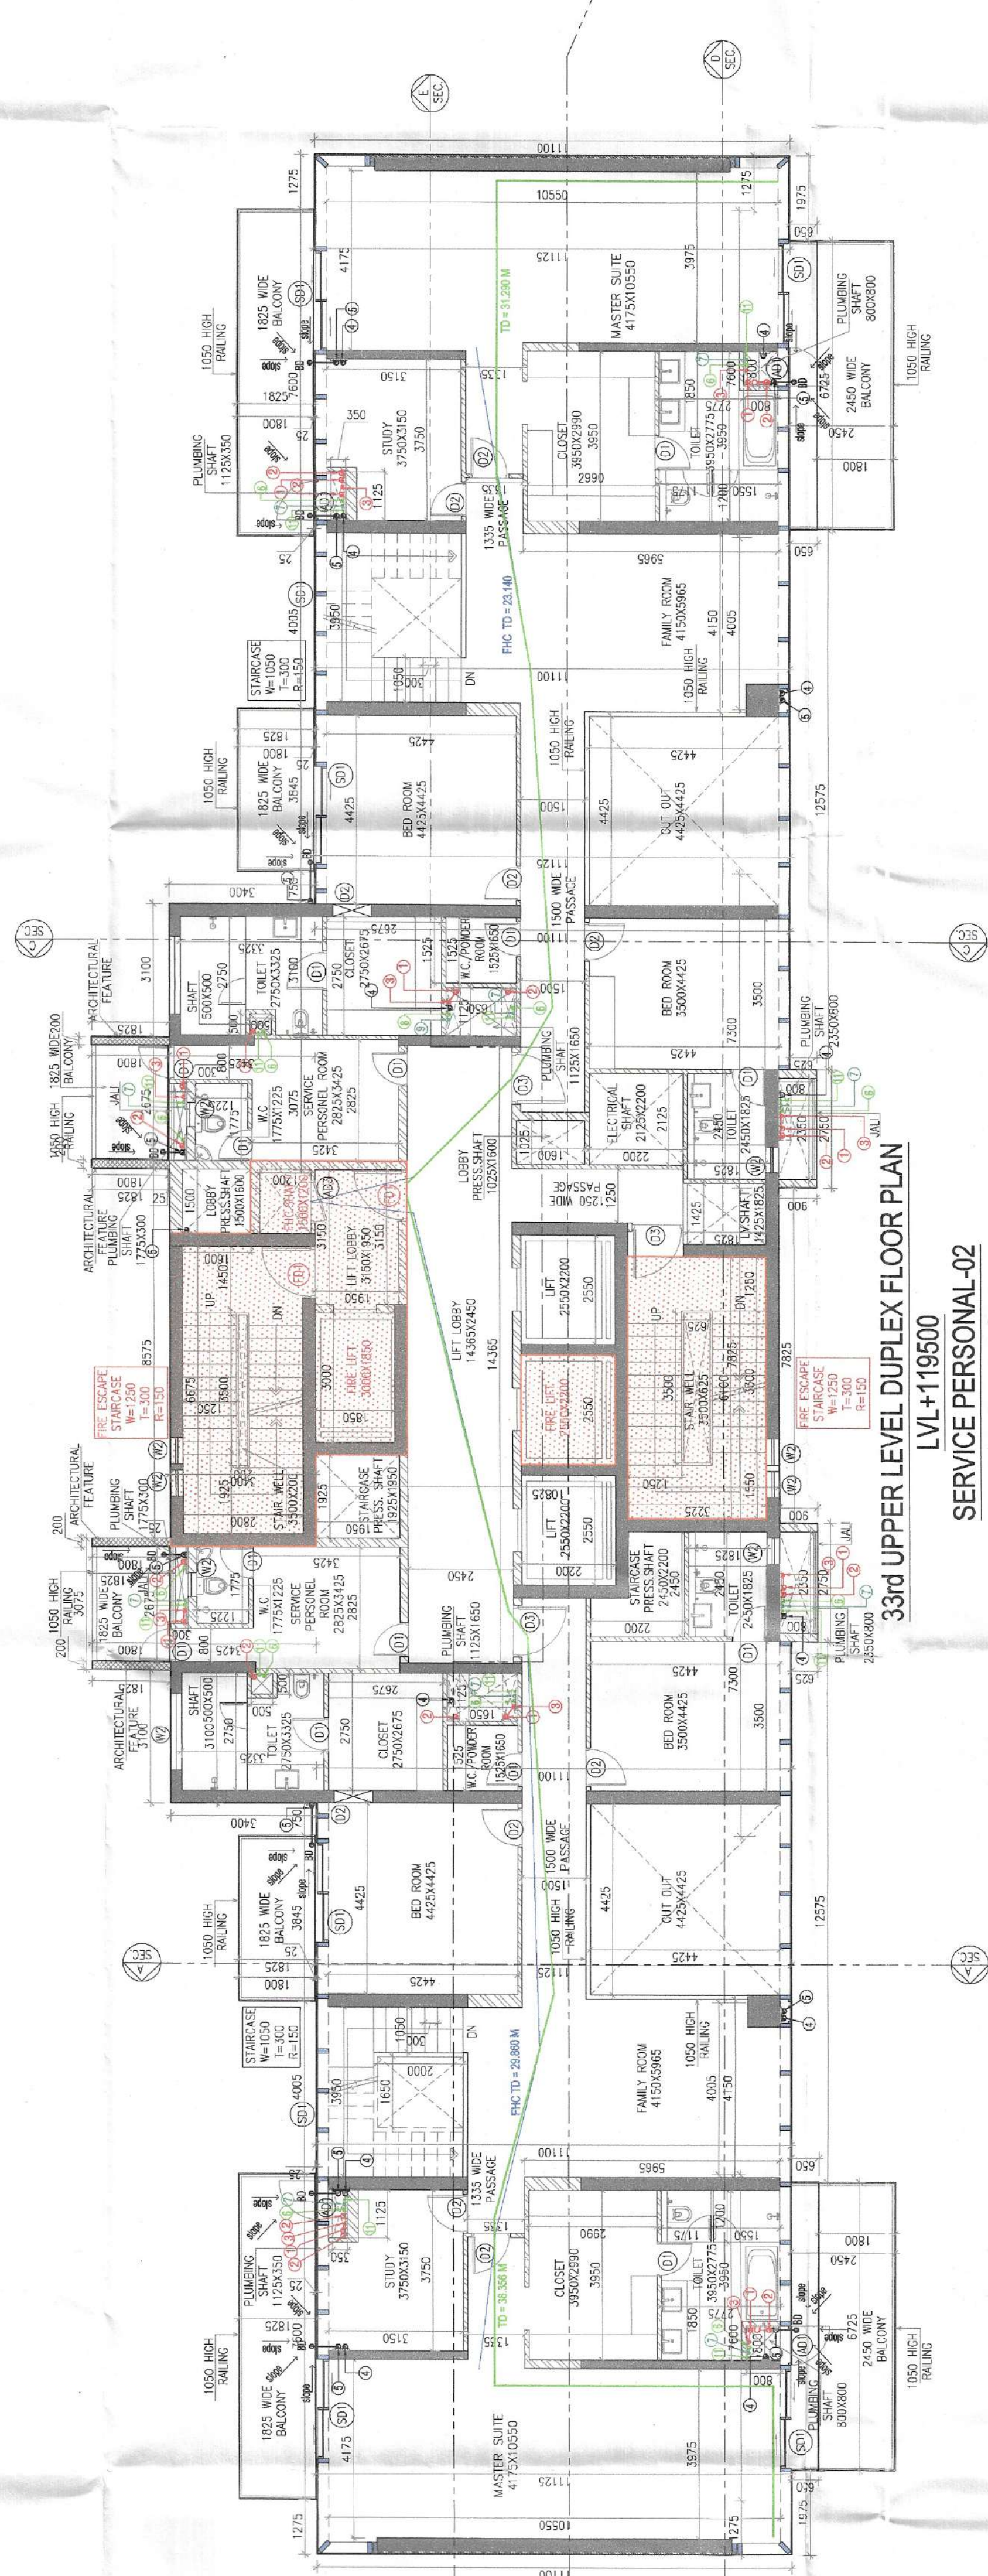

33rd UPPER LEVEL DUPLEX FLOOR PLAN