



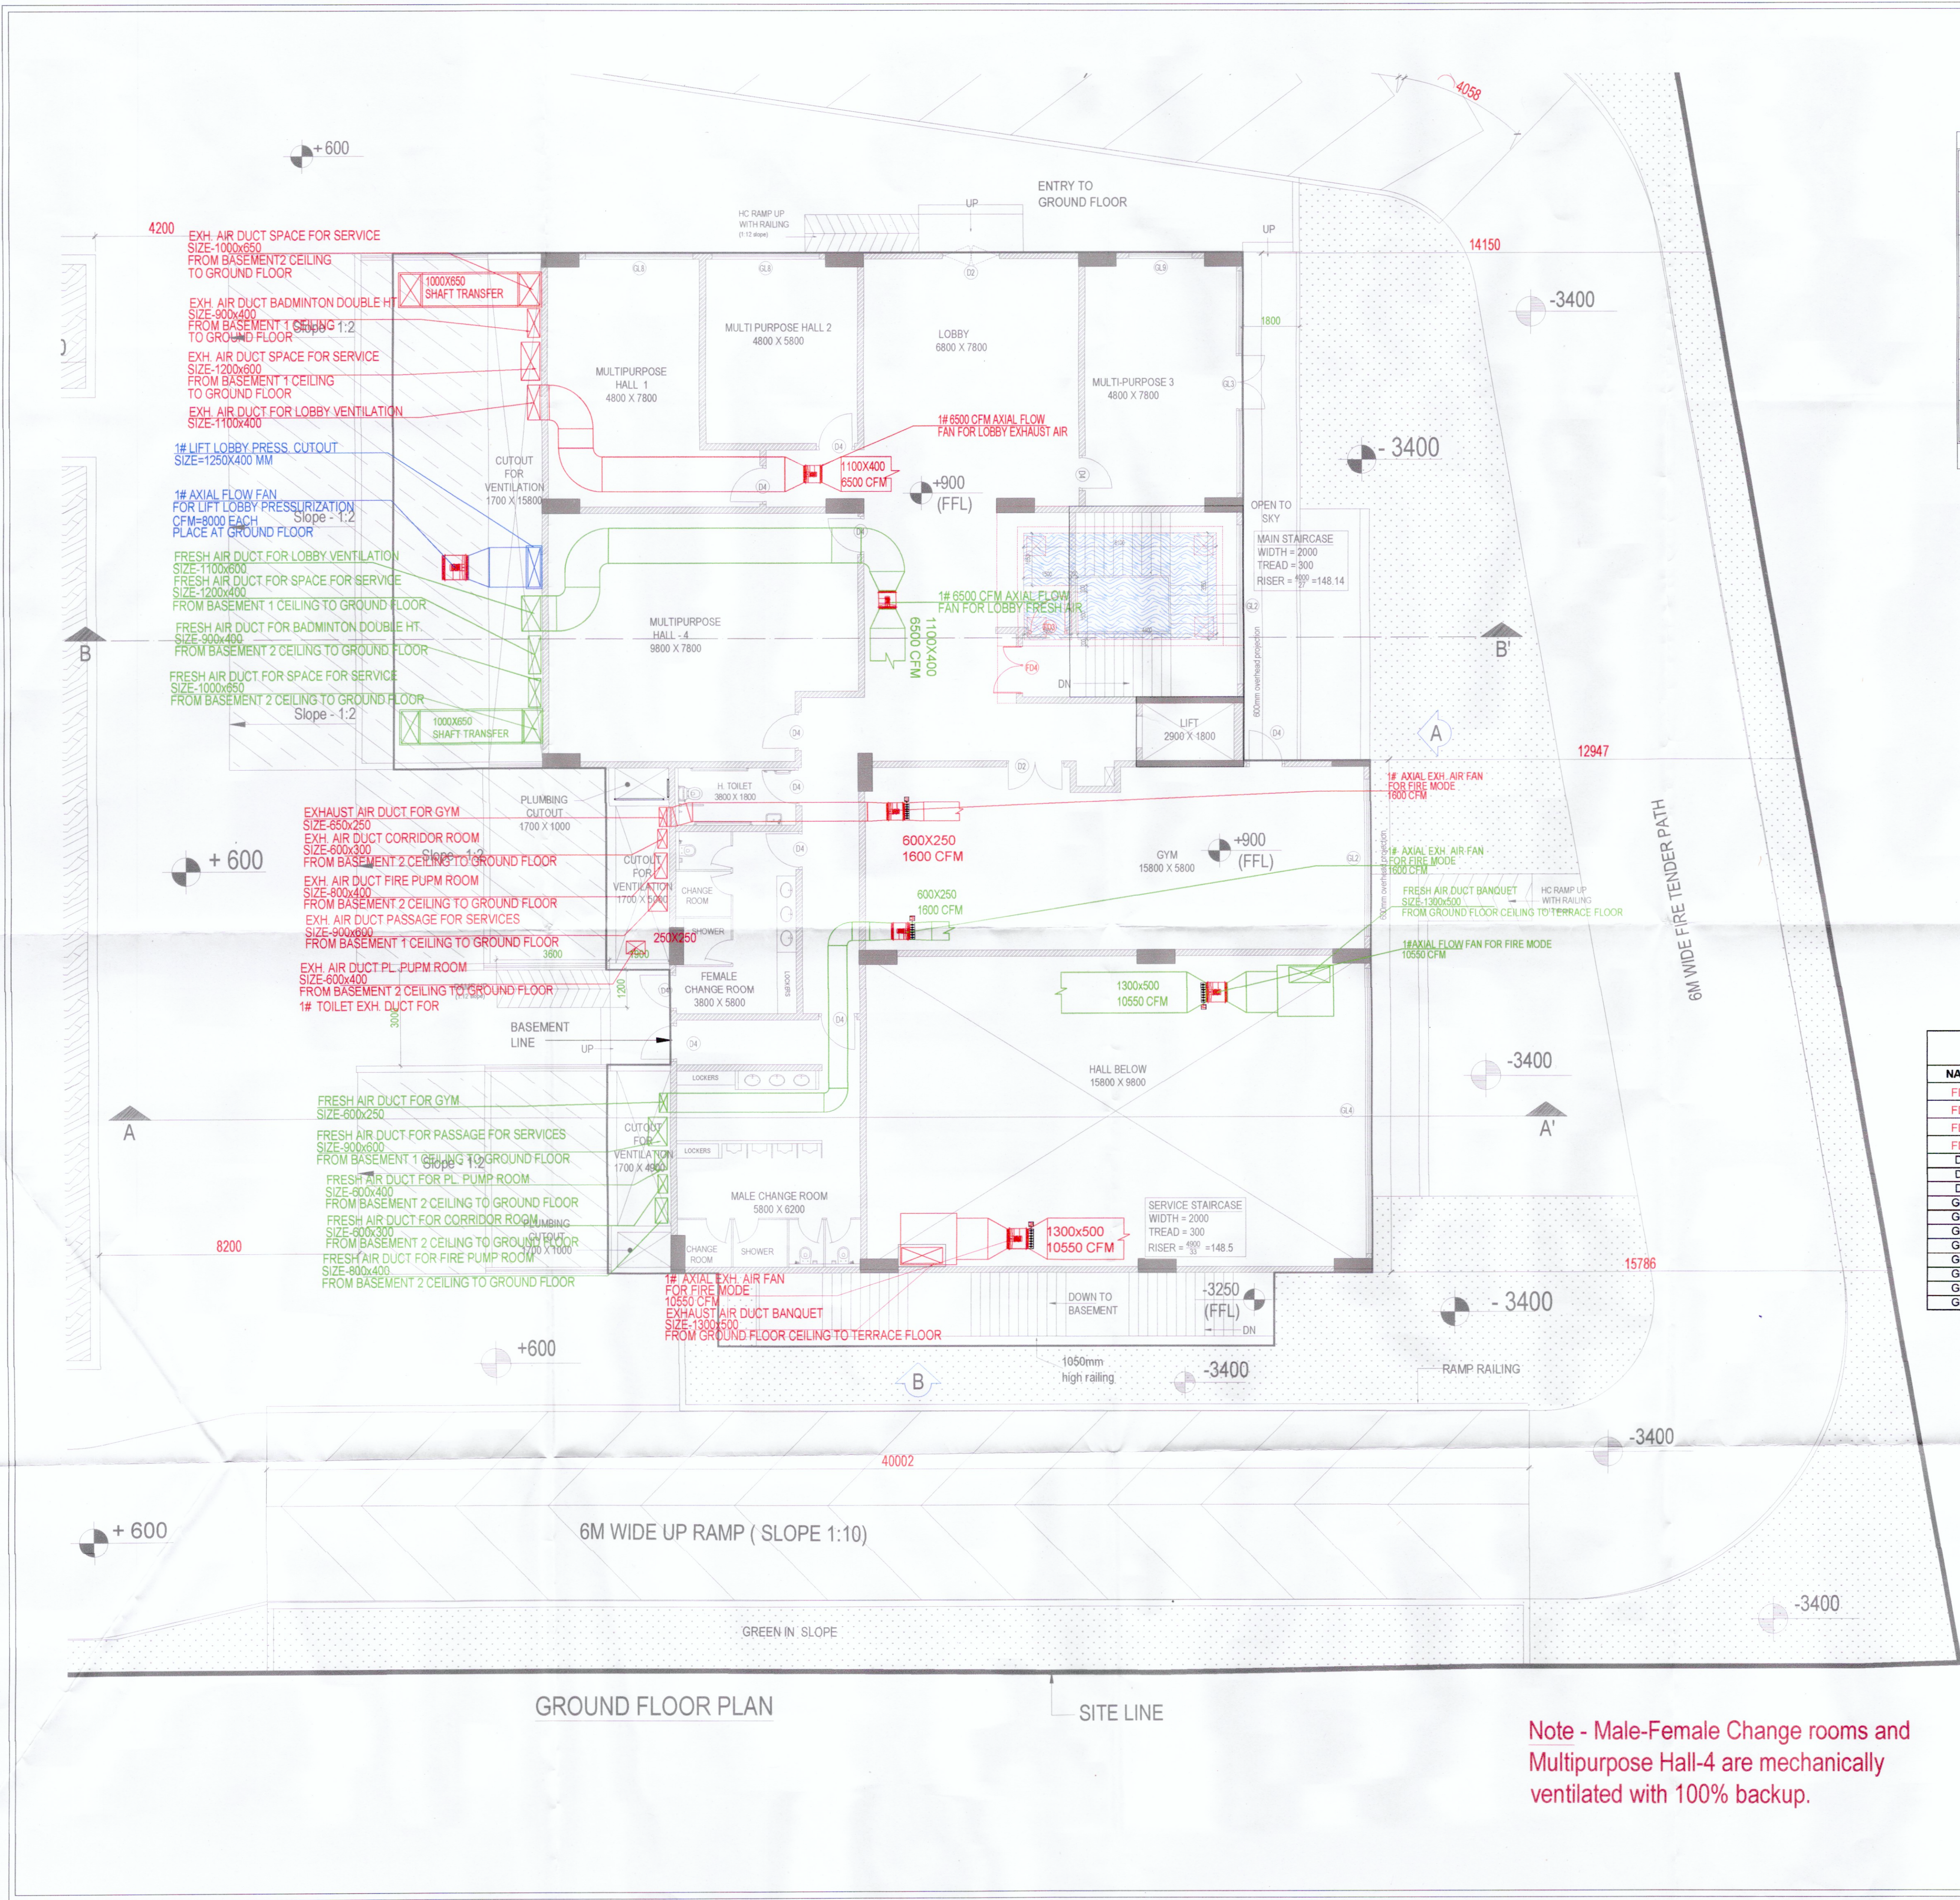

LEGEND		SYMBLE
1.	EXHAUST AIR CUTOUT	
2.	FRESH AIR CUTOUT	
3.	EXHAUST AIR DUCT	
4.	FRESH AIR DUCT	
5.	AXIAL FLOW FAN	
6.	AXIAL FLOW FAN	

COMMUNITY BUILDING - GROUND FLOOR VENTILATION											
GYM	91.8	880	5.1	7680	12	1587	1600	EXHAUST	1	AXIAL	FIRE + NORMAL MODE
							1600	SUPPLY	1		
LOBBY	157	1050	19	32109	12	8422	6000	EXHAUST	1	AXIAL	FIRE + NORMAL MODE
							6000	SUPPLY	1		
HALL BELOW	153	1047	32	52701	12	10540	10500	EXHAUST	1	AXIAL	FIRE + NORMAL MODE
							10500	SUPPLY	1		
TOILET		28	301	12	3617	10	603			600	

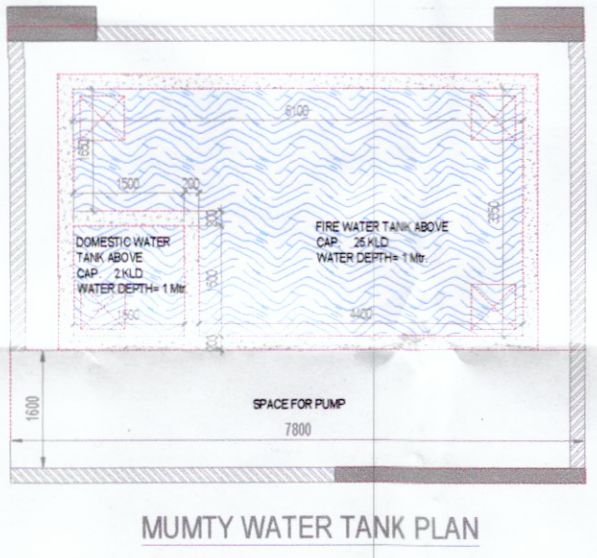

DOOR WINDOW SCHEDULE				
NAME	SIZE WxH (mm)	SILL (mm)	LINTEL (mm)	FIRE RATING
FD1	2000 x 2400	0	2400	2 HOURS FIRE RATED
FD2	2500 x 2400	0	2400	2 HOURS FIRE RATED
FD3	1200 x 2400	0	2400	2 HOURS FIRE RATED
FD4	1500 x 2400	0	2400	2 HOURS FIRE RATED
D1	2000 x 2400	0	2400	
D2	1800 x 2400	0	2400	
D4	1200 x 2400	0	2400	
GL1	5400 x 3000	0	3000	
GL2	5000 x 5400	0	5400	
GL3	7000 x 5400	0	5400	
GL4	9000 x 5400	0	5400	
GL5	5000 x 3000	0	3000	
GL6	7000 x 3000	0	3000	
GL7	9000 x 3000	0	3000	
GL8	3400 x 2400	0	2400	

AUTHORITY STAMP :

Fire Fighting Scheme Approved
Vide letter No. 73/2024-6
Dated 22/3/2024
Deputy Director (Tech.)

Certified that Fire Fighting Scheme is as per N.B.C. Part-IV, revised 2018

Sum Gurugram
FSO Gurugram
FSO Gurugram
b/m Gurugram

KEY PLAN :

ARCHITECT:-
rajeev agarwal architects
J-1853, chaitanyan park
new delhi - 110018
tel: 011-40525848
website: www.rajeevagarwal.com

STRUCTURE
NNC DESIGN INTERNATIONAL
C-106, 2nd Floor, Sector 77, Gurugram, Haryana
New Delhi - 110018
Tel: 011-40525848
Email: nncdesigninternational@gmail.com
www.nncdesigninternational.com

MEP Consultants
PDA
150, 2nd Floor, Sector 77, Gurugram
Haryana - 110018
Tel: 011-40525848
Email: pdaconsultants@gmail.com
www.pdaconsultants.com

PROJECT LANDSCAPE CONSULTANTS
Oracles | Plural Design Consultants
G-98 Kalkaji New Delhi 110 019
India | +91 11 2648 1530 | +91 98110 20590

PROJECT TITLE

Approval of revised building plans of Group Housing Colony area measuring 16.54 acres (license no. 67 of 2011 dated 16.07.2011), sector-77 Gurugram being developed by Jonpriya Build Estate Pvt.Ltd. & Others C/o Umang Realtech Pvt.Ltd.

ARCHITECT'S SIGNATURE / STAMP :
RAJEEV KUMAR AGARWAL
ARCHITECT CA/88/1915

OWNER SIGNATURE / STAMP :
KEYSTONE WORLD PRIVATE LTD.
Director/Authorised Signatory

DRAWING TITLE :
**COMMUNITY BUILDING
GROUND FLOOR
FIRE & VENTILATION LAYOUT**

SCALE
1:100 (A0)

DATE
15-02-2024

DRAWING NO.
PDA-173/VENT-GR-03

RELEASED FOR :
☐ INFORMATION
☐ EIA
☐ TENDER
☐ ADVANCE COPY
☒ SUBMISSION DRG
☐ GFC

Note - Male-Female Change rooms and Multipurpose Hall-4 are mechanically ventilated with 100% backup.