
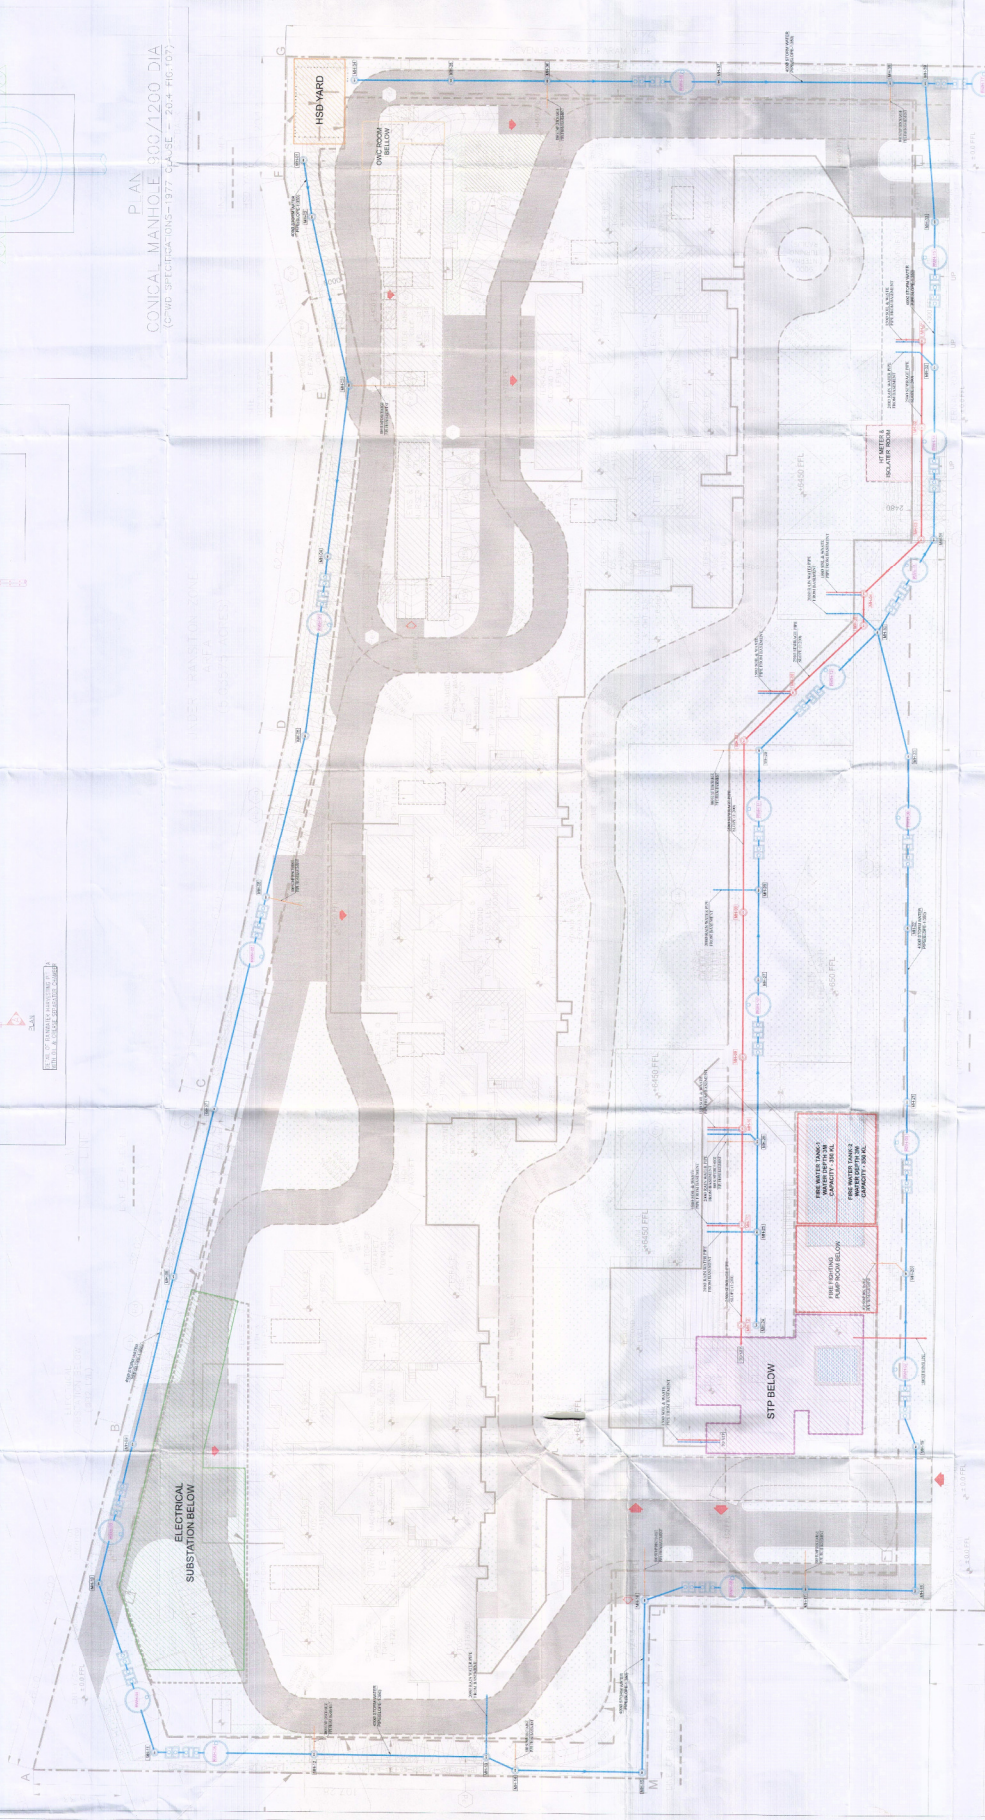
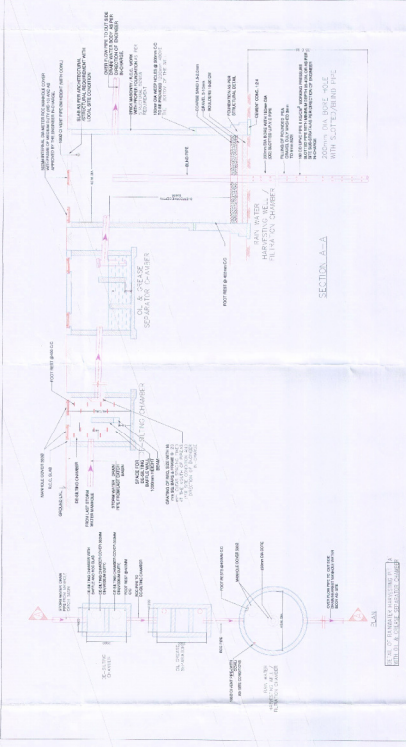


LEGEND-

S.NO	DESCRIPTION	SYMBOL
1	STORM WATER MANHOLE	MH
2	STORM WATER HARVESTING PIT	
2	SEWAGE MANHOLE	MH
3	SEWAGE LINE	

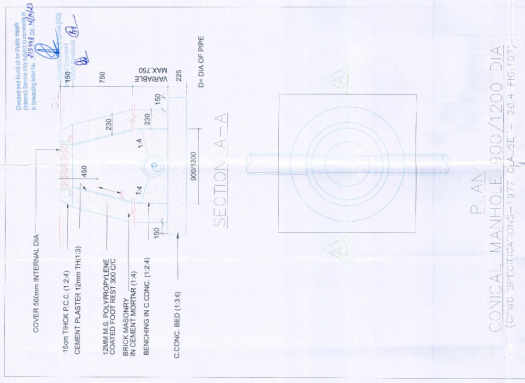

5 KARAM WIDE

RELATIVE TO KARAM WIDE

DRAWING TITLE:
SITE PLAN STORM WATER & SEWAGE LAYOUT
DATE: 22/08/2023
SCALE: 1:1000
REVISION: NO
DESIGNED BY: GR-SCV-PL-01-02
STATUS: SUBMISSION DRAWING

SERVICES CONSULTANTS:
SINELAC CONSULTANTS PVT LTD
 C-44/2, OHRA INDUSTRIAL AREA, PHASE II, NEW DELHI-110028 TEL: 2638510, 69203955 E-mail: sinelac@gmail.com

PROJECT NAME: CONSULTANT
PROJECT LOCATION: OHRA INDUSTRIAL AREA, PHASE II, NEW DELHI-110028
PROJECT DESCRIPTION: STORM WATER & SEWAGE LAYOUT
PROJECT DATE: 22/08/2023
PROJECT STATUS: SUBMISSION DRAWING

PROJECT NAME: CONSULTANT
PROJECT LOCATION: OHRA INDUSTRIAL AREA, PHASE II, NEW DELHI-110028
PROJECT DESCRIPTION: STORM WATER & SEWAGE LAYOUT
PROJECT DATE: 22/08/2023
PROJECT STATUS: SUBMISSION DRAWING

PROJECT NAME: CONSULTANT
PROJECT LOCATION: OHRA INDUSTRIAL AREA, PHASE II, NEW DELHI-110028
PROJECT DESCRIPTION: STORM WATER & SEWAGE LAYOUT
PROJECT DATE: 22/08/2023
PROJECT STATUS: SUBMISSION DRAWING

PROJECT NAME: CONSULTANT
PROJECT LOCATION: OHRA INDUSTRIAL AREA, PHASE II, NEW DELHI-110028
PROJECT DESCRIPTION: STORM WATER & SEWAGE LAYOUT
PROJECT DATE: 22/08/2023
PROJECT STATUS: SUBMISSION DRAWING

PROJECT NAME: CONSULTANT
PROJECT LOCATION: OHRA INDUSTRIAL AREA, PHASE II, NEW DELHI-110028
PROJECT DESCRIPTION: STORM WATER & SEWAGE LAYOUT
PROJECT DATE: 22/08/2023
PROJECT STATUS: SUBMISSION DRAWING