


D.T.P. (HQ) S.T.P. (HQ) S.T.P. (G) C.T.P. (G)
Member B.P.A.C. Member B.P.A.C. Member B.P.A.C. Chairman B.P.A.C.
Architect (HQ) ATP (HQ) (Dinesh Kumar) PA (HQ)

SANCTIONED
TO BE READ WITH THIS OFFICE
MEMO NO.: 26034
DATED: 09/08/23

Checked and found ok for Public Health
(Internal) Service only subject to comments in
in forwarding letter No. 11378.DV.23.01.2023

Superintendent Engineer (HQ)
for Chief Engineer-I
HIS/16/23
21/6/23

DD (H)
MEMBER
B.P.A.C.

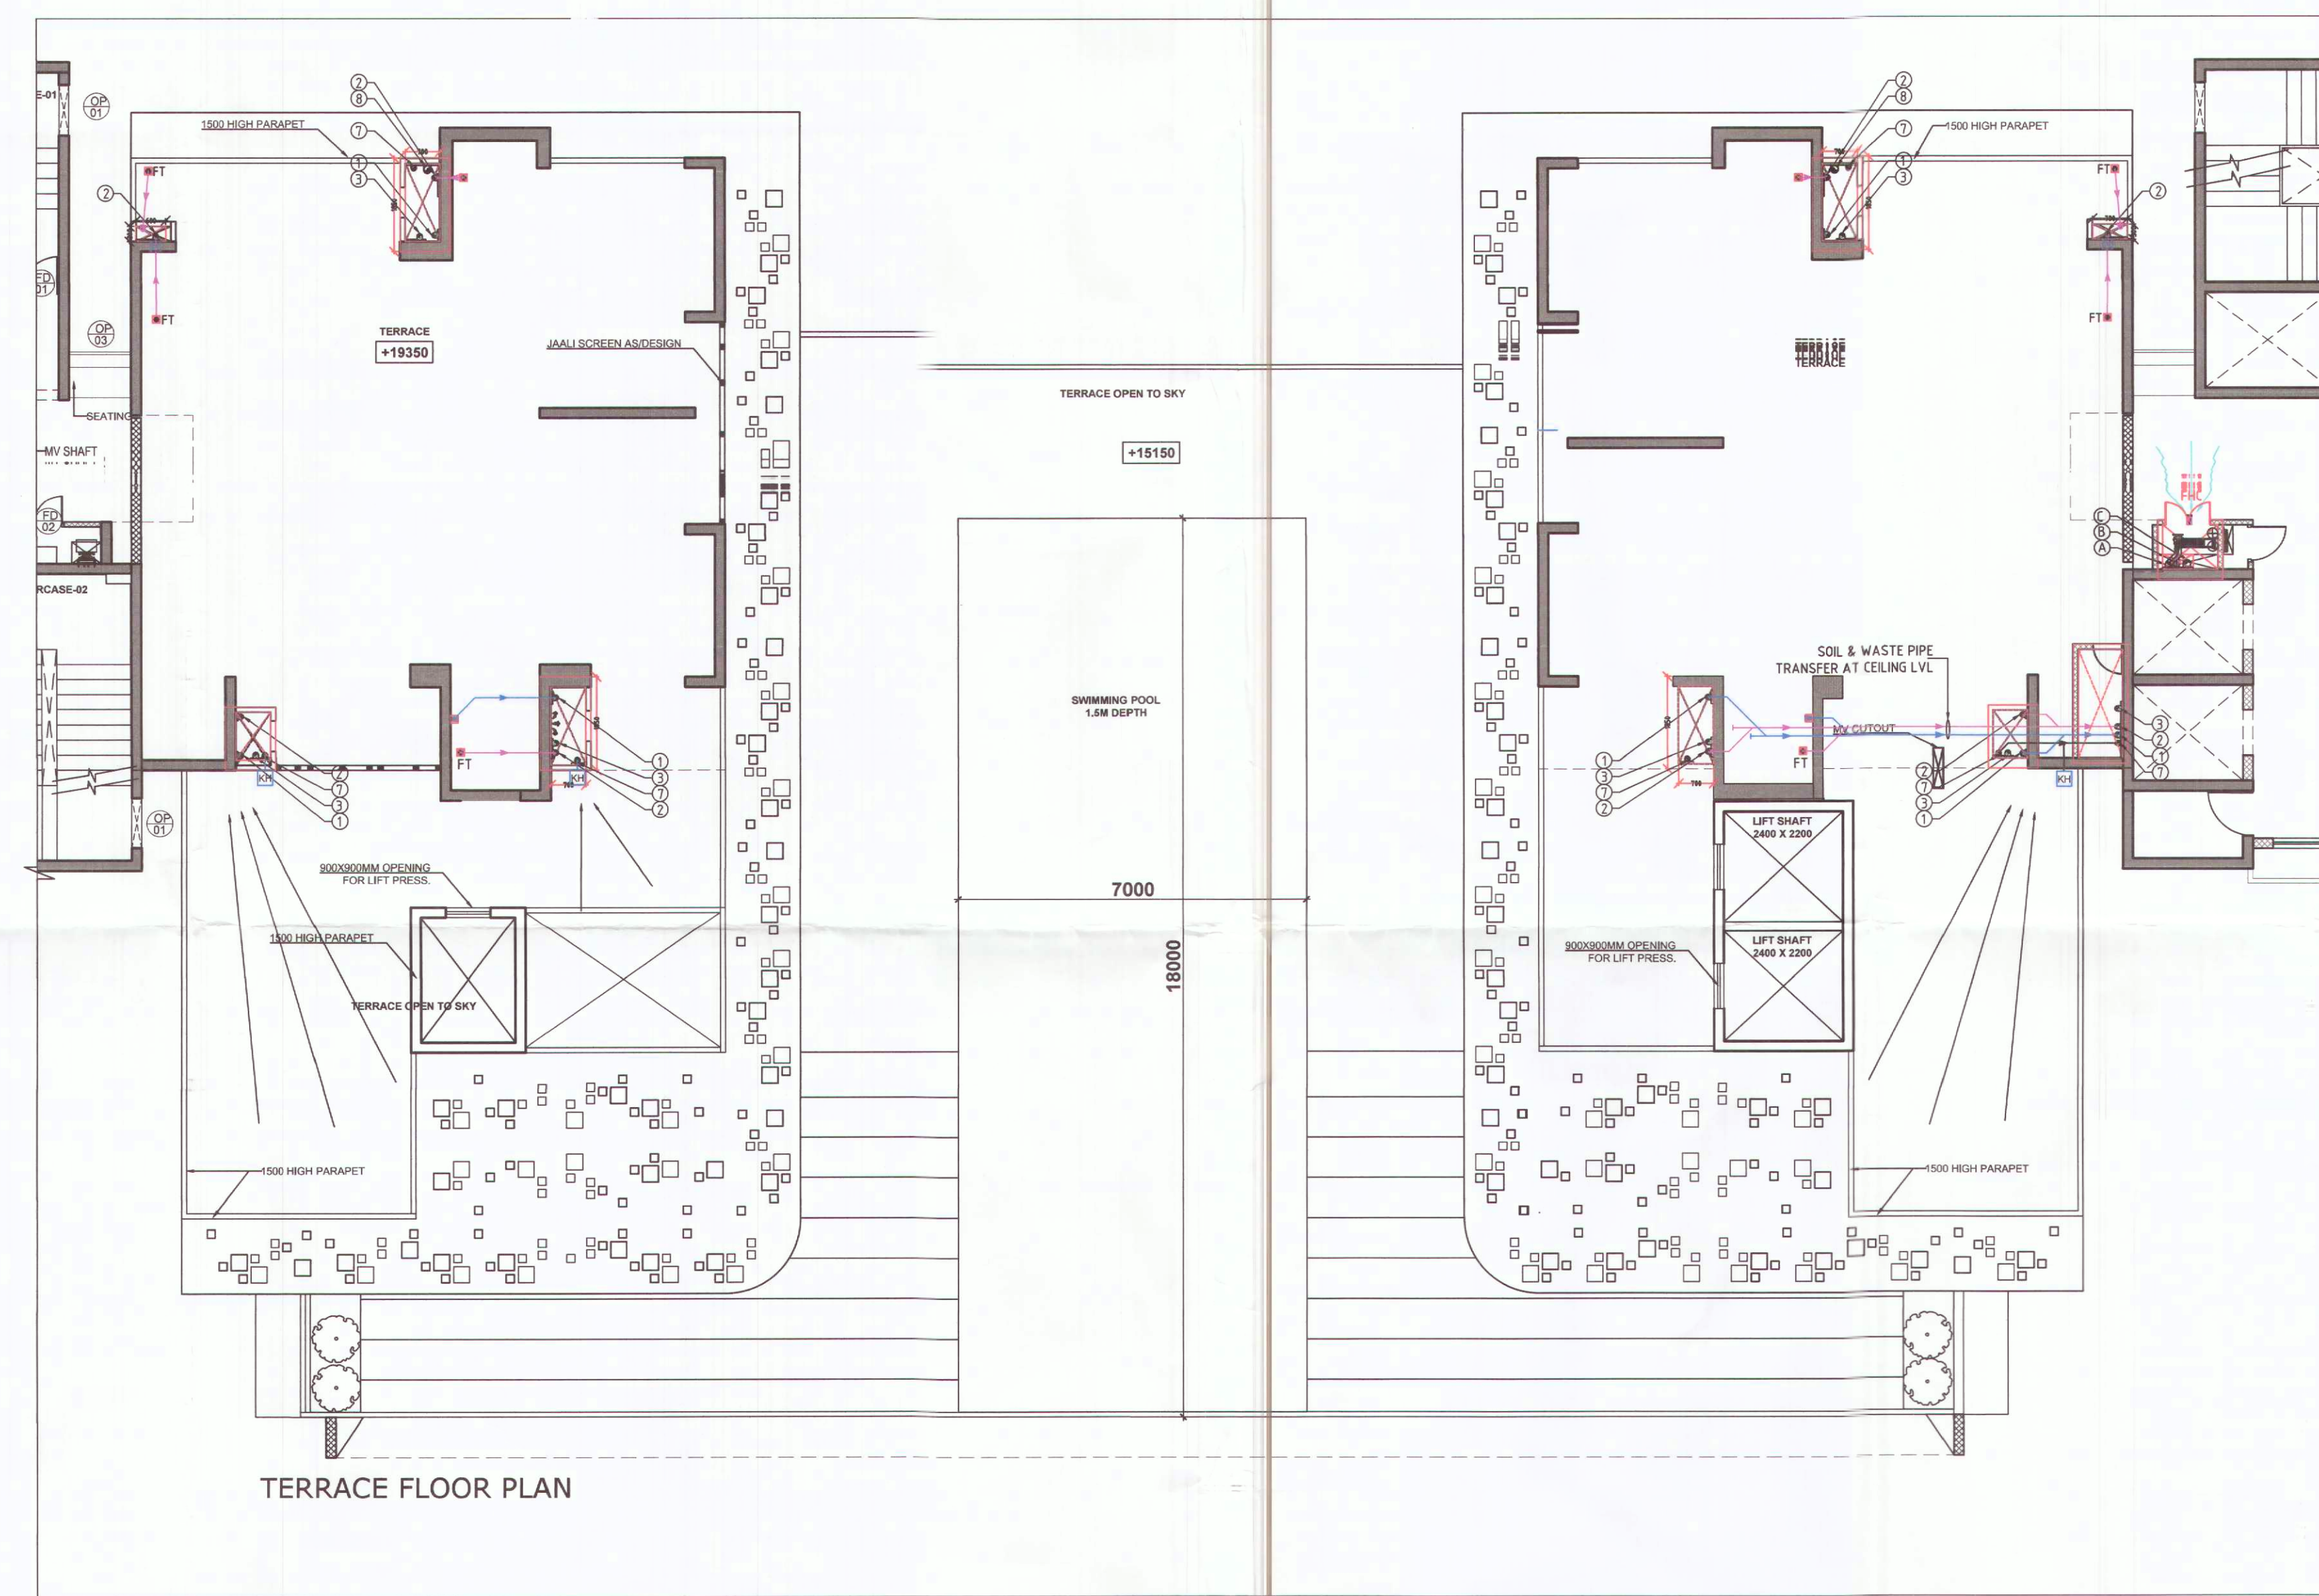

PLUMBING LEGEND-		
S.NO.	DESCRIPTION	SYMBOL
1.	110 OD uPVC VERTICAL SOIL & WASTE PIPE	①
2.	110 OD uPVC VERTICAL SOIL & WASTE PIPE	②
3.	90 OD uPVC ANTISEPTIC WASTE & VENT PIPE	③
4.	DOMESTIC WATER SUPPLY PIPE	④
5.	FLUSHING WATER SUPPLY PIPE	⑤
6.	90 OD uPVC RAIN WATER PIPE FOR BALCONY	⑥
7.	160 OD uPVC RAIN WATER PIPE FOR TERRACE	⑦
8.	DOMESTIC WATER SUPPLY RISER PIPE	⑧
9.	FLUSHING WATER SUPPLY RISER PIPE	⑨
10.	FLOOR TRAP	FT
11.	FLOOR DRAIN	FD
12.	URINAL TRAP	UT
13.	ACCESS DOOR	AD
14.	450X150 mm KHURRA	KH

PIPE SCHEDULE	
DESCRIPTION	SIZE
PIPE DIA FROM FT TO VERTICAL STACK	110 OD uPVC
PIPE DIA FROM WC TO VERTICAL STACK	110 OD uPVC
PIPE DIA FROM FD TO FT	63 OD uPVC
PIPE DIA FROM WB TO FT	40 OD uPVC
PIPE DIA FROM KITCHEN SINK TO FT	50 OD uPVC

SCHEDULE OF FLOOR CUTOUTS		
S.NO.	DESCRIPTION	SIZE OF CUTOUT
1.	CUTOUT FOR WATER CLOSET OUTLET PIPE	150X150mm
2.	CUTOUT FOR FLOOR TRAP OUTLET PIPE	150X150mm

A	1000 WET RISER PIPE
B	800 DRAIN PIPE
C	1500 SPRINKLER PIPE
FHC	FIRE HOSE CABINET

PROPOSED GROUP HOUSING UNDER
RETIREMENT HOUSING POLICY AREA 2.60
ACRES, IN SECTOR 50, GURUGRAM
LIC NO. 1610C 2007 DT. 7.10.2022
PIONEER J.K SENIOR LIVING LLP

COMMUNITY FACILITY-
TERRACE FLOOR PLAN
PLUMBING LAYOUT

DRG.NO. M-CF-2.6
SCALE : 1:100
DATE : 27.12.2022
DEALT : SIMRAN

ARCHITECT:
GAMRAJ SANAN
CA Registration No. CA/99/25531
ARCHITECTS SIGN.

NORTH

For PIONEER J.K SENIOR LIVING LLP
Authorized Signatory