



6.0 M WIDE GREEN MOTORABLE FIRE TENDER PATH

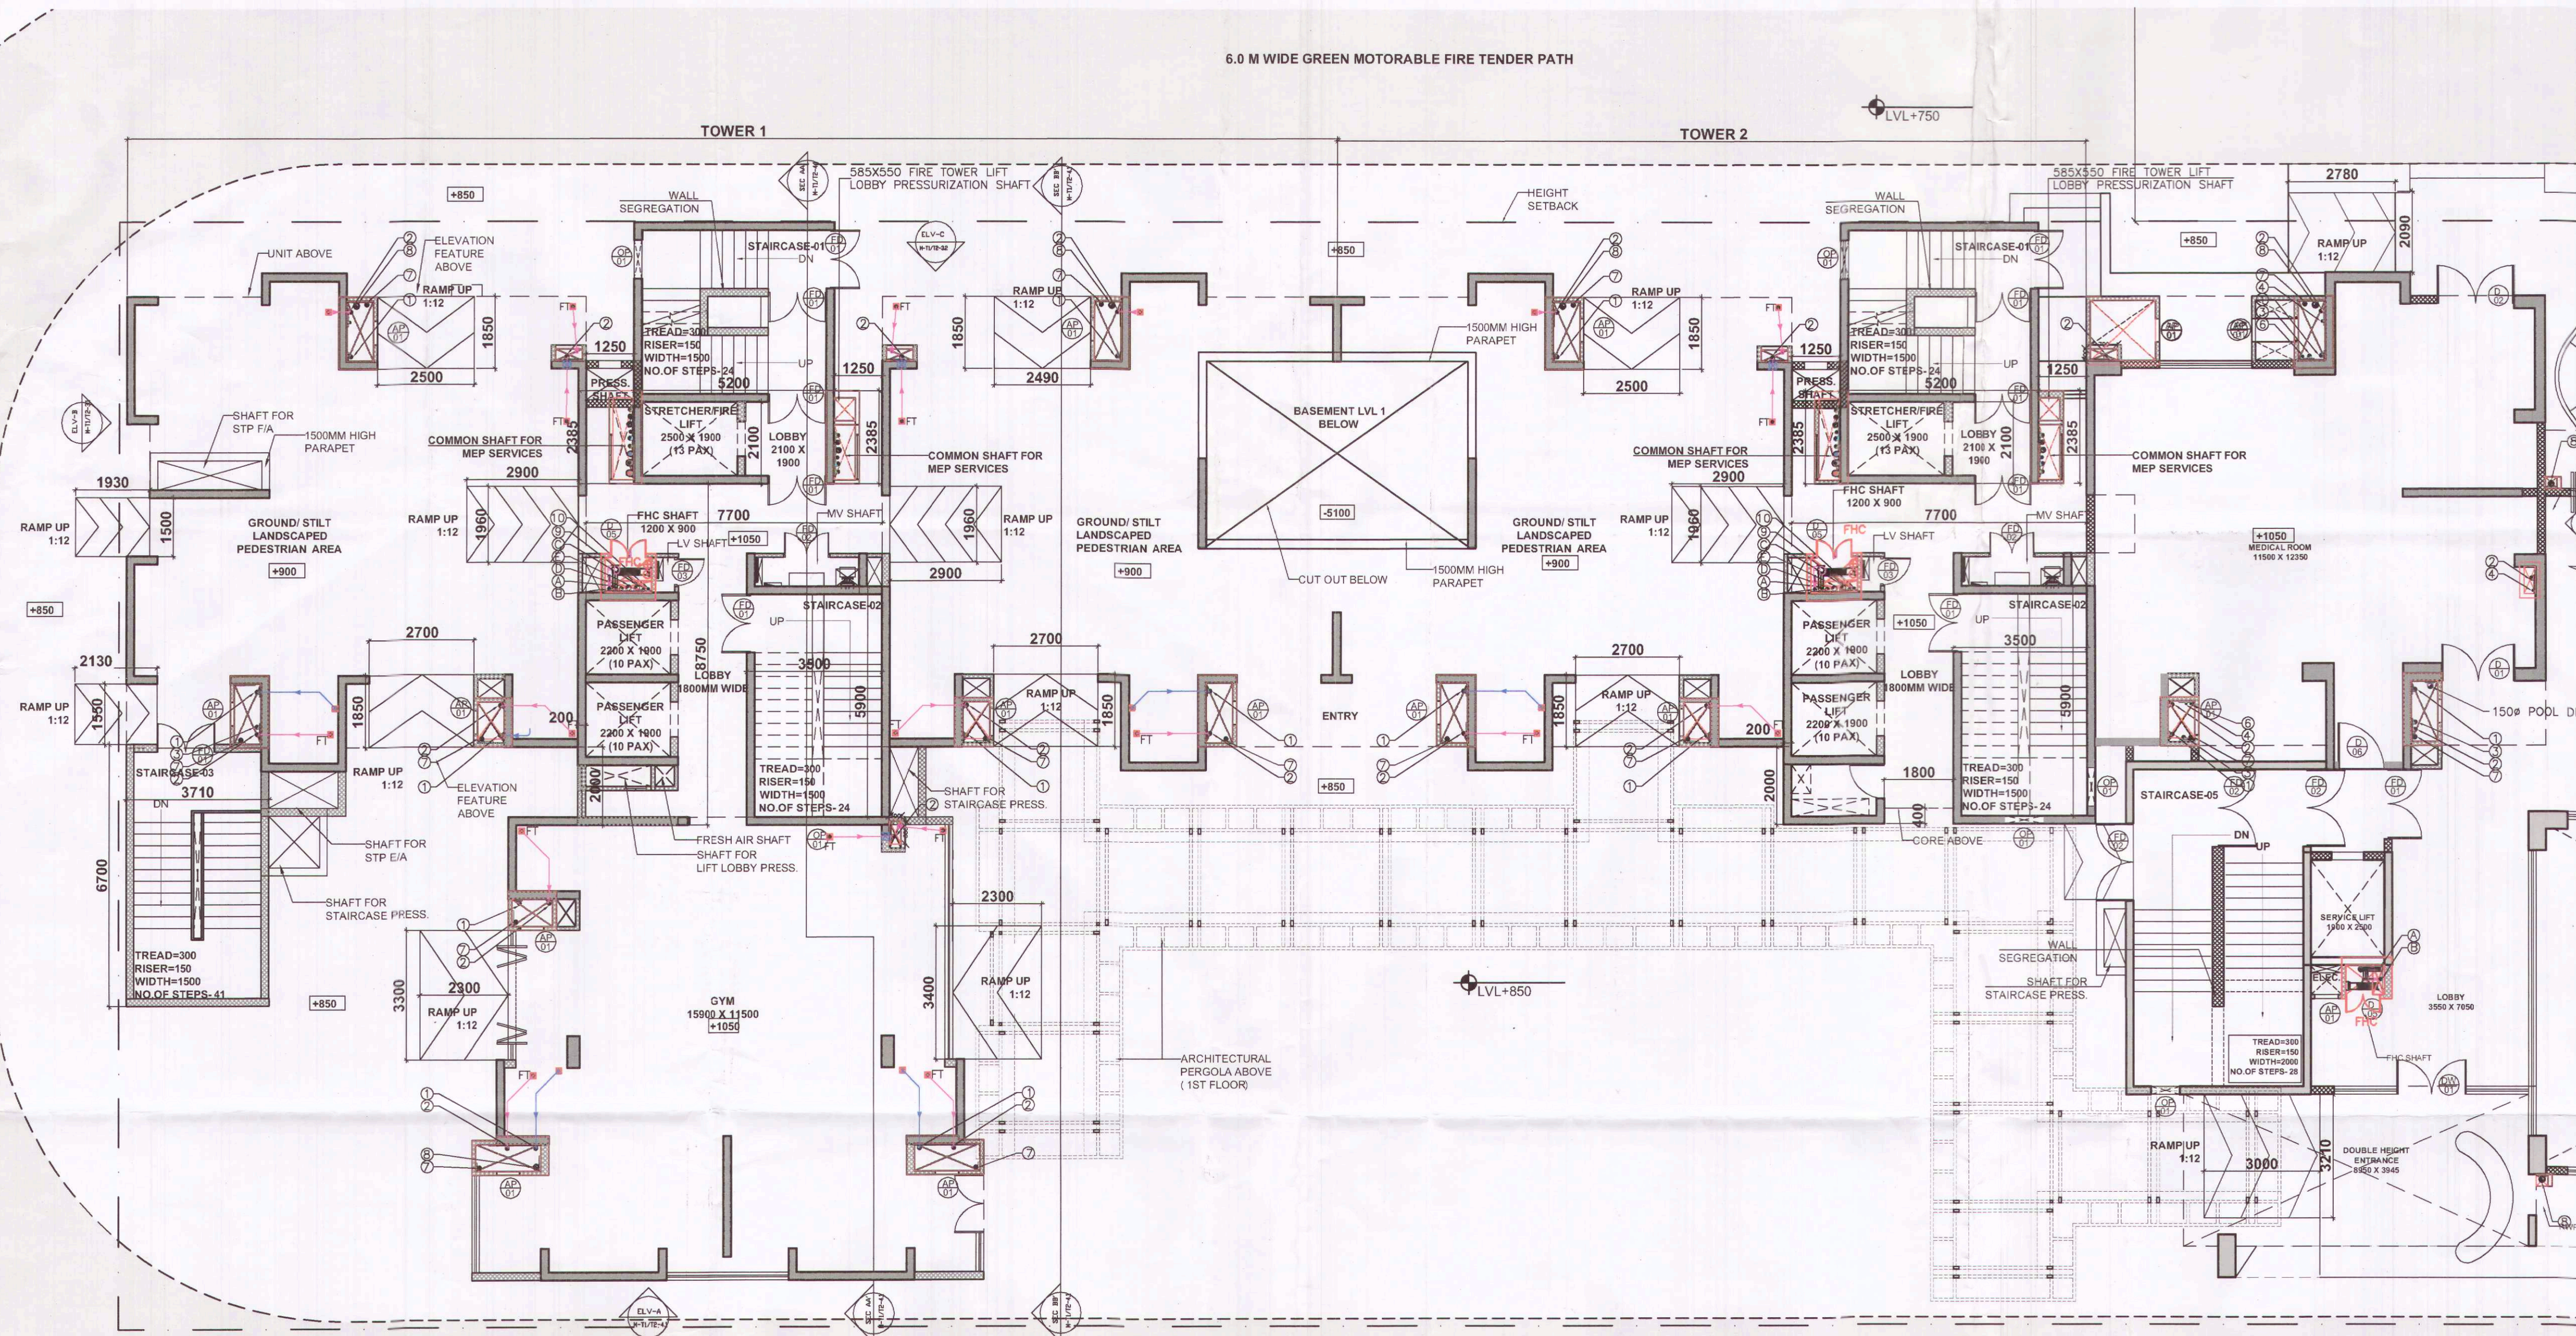

GROUND/STILT FLOOR PLAN


6.0 M WIDE GREEN MOTORABLE FIRE TENDER PATH

TOWER 1

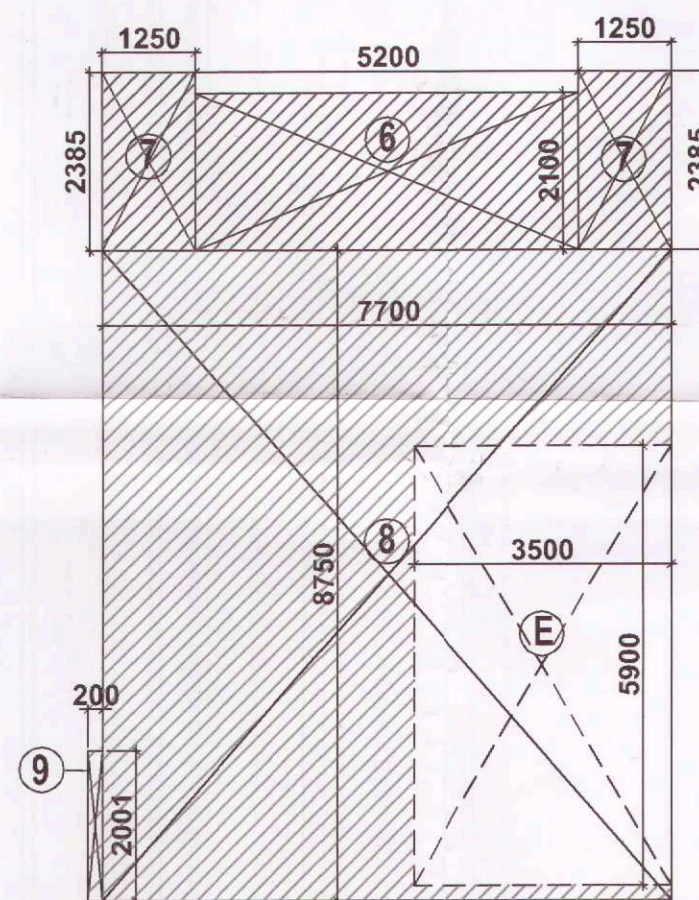

GROUND/STILT FLOOR- FAR CALCULATION PLAN

TOWER 2

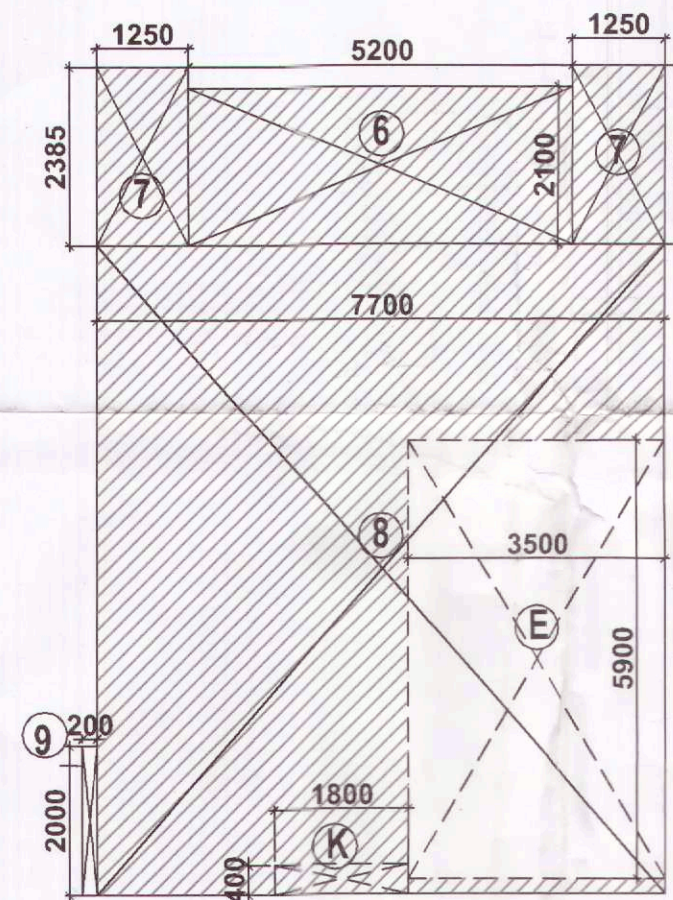

Checked and found ok for Public Health
(Internal) Service only subject to comments in
in forwarding letter No. 11378.....DN.23/1/2023

Superintending Engineer (HQ)
for Chief Engineer-4
HSVP, Panchkula
21/6/23

ATP(HQ) S.T.P(HQ) S.T.P(G) S.T.P(Hr)
Member Member Secretary Member Chairman
B.P.A.C. B.P.A.C. B.P.A.C. B.P.A.C.
Architect (HQ) (Dinesh Kumar) PA(HQ)
DOT(HQ) Member BPAC

PIPE SCHEDULE
DESCRIPTION SIZE
PIPE DIA FROM FT TO VERTICAL STACK 110 OD uPVC
PIPE DIA FROM WC TO VERTICAL STACK 110 OD uPVC
PIPE DIA FROM FD TO FT 63 OD uPVC
PIPE DIA FROM WB TO FT 40 OD uPVC
PIPE DIA FROM KITCHEN SINK TO FT 50 OD uPVC

SANCTIONED
TO BE READ WITH THIS OFFICE
MEMO NO. 26024
DATE: 09-08-20

SCHEDULE OF FLOOR CUTOUTS

S.NO.	DESCRIPTION	SIZE OF CUTOUT
1.	CUTOUT FOR WATER CLOSET OUTLET PIPE	150X150mm
2.	CUTOUT FOR FLOOR TRAP OUTLET PIPE	150X150mm

FIRE FIGHTING LEGEND:-

A	100# FIRE HYDRANT PIPE LOW ZONE
B	80# DRAIN PIPE
C	150# SPRINKLER PIPE LOW ZONE
D	100# FIRE HYDRANT PIPE HIGH ZONE
E	150# SPRINKLER PIPE HIGH ZONE
FHC	FIRE HOSE CABINET

TOWER 1/2/3/4

DOOR/ WINDOW	ROUGH OPENING	SILL	LINTEL
D01	1200X2400	-	2400
D02	1050X2400	-	2400
D03	800X2400	-	2400
D04	900X2400	-	2400
D05	900X2100	300	2400
D06	1000X2400	-	2400
D07	1200X2400	-	2400
FD01	1500X2400	-	2400
FD02	1200X2100	300	2400
FD03	750X2100	300	2400
DW01	1900X2400	-	2400
DW02	1800X2400	-	2400
DW03	-	-	-
DW04	-	-	-
W01	1900X1800	600	2400
W02	800X1800	600	2400
W03	600X1200	1200	2400
W04	600X1300	1100	2400
W05	700X1300	1100	2400
W06	1000X1300	1100	2400
W07	500X2300	100	2400
OP01	1000X1300	1100	2400

PLUMBING LEGEND:-

S.NO.	DESCRIPTION	SYMBOL
1.	160 OD uPVC VERTICAL SOIL & VENT PIPE	①
2.	160 OD uPVC VERTICAL WASTE & VENT PIPE	②
3.	110 OD uPVC VERTICAL SOIL & VENT PIPE	③
4.	110 OD uPVC VERTICAL WASTE & VENT PIPE	④
5.	90 OD uPVC ANTISYPHONIC PIPE	⑤
6.	DOMESTIC WATER SUPPLY DOWN TAKE PIPE	⑥
7.	DOMESTIC WATER SUPPLY PIPE (BOOSTED)	⑦
8.	FLUSHING WATER SUPPLY DOWN TAKE PIPE	⑧
9.	90 OD uPVC RAIN WATER PIPE FOR TERRACE	⑨
10.	160 OD uPVC RAIN WATER PIPE FOR TERRACE	⑩
11.	40# DOMESTIC WATER SUPPLY RISER PIPE	⑪
12.	32# FLUSHING WATER SUPPLY RISER PIPE	⑫
13.	FLOOR TRAP	FT
14.	FLOOR DRAIN	FD
15.	MULTI TRAP	MT
16.	ACCESS DOOR	AD
17.	FLOOR CLEAN OUT	FCO
18.	DOMESTIC WATER SUPPLY	DWS
19.	FLUSHING WATER SUPPLY	FWS

NOTE- 1.ALL DWELLING UNIT MAIN DOOR
TO BE ONE HOUR FIRE RATED DOOR
NATURAL LIGHT &
VENTILATION UNITS ARE ALSO
MECHANICALLY LIT & VENTILATED.

PROPOSED GROUP HOUSING UNDER
RETIREMENT HOUSING POLICY AREA 2.60
ACRES, IN SECTOR 50, GURUGRAM
(LIC.NO.161 OF 2022 DT.07.10.2022
PIONEER J.K. SENIOR LIVING LLP)

T1/T2-GROUND/STILT
FLOOR PLAN-
FAR CALCULATION PLAN

DRG.NO. M-T1/T2-2.2

SCALE : 1:100

DATE : 09.06.2023

DEALT : SIMRAN

OWNER'S SIGN

CA Registration No. CA/99/25551

ARCHITECT'S SIGN

