



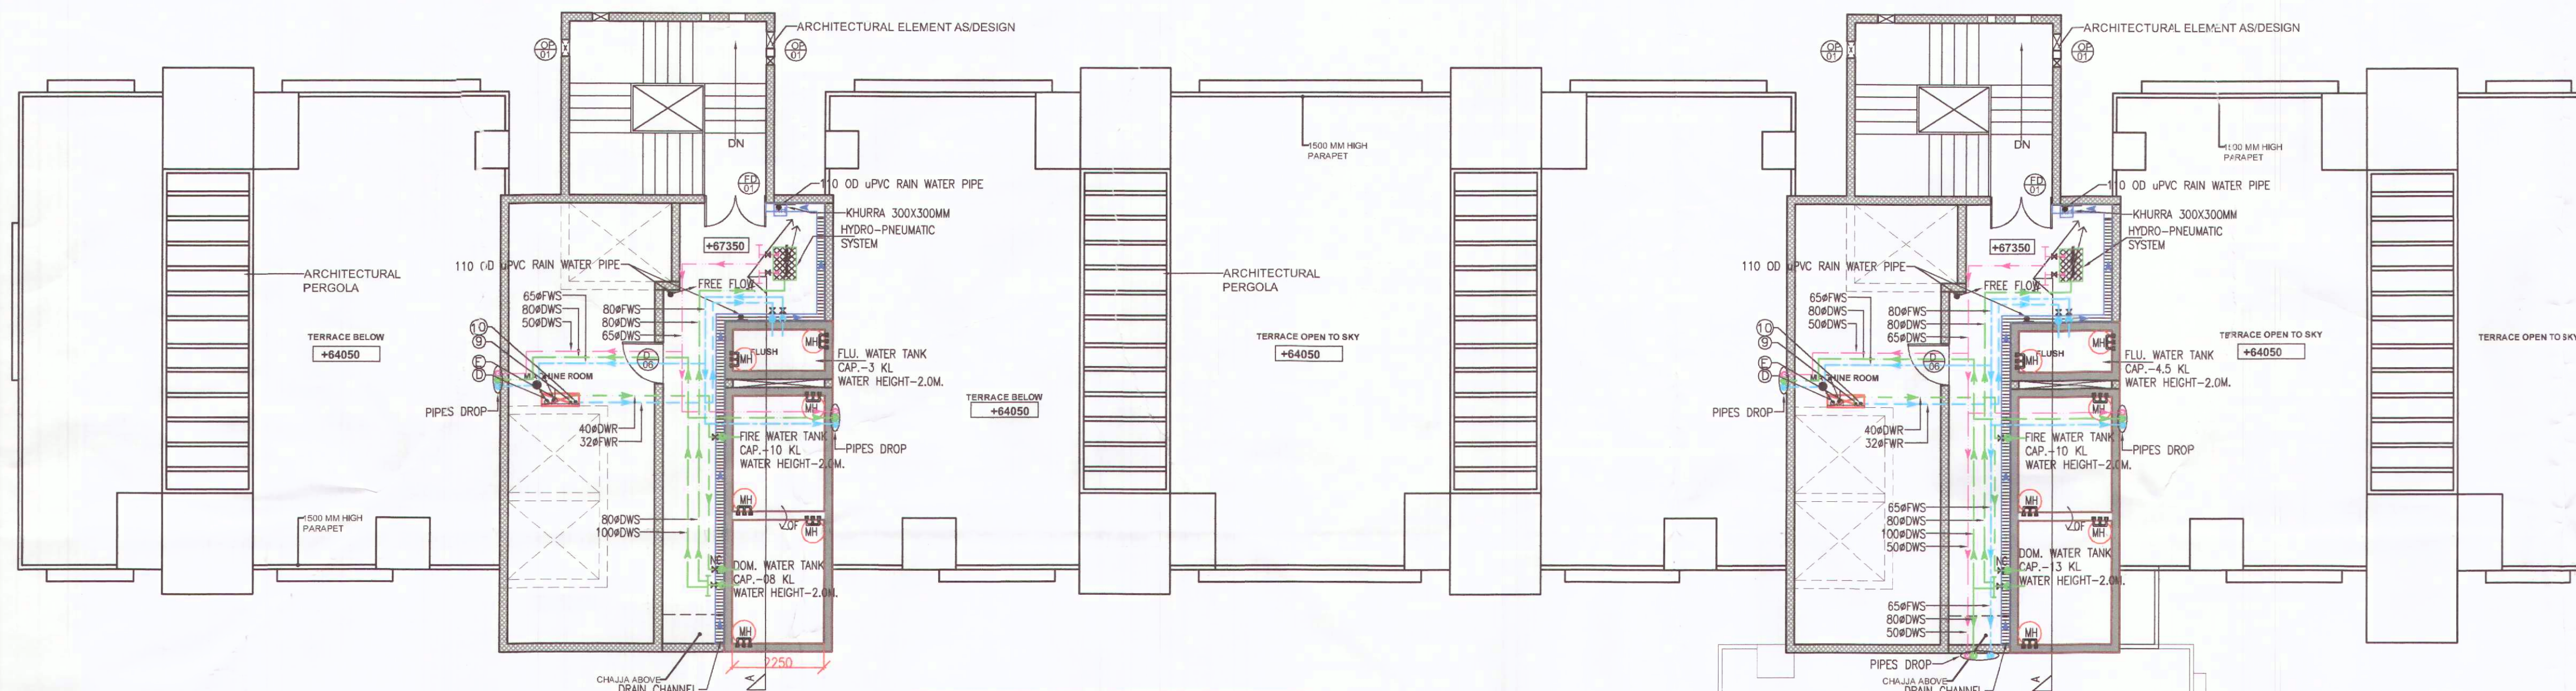

S.NO.	DESCRIPTION	SYMBOL
1.	160 OD uPVC VERTICAL SOIL & VENT PIPE	①
2.	160 OD uPVC VERTICAL WASTE & VENT PIPE	②
3.	110 OD uPVC VERTICAL SOIL & VENT PIPE	③
4.	110 OD uPVC VERTICAL WASTE & VENT PIPE	④
5.	90 OD uPVC ANTISYPHONIC PIPE	⑤
6.	DOMESTIC WATER SUPPLY DOWN TAKE PIPE	⑥
7.	DOMESTIC WATER SUPPLY PIPE (BOOSTED)	⑦
8.	FLUSHING WATER SUPPLY DOWN TAKE PIPE	⑧
9.	90 OD uPVC RAIN WATER PIPE FOR BALCONY	⑨
10.	160 OD uPVC RAIN WATER PIPE FOR TERRACE	⑩
11.	40# DOMESTIC WATER SUPPLY RISER PIPE	⑪
12.	32# FLUSHING WATER SUPPLY RISER PIPE	⑫
13.	DOMESTIC WATER SUPPLY	DWS
14.	FLUSHING WATER SUPPLY	FWS
15.	DOMESTIC WATER RISER	DWR
16.	FLUSHING WATER RISER	FWR
17.	BALL VALVE/BUTTER FLY VALVE	M

FIRE FIGHTING LEGEND:-	
A	100# FIRE HYDRANT PIPE LOW ZONE
B	80# DRAIN PIPE
C	150# SPRINKLER PIPE LOW ZONE
D	100# FIRE HYDRANT PIPE HIGH ZONE
E	150# SPRINKLER PIPE HIGH ZONE
FHC	FIRE HOSE CABINET

MACHINE LEVEL PLAN

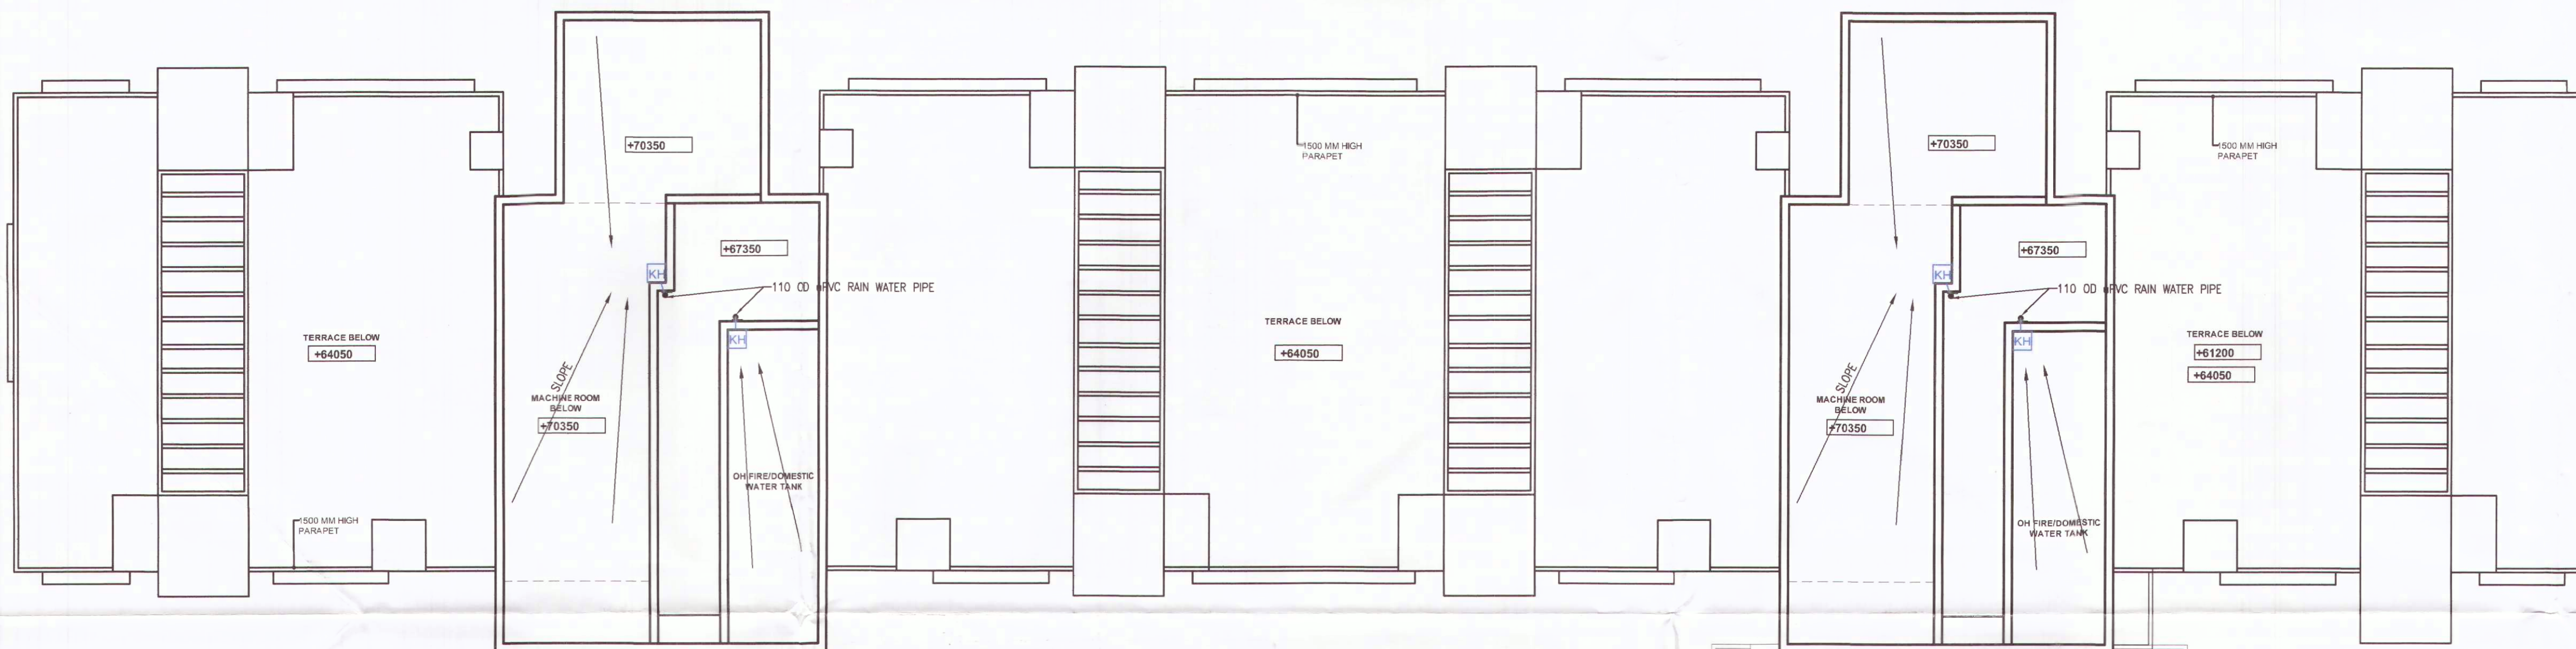

ROOF PLAN

Checked and found ok for Public Health
(Internal) Service only subject to comments in
in forwarding letter No. 11378.....Dt. 23/1/2023

Superintending Engineer (HC)
for Civil Engineer-I
HSV, Dhanikuta
21/1/23
SOPW-1

NOTE- ALL DWELLING UNIT MAIN DOOR
TO BE ONE HOUR FIRE RATED DOOR
PROPOSED GROUP HOUSING UNDER
RETIREMENT HOUSING POLICY AREA 2.60
ACRES, IN SECTOR 50, GURUGRAM

T3/T4 - MACHINE LVL/ ROOF
FLOOR PLAN
PLUMBING LAYOUT

DRG.NO. M-T3/T4-2.7

SCALE : 1:100

DATE : 27.12.2022

DEALT : SIMRAN

OWNERS SIGN: SENIOR LIVING L1 ARCHITECTS SIGN.

Authorised Signatory

CA Registration No. CA/99/25531

Architect: GADGAY SANAN

Architects SIGN.