


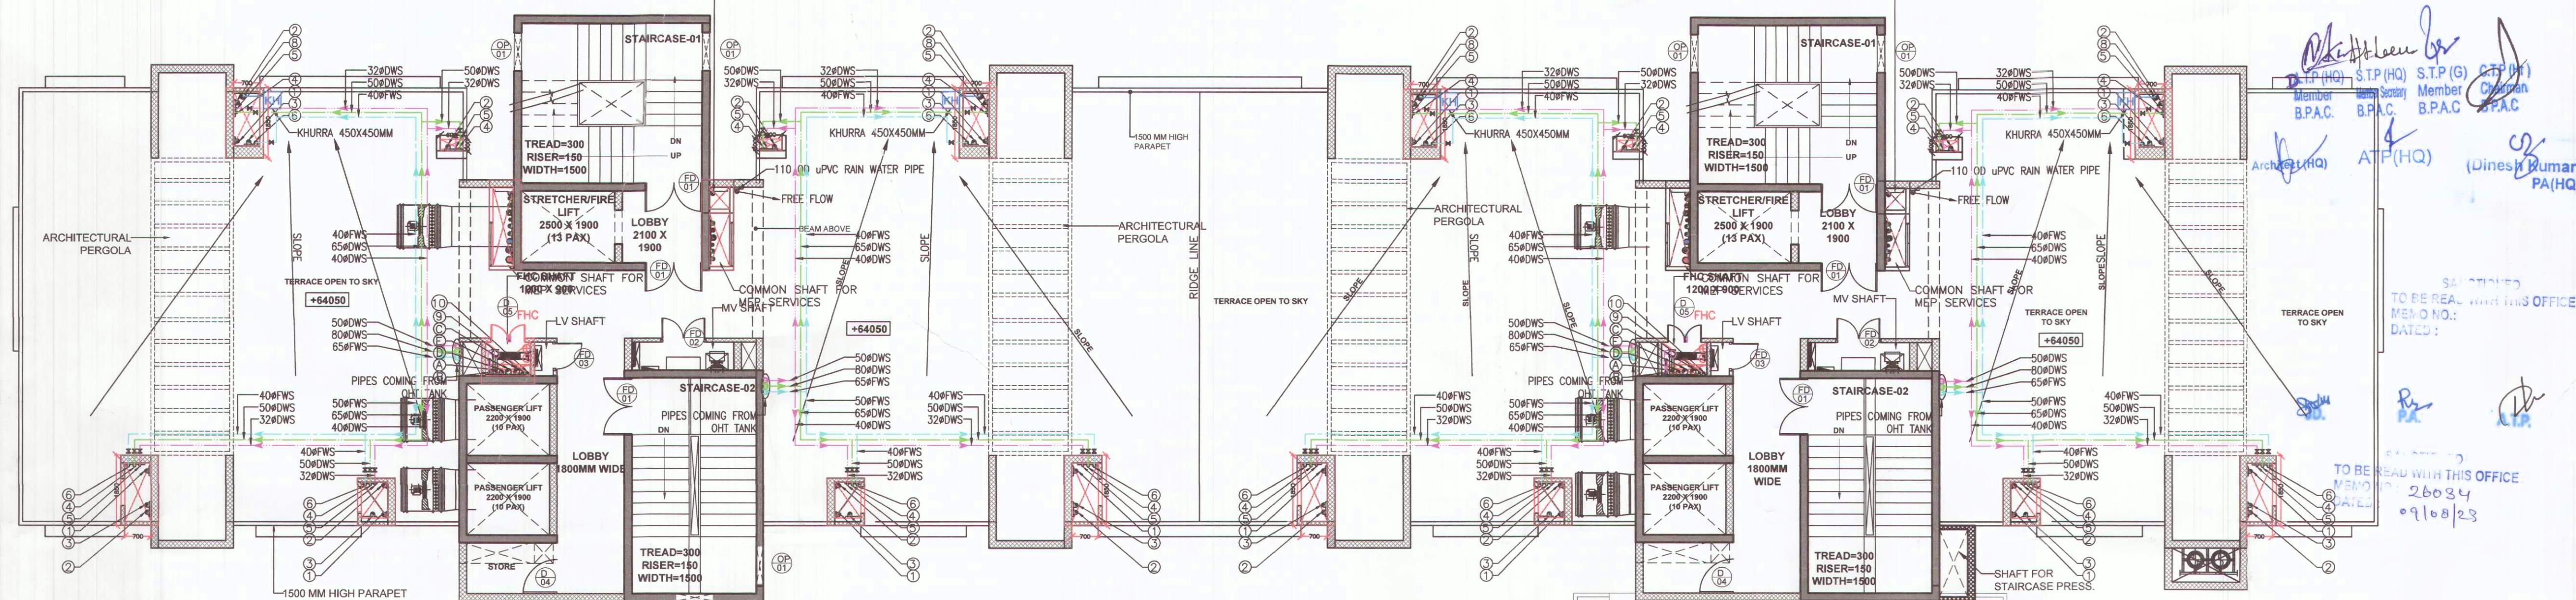

PLUMBING LEGEND:-		
S.NO.	DESCRIPTION	SYMBOL
1.	160 OD UPVC VERTICAL SOIL & VENT PIPE	①
2.	160 OD UPVC VERTICAL WASTE & VENT PIPE	②
3.	110 OD UPVC VERTICAL SOIL & VENT PIPE	③
4.	110 OD UPVC VERTICAL WASTE & VENT PIPE	④
5.	90 OD UPVC ANTISYPHONIC PIPE	⑤
6.	DOMESTIC WATER SUPPLY DOWN TAKE PIPE	⑥
7.	DOMESTIC WATER SUPPLY PIPE (BOOSTED)	⑦
8.	FLUSHING WATER SUPPLY DOWN TAKE PIPE	⑧
9.	90 OD UPVC RAIN WATER PIPE FOR BALCONY	⑨
10.	160 OD UPVC RAIN WATER PIPE FOR TERRACE	⑩
11.	40# DOMESTIC WATER SUPPLY RISER PIPE	⑪
12.	32# FLUSHING WATER SUPPLY RISER PIPE	⑫
13.	DOMESTIC WATER SUPPLY	DWS
14.	FLUSHING WATER SUPPLY	FWS
15.	DOMESTIC WATER RISER	DWR
16.	FLUSHING WATER RISER	FWR
17.	BALL VALVE/BUTTER FLY VALVE	Ⓜ

FIRE FIGHTING LEGEND:-		
A	100# FIRE HYDRANT PIPE LOW ZONE	
B	80# DRAIN PIPE	
C	150# SPRINKLER PIPE LOW ZONE	
D	100# FIRE HYDRANT PIPE HIGH ZONE	
E	150# SPRINKLER PIPE HIGH ZONE	
FHC	FIRE HOSE CABINET	


TERRACE PLAN

TERRACE PLAN



TOWER 3-MUMTY FLOOR AREA CALCULATION				
S.NO.	LENGTH(M)	WIDTH(M)	NO.	AREA(SQ.M.)
COVERED AREA				
1	5.20	6.70	1.00	34.84
2	1.45	2.30	2.00	6.67
3	8.10	8.75	1.00	70.88
TOTAL ADDITIONS (A)				112.39
DEDUCTION				
A	DEDUCTION (B)			0.00
NET COVERED AREA= COVERED AREA (A) - DEDUCTION (B)				112.39

TOWER 4-MUMTY FLOOR AREA CALCULATION				
S.NO.	LENGTH(M)	WIDTH(M)	NO.	AREA(SQ.M.)
COVERED AREA				
1	5.20	6.70	1.00	34.84
2	1.45	2.30	2.00	6.67
3	8.10	8.75	1.00	70.88
TOTAL ADDITIONS (A)				112.39
DEDUCTION				
A	DEDUCTION (B)			0.00
NET COVERED AREA= COVERED AREA (A) - DEDUCTION (B)				112.39

TOWER 1/2/3/4			
DOOR/WINDOW	ROUGH OPENING	SILL	LINTEL
D01	1200X2400	-	2400
D02	1050X2400	-	2400
D03	800X2400	-	2400
D04	900X2400	-	2400
D05	900X2100	300	2400
D06	1000X2400	-	2400
D07	1200X2400	-	2400
FD01	1500X2400		2400
FD02	1200X2100	300	2400
FD03	750X2100	300	2400
DW01	1900X2400	-	2400
DW02	1800X2400	-	2400
DW03			
DW04			
W01	1900X1800	600	2400
W02	800X1800	600	2400
W03	600X1200	1200	2400
W04	600X1300	1100	2400
W05	700X1300	1100	2400
W06	1000X1300	1100	2400
OP01	1000X1300	1100	2400
AP01	600X2100	300	2400

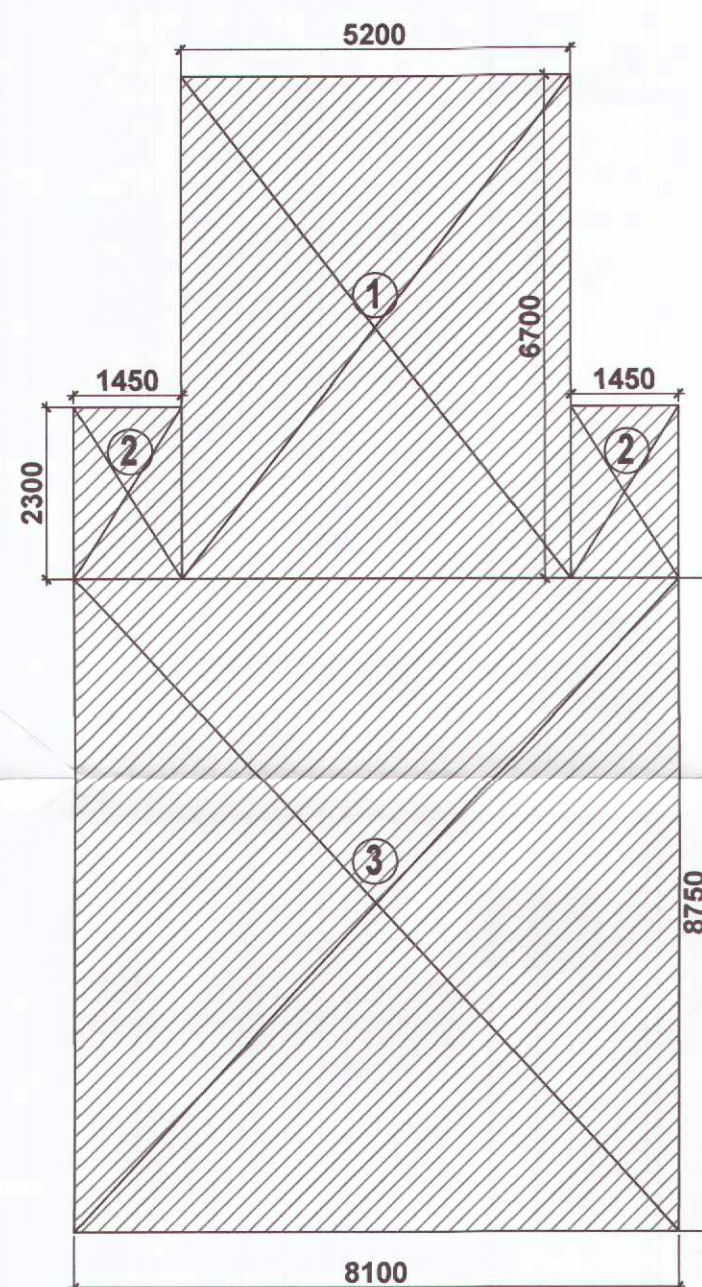

TERRACE LEVEL- UNIT AREA CALCULATION PLAN

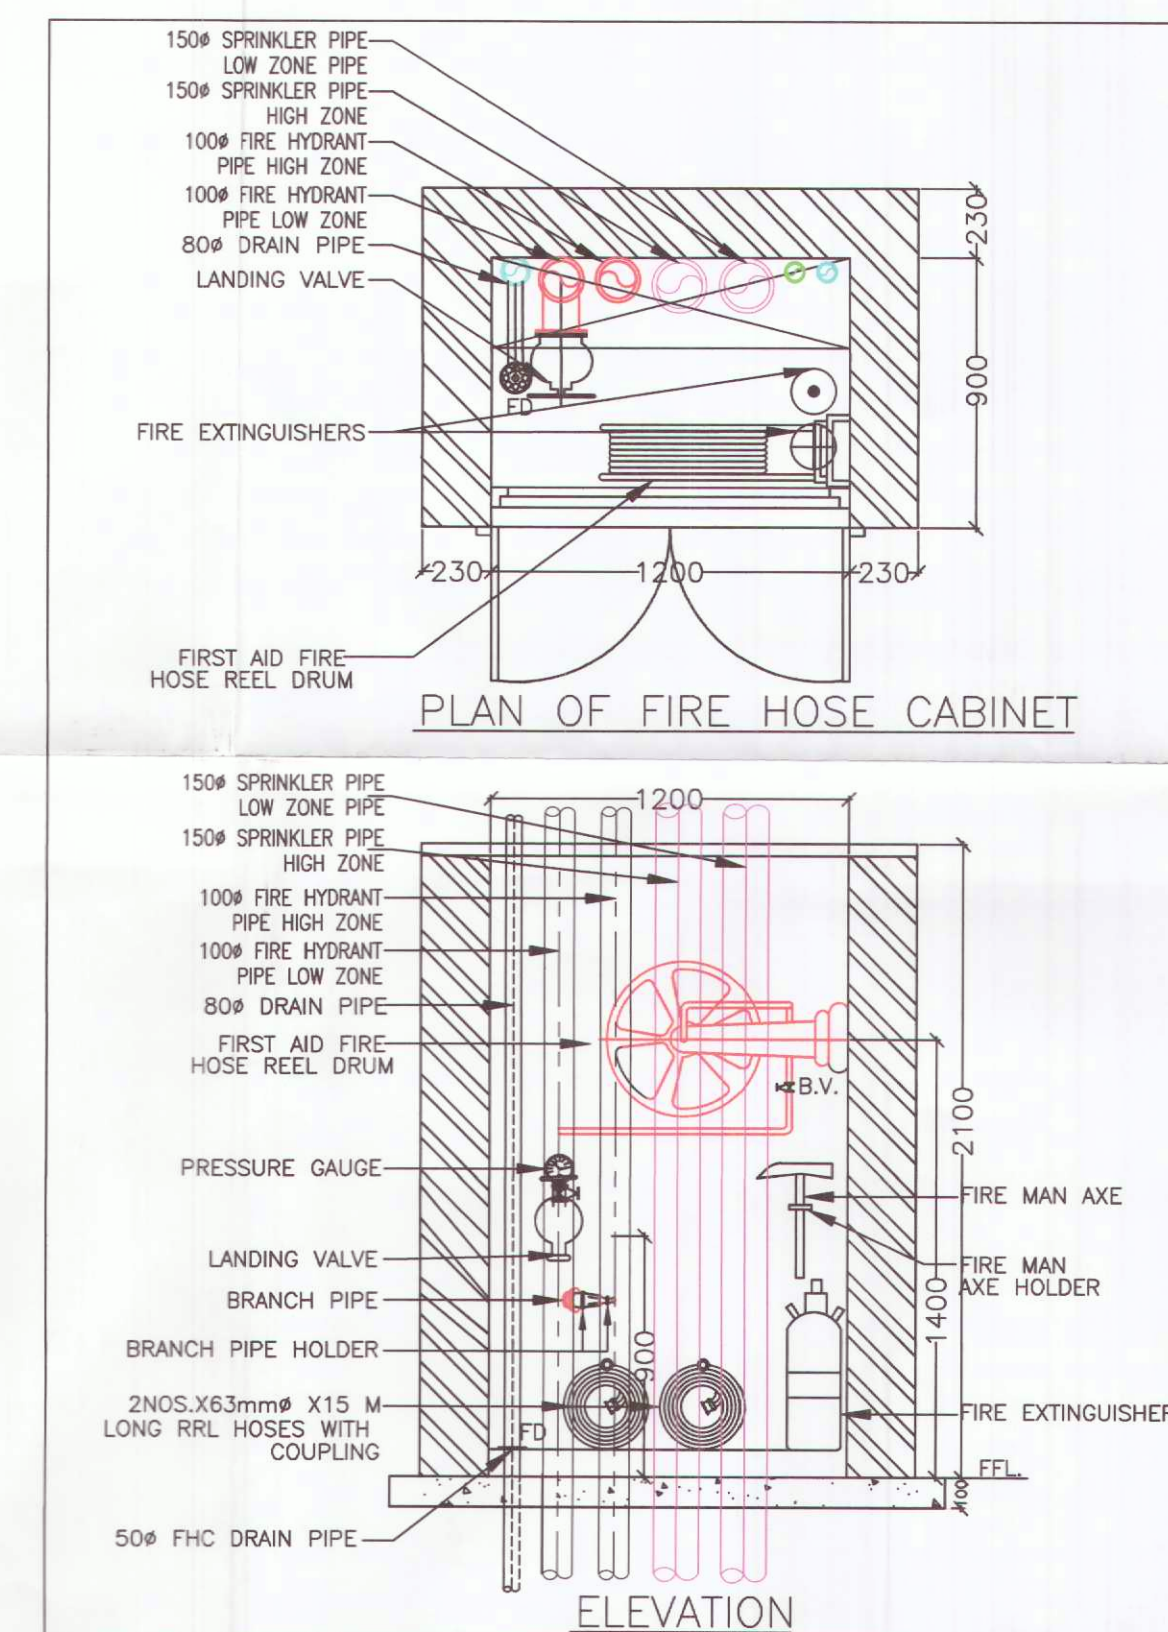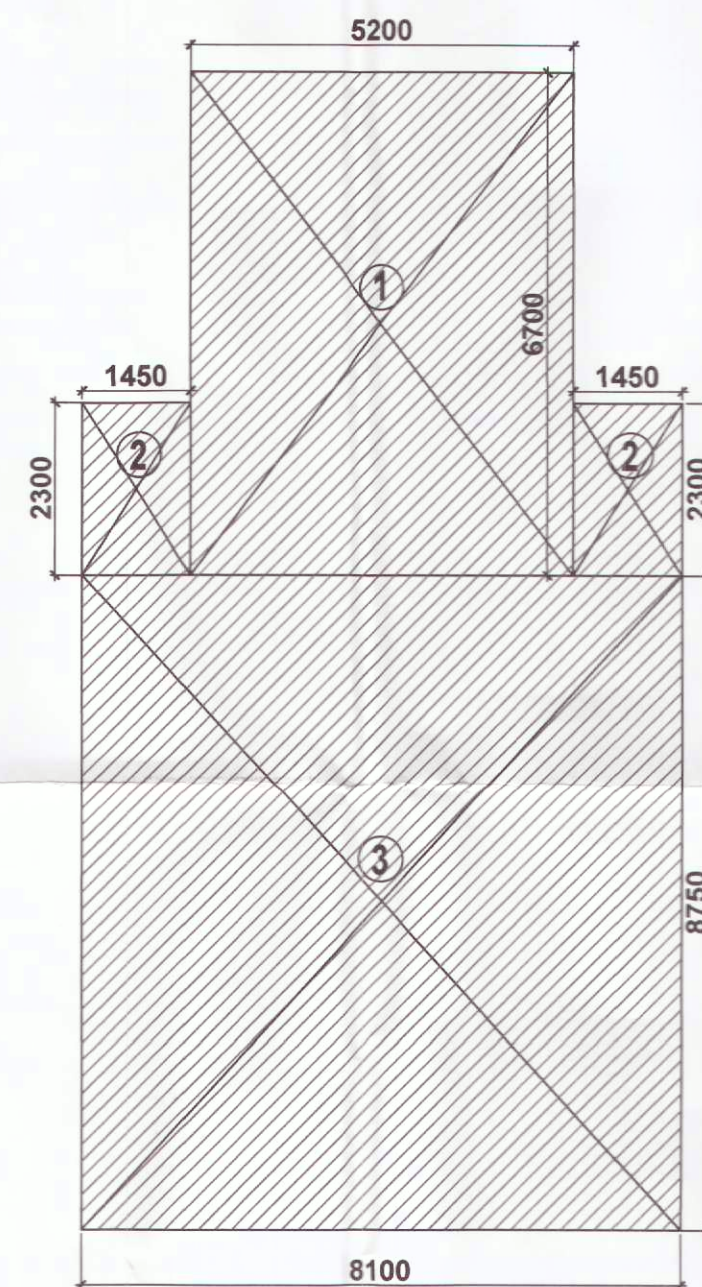

NOTE- ALL DWELLING UNIT MAIN DOOR TO BE ONE HOUR FIRE RATED DOOR

PROPOSED GROUP HOUSING UNDER RETIREMENT HOUSING POLICY AREA 2.60 ACRES, IN SECTOR 50, GURUGRAM LIC. NO. 161 OF 2022 DT. 7.10.2022 PIONEER J.K. SENIOR LIVING LLP

T3/T4- TERRACE FLOOR PLAN PLUMBING LAYOUT

DRG.NO. M-T3/T4-2.6 ARCHITECT: GANAKA SANAN

SCALE: 1:100 DATE: 27.12.2022

DEALT: SIMRAN CA Registration No. CA/99/25531

OWNERS SIGN: SENIOR LIVING LLP ARCHITECTS SIGN: [Signature]

Authorised Signatory

Checked and found ok for Public Health (Internal) Service only subject to comments in forwarding letter No. 11378 D.V. 23-01-2023

Supervising Engineer (HQ) for Chief Engineer-1 H.O.P. Patilwala 21/01/23

DDVT MEMBER BPAC