


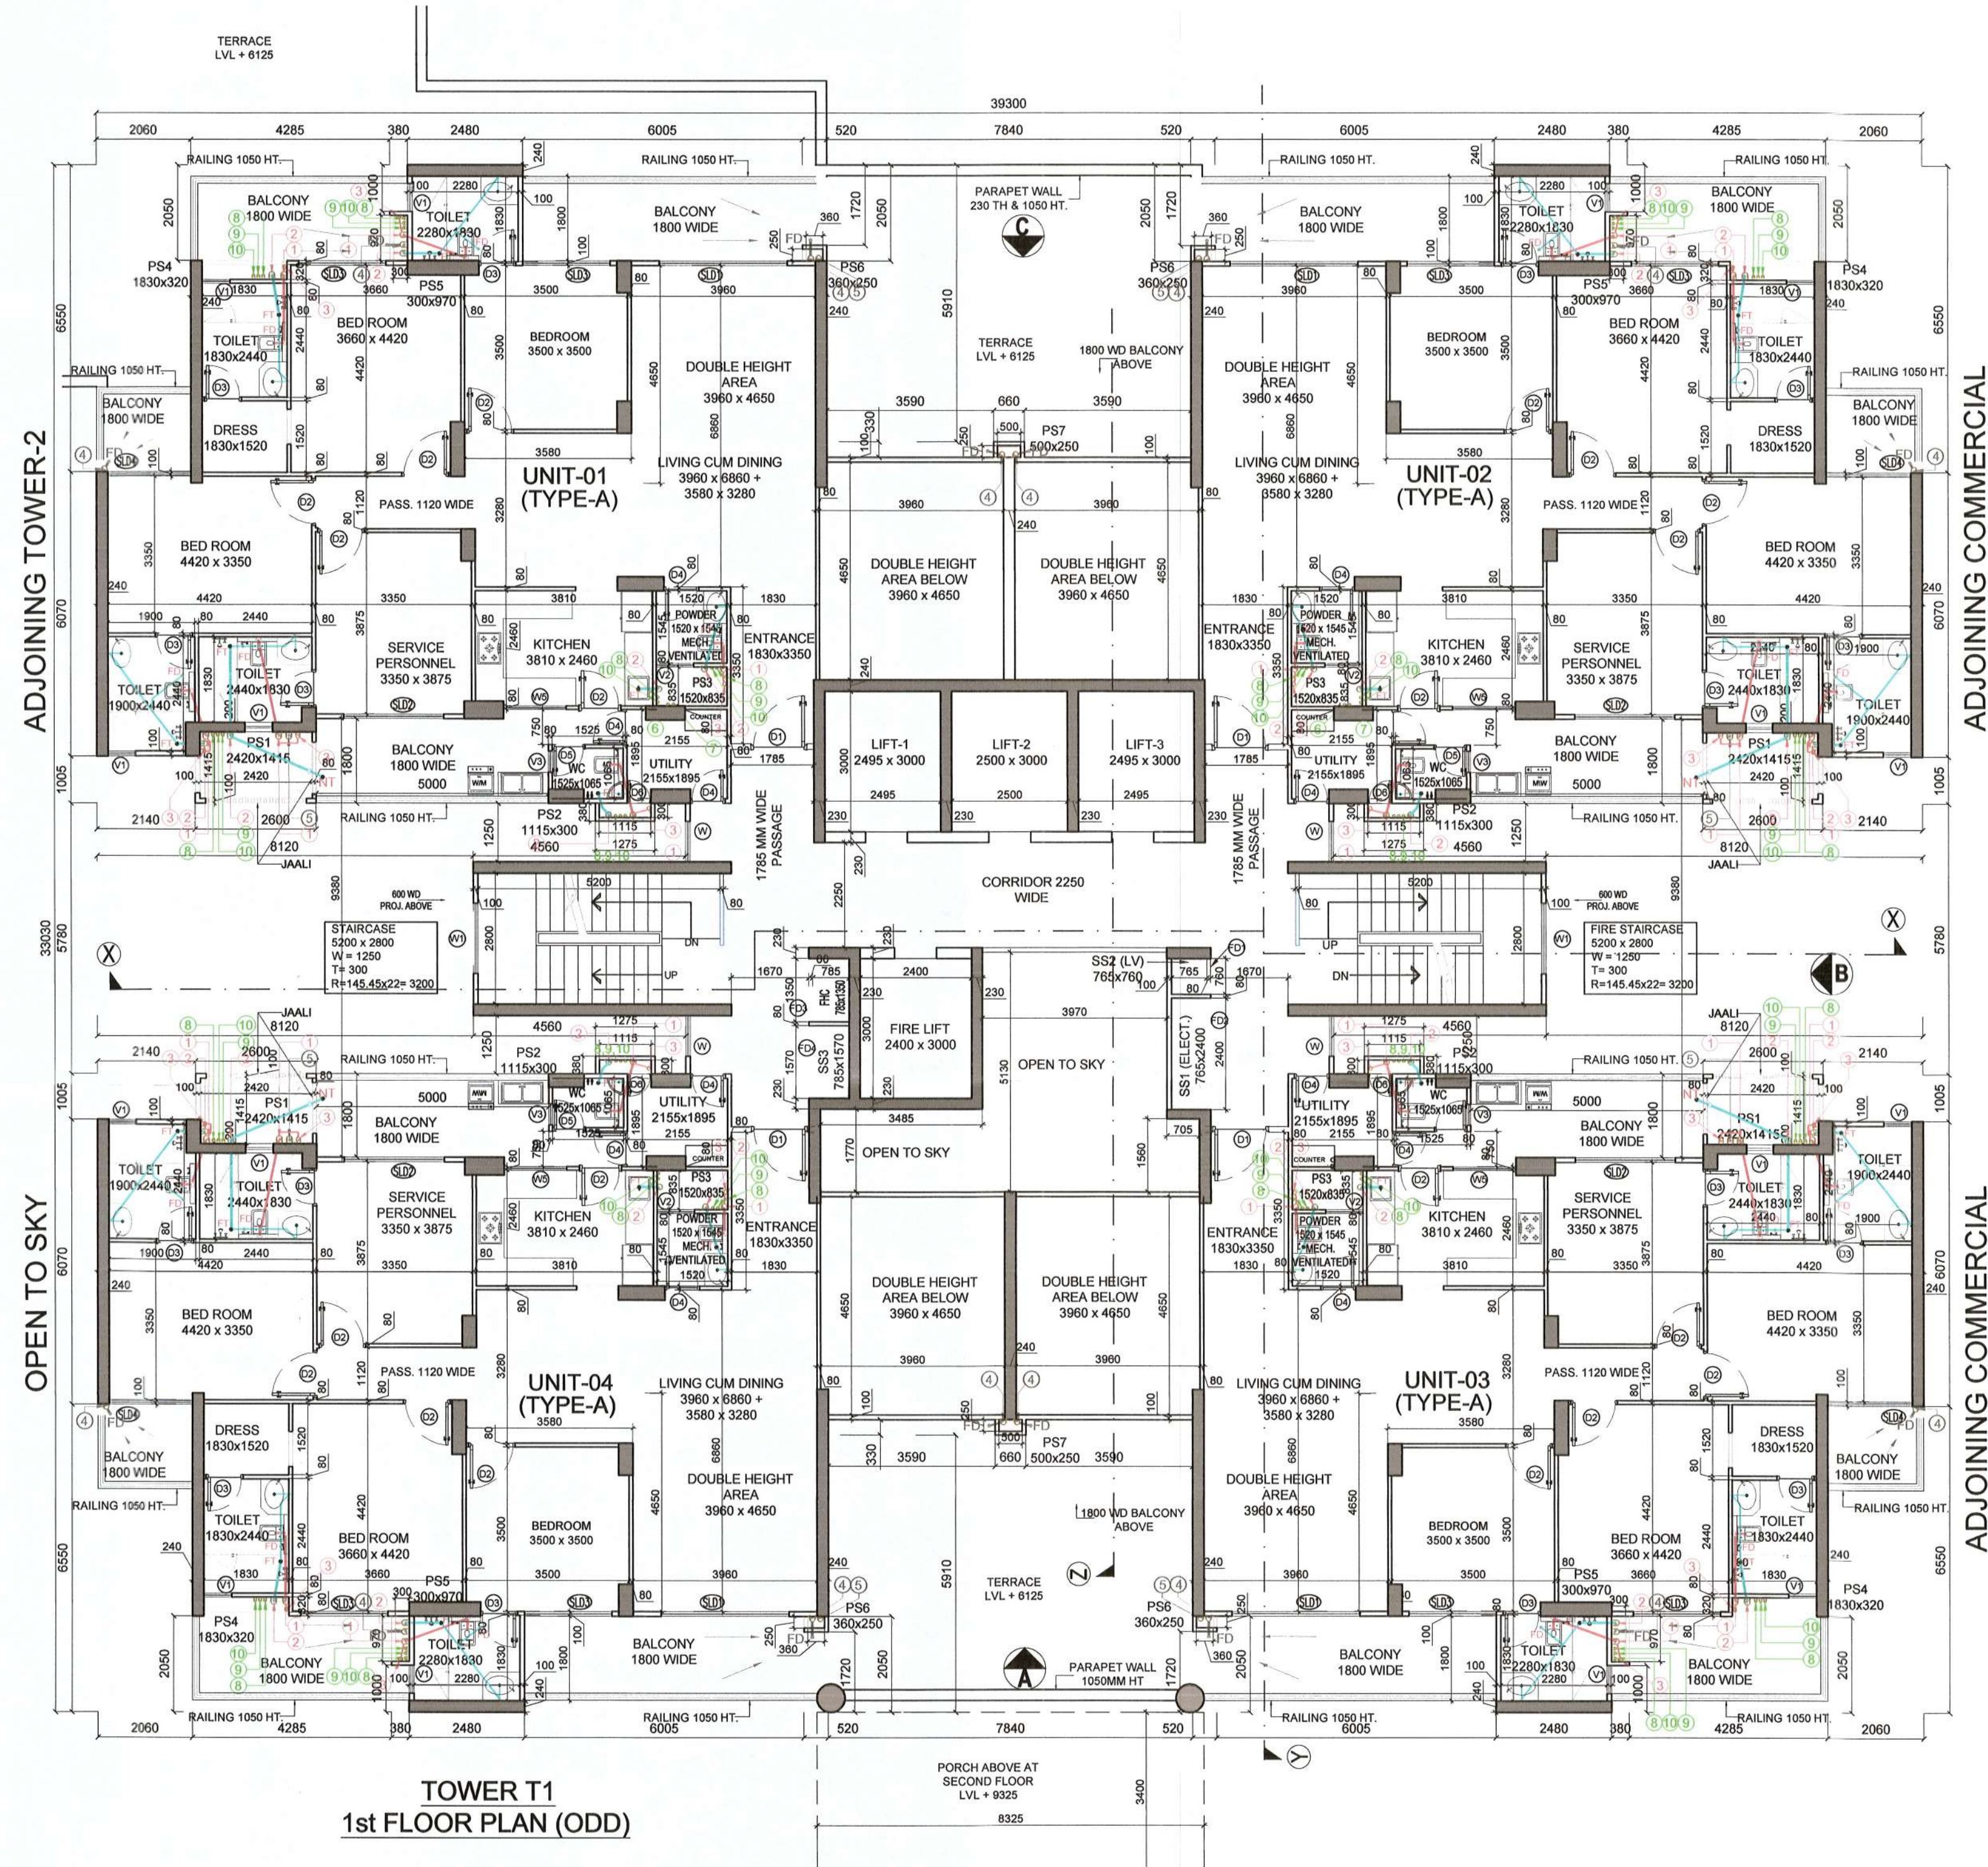

DOORS & WINDOWS SCHEDULE

TYPE	WIDTH	CILL	LINTEL
FD	1200	0.0	2400
ONE HOUR FIRE RATED DOOR			
D1	1200	0.0	2400
D2	1000	0.0	2400
D3	800	0.0	2400
D4	750	0.0	2400
D5	700	0.0	2400
D6	550	0.0	2100
SLD1	2750	0	4500
SLD1A	2750	0	2400
SLD2	2150	0	2400
SLD3	1875	0	2400
SLD4	1620	0	2400
SLD4	2400	0	2400
SLD5	1595	0	2400
DW1	900/1000	0-1050	2400
DW2	900/700	0-600	2400
DW3	1200/620	0-600	2400
W	870	900	2400
LOUVERED WINDOW IN STAIRCASE			
W1	1500	1200	2400
W2	900	1050	2400
W3	1200	900	2400
W4	1700	900	2400
W5	1350	1350	2400
V1	800	1200	2400
V2	800	750	2400
V3	450	1200	2400

PLUMBING LEGEND

(1)	110 OD uPVC (SWR) SOIL / VENT PIPE
(2)	110 OD uPVC (SWR) WASTE & VENT PIPE
(3)	75 OD uPVC ANTISIPHONAGE
(4)	90 OD uPVC RAIN WATER PIPE ONLY BALCONY
(5)	110 OD uPVC RAIN WATER PIPE
(6a)	160 OD uPVC RAIN WATER PIPE
(6)	65 DIA. SERVICE PERSONNEL WATER SUPPLY RISER
(7)	50 DIA. FLUSHING WATER SUPPLY RISER
(8)	SERVICE PERSONNEL WATER SUPPLY DN
(9)	FLUSHING WATER SUPPLY DN
(10)	SERVICE PERSONNEL WATER SUPPLY DN FOR UPPER 3 FLOOR
(11)	BALL / BUTTER FLY VALVE
FT / UT	FLOOR TRAP (DEEP SEAL 'P' / 'S' TRAP) WITH MIN. 50 MM WATER SEAL SIZE = 110 x 110 x 75 MM
FD	FLOOR DRAIN
KH	KHURRA 450 x 450 MM
HG	HORIZONTAL GRATING

Checked and found ok for Public Health
(Internal) Service only subject to comments in
in forwarding letter No. LSC.34.5...Dtd. 15.11.23

Superintendent Engineer (HQ)
for Chief Engineer
HSVP, Pimpri
SDEW-1

NOTE:- 1. ALL MAIN UNIT ENTRY DOOR WILL BE ONE HOUR FIRE RATED DOOR
2. ALL SHAFTS (FHC, ELECTRICAL & LV) DOOR WILL BE FIRE DOOR.
3. STAIRCASE WILL HAVE LOUVERED WINDOW

SANCTIONED
TO BE READ WITH THIS OFFICE
MEMO NO.: ZP-1442 JPD(RA) 2023
DATED: 3-11-2023

DTP (HQ) S.T.P (HQ) S.T.P (HQ) S.T.P (HQ)
Member Secretary Member Chairman
B.P.A.C. B.P.A.C. B.P.A.C.
Consultant Architect ATP (HQ)
Ram Avtar Bassi JD (HQ) Member BPAC

OWNER :
DECENT BUILDHOMES PRIVATE LIMITED
PREVIOUSLY KNOWN AS BNB LAND DEVELOPERS
PRIVATE LIMITED
ADDRESS- 301, 3rd FLOOR INDRAPRAKASH
BUILDING 21, BARAKHAMBA ROAD, NEW DELHI 110001

PROJECT :
PROPOSED BUILDING PLANS OF GROUP HOUSING
COLONY FOR AN AREA MEASURING 4.0375 ACRES
UNDER TOD POLICY DATED 09.02.2016 (LICENSE NO
40 OF 2022 DATED 12.04.2022 IN SECTOR-70,
GURUGRAM MANESAR URBAN COMPLEX BEING
DEVELOPED BY DECENT BUILDHOMES PVT. LTD.

TITLE :
1st FLOOR PLAN (TOWER 01)

ARCHITECTS DRG.NO.-T1-04

GIAN P. MATHUR AND ASSOCIATES (P) LTD.
C-55, East Of Kailash, New Delhi-110065
T: 46099591 / 46099512
E: info@gpmindia.com | W: www.gpmindia.com

SCALE: 1: 100 ARCHITECT'S SIGN OWNER'S SIGN
DATE: APR 2023 GIAN P. MATHUR ARCHITECT
DRAWN: SANDHYA B. Archt., M.C.A. I.I.A
CKD BY: PRITI CA No. 80/5769

