



56660

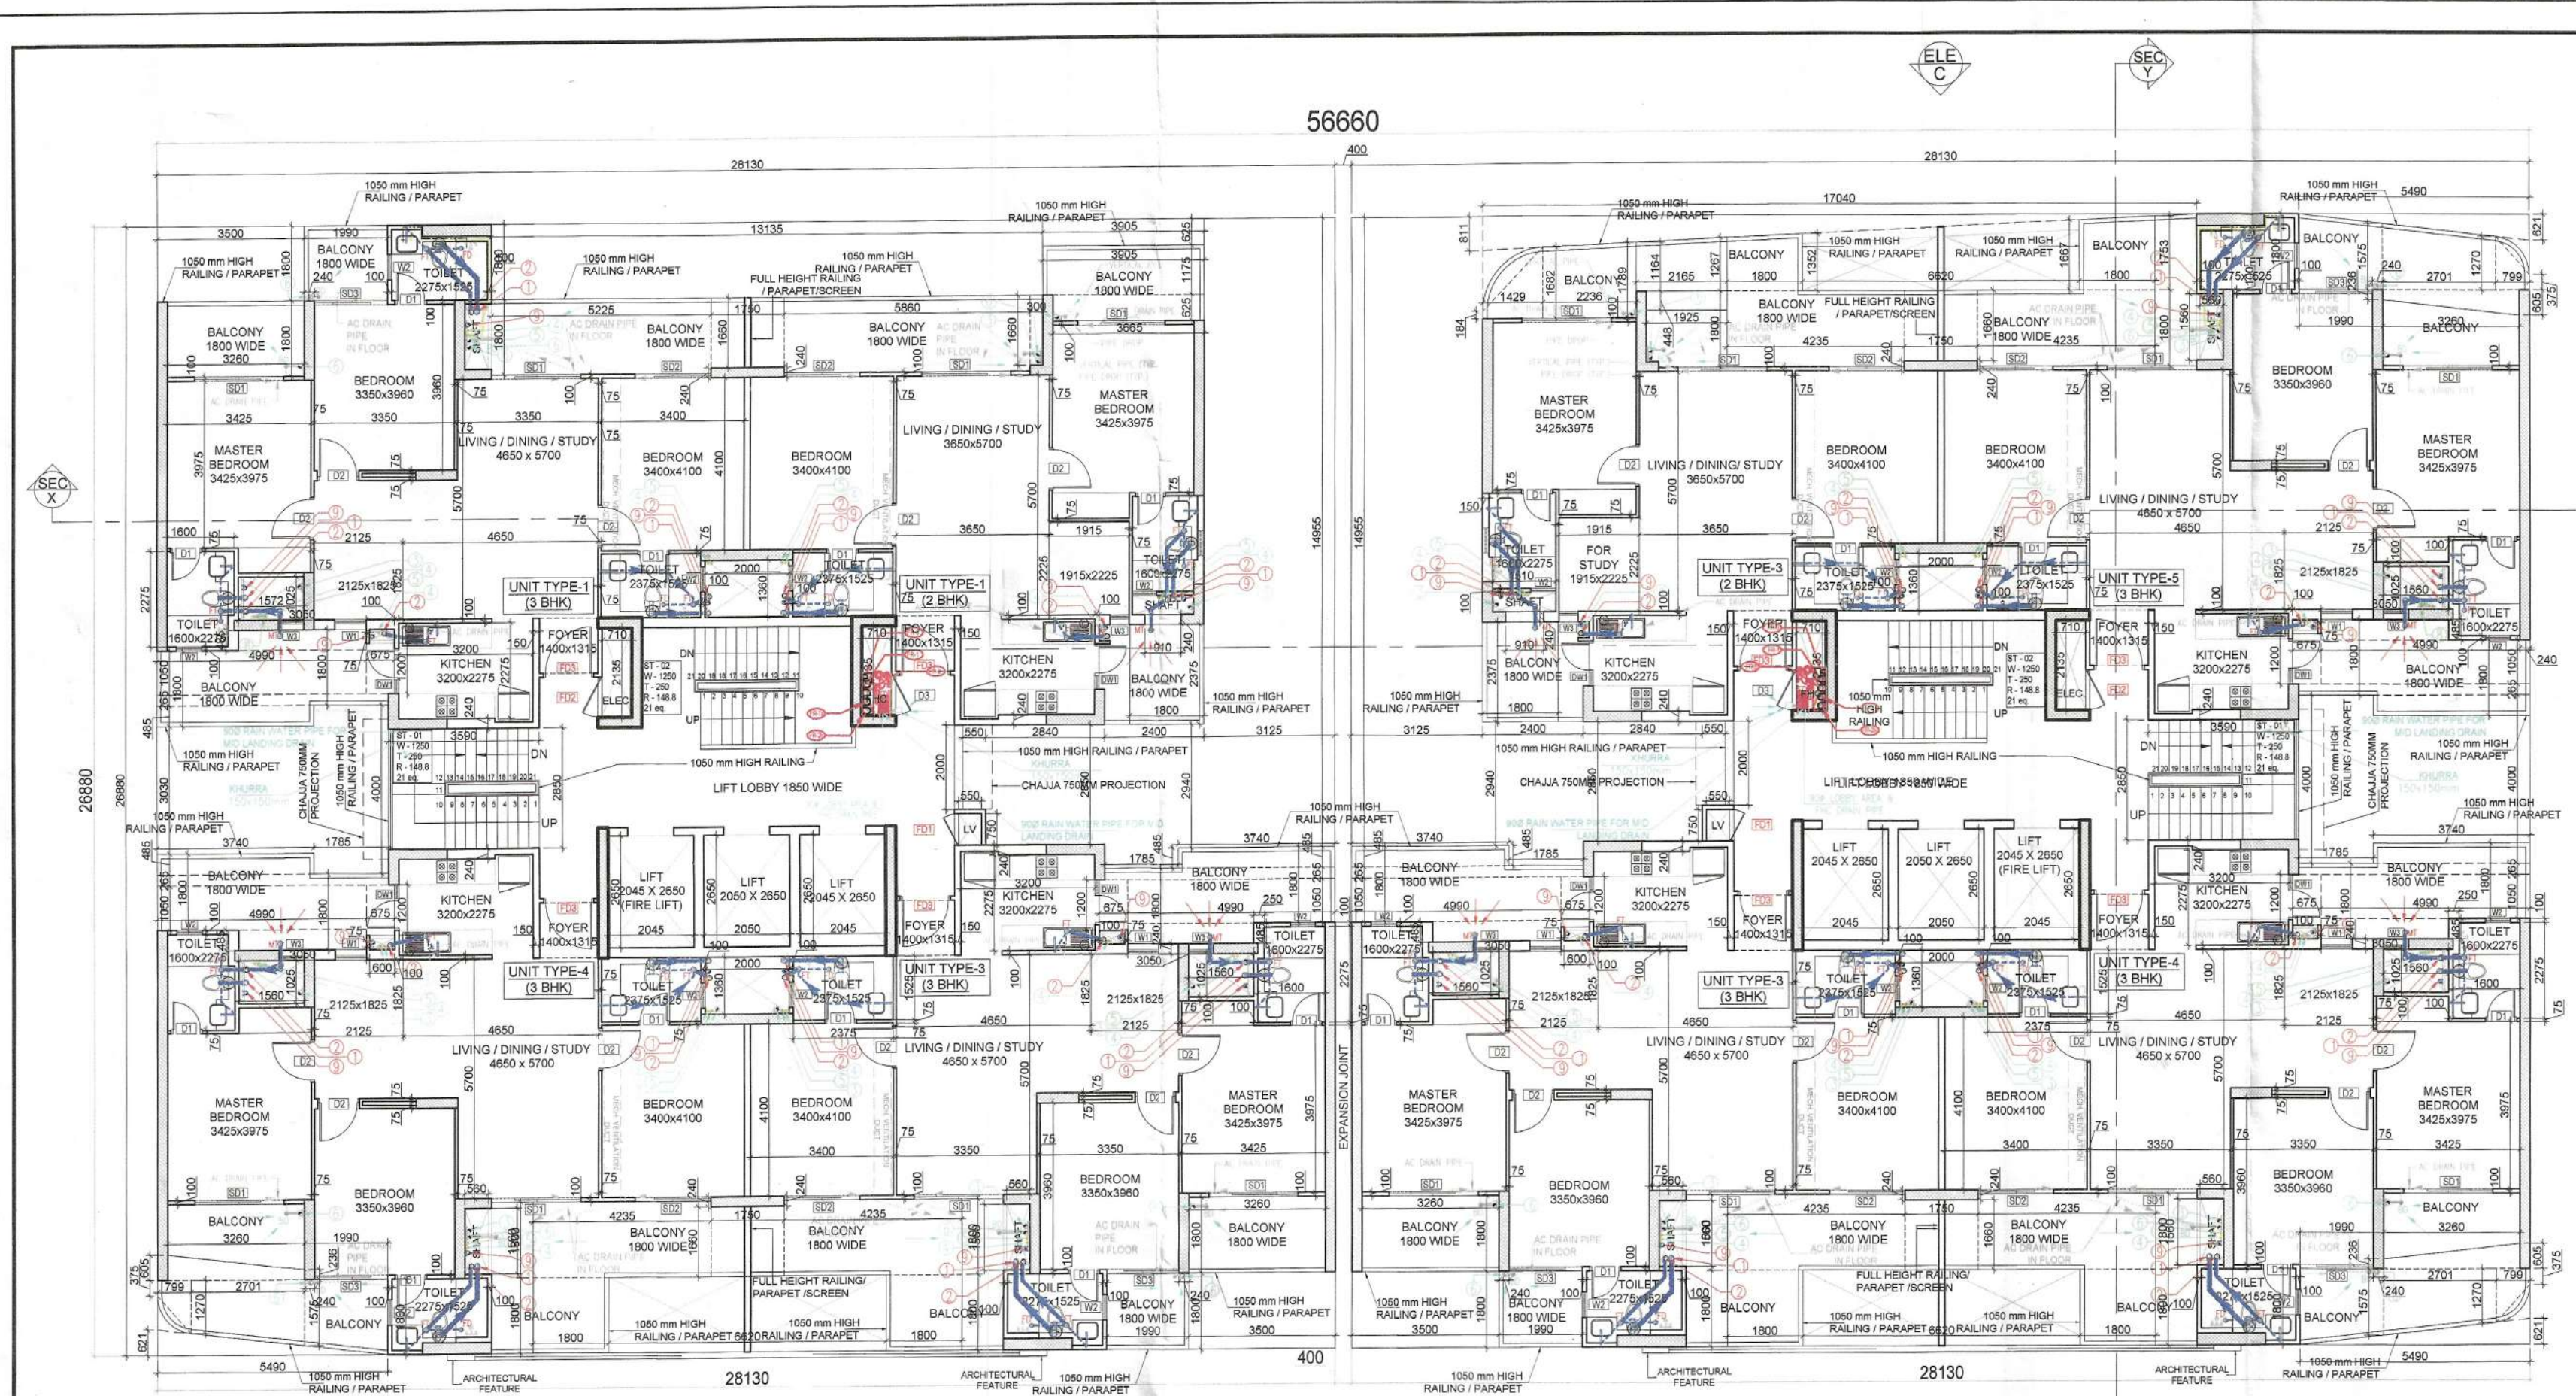

(TOWER -I)

6th FLOOR PLAN
(BLOCK - 5)

(TOWER -J)

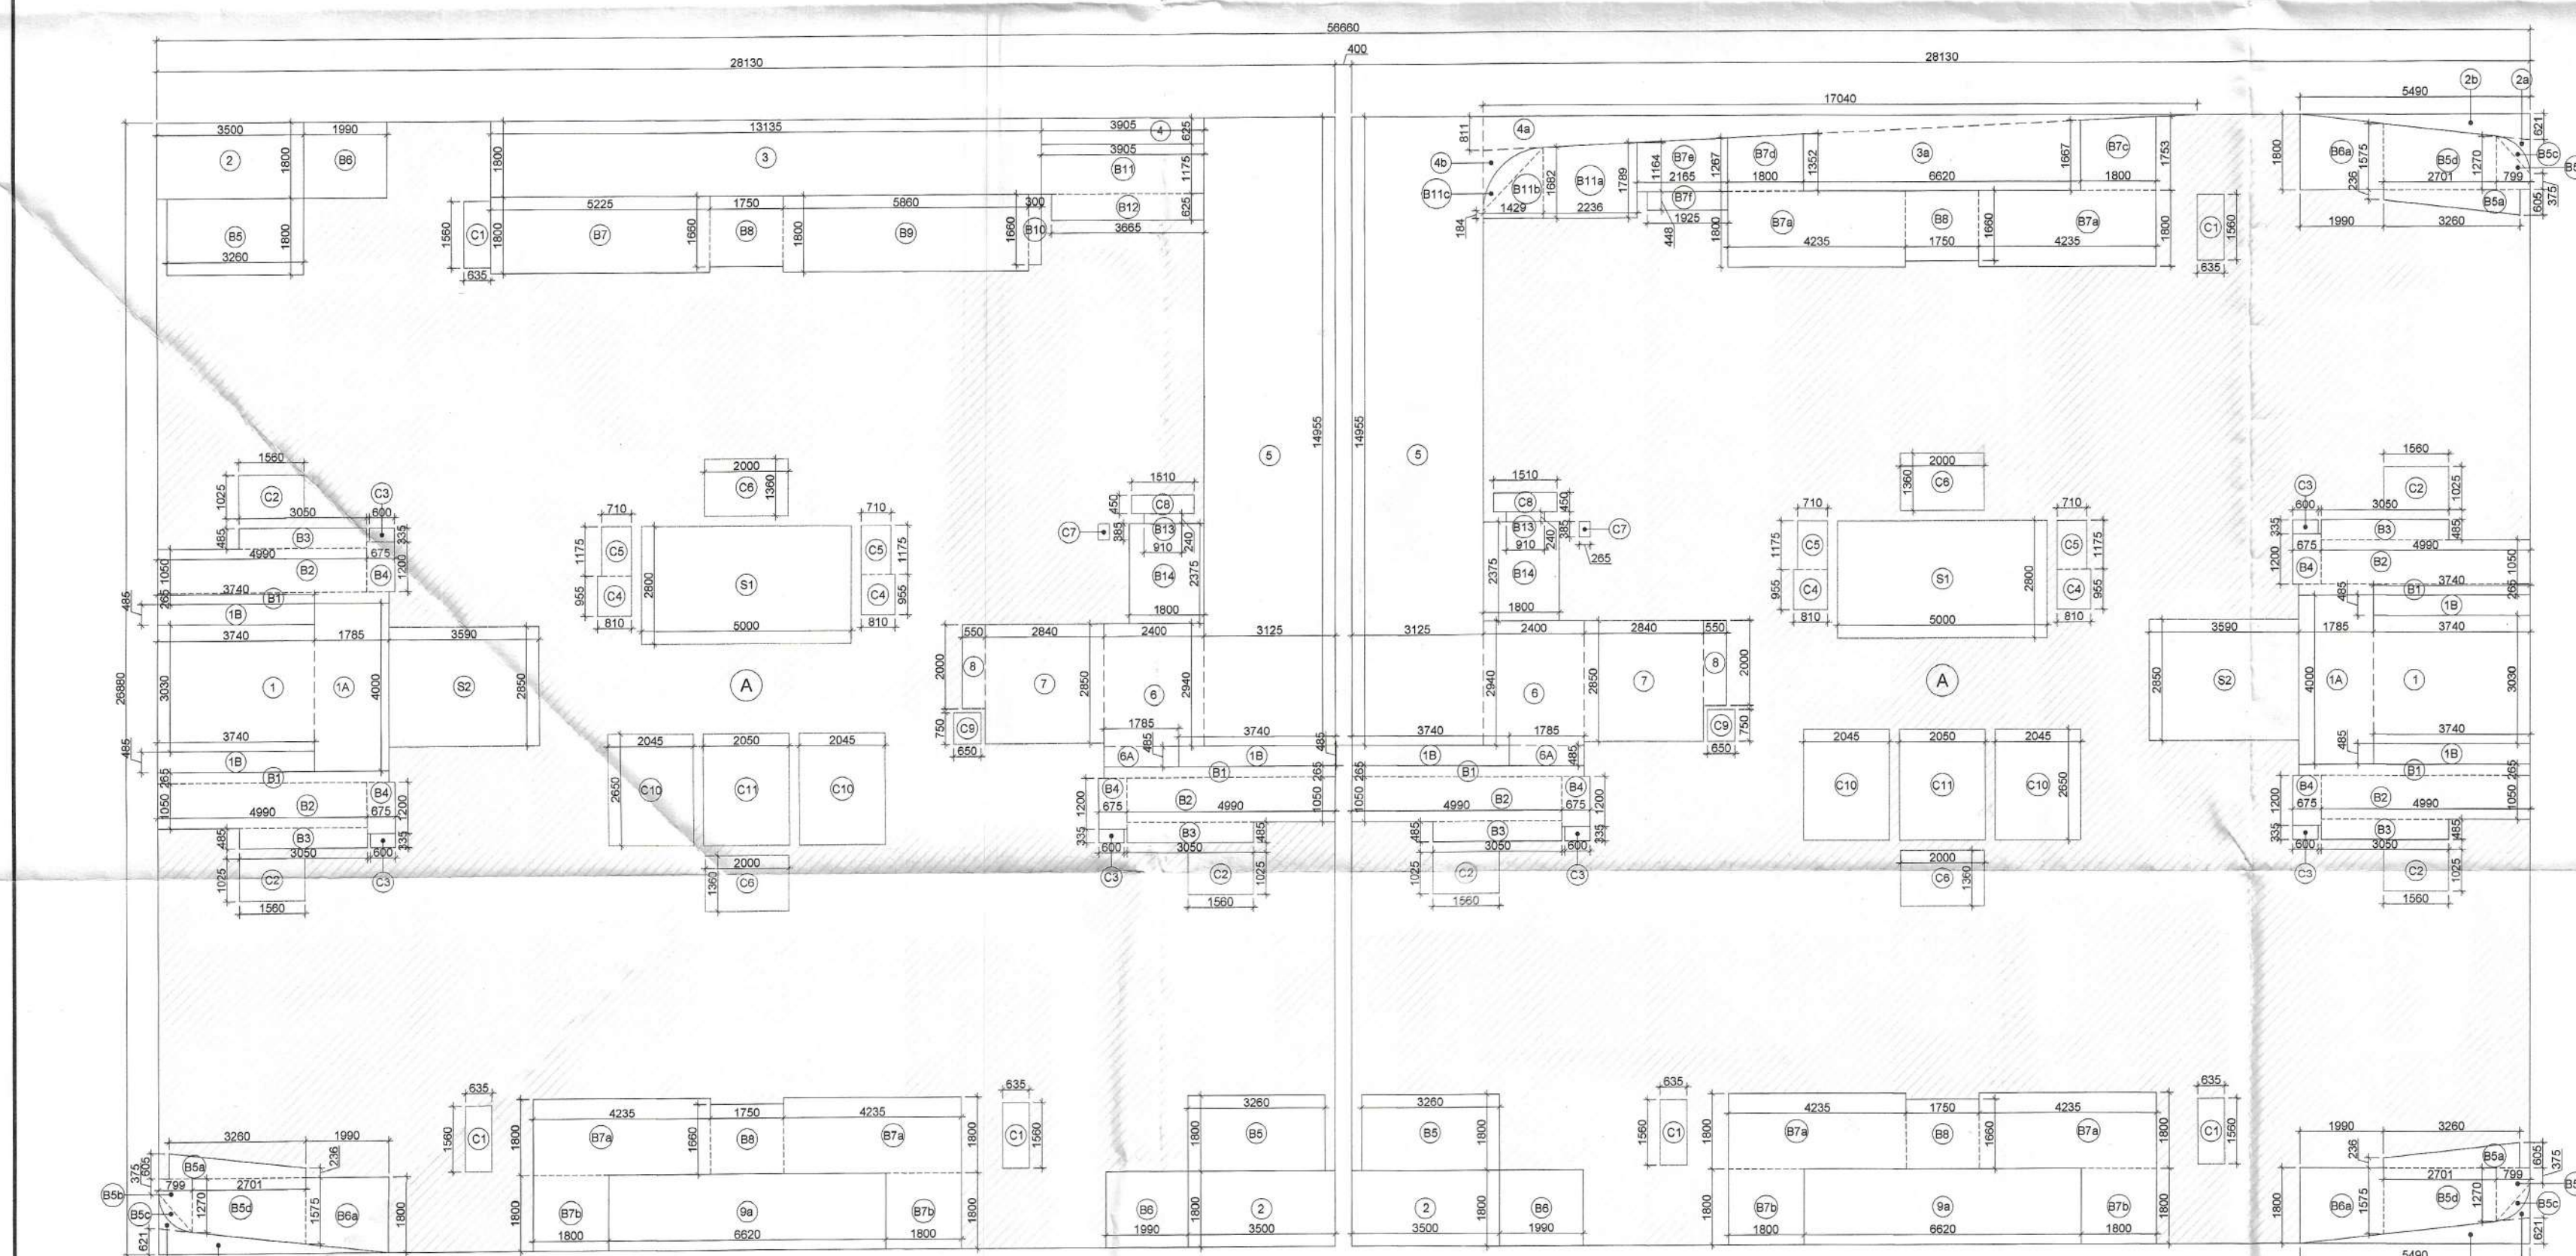

(TOWER -I)

6th FLOOR AREA DIAGRAM
(BLOCK 05)

(TOWER -J)

AREA CALCULATION FOR 6TH FLOOR

ENVELOPE AREA						
S.NO.	NOS.	FORMULA	LENGTH (L)	WIDTH (W)	WIDTH (W')	AREA
A	2	L X W	28.130	26.880		1512.269 SQM.
TOTAL (A) =						1512.269 SQM.

BALCONY						
B1	6	L X W	5.525	0.265		8.785 SQM.
B2	6	L X W	4.990	1.050		31.437 SQM.
B3	6	L X W	3.050	0.485		8.876 SQM.
B4	6	L X W	0.675	1.200		4.860 SQM.
B5	3	L X W	3.260	1.800		17.604 SQM.
B5a	3	1/2 (W+W')XL	3.260	0.605	0.236	4.112 SQM.
B5b	3	1/2 (W+W')XL	0.799	0.375	1.270	1.972 SQM.
B5c	3	PLINE AREA				0.564 SQM.
B5d	3	1/2 (W+W')XL	2.701	1.270	1.575	11.527 SQM.
B6	3	L X W	1.990	1.800		10.746 SQM.
B6a	3	1/2 (W+W')XL	1.990	1.575	1.800	10.074 SQM.
B7	1	L X W	5.225	1.800		9.405 SQM.
B7a	6	L X W	4.235	1.800		45.738 SQM.
B7b	4	L X W	1.800	1.800		12.960 SQM.
B7c	1	1/2 (W+W')XL	1.800	1.667	1.753	3.078 SQM.
B7d	1	1/2 (W+W')XL	1.800	1.267	1.352	2.357 SQM.
B7e	1	1/2 (W+W')XL	2.165	1.164	1.267	2.632 SQM.
B7f	1	L X W	1.925	0.448		0.862 SQM.
B8	4	L X W	1.750	1.660		11.620 SQM.
B9	1	L X W	5.860	1.800		10.548 SQM.
B10	1	L X W	0.300	1.660		0.498 SQM.
B11	1	L X W	3.905	1.175		4.588 SQM.
B11a	1	1/2 (W+W')XL	2.236	1.682	1.789	3.881 SQM.
B11b	1	1/2 (W+W')XL	1.429	0.184	1.682	1.333 SQM.
B11c	1	PLINE AREA				0.589 SQM.
B12	1	L X W	3.665	0.625		2.291 SQM.
B13	2	L X W	0.910	0.240		0.437 SQM.
B14	2	L X W	1.800	2.375		8.550 SQM.
1B	6	L X W	3.740	0.485		10.883 SQM.
TOTAL (B) =						242.806 SQM.

CUT OUT / DEDUCTION AREA						
1	2	L X W	3.740	3.030		22.664 SQM.
1A	2	L X W	1.785	4.000		14.280 SQM.
2	3	L X W	3.500	1.800		18.900 SQM.
2a	3	PLINE AREA				0.399 SQM.
2b	3	1/2 X L X W	5.490	0.621		5.114 SQM.
3	1	L X W	13.135	1.800		23.643 SQM.
3a	1	1/2 (W+W')XL	6.620	1.352	1.667	9.993 SQM.
4	1	L X W	3.905	0.625		2.441 SQM.
4a	1	1/2 X L X W	17.040	0.811		6.910 SQM.
4b	1	PLINE AREA				0.431 SQM.
5	2	L X W	3.125	14.955		93.469 SQM.
6	2	L X W	2.400	2.940		14.112 SQM.
6A	2	L X W	1.785	0.485		1.731 SQM.
7	2	L X W	2.840	2.850		16.188 SQM.
8	2	L X W	0.550	2.000		2.200 SQM.
9a	2	L X W	6.620	1.800		23.832 SQM.
C1	6	L X W	0.635	1.560		5.944 SQM.
C2	6	L X W	1.560	1.025		9.594 SQM.
C3	6	L X W	0.600	0.335		1.206 SQM.
C4	4	L X W	0.810	0.955		3.094 SQM.
C5	4	L X W	0.710	1.175		3.337 SQM.
C6	4	L X W	2.000	1.360		10.880 SQM.
C7	2	L X W	0.265	0.385		0.204 SQM.
C8	2	L X W	1.510	0.450		1.359 SQM.
C9	2	L X W	0.650	0.750		0.975 SQM.
C10	4	L X W	2.045	2.650		21.677 SQM.
C11	2	L X W	2.050	2.650		10.865 SQM.
TOTAL (C) =						325.442 SQM.

NON FAR AREA						
S1	2	L X W	5.000	2.800		28.000 SQM.
S2	2	L X W	3.590	2.850		20.463 SQM.
TOTAL (D) =						48.463 SQM.
TOTAL FAR AREA (A+B+C+D)						895.558 SQM.
TOTAL COVERED AREA = (A+B+C)						944.021 SQM.
TOTAL BUILT UP AREA (A-C)						1186.827 SQM.

This is a "PROVISIONAL BUILDING PLAN" approved only for the purpose of inviting objections from the general public

DDP (T) MEMBER BPAC
S.T.P. (H) Member Secretary B.P.A.C.
Consultant Architect
Rajesh Dutt JD(HQ)

S.T.P. (G) Member Secretary B.P.A.C.
S.T.P. (H) Chairman B.P.A.C.
ATP(HQ)


Checked and found ok for Public Health (Internal) Service only subject to comments in forwarding letter No. 15570.../24/01/24

Superintending Engineer (HQ) for Chief Engineer-I HSPV, Panchula

DOOR WINDOW OPENING SCHEDULE						
TYPE	WIDTH	HEIGHT	CILL	LINTEL	FIRE RATING	
D1	750	2425	00	2425		
D2	1000	2425	00	2425		
DW1	1075	2425	00	2425		
DW2	2850	2425	00	2425		
DW3	6070	2425	00	2425		
GL1	6650	2425	00	2425		
SD	900	2325	100	2425		
SD1	2125	2425	00	2425		
SD2	1800	2425	00	2425		
SD3	1750	2425	00	2425		
W1	750	1525	000	2425		
W2	600	1225	1200	2425		
W3	600x480	1525	000	2425		
W4	2100	1525	000	2425		
W5	1400	1625	000	2425		
V1	600	925	1600	2425		
F1	750	2325	100	2425	2 HR FIRE RATING DOOR	
F2	800	2325	100	2425	2 HR FIRE RATING DOOR	
F3	1200	2425	00	2425	1 HR FIRE RATING DOOR	
F4	1250	2425	00	2425	2 HR FIRE RATING DOOR	
F5	1250	2100	00	2100	2 HR FIRE RATING DOOR	

PLUMBING LEGEND:						
1	1100 SOIL PIPE					
2	1100 WASTE PIPE					
3	1100 RAIN WATER PIPE					
4	1000 DN WASTE PIPE					
5	50MM FROM ROOSTER PUMP FOR TOP TWO FLOORS					
6	FWB DN TAKE PIPE					
7	1100 BALCONY DRAIN PIPE					
8	50R DOMESTIC WATER SUPPLY RISER					
9	50R FLUSHING WATER SUPPLY RISER					
10	75R ANTIPHONAGE PIPE					
WB TO FT	40R WASTE PIPE					
SNK TO FT	50R WASTE PIPE					
FD	FLOOR DRAIN WITH GRATING					
FT	FLOOR TRAP WITH GRATING					
MTD	MULTI TRAP WITH GRATING					
SD	BALCONY DRAIN WITH GRATING					
DWB	DOMESTIC WATER SUPPLY PIPE					
FWB	FLUSHING WATER SUPPLY PIPE					
DWB	DWB PIPE THROUGH ROOSTER PUMP					
G	GEYSER TOILET GEYSER DELTR					
G	GEYSER KITCHEN GEYSER DELTR					
P	ROOSTER PUMP SET FOR TOP TWO FLOORS					
C	CATCH BASIN 1100x500mm					

NOTE:-
1. The kitchen space has been considered as non-habitable space as per NBC 2016 Part-3 Section 2.4.5 Clause, thus lighting and ventilation clause for kitchen do not apply only for main units kitchen.
2. Toilets are mechanically ventilated wherever marked in plan.

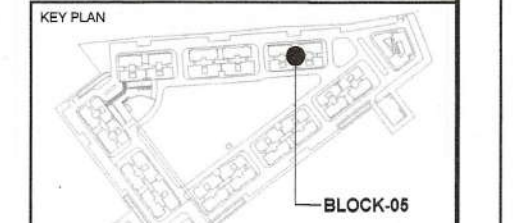

PROJECT
REVISED BUILDING PLANS FOR GROUP HOUSING COLONY UNDER MIXED LAND USE IN T-20 ZONE FOR AN AREA MEASURING 16.1125 ACRES (89% GROUP HOUSING COMPONENT AND 11% COMMERCIAL COMPONENT) LICENSE NO.108 OF 2022 DATED 05.08.2022 IN REVENUE ESTATE OF CHAMRA SECTOR-113 GURUGRAM MANESAR URBAN COMPLEX BEING DEVELOPED BY M/S NOURISH DEVELOPERS PVT. LTD.

DATE: 03/16/24
Scale: 1:100
Drawing No: 13

FOR THE ARCHITECT
Rajesh Dutt
FOR THE CLIENT
Rajesh Dutt

FOR THE SUPERINTENDING ENGINEER
Rajesh Dutt

FOR THE CHIEF ENGINEER-I
Rajesh Dutt

FOR THE CHIEF ENGINEER-II
Rajesh Dutt

FOR THE CHIEF ENGINEER-III
Rajesh Dutt