



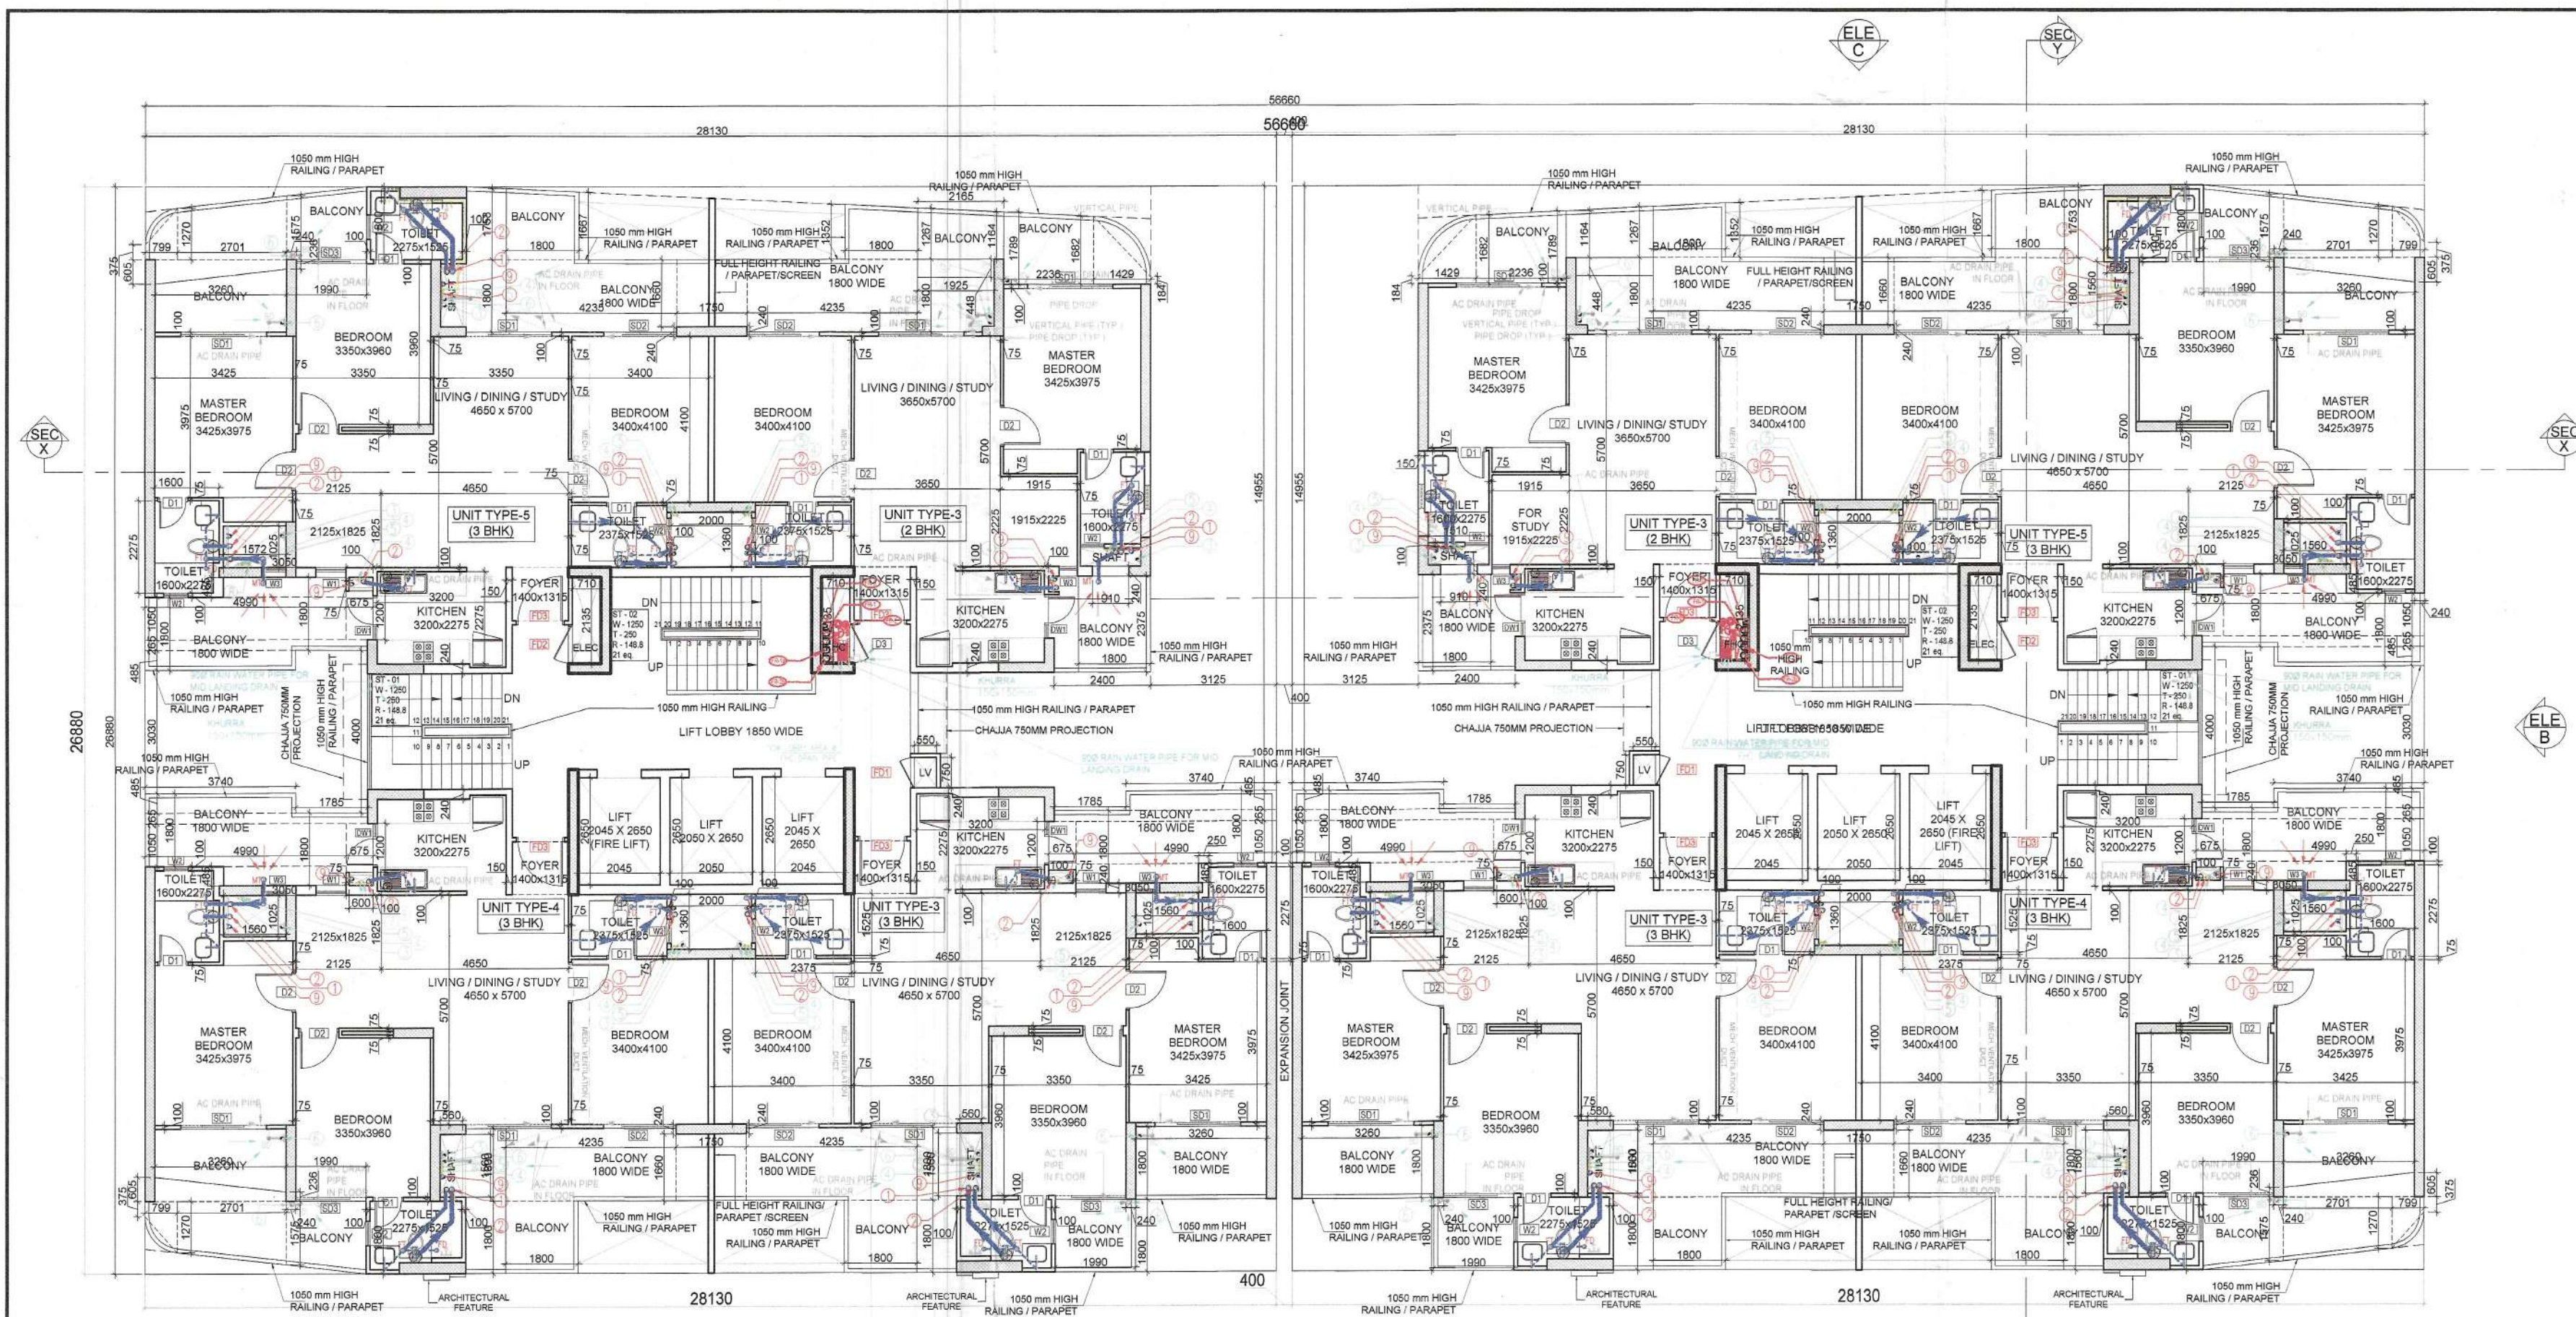

(TOWER-I)

26th, 27th, & 28th FLOOR PLAN
(BLOCK - 5)

(TOWER-J)

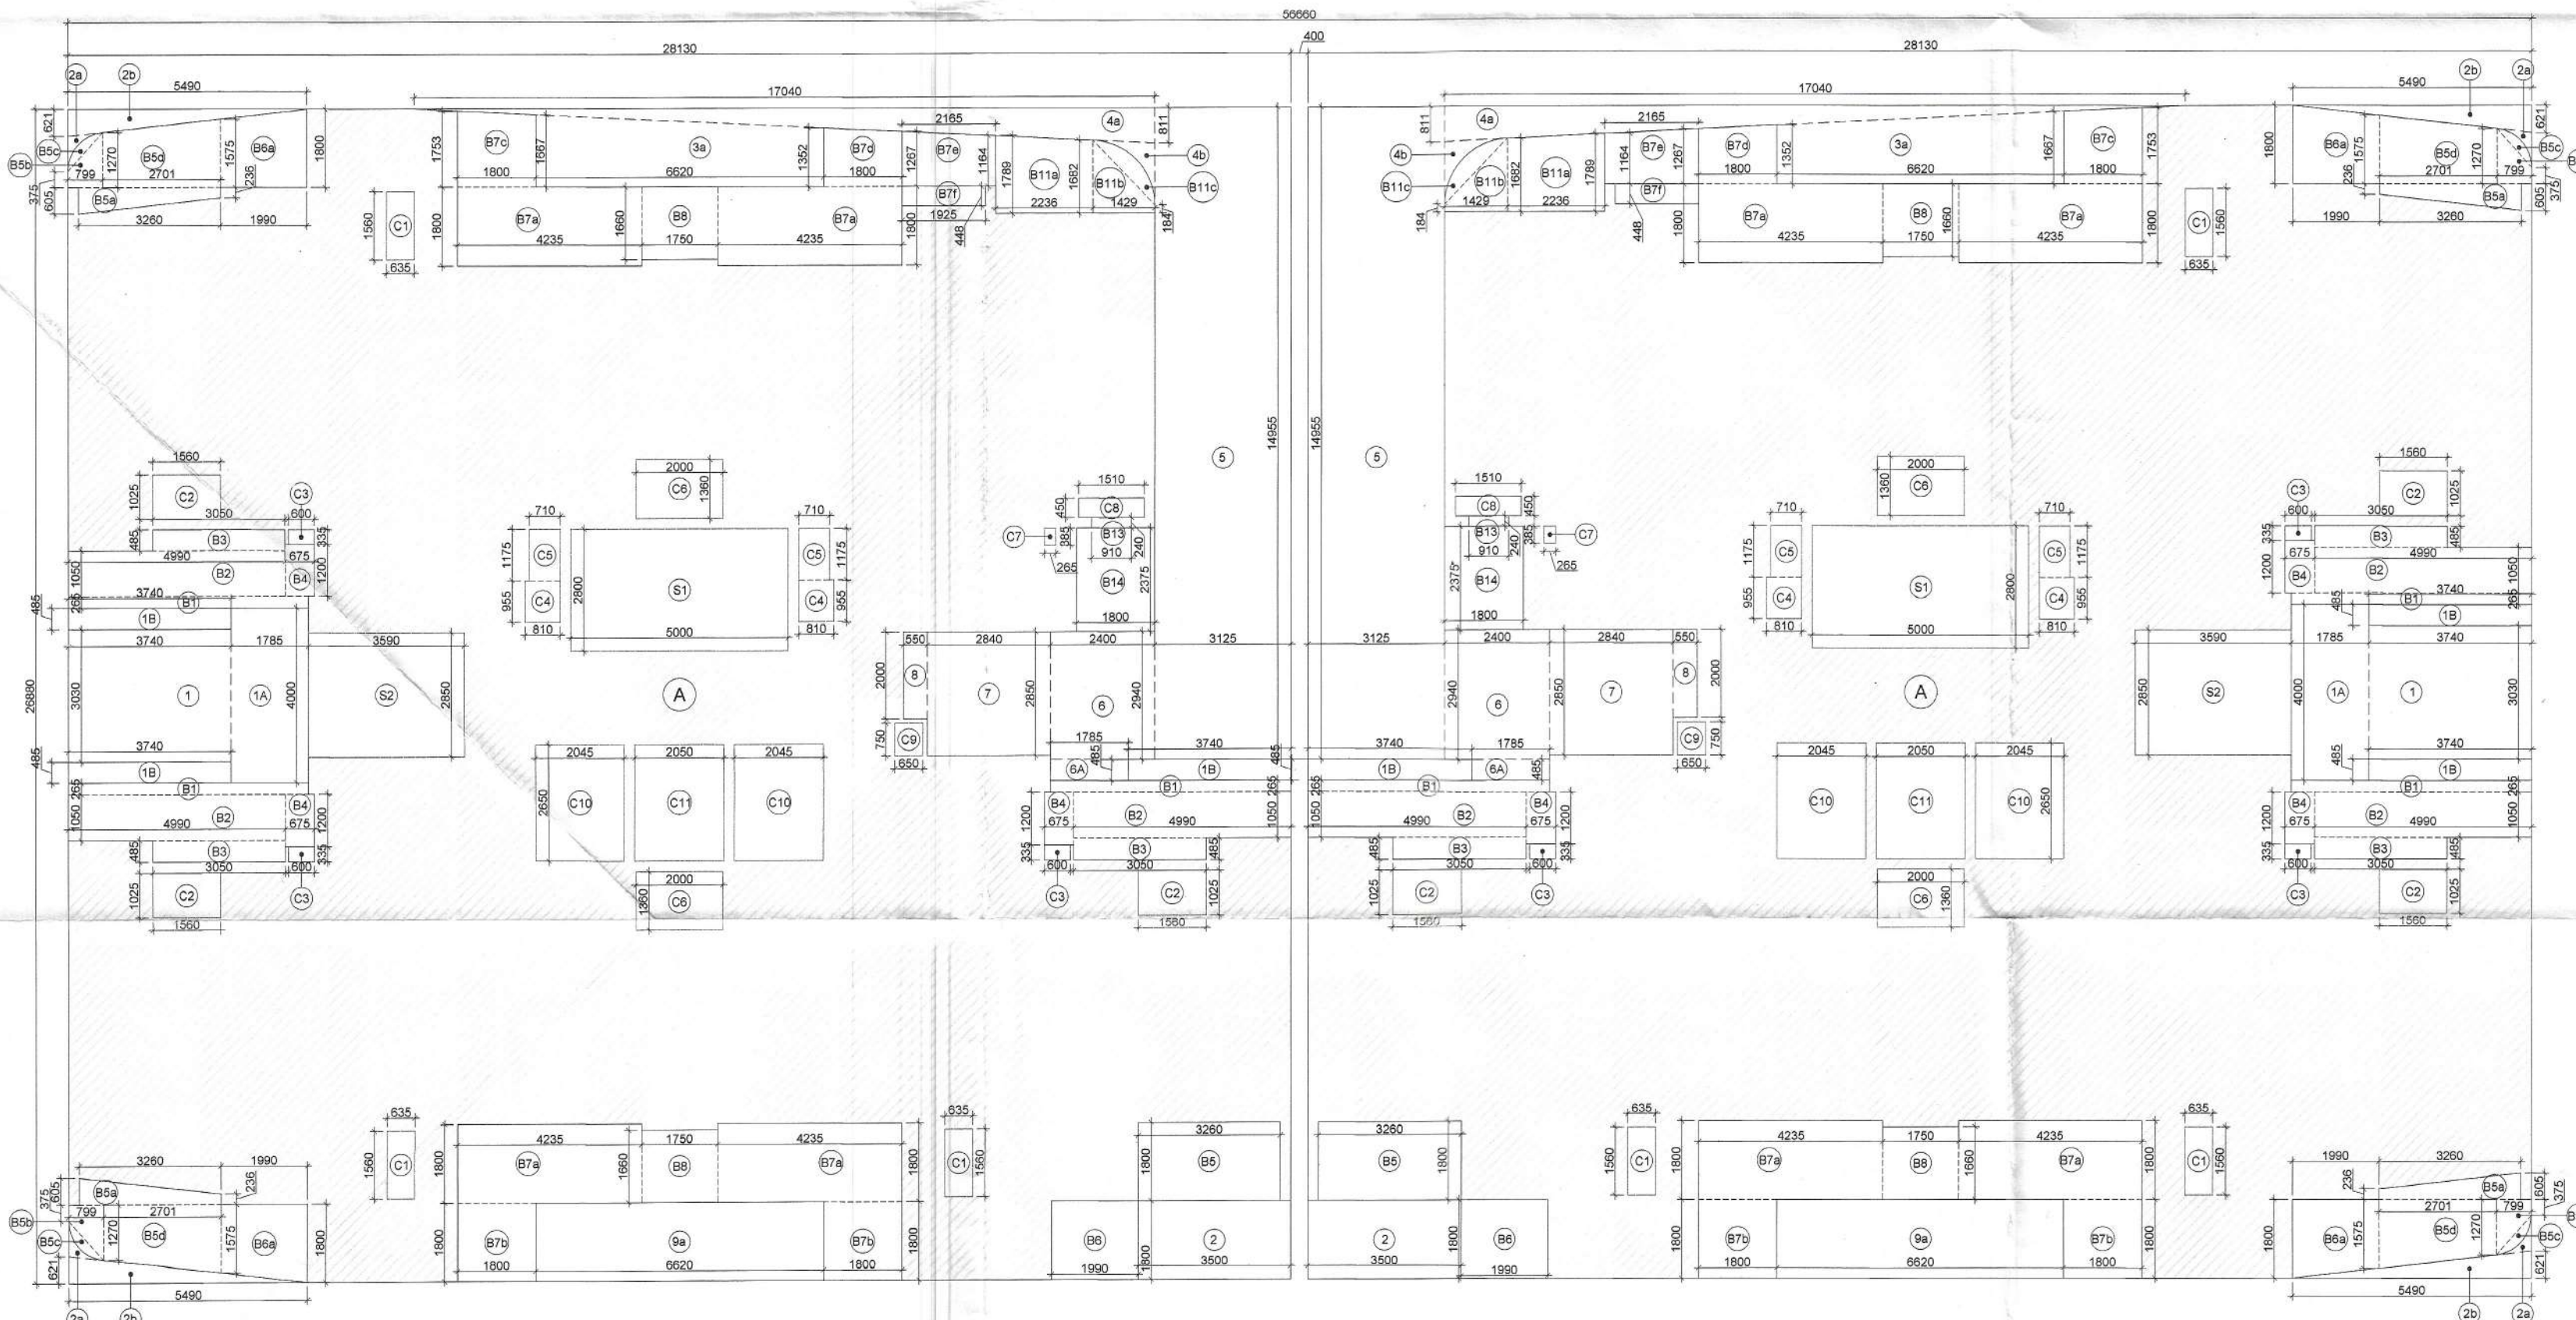


(TOWER-I)

26th, 27th, & 28th FLOOR AREA DIAGRAM
(BLOCK 05)

(TOWER-J)

AREA CALCULATION FOR 26TH, 27TH & 28TH FLOOR						
ENVELOPE AREA						
S.NO.	NOS.	FORMULA	LENGTH (L)	WIDTH (W)	AREA	UNITS
A	2	L X W	28.130	26.880	1512.269	SQM.
TOTAL (A) =					1512.269	SQM.
BALCONY						
B1	6	L X W	5.525	0.265	8.785	SQM.
B2	6	L X W	4.990	1.050	31.437	SQM.
B3	6	L X W	3.050	0.485	8.876	SQM.
B4	6	L X W	0.675	1.200	4.860	SQM.
B5	2	L X W	3.260	1.800	11.736	SQM.
B5a	4	1/2 (W+W')XL	3.260	0.605	5.483	SQM.
B5b	4	1/2 (W+W')XL	0.799	0.375	2.629	SQM.
B5c	4	PUNE AREA			0.752	SQM.
B5d	4	1/2 (W+W')XL	2.701	1.270	15.369	SQM.
B6	2	L X W	1.990	1.800	7.164	SQM.
B6a	4	1/2 (W+W')XL	1.990	1.575	13.433	SQM.
B7a	8	L X W	4.235	1.800	60.984	SQM.
B7b	4	L X W	1.800	1.800	12.960	SQM.
B7c	2	1/2 (W+W')XL	1.800	1.667	6.156	SQM.
B7d	2	1/2 (W+W')XL	1.800	1.267	4.714	SQM.
B7e	2	1/2 (W+W')XL	2.165	1.164	5.263	SQM.
B7f	2	L X W	1.925	0.448	1.725	SQM.
B8	4	L X W	1.750	1.660	11.620	SQM.
B11a	2	1/2 (W+W')XL	2.236	1.682	7.761	SQM.
B11b	2	1/2 (W+W')XL	1.429	0.184	2.667	SQM.
B11c	2	PUNE AREA			1.178	SQM.
B13	2	L X W	0.910	0.240	0.437	SQM.
B14	2	L X W	1.800	2.375	8.550	SQM.
1B	6	L X W	3.740	0.485	10.883	SQM.
TOTAL (B) =					245.420	SQM.
CUT OUT / DEDUCTION AREA						
1	2	L X W	3.740	3.030	22.664	SQM.
1A	2	L X W	1.785	4.000	14.280	SQM.
2	2	L X W	3.500	1.800	12.600	SQM.
2a	4	PUNE AREA			0.532	SQM.
2b	4	1/2 X L X W	5.490	0.621	6.819	SQM.
3a	2	1/2 (W+W')XL	6.620	1.352	19.986	SQM.
4a	2	1/2 X L X W	17.040	0.811	13.819	SQM.
4b	2	PUNE AREA			0.862	SQM.
5	2	L X W	3.125	14.955	93.469	SQM.
6	2	L X W	2.400	2.940	14.112	SQM.
6A	2	L X W	1.785	0.485	1.731	SQM.
7	2	L X W	2.840	2.850	16.188	SQM.
8	2	L X W	0.550	2.000	2.200	SQM.
9a	2	L X W	6.620	1.800	23.832	SQM.
C1	6	L X W	0.635	1.560	5.944	SQM.
C2	6	L X W	1.560	1.025	9.594	SQM.
C3	6	L X W	0.600	0.335	1.206	SQM.
C4	4	L X W	0.810	0.955	3.094	SQM.
C5	4	L X W	0.710	1.175	3.337	SQM.
C6	4	L X W	2.000	1.360	10.880	SQM.
C7	2	L X W	0.265	0.385	0.204	SQM.
C8	2	L X W	1.510	0.450	1.359	SQM.
C9	2	L X W	0.650	0.750	0.975	SQM.
C10	4	L X W	2.045	2.650	21.677	SQM.
C11	2	L X W	2.050	2.650	10.865	SQM.
TOTAL (C) =					312.229	SQM.
NON FAR AREA						
S1	2	L X W	5.000	2.800	28.000	SQM.
S2	2	L X W	3.590	2.850	20.463	SQM.
TOTAL (D) =					48.463	SQM.
TOTAL FAR AREA (A-(B+C+D))					906.166	SQM.
TOTAL COVERED AREA = (A-(B+C))					954.619	SQM.
TOTAL BUILT UP AREA (A-C)					1200.040	SQM.

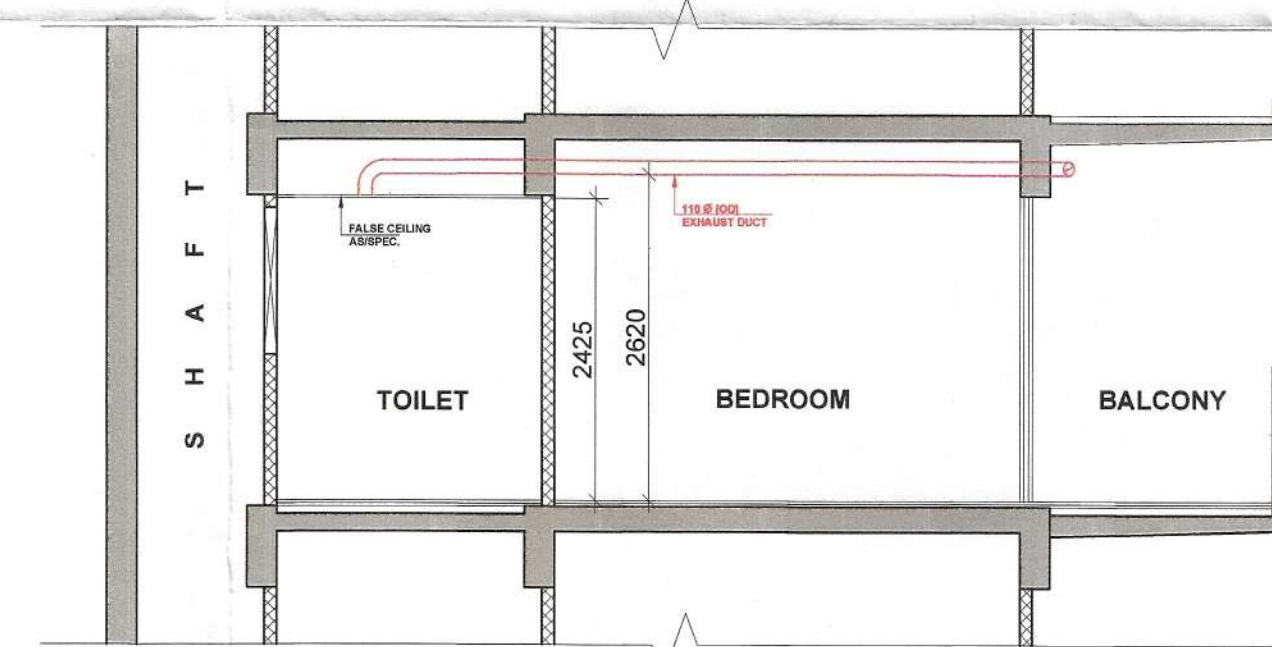

This is a "PROVISIONAL BUILDING PLAN" approved only for the purpose of inviting Objections from the general public.

DDT (M) MEMBER BPAC

S.T.P. (H) Member Secretary B.P.A.C.

S.T.P. (G) Member Secretary B.P.A.C.

S.T.P. (H) Member Secretary B.P.A.C.

Consultant Architect

ATP (H)

ATP

Atul Dutt J.D. (H)

Checked and found ok for Public Health (Internal) Service only subject to compliance in long term.

15/03/24


24/01/24

Superintending Engineer (H) for Chief Engineer HSP, Paschikula

DOOR WINDOW OPENING SCHEDULE						
TYPE	WIDTH	HEIGHT	CELL	UNITS	FIRE RATING	
D1	750	2425	00	2425		
D2	1000	2425	00	2425		
DW1	1075	2425	00	2425		
DW2	2850	2425	00	2425		
DW3	4075	2425	00	2425		
GL1	6050	2425	00	2425		
SD	800	2325	100	2425		
SD1	2125	2425	00	2425		
SD2	1800	2425	00	2425		
SD3	1750	2425	00	2425		
W1	750	1225	00	2425		
W2	600	1225	1200	2425		
W3	600/450	1525	00	2425		
W4	2100	1525	00	2425		
W5	1400	1525	00	2425		
V1	600	825	1500	2425		
F1	750	2325	100	2425	21H FIRE	
F2	800	2325	100	2425	21H FIRE	
F3	800	2325	100	2425	21H FIRE	
F4	1200	2425	00	2425	21H FIRE	
F5	1200	2425	00	2425	21H FIRE	
F6	1200	2100	00	2100	21H FIRE	

PLUMBING LEGEND:	
①	1100 SOIL PIPE
②	1100 WASTE PIPE
③	1100 RAIN WATER PIPE
④	DN 100 DN TAKE PIPE
⑤	DN 100 DN TAKE PIPE
⑥	DN 100 DN TAKE PIPE
⑦	DN 100 DN TAKE PIPE
⑧	DN 100 DN TAKE PIPE
⑨	DN 100 DN TAKE PIPE
⑩	DN 100 DN TAKE PIPE
⑪	DN 100 DN TAKE PIPE
⑫	DN 100 DN TAKE PIPE
⑬	DN 100 DN TAKE PIPE
⑭	DN 100 DN TAKE PIPE
⑮	DN 100 DN TAKE PIPE
⑯	DN 100 DN TAKE PIPE
⑰	DN 100 DN TAKE PIPE
⑱	DN 100 DN TAKE PIPE
⑲	DN 100 DN TAKE PIPE
⑳	DN 100 DN TAKE PIPE
㉑	DN 100 DN TAKE PIPE
㉒	DN 100 DN TAKE PIPE
㉓	DN 100 DN TAKE PIPE
㉔	DN 100 DN TAKE PIPE
㉕	DN 100 DN TAKE PIPE
㉖	DN 100 DN TAKE PIPE
㉗	DN 100 DN TAKE PIPE
㉘	DN 100 DN TAKE PIPE
㉙	DN 100 DN TAKE PIPE
㉚	DN 100 DN TAKE PIPE
㉛	DN 100 DN TAKE PIPE
㉜	DN 100 DN TAKE PIPE
㉝	DN 100 DN TAKE PIPE
㉞	DN 100 DN TAKE PIPE
㉟	DN 100 DN TAKE PIPE
㊱	DN 100 DN TAKE PIPE
㊲	DN 100 DN TAKE PIPE
㊳	DN 100 DN TAKE PIPE
㊴	DN 100 DN TAKE PIPE
㊵	DN 100 DN TAKE PIPE
㊶	DN 100 DN TAKE PIPE
㊷	DN 100 DN TAKE PIPE
㊸	DN 100 DN TAKE PIPE
㊹	DN 100 DN TAKE PIPE
㊺	DN 100 DN TAKE PIPE
㊻	DN 100 DN TAKE PIPE
㊼	DN 100 DN TAKE PIPE
㊽	DN 100 DN TAKE PIPE
㊾	DN 100 DN TAKE PIPE
㊿	DN 100 DN TAKE PIPE

NOTE:-
1. The kitchen space has been considered as non-habitable space as per NBC 2016 Part-3 Section 2.4.5 clause. Thus lighting and ventilation clause for kitchen do not apply only for main units kitchen.
2. Toilets are mechanically ventilated wherever marked in plan.

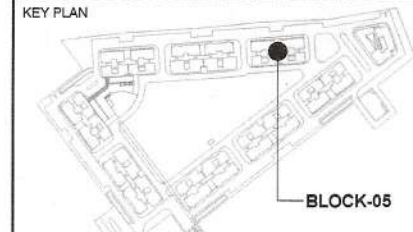

PROJECT
REVISED BUILDING PLANS FOR GROUP HOUSING COLONY UNDER MIXED LAND USE IN T.O. ZONE FOR AN AREA MEASURING 16.1125 ACRES (89% GROUP HOUSING COMPONENT AND 11% COMMERCIAL COMPONENT) (LICENSE NO. 198 OF 2022 DATED 05.08.2022) IN REVENUE ESTATE OF CHALMA, SECTOR-113, GURUGRAM MANESAR URBAN COMPLEX, BEING DEVELOPED BY M/S NOURISH DEVELOPERS PVT. LTD.

OWNER'S SEAL & SIGNATURE

Architect's Seal & Signature

REGD. No. 93/11-197

Scale: 1:100

Drawing No: BLOCK 05: TOWER-I & J

26TH, 27TH & 28TH FLOOR PLAN & AREA DIAGRAMS

17