



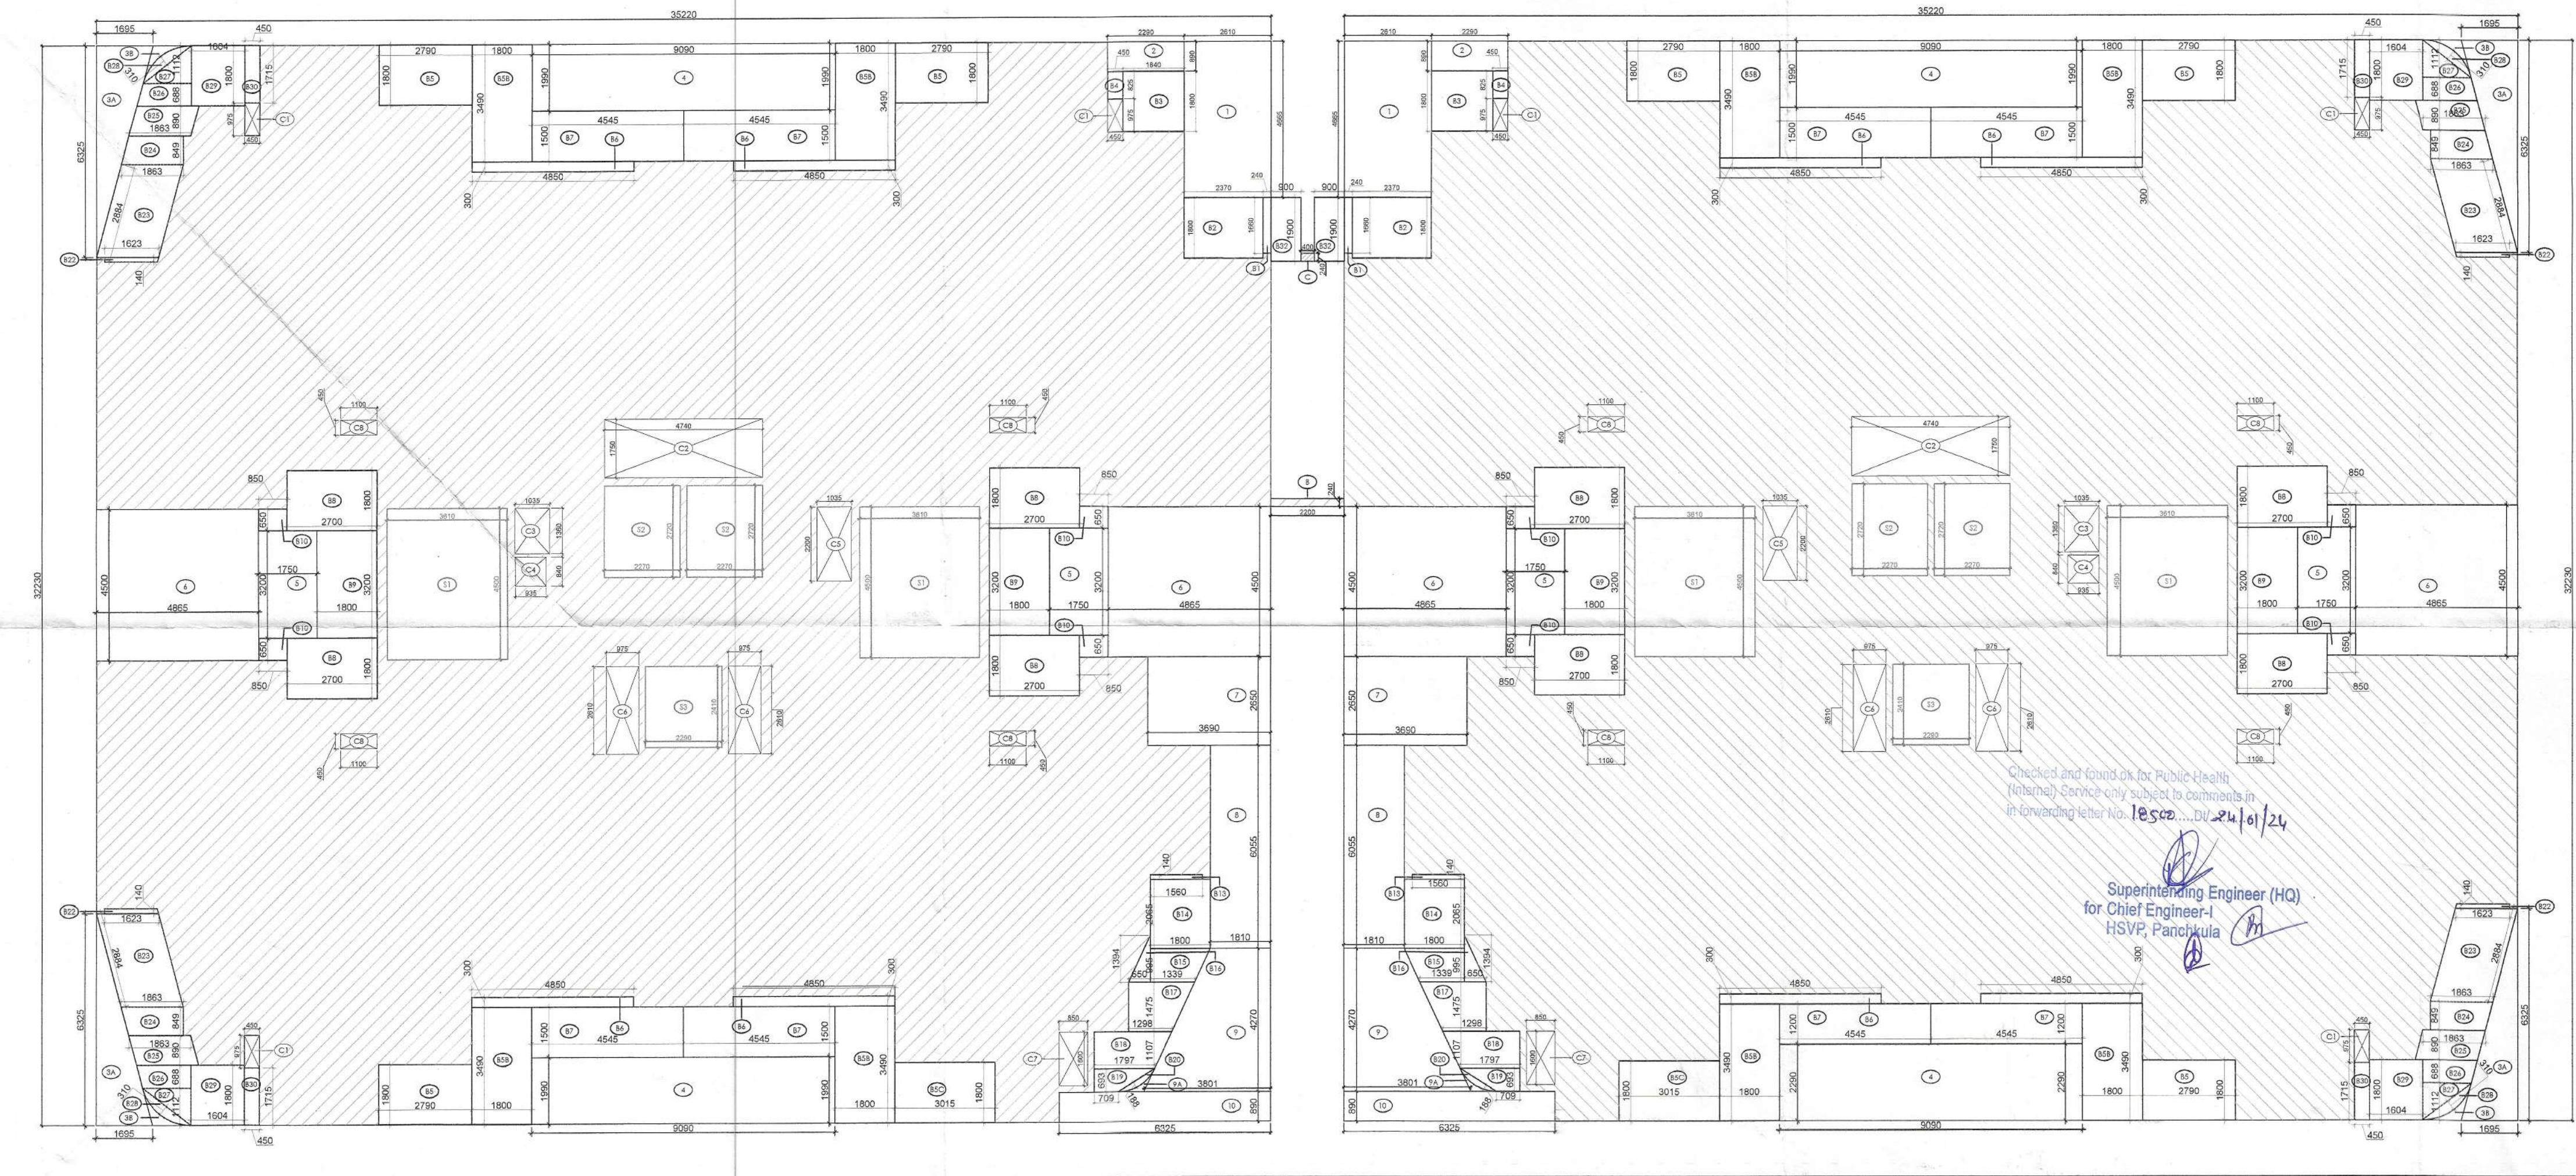

Checked and found ok for Public Health
(Internal) Service only subject to comments in
in forwarding letter No. 18500....DI/24.6/24

Superintending Engineer (H
for Chief Engineer-I
HSVP, Panchkula

This is a "PROVISIONAL BUILDING PLAN"
approved only for the purpose of inviting
Objections from the general public

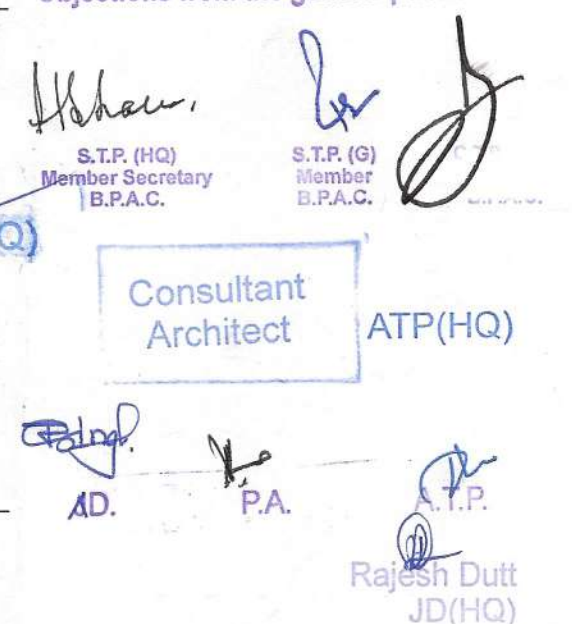


Rajesh Dut
JD(HQ

<u>PLUMBING LEGEND:-</u>	
①	110Ø SOIL PIPE
②	110Ø WASTE PIPE
③	110Ø RAIN WATER PIPE
④	DWS DN TAKE PIPE
⑤	DWS FROM BOOSTER PUMP FOR TWO FLOOR
⑥	FWS DN TAKE PIPE
⑦	110Ø BALCONY DRAIN PIPE
⑧	65Ø DOMESTIC WATER SUPPLY RISER
⑨	50Ø FLUSHING WATER SUPPLY RISER
⑩	75Ø ANTISYPHONAGE PIPE
WB TO FT	32Ø WASTE PIPE
SINK TO FT	50Ø WASTE PIPE
FD	FLOOR DRAIN WITH GRATING
FT	FLOOR TRAP WITH GRATING
MT	MULTI TRAP WITH GRATING
BD	BALCONY DRAIN WITH GRATING
DWS	DOMESTIC WATER SUPPLY PIPE
FWS	FLUSHING WATER SUPPLY PIPE
DWS	DWS PIPE THROUGH BOOSTER PUMP
⊙ GEYSER	TOILET GEYSER 25LTR
⊙ GEYSER	KITCHEN GEYSER 6LTR
P	BOOSTER PUMP SET FOR TOP TWO FLOOR
	CATCH BASIN 1100x500mm

1. The kitchen space has been considered as non-habitable space as per NBC 2017 Part-3 Section 2.45 clause, thus light and ventilation clause for kitchen do not apply only for main units kitchen.

2. Toilets are mechanically ventilated wherever marked in plan.

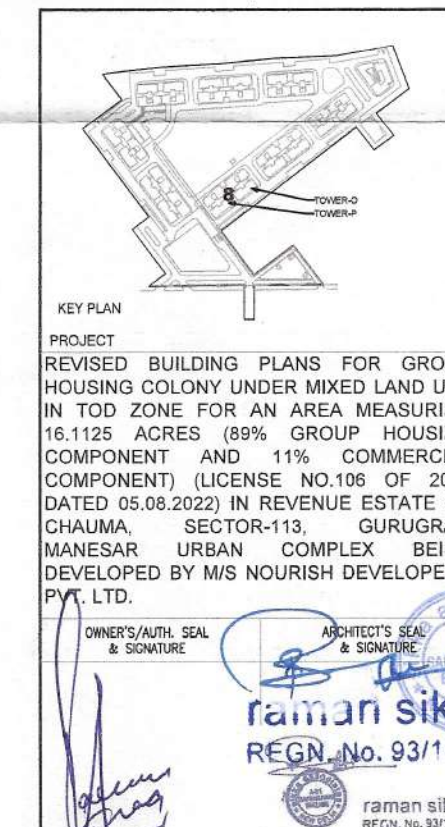

Scale :	
Drawing Title:-	Drawing No:-
BLOCK - 08 : 2, 8, 26, 27TH FLOOR PLAN & AREA	45