


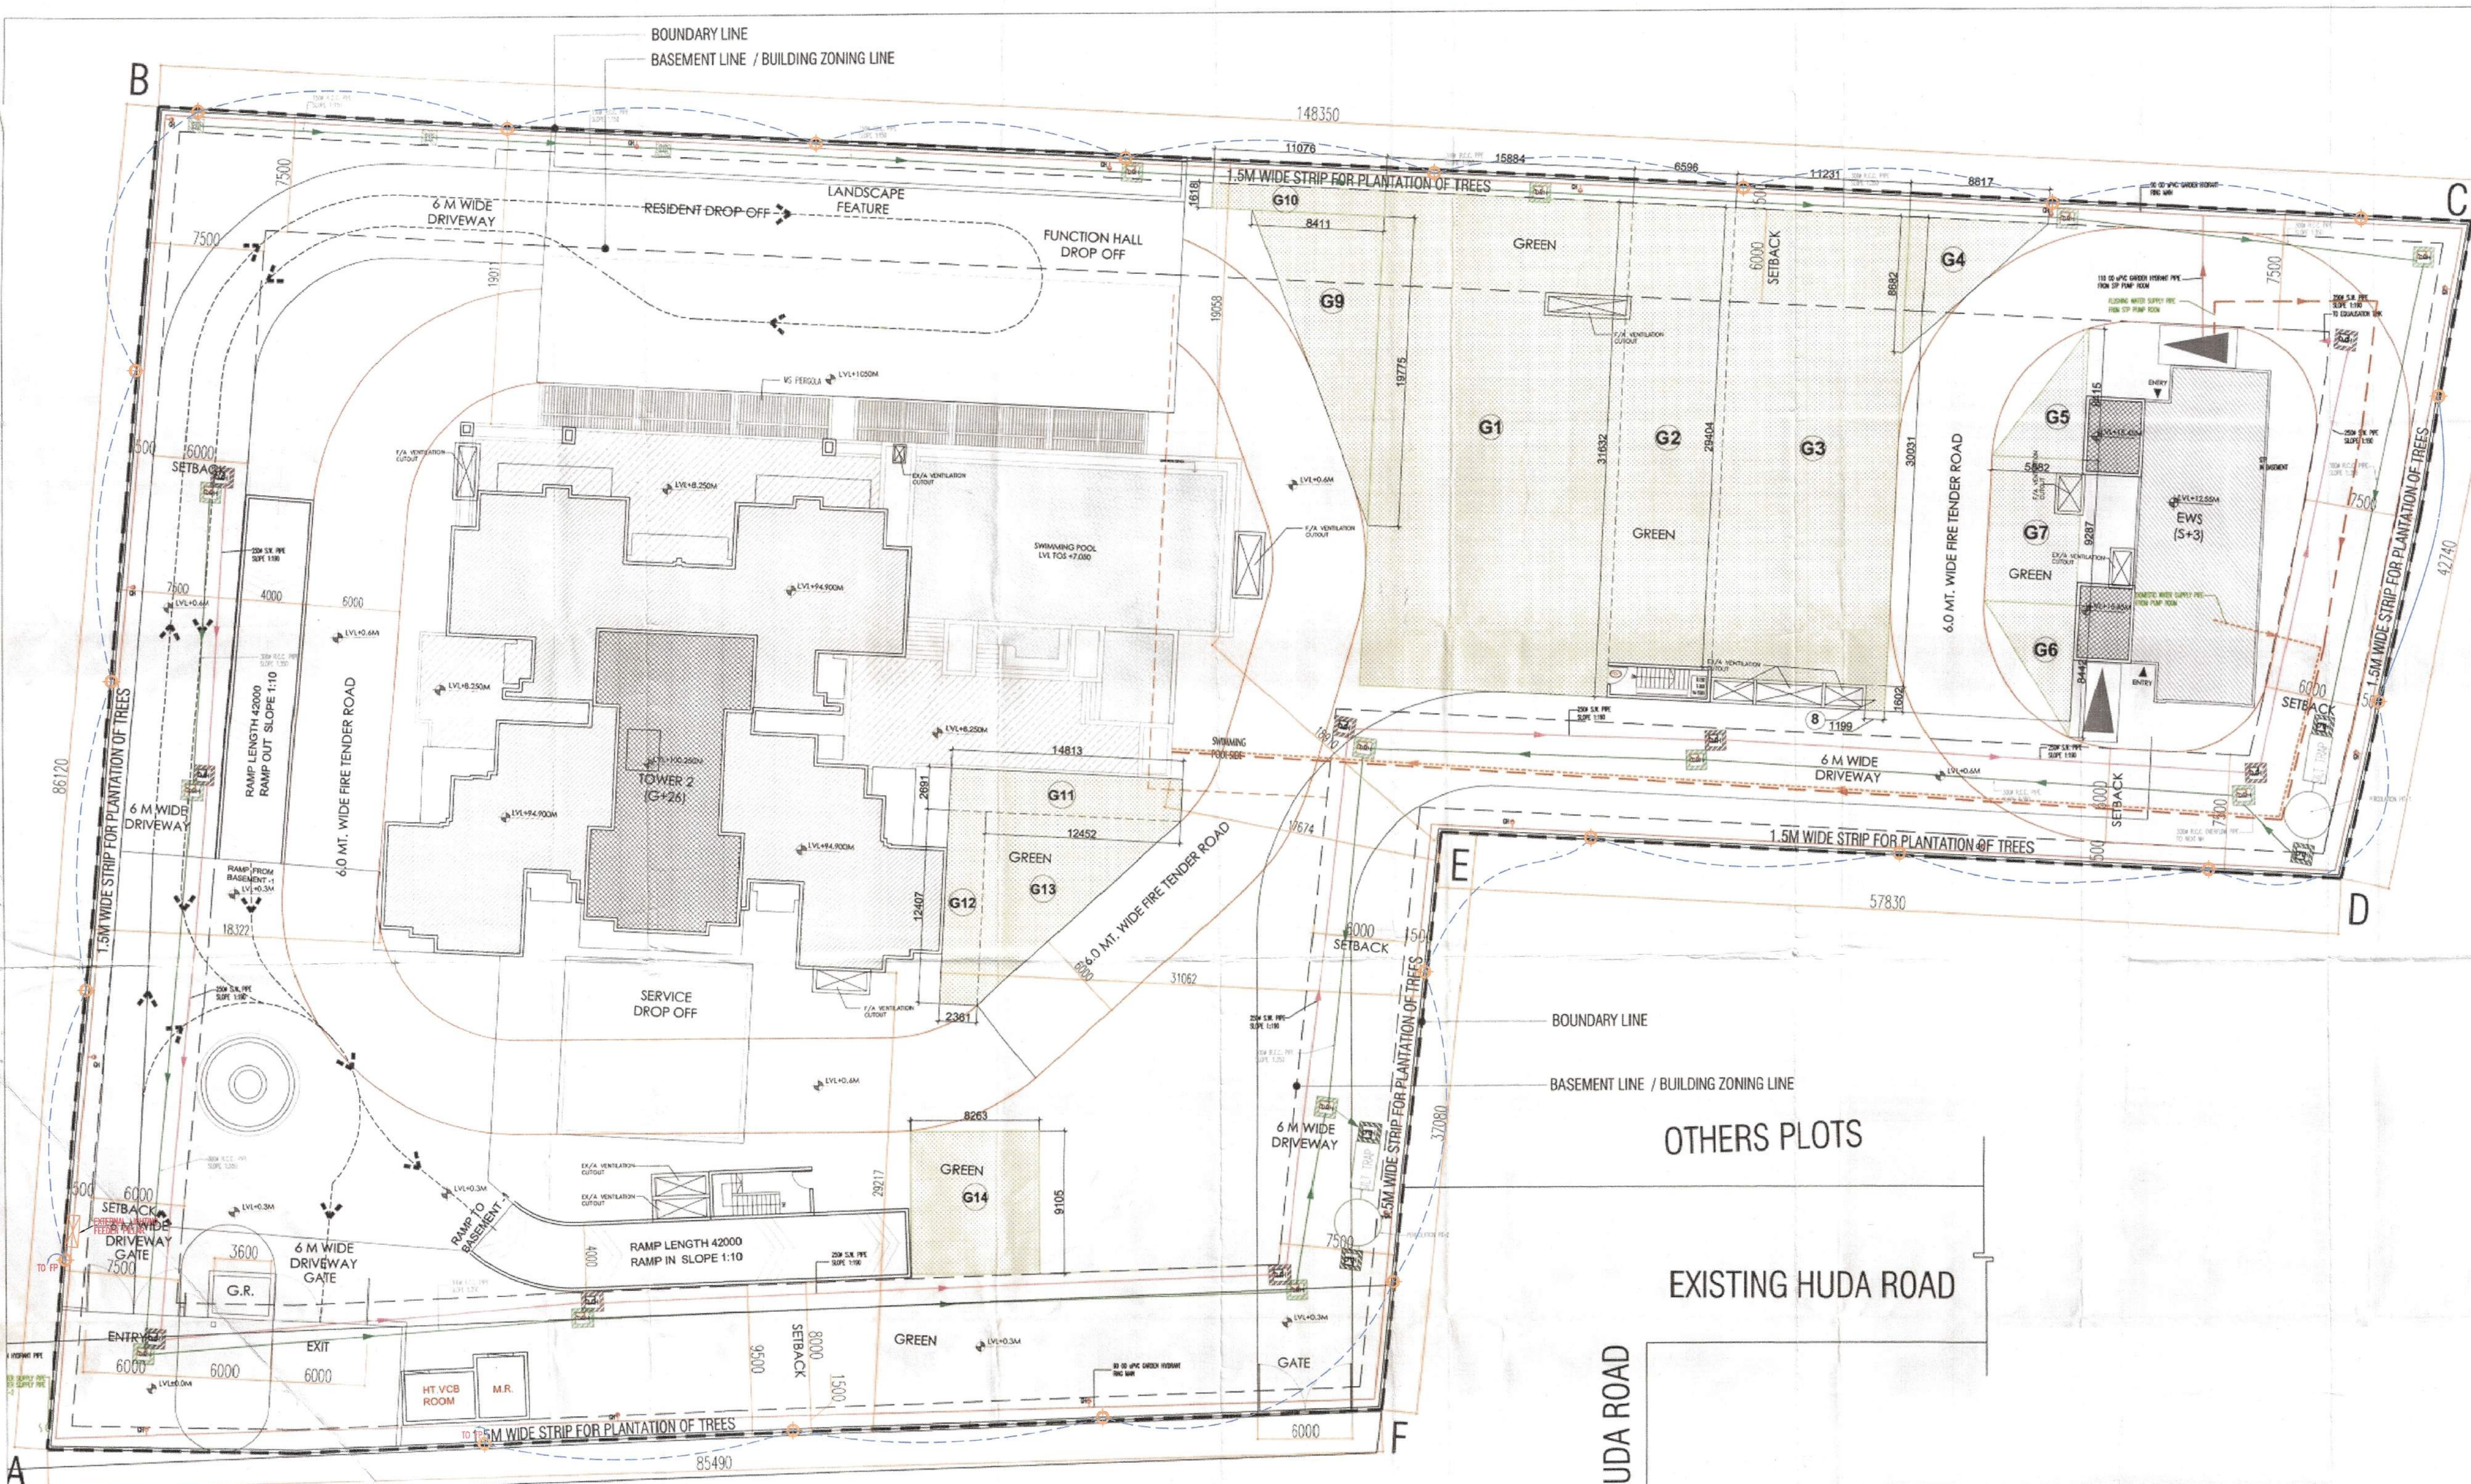

10 M WIDE ROAD

OTHERS PLOTS

EXISTING HUDA ROAD

OTHERS PLOTS

NOTES & REFERENCES

Director
Town & Country Planning
Haryana, Chandigarh

POCKET-2

LEGEND:

S.R. = GURD ROOM
M.R. = METER ROOM

DESIGN ARCHITECT :-

KA

RAJINDER KUMAR ASSOCIATES

ARCHITECTS 8-417 SHOPPING CENTRE
PLANNERS RAJAPURAM GHAZIABAD, U.P. INDIA
DESIGNERS NEW DELHI - 110029
ENGINEERS T 91 11 2610203-31
F 91 11 2610204

STRUCTURAL ENGINEER:

738(S-2) Second Floor
Nili Khand - 1,
Indrapuram Ghaziabad, U.P. India.
Cell: +91-9671122470
Email: santosh.singh@edr-group.com
Web: www.edr-group.com

CONSULTING ENGINEERS

CLIENT NAME:

PAX PROPERTIES PVT. LTD. IN COLLABORATION
WITH ALPHA CORP DEVELOPMENT PVT. LTD.

PROJECT TITLE

PROPOSED BUILDING PLAN OF GROUP HOUSING COLONY
FOR AN AREA
MEASURING 2.3828 ACRES (LICENSE NO. 12 OF 2018
DATED 09.02.2018) BEING DEVELOPED BY
PAX PROPERTIES PVT. LTD. IN
COLLABORATION WITH ALPHA CORP DEVELOPMENT
PVT. LTD.
IN THE REVENUE ESTATE OF VILLAGE
GURUGRAM, SECTOR-15,
PART-II, GURUGRAM, MANESAR URBAN COMPLEX,
TEHSIL & DISTRICT GURUGRAM, HARYANA.

CLIENT'S SIGNATURE & STAMP:

[Signature]

ARCHITECT'S SIGNATURE & SEAL:

RAJINDER KUMAR
For Service Estimate
Executive Engineer
HSVP Division No.1
Gurgaon

[Signature]

Stamp: Rajinder Kumar Associates, 8-417 Shopping Centre, Rajapuram Ghaziabad, U.P. India. Cell: +91-9671122470, Email: santosh.singh@edr-group.com, Web: www.edr-group.com.

DRAWING STATUS

SUBMISSION DRAWING

DRAWING TITLE

POCKET-2
SITE PLAN

SCALE - 1:100

DATED - APRIL - 2018

DWG. NUMBER

SUB-P2-AR-SITE

REVISIONS

R0

EXTERNAL LIGHTING LAYOUT