



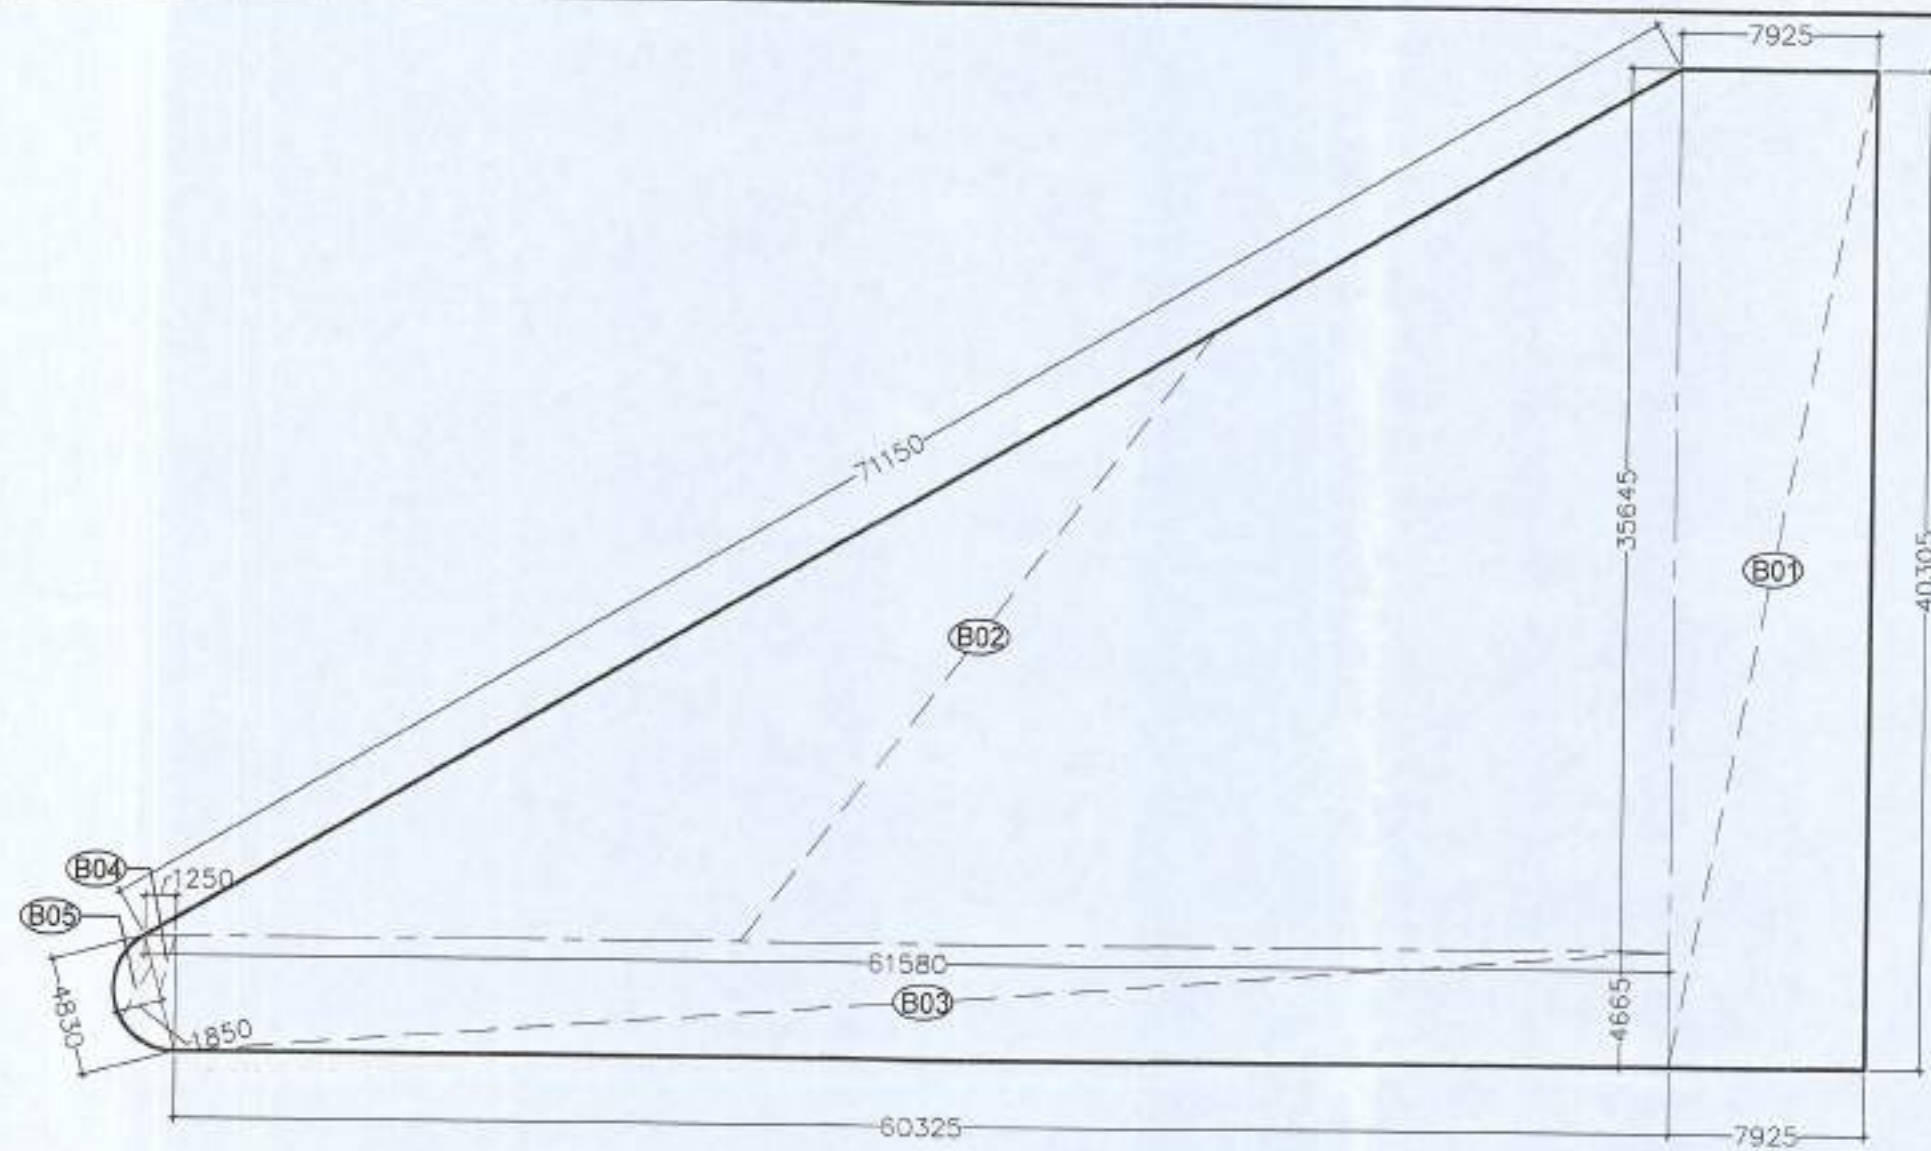

| BASEMENT-01 AREA CALCULATION                          |        |         |         |     |      |              |
|-------------------------------------------------------|--------|---------|---------|-----|------|--------------|
| TOTAL COVERED AREA AT BASEMENT-01 = ENVELOPE AREA (A) |        |         |         |     |      |              |
| ENVELOPE AREA (A)                                     |        |         |         |     |      |              |
| S.No.                                                 | Length | Breadth | Formula | No. |      | Area (SQM)   |
| B01                                                   | 7.925  | X       | 40.305  | X   | 1.00 | 1 = 319.417  |
| B02                                                   | 61.580 | X       | 35.645  | X   | 0.50 | 1 = 1097.510 |
| B03                                                   | 60.325 | X       | 4.665   | X   | 1.00 | 1 = 281.416  |
| B04                                                   | 1.250  | X       | 4.665   | X   | 0.50 | 1 = 2.916    |
| B05                                                   | 1.850  | X       | 4.830   | X   | 0.67 | 1 = 5.987    |
| TOTAL ENVELOPE AREA (A)                               |        |         |         |     |      | 1707.245     |

| Staircase Calculation For 1st. Basement Floor |                                  |                 |                            |                     |                       |
|-----------------------------------------------|----------------------------------|-----------------|----------------------------|---------------------|-----------------------|
| Total floor area                              |                                  |                 | 1707.245                   |                     | sqm                   |
| Floors                                        | Average occupant load as per NBC | No. of occupant | As per NBC (10/min/Person) | Stair case Required | Stair case Provided   |
| Mercantile Area                               | 1707.245                         | 30              | 58.91                      | 10                  | 589.08                |
|                                               |                                  |                 |                            |                     | ST-01 = 1800 MM       |
|                                               |                                  |                 |                            |                     | ST-02 = 1500 MM       |
|                                               |                                  |                 |                            |                     | TOTAL STAIR = 3300 MM |

1st. BASEMENT FLOOR PLAN ( BLOCK-B )  
LVL. - 3.550 M

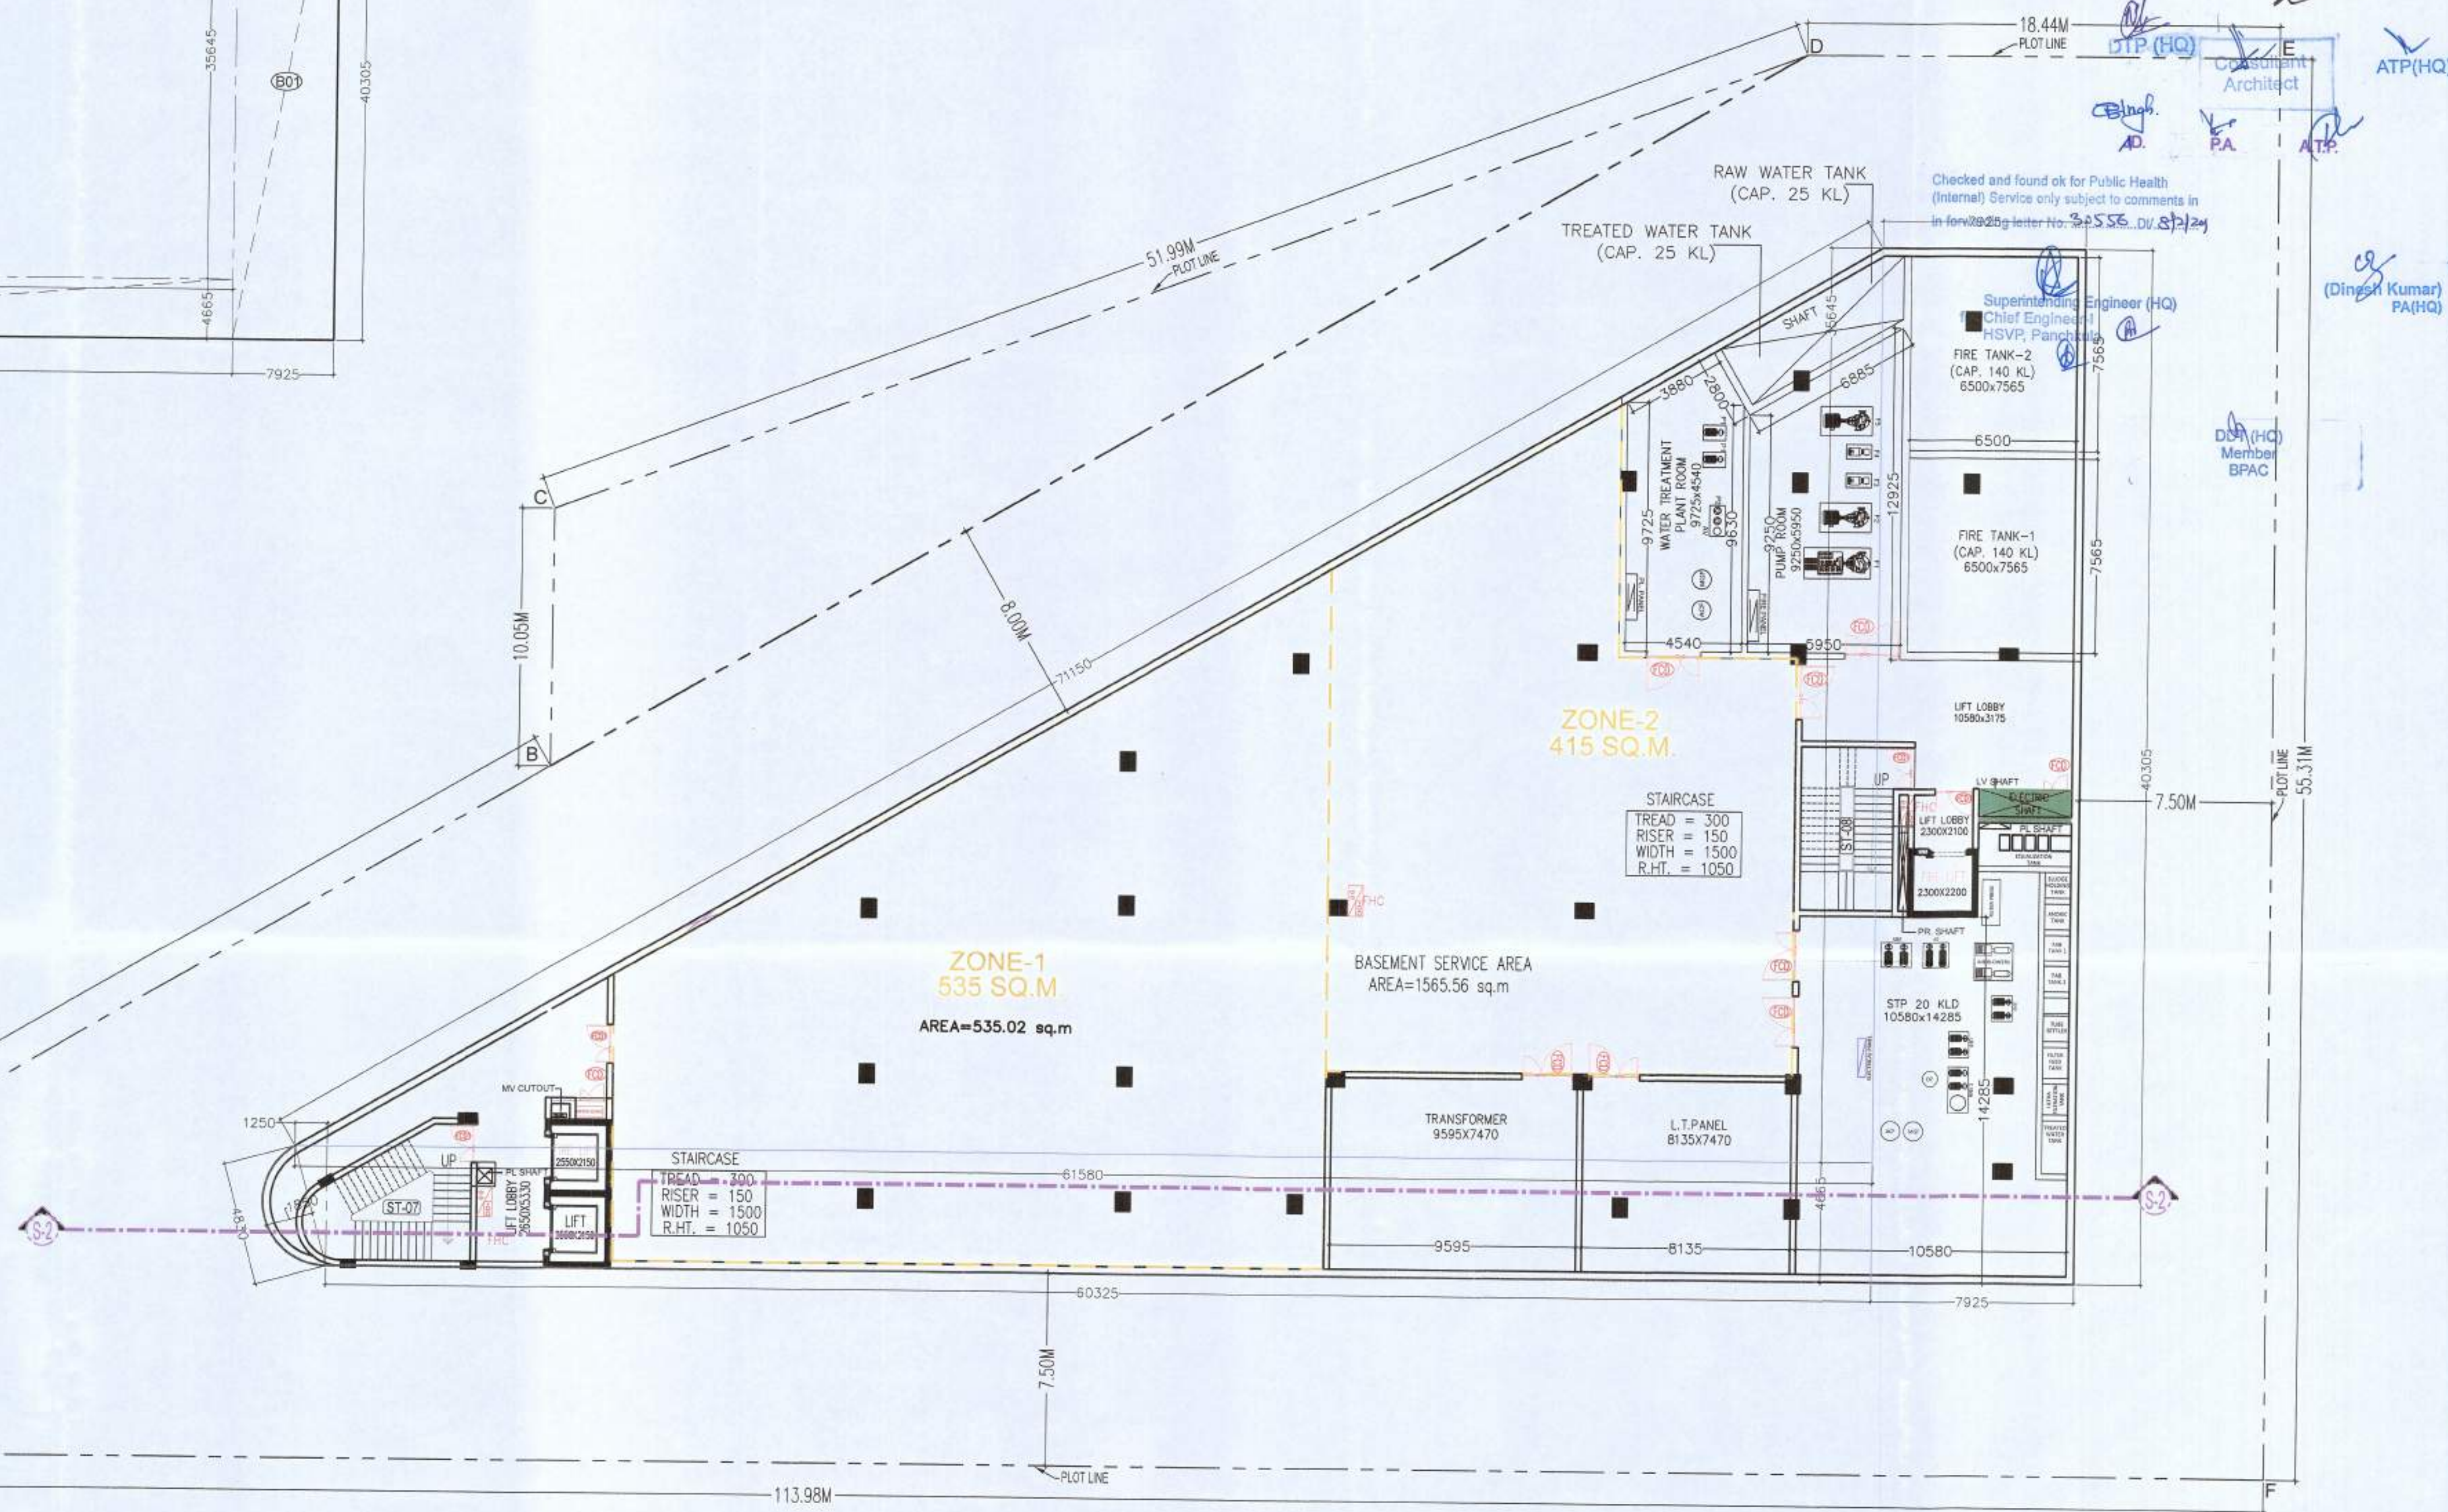

| SCHEDULE OF OPENINGS |       |        |          |        |
|----------------------|-------|--------|----------|--------|
| TYPE                 | WIDTH | HEIGHT | SILL HT. | LINTEL |
| D2                   | 750   | 2100   | 300      | 2100   |
| D3                   | 1000  | 2100   | -        | 2100   |
| D4                   | 900   | 2100   | -        | 2100   |
| D5                   | 2100  | 2100   | -        | 2100   |
| D6                   | 1500  | 2100   | -        | 2100   |
| FCD                  | 2000  | 2100   | -        | 2100   |
| FCD1                 | 1500  | 2100   | -        | 2100   |
| W1                   | 3800  | 2470   | 900      | 3370   |
| W2                   | 9000  | 2470   | 900      | 3370   |
| W3                   | 2000  | 2100   | 600      | 1500   |

| LEGEND FOR PLUMBING |                                           |
|---------------------|-------------------------------------------|
| ①                   | 110 OD SRR PVC SOIL & VENT PIPE           |
| ②                   | 110 OD SRR PVC WASTE & VENT PIPE          |
| ③                   | DNMS RISER PIPE                           |
| ④                   | DNMS RISER PIPE                           |
| ⑤                   | 180 OD uPVC RAIN WATER PIPE (FOR TERRACE) |
| ⑥                   | 110 OD uPVC RAIN WATER PIPE (FOR TERRACE) |
| ⑦                   | DNMS RISER TO D.H.T. FILLING              |
| FT                  | FLOOR TRAP                                |
| FD                  | FLOOR DRAIN                               |
| UT                  | URINAL TRAP                               |

For AMEYA COMMERCIAL PROJECTS PVT. LTD.

**GIAN P. MATHUR**  
ARCHITECT  
B. Arch., V.C.A., I.I.A.  
CA No. 80/5769

OWNER'S SIGN ARCHITECT'S SIGN

PROJECT:-  
REVISED BUILDING PLAN OF COMMERCIAL COLONY 2.55 ACRES  
( LICENCE NO 44 OF 2019 DATED 05-03-2019) IN SECTOR-84,  
GURUGRAM MENESAR URBAN COMPLEX BEING DEVELOPED BY  
RAMPRASTHA TOWERS PVT. LTD. AND OTHERS IN COLLABORATION  
WITH AMEYA COMMERCIAL PROJECTS PVT. LTD.

TITLE:- 1st. BASEMENT ( BLOCK-B ) DRAWING NO:- SB-B01/08

THIS DRAWING IS THE PROPERTY OF  
GIAN P. MATHUR & ASSOCIATES (P) LTD. AND  
SHALL NOT BE USED COPIED OR  
REPRODUCED WITHOUT THEIR  
WRITTEN PERMISSION

SCALE:- 1:150