



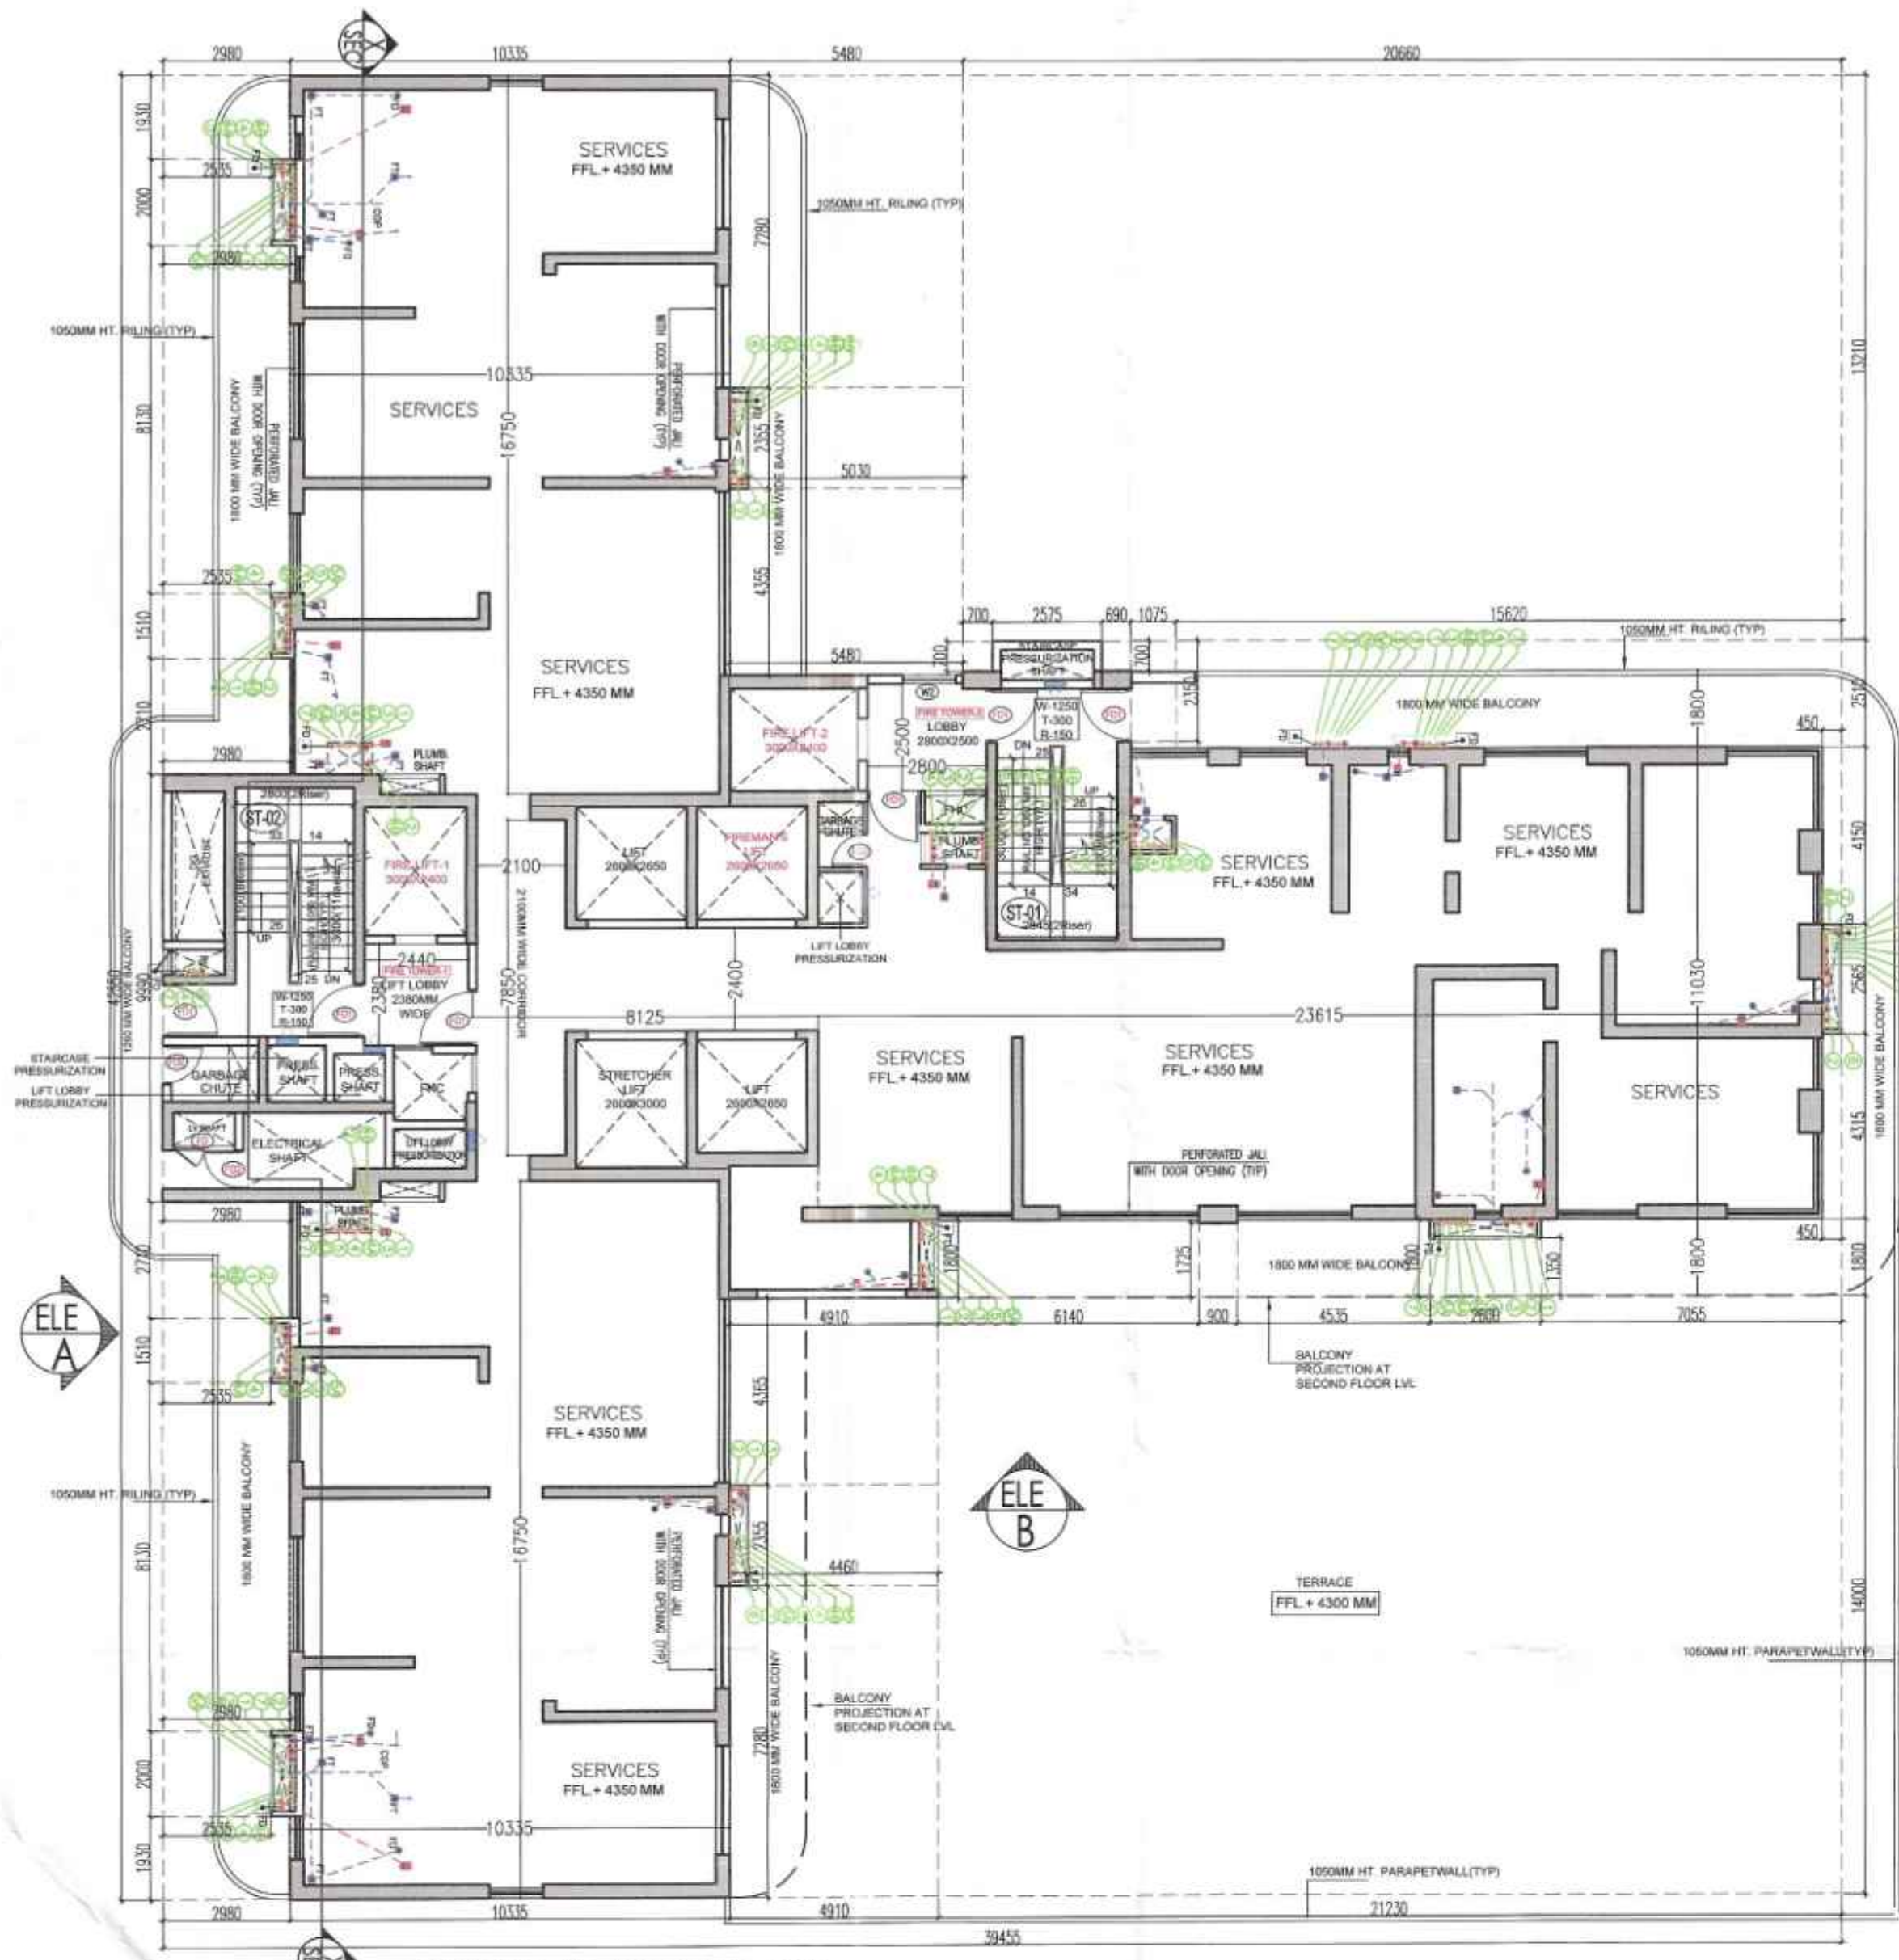

SERVICE FLOOR AT
FIRST FLOOR LVL

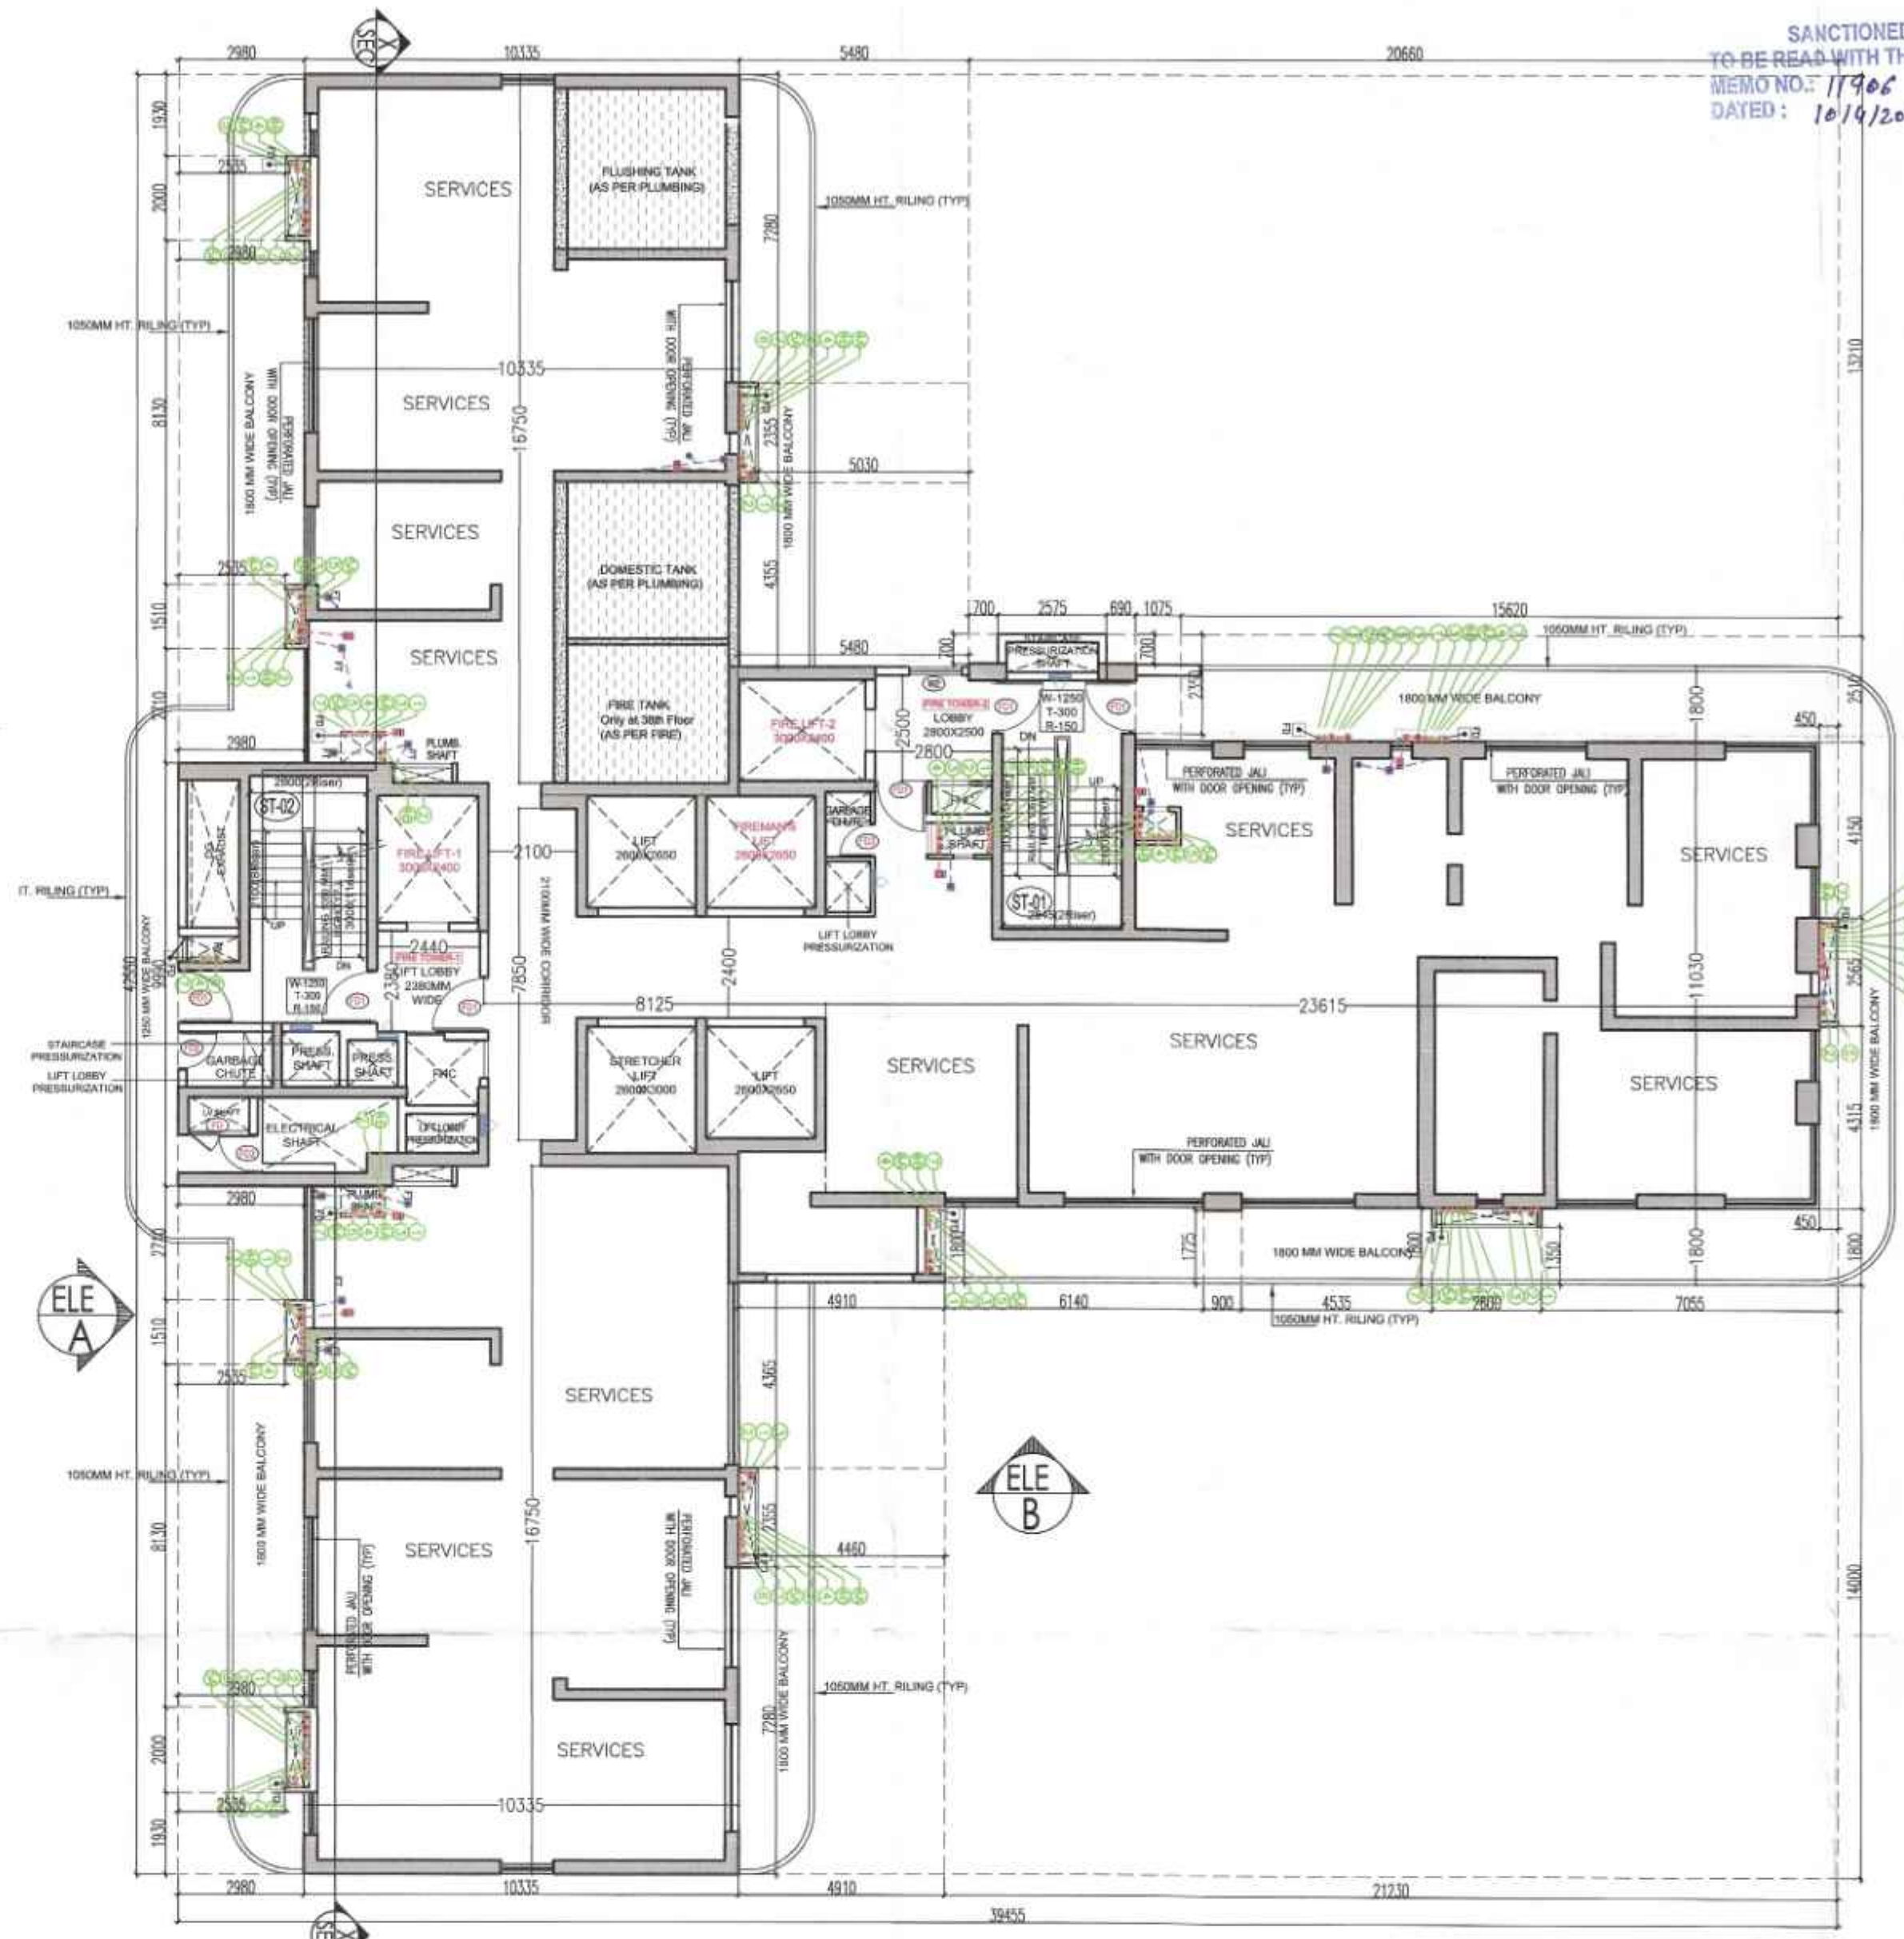


SERVICE FLOOR AT
20TH & 38TH FLOOR

LEGEND

SYMBOL	DESCRIPTION
①	110 OD SOIL AND VENT PIPE
②	110 OD WASTE AND VENT PIPE
③	110 OD KITCHEN WASTE AND VENT PIPE
④	75# ANTISYPHONAGE PIPE
⑤	DOMESTIC WATER SUPPLY DN. TAKE PIPE
⑥	DOMESTIC WATER SUPPLY DN. TAKE PIPE FOR TOP FIVE FLOORS (PRESSURE SUPPLY)
⑦	DOMESTIC WATER SUPPLY DN. TAKE PIPE
⑧	FLUSHING WATER SUPPLY DN. TAKE PIPE
⑨	FLUSHING WATER SUPPLY DN. TAKE PIPE
⑩	160 OD uPVC TERRACE RAIN WATER PIPE
⑪	75# uPVC RAIN WATER PIPE (BALCONY)
⑫	DOMESTIC WATER SUPPLY RISER
⑬	FLUSHING WATER SUPPLY RISER
⑭	FLOOR DRAIN
⑮	FLOOR TRAP
⑯	LEDGE WALL
⑰	CUTOUT IN FLOOR
⑱	MAINTENANCE LOUVER DOOR REQUIRED

TOWER-B
SCHEDULE OF OPENING

Sl. No.	LEGEND	WIDTH (MM)	HEIGHT (MM)	CLL (MM)	BRTE (MM)	HEIGHT (MM)
1	D1	1200	-	0	2000	2100
2	D2	900	-	0	2000	2100
3	D3	750	-	0	2000	2100
4	D4	1200	-	0	2000	2100
5	MD	2000	-	0	2000	2100
6	F101	2000 CLEAR	-	0	2000	2100
7	F102	2000 CLEAR	-	0	2000	2100
8	F103	900	-	0	2000	2100
9	F104	900	-	0	2000	2100
10	FD	AS/SERVICE	-	0	2000	2100
11	S01	4115	-	0	2700	2700
12	S02	3500	-	0	2700	2700
13	S03	2700	-	0	2700	2700
14	S04	2500	-	0	2700	2700
15	S05	2400	-	0	2700	2700
16	S06	1900	-	0	2700	2700
17	S07	1740	-	0	2700	2700
18	S08	2000x2200	-	0	2700	2700
19	S09	1900x2200	-	0	2700	2700
20	DW1	850	1000	2050	2700	2700
21	DW2	850	750	2050	2700	2700
22	W1	1200	600	2050	2700	2700
23	W2	1200	600	2050	2700	2700
24	V	-	630	1300	2700	2700
25	V1	-	600	1300	2700	2700
26	V2	-	1500	1900	2700	2700
27	V3	-	900	1200	2700	2700
28	GL	-	3900	0	2700	2700
29	GL1	-	1250	0	2700	2700
30	GL2	-	2700x1200	0	2700	2700
31	GL3	-	2700	0	2700	2700
32	GL4	-	2000	0	2700	2700
33	GL5	-	2000	0	2700	2700
34	GL6	-	2275	0	2700	2700
35	GL7	-	1400	0	2700	2700
36	GL8	-	3300	0	2700	2700
37	GL9	-	2395	0	2700	2700
38	GL10	-	2000	0	2700	2700

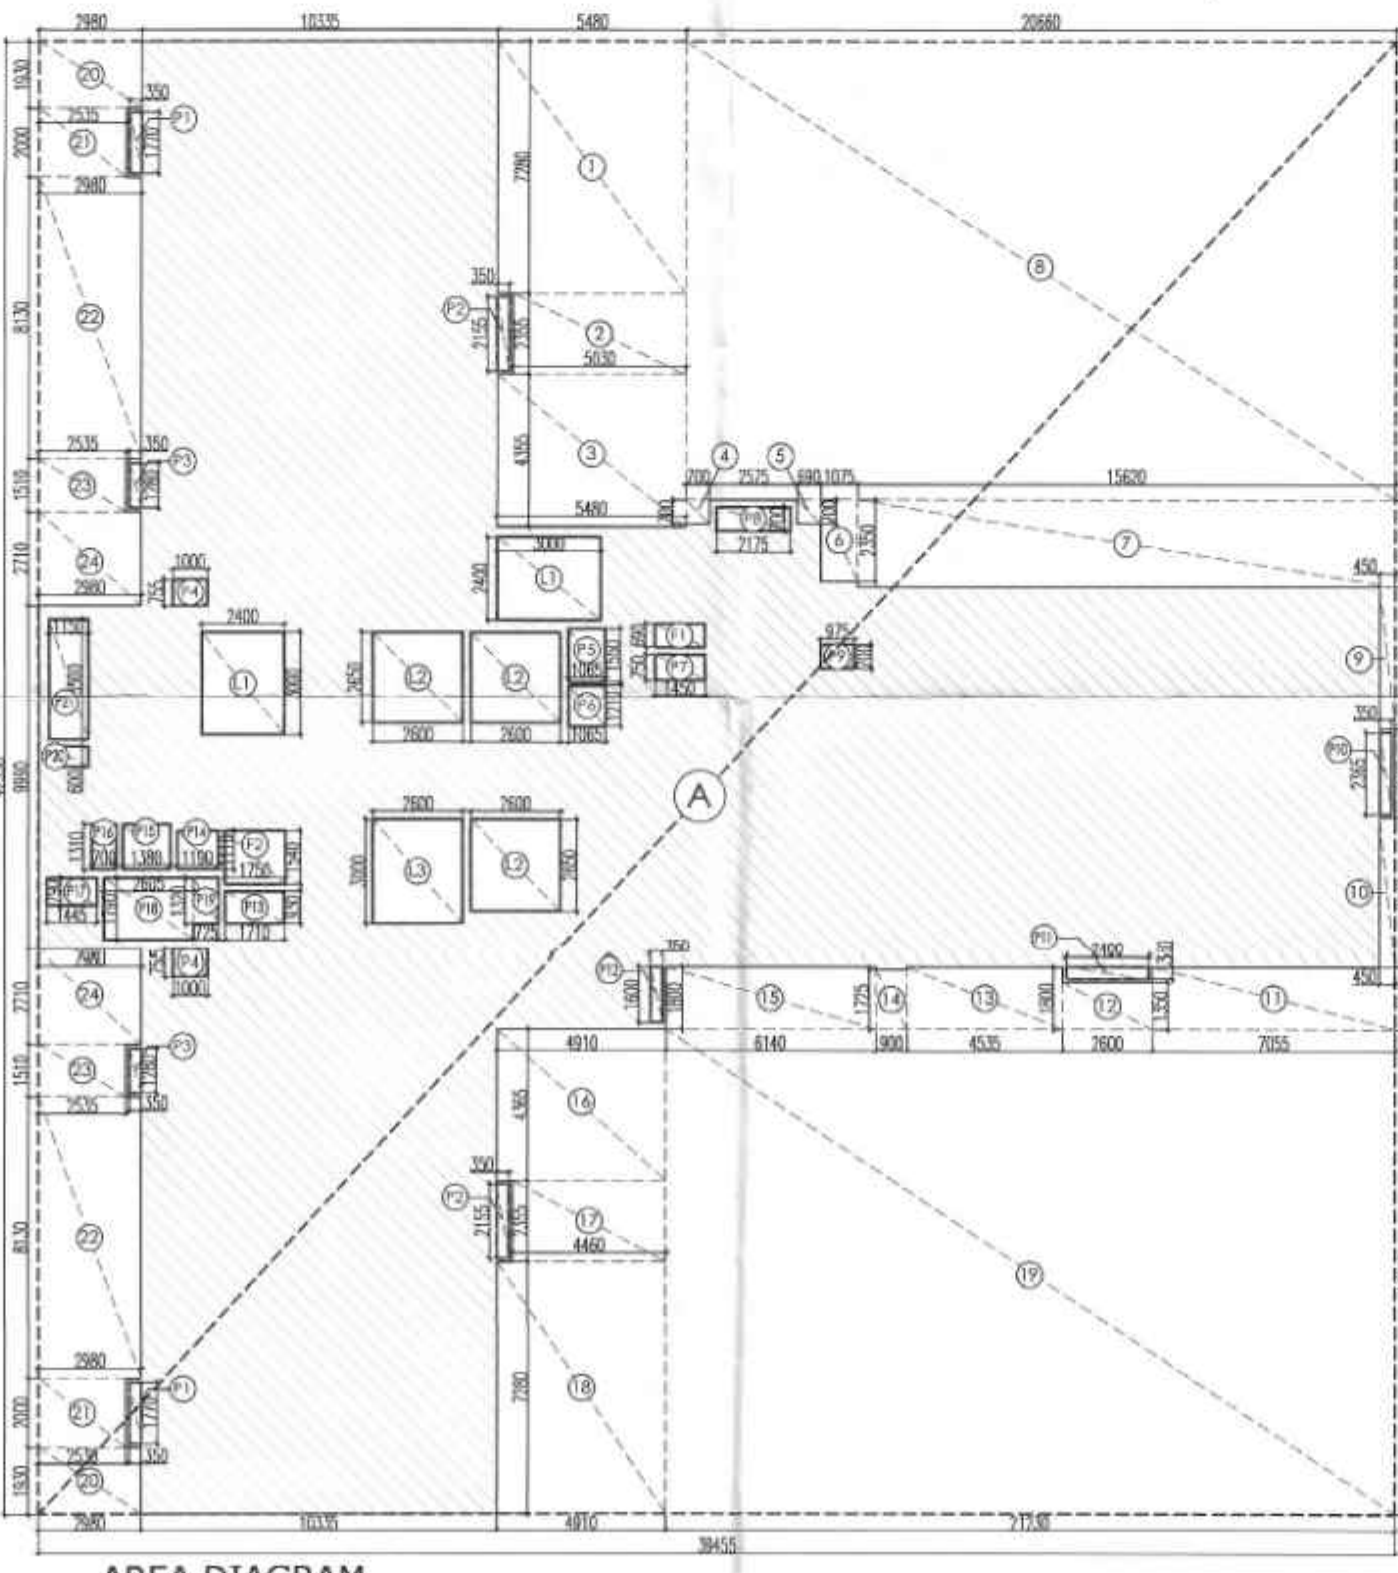

AREA DIAGRAM
SERVICE FLOOR (TYP.)

TOWER - B - SERVICE FLOOR AREA
(1st, 20th & 38th Floor)

Sl. No.	DESCRIPTION	WIDTH (MM)	HEIGHT (MM)	CLL (MM)	BRTE (MM)	HEIGHT (MM)
1	D1	1200	-	0	2000	2100
2	D2	900	-	0	2000	2100
3	D3	750	-	0	2000	2100
4	D4	1200	-	0	2000	2100
5	MD	2000	-	0	2000	2100
6	F101	2000 CLEAR	-	0	2000	2100
7	F102	2000 CLEAR	-	0	2000	2100
8	F103	900	-	0	2000	2100
9	F104	900	-	0	2000	2100
10	FD	AS/SERVICE	-	0	2000	2100
11	S01	4115	-	0	2700	2700
12	S02	3500	-	0	2700	2700
13	S03	2700	-	0	2700	2700
14	S04	2500	-	0	2700	2700
15	S05	2400	-	0	2700	2700
16	S06	1900	-	0	2700	2700
17	S07	1740	-	0	2700	2700
18	S08	2000x2200	-	0	2700	2700
19	S09	1900x2200	-	0	2700	2700
20	DW1	850	1000	2050	2700	2700
21	DW2	850	750	2050	2700	2700
22	W1	1200	600	2050	2700	2700
23	W2	1200	600	2050	2700	2700
24	V	-	630	1300	2700	2700
25	V1	-	600	1300	2700	2700
26	V2	-	1500	1900	2700	2700
27	V3	-	900	1200	2700	2700
28	GL	-	3900	0	2700	2700
29	GL1	-	1250	0	2700	2700
30	GL2	-	2700x1200	0	2700	2700
31	GL3	-	2700	0	2700	2700
32	GL4	-	2000	0	2700	2700
33	GL5	-	2000	0	2700	2700
34	GL6	-	2275	0	2700	2700
35	GL7	-	1400	0	2700	2700
36	GL8	-	3300	0	2700	2700
37	GL9	-	2395	0	2700	2700
38	GL10	-	2000	0	2700	2700

NET AREA

Sl. No.	DESCRIPTION	WIDTH (MM)	HEIGHT (MM)	CLL (MM)	BRTE (MM)	HEIGHT (MM)
1	D1	1200	-	0	2000	2100
2	D2	900	-	0	2000	2100
3	D3	750	-	0	2000	2100
4	D4	1200	-	0	2000	2100
5	MD	2000	-	0	2000	2100
6	F101	2000 CLEAR	-	0	2000	2100
7	F102	2000 CLEAR	-	0	2000	2100
8	F103	900	-	0	2000	2100
9	F104	900	-	0	2000	2100
10	FD	AS/SERVICE	-	0	2000	2100
11	S01	4115	-	0	2700	2700
12	S02	3500	-	0	2700	2700
13	S03	2700	-	0	2700	2700
14	S04	2500	-	0	2700	2700
15	S05	2400	-	0	2700	2700
16	S06	1900	-	0	2700	2700
17	S07	1740	-	0	2700	2700
18	S08	2000x2200	-	0	2700	2700
19	S09	1900x2200	-	0	2700	2700
20	DW1	850	1000	2050	2700	2700
21	DW2	850	750	2050	2700	2700
22	W1	1200	600	2050	2700	2700
23	W2	1200	600	2050	2700	2700
24	V	-	630	1300	2700	2700
25	V1	-	600	1300	2700	2700
26	V2	-	1500	1900	2700	2700
27	V3	-	900	1200	2700	2700
28	GL	-	3900	0	2700	2700
29	GL1	-	1250	0	2700	2700
30	GL2	-	2700x1200	0	2700	2700
31	GL3	-	2700	0	2700	2700
32	GL4	-	2000	0	2700	2700
33	GL5	-	2000	0	2700	2700
34	GL6	-	2275	0	2700	2700
35	GL7	-	1400	0	2700	2700
36	GL8	-	3300	0	2700	2700
37	GL9	-	2395	0	2700	2700
38	GL10	-	2000	0	2700	2700

BUILTUP AREA AT SERVICE FLOOR LVL. = 710.612 sq. mtrs.

Note :-

- BUILDING HAS AUTOMATIC SPRINKLER SYSTEM WHEREVER REQUIRED BY NBC.
- BUILDING WILL BE DESIGNED (STRUCTURES) AS PER RELEVANT IS CODES FOR EARTH QUAKE RESISTANCE.
- FOR SOIL WASTE SINGLE STACK SYSTEM WILL BE ADOPTED AS PER APPROVED IN NBC 2019 FOR BUILDING OR FOR PUBLIC HEALTH (Internal) Service only subject to comments in.
- ALL LIFTS & COMMON AREA WITH EMERGENCY LIGHTING TO HAVE 100% POWER BACKUP AS PER NBC REQUIREMENTS.
- ALL DIMENSIONS ARE IN MM.


Superintending Engineer (HQ)
for Chief Engineer-I
MSVP, Panchkula

NOTE :- ALL LIFT WELLS & BASEMENTS SHALL BE MECHANICALLY VENTILATED.

DDA (T) MEMBER BPAC
S.T.P. (HQ)
Member Secretary B.P.A.C.
DTP (HQ)

Consultant Architect
S.T.P. (HQ)
Member Secretary B.P.A.C.
ATP (HQ)

Ram Akar Bassi
JD (HQ)

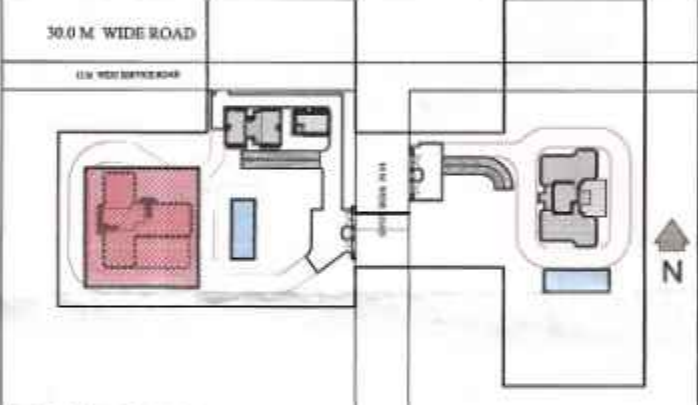

KEY PLAN
Project:

PROPOSED GROUP HOUSING
COLONY FOR AN AREA
MEASURING 7.35625 ACRES
(LICENCE NO. 136 OF 2023
DATED 30/06/2023) IN SECTOR -
32, SOHNA, BEING DEVELOPED
BY ST. PATRICKS REALTY PVT.
LTD. AND OTHERS.

Client:-
ST. PATRICKS REALTY PVT. LTD.

ARCHITECT'S SEAL & SIGNATURE
OWNER'S SEAL & SIGNATURE

GIAN P. MATHUR
B. Arch., M.C.A. I.I.A.
CA No. 00/5769

FEB. 2024 SCALE : 1:125
DRAWING TITLE:-
(TOWER -B)
FIRST FLOOR PLAN (1ST
SERVICE FLOOR) & 20TH &
38TH FLOOR PLAN
(2ND & 3RD SERVICE FLOOR)

DRAWING NO.-
SB/AR/TB/02
CENTRAL PARK-III