


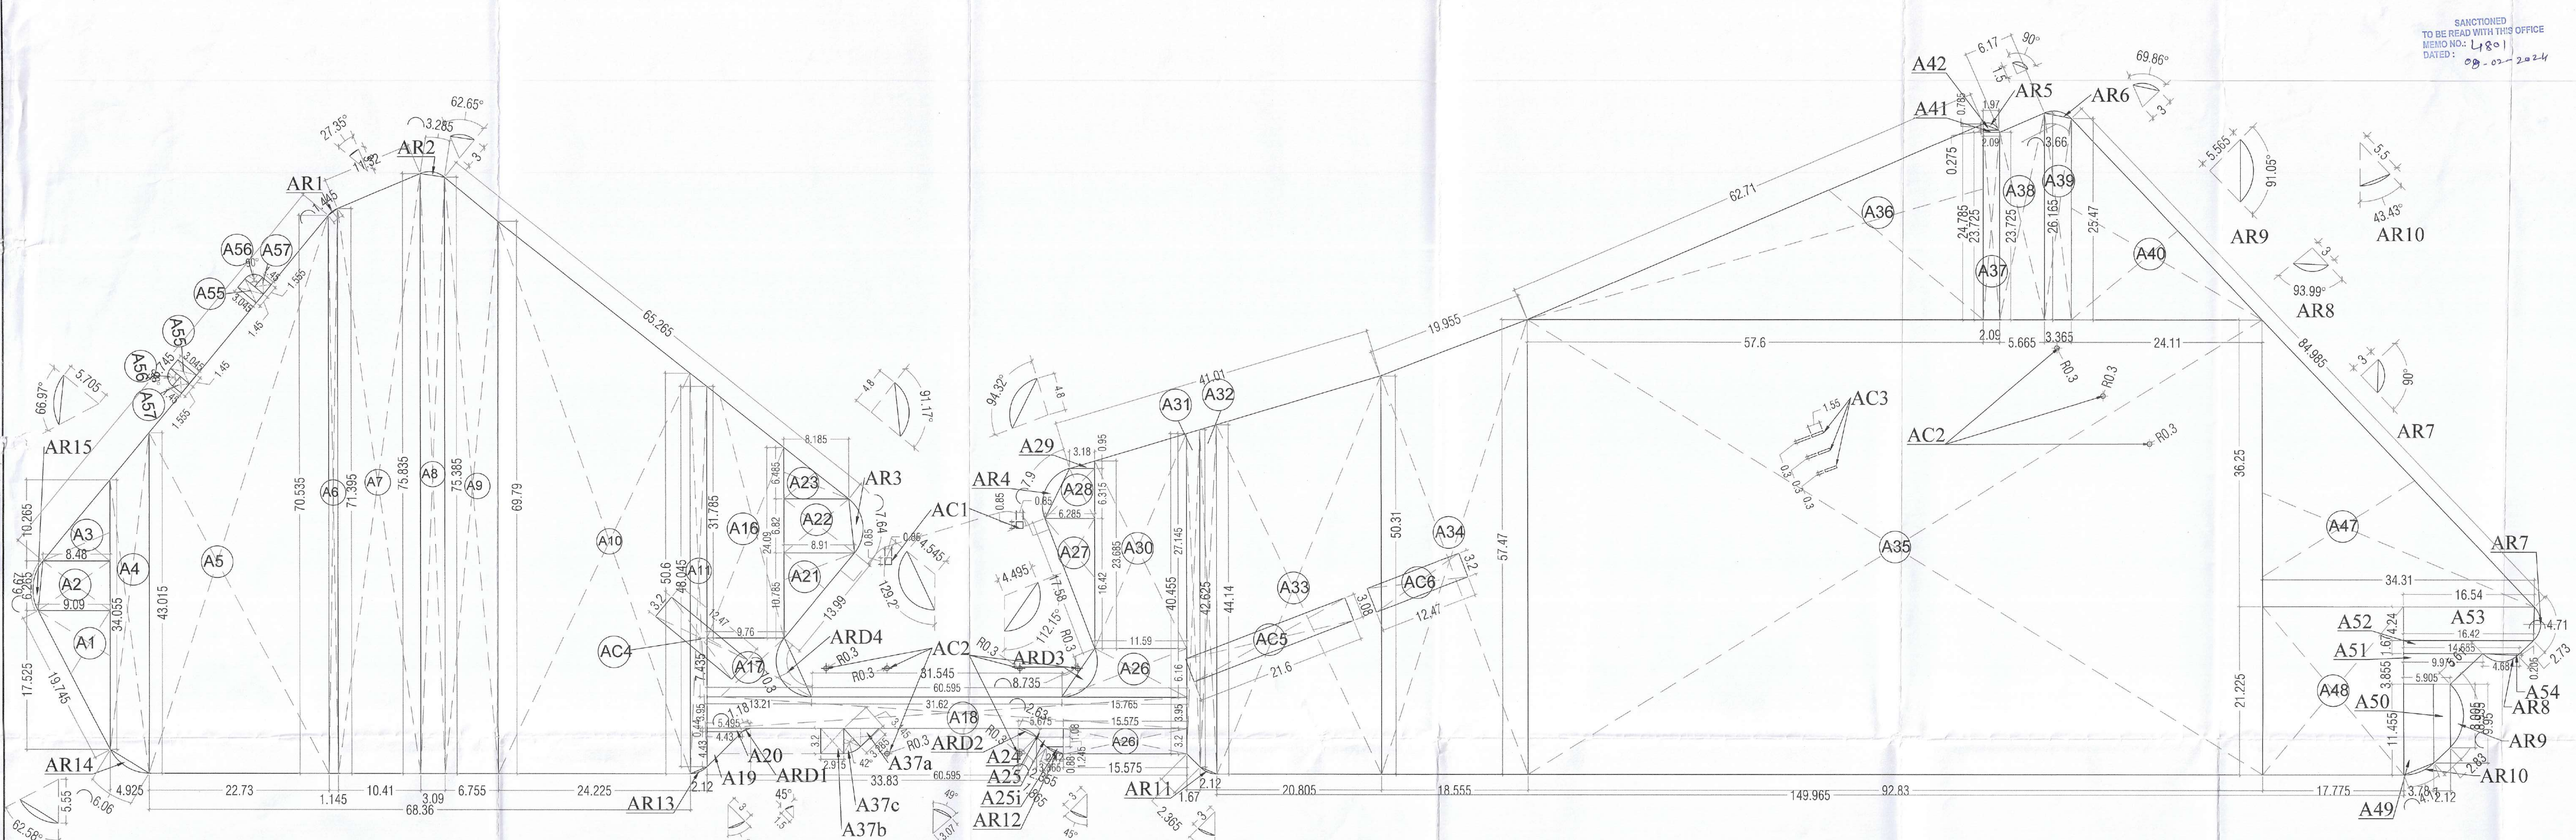


FIRST FLOOR- AREA DIAGRAM


Population Calculation 1ST FLOOR	AREA	POPULATION
TOTAL POPULATION RETAIL (66 SQ. M. P.P)	13061.902	2180

Floor	Population	Per unit width (mm)	Total width required (mm)	Total width provided (mm)
First Floor	2180	10	21800	21800


1ST FLOOR (RETAIL)	PERMANENT POPULATION (10%)	FLOATING POPULATION (90%)	TOTAL REQUIRED	TOTAL PROVIDED
POPULATION	218	1962		
	MALE(203)	FEMALE (115)	MALE	FEMALE
	145	73	1308	654
W.C	6	8	27	33
URINAL	6	0	27	0
W.B	6	5	27	14

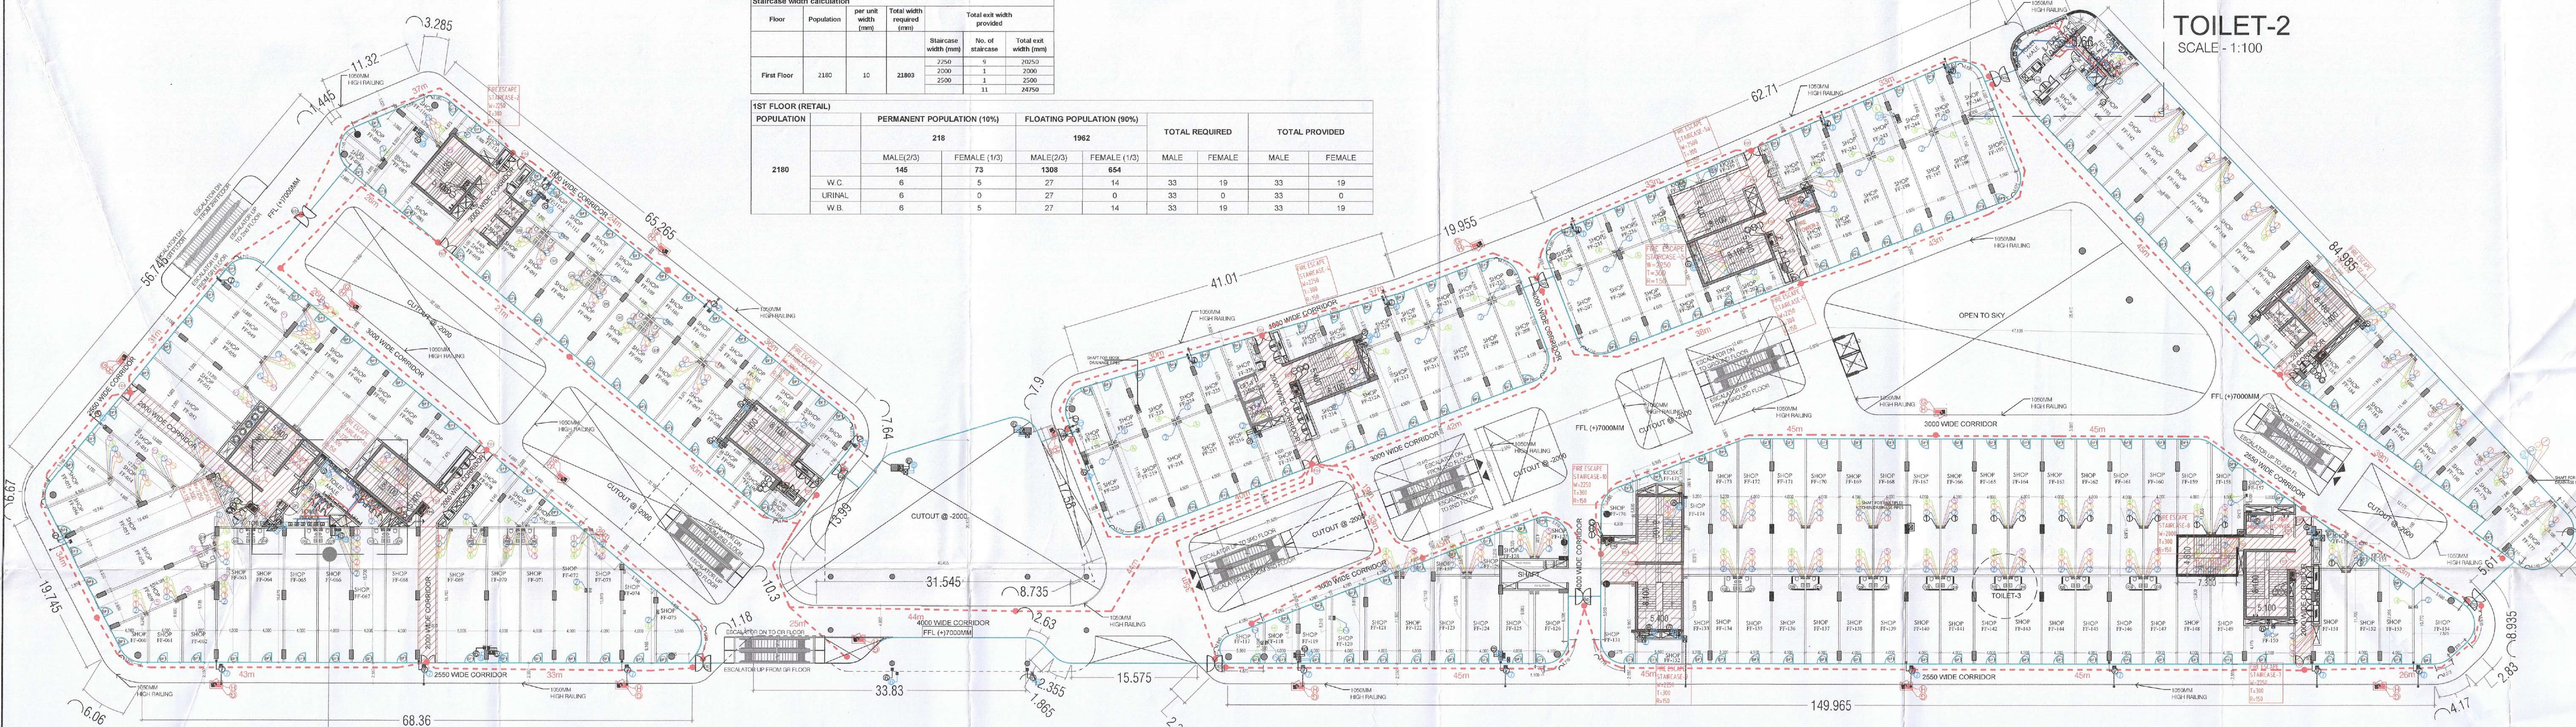


FIRST FLOOR

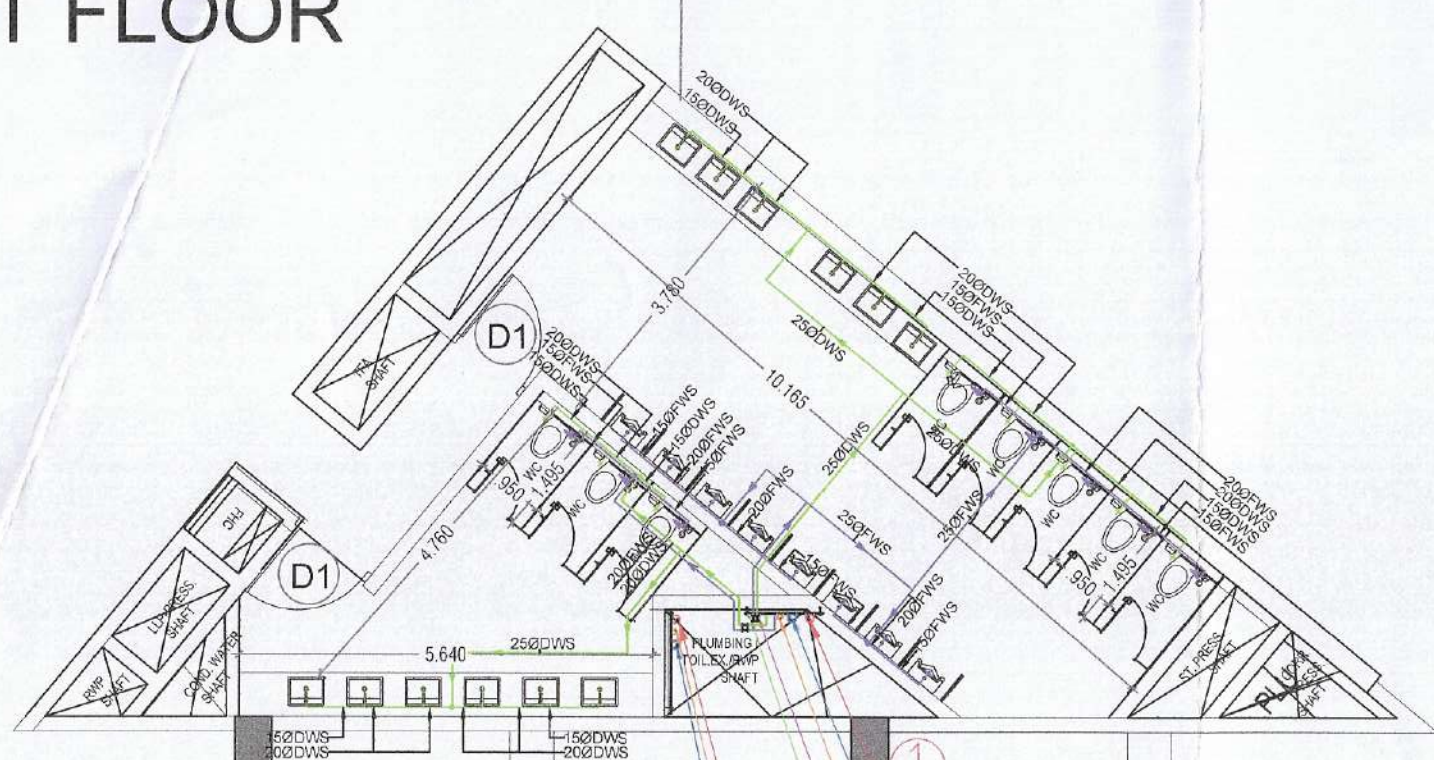

TOILET-1
SCALE - 1:100

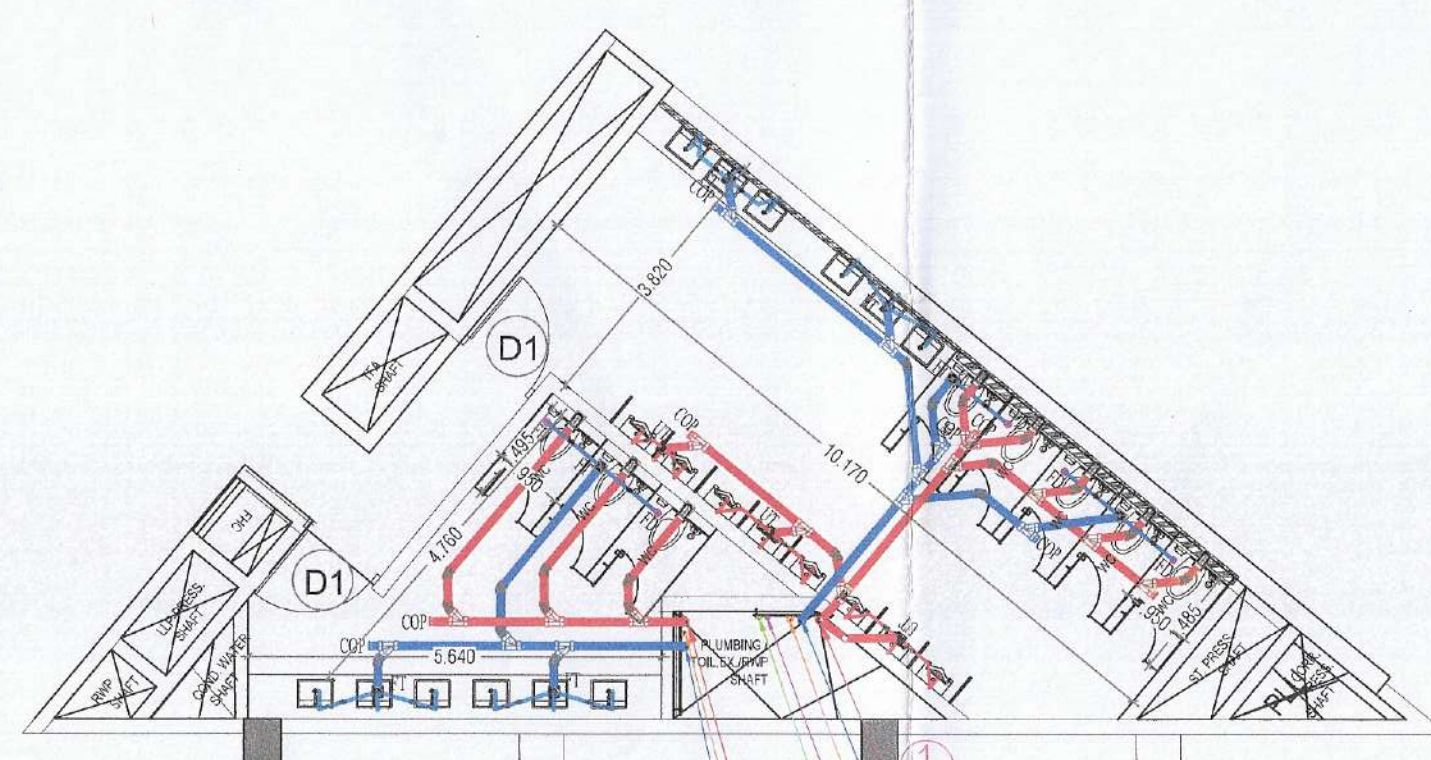

TOILET-2
SCALE - 1:100

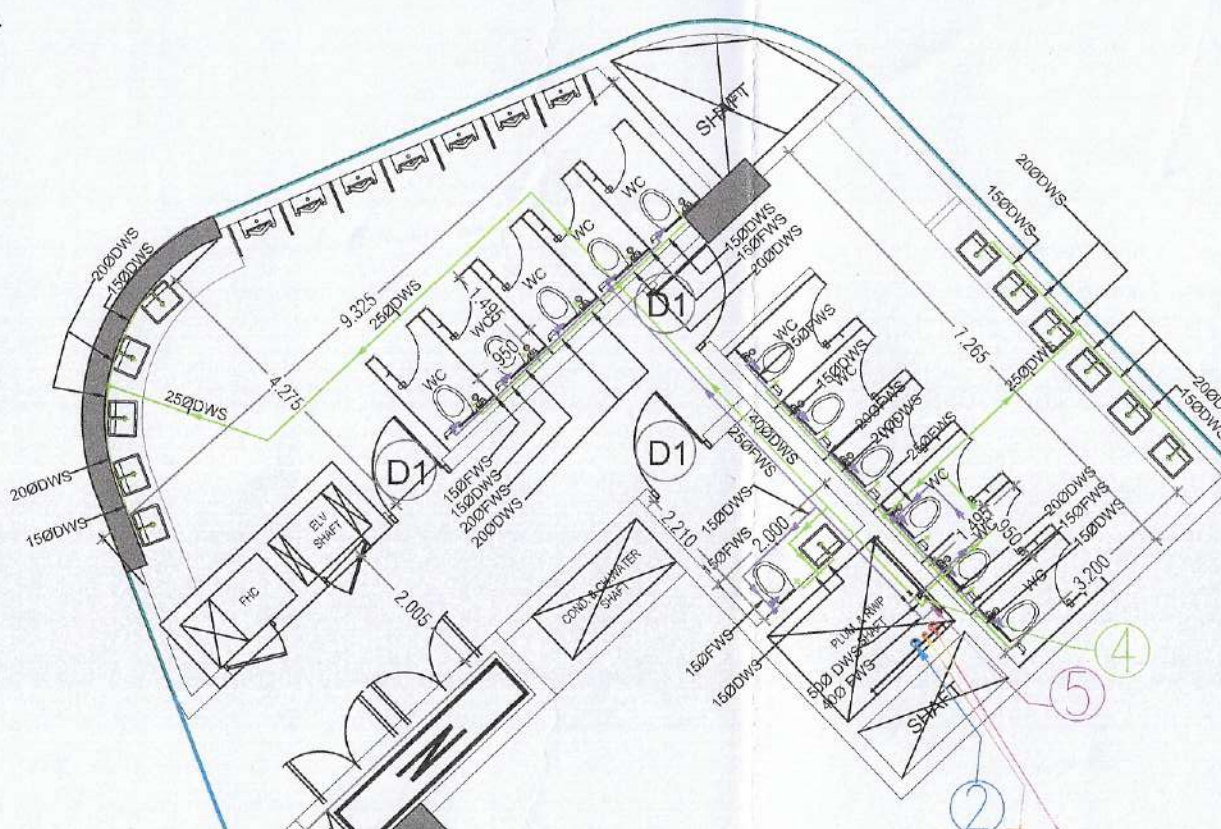

TOILET-3
SCALE - 1:100

Sanctioned TO BE READ WITH THIS OFFICE MEMO NO. L/1801 DATED: 09-05-2024

Consultant Architect: DTP (HQ) STP (HQ) CTP (HQ) STP (HQ) CTP (HQ) STP (HQ) CTP (HQ)

Note:-

- BUILDING HAS AUTOMATIC SPRINKLER SYSTEM WHEREVER REQUIRED BY NBC.
- BUILDING WILL BE DESIGNED (STRUCTURES) AS PER RELEVANT IS CODES FOR EARTH QUAKE RESISTANCE.
- ALL DIMENSIONS ARE IN METERS.

LEGEND/ABBREVIATIONS:

S.No.	SYMBOL	TAG	DESCRIPTION
(1)		110 OD SOIL PIPE	
(2)		110 OD WASTE PIPE	
(3)		150 OD WASTE PIPE FOR KITCHEN	
(4)		75 OD ANTIPHONAGE PIPE	
(5)		DOMESTIC WATER SUPPLY PIPE	
(6)		FLUSHING WATER SUPPLY PIPE	
(7)		160 OD RAIN WATER PIPE FOR TERRACE	
(8)		110 OD RAIN WATER PIPE FOR BALCONY	
(9)		DOMESTIC WATER RISER PIPE	
(10)		SOFT WATER RISER PIPE	
(11)		FIRE HYDRANT PIPE	
(12)		FIRE DRAIN PIPE	
(13)		FIRE SPRINKLER PIPE	
(14)		FD FLOOR DRAIN	
(15)		FT FLOOR TRAP	
(16)		UT URINAL TRAP	
(17)		COP CLEAN OUT PLUG	

DOOR/WINDOW (GLAZING) SCHEDULE

TYPE	WIDTH (FINISHED)	GLAZING (FROM FFL IN MM)	LINTEL (FROM FFL IN MM)
FD1	2250	0	2450
FD2	1500	0	2450
FD3	900	150	2450
D1	1000	0	2450
D2	1050	0	2450
D3	700	0	2150
GD1	2000	0	3200
SF1	1200	0	2450

PROJECT:

"PROPOSED BUILDING PLANS OF COMMERCIAL COLONY MEASURING 3.652 ACRES (LICENSE NO. 60 OF 2013 DATED 16.07.2013) AND 3.9937 ACRES (LICENSE NO. 61 OF 2013 DATED 16.07.2013) TOTAL AREA MEASURING 7.649 ACRES IN SECTOR - 82, GURUGRAM MANESAR URBAN COMPLEX BEING DEVELOPED BY ELAN IMPERIAL PRIVATE LIMITED (FORMERLY KNOWN AS AMBIENCE INFRASTRUCTURE DEVELOPERS PVT. LTD.)"

OWNERS SEAL & SIGNATURE:

For Elan Imperial Private Limited
Authorised Signatory

ARCHITECT'S SEAL & SIGNATURE:

RAJINDER KUMAR
CA/2490775

NOV.-2023. Scale: 1:300

Drawing Title:- FIRST FLOOR PLAN & AREA DIAGRAM

Drawing No:- A-06