



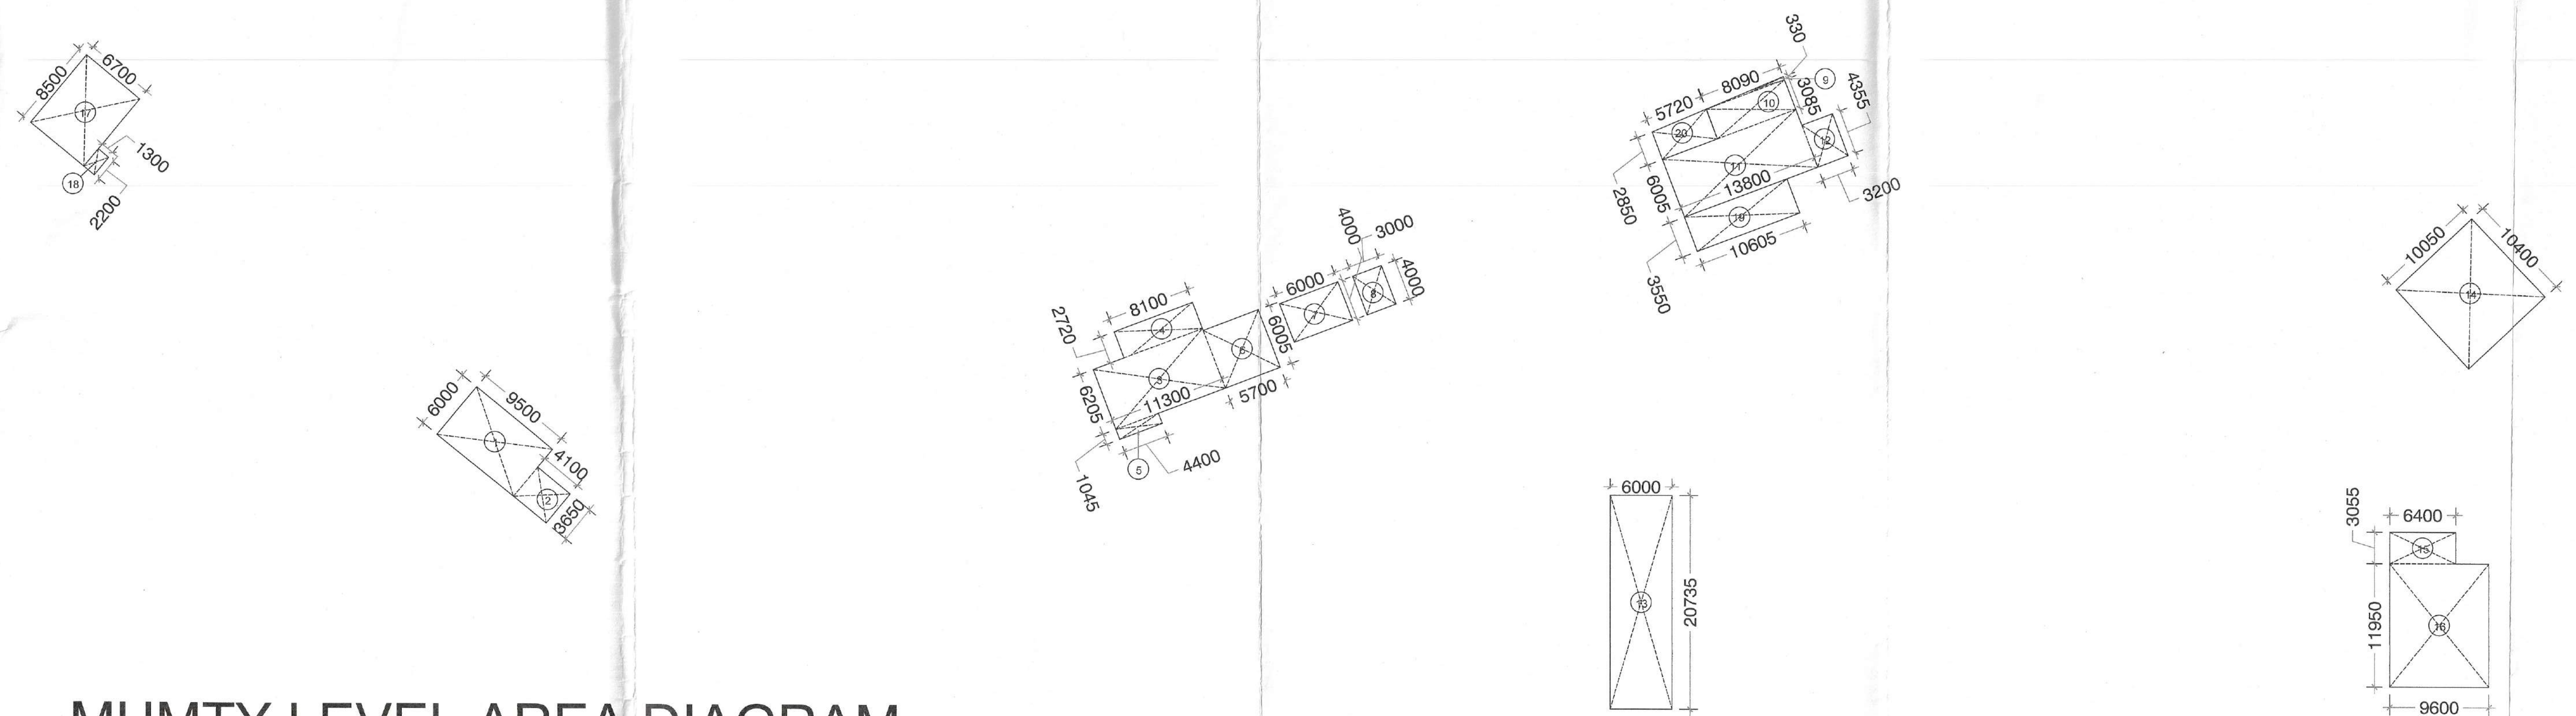

MUMTY LEVEL AREA DIAGRAM

MUMTY AREA CALCULATIONS DETAIL							
AREA CALCULATION							
S. NO.	SHAPE	LENGTH (L)	WIDTH (B)	HEIGHT (H)	FACTOR	AREA	FORMULA
		(HOR.) / mts.	(HOR.) / mts.	(VERT.) / mts.		(SQ.MTS.)	
ADDITIONS							
1	RECTANGLE	9.500	6.000		1	57.000	LXB
2	RECTANGLE	4.100	3.650		1	14.965	LXB
3	RECTANGLE	11.300	6.705		1	76.117	LXB
4	RECTANGLE	8.100	1.215		1	9.830	LXB
5	RECTANGLE	4.400	1.045		1	4.598	LXB
6	RECTANGLE	5.700	6.005		1	34.229	LXB
7	RECTANGLE	6.000	4.000		1	24.000	LXB
8	RECTANGLE	3.000	4.000		1	12.000	LXB
9	TRIANGLE	8.090		0.330	0.5	1.335	0.5XHXH
10	RECTANGLE	8.090	3.085		1	24.958	LXB
11	RECTANGLE	13.800	6.005		1	82.689	LXB
12	RECTANGLE	3.200	4.355		1	13.936	LXB
13	RECTANGLE	6.000	20.735		1	124.410	LXB
14	RECTANGLE	10.050	10.400		1	104.520	LXB
15	RECTANGLE	6.400	13.955		1	89.552	LXB
16	RECTANGLE	9.600	11.000		1	114.720	LXB
17	RECTANGLE	8.500	6.720		1	56.950	LXB
18	RECTANGLE	1.300	2.200		1	2.860	LXB
19	RECTANGLE	10.600	3.550		1	37.630	LXB
20	RECTANGLE	5.270	2.850		1	15.020	LXB
TOTAL AREA (X)						837.699	SQ.M.
NON FAR AREA FOR MUMTY LEVEL						837.699	SQ.M.

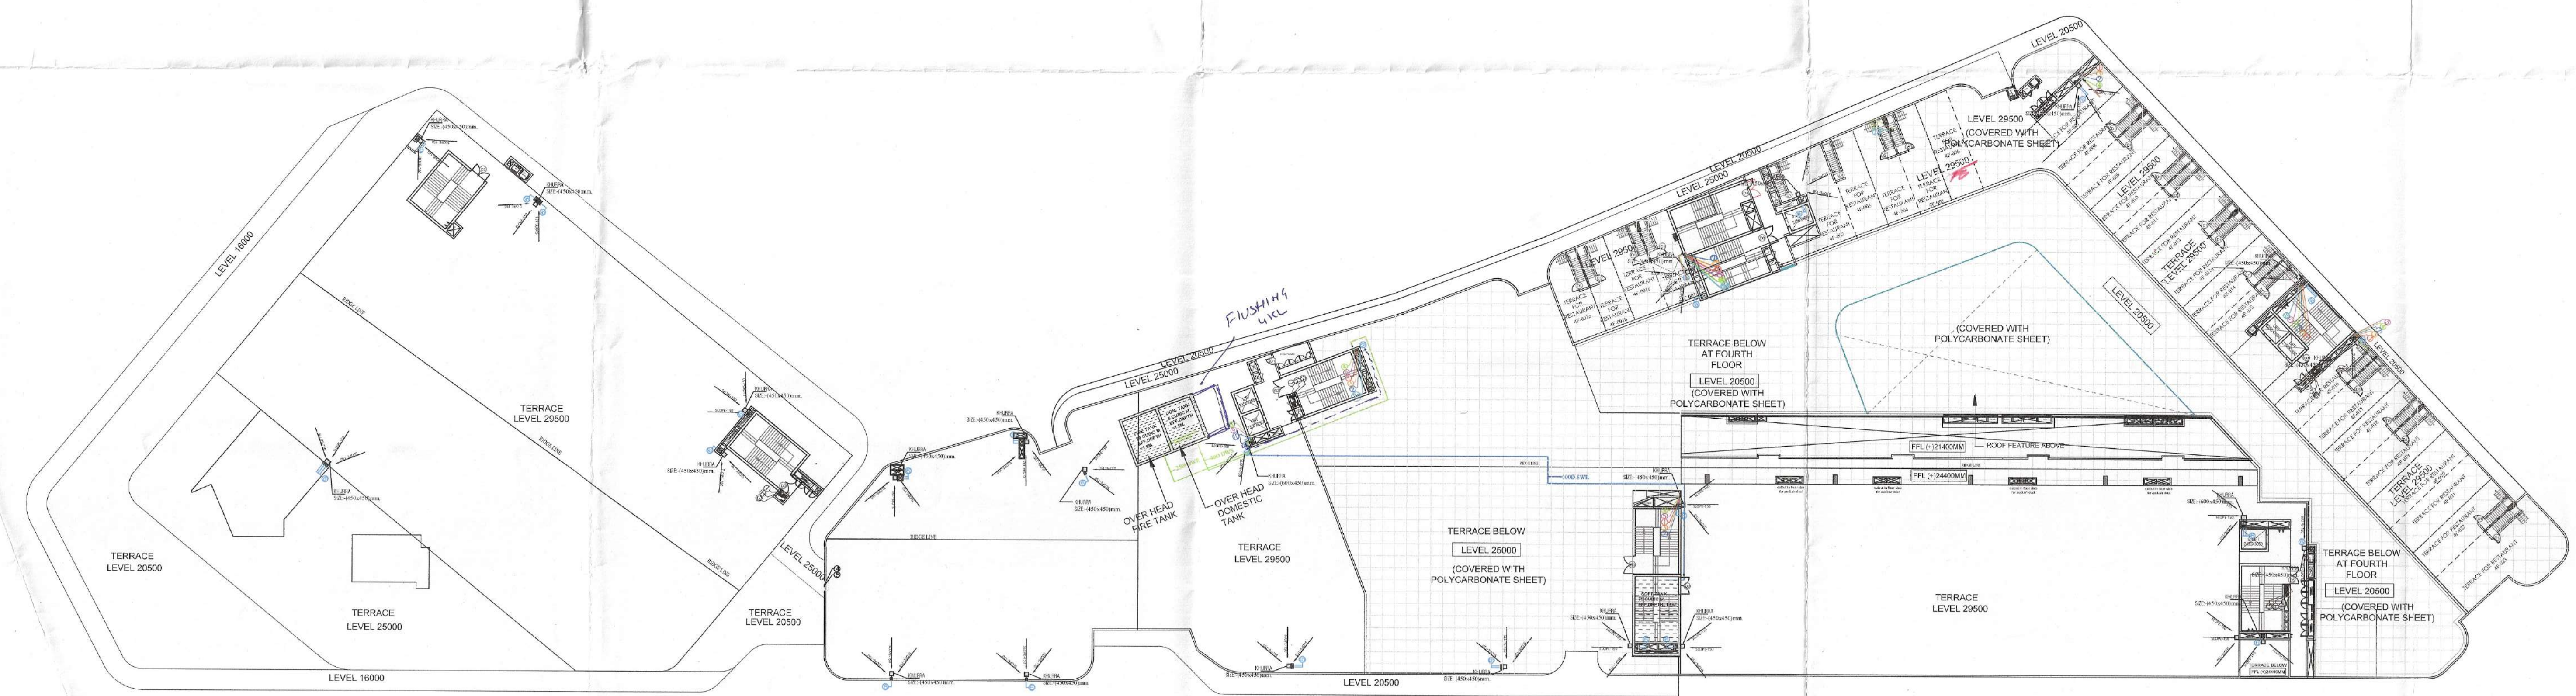

TERRACE FLOOR PLAN

All levels are in mm

LEGEND/ABBREVIATIONS:		
S.No.	SYMBOL	DESCRIPTION:
(1)		110 OD SOIL PIPE
(2)		110 OD WASTE PIPE
(3)		150 OD WASTE PIPE FOR KITCHEN
(4)		75 OD ANTIPHONAGE PIPE
(5)		DOMESTIC WATER SUPPLY PIPE
(6)		FUSHING WATER SUPPLY PIPE
(7)		160 OD RAIN WATER PIPE FOR TERRACE
(8)		110 OD RAIN WATER PIPE FOR BALCONY
(9)		DOMESTIC WATER RISER PIPE
(10)		FUSHING WATER RISER PIPE
(11)		PIPE HYDRANT TAP
(12)		FIRE DRAIN PIPE
(13)		FIRE SPRINKLER PIPE
(14)		FD FLOOR DRAIN
(15)		FT FLOOR TRAP
(16)		UTRINAL TRAP
(17)		COP CLEAN OUT PLUG

PROJECT:

"PROPOSED BUILDING PLANS OF COMMERCIAL COLONY MEASURING 3.6562 ACRES (LICENSE NO. 60 OF 2013 DATED 16.07.2013) AND 3.9937 ACRES (LICENSE NO. 61 OF 2013 DATED 16.07.2013) TOTAL AREA MEASURING 7.6499 ACRES IN SECTOR - 82, GURUGRAM MANESAR URBAN COMPLEX BEING DEVELOPED BY ELAN IMPERIAL PRIVATE LIMITED (FORMERLY KNOWN AS AMBIENCE INFRASTRUCTURE DEVELOPERS PVT. LTD.),"

ARCHITECTS



MUMTY ROOM LEVEL PLAN

All levels are in mm

Checked and found ok for Public Health
(Internal) Service only subject to comments in
in forwarding letter No. 271537 DU 20/1/2023

Superintendent Engineer (HQ)
for Chief Engineer-I
HSVP, Panchkula

OWNER'S SEAL & SIGNATURE			
For Elan Imperial Private Limited  Authorized Signatory			
ARCHITECT'S SEAL & SIGNATURE			
RAJINDER KUMAR CA/2490/75 			
NOV.-2023	Scale : 1:350		
Drawing Title:-		Drawing No	
TERRACE FLOOR PLAN, MUMTY LEVEL PLAN, MUMTY LEVEL AREA PLAN		A-11	

Threes