

TO BE READ WITH THIS OFFICE
MEMO NO.: 6681
DATED: 22.02.2024

LEGEND:-

1	1000 SOIL & VENT PIPE
2	1000 WASTE & VENT PIPE
3	1500 RAIN WATER PIPE
4	DOMESTIC WATER SUPPLY ON TAKE PIPE
5	FLUSHING WATER SUPPLY ON TAKE PIPE
6	750 BALCONY DRAIN PIPE
7	DOMESTIC WATER RISER TO O.H. TANK
8	FLUSHING WATER RISER TO O.H. TANK
9	750 ANTISIPHONAGE PIPE
10	DOMESTIC WATER SUPPLY BY BOOSTER PUMP
WB TO FT	320 WASTE PIPE
FD TO FT	500 WASTE PIPE
FT TO VERTICAL STACK	1000 WASTE PIPE
W.C. TO VERTICAL STACK	1000 SOIL PIPE
FD	FLOOR DRAIN (80x50mm)
FT	FLOOR TRAP (120x75mm)
FCO	FLOOR CLEAN OUT
WV	WALL VALVE
DWS	DOMESTIC WATER SUPPLY
FWS	FLUSHING WATER SUPPLY


CS CATCH BASIN (450x450mm)
DRAINAGE SUMP (SIZE=1.2x1.2x1.5m)

This is a "PROVISIONAL BUILDING PLAN" approved only for the purpose of inviting Objections from the general public.

DTP (HQ) S.T.P. (HQ) Member Secretary B.P.A.C.
S.T.P. (D) Member B.P.A.C.
S.T.P. (H) Chairman B.P.A.C.

Constant Architect
DTP (HQ)
Ram Avatar Bassi JD (HQ)

S.NO.	TYPE	WIDTH	HEIGHT	CILL LEVEL	LINTEL LEVEL	TYP
DOOR						
1	D	2000	2400	±00	2400	
2	D1	1000	2400	±00	2400	
3	D2	800	2400	±00	2400	
4	D3	1200	2400	±00	2400	
5	D4	1500	2400	±00	2400	
6	D5	2400	2400	±00	2400	
GLAZING/ WINDOW						
1	GL1	11585	6100	±00	6100	
2	GL2	6650	6100	±00	6100	
3	GL3	7800	5300	±00	5300	
4	GL4	14600	5300	±00	5300	
5	GL5	2400	5300	±00	5300	
6	W1	2100	2400	600	2400	
FIRE DOOR						
1	FD1	2000	2400	±00	2400	FIRE C
2	FD2	1200	2400	±00	2400	FIRE C
3	FD3	1200	2400	±00	2400	FIRE C
4	FD4	900	2400	±00	2400	FIRE C

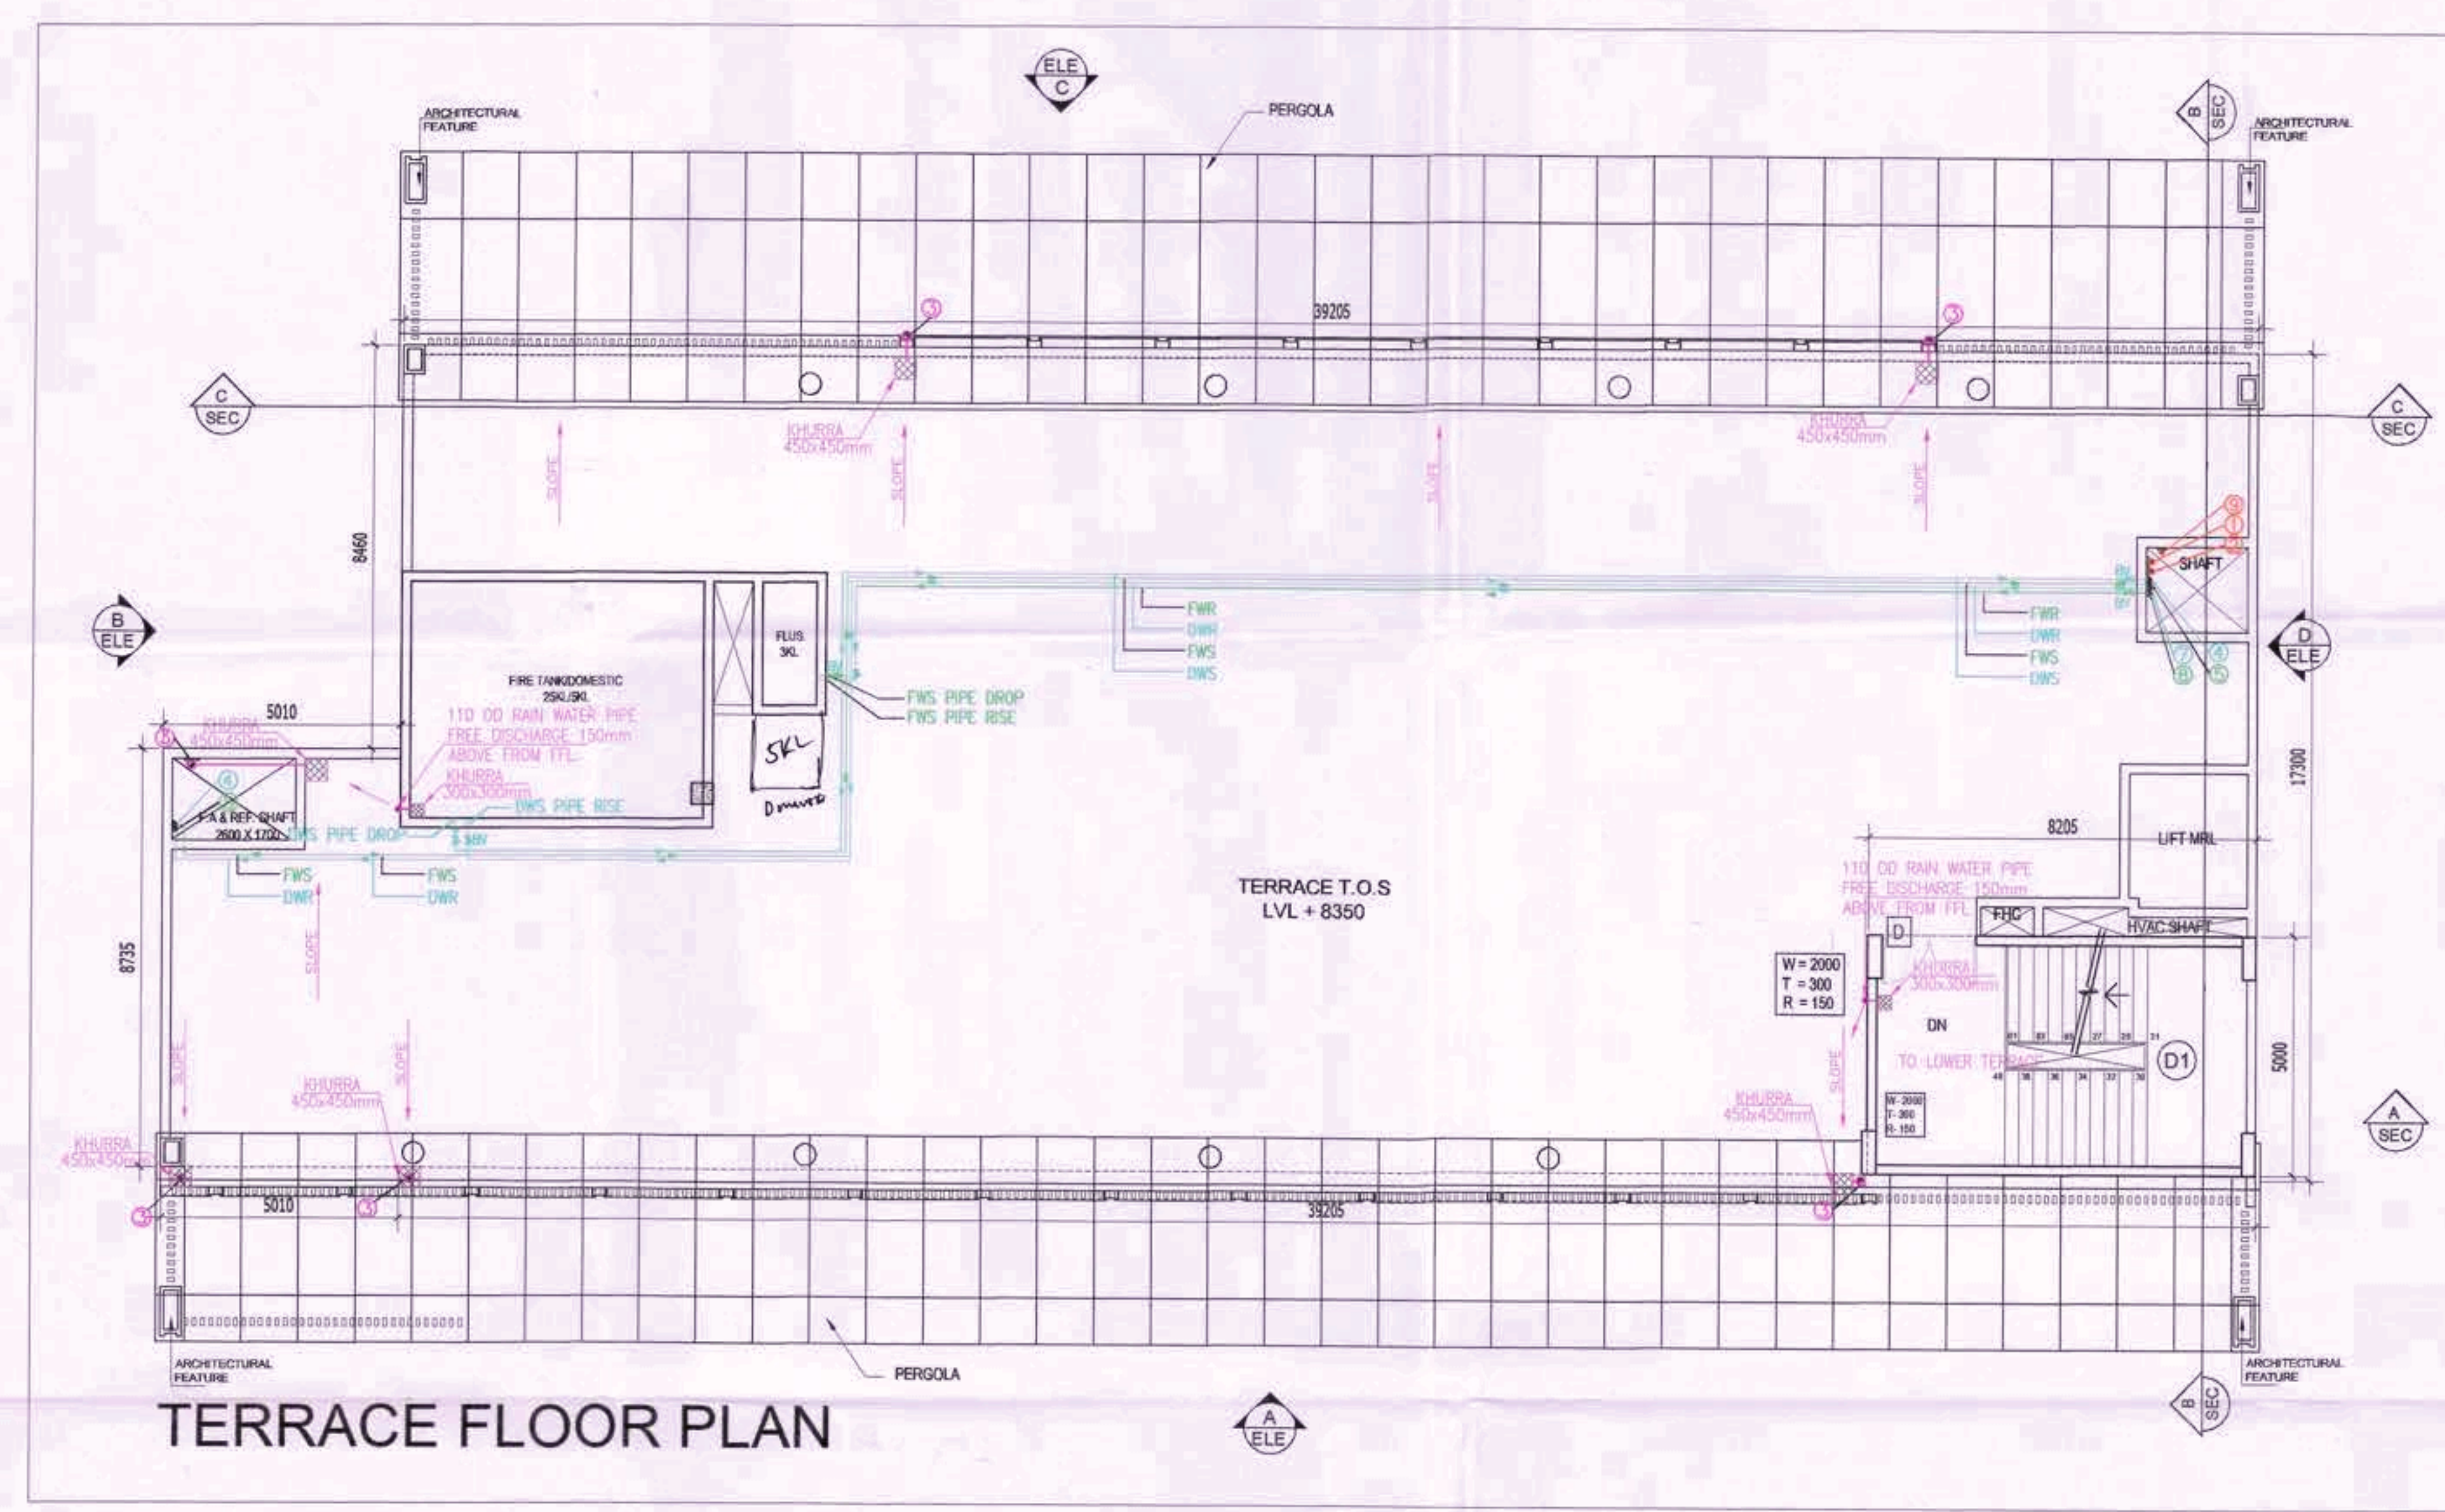

TERRACE FLOOR PLAN

ARCHITECTS:-
C. P. KUKREJA ARCHITECTS
ASHIRWAD BUILDING
D-1, GREEN PARK
NEW DELHI - 110016
PHONE:- 26863953 FAX:- 26865770,
EMAIL:- cpk@cpkukreja.com



KEY PLAN

SUBMISSION DRAWINGS

REVISED BUILDING PLAN FOR GROUP HOUSING COLONY BEING DEVELOPED, OVER LAND ADMEASURING 12.356 ACRES SITUATED IN SECTOR-2, GWAL PAHARI, HARYANA, UNDER LICENSE NO. 98 of 2011 DATED 11.11.2011, BY ADANI INFRASTRUCTURE AND DEVELOPERS PRIVATE LIMITED.

Checked and found ok for Public Health (Internal) Service only subject to comments in forwarding letter No. 27/12/2024

Superintending Engineer (HQ) for Chief Engineer-I HSVP, Panchkula

OWNER'S SIGN.	ARCHITECT'S SIGN.
SCALE 1:100	DATE DECEMBER 2023
DRAWING TITLE COMMUNITY CENTER TERRACE FLOOR PLAN,	
DWG. NO. 45/54	