



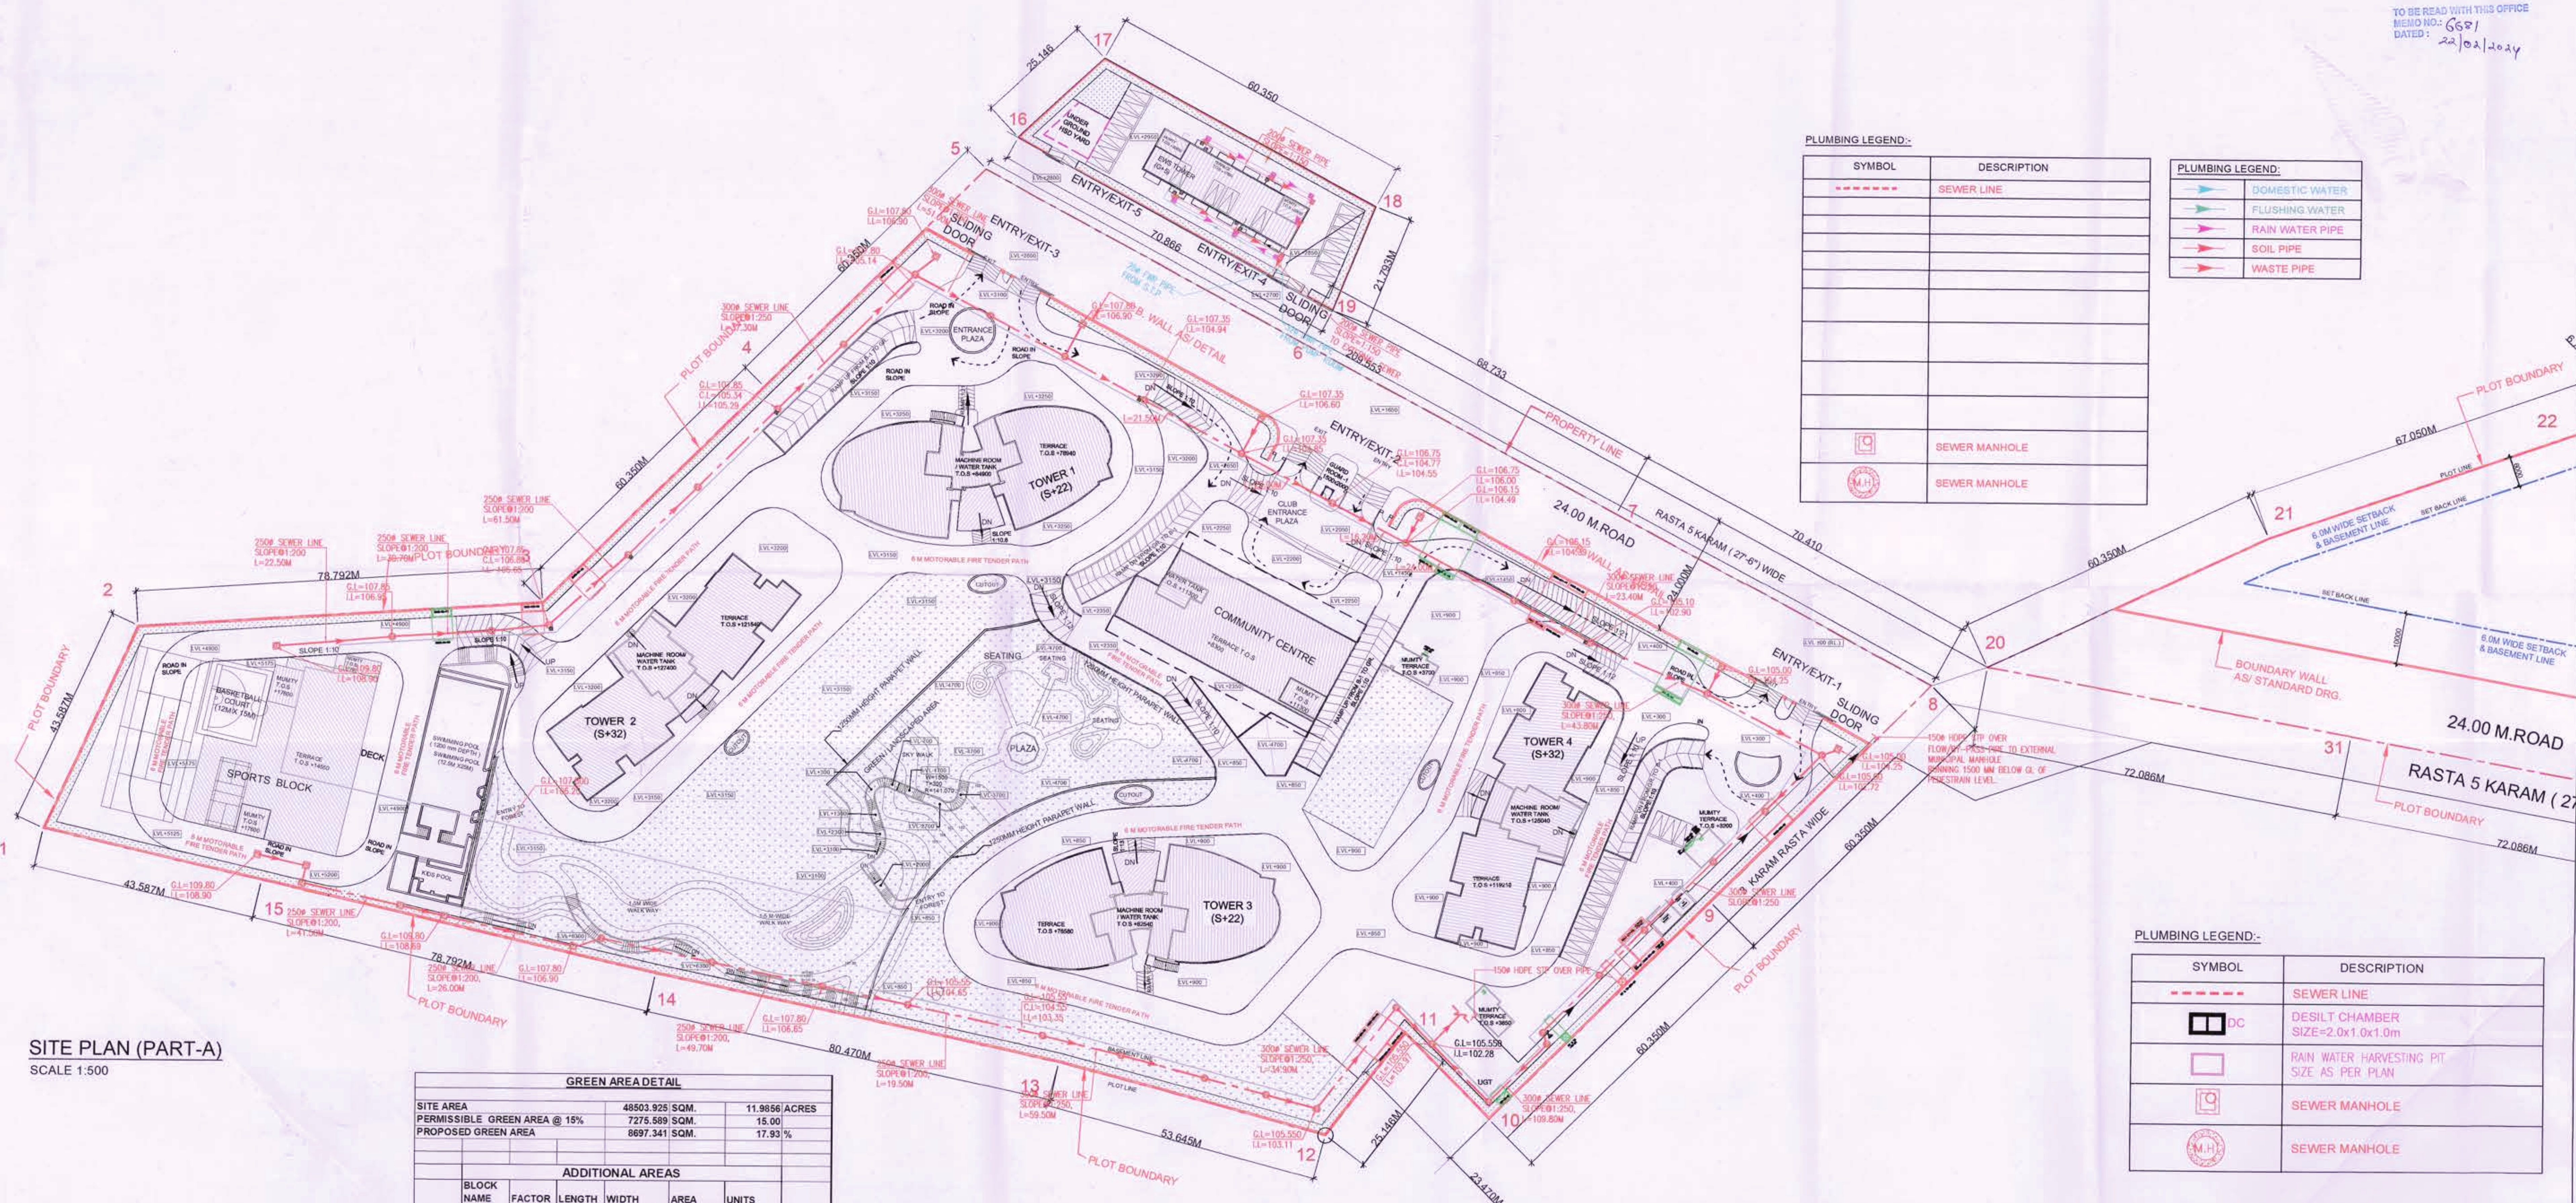

SITE PLAN (PART-A)
SCALE 1:500

GREEN AREA DETAIL					
SITE AREA		48503.925 SQM.	11.9856 ACRES		
PERMISSIBLE GREEN AREA @ 15%		7275.589 SQM.	15.00		
PROPOSED GREEN AREA		8697.341 SQM.	17.93 %		
ADDITIONAL AREAS					
BLOCK NAME	FACTOR	LENGTH	WIDTH	AREA	UNITS
G1	0.5	15.287	11.218	85.745	SQM
G2	1	13.014	20.041	260.614	SQM
G3	0.5	13.420	19.995	134.166	SQM
G4	0.5	46.608	30.308	706.298	SQM
G5	1	4.800	21.660	103.968	SQM
G6	1	4.800	39.752	190.810	SQM
G7	1	15.353	76.996	1182.150	SQM
G8	1	8.728	9.485	82.785	SQM
G9	1	26.429	74.998	1982.122	SQM
G10	1	8.470	34.744	294.282	SQM
G11	0.5	6.722	22.136	74.390	SQM
G12	1	16.844	4.795	80.767	SQM
G13	1	6.957	8.587	59.740	SQM
G14	0.5	21.977	14.540	159.773	SQM
G15	0.5	7.955	22.720	90.409	SQM
G16	1	5.510	16.440	90.584	SQM
G17	0.5	18.453	23.787	219.471	SQM
G18	1	97.078	8.793	853.807	SQM
G19	0.5	19.538	9.865	97.548	SQM
G20	1	16.035	1.500	24.053	SQM
G21	1	15.750	32.070	505.103	SQM
G22	1	25.026	1.500	37.539	SQM
G23	1	1.500	13.880	20.820	SQM
G24	1	1.500	13.880	20.820	SQM
G25	1	1.500	2.330	3.495	SQM
G26	1	1.500	27.821	41.732	SQM
G27	1	1.500	20.408	30.612	SQM
G28	1	1.500	6.301	9.452	SQM
G29	1	1.500	10.490	15.735	SQM
G30	1	1.500	20.489	30.734	SQM
G31	1	1.500	16.500	24.750	SQM
G32	1	1.500	3.760	5.640	SQM
G33	1	1.500	3.141	4.712	SQM
G34	1	1.500	2.885	4.328	SQM
G35	1	1.500	50.036	75.054	SQM
G36	1	1.500	9.079	13.619	SQM
G37	1	1.500	9.160	13.740	SQM
G38	1	1.500	76.870	119.805	SQM
G39	1	1.500	6.940	10.410	SQM
G40	1	1.500	13.655	20.483	SQM
G41	1	1.500	55.862	83.793	SQM
G42	1	1.500	41.838	62.757	SQM
G43	1	1.500	60.717	91.076	SQM
G44	1	1.500	139.841	209.762	SQM
G45	1	1.500	55.828	83.742	SQM
TOTAL GREEN AREA PROPOSED =		8312.997 SQM.			
EWS GREEN AREA					
G46	1	1.500	5.319	7.978	SQM
G47	1	1.500	43.791	65.687	SQM
G48	1	1.500	4.332	6.498	SQM
G49	1	1.500	20.358	30.537	SQM
G50	0.5	6.123	18.194	35.701	SQM
G51	1	5.545	18.194	100.886	SQM
G52	1	1.500	56.839	89.759	SQM
G53	1	1.500	18.199	27.299	SQM
EWS GREEN AREA PROPOSED =		384.344 SQM.			
TOTAL GREEN AREA PROPOSED =		8697.341 SQM.			

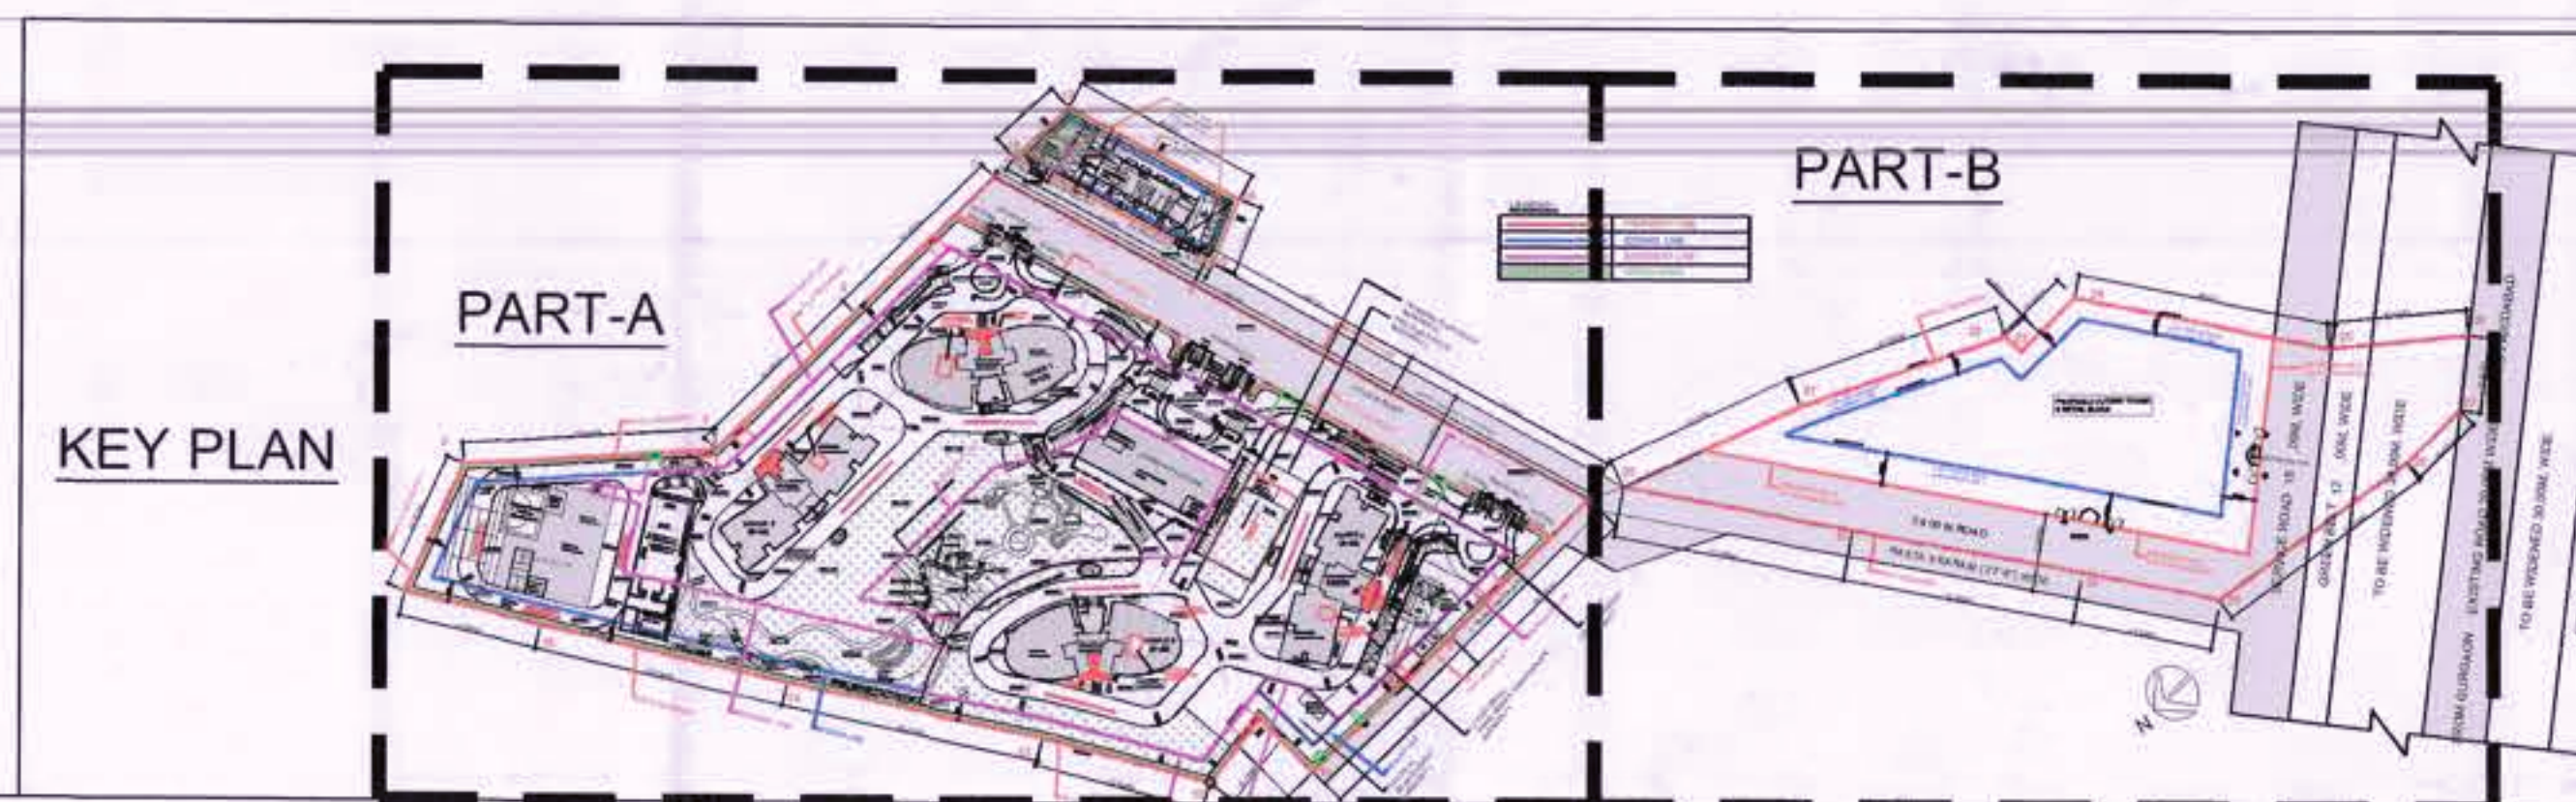

PLUMBING LEGEND:-

SYMBOL	DESCRIPTION
---	SEWER LINE
---	SEWER MANHOLE
---	SEWER MANHOLE

PLUMBING LEGEND:-

SYMBOL	DESCRIPTION
---	DOMESTIC WATER
---	FLUSHING WATER
---	RAIN WATER PIPE
---	SOIL PIPE
---	WASTE PIPE

PLUMBING LEGEND:-

SYMBOL	DESCRIPTION
---	SEWER LINE
DC	DESILT CHAMBER SIZE=2.0x1.0x1.0m
---	RAIN WATER HARVESTING PIT SIZE AS PER PLAN
---	SEWER MANHOLE
---	SEWER MANHOLE


TO BE READ WITH THIS OFFICE
MEMO NO: 687
DATED: 22/02/2024

This is a "PROVISIONAL BUILDING PLAN"
approved only for the purpose of obtaining
Objections from the general public.

DTP (HQ)
C. P. KUKREJA ARCHITECTS
DTP (HQ)
Ram Arav Basi
JD (HQ)

ARCHITECTS:
C. P. KUKREJA ARCHITECTS

ASHIRWAD BUILDING
D-1, GREEN PARK,
NEW DELHI - 110016,
PHONE: 26862953 FAX: 26865770,
EMAIL: cpka@cpkukreja.com

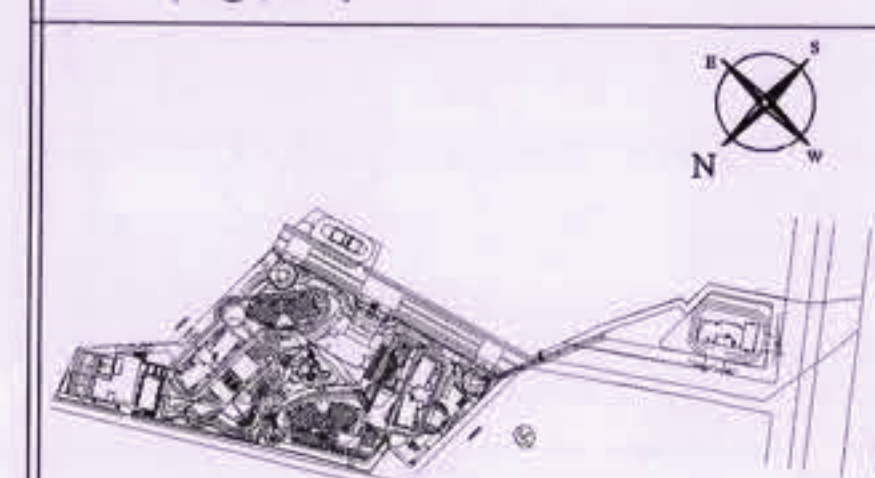

KEY PLAN

SUBMISSION DRAWINGS

REVISED BUILDING PLAN FOR GROUP
HOUSING COLONY BEING
DEVELOPED, OVER LAND
ADMEASURING 12.356 ACRES
SITUATED IN SECTOR-2, GWAL
PAHARI, HARYANA, UNDER LICENSE
NO. 98 OF 2011 DATED 11.11.2011, BY
ADANI INFRASTRUCTURE AND
DEVELOPERS PRIVATE LIMITED.

OWNER'S SIGN
ARCHITECT'S SIGN

SCALE 1:500 DATE DECEMBER-2023

DRAWING TITLE
SITE PLAN
LAND PARCEL-A
SEWERAGE LAYOUT

DWG NO
3a/54