

PLUMBING LEGEND:	
	RAIN WATER PIPE
PLUMBING LEGEND:	
	STORM WATER LINE
	CATCH BASIN
	STORM WATER MANHOLE

SYMBOL	DESCRIPTION
	SEWER LINE
	STORM WATER LINE
	STORM WATER DRAIN CHANNEL
	CATCH BASIN
	STORM WATER MANHOLE
	Drain Chamber SIZE: 4.0m x 1.5m
	RAIN WATER HARVESTING RI SIZE AS PER PLAN

This is a "PROVISIONAL PLUMBING PLAN" drawn only for reference purposes of building approvals from the competent authority.


OTR (H)
Architect

OTR (H)
Architect

TO BE READ WITH THIS OFFICE
DATED: 11.11.2011


GREEN AREA DETAIL			
SITE AREA	4893.925 SQM	11.8564 ACRES	
PERMISSIBLE GREEN AREA @ 15%	734.089 SQM		15.00
PROPOSED GREEN AREA	8897.341 SQM		17.93%
ADDITIONAL AREAS			
BLOCK NAME	FACTOR	LENGTH	WIDTH
G1	1.500	11.318	11.318
G2	1.500	13.014	20.541
G3	0.5	13.420	19.895
G4	0.5	48.808	30.305
G5	1.500	13.420	19.895
G6	1.500	39.752	16.810
G7	1.500	15.353	76.868
G8	1.500	8.728	9.458
G9	1.500	8.728	9.458
G10	1.500	8.728	9.458
G11	0.5	6.722	22.196
G12	1.500	18.844	4.795
G13	1.500	18.844	4.795
G14	0.5	21.977	14.540
G15	0.5	7.855	22.750
G16	0.5	18.510	15.450
G17	0.5	18.510	15.450
G18	1.500	97.078	6.793
G19	0.5	18.338	9.855
G20	1.500	18.338	9.855
G21	1.500	18.338	9.855
G22	1.500	25.028	1.500
G23	1.500	13.880	1.500
G24	1.500	13.880	1.500
G25	1.500	13.880	1.500
G26	1.500	27.821	41.742
G27	1.500	20.408	30.812
G28	1.500	10.940	15.745
G29	1.500	20.408	30.812
G30	1.500	16.500	24.750
G31	1.500	16.500	24.750
G32	1.500	16.500	24.750
G33	1.500	3.141	4.715
G34	1.500	2.885	4.328
G35	1.500	50.036	75.054
G36	1.500	50.036	75.054
G37	1.500	9.168	13.746
G38	1.500	78.870	118.805
G39	1.500	6.640	10.416
G40	1.500	16.500	24.750
G41	1.500	35.862	43.793
G42	1.500	41.538	62.757
G43	1.500	60.717	91.076
G44	1.500	15.353	76.868
G45	1.500	25.628	33.742
TOTAL GREEN AREA PROPOSED = 8312.997 SQM.			

EWS GREEN AREA			
G24	1.500	5.318	7.978
G27	1.500	4.132	6.198
G48	1.500	20.358	30.537
G50	0.5	6.125	18.194
G51	1.500	15.353	76.868
G52	1.500	25.628	33.742
G53	1.500	18.199	27.299
TOTAL GREEN AREA PROPOSED = 384.344 SQM.			

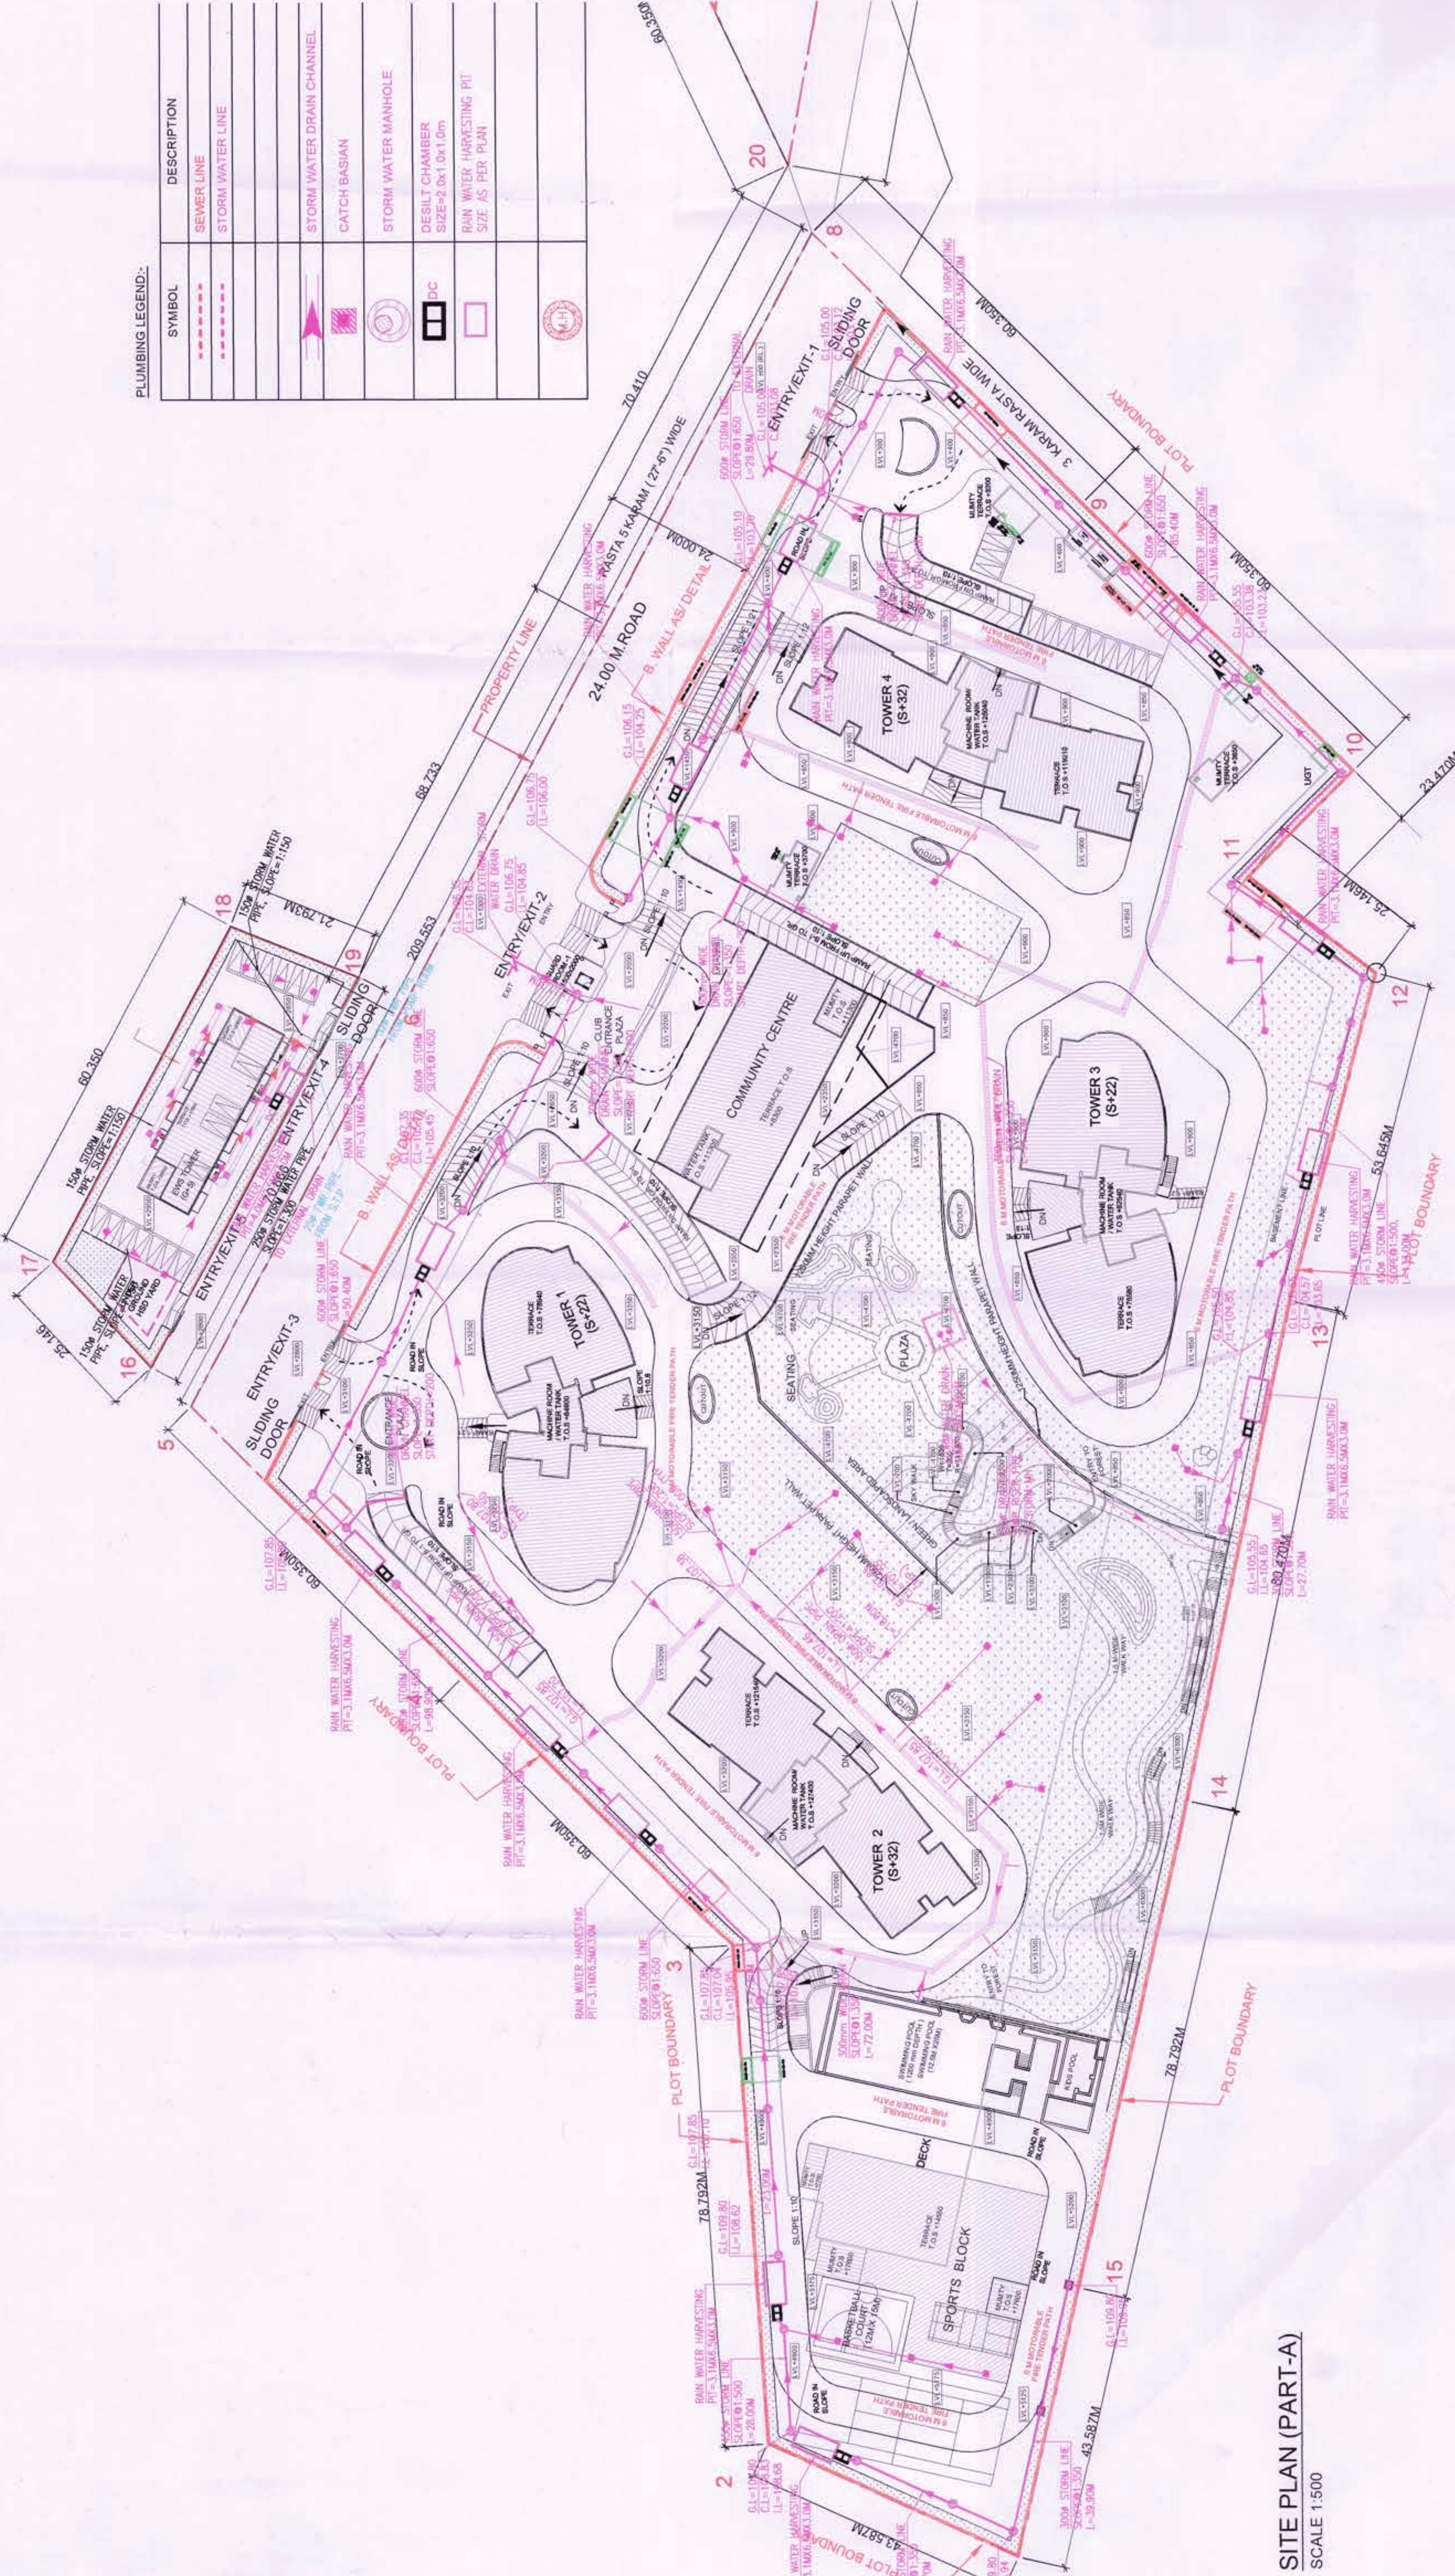


SITE PLAN (PART-A)
SCALE 1:500

ARCHITECTS:
C. P. KUKREJA ARCHITECTS
ASHIRWAD BUILDINGS
NEW DELHI - 110016
PHONE: 26663833 FAX: 26667770
EMAIL: cpk@cpkarchitects.com

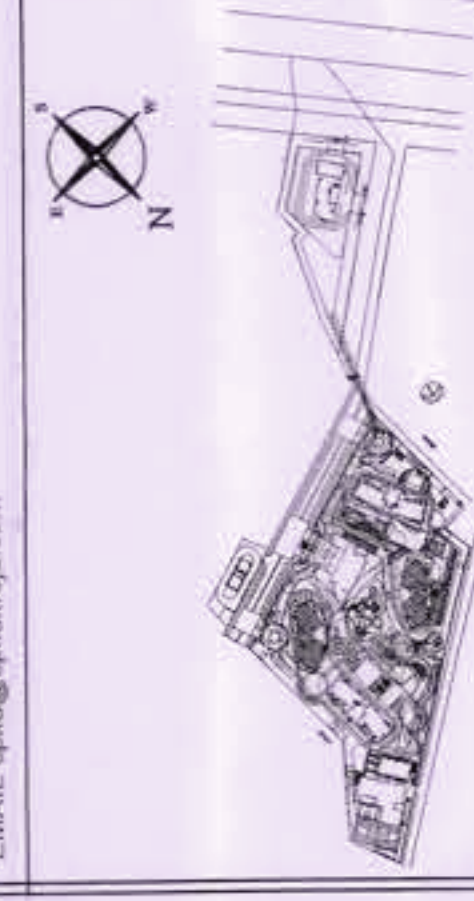

KEY PLAN
SUBMISSION DRAWINGS
REVISED BUILDING PLAN FOR GROUP HOUSING COLONY BEING DEVELOPED, OVER LAND ADMEASURING 12.356 ACRES SITUATED IN SECTOR-2, GWALAHARI, HARYANA, UNDER LICENSE NO. 98 OF 2011 DATED 11.11.2011, BY ADANI INFRASTRUCTURE AND DEVELOPERS PRIVATE LIMITED.

OWNER'S SIGN	ARCHITECT'S SIGN
SCALE: 1:500	SHEET: 000000003
DRAWING TITLE: SITE PLAN LAND PARCELA STORM WATER LAYOUT	DWG. NO: 30/54

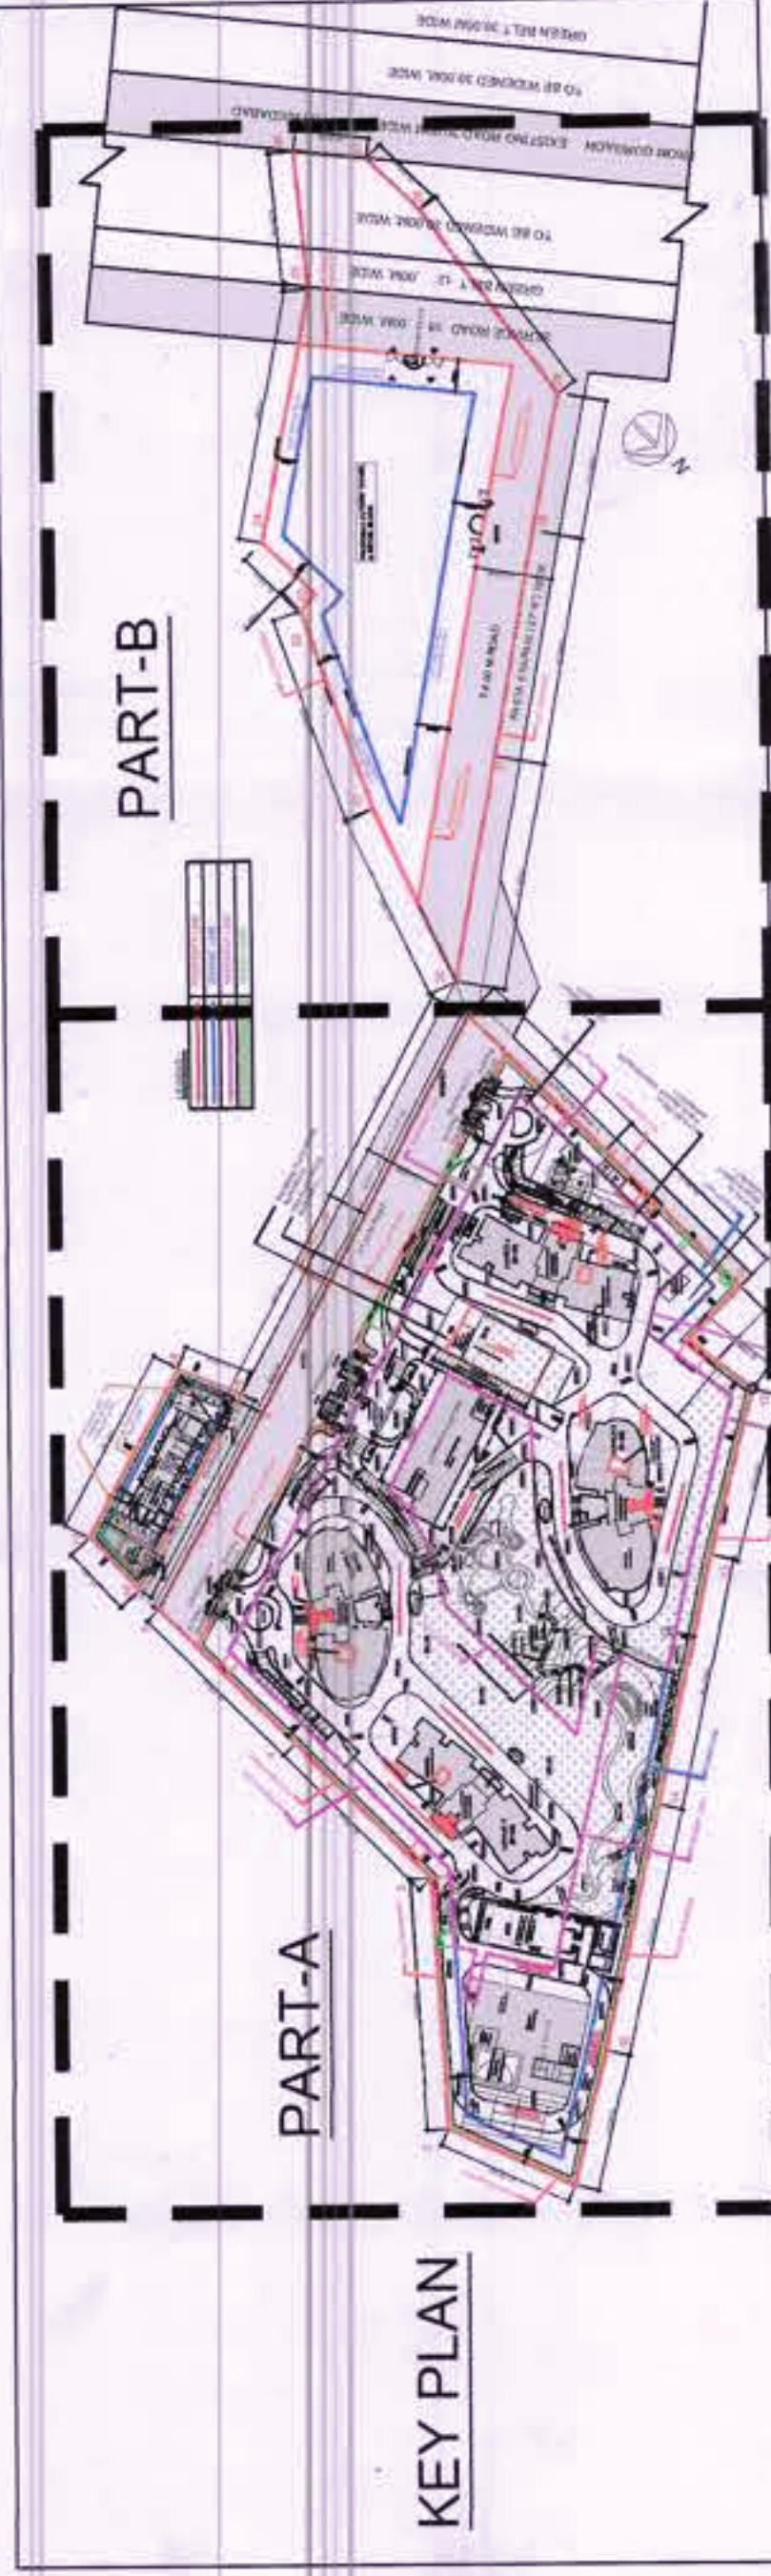

Checked and found ok for Public Health (Internal) Services only subject to comments in forwarding letter No. 27/12/16, dated 12/12/17.

Stamp of Civil Engineering Engineer (HOD) HSPV, Panchkula