

THIS IS A "PROVISIONAL" DRAWING. It is not to be used for the purpose of making any construction or for the purpose of obtaining any license or for the purpose of obtaining any other approval from the concerned public authorities. The user of this drawing is advised to consult the concerned public authorities for the purpose of obtaining any license or for the purpose of obtaining any other approval from the concerned public authorities.

TO BE USED WITH THIS DRAWING
DATED: 22.12.24


Architect
C.P. KUKREJA ARCHITECTS
PLOT NO. 30/54
SECTOR 10, GATEWAY INDIA, NEW DELHI - 110016

PLUMBING LEGEND:	
	DOMESTIC WATER
	FLUSHING WATER
	RAIN WATER PIPE
	WASTE PIPE

PLUMBING LEGEND:-	
	IRRIGATION LINE
	BALL/BUTTERFLY VALVE
	GARDEN HYDRANT

PLUMBING LEGEND:	
	SEWER LINE
	IRRIGATION LINE
	BALL/BUTTERFLY VALVE
	GARDEN HYDRANT

PLUMBING LEGEND:	
	DOMESTIC WATER
	FLUSHING WATER
	RAIN WATER PIPE
	WASTE PIPE

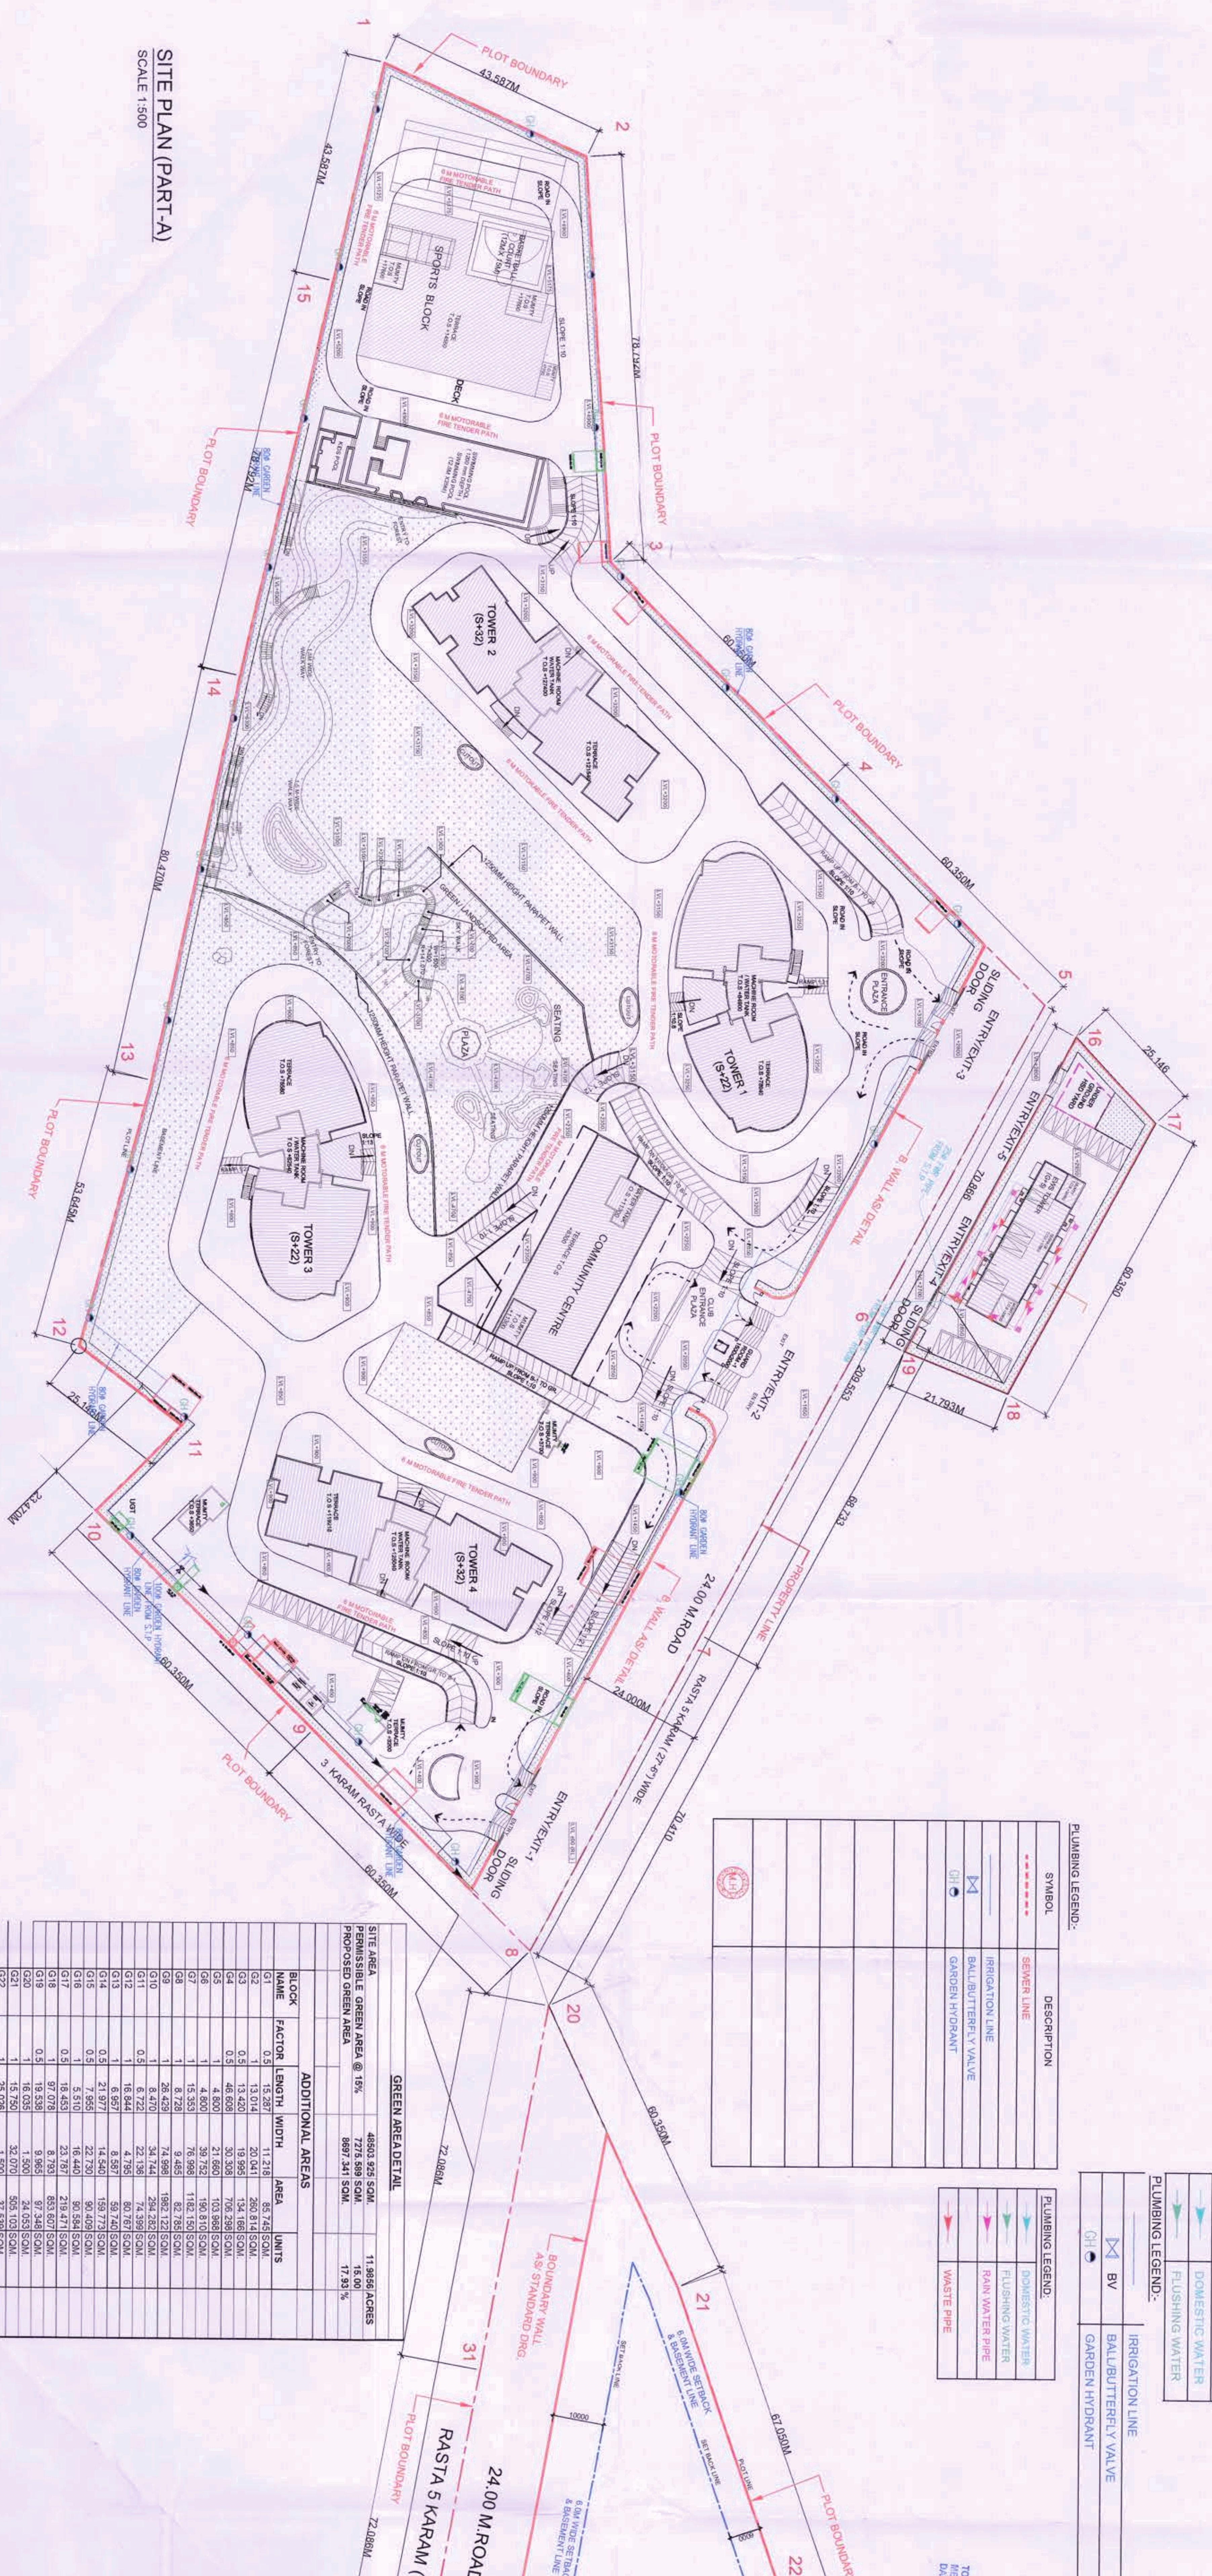


SITE PLAN (PART A)
SCALE 1:300

GREEN AREA DETAIL	
SITE AREA	4893.525 SQM.
PERMISSIBLE GREEN AREA @ 15%	734.028 SQM.
PROPOSED GREEN AREA	889.241 SQM.
	17.93 %

BLOCK			
NAME	FACTOR	LENGTH	WIDTH
G1	0.3	13.014	20.041
G2	0.3	13.420	19.856
G3	0.3	13.420	19.856
G4	0.3	13.420	19.856
G5	0.3	13.420	19.856
G6	0.3	13.420	19.856
G7	0.3	13.420	19.856
G8	0.3	13.420	19.856
G9	0.3	13.420	19.856
G10	0.3	13.420	19.856
G11	0.3	13.420	19.856
G12	0.3	13.420	19.856
G13	0.3	13.420	19.856
G14	0.3	13.420	19.856
G15	0.3	13.420	19.856
G16	0.3	13.420	19.856
G17	0.3	13.420	19.856
G18	0.3	13.420	19.856
G19	0.3	13.420	19.856
G20	0.3	13.420	19.856
G21	0.3	13.420	19.856
G22	0.3	13.420	19.856
G23	0.3	13.420	19.856
G24	0.3	13.420	19.856
G25	0.3	13.420	19.856
G26	0.3	13.420	19.856
G27	0.3	13.420	19.856
G28	0.3	13.420	19.856
G29	0.3	13.420	19.856
G30	0.3	13.420	19.856
G31	0.3	13.420	19.856
G32	0.3	13.420	19.856
G33	0.3	13.420	19.856
G34	0.3	13.420	19.856
G35	0.3	13.420	19.856
G36	0.3	13.420	19.856
G37	0.3	13.420	19.856
G38	0.3	13.420	19.856
G39	0.3	13.420	19.856
G40	0.3	13.420	19.856
G41	0.3	13.420	19.856
G42	0.3	13.420	19.856
G43	0.3	13.420	19.856
G44	0.3	13.420	19.856
G45	0.3	13.420	19.856
TOTAL GREEN AREA PROPOSED = 8312.897 SQM.			

EWS GREEN AREA	
G47	1.500
G48	1.500
G49	1.500
G50	1.500
G51	1.500
G52	1.500
G53	1.500
TOTAL GREEN AREA PROPOSED = 344.344 SQM.	

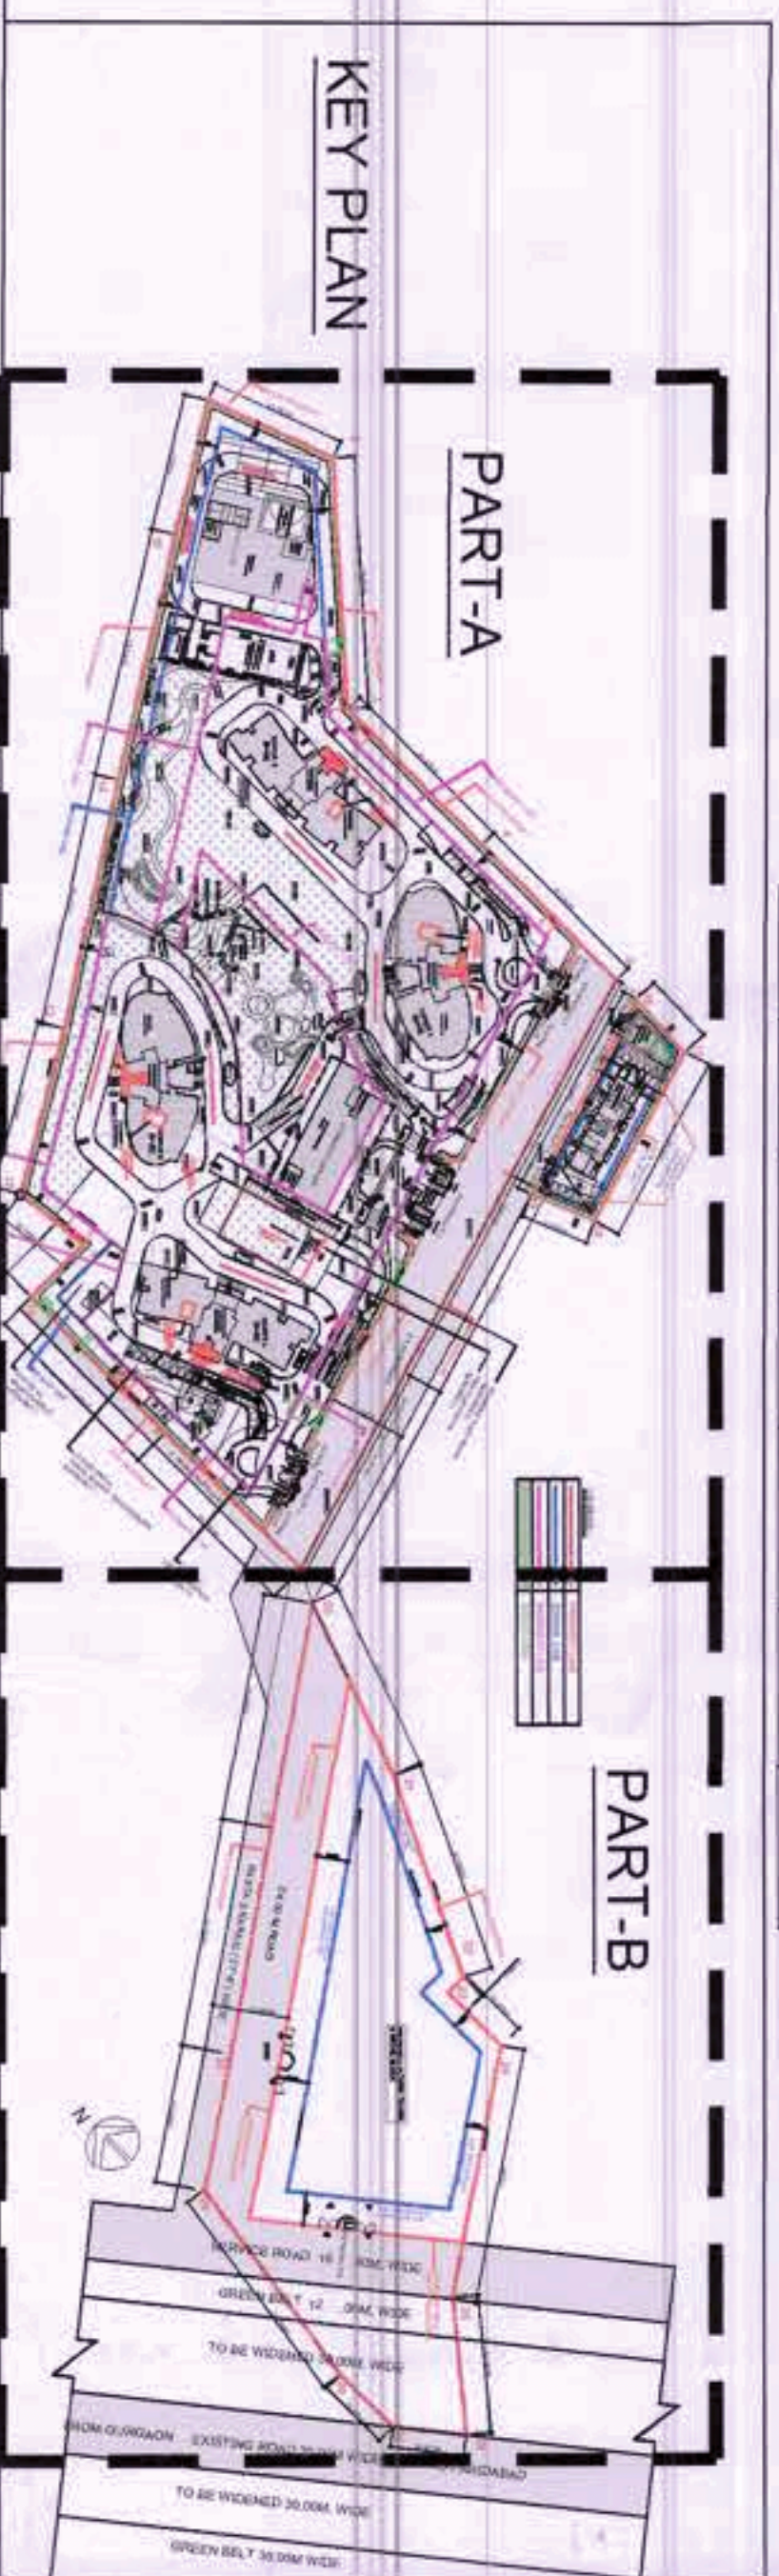

ARCHITECTS:
C. P. KUKREJA ARCHITECTS
ASHRWAAD BUILDING
NEW DELHI - 110016
PHONE: 26863353 FAX: 26865770
EMAIL: cpk@cpkarchitects.com

OWNERS: SSM
ARCHITECTS: SSM
DRAWING TITLE: SITE PLAN
LAND PARCELS
WATER SUPPLY LAYOUT
DATE: 30/04

REVISOR: SSM
ARCHITECTS: SSM
DRAWING TITLE: SITE PLAN
LAND PARCELS
WATER SUPPLY LAYOUT
DATE: 30/04