
 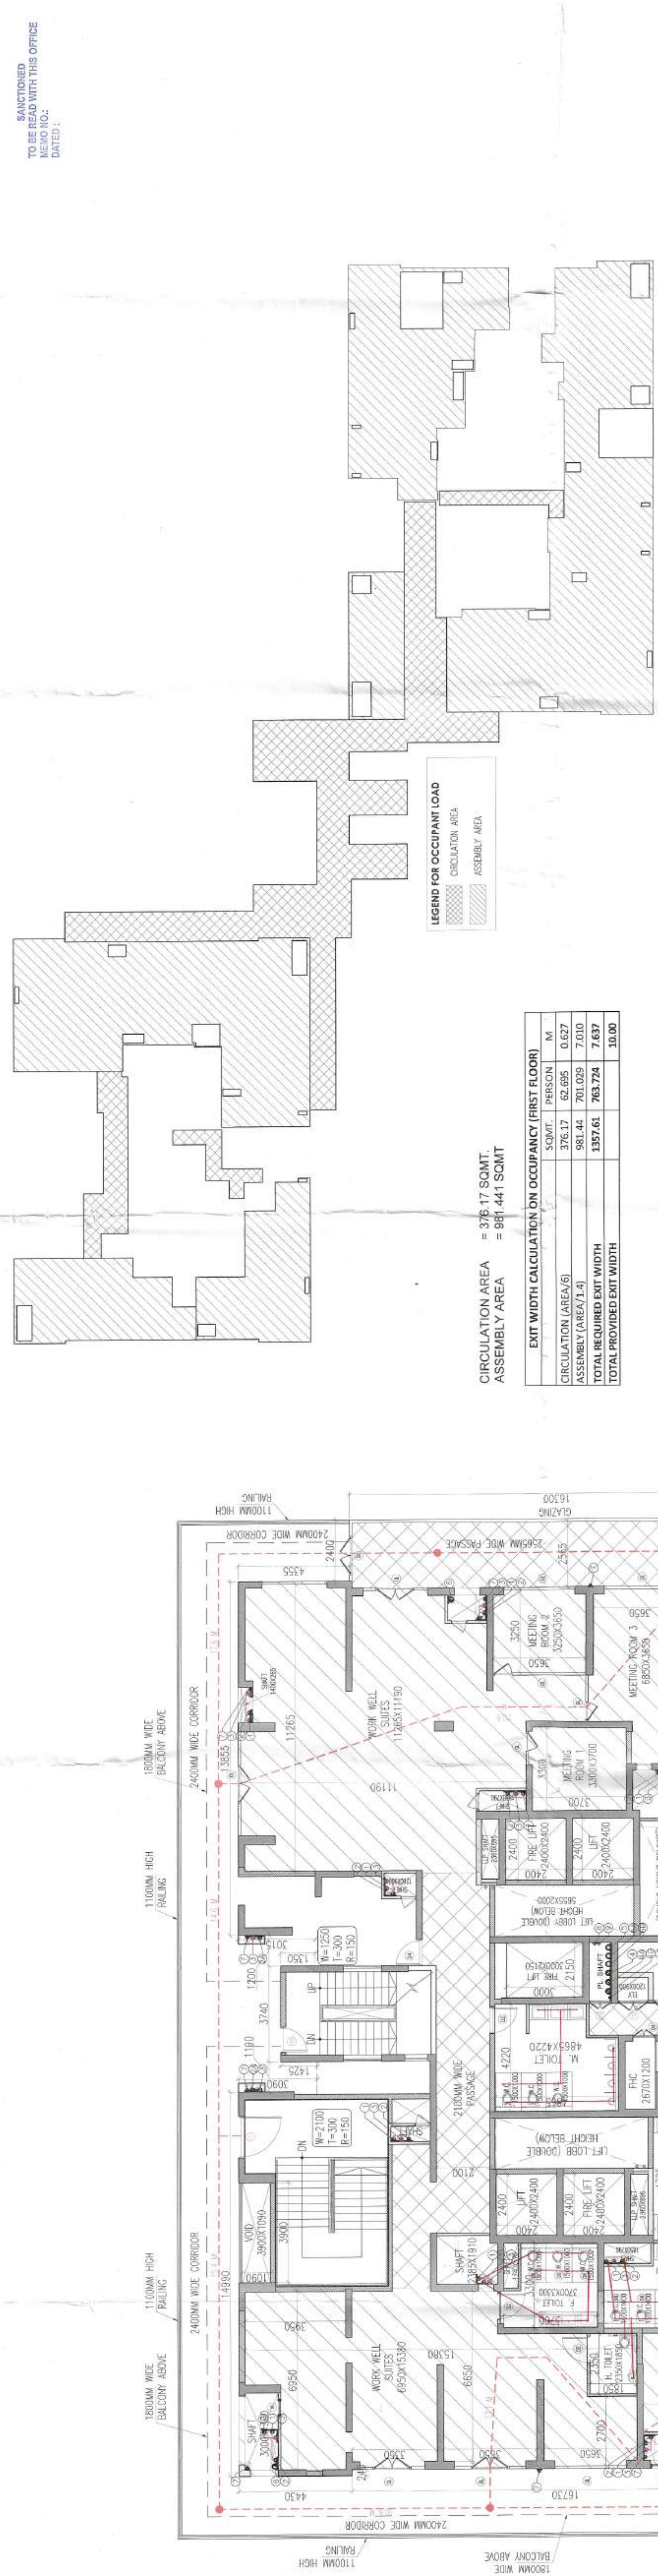
 




1ST FLOOR PLANS (COMMUNITY BUILDING-01)

SYMBOL	DESCRIPTION
①	110 OD SOIL AND VENT PIPE
②	110 OD WASTE AND VENT PIPE
③	110 OD KITCHEN WASTE AND VENT PIPE
④	110 OD ANTI-SIPHONAGE PIPE
⑤	DOMESTIC WATER SUPPLY DN, TACK PIPE
⑥	DOMESTIC WATER SUPPLY DN, TACK PIPE
⑦	DOMESTIC WATER SUPPLY DN, TACK PIPE FOR TOP 4TH FLOORS (PRESSURE SUPPLY)
⑧	FLUSHING WATER SUPPLY DN, TACK PIPE
⑨	FLUSHING WATER SUPPLY DN, TACK PIPE
⑩	60 OD UPVC TERRACE RAIN WATER PIPE
⑪	110 OD JAWAN THROUGH RAIN WATER PIPE
⑫	75Ø UPVC RAIN WATER PIPE (BALCONY)
⑬	DOMESTIC WATER SUPPLY RISER
⑭	FLUSHING WATER SUPPLY RISER
⑮	FLOOR DRAIN
⑯	FLOOR TRAP
⑰	EDGE WALL
⑱	OUTDOOR FLOOR

PROJECT	LAND OWNER / DEVELOPER	BIP HOLDER	DESIGN CONSULTANT	SERVICES CONSULTANTS	STRUCTURAL CONSULTANTS	LICENSE DETAIL	DATE :	ARCHITECTS SEAL & SIGNATURE	LAND OWNERS/DEVELOPER SIGNATURE	BP HOLDER/Contractor/Permitted Occupant SIGNATURE	DWG. NO.	42
PROPOSED GROUP HOUSING AT VILLAGE HARSARU, SECTOR 36A, SUB-TEHSIL HARSARU, DISRICT GURUGRAM, HARYANA, 122001	DELTA PROPCON PVT LTD 3RD FLOOR, CENTRAL PLAZA MALL, SECTOR 53, GURUGRAM-122002	MAX ESTATES GURGAON LIMITED MAX TOWER, G-001/A-1 SECTOR-16B, NOIDA, GAUTAM BUDDHA NAGAR - 201301	RSP Design Consultants Pvt. Ltd. RSP Design Consultants Pvt. Ltd., Sri Aurobindo Bhawan, Sector-46 Sohna Road, Gurugram 122019 Phone: 011-26555110/26555159 Fax: 011-26555110/26555159 Email: rsp@rspindia.net Web: www.rspindia.net	Servicio Consultants/Private Limited Servicio Consultants Pvt. Ltd., Phase II, New Delhi - 110 020, India Phone: 011-26555110/26555159 Fax: 011-26555110/26555159 5291@servicio.com	Vinodh Consultants Vinodh Consultants Pvt. Ltd., C-35, Park Road, Enclave, Gurgaon (Kashish - I), Haryana Phone: 011-26555110/26555159 Email: vinodh@vinodhconsultants.com	LICENSE NO. 38 OF 2013 DATED 04.06.2013 GRANTED FOR 23.4188 ACRES AND LICENSE NO. 97 OF 2013 DATED 08.11.2013 GRANTED FOR 1.6875 ACRES WITH ADDITIONAL AREA MEASURING 1.05 ACRES UNDER TRANSIT ORIENTED DEVELOPMENT POLICY OF GURUGRAM. THE TOTAL AREA OF THE PROJECT IS 26.1163 ACRES IN SECTOR - 36A, GURUGRAM MANESAR URBAN COMPLEX BEING DEVELOPED BY DELTA PROPCON PVT. LTD.		 A. V. NETHI F. No. 25922, P. No. 1050 H. No. 25922, P. No. 1050 Affiliated Signatory			DWG. TITLE: 1ST FLOOR PLANS (COMMUNITY BUILDING-01)	SUBMISSION DRAWING