



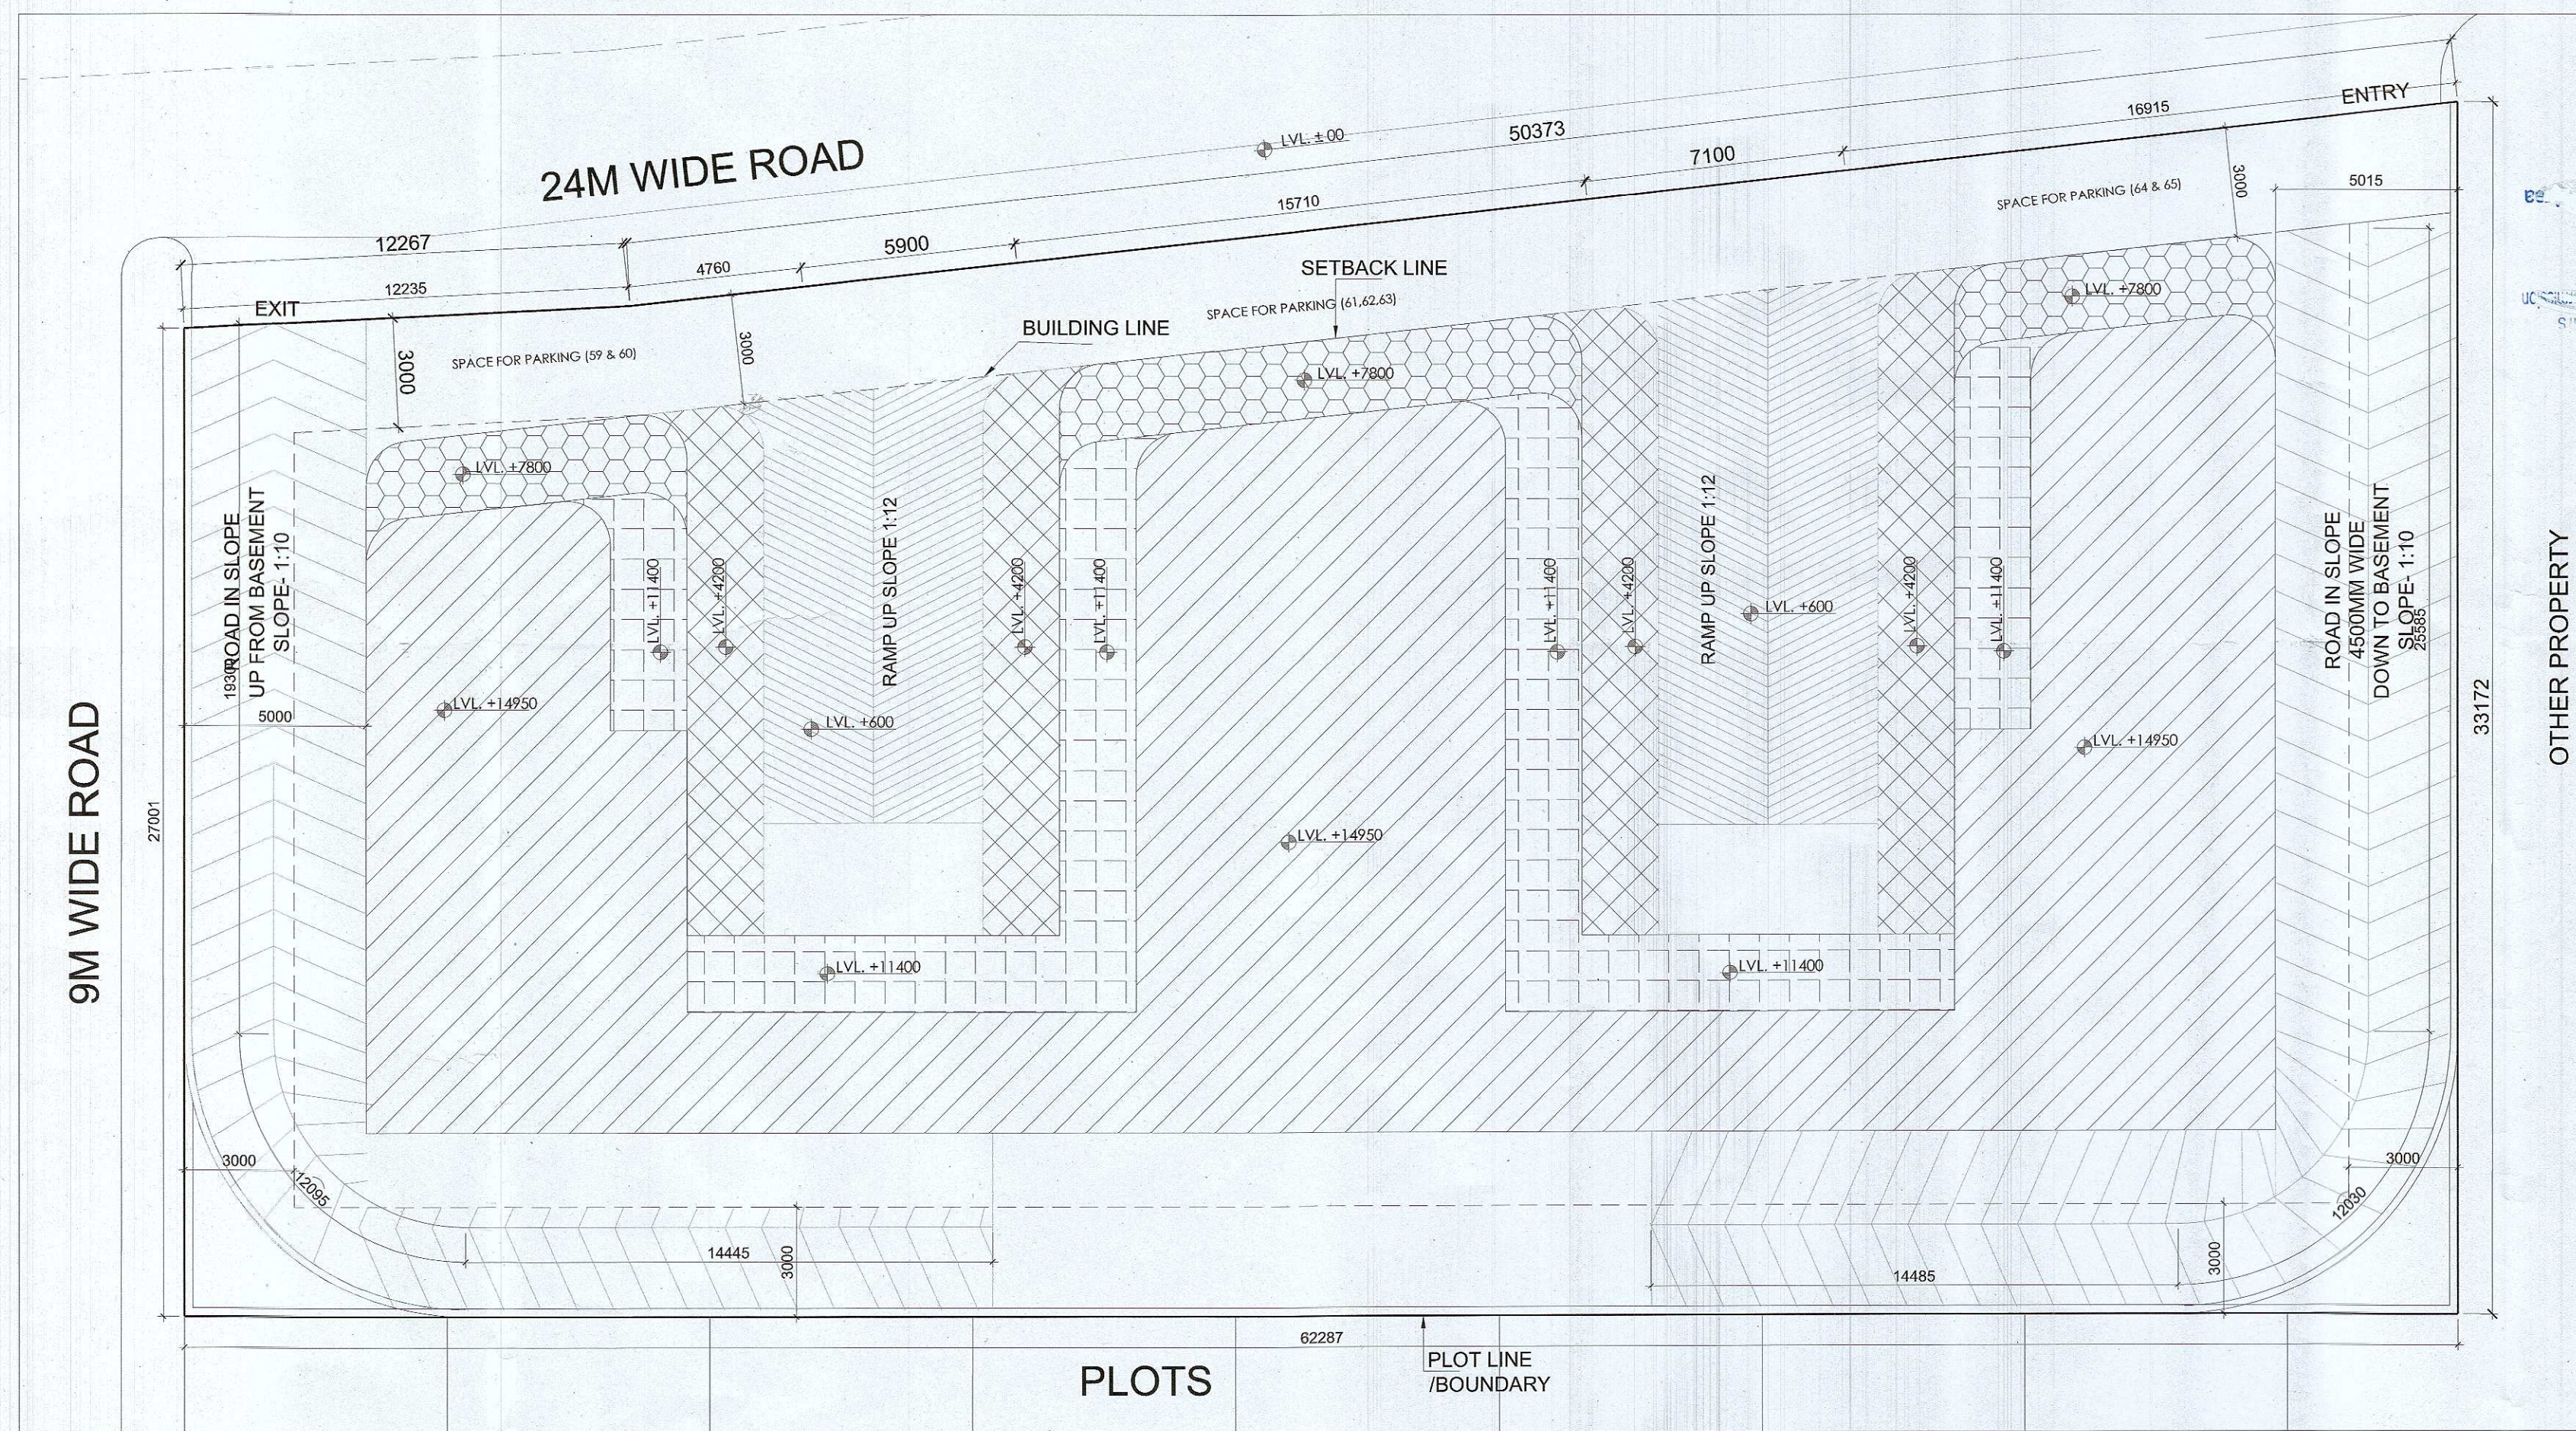

FIRE LEGEND	
4.5KG CO2 TYPE FIRE EXTINGUISHER	
6.KG ABC TYPE FIRE EXTINGUISHER	
FIRE HOSE CABINET	

TOILET INTERNAL DETAIL	
SYMBOL	ABBREVIATION
A	1000 SOIL PIPE
A1	400 SOIL PIPE
B	1000 WASTE PIPE
B1	400 WASTE PIPE
B2	500 WASTE PIPE
FT	FLOOR TRAP
FD	FLOOR DRAIN
COP	CLEAN OUT PLUG
150X150mm CUTOUT	

SHAFT PIPE	DETAIL	DESCRIPTION
1	SP	1000 SOIL PIPE
2	WP	1000 WASTE PIPE
3	FWS	FLUSHING WATER RISER
4	CWS	COLD WATER RISER
5	CWS	COLD WATER SUPPLY DROP
6	FWS	FLUSHING WATER SUPPLY DROP
7	RWP	1000 RAIN WATER PIPE
8		1000 FIRE DN.COMER PIPE
9		800 DRAIN PIPE

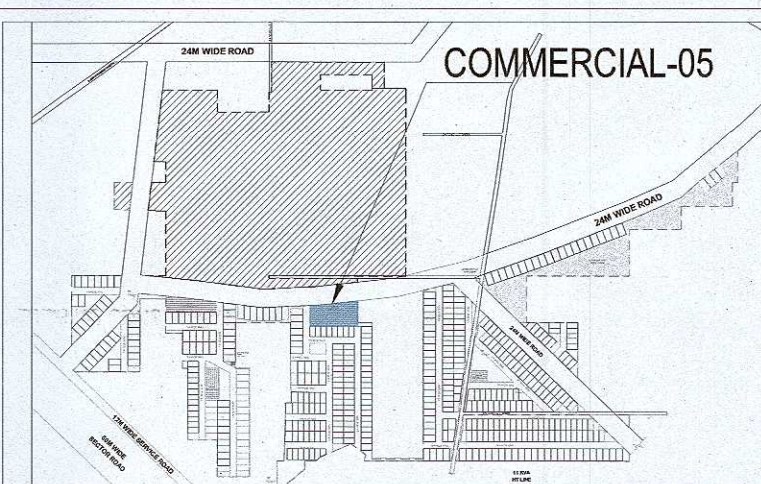

DOORS & WINDOWS OPENING SCHEDULE						
S.NO	TYPE	ROUGH OPENING (IN MM)				LOCATIONS
		WIDTH	HEIGHT	SILL LVL	LINTEL LVL	
1	D1	900	2100	+00	+2100	TOILET
2	D2	1500	2400	+00	+2400	STAIRCASE
3	D3	1200	2100	+00	+2100	TOILET
4	V1	1500	600	+1500	+2100	TOILET
5	V2	600	600	+1500	+2100	TOILET
6	GL1	2100	2400	+300	+2400	SHOP
7	GL2	1875	2400	+00	+2400	SHOP
8	GL3	8300	2400	+00	+2400	SHOP
9	GL4	2400	2400	+00	+2400	SHOP
10	GL5	3100	2400	+00	+2400	SHOP
11	GL6	2150	2400	+00	+2400	SHOP
12	GL7	2515	2400	+00	+2400	SHOP
13	GL8	2700+3845	2400	+00	+2400	SHOP
14	GL9	10900	2400	+00	+2400	SHOP
15	GL10	9075	2400	+00	+2400	SHOP
16	GL11	8445	2400	+00	+2400	SHOP
17	GL12	1700	2400	+00	+2400	SHOP
18	GL13	2600	2400	+00	+2400	SHOP
19	GL14	3800	2400	+00	+2400	SHOP
20	GL15	9235	2400	+00	+2400	SHOP
21	GL16	11785	2400	+00	+2400	SHOP
22	GL17	2650+15745	2400	+00	+2400	SHOP
23	GL18	10410	2400	+00	+2400	SHOP
24	GL19	4365	2400	+00	+2400	SHOP
25	GL20	4150	2400	+00	+2400	SHOP
26	GL21	5935	2400	+00	+2400	SHOP
27	GL22	5465	2400	+00	+2400	SHOP
28	GL23	2650+1845	2400	+00	+2400	SHOP
29	GL24	2400	2400	+00	+2400	SHOP
30	GL25	10185	2400	+00	+2400	SHOP
31	GL26	5545+2130	2400	+00	+2400	SHOP
32	GL27	6275+2130	2400	+00	+2400	SHOP
33	GL28	2100	2400	+00	+2400	SHOP
34	GL29	1800	2400	+00	+2400	SHOP
35	GL30	13775	2400	+00	+2400	SHOP
36	GL31	4245	2400	+00	+2400	SHOP
37	GL32	5800	2400	+00	+2400	SHOP
38	GL33	4000	2400	+00	+2400	SHOP
39	GL34	5350	2400	+00	+2400	SHOP

NOTE: ALL LEVELS ARE FROM FFL

SUBMISSION DRAWING

CLIENT
LOON LAND DEVELOPMENT LTD.

PROJECT
LAYOUT PLAN OF PROPOSED RESIDENTIAL
PLOTED COLONY UNDER DEEN DAYAL JAN AWAS
Yोजना SCHEME-2016 IN SECTOR-79-79B,
GURUGRAM
(HR.) LAND MEASURING 45.822 ACRES. BEING
DEVELOPED BY LOON LAND DEVELOPMENT LTD.

ARCHITECTS
Confluence

B- 421, NEW FRIENDS Ph: +91-11-46130600 ccs@inconfluence.com Member of IGBC
COLONY N.D-85 INDIA Ph: +91-11-40564768 www.inconfluence.com ISO - 9001 : 2000
architecture urban design hospitality interiors

PLUMBING CONSULTANT



KUMAR ENDECON PVT. LTD.
40/60, SECOND FLOOR, CR
PARK, NEW DELHI -110019

DRAWING NO. REVISION

DRAWING TITLE
**COMMERCIAL PLOT (05)
FLOOR PLANS**

OWNER SIGN

ARCHITECT SIGN



Sanctioned and Valid For 2 Years
Subject to Validity of Licence CLU Extension Permission
Chairperson
Building Plan Committee Controlled Area
Gurgaon Circle, Gurgaon

JD.

P.A.

ART.P.

