



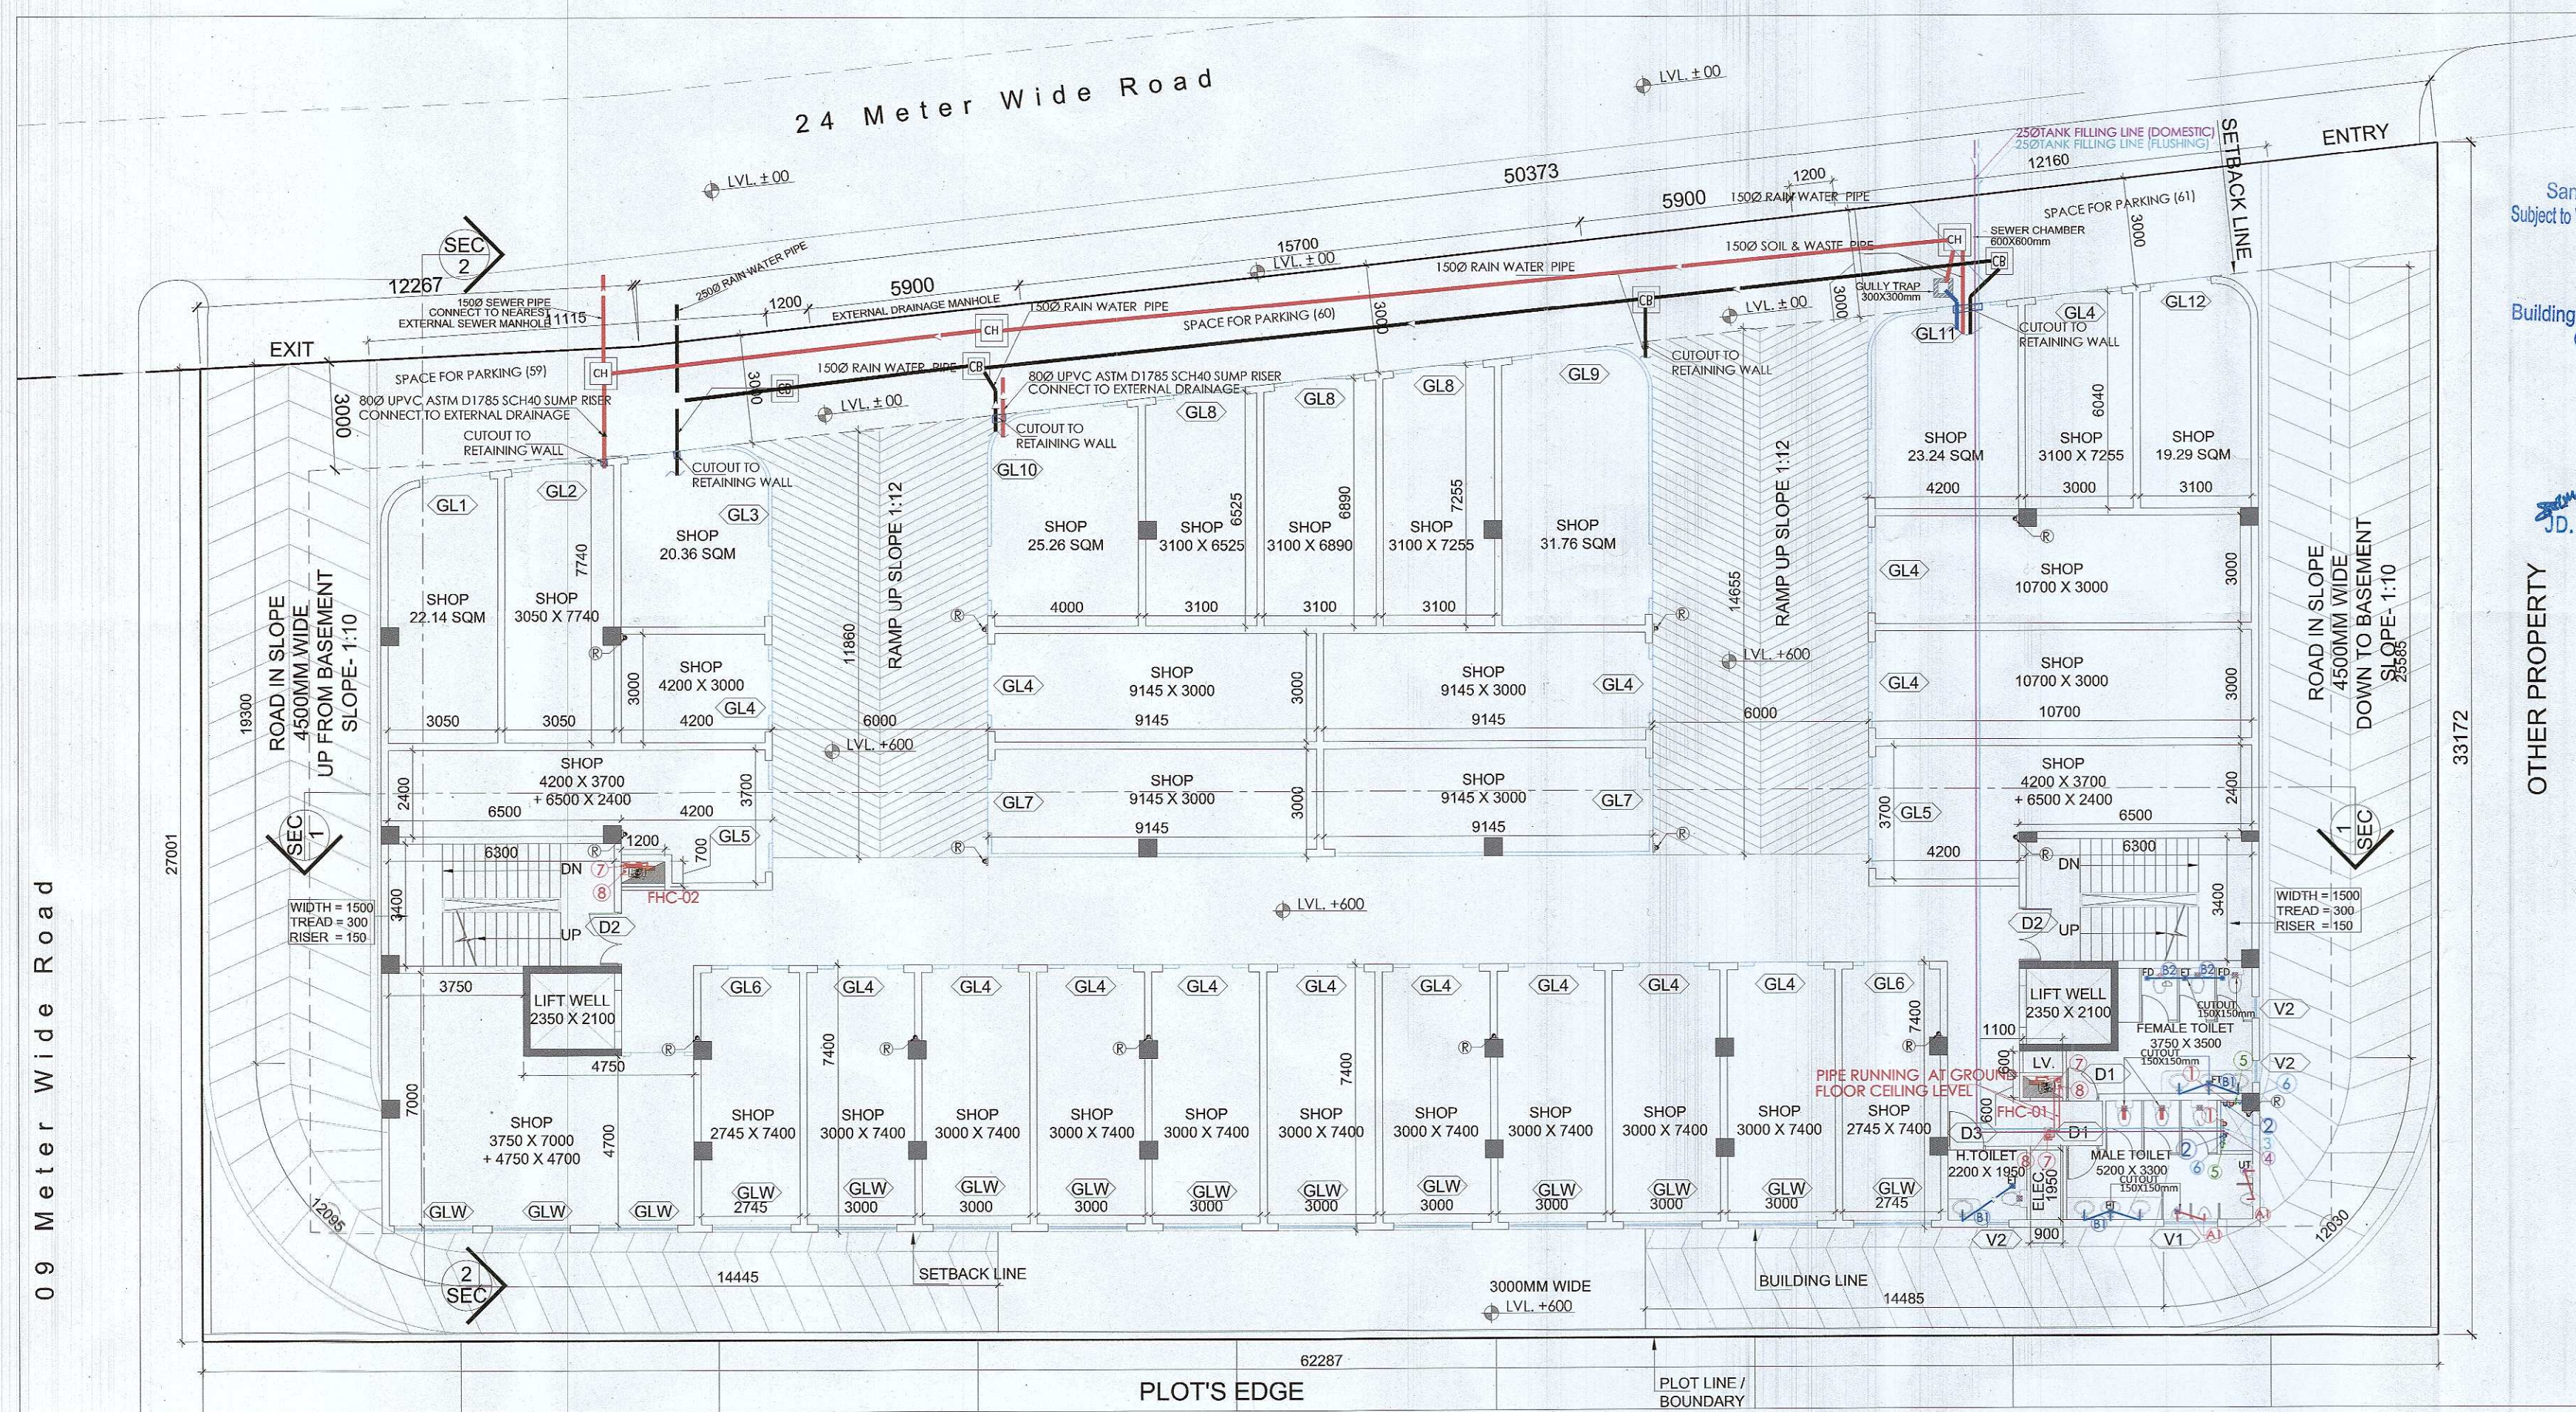

1 GROUND FLOOR PLAN
SCALE 1:200

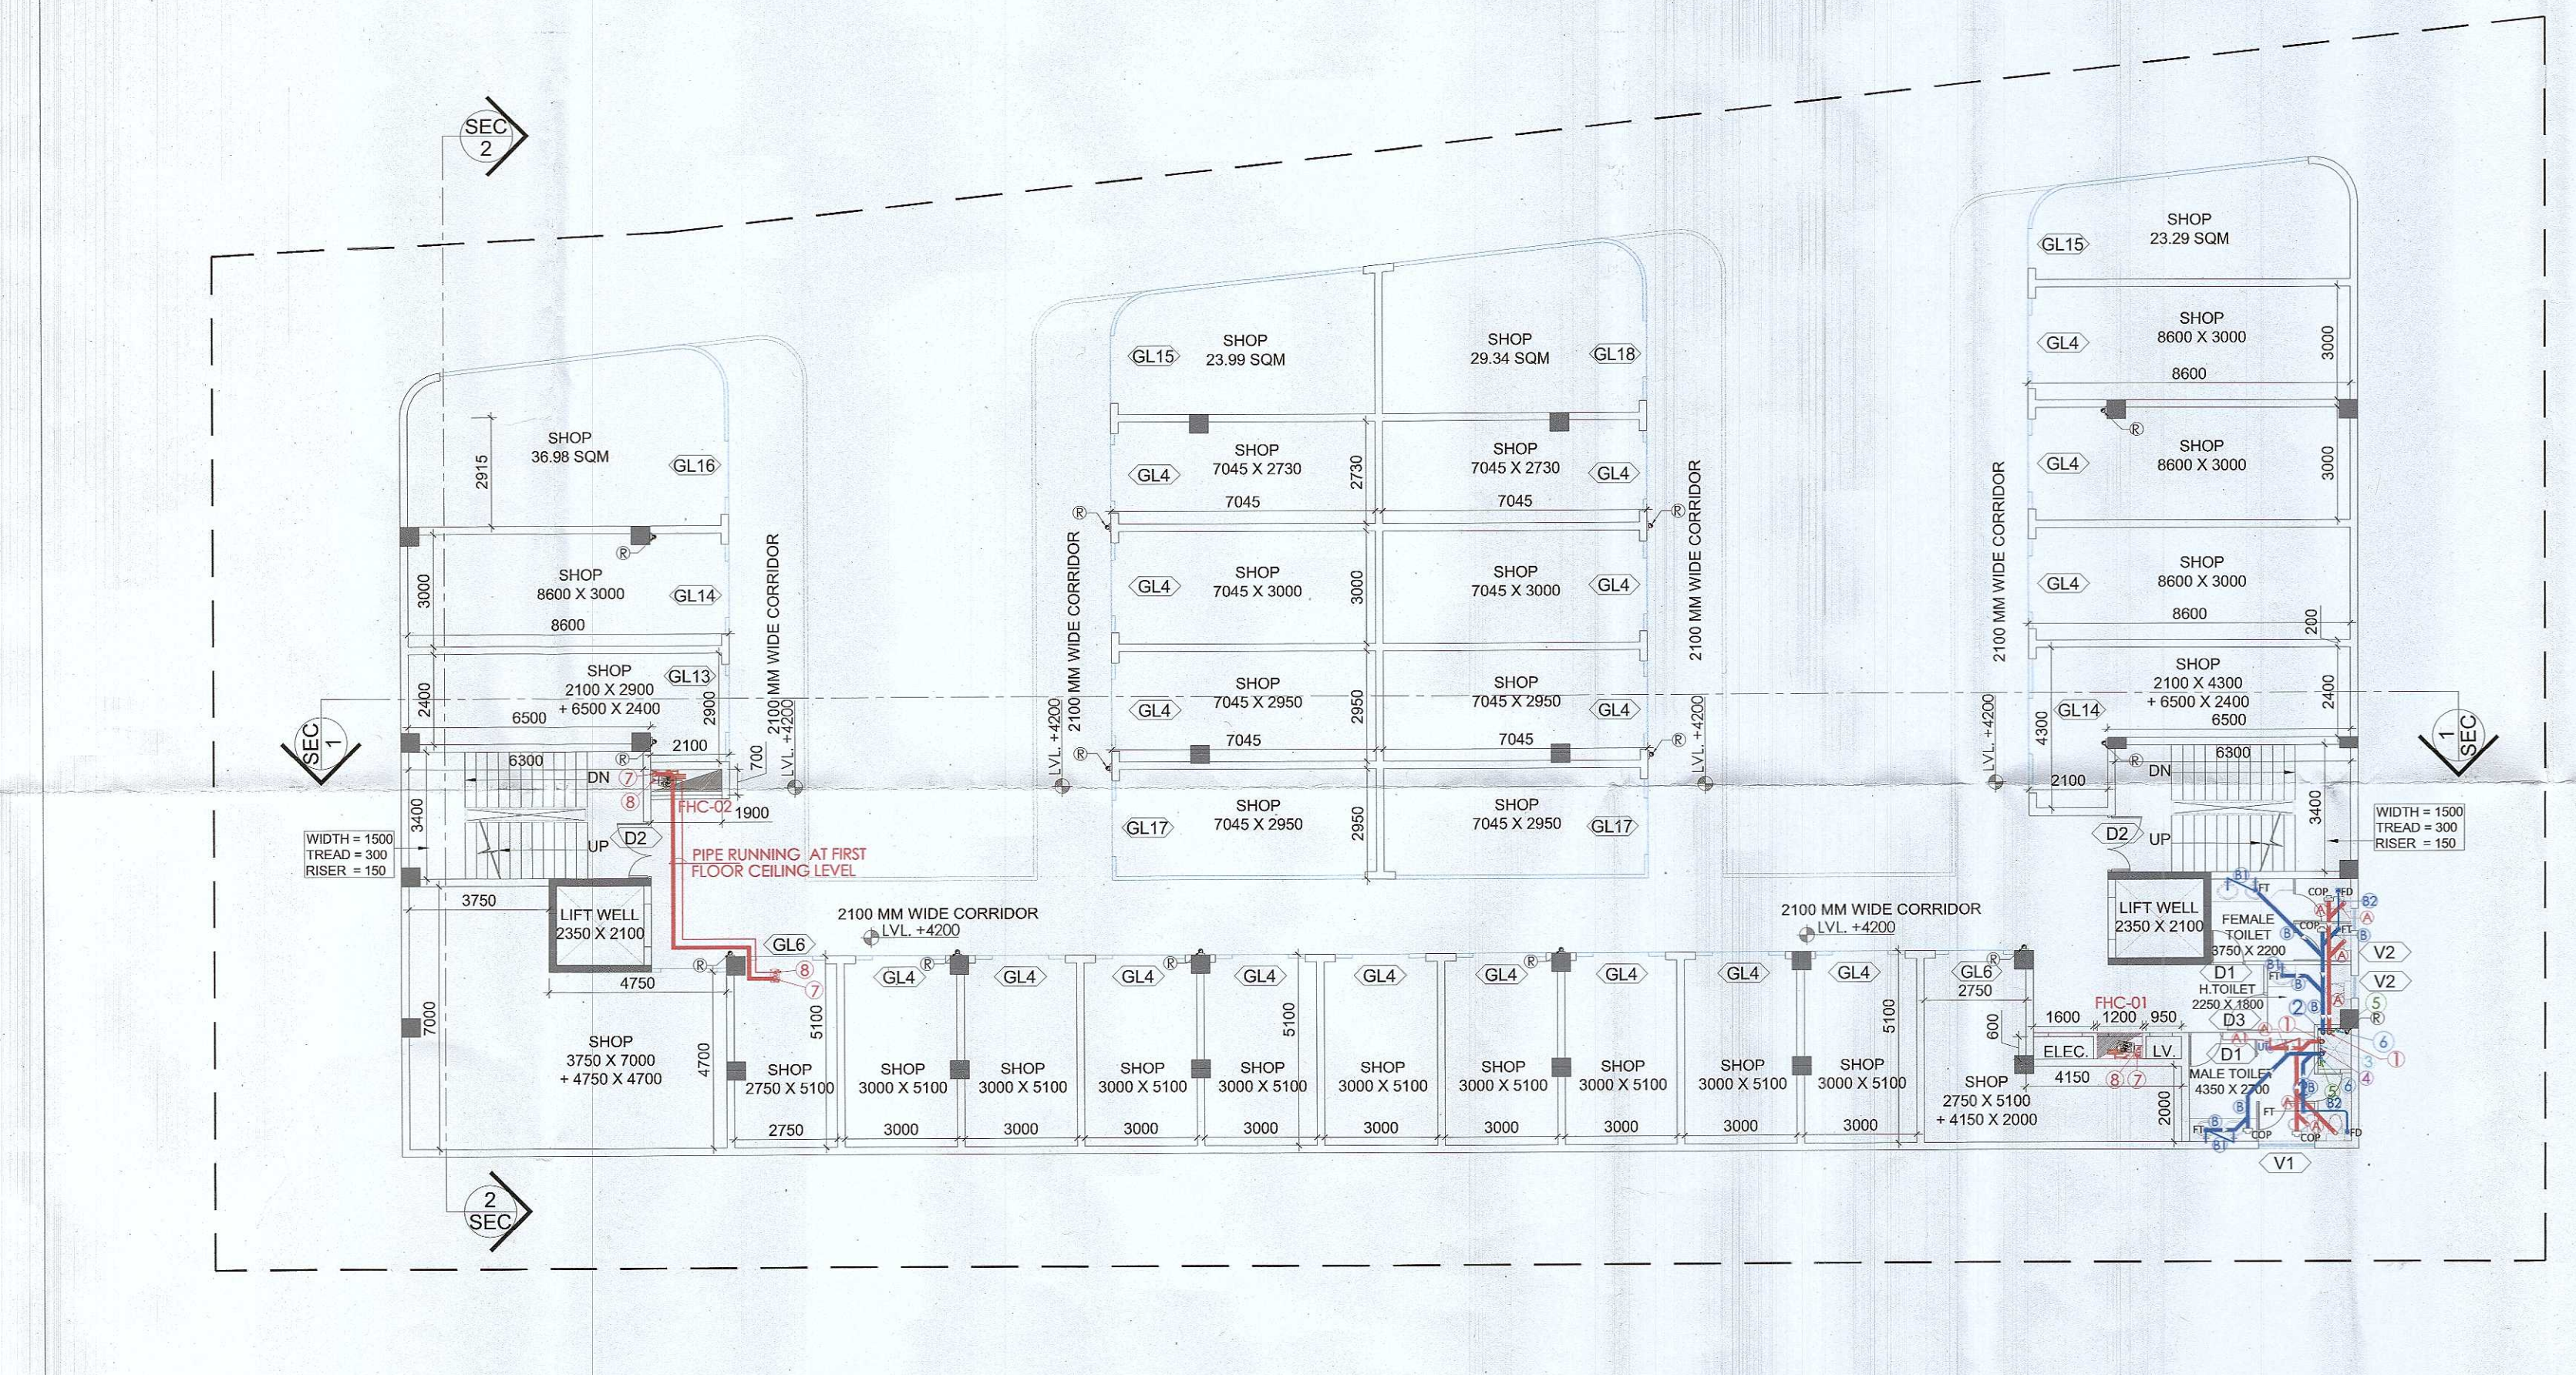

3 FIRST FLOOR PLAN
SCALE 1:150

FIRE LEGEND	
4.5KG CO2 TYPE FIRE EXTINGUISHER	
6.KG ABC TYPE FIRE EXTINGUISHER	
FIRE HOSE CABINET	


Sanctioned and Valid For 2 Years
Subject to Validity of Licence CLU/Extension Permission

Chairperson
Building Plan Committee Controlled Area
Gurgaon Circle, Gurgaon

OTHER PROPERTY

TOILET INTERNAL DETAIL	
SYMBOL	ABBREVIATION
A	1000 SOIL PIPE
A1	400 SOIL PIPE
B	1000 WASTE PIPE
B1	400 WASTE PIPE
B2	500 WASTE PIPE
FT	FLOOR TRAP
FD	FLOOR DRAIN
COP	CLEAN OUT PLUG
⊗	150X150mm CUTOUT

SHAFT PIPE DETAIL		
SYMBOL	ABBREVIATION	DESCRIPTION
①	SP	1000 SOIL PIPE
②	WP	1000 WASTE PIPE
③	FWS	FLUSHING WATER RISER
④	CWS	COLD WATER RISER
⑤	CWS	COLD WATER SUPPLY DROP
⑥	FWS	FLUSHING WATER SUPPLY DROP
⑦	RWP	1000 RAIN WATER PIPE
⑧		800 DRAIN PIPE

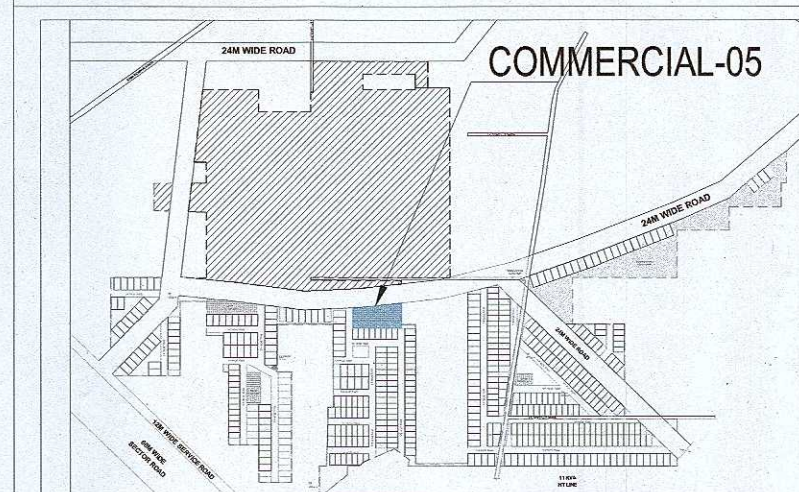

5 KEY PLAN
SCALE 1:500

DOORS & WINDOWS OPENING SCHEDULE

S.NO.	TYPE	WIDTH	HEIGHT	SILL LVL	UNTEL LVL	LOCATIONS
1	D1	900	2100	+00	+2100	TOILET
2	D2	1500	2400	+00	+2400	STAIRCASE
3	D3	1200	2100	+00	+2100	TOILET
4	V1	1500	600	+1500	+2100	TOILET
5	V2	600	600	+1500	+2100	TOILET
6	GL1	2100	2400	+00	+2400	SHOP
7	GL2	1975	2400	+00	+2400	SHOP
8	GL3	2885	2400	+00	+2400	SHOP
9	GL4	8300	2400	+00	+2400	SHOP
10	GL5	2400	2400	+00	+2400	SHOP
11	GL6	3100	2400	+00	+2400	SHOP
12	GL7	2150	2400	+00	+2400	SHOP
13	GL8	2515	2400	+00	+2400	SHOP
14	GL9	2700+8845	2400	+00	+2400	SHOP
15	GL10	10900	2400	+00	+2400	SHOP
16	GL11	2600	2400	+00	+2400	SHOP
17	GL12	8075	2400	+00	+2400	SHOP
18	GL13	8445	2400	+00	+2400	SHOP
19	GL14	1700	2400	+00	+2400	SHOP
20	GL15	2600	2400	+00	+2400	SHOP
21	GL16	9225	2400	+00	+2400	SHOP
22	GL17	11785	2400	+00	+2400	SHOP
23	GL18	2650+6745	2400	+00	+2400	SHOP
24	GL19	10410	2400	+00	+2400	SHOP
25	GL20	4365	2400	+00	+2400	SHOP
26	GL21	2100	2400	+00	+2400	SHOP
27	GL22	4150	2400	+00	+2400	SHOP
28	GL23	5935	2400	+00	+2400	SHOP
29	GL24	5465	2400	+00	+2400	SHOP
30	GL25	2650+4645	2400	+00	+2400	SHOP
31	GL26	2400	2400	+00	+2400	SHOP
32	GL27	10185	2400	+00	+2400	SHOP
33	GL28	5545+2130	2400	+00	+2400	SHOP
34	GL29	6275+2130	2400	+00	+2400	SHOP
35	GL30	2100	2400	+00	+2400	SHOP
36	GL31	1800	2400	+00	+2400	SHOP
37	GL32	13775	2400	+00	+2400	SHOP
38	GL33	4245	2400	+00	+2400	SHOP
39	GL34	4945	2400	+00	+2400	SHOP
40	GL35	5600	2400	+00	+2400	SHOP
41	GL36	4000	2400	+00	+2400	SHOP
42	GL37	5350	2400	+00	+2400	SHOP

NOTE: ALL LEVELS ARE FROM FFL

SUBMISSION DRAWING

CLIENT
LOON LAND DEVELOPMENT LTD.

PROJECT
LAYOUT PLAN OF PROPOSED RESIDENTIAL
PLOTED COLONY UNDER DEEN DAYAL JAN AWAS
YOJNA SCHEME-2016 IN SECTOR-79-79b,
GURUGRAM
(HR.) LAND MEASURING 45.822 ACRES. BEING
DEVELOPED BY LOON LAND DEVELOPMENT LTD.

ARCHITECTS
Confluence

B-421, NEW FRIENDS COLONY N.D-65 INDIA
Ph: +91-11-46130500 ccs@confluence.com Member of IGC
Ph: +91-11-46547158 www.confluence.com ISO - 9001:2000
architecture urban design hospitality interiors

PLUMBING CONSULTANT

KEPL
KUMAR ENDECON PVT. LTD.
40/60, SECOND FLOOR, CR
PARK, NEW DELHI -110019

DRAWING NO. REVISION

DRAWING TITLE
COMMERCIAL PLOT (05)
FLOOR PLANS

OWNER SIGN

ARCHITECT SIGN

