



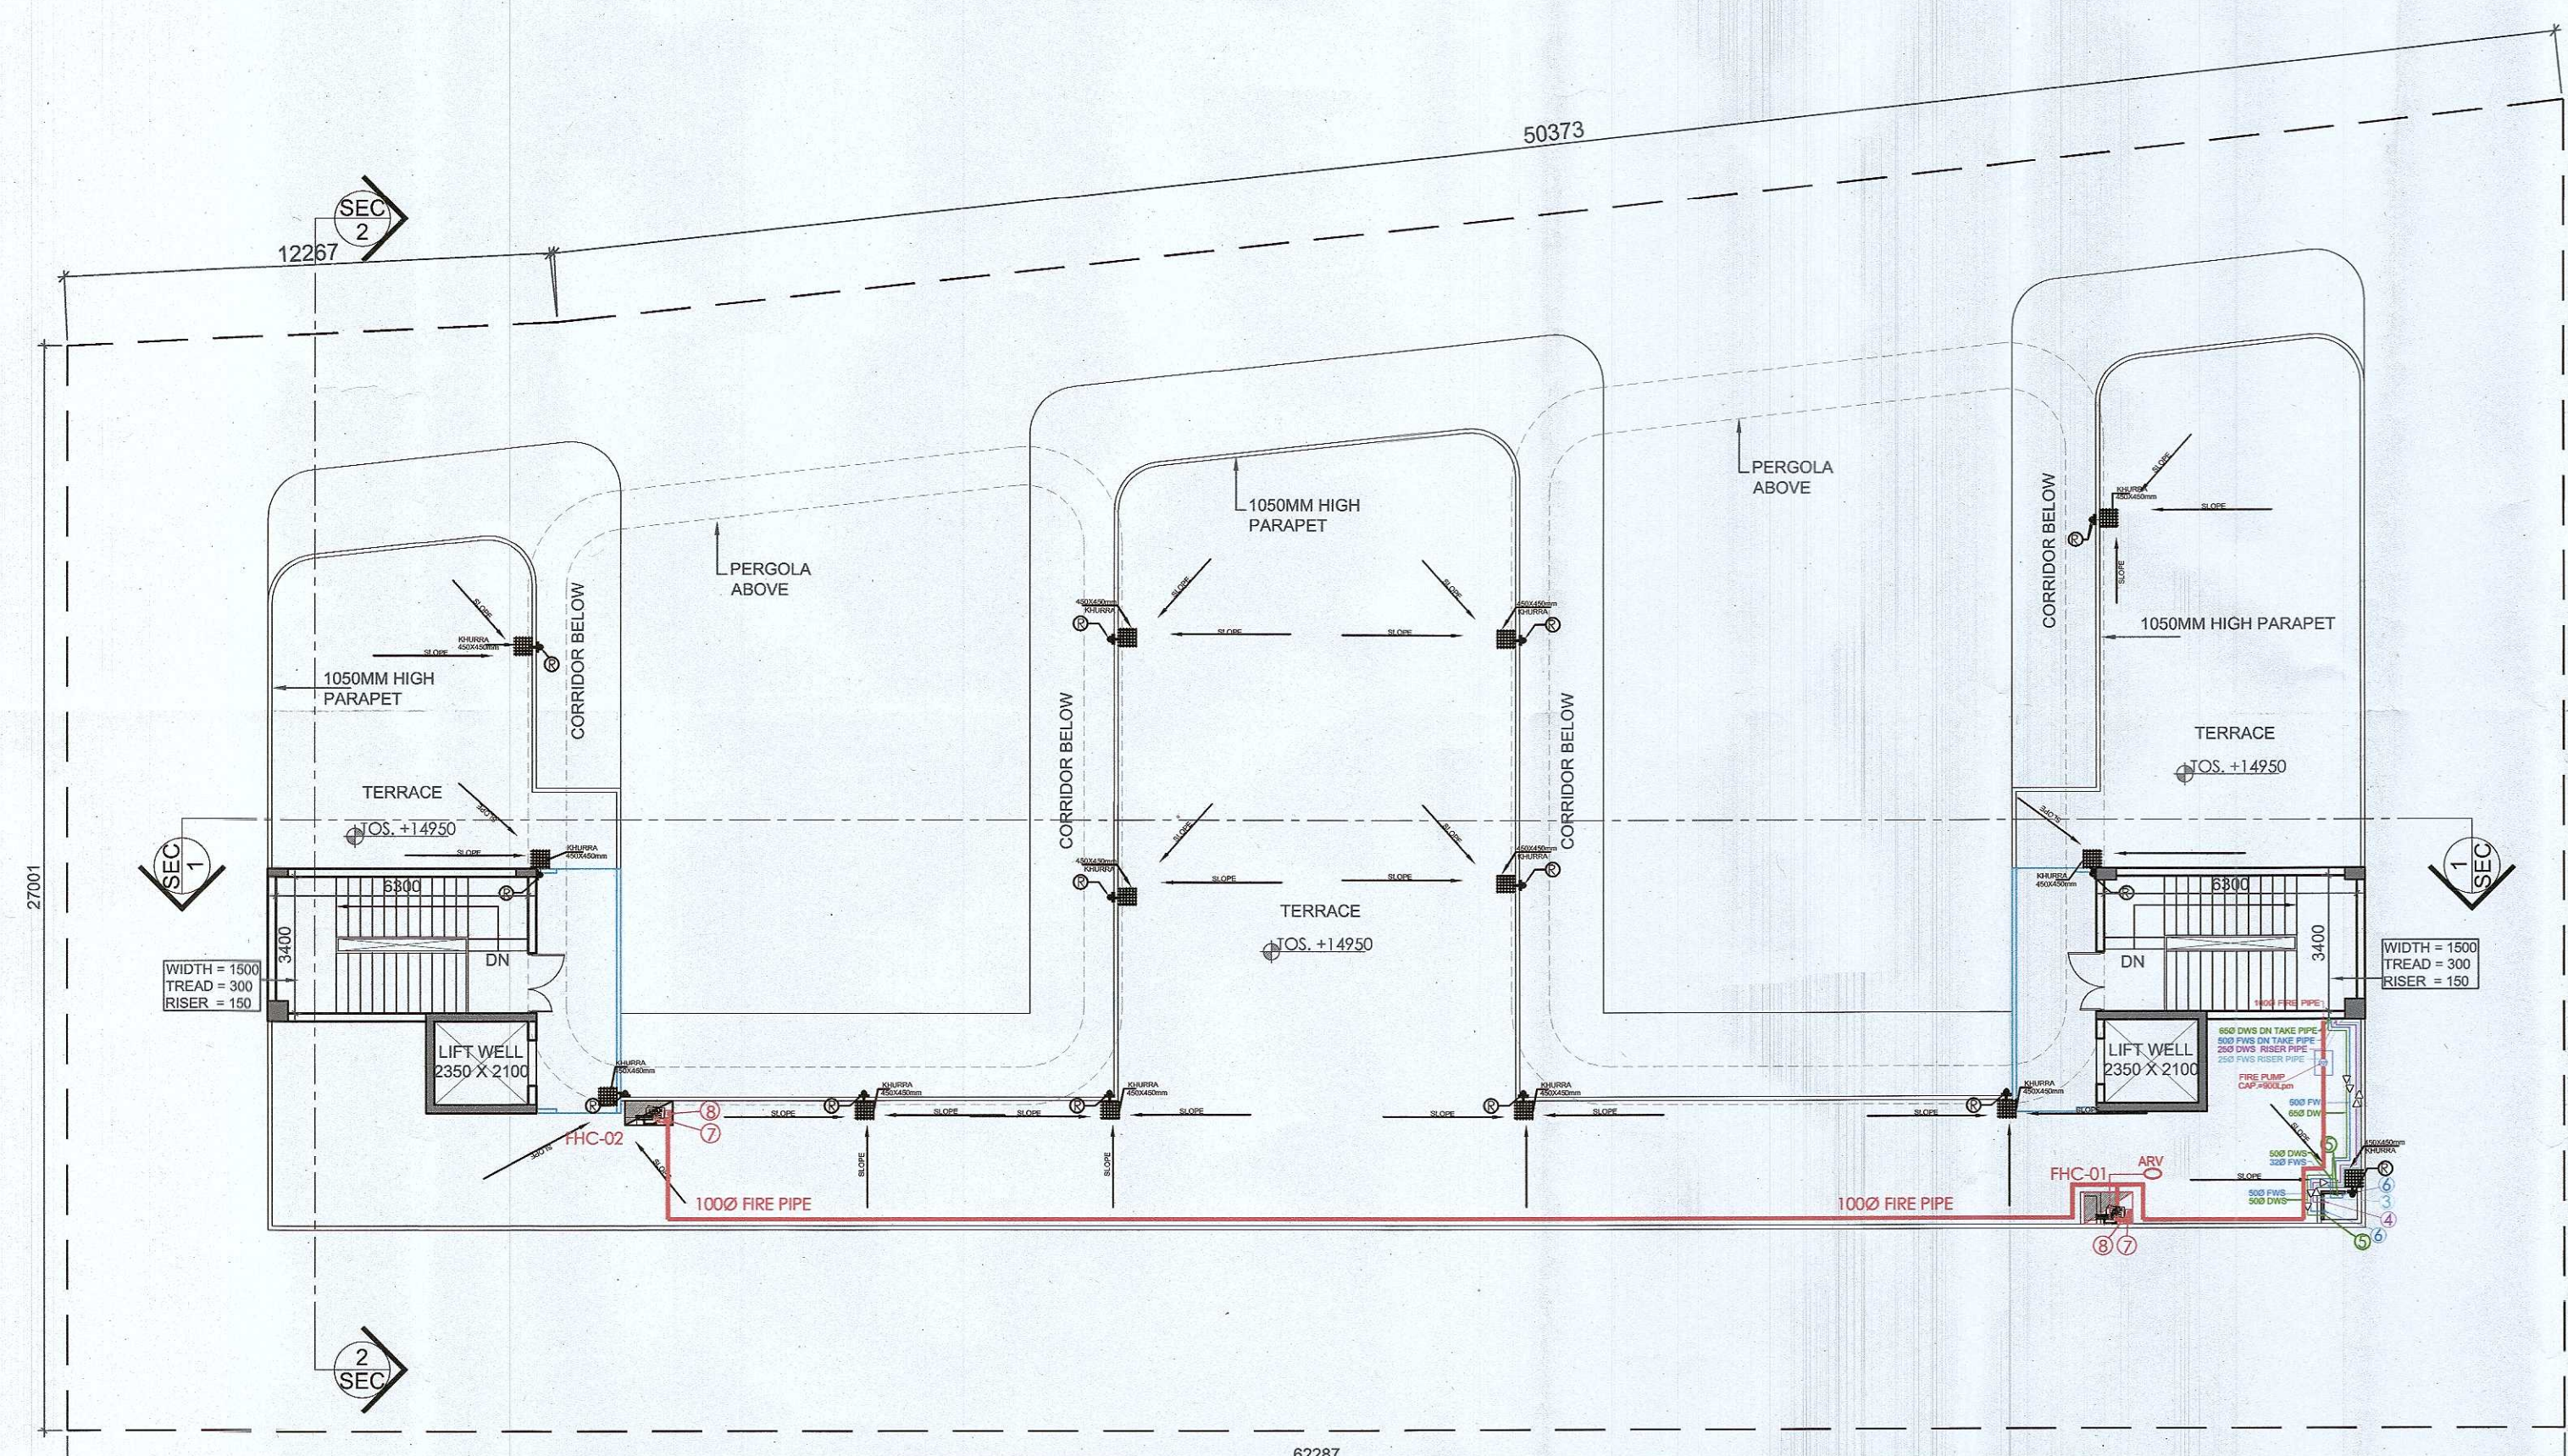

1 TERRACE PLAN
SCALE 1:100

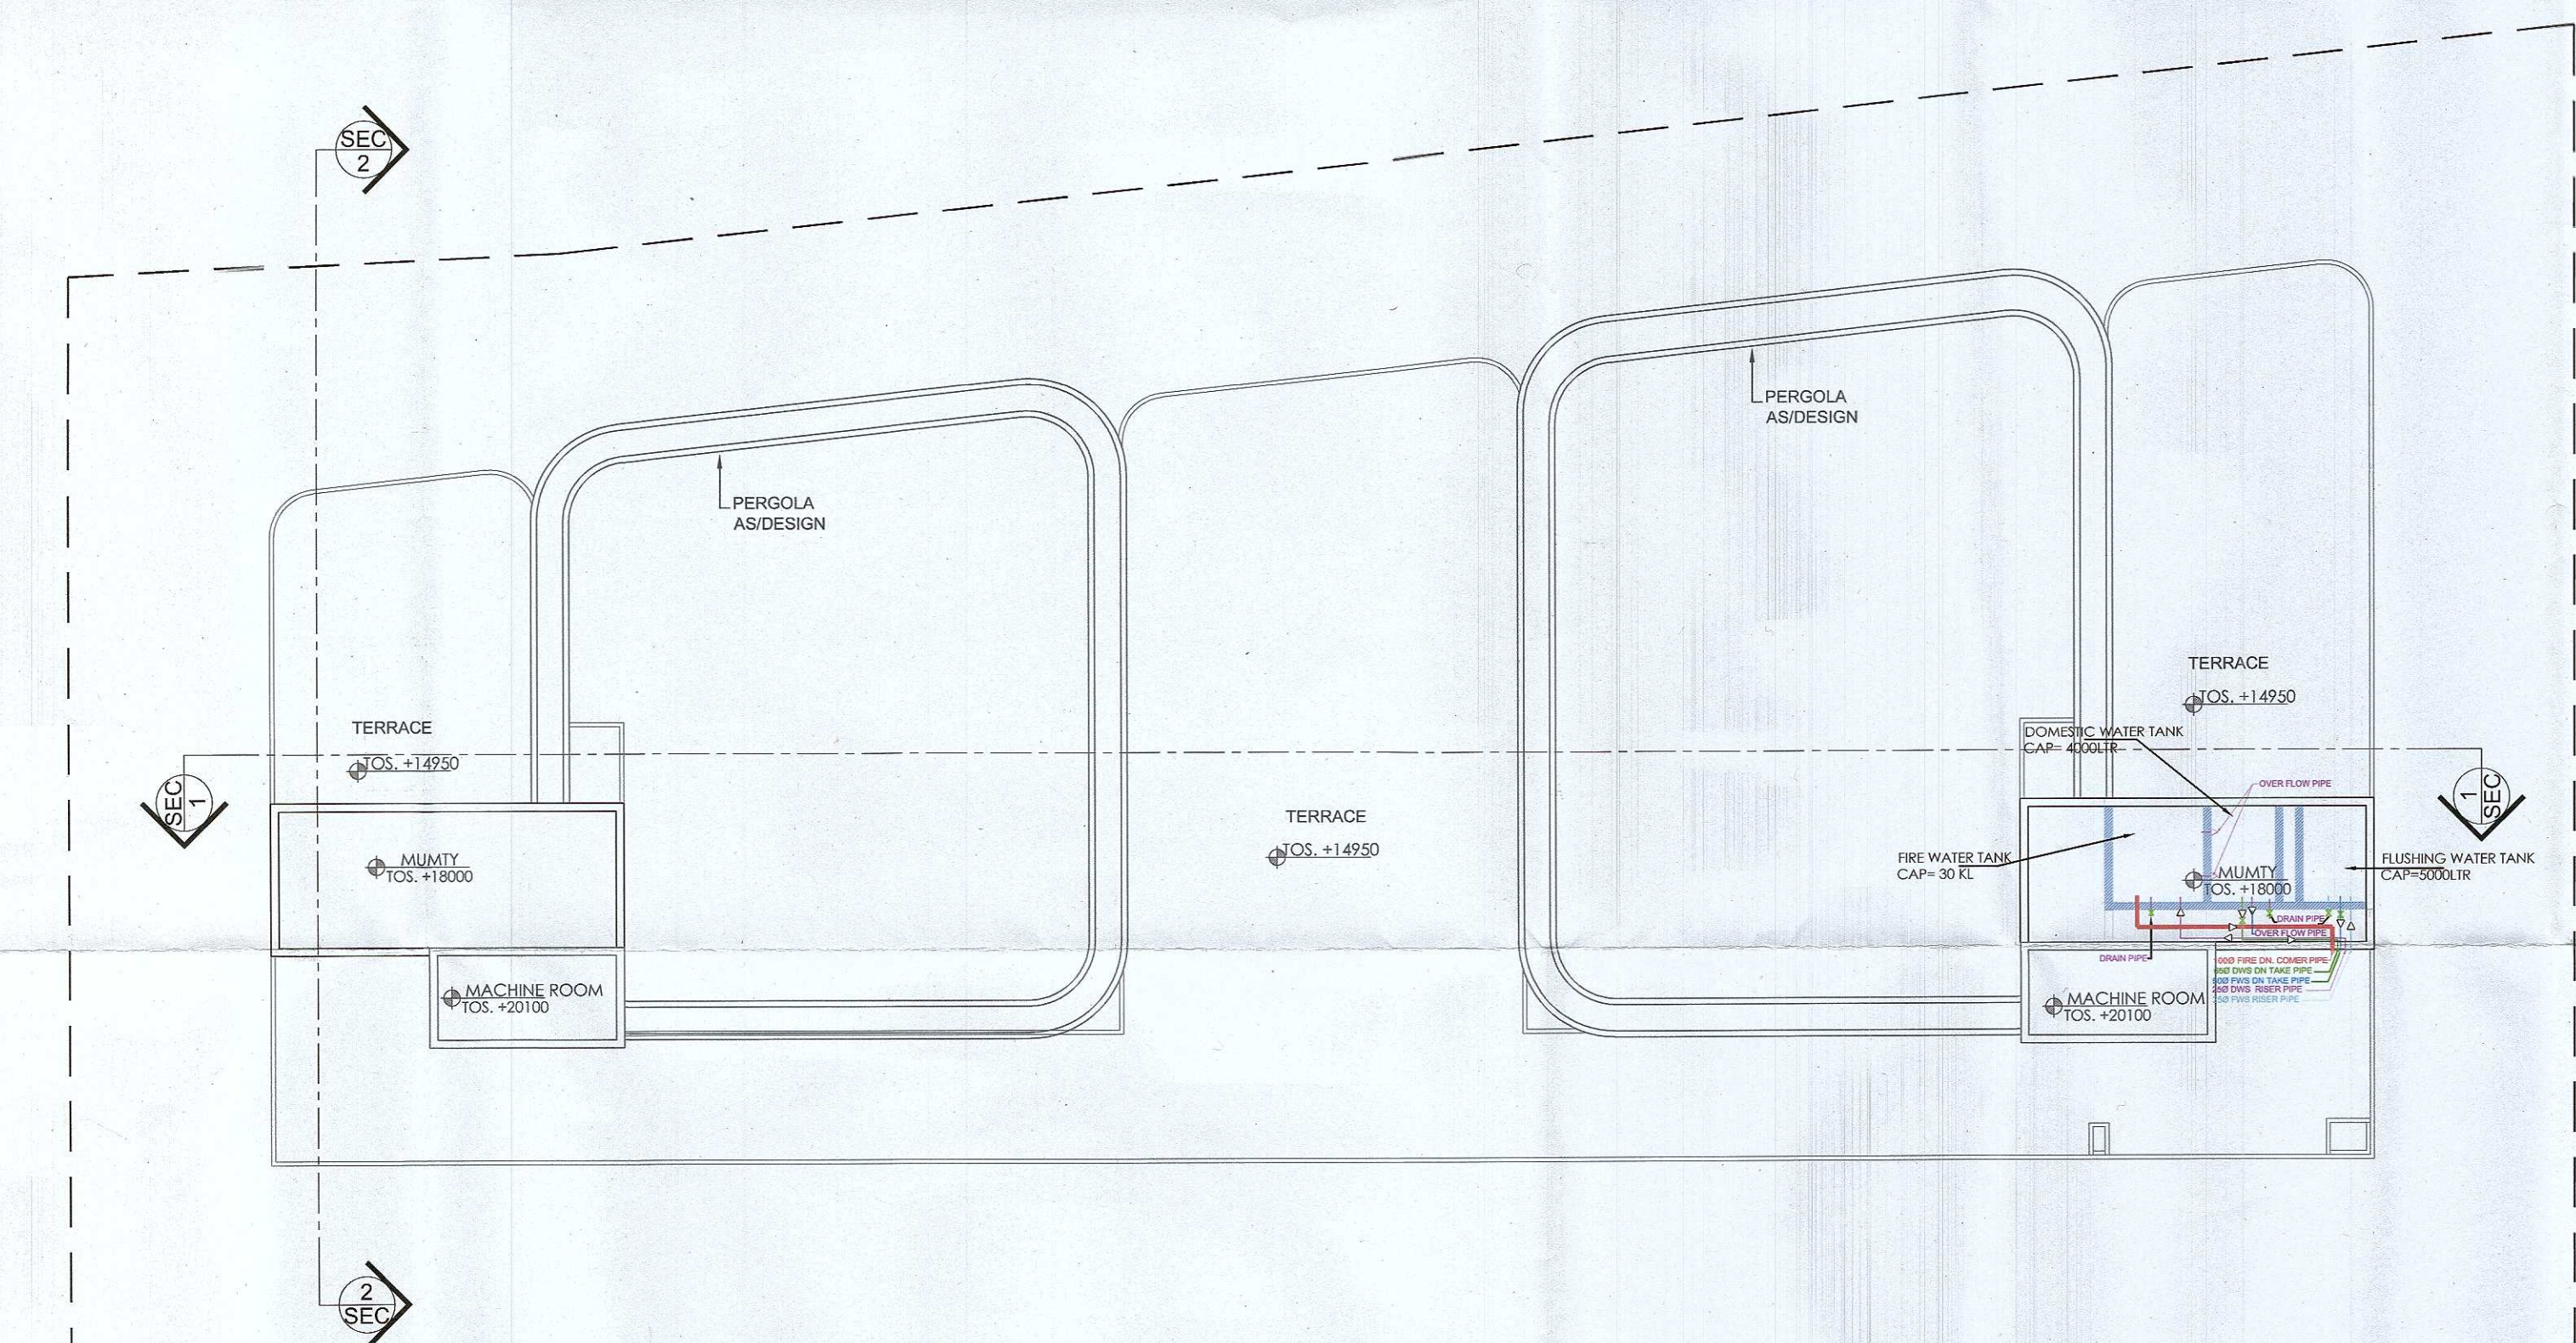

2 MUMTY/MACHINE ROOM PLAN
SCALE 1:100


FIRE LEGEND	
4.5KG CO2 TYPE FIRE EXTINGUISHER	
6.KG ABC TYPE FIRE EXTINGUISHER	
FIRE HOSE CABINET	

Sanctioned and Valid For 2 Years
Subject to Validity of Licence CLUE Extension Permission
Chairperson
Building Plan Committee Controlled Area
Gurgaon Circle, Gurgaon

TOILET INTERNAL DETAIL	
SYMBOL	ABBREVIATION
Ⓐ	1000 SOIL PIPE
Ⓐ	400 SOIL PIPE
Ⓑ	1000 WASTE PIPE
Ⓑ	400 WASTE PIPE
Ⓒ	500 WASTE PIPE
FT	FLOOR DRAIN
FD	FLOOR TRAP
COP	CLEAN OUT PLUG
Ⓔ	150X150mm CUTOUT

S.D.
P.A.
A.T.P.

SHAFT PIPE DETAIL		
SYMBOL	ABBREVIATION	DESCRIPTION
Ⓐ	SP	1000 SOIL PIPE
Ⓑ	WP	1000 WASTE PIPE
Ⓒ	FWS	FLUSHING WATER RISER
Ⓓ	CWS	COLD WATER RISER
Ⓔ	CWS	COLD WATER SUPPLY DROP
Ⓕ	FWS	FLUSHING WATER SUPPLY DROP
Ⓖ	RWP	1000 RAIN WATER PIPE
Ⓗ		1000 FIRE DN.COMER PIPE
Ⓘ		800 DRAIN PIPE

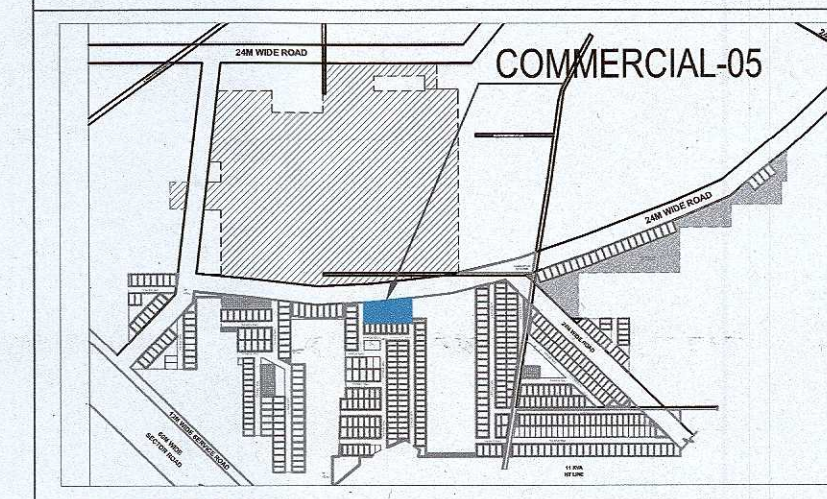

3 KEY PLAN
SCALE 1:5

DOORS & WINDOWS OPENING SCHEDULE						
S.NO.	TYPE	ROUGH OPENING (IN MM)				LOCATIONS
		WIDTH	HEIGHT	SILL LVL	LINTEL LVL	
1	D1	900	2100	+00	+2100	TOILET
2	D2	1900	2400	+00	+2400	STAIRCASE
3	D3	1200	2100	+00	+2100	TOILET
4	V1	1500	600	+1500	+2100	TOILET
5	V2	600	600	+1500	+2100	TOILET
6	GL1	2100	2400	+300	+2400	SHOP
7	GL2	1975	2400	+00	+2400	SHOP
8	GL3	2865	2400	+00	+2400	SHOP
9	GL4	6300	2400	+00	+2400	SHOP
10	GL5	2400	2400	+00	+2400	SHOP
11	GL6	3100	2400	+00	+2400	SHOP
12	GL7	2150	2400	+00	+2400	SHOP
13	GL8	2815	2400	+00	+2400	SHOP
14	GL9	2700+8845	2400	+00	+2400	SHOP
15	GL10	10900	2400	+00	+2400	SHOP
16	GL11	9075	2400	+00	+2400	SHOP
17	GL12	8445	2400	+00	+2400	SHOP
18	GL13	1700	2400	+00	+2400	SHOP
19	GL14	2600	2400	+00	+2400	SHOP
20	GL15	3600	2400	+00	+2400	SHOP
21	GL16	9235	2400	+00	+2400	SHOP
22	GL17	11785	2400	+00	+2400	SHOP
23	GL18	2630+4745	2400	+00	+2400	SHOP
24	GL19	10410	2400	+00	+2400	SHOP
25	GL20	4365	2400	+00	+2400	SHOP
26	GL21	4150	2400	+00	+2400	SHOP
27	GL22	5935	2400	+00	+2400	SHOP
28	GL23	5465	2400	+00	+2400	SHOP
29	GL24	2830+8845	2400	+00	+2400	SHOP
30	GL25	2400	2400	+00	+2400	SHOP
31	GL26	10185	2400	+00	+2400	SHOP
32	GL27	5445+2130	2400	+00	+2400	SHOP
33	GL28	6275+2130	2400	+00	+2400	SHOP
34	GL29	2100	2400	+00	+2400	SHOP
35	GL30	1800	2400	+00	+2400	SHOP
36	GL31	13775	2400	+00	+2400	SHOP
37	GL32	4245	2400	+00	+2400	SHOP
38	GL33	5600	2400	+00	+2400	SHOP
39	GL34	4000	2400	+00	+2400	SHOP
40	GL35	5300	2400	+00	+2400	SHOP

NOTE: ALL LEVELS ARE FROM FFL

SUBMISSION DRAWING

CLIENT
LOON LAND DEVELOPMENT LTD.

PROJECT
LAYOUT PLAN OF PROPOSED RESIDENTIAL
PLOTTED COLONY UNDER DEEN DAYAL JAN AWAS
YOUNA SCHEME-2016 IN SECTOR-79-79b,
GURUGRAM
(HR.) LAND MEASURING 45.822 ACRES. BEING
DEVELOPED BY LOON LAND DEVELOPMENT LTD.

ARCHITECTS
Confluence

B-421, NEW FRIENDS Ph: +91-11-46130900 ccs@inconfluence.com Member of IGBIC
COLONY N.D-65 INDIA Ph: +91-11-46564768 www.inconfluence.com ISO - 9001: 2000
architecture urban design hospitality interiors

PLUMBING CONSULTANT
KUMAR ENDECON PVT. LTD.

40/60, SECOND FLOOR, CR
PARK, NEW DELHI -110019

DRAWING NO. REVISION

DRAWING TITLE
COMMERCIAL PLOT (05)
FLOOR PLANS

OWNER SIGN ARCHITECT SIGN

