


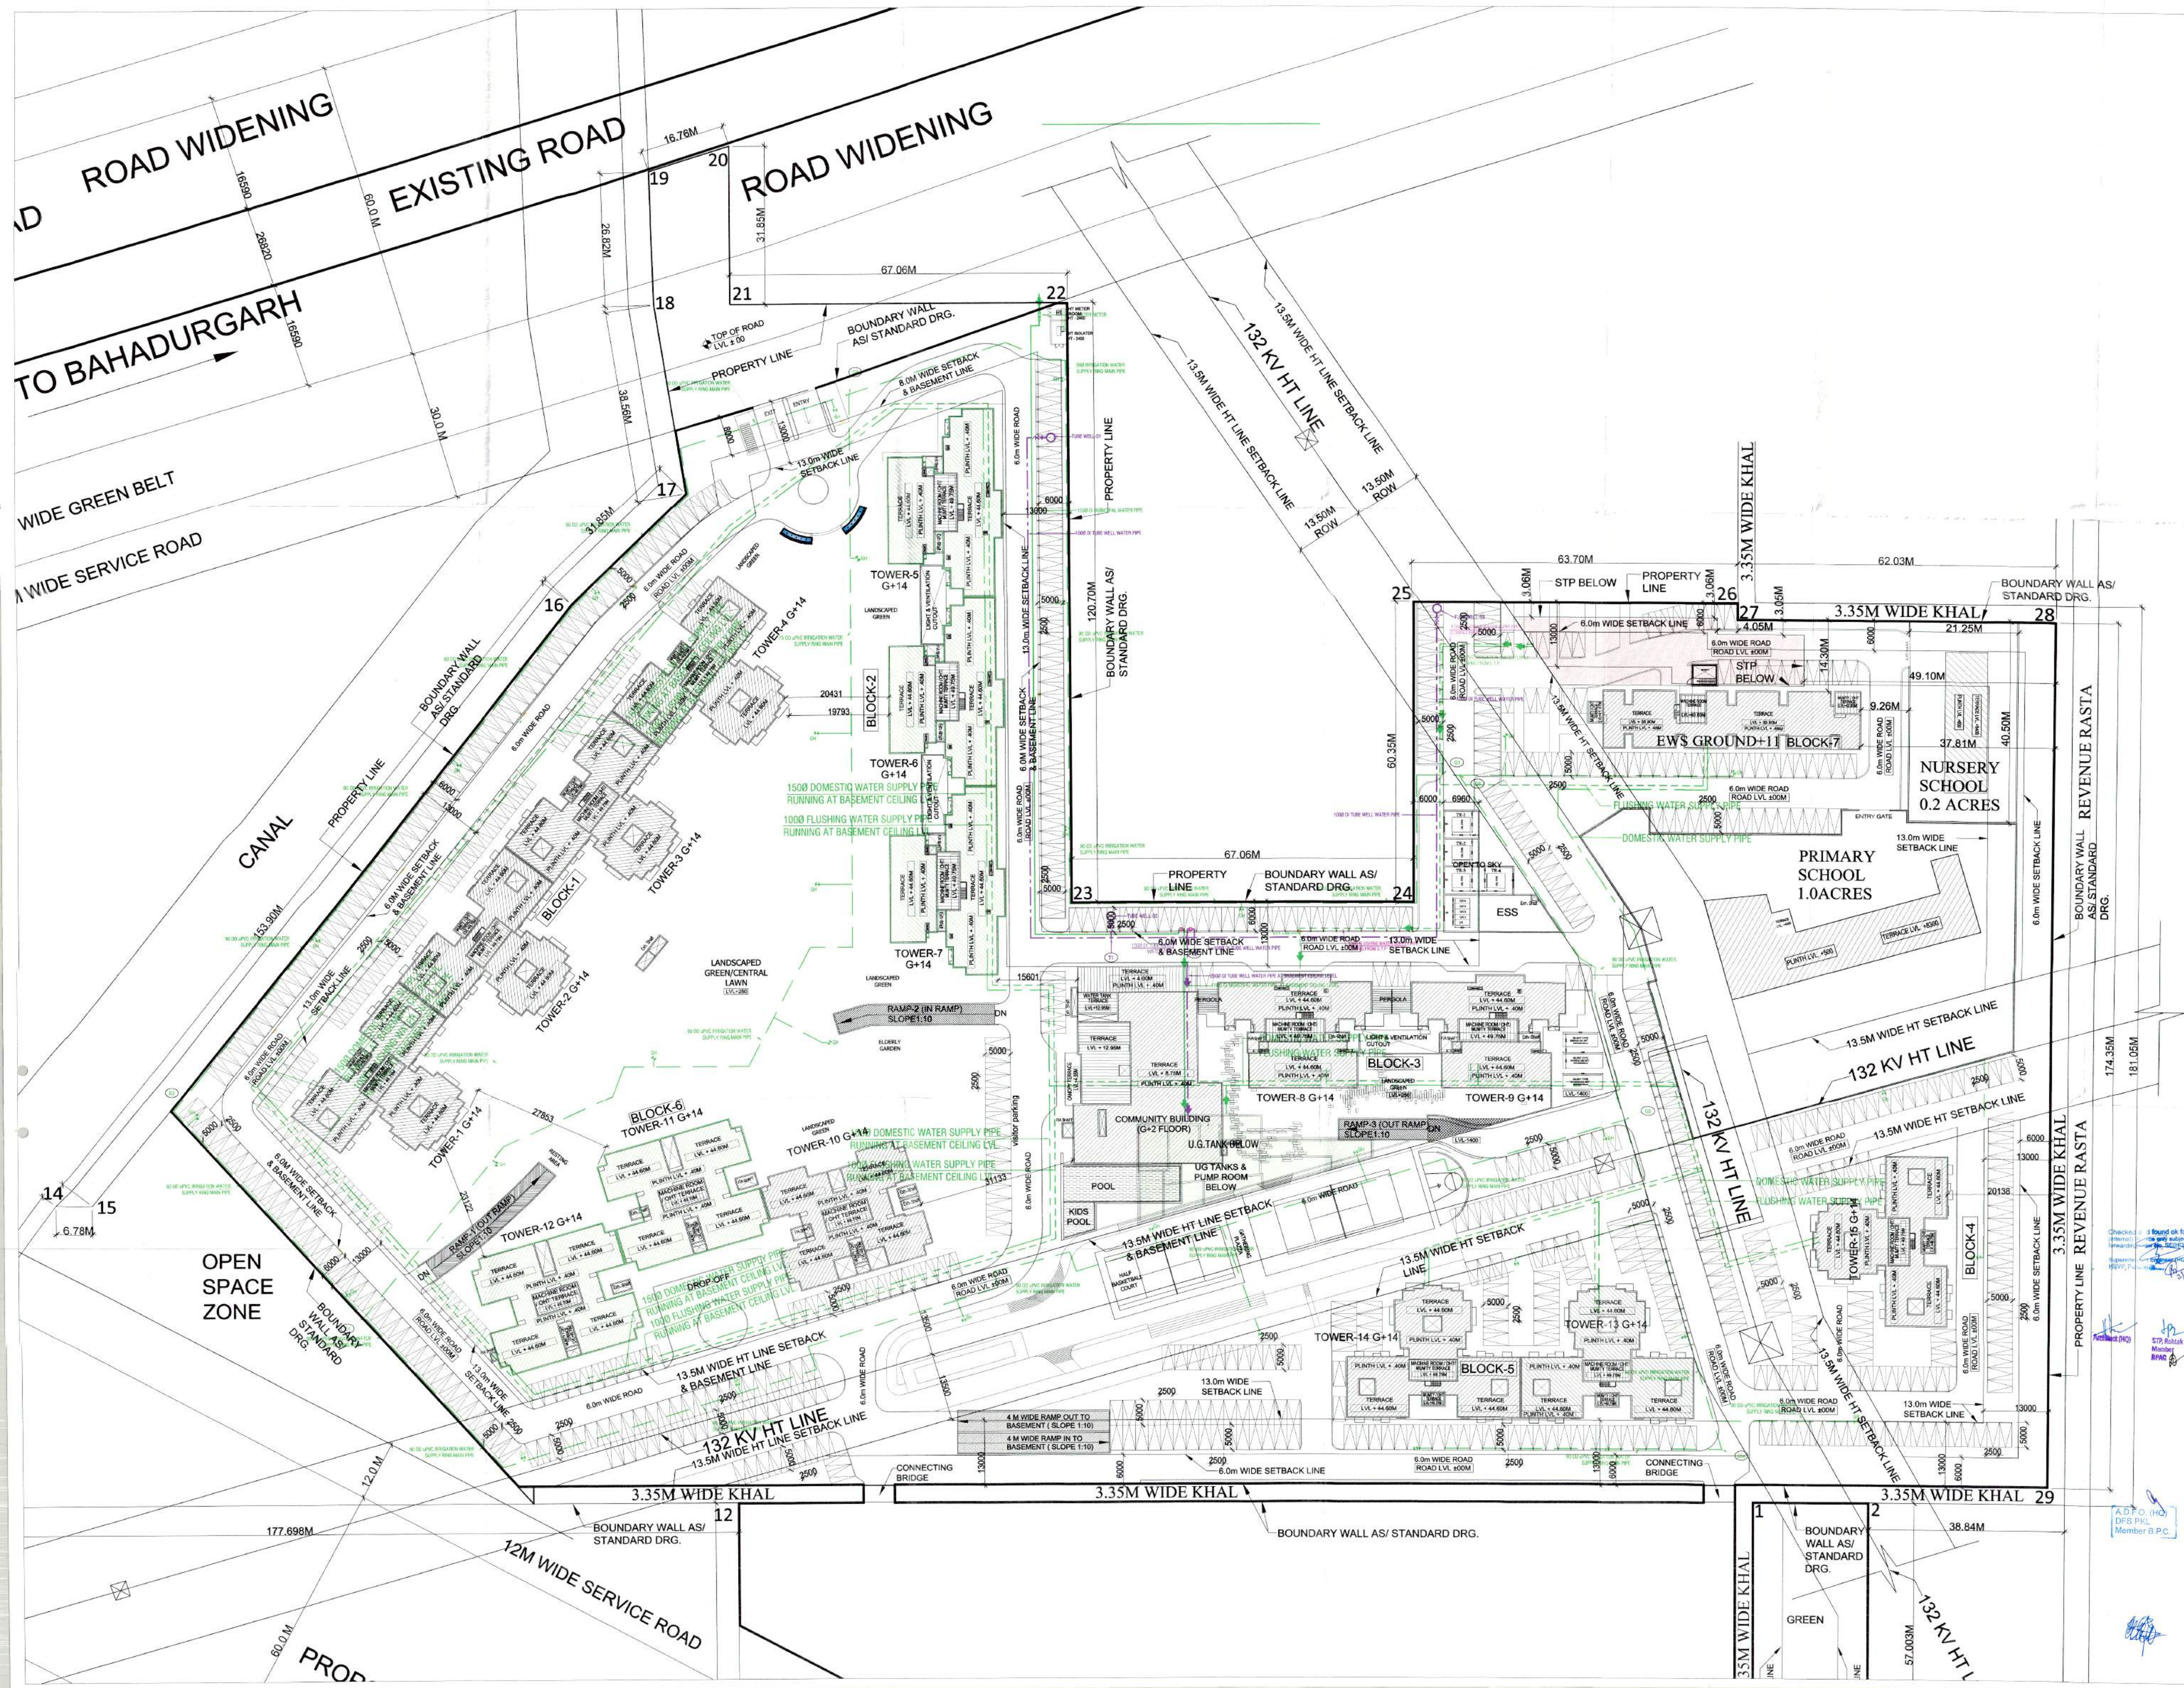

This drawing is a "COPYRIGHT" work of the drawing or part thereof may not be used or reproduced without the permission of the Architect.

NO. OF PRINTS	DATE	ISSUED TO	REMARKS

REVISION: DATE DESCRIPTION BY

GENERAL NOTES

- All dimensions are in mm unless mentioned otherwise.
- No dimensions are to be scaled from this drawing.

GENERAL NOTES

- FIRE SAFETY MEASURES**
a) The owner will ensure the provision of proper fire safety measures in the multi storied buildings conforming to the provisions of Rule 1965 NBC and the same should be got certified from the competent authority.
b) Electric Sub Station / generator room if provided should be on solid ground near DOLT. Control panel on ground floor or in upper basement and it should be located on outer periphery of the building. The same should be got approved from Chief Electrical Inspector Haryana.
- SOLAR WATER HEATING SYSTEM**
The provision of solar water heating system shall be as per norms specified by HAREDA and shall be made operational in each building block before applying for an occupation certificate.
- RAIN WATER HARVESTING SYSTEM**
The rain water harvesting system shall be provided as per Central Ground Water Authority norms/Haryana Govt. notification as applicable.

LEGEND:

- TUBE WELL LINE
- MUNICIPAL WATER SUPPLY LINE
- DOMESTIC WATER SUPPLY
- FLUSHING WATER SUPPLY LINE
- GARDEN IRRIGATION SUPPLY LINE
- GARDEN HYDRANT
- VALVE CHAMBER (450X600)MM

KEY PLAN

REVISED SUBMISSION DRAWINGS

PROJECT: REVISED BUILDING PLANS FOR GROUP HOUSING COLONY MEASURING 21.7025 Acres/LICENCE No. 60 of 2014 dated 30/06/2014 for 16.43125 Acres & LICENSE No. 120 of 2014 dated 22/08/2014 for 5.278 Acres) IN SECTOR-37, BAHADURGARH BEING DEVELOPED BY HLT RESIDENCY PVT. LTD. AND OTHERS IN COLLABORATION WITH HLT PROMOTERS PVT. LTD.

CHECKED BY	APPROVED BY
DEEPAK	S.A. SHARMA

SCALE: 1:500

DRAWING TITLE: SITE PLAN - FIRE & GARDEN IRRIGATION LAYOUT PLAN

FOR HLT PROMOTERS PVT. LTD.

ARCHITECTS: C. P. KURREJA ARCHITECTS
ASHIRWAD BUILDING,
D-1 GREEN PARK,
NEW DELHI - 110016
PHONE: 011-26863953 FAX: 011-26865770
E-MAIL: cpk@cpkarchitects.com

STRUCTURAL CONSULTANTS: TPO TECHNICAL PROJECTS CONSULTANTS (P) LTD.
W-9-B-7A SECTOR 37, NOIDA
UTTAR PRADESH-201301 (INDIA)
BOARD NO: 91-120-420080

MEP SERVICES CONSULTANTS: PARADISE CONSULTANTS
Plot No. 103, Basement,
Near Living Style Mall, Jasola Vihar
New Delhi - 110025
Phone: 011-26453216
E-mail: paradiseconsultants@gmail.com
website: www.paradisecommunity.com

DRAWING NO: 14007TH/REVISED/ST/ST/PLANS/SP04
CAD NO:

DRG NO: 4/35