




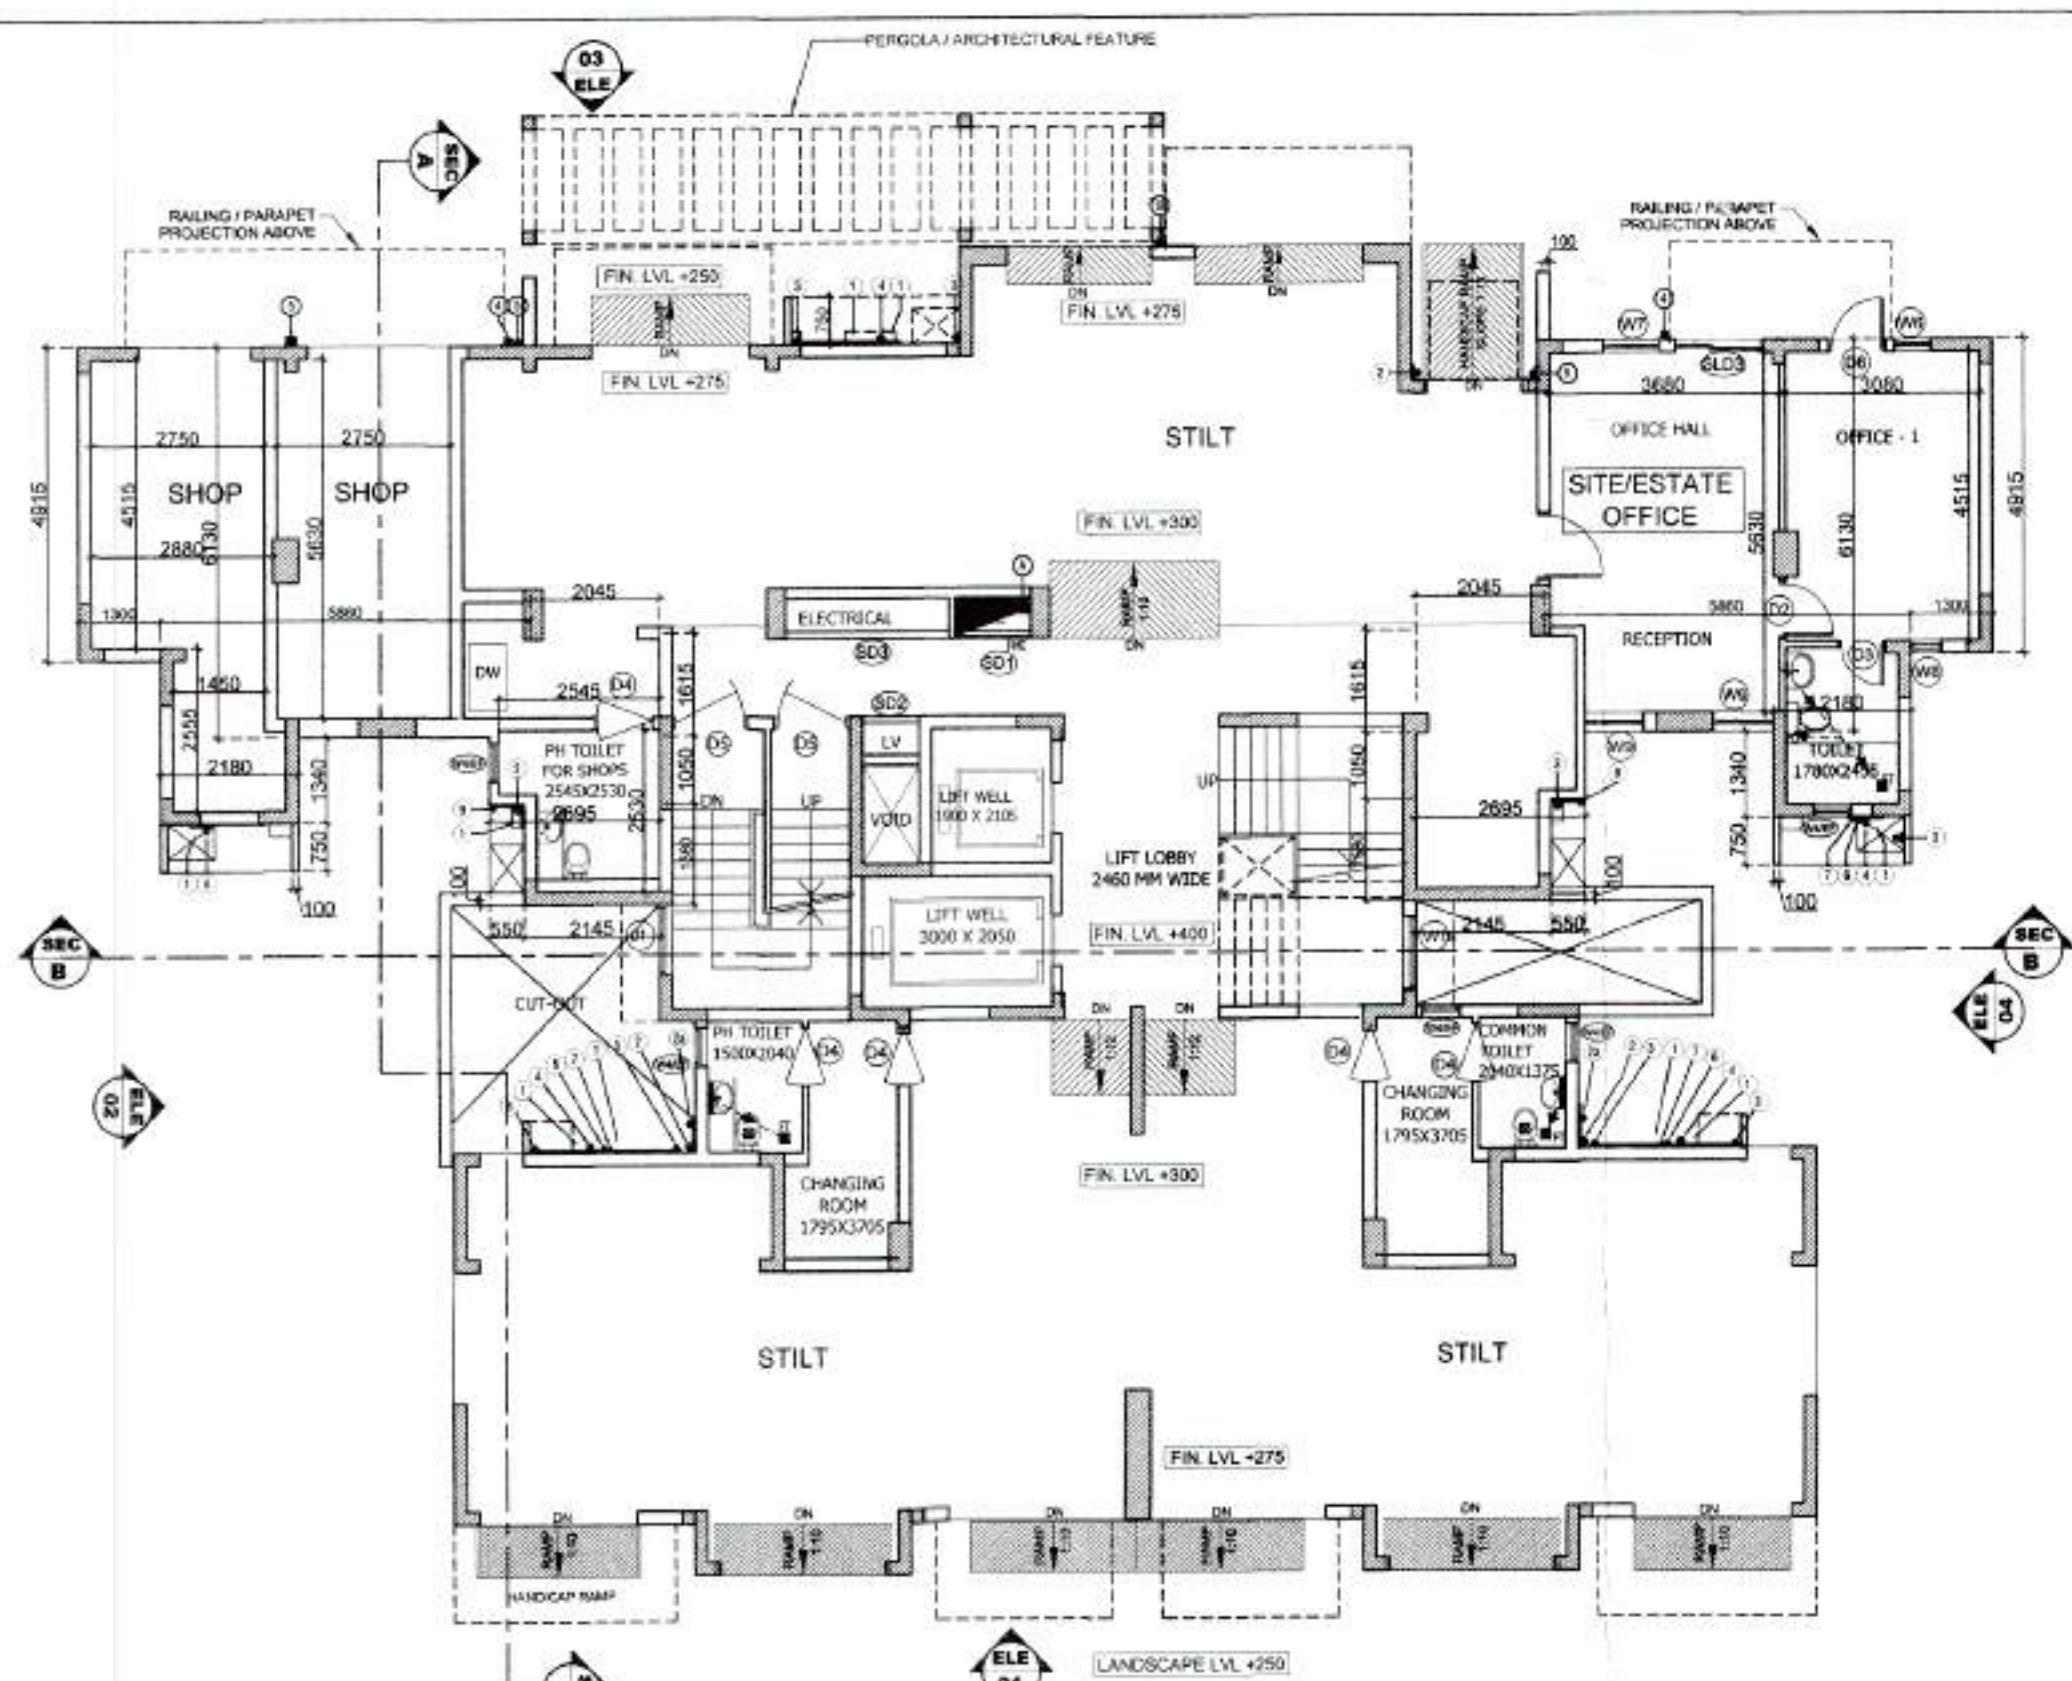


STILT/ GROUND FLOOR PLAN
(For Tower T-8)

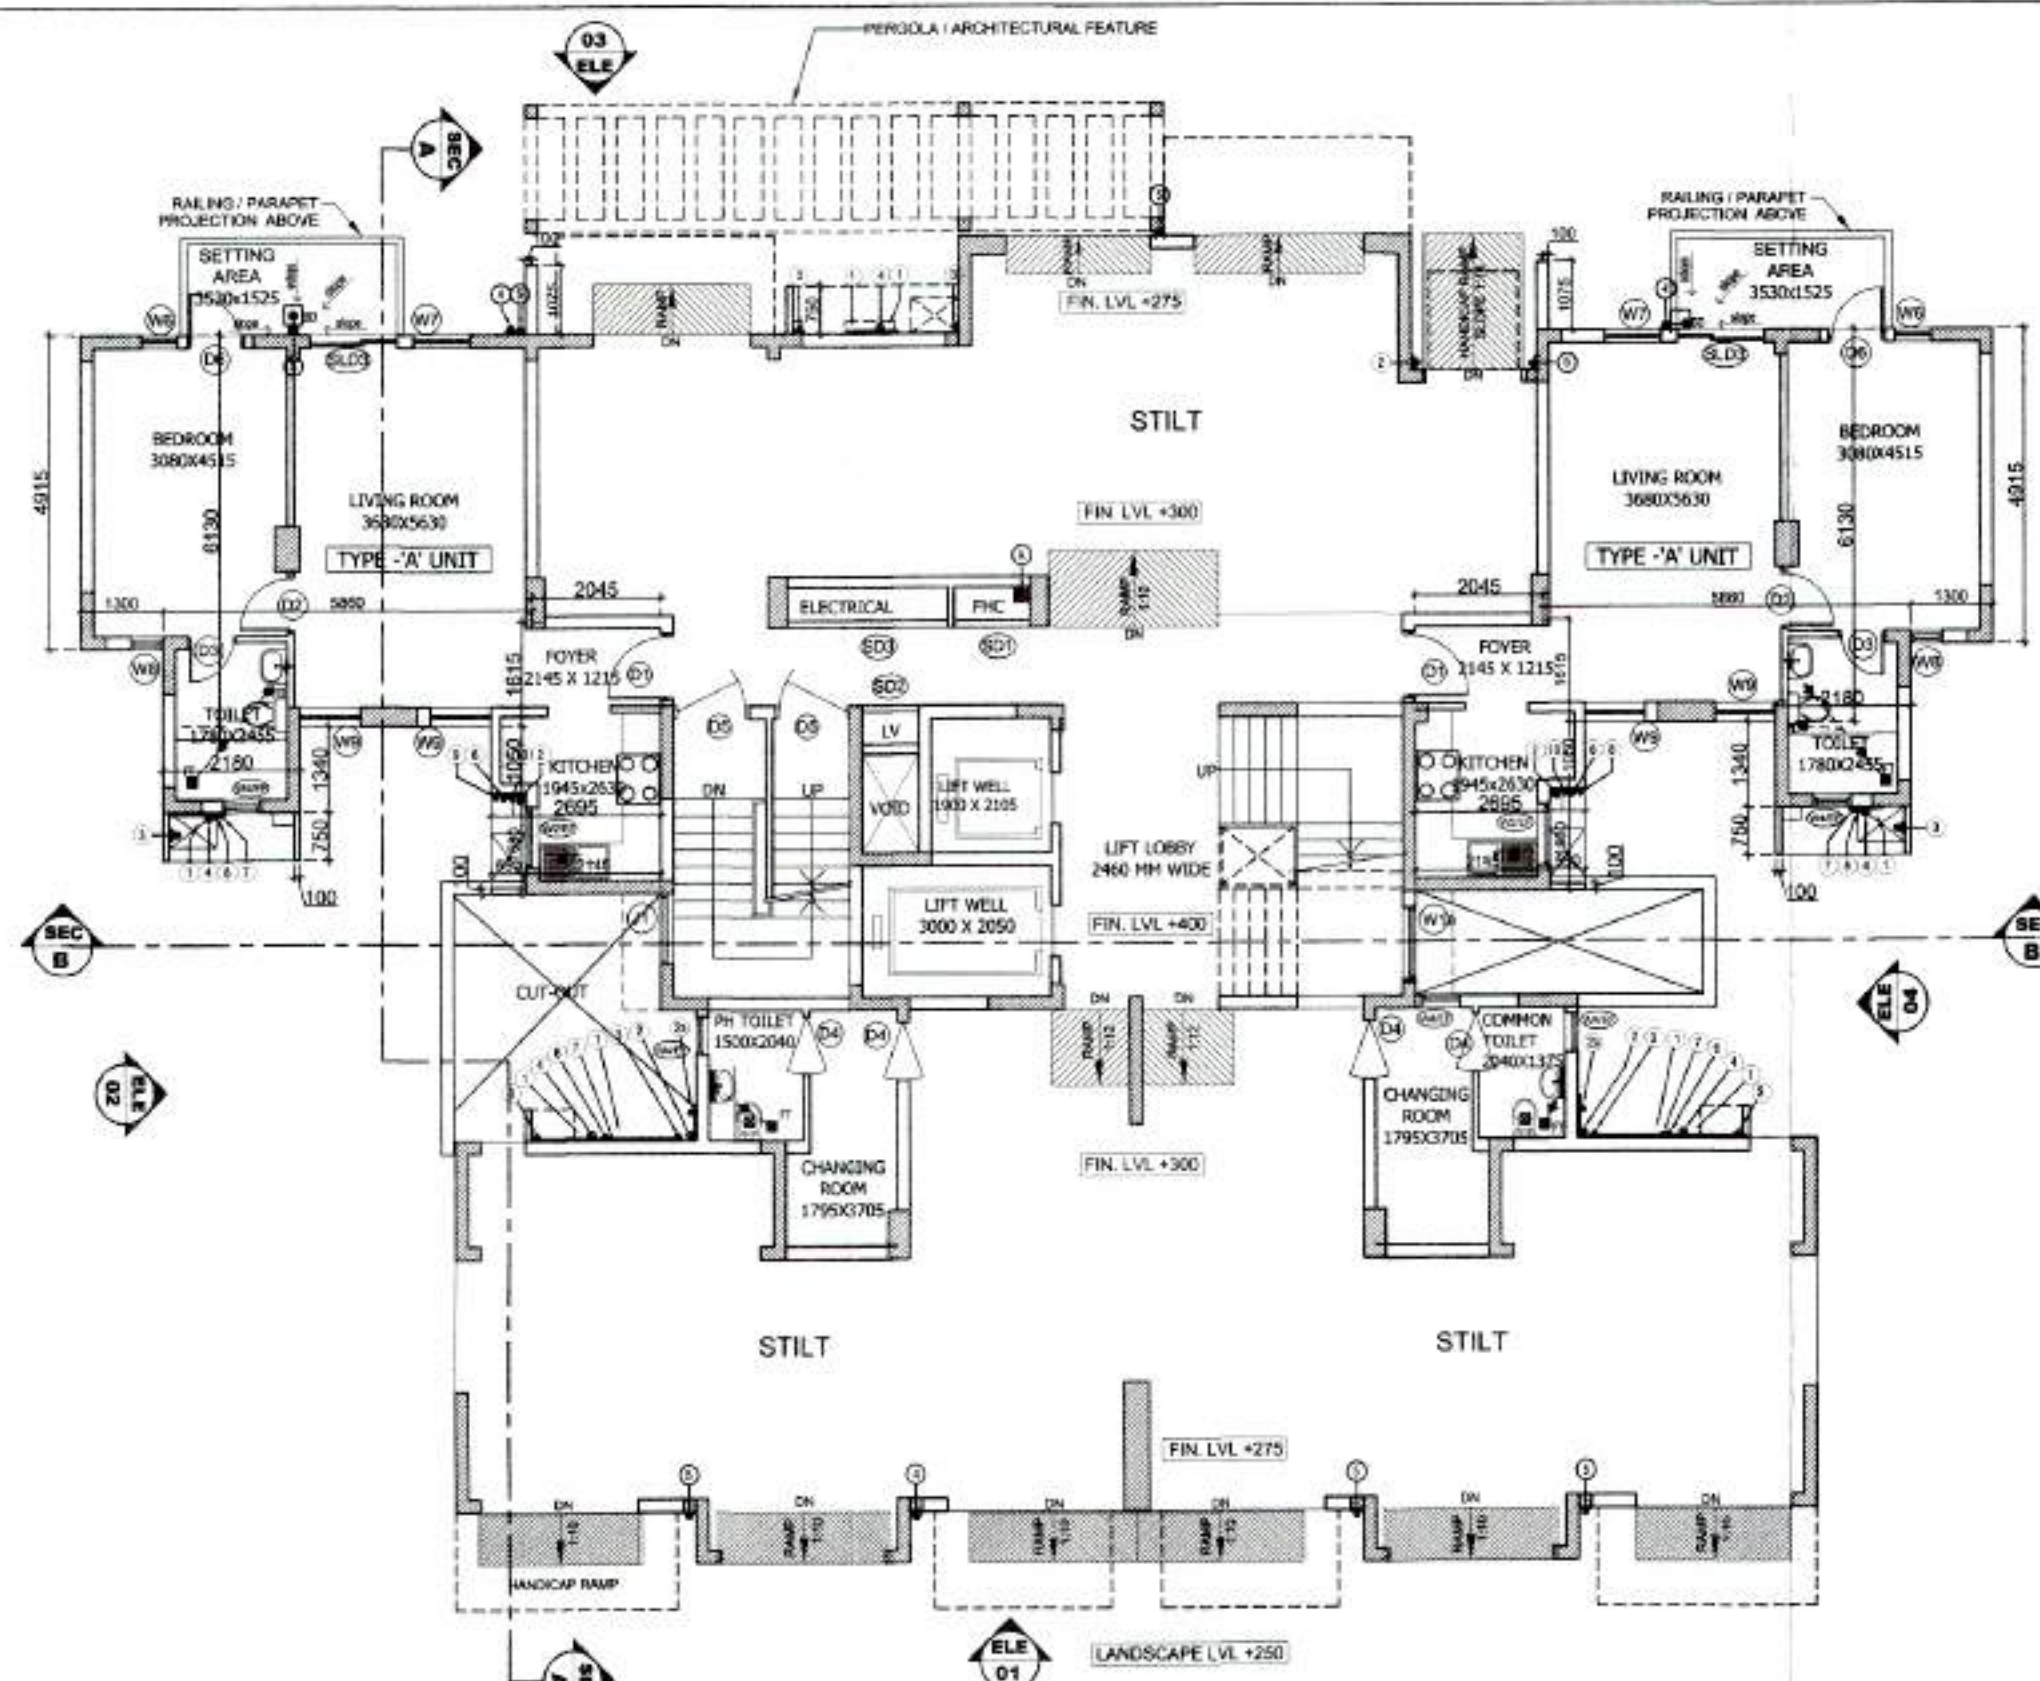

STILT/ GROUND FLOOR PLAN
(For Tower T-9)

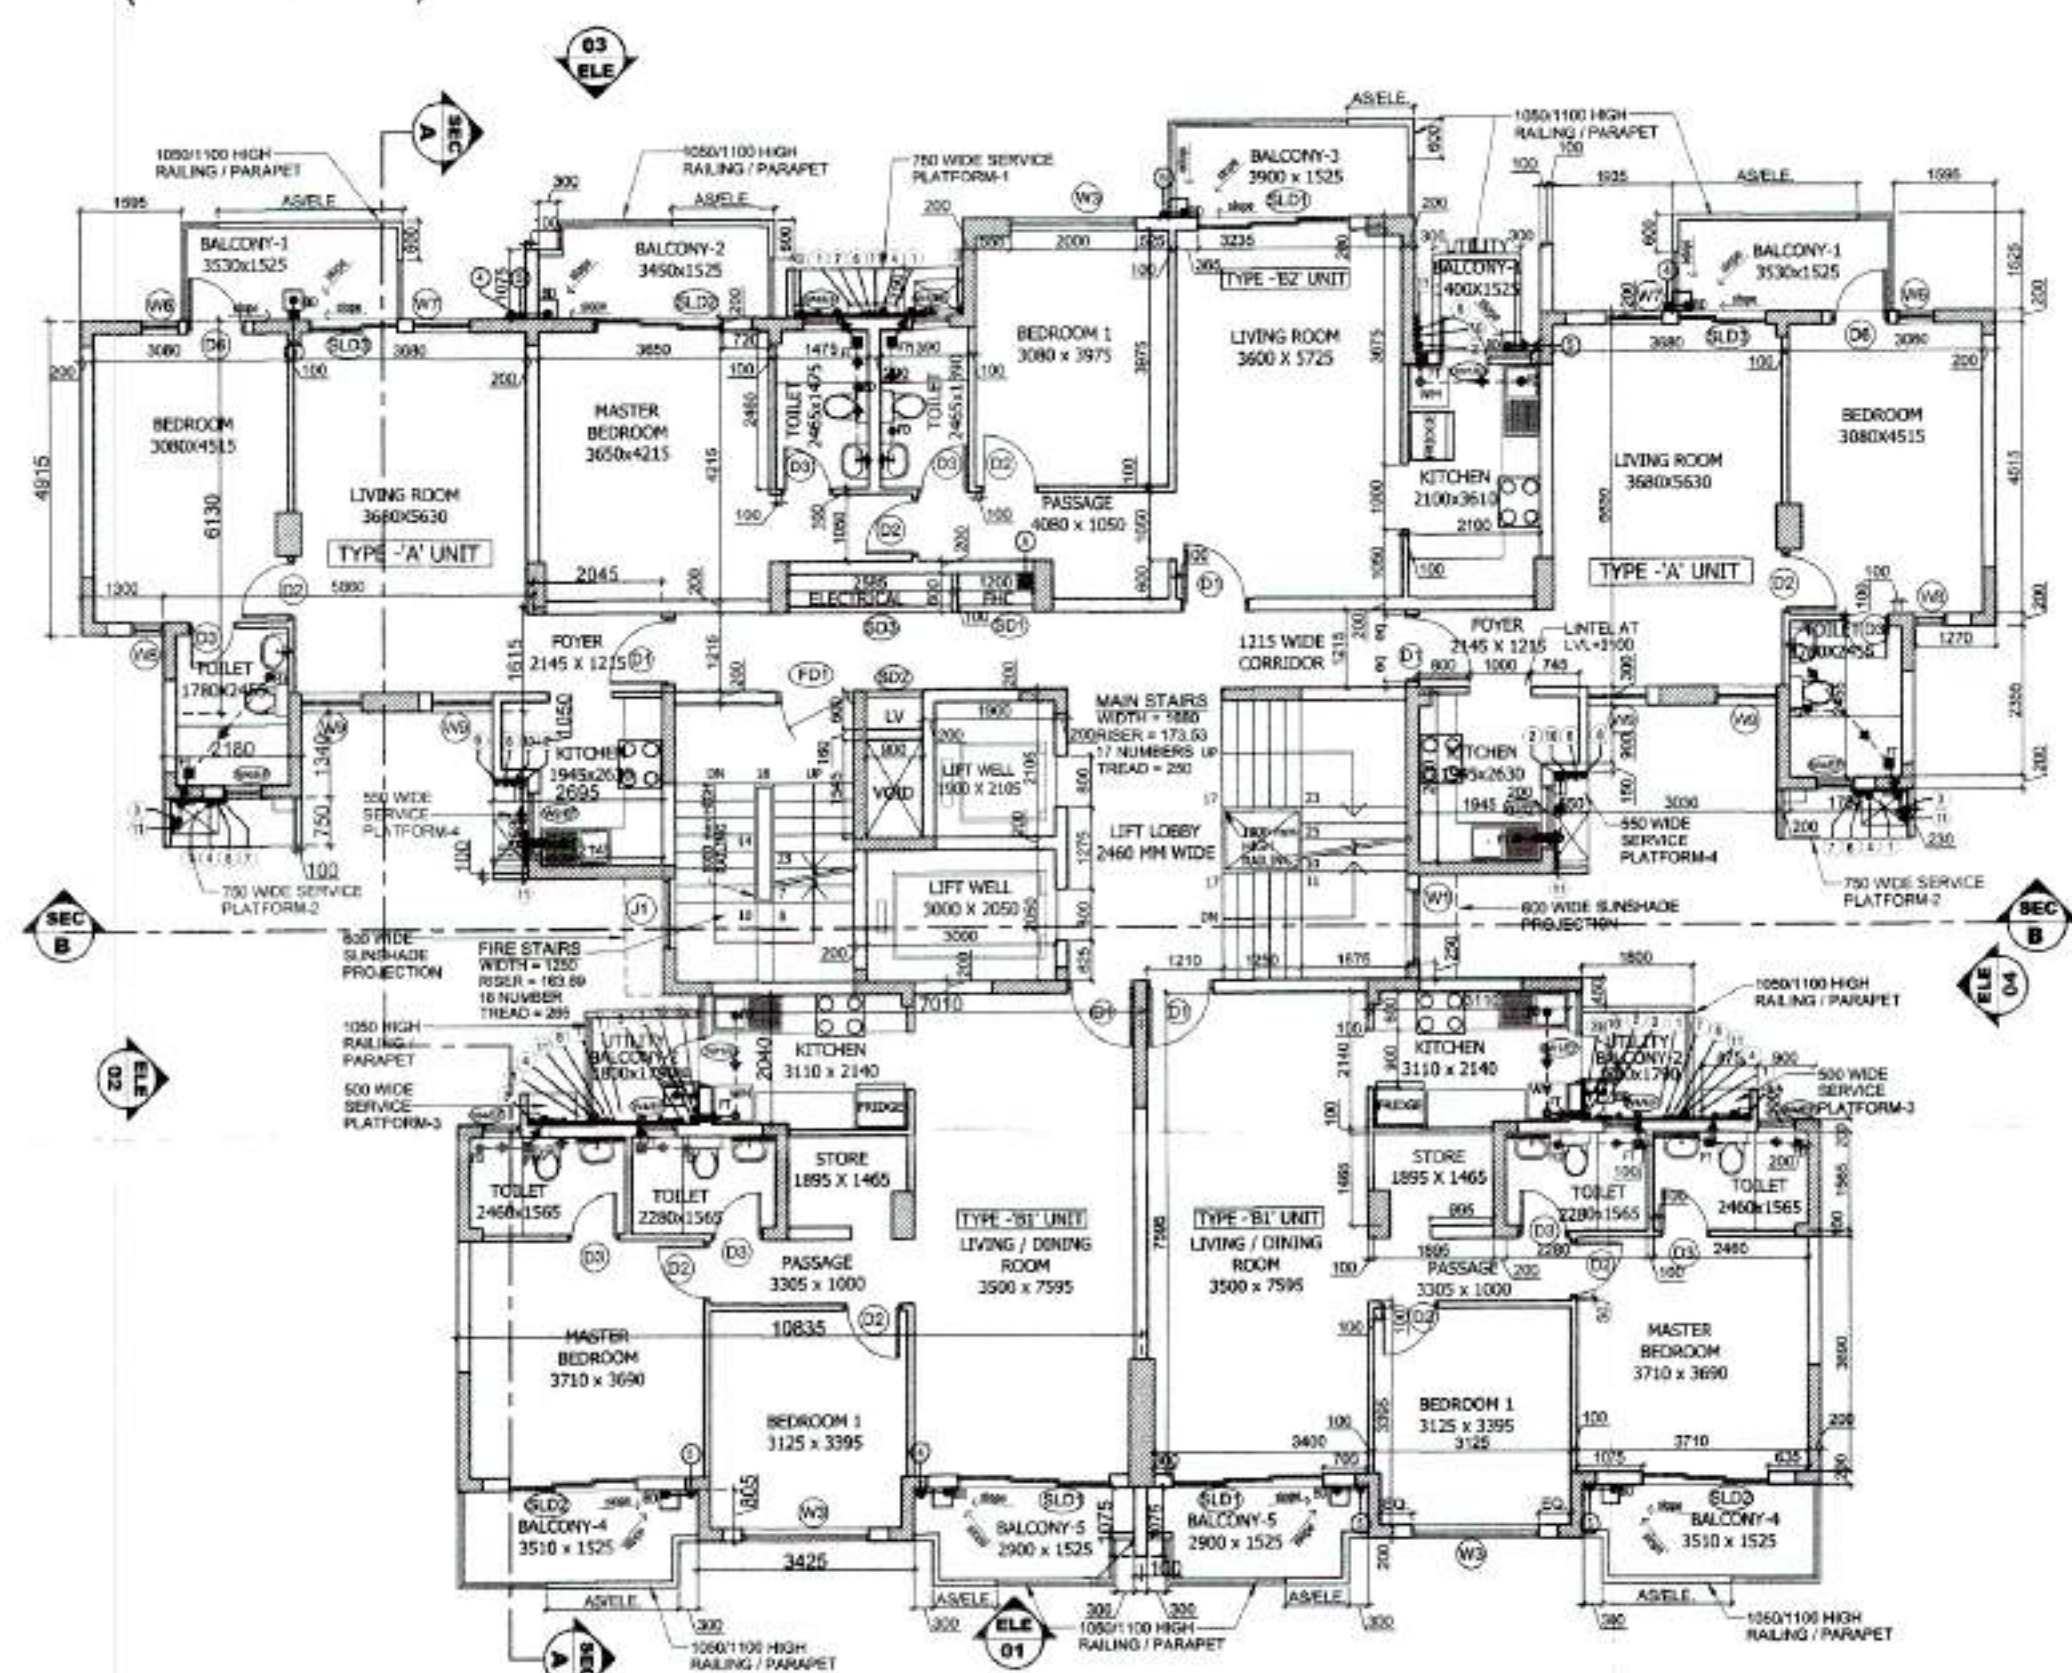

TYPICAL FLOOR PLAN (1ST TO 14TH FLOORS)
(For Towers T-8 & T-9)

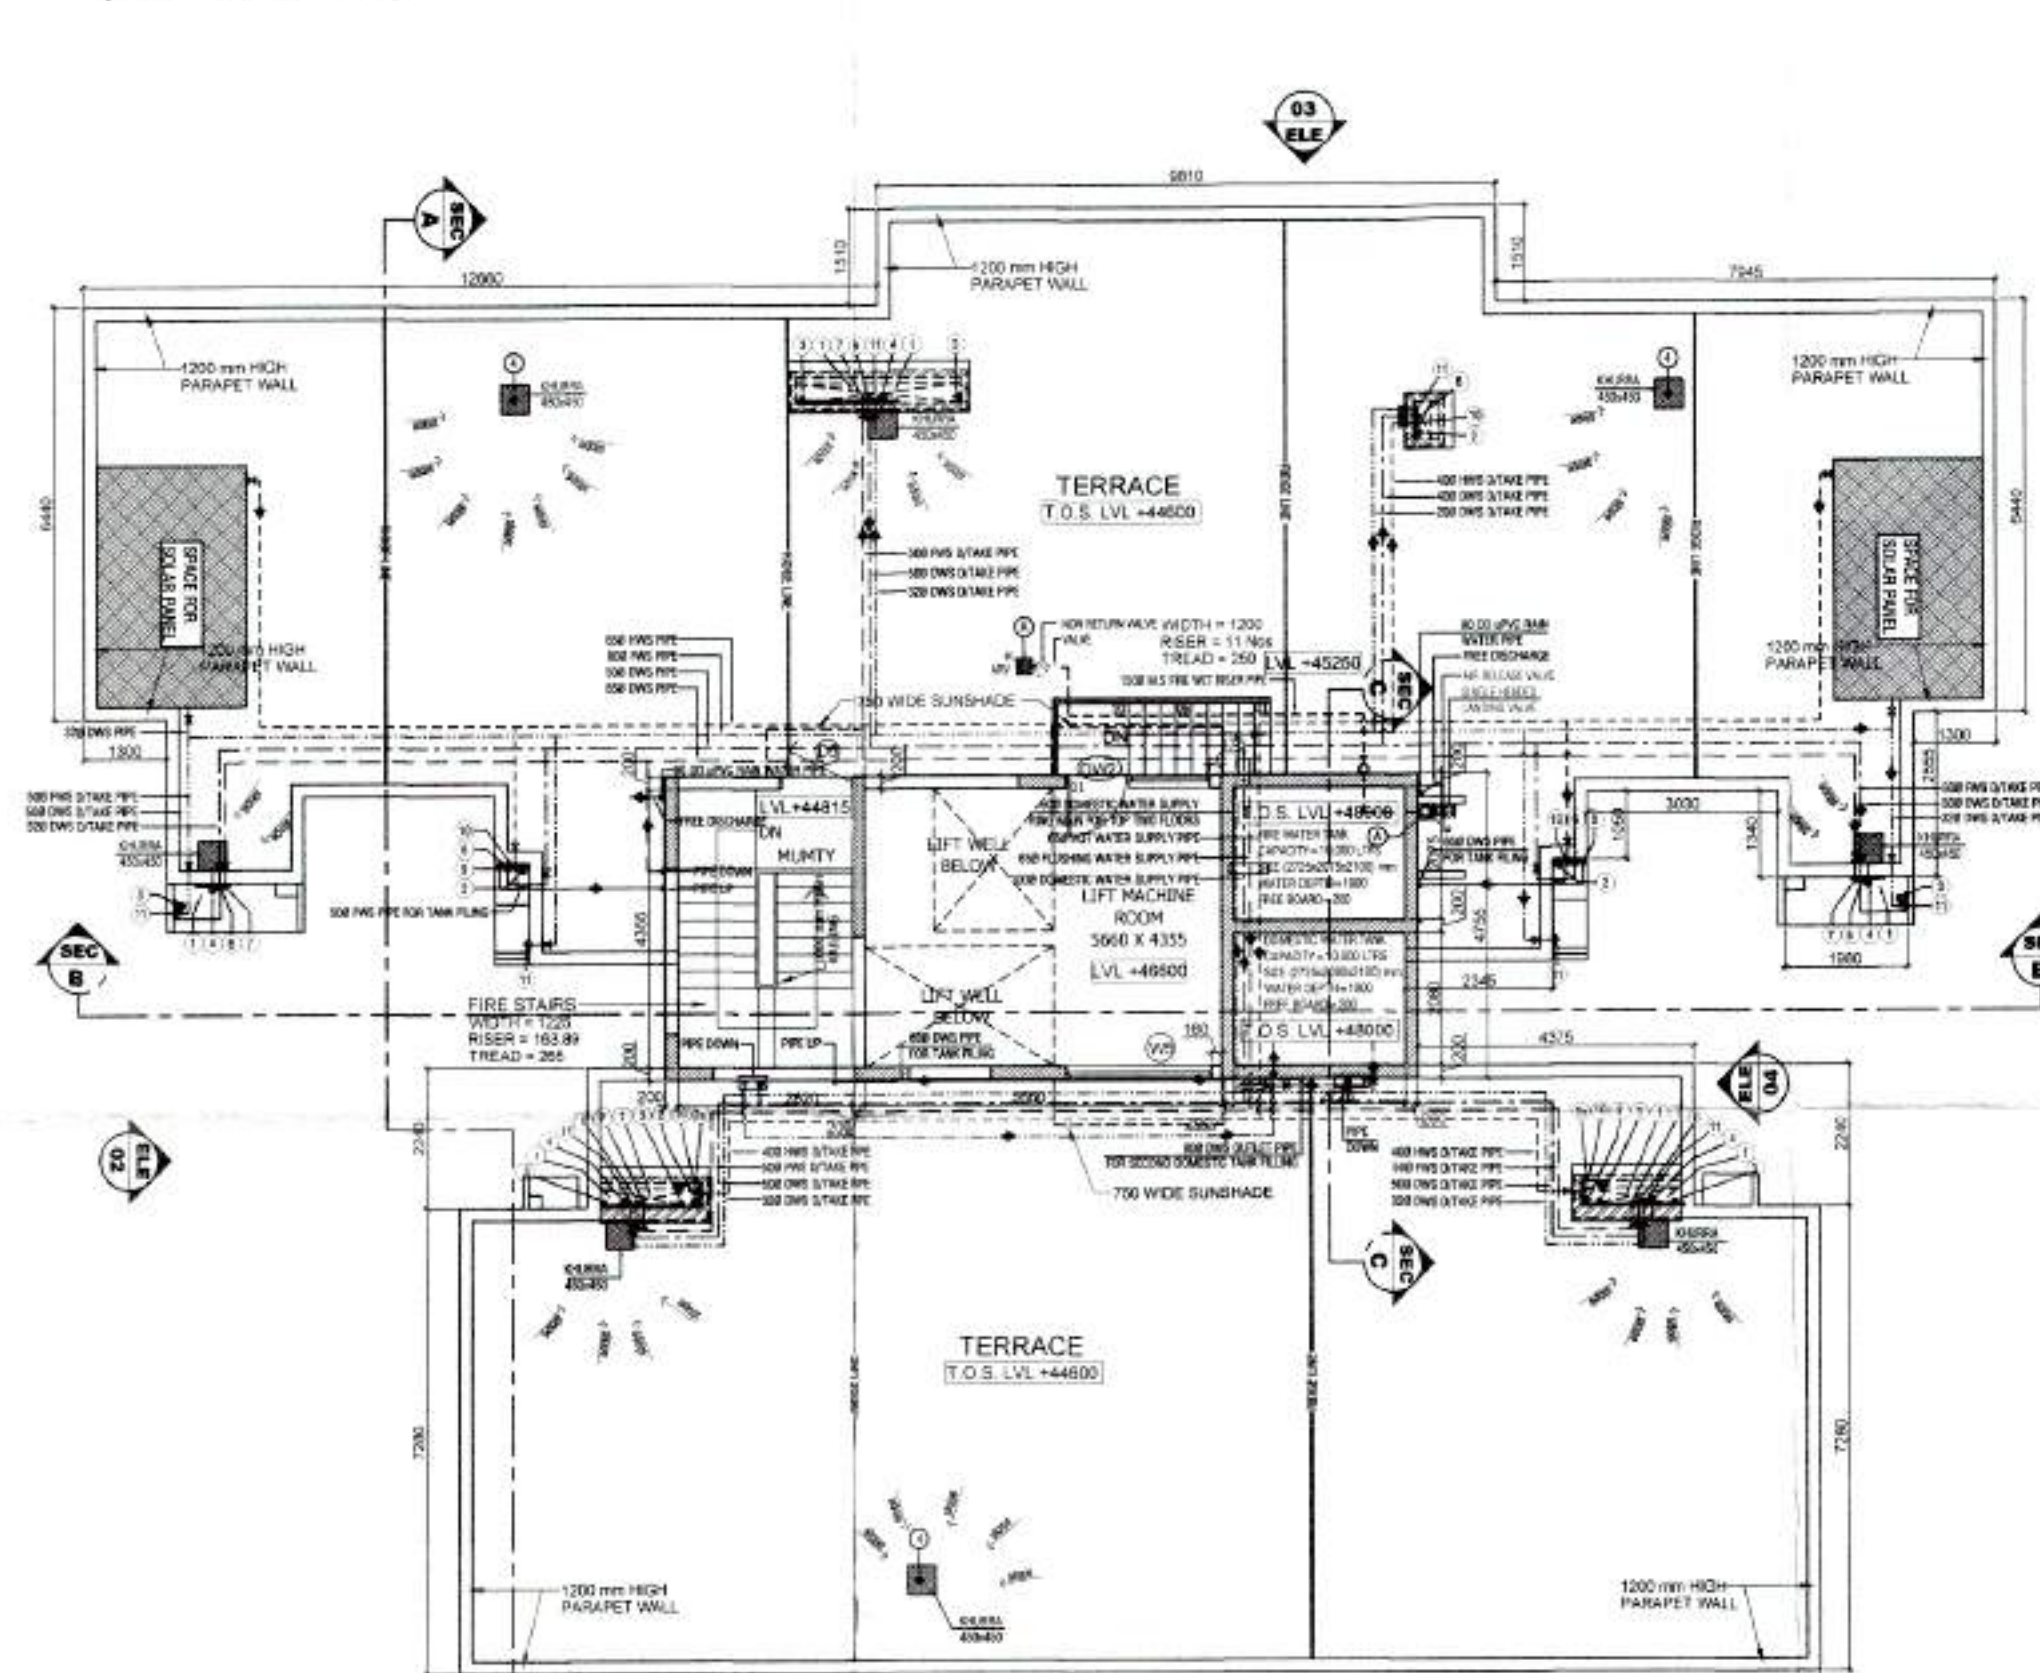


TERRACE PLAN
(For Towers T-8 & T-9)


S.NO	TYPE	WIDTH	HEIGHT	CLL	LOCATION
1	D1	1000	2100	00	MAIN ENTRY
2	D2	900	2100	00	BED ROOMS
3	D3	800	2100	00	TOILETS
4	D4	900	2100	00	CHANGING ROOM
5	D5	1200	2100	00	FIRE STAIRCASE
6	D6	900	2100	00	BED ROOMS
7	D7	1000	2100	00	TOILET ROOM & BATH
8	D8	1200	2100	00	FIRE
9	D9	900	2100	00	LV SHAFT
10	D10	800	2100	00	LV SHAFT IN BASEMENT
11	D11	2500	2100	00	ELECTRICAL SHAFT
12	D12	1450	2100/2000	00/1150	KITCHEN
13	D13	2450	2100/1000	00/1000	MACHINE ROOM
14	D14	2450	2100	00	LIVING ROOMS
15	D15	2000	2100	00	MASTER BED ROOMS
16	D16	1300	2100	00	BED ROOMS
17	D17	1200	2100	00	FIRE STAIRCASE
18	D18	1125	1200	00	MAIN STAIRCASE
19	D19	1125	1125	00	MAIN STAIRCASE
20	D20	900	1200	00	KITCHEN
21	D21	2000	1650	450	BEDROOMS
22	D22	800	900	1200	TOILETS
23	D23	2300	1650	1050	MACHINE ROOM
24	D24	875	1850	450	BEDROOM
25	D25	900	1200	900	LIVING ROOM
26	D26	500	1650	450	BEDROOM
27	D27	900	1200	900	LIVING ROOM
28	D28	1100	1000	1300	FIRE STAIRCASE
29	D29	3000	900	1200	F.T.A SHAFTS

PIPE NO.	DESCRIPTION
1	110.00 UPVC S&L, WASTE & VENT PIPE
2	110.00 UPVC WASTE & VENT PIPE
3	110.00 UPVC WASTE PIPE FOR WASH
4	75.00 UPVC WASTE PIPE FOR WASH
5	75.00 UPVC WASTE PIPE FOR WASH
6	110.00 UPVC WASTE PIPE FOR WASH
7	110.00 UPVC WASTE PIPE FOR WASH
8	110.00 UPVC WASTE PIPE FOR WASH
9	110.00 UPVC WASTE PIPE FOR WASH
10	110.00 UPVC WASTE PIPE FOR WASH
11	110.00 UPVC WASTE PIPE FOR WASH
12	110.00 UPVC WASTE PIPE FOR WASH
13	110.00 UPVC WASTE PIPE FOR WASH
14	110.00 UPVC WASTE PIPE FOR WASH
15	110.00 UPVC WASTE PIPE FOR WASH
16	110.00 UPVC WASTE PIPE FOR WASH
17	110.00 UPVC WASTE PIPE FOR WASH
18	110.00 UPVC WASTE PIPE FOR WASH
19	110.00 UPVC WASTE PIPE FOR WASH
20	110.00 UPVC WASTE PIPE FOR WASH
21	110.00 UPVC WASTE PIPE FOR WASH
22	110.00 UPVC WASTE PIPE FOR WASH
23	110.00 UPVC WASTE PIPE FOR WASH
24	110.00 UPVC WASTE PIPE FOR WASH
25	110.00 UPVC WASTE PIPE FOR WASH
26	110.00 UPVC WASTE PIPE FOR WASH
27	110.00 UPVC WASTE PIPE FOR WASH
28	110.00 UPVC WASTE PIPE FOR WASH
29	110.00 UPVC WASTE PIPE FOR WASH

1	WATER MAINS TO BE Laid AT 1000 MM DEPTH
2	WATER MAINS TO BE Laid AT 1000 MM DEPTH
3	WATER MAINS TO BE Laid AT 1000 MM DEPTH
4	WATER MAINS TO BE Laid AT 1000 MM DEPTH
5	WATER MAINS TO BE Laid AT 1000 MM DEPTH
6	WATER MAINS TO BE Laid AT 1000 MM DEPTH
7	WATER MAINS TO BE Laid AT 1000 MM DEPTH
8	WATER MAINS TO BE Laid AT 1000 MM DEPTH
9	WATER MAINS TO BE Laid AT 1000 MM DEPTH
10	WATER MAINS TO BE Laid AT 1000 MM DEPTH
11	WATER MAINS TO BE Laid AT 1000 MM DEPTH
12	WATER MAINS TO BE Laid AT 1000 MM DEPTH
13	WATER MAINS TO BE Laid AT 1000 MM DEPTH
14	WATER MAINS TO BE Laid AT 1000 MM DEPTH
15	WATER MAINS TO BE Laid AT 1000 MM DEPTH
16	WATER MAINS TO BE Laid AT 1000 MM DEPTH
17	WATER MAINS TO BE Laid AT 1000 MM DEPTH
18	WATER MAINS TO BE Laid AT 1000 MM DEPTH
19	WATER MAINS TO BE Laid AT 1000 MM DEPTH
20	WATER MAINS TO BE Laid AT 1000 MM DEPTH
21	WATER MAINS TO BE Laid AT 1000 MM DEPTH
22	WATER MAINS TO BE Laid AT 1000 MM DEPTH
23	WATER MAINS TO BE Laid AT 1000 MM DEPTH
24	WATER MAINS TO BE Laid AT 1000 MM DEPTH
25	WATER MAINS TO BE Laid AT 1000 MM DEPTH
26	WATER MAINS TO BE Laid AT 1000 MM DEPTH
27	WATER MAINS TO BE Laid AT 1000 MM DEPTH
28	WATER MAINS TO BE Laid AT 1000 MM DEPTH
29	WATER MAINS TO BE Laid AT 1000 MM DEPTH

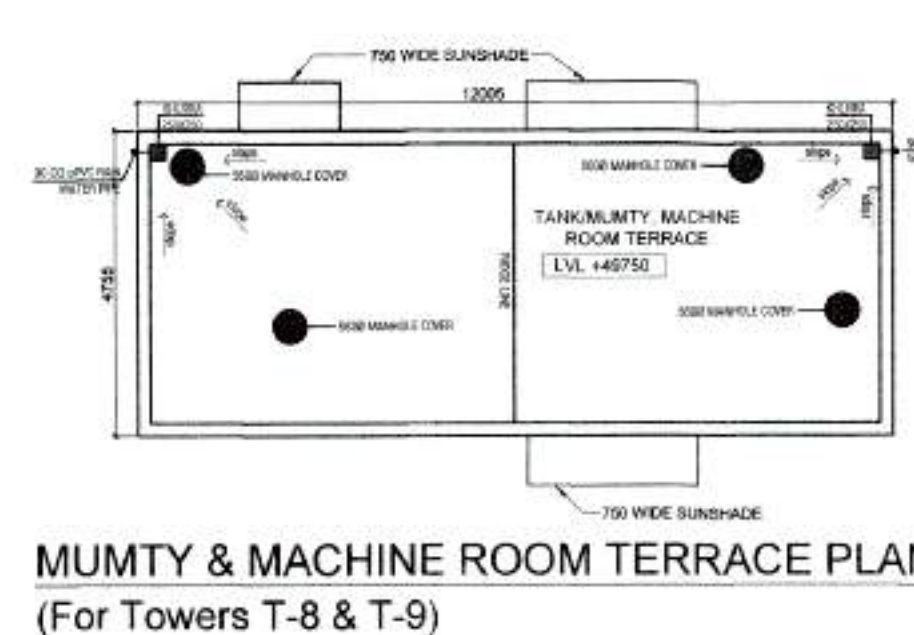


MUMTY & MACHINE ROOM TERRACE PLAN
(For Towers T-8 & T-9)

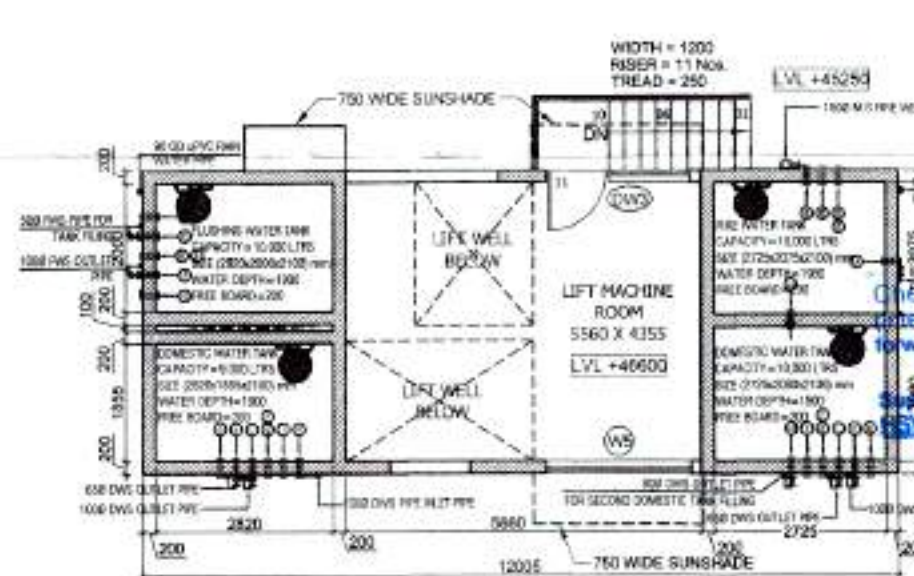

TANK & MACHINE ROOM LEVEL PLAN
(For Towers T-8 & T-9)

NO. OF PRINTS	DATE	ISSUED TO	REMARKS
1	20/08/2014	STP, Rishabh Member	
2	20/08/2014	STP, Rishabh Member	
3	20/08/2014	STP, Rishabh Member	
4	20/08/2014	STP, Rishabh Member	
5	20/08/2014	STP, Rishabh Member	
6	20/08/2014	STP, Rishabh Member	
7	20/08/2014	STP, Rishabh Member	
8	20/08/2014	STP, Rishabh Member	
9	20/08/2014	STP, Rishabh Member	
10	20/08/2014	STP, Rishabh Member	
11	20/08/2014	STP, Rishabh Member	
12	20/08/2014	STP, Rishabh Member	
13	20/08/2014	STP, Rishabh Member	
14	20/08/2014	STP, Rishabh Member	
15	20/08/2014	STP, Rishabh Member	
16	20/08/2014	STP, Rishabh Member	
17	20/08/2014	STP, Rishabh Member	
18	20/08/2014	STP, Rishabh Member	
19	20/08/2014	STP, Rishabh Member	
20	20/08/2014	STP, Rishabh Member	

GENERAL NOTES
1. ALL DIMENSIONS ARE IN MM UNLESS MENTIONED OTHERWISE

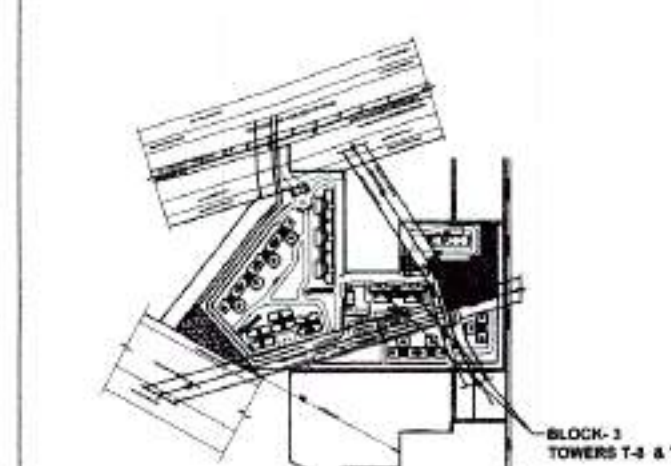

REVISED SUBMISSION DRAWINGS

PROJECT
REVISED BUILDING PLANS FOR GROUP HOUSING COLONY MEASURING 21.70925 Acres (LICENCE No. 60 of 2014 dated 30/06/2014 for 16.43125 Acres & LICENSE NO. 120 of 2014 dated 22/08/2014 for 5.278 Acres) IN SECTOR-37, BAHADURGARH BEING DEVELOPED BY HLT RESIDENCY PVT. LTD. AND OTHERS IN COLLABORATION WITH HL PROMOTERS PVT. LTD.

DATE	CHECKED BY	APPROVED BY
MARCH-2018	DEEPAK	S.M. SHARMA

SCALE
1: 100
DEALT BY
S. LAL

DRAWING TITLE
BLOCK-3
TOWERS T-8 & T-9
(GROUND / STILT +14 FLOORS)

BASEMENT, STILT / GROUND FLOOR & TYPICAL FLOOR PLANS, TERRACE, TANK & MACHINE ROOM, MUMTY MACHINE ROOM TERRACE PLAN

OWNER'S SIGN: ARCHITECT'S SIGN:

FOR HLT RESIDENCY PVT. LTD.
Auth Signatory: S. M. SHARMA
Council of Architecture
Registration No. CA/79/5029

ARCHITECTS:
C. P. KUKREJA ARCHITECTS
ASHIRWAD BUILDING,
D-1, GREEN PARK,
NEW DELHI - 110016
PHONE: +91 11 26863953, FAX: +91 11 26865770
EMAIL: cpkukreja@cpkukreja.com

DESIGN & ENGINEERING: TPC TECHNICAL PROJECTS CONSULTANTS (P) LTD.
B-1/1, SECTOR 37, INDIA
B-1/1, SECTOR 37, INDIA
B-1/1, SECTOR 37, INDIA

DESIGN & ENGINEERING: TPC TECHNICAL PROJECTS CONSULTANTS (P) LTD.
B-1/1, SECTOR 37, INDIA
B-1/1, SECTOR 37, INDIA
B-1/1, SECTOR 37, INDIA

