


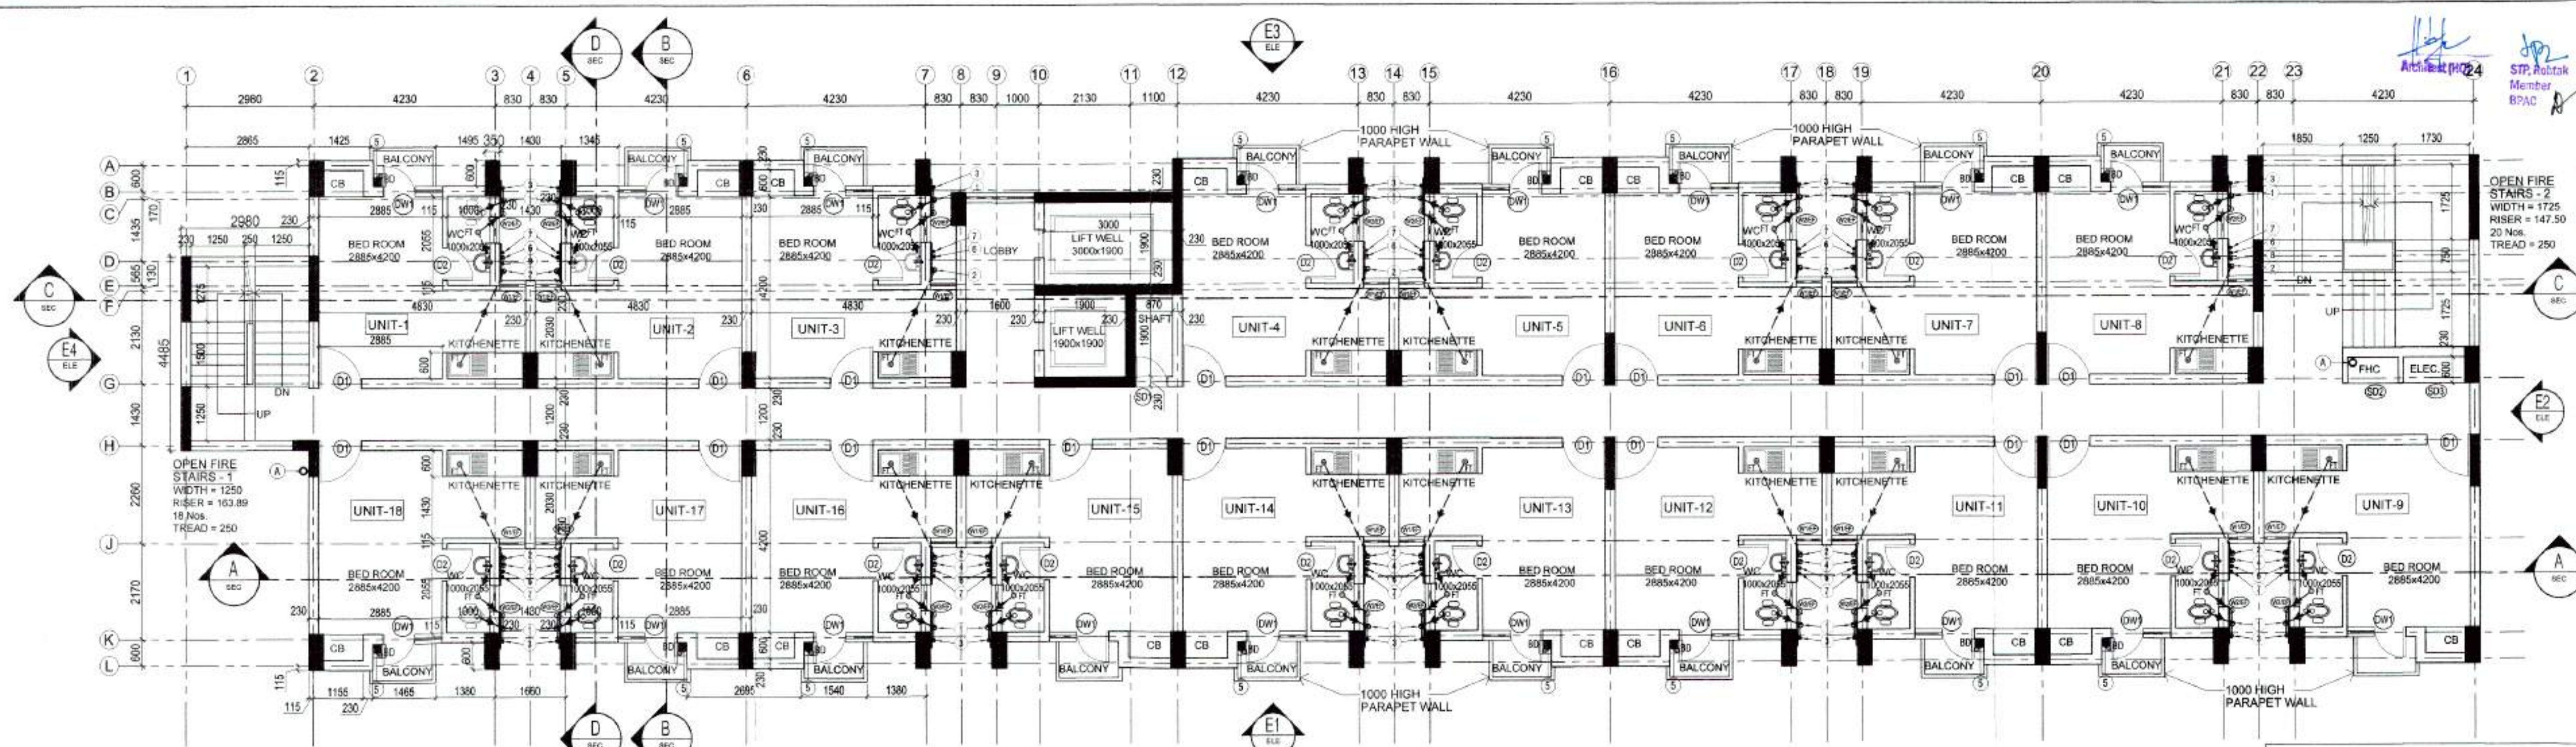

TYPICAL FLOOR PLAN-1ST TO 11TH FLOOR
(EWS BLOCK)

CARPET AREA OF ONE EWS UNIT				
ROOM	NO.	AREA (SQM)	AREA (SQFT)	TOTAL
BED ROOM	1	2.885	3.117	12.117
KITCHENETTE	1	1.800	1.945	3.945
BATH	1	0.900	0.969	0.969
WC	1	0.900	0.969	0.969
CB	1	0.900	0.969	0.969
TOTAL				20.968

PIPE NO.	DESCRIPTION
1	110 OD UPVC SOIL, WASTE & VENT PIPE
2	110 OD UPVC WASTE & VENT PIPE
3	90 OD UPVC WASTE PIPE FOR W.M
4	75 OD UPVC ANTI-SYPHONAGE PIPE
5	110 OD UPVC TERRACE RAIN WATER PIPE
6	90 OD UPVC RAIN WATER PIPE FOR BALCONY


8	DOMESTIC WATER SUPPLY D/N TAKE PIPE *
7	FLUSHING WATER SUPPLY D/N TAKE PIPE *
8	50B DOMESTIC WATER SUPPLY RISER *
9	40B FLUSHING WATER SUPPLY RISER *
10	HOT WATER SUPPLY PIPE
11	DOMESTIC WATER SUPPLY D/N TAKE PIPE FOR TOP TWO FLOOR
12	FLOOR TRAP (110x110) MM

FD	FLOOR DRAIN (110x63) MM
BD	BALCONY DRAIN (110x63) MM
OD	OUTER DIA OF PIPE
FT	WASH BASIN
FT	WALL
FT	40 OD UPVC WASTE PIPE
FT	63 OD UPVC WASTE PIPE

FT	63 OD UPVC WASTE PIPE
FT	75 OD UPVC ANTI-SYPHONAGE PIPE
FT	110 OD UPVC SOIL PIPE
FT	110 OD UPVC WASTE PIPE

FIRE LEGEND :-	
A	1500 M.S FIRE WET RISER PIPE
FHC	FIRE HOSE CABINET
IMPORTANT NOTES:-	
1. 1500 M.S FIRE WET RISER PIPE.	

S.NO	TYPE	WIDTH	HEIGHT	CILL	LINTEL	LOCATION
1	D1	1000	2150	00	2150	BED ROOM
2	D2	750	2150	00	2150	WC
3	D3	1000	2150	00	2150	MACHINE ROOM
4	DW1	1300	2150/1250	00/900	2150	BALCONY
5	FD1	1200	2100	00	2100	STAIRCASE - 1 MUMTY
6	FD2	1800	2100	00	2100	STAIRCASE - 2 MUMTY
7	W1/EF	600	1250	900	2150	KITCHENETTE
8	W2/EF	600	1250	900	2150	WC
9	W3	1600	1250	900	2150	LIFT LOBBY/MACHINE ROOM
10	W4	1200	1250	900	2150	MACHINE ROOM
11	SD1	750	2150	00	2150	SHAFT
12	SD2	1200	2050	100	2150	FHC
13	SD3	1430	2050	100	2150	ELEC. SHAFT

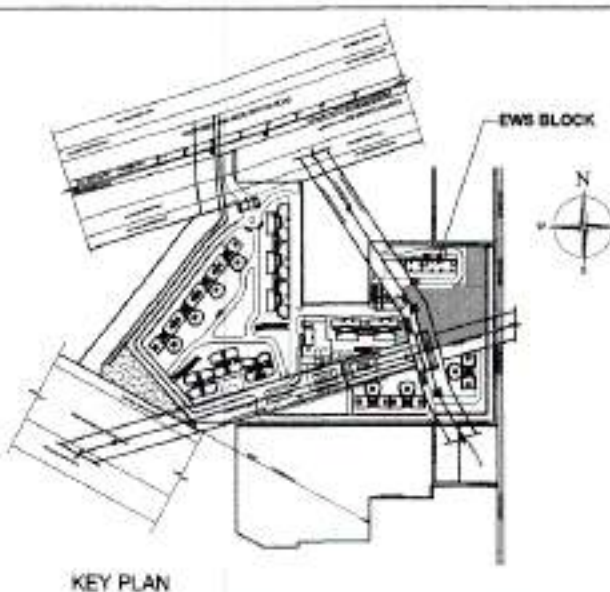

REVISED SUBMISSION DRAWINGS
PROJECT
REVISED BUILDING PLANS FOR GROUP HOUSING COLONY MEASURING 21.70925 Acres (LICENCE No 60 of 2014 dated 30/06/2014 for 16.43125 Acres & LICENCE No. 120 of 2014 dated 22/08/2014 for 5.278 Acres) IN SECTOR-37, SAHADURGARH BEING DEVELOPED BY HLT RESIDENCY PVT. LTD. AND OTHERS IN COLLABORATION WITH HLT PROMOTERS PVT. LTD.

DATE	CHECKED BY	APPROVED BY
MARCH 2018	DEEPAK	S. M. SHARMA
SCALE	DEALT BY	
1: 75	S. LAL	

DRAWING TITLE
BLOCK-7 / EWS BLOCKS (G+11)


GROUND FLOOR & TYPICAL FLOOR PLAN

OWNERS SIGN: *[Signature]*
ARCHITECTS SIGN: *[Signature]*
FOR HLT PROMOTERS PVT. LTD.
S. M. SHARMA
Council of Architecture
Registration No. CA/195029

ARCHITECTS:
C. P. KUKREJA ARCHITECTS
ASHIRVAD BUILDING,
D-1, GREEN PARK,
NEW DELHI - 110016
PHONE : 011 26863553 FAX : 011 26865770
EMAIL: cpk@cpkukreja.com
TECHNICAL CONSULTANTS:
TPC
TPC TECHNICAL PROJECTS CONSULTANTS (P) LTD.
UTTAR PRDESH 20130 (INDIA)
ROD NO. 91-110-439999
GIRGANI HYDERABAD NEW DELHI INDIA
MEP Services Consultants:
PARADISE CONSULTANTS
Plot No. 103, Basement,
Near Ling Shye Mall, Jasola Vihar
Landline : +91-11-29493501, 26943216
New Delhi - 110025
E-mail: paradiseconsultants@gmail.com
website: www.paradiseconsultants.com

DRAWING NO.	DRG. NO.
14007TH BH/SUB/BLOCK-7/EWSA-FP00	22/35
CAD NO.	

CARPET AREA DIAGRAM
FOR TYPICAL EWS UNIT

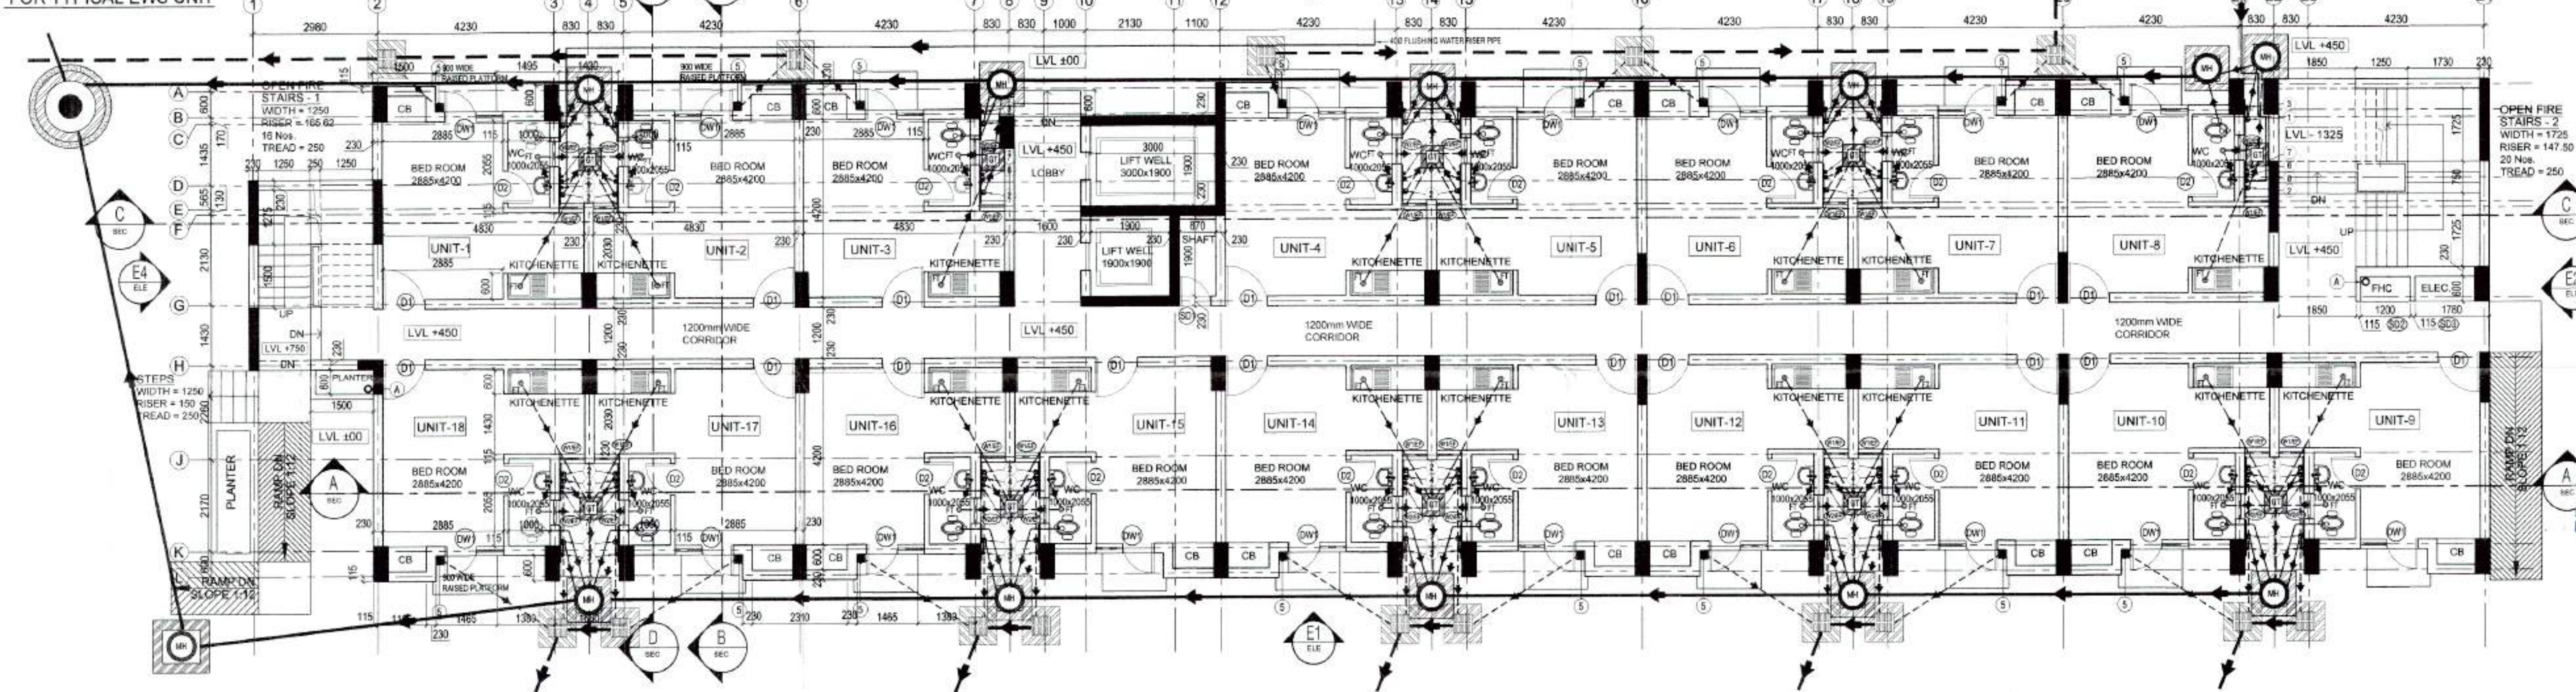

GROUND FLOOR PLAN (EWS BLOCK)