


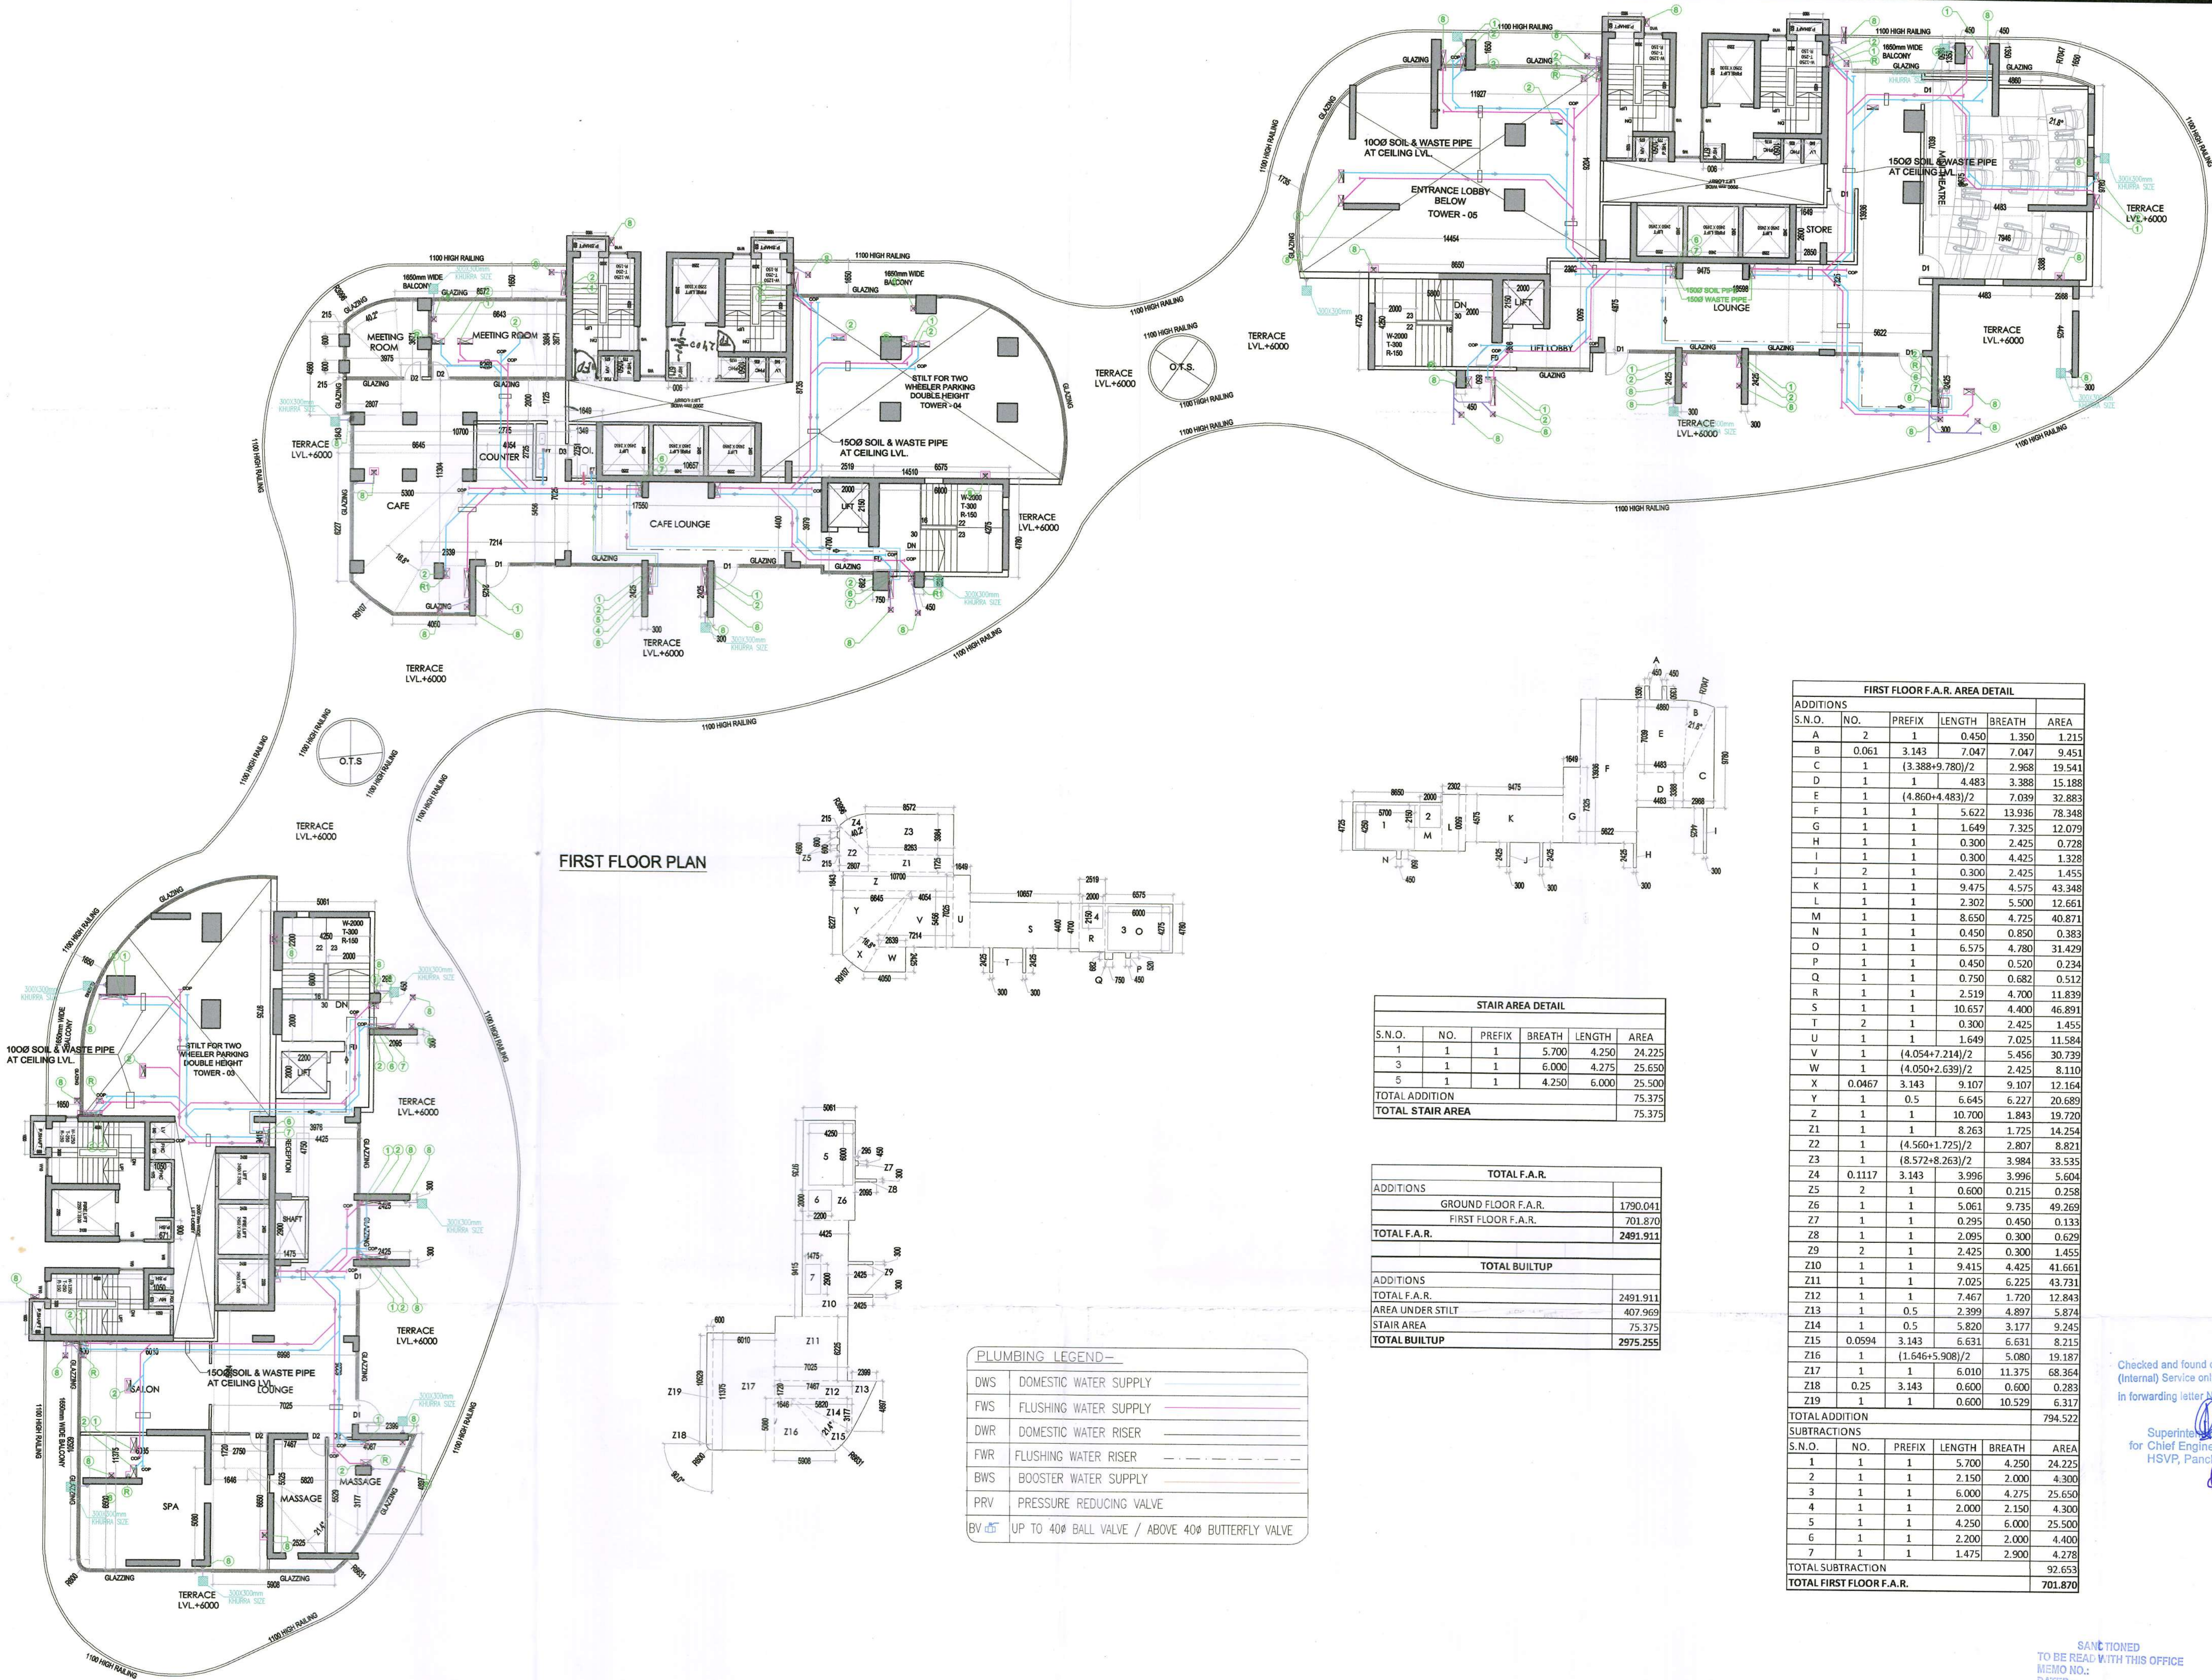

PLUMBING LEGEND:-		
1	110 OD SOIL PIPE	
2	110 OD WASTE PIPE	
3	75 OD ANTI VENT PIPE	
4	DOMESTIC WATER SUPPLY PIPE LOW ZONE	
4A	DOMESTIC WATER SUPPLY PIPE HIGH ZONE	
5	FLUSHING WATER SUPPLY PIPE LOW ZONE	
5A	FLUSHING WATER SUPPLY PIPE HIGH ZONE	
6	DOMESTIC WATER RISER PIPE TO OHT	
7	FLUSHING WATER RISER PIPE TO OHT	
8	110 OD RAIN WATER PIPE	
R	160 OD RAIN WATER PIPE	
FT	FLOOR TRAP	
FD	FLOOR DRAIN	
BD	BALCONY DRAIN	
COP	CLEAN OUT PLUG	

DOOR OPENING SCHEDULE				
NO.	SIZE	SILL LEVEL	LINTEL LVL	REMARK
D1	1200 X 2400	00 MM	2400 MM	SINGLE LEAF DOOR
D2	1200 X 2400	00 MM	2400 MM	SINGLE LEAF DOOR
D3	900 X 2400	00 MM	2400 MM	SINGLE LEAF DOOR
D4	700 X 2400	00 MM	2400 MM	SINGLE LEAF DOOR
GD	2000X 3000	00 MM	3000 MM	DOUBLE LEAF DOOR

WINDOW SCHEDULE				
NO.	SIZE	SILL LEVEL	LINTEL LVL	REMARK
W6	1200 X 2400	00 MM	2400 MM	SLIDING WINDOW
W7	600 X 2400	+400 MM	2800 MM	SLIDING WINDOW
W10	900 X 1950	00 MM	2800 MM	SLIDING WINDOW

- NOTES:-
- FD- 2 HOUR FIRE RATED DOOR
 - FD2- 1 HOUR FIRE RATED DOOR
 - F.H.C- FIRE HOSE CABINET
 - P.S.- PRESURIZATION SHAFT
 - S. ROOM- SERVANT ROOM
 - P.R- POWDER ROOM
 - P.R WILL BE MECHANICALLY VENTILATED & ARTIFICIALLY LIT
 - W.C- WATER CLOSET

PROJECT:-
PROPOSED BUILDING PLAN FOR RESIDENTIAL COLONY UNDER NILP POLICY DATED 11.05.2022 OVER AN AREA MEASURING 10.071875 ACRES LICENSE NO. 225 OF 2023 DATED 30/10/2023 (7.434375 Acres UNDER MIGRATION FROM LICENSE NO. 92 OF 2023 DATED 21-04-2023 GRANTED FOR DDJAY AFFORDABLE PLOTTED COLONY AND FRESH APPLIED AREA MEASURING 2.6375 Acres) IN SECTOR-59&63A, GURUGRAM MANESAR URBAN COMPLEX BEING DEVELOPED BY - 4S DEVELOPERS P V T L T D

Checked and found ok for Public Health (Internal) Service only subject to confirmation of the ARCHITECT:-
In forwarding letter No. 522/19 D.V. 28-7-24

Superintendent Engineer (H) for Chief Engineer-I HSPV, Panchkula

VIKAS AHLAWAT ARCHITECTS
ARCHITECTURE, INTERIORS, PLANNING
Unit No.303/Anex Time Center, Sushy Sector-54, Golf Course Road, Gurgaon
O - 0124-4284293 M- 0-9899159466 Mail - ar.vikas.ahlawat@gmail.com

OWNERS SIGNATURE:-
For 4S Developers Pvt. Ltd.
Authorised Signatory

ARCHITECT SIGNATURE:-
Ar. VIKAS AHLAWAT
CA/2013/59929

DRAWING TITLE:
**COMMUNITY BUILDING
PLAN & AREA CALCULATION**

DATE:- JAN-2024
SCALE:- 1:200 (A1)

SHEET NO.
C-2