


Sanctioned
Vide Memo No. 23578 Dated 30/08/2024

Sanctioned
Vide Memo No. 23578 Dated 30/08/2024

LEGEND: FIRE SYSTEM		
S. No.	SYMBOL	DESCRIPTION
1.	—	YARD FIRELINE
2.	—	UNDER GROUND PIPE (U/G)
3.	—	UNDER GROUND PIPE (U/G)
4.	—	UNDER GROUND PIPE (U/G)
5.	—	UNDER GROUND PIPE (U/G)
6.	—	UNDER GROUND PIPE (U/G)
7.	—	UNDER GROUND PIPE (U/G)
8.	—	UNDER GROUND PIPE (U/G)
9.	—	UNDER GROUND PIPE (U/G)
10.	—	UNDER GROUND PIPE (U/G)
11.	—	UNDER GROUND PIPE (U/G)
12.	—	UNDER GROUND PIPE (U/G)
13.	—	UNDER GROUND PIPE (U/G)
14.	—	UNDER GROUND PIPE (U/G)
15.	—	UNDER GROUND PIPE (U/G)
16.	—	UNDER GROUND PIPE (U/G)
17.	—	UNDER GROUND PIPE (U/G)
18.	—	UNDER GROUND PIPE (U/G)
19.	—	UNDER GROUND PIPE (U/G)
20.	—	UNDER GROUND PIPE (U/G)

LEGEND: PLUMBING		
S. No.	SYMBOL	DESCRIPTION
1.	—	1000 PPS SANITARY PIPE (R/W)
2.	—	1000 PPS SANITARY PIPE (R/W)
3.	—	1000 PPS SANITARY PIPE (R/W)
4.	—	1000 PPS SANITARY PIPE (R/W)
5.	—	1000 PPS SANITARY PIPE (R/W)
6.	—	1000 PPS SANITARY PIPE (R/W)
7.	—	1000 PPS SANITARY PIPE (R/W)
8.	—	1000 PPS SANITARY PIPE (R/W)
9.	—	1000 PPS SANITARY PIPE (R/W)
10.	—	1000 PPS SANITARY PIPE (R/W)
11.	—	1000 PPS SANITARY PIPE (R/W)
12.	—	1000 PPS SANITARY PIPE (R/W)
13.	—	1000 PPS SANITARY PIPE (R/W)
14.	—	1000 PPS SANITARY PIPE (R/W)
15.	—	1000 PPS SANITARY PIPE (R/W)
16.	—	1000 PPS SANITARY PIPE (R/W)
17.	—	1000 PPS SANITARY PIPE (R/W)
18.	—	1000 PPS SANITARY PIPE (R/W)
19.	—	1000 PPS SANITARY PIPE (R/W)
20.	—	1000 PPS SANITARY PIPE (R/W)

Sanctioned
Vide Memo No. 23578 Dated 30/08/2024

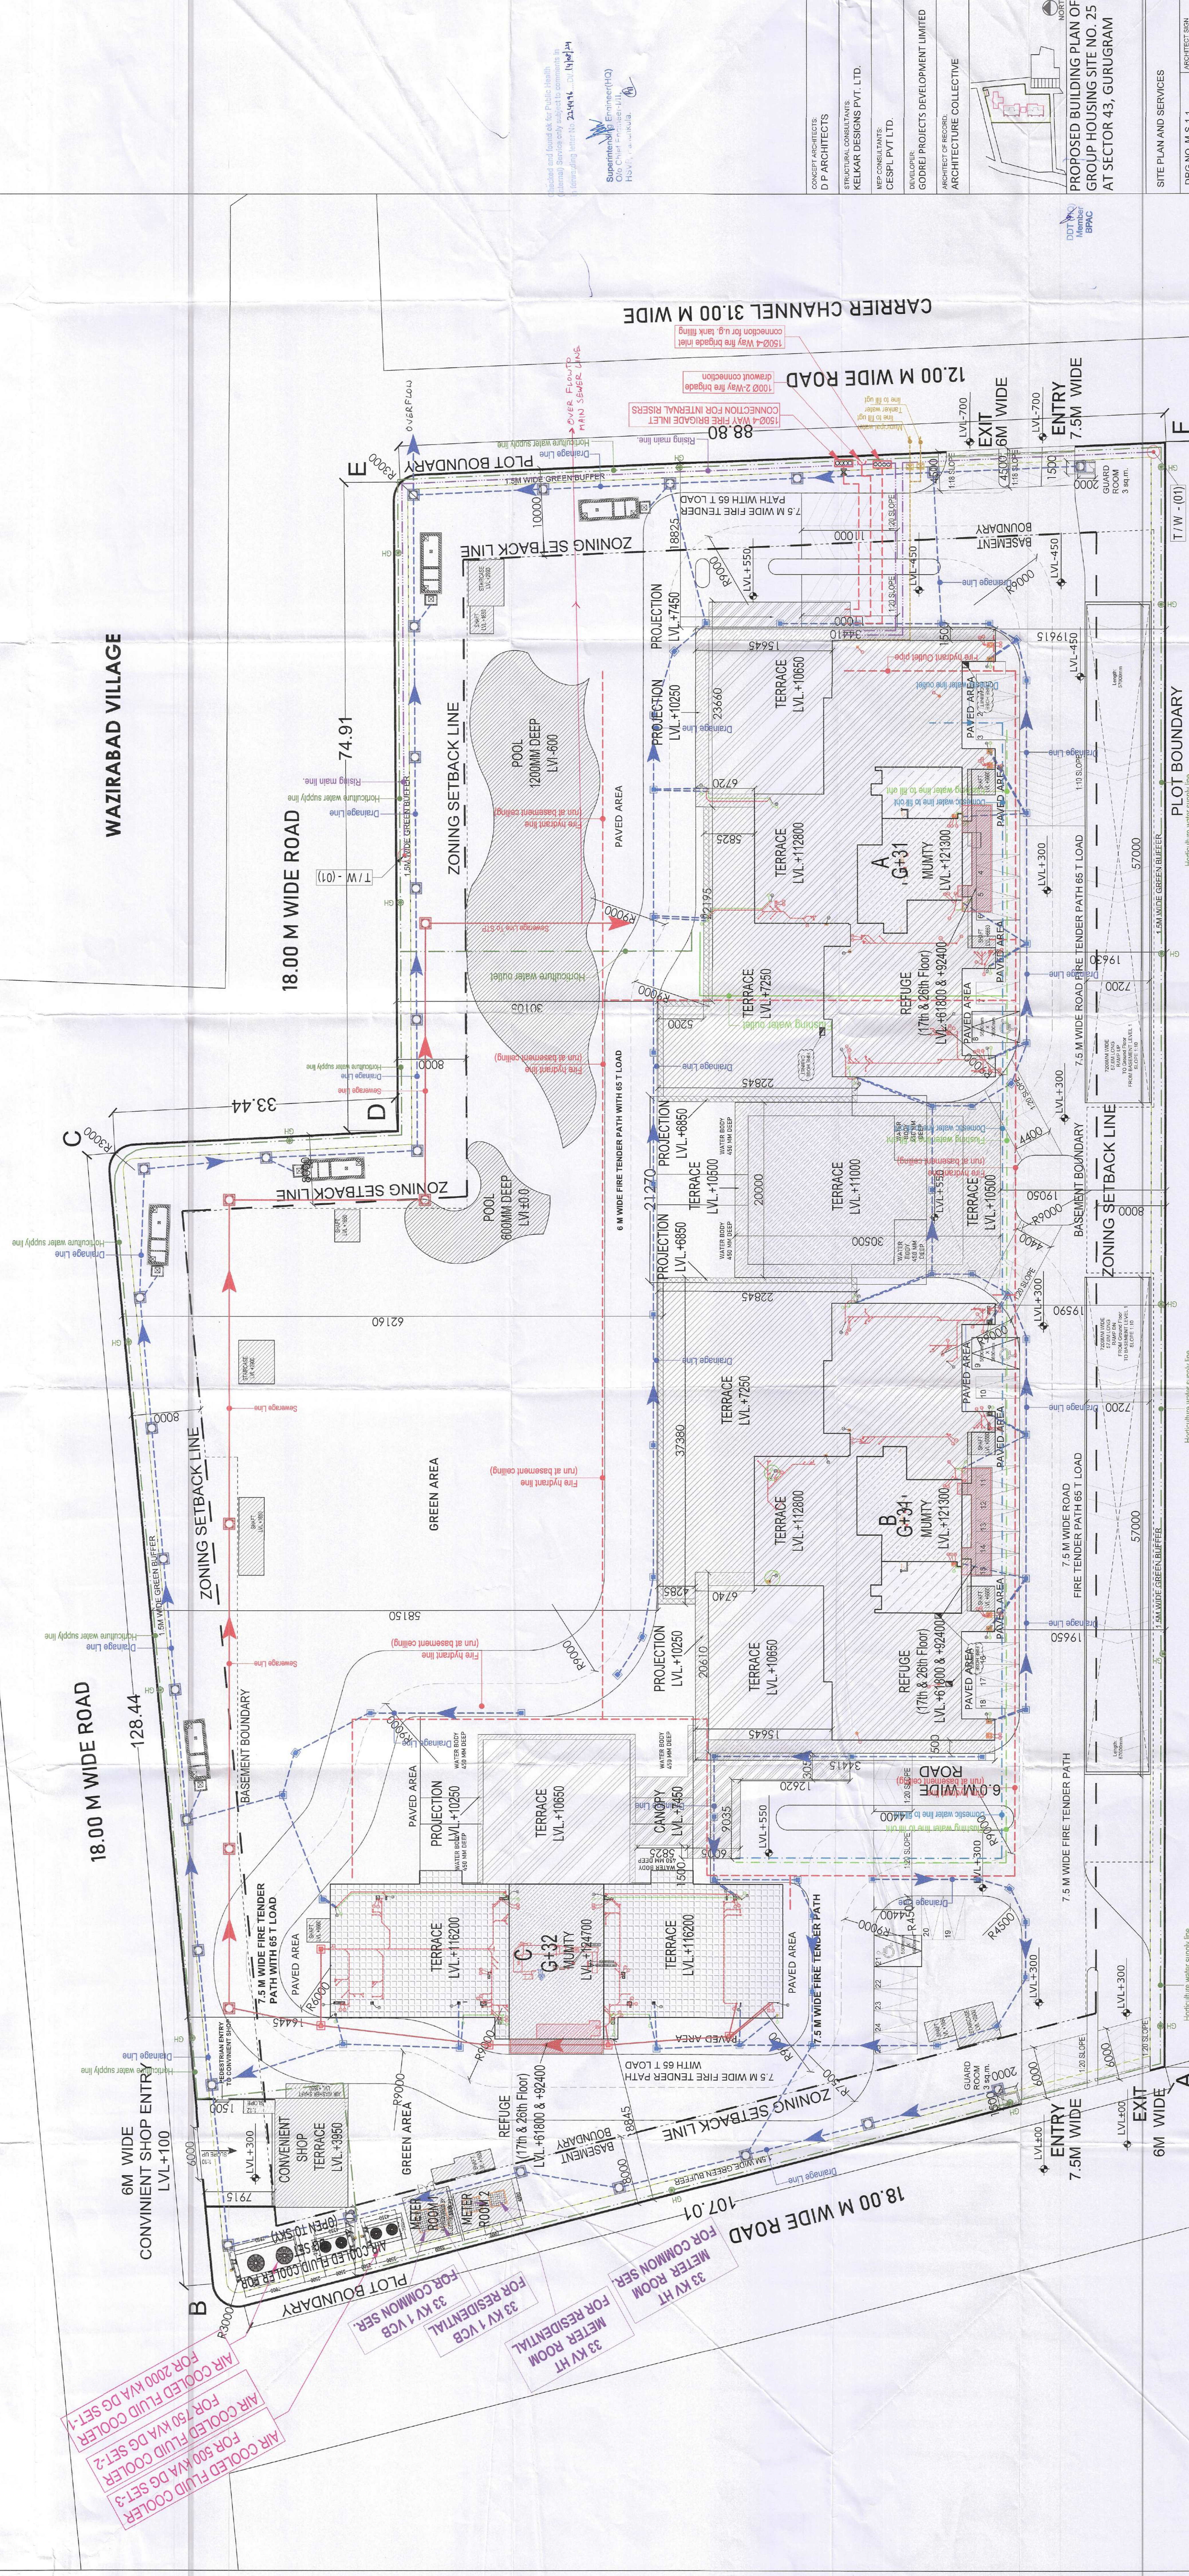

INDIAN INSTITUTE OF MANAGEMENT
SITE FOR COLLEGE 6.00 ACRES (APPROX.)

SITE PLAN & SERVICES
SCALE 1:250

SITE PLAN & SERVICES
SCALE 1:250