




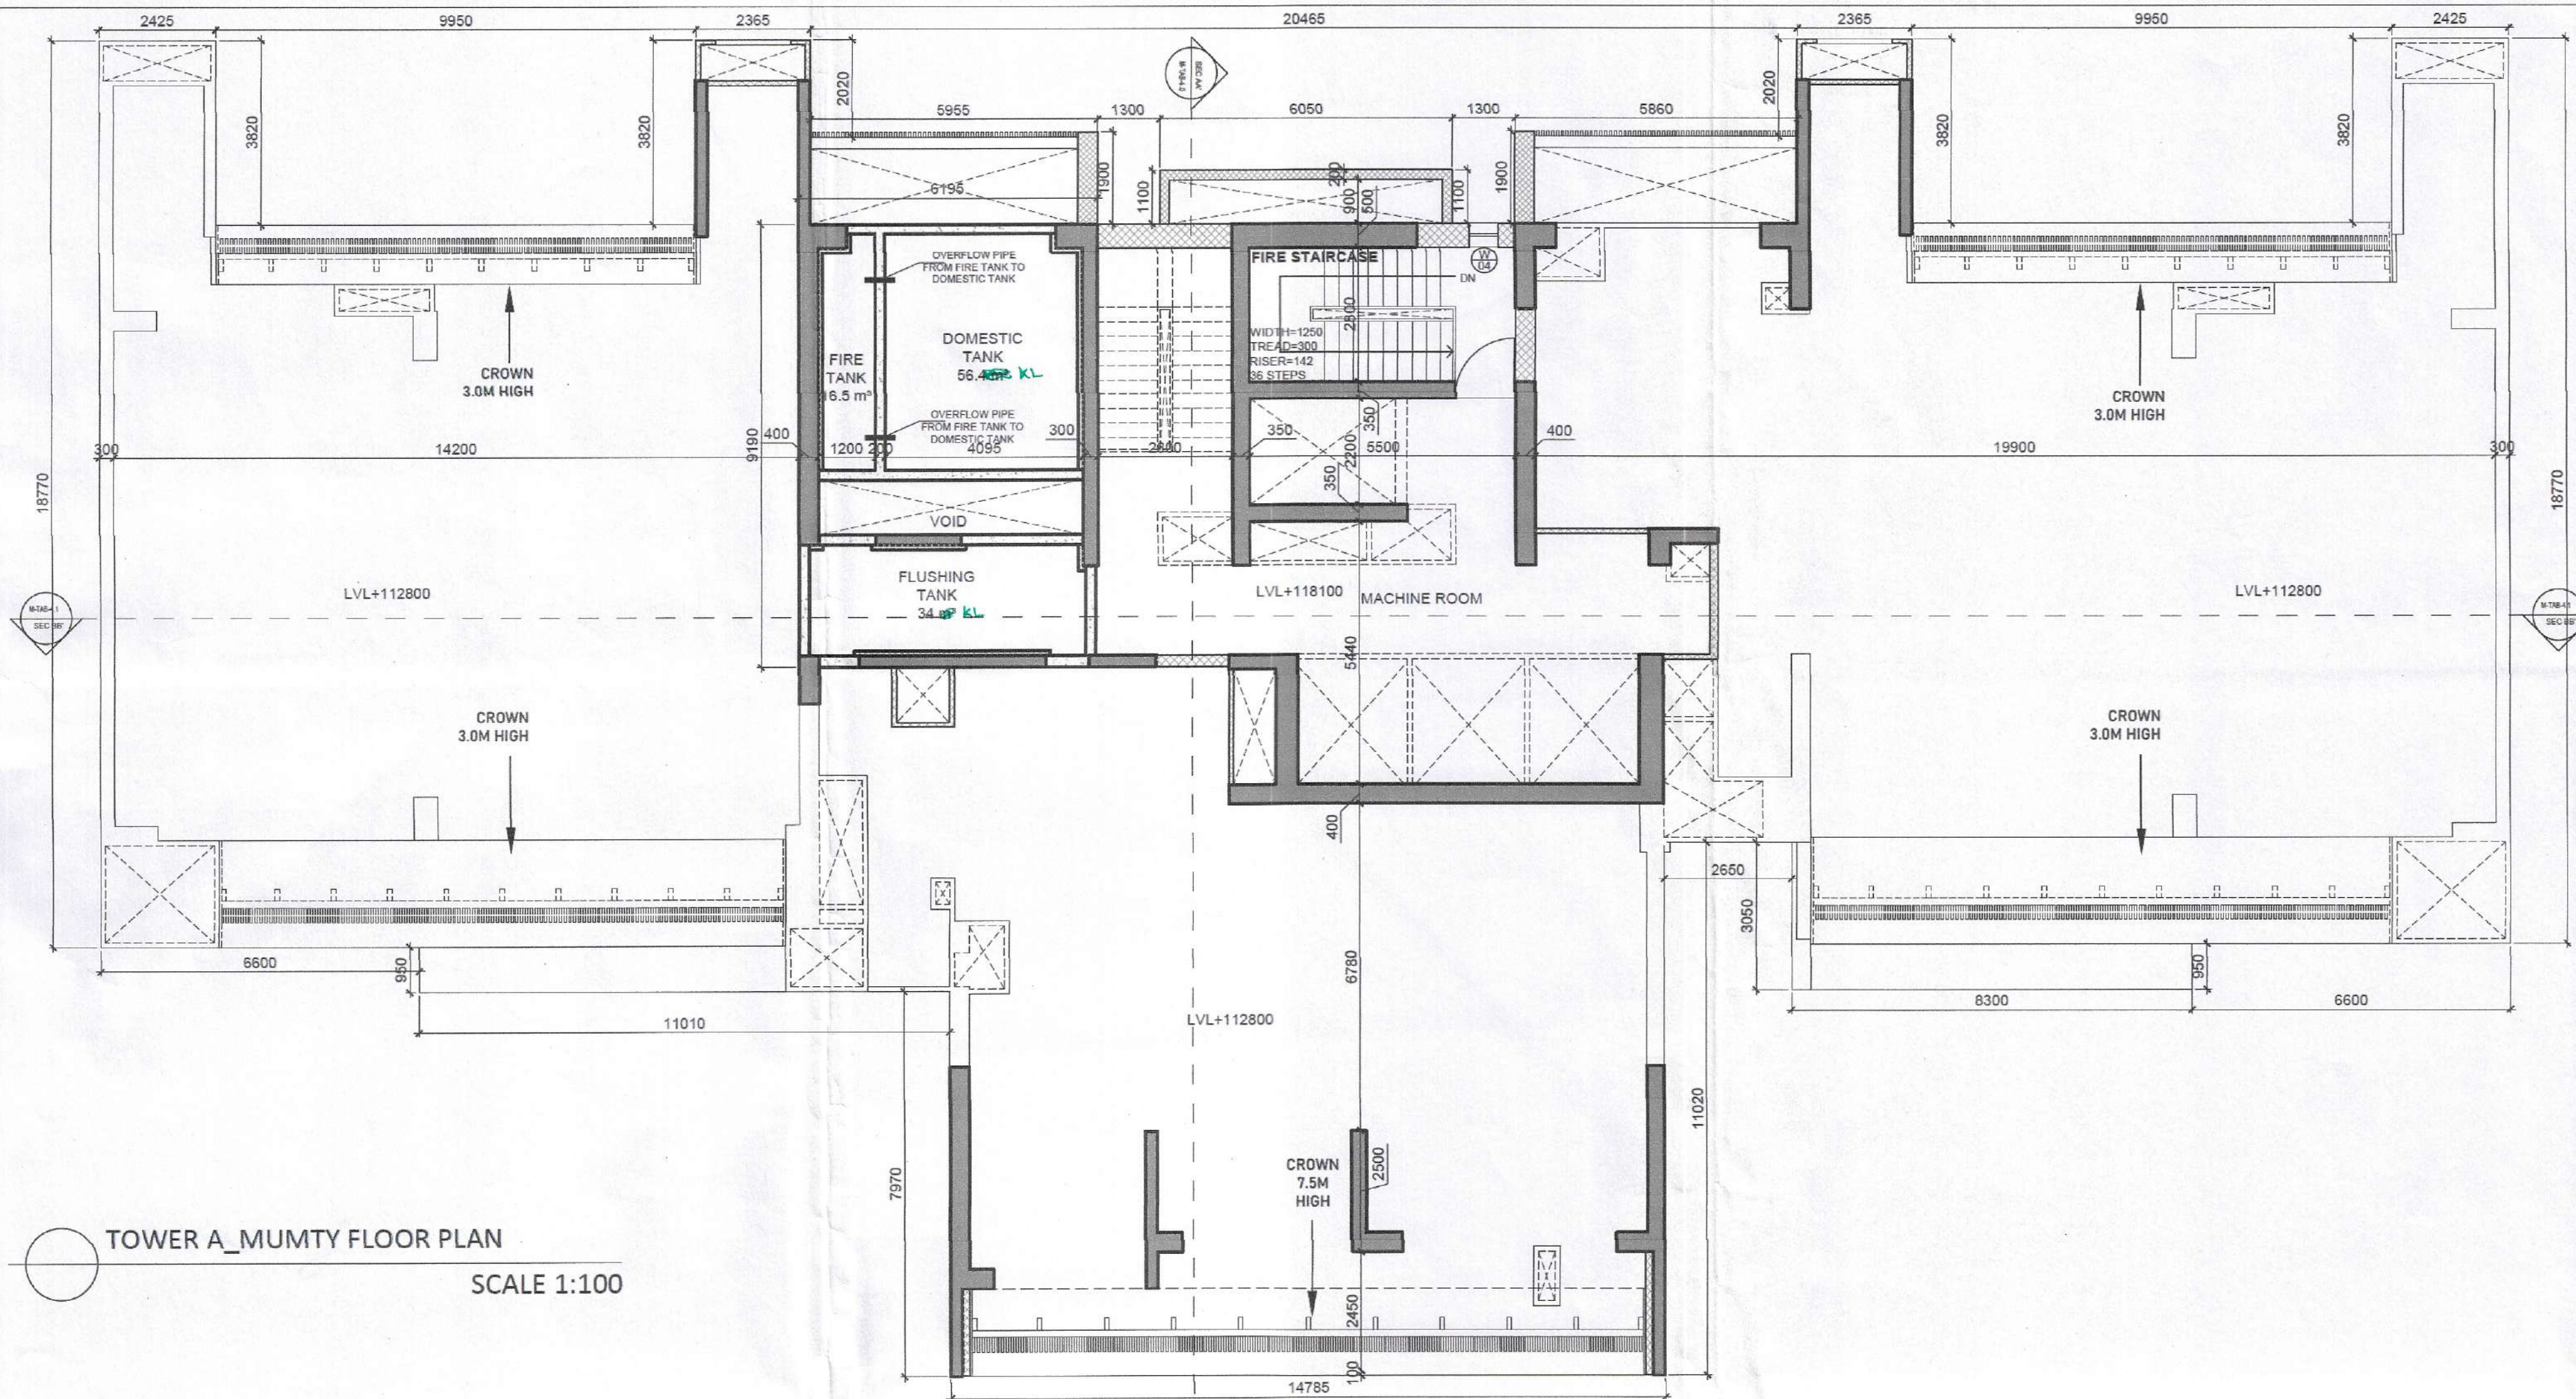

TOWER A_MUMTY FLOOR PLAN
SCALE 1:100

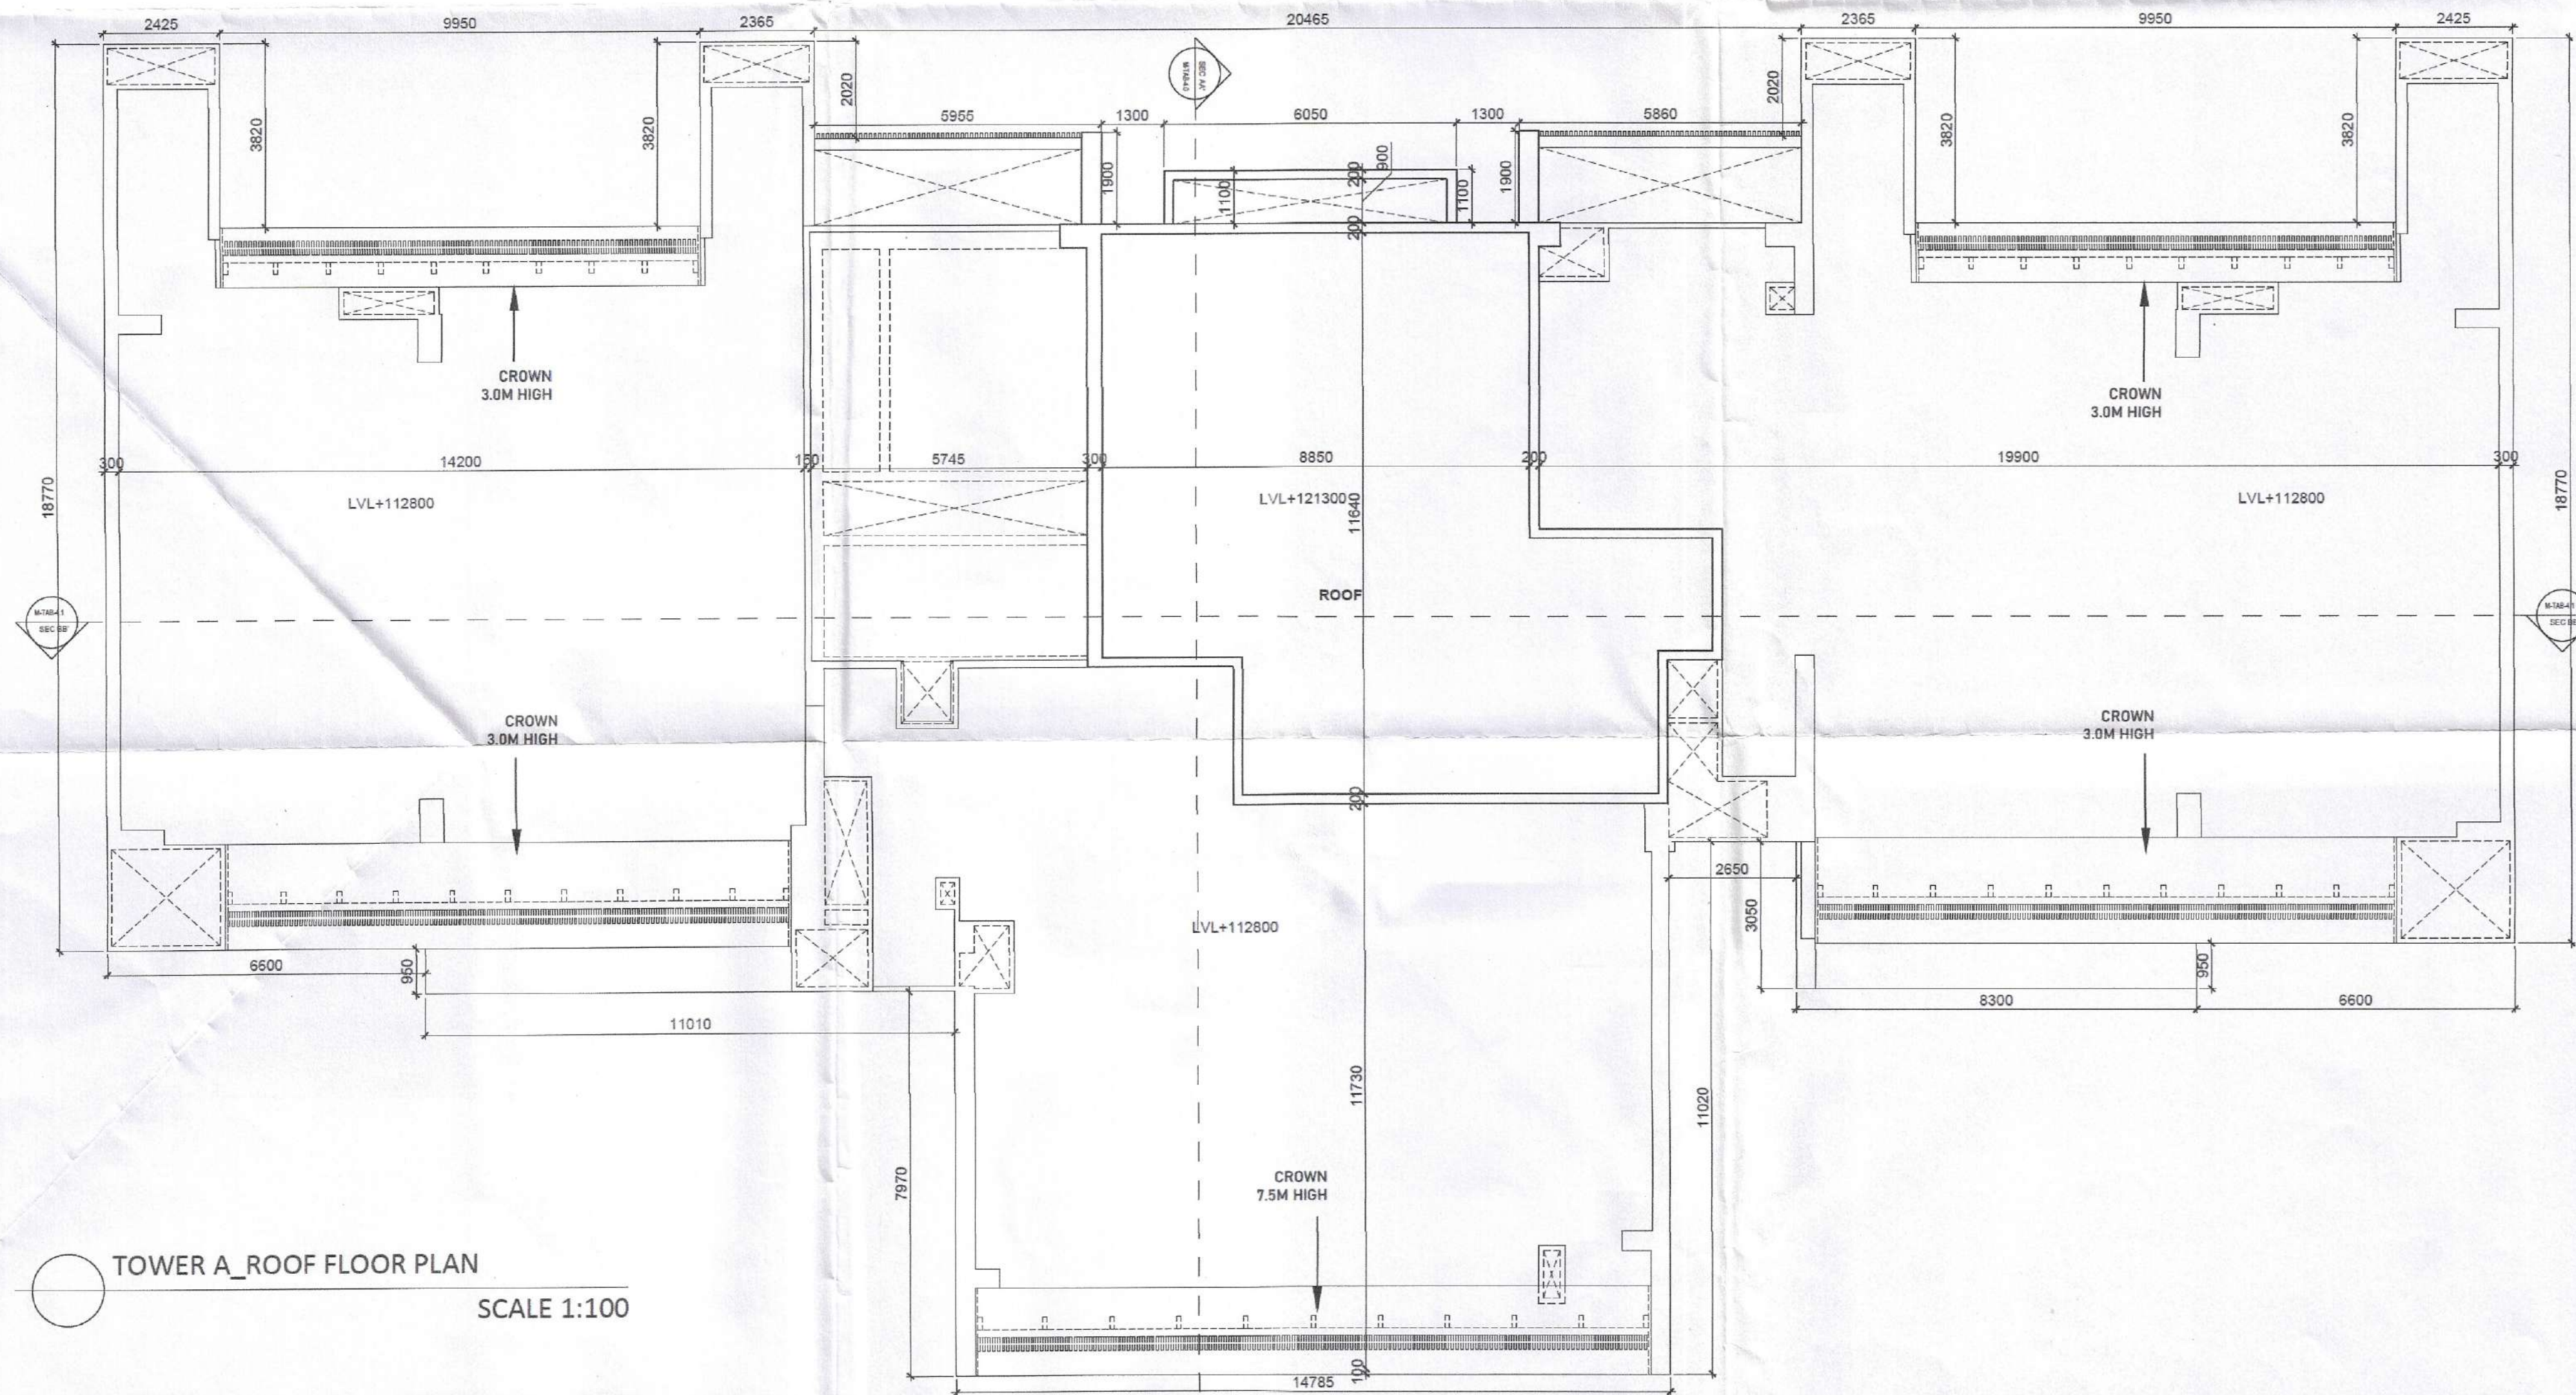

TOWER A_ROOF FLOOR PLAN
SCALE 1:100

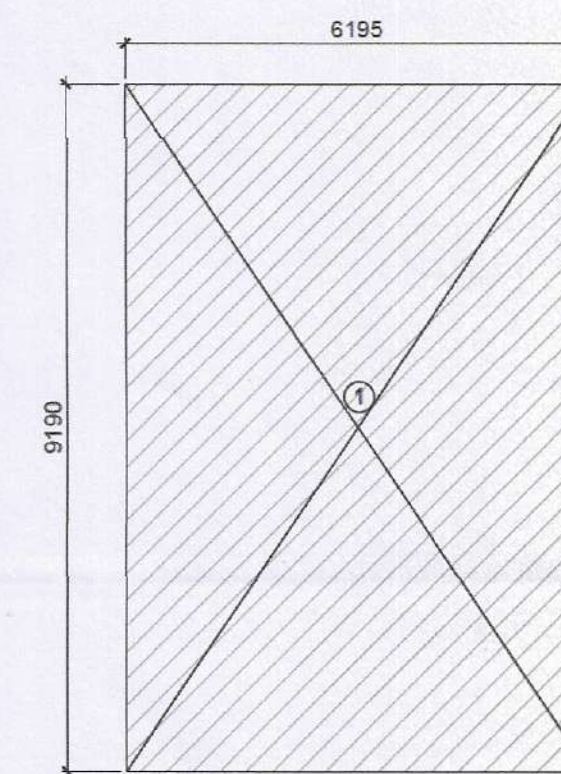

TOWER A_MUMTY FLOOR AREA DIAGRAM
SCALE 1:100

TOWER A: MUMTY FLOOR NON FAR CALCULATION				
S.NO.	LENGTH(M)	WIDTH(M)	NO.	AREA(SQ.M.)
COVERED AREA				
1	6.195	9.190	1	56.932
TOTAL ADDITIONS (A)				56.932

TOWER A&B: Door Window Schedule				
DOOR/WINDOW	WIDTH	HEIGHT	SILL	LINTEL
D01	750	2100	300	2400
D02	800	2400	0	2400
D03	750	2100	300	2400
D04	1050	2400	0	2400
D05	750	2100	300	2400
D06	900	2600	0	2600
D09	450	2100	300	2400
D13	910	2100	300	2400
D14	800	2600	0	2600
O	0	0	0	0
FD01	1250	2400	0	2400
FD02	1500	2100	300	2400
FD03	900	2400	0	2400
FD04	750	2100	300	2400
FD05	1250	2400	0	2400
FD06	1250	2600	0	2600
O	0	0	0	0
W01	750	2100	300	2400
W02	600	1200	1200	2400
W03	800	800	1200	2000
W04	600	700	1200	1900
W06	2700	1700	900	2600
W07	600	1400	1200	2600
O	0	0	0	0
DW01	2450	2600	0	2600
DW02	2700	2600	0	2600
DW03	1575	2600	0	2600
DW04	2050	2600	0/1200	2600
DW05	7200	2600	0	2600
DW07	3050	2600	0	2600
DW08	3505	2600	0	2600
DW11	1520	2600	0/1200	2600

SANCTIONED
VIDE MEMO No. 235988 DATED 30/07/2024

DTP (HQ)
Member Secretary
BPAC

STP
Member
BPAC

CTP
Chairman
BPAC

Recommended for Sanction
Senior Town Planner
KUDA, Gurugram
Member BPAC

DTP

DDT(V)
MEMBER
BPAC

- NOTES :-
- VRV System is being provided.
 - Full DG power back up is being provided.
 - Toilets are mechanical ventilated.
 - All lifts shall have 100% power back-up.
 - All electrical installations shall be as per provision of NBC.
 - Fire-fighting/safety provisions will be as per relevant NBC provisions.
 - Basement area shall have mechanically ventilated as per relevant code.
 - All toilets are ventilated as per Haryana Building Code 2017.
 - Building has automatic sprinkler system wherever required by NBC.
 - Building will be designed (structures) as per relevant I.S. codes for earthquake resistance.
 - Solar panels of required capacity shall be provided on roof top as per hareda/zoning norms.
 - All handicap ramps with railing.
 - All fire fighting installations shall be as per provision of NBC.
 - The rainwater harvesting system shall be provided as per central ground water authority norms.

CONCEPT ARCHITECTS:
D P ARCHITECTS

STRUCTURAL CONSULTANTS:
KELKAR DESIGNS PVT. LTD.

MEP CONSULTANTS:
CESPL PVT LTD.

DEVELOPER:
GODREJ PROJECTS DEVELOPMENT LIMITED

ARCHITECT OF RECORD:
ARCHITECTURE COLLECTIVE

PROPOSED BUILDING PLAN OF
GROUP HOUSING SITE NO. 25
AT SECTOR 43, GURUGRAM

Checked and found ok for Public Health
(Internal) Service only subject to comments in
in forwarding letter No. 224496, Dtd. 14/8/24

TOWER A
MUMTY AND ROOF PLAN

Superintending Engineer(HQ)
O/o Chief Engineer-I/II,
HSVP, Panchkula.

DRG.NO. M-TA-2.7

SCALE: 1:100

DATE:

DEALT: VANSHICA

OWNER'S SIGN
For Godrej Projects Development Limited

ARCHITECT SIGN AND STAMP:
GAURAV SANJAN

Authorised Signatory