



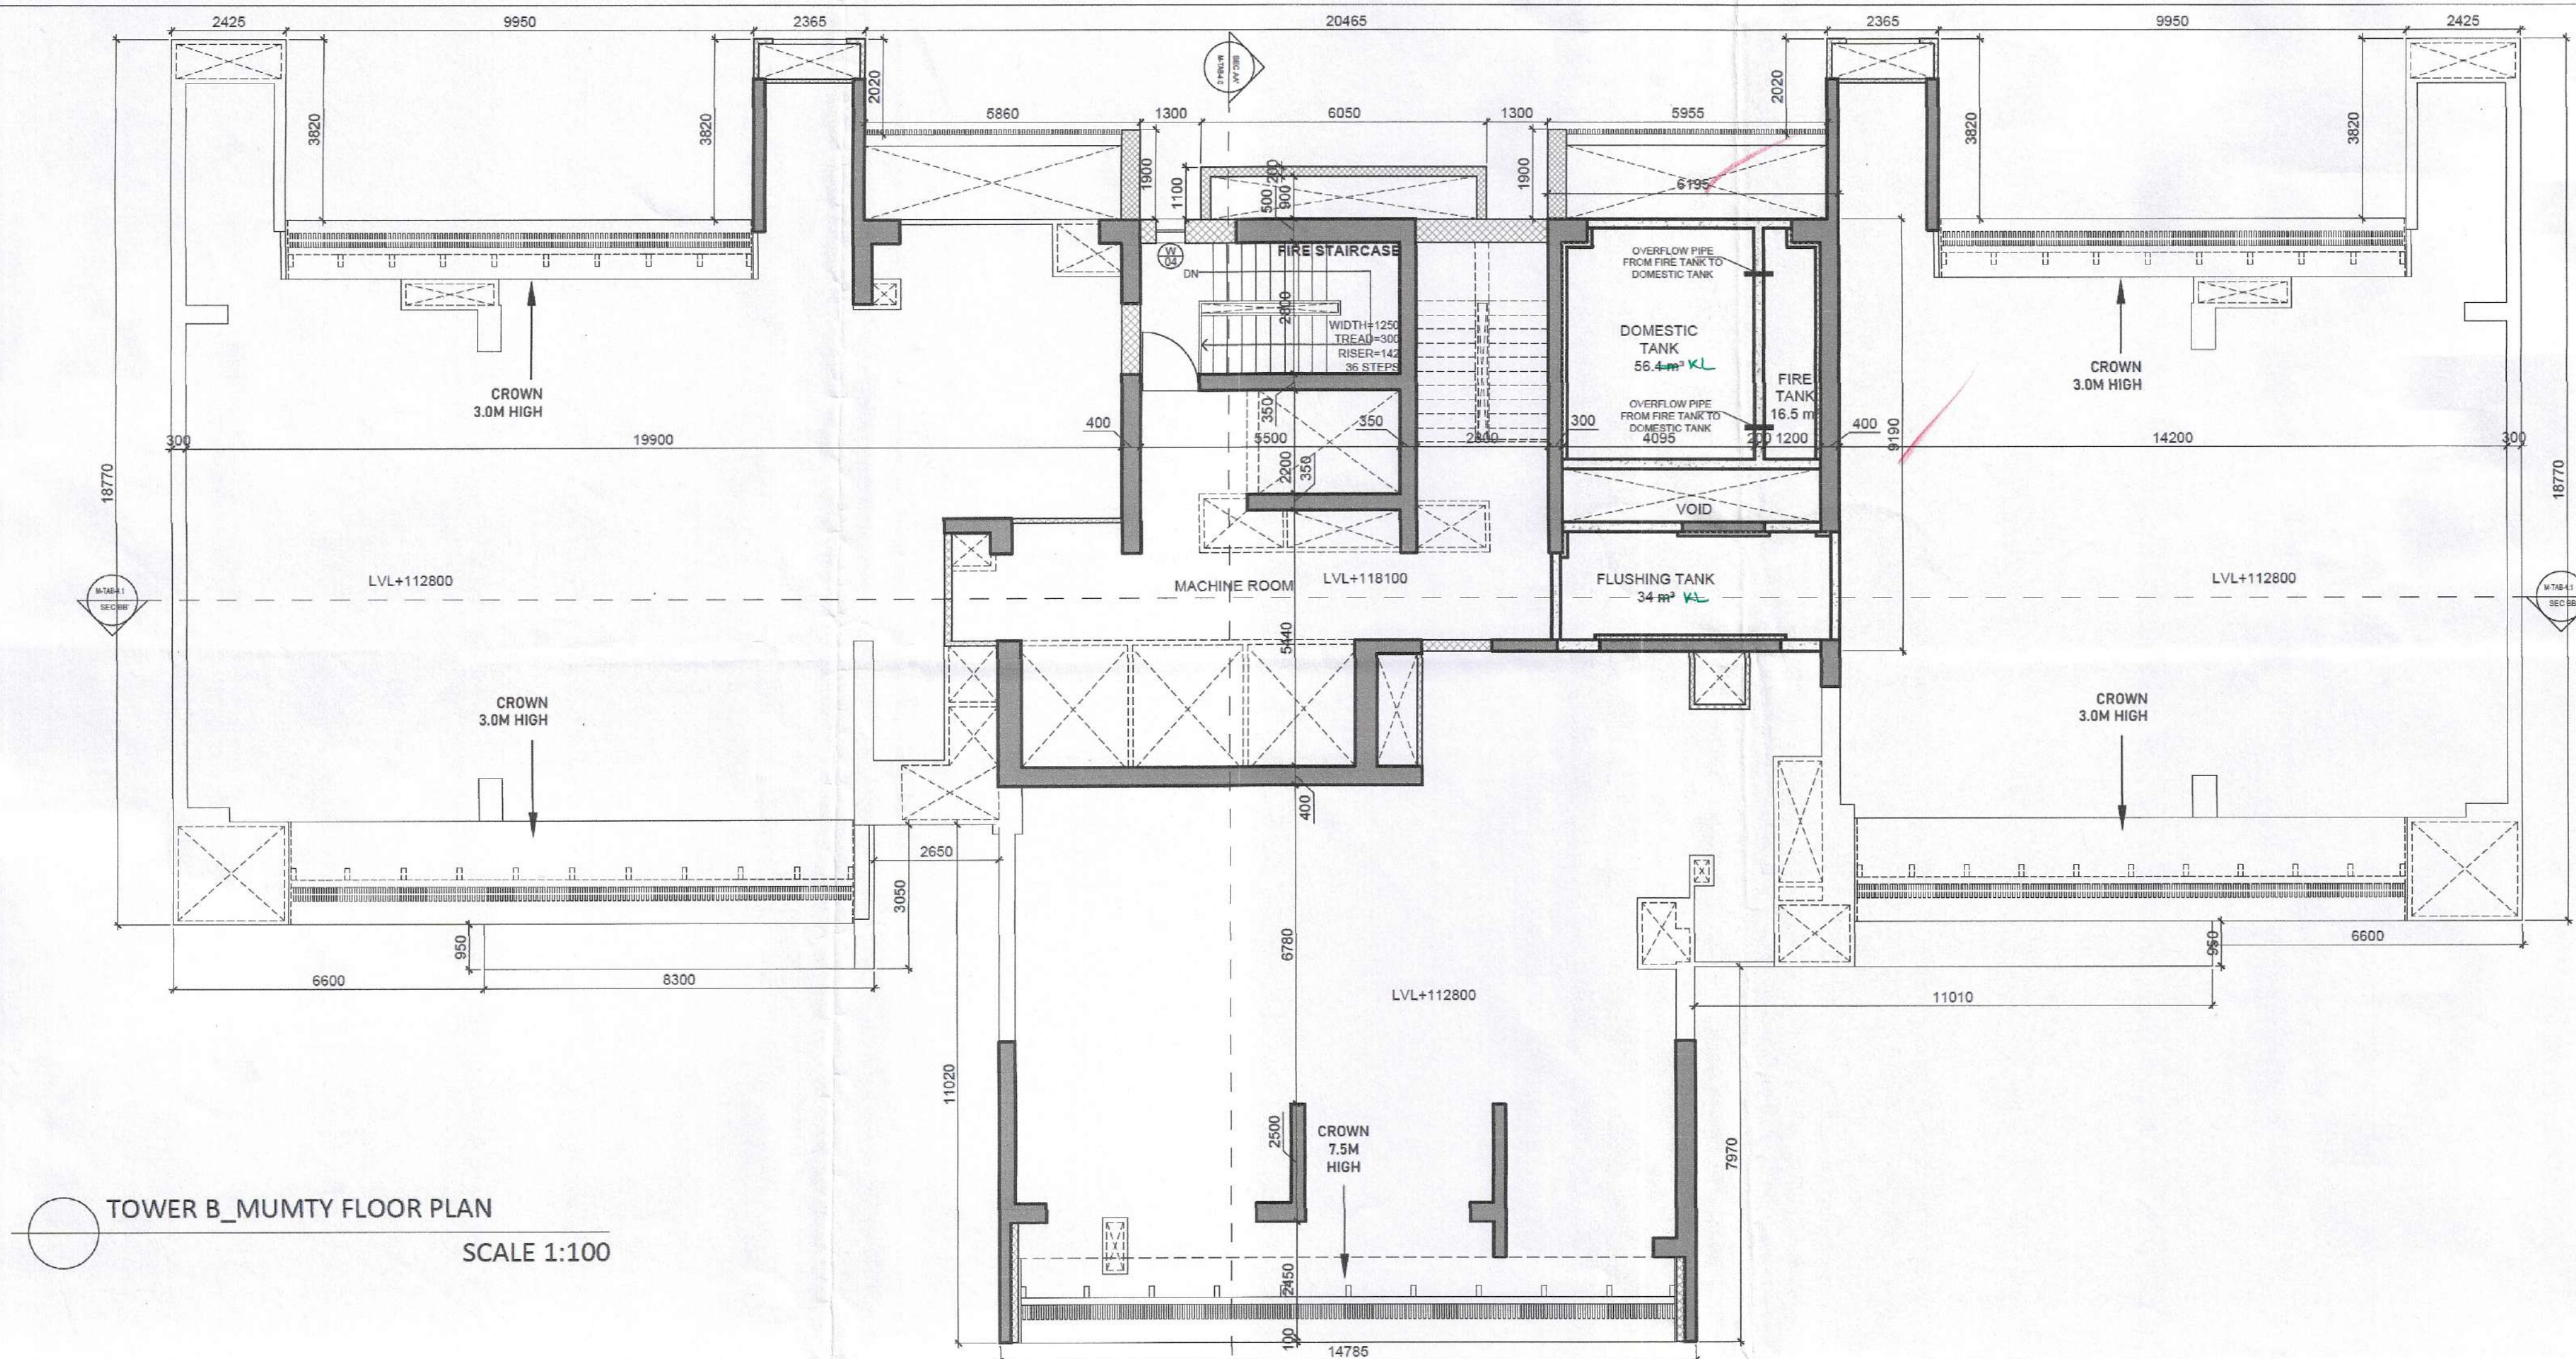

TOWER B_MUMTY FLOOR PLAN
SCALE 1:100

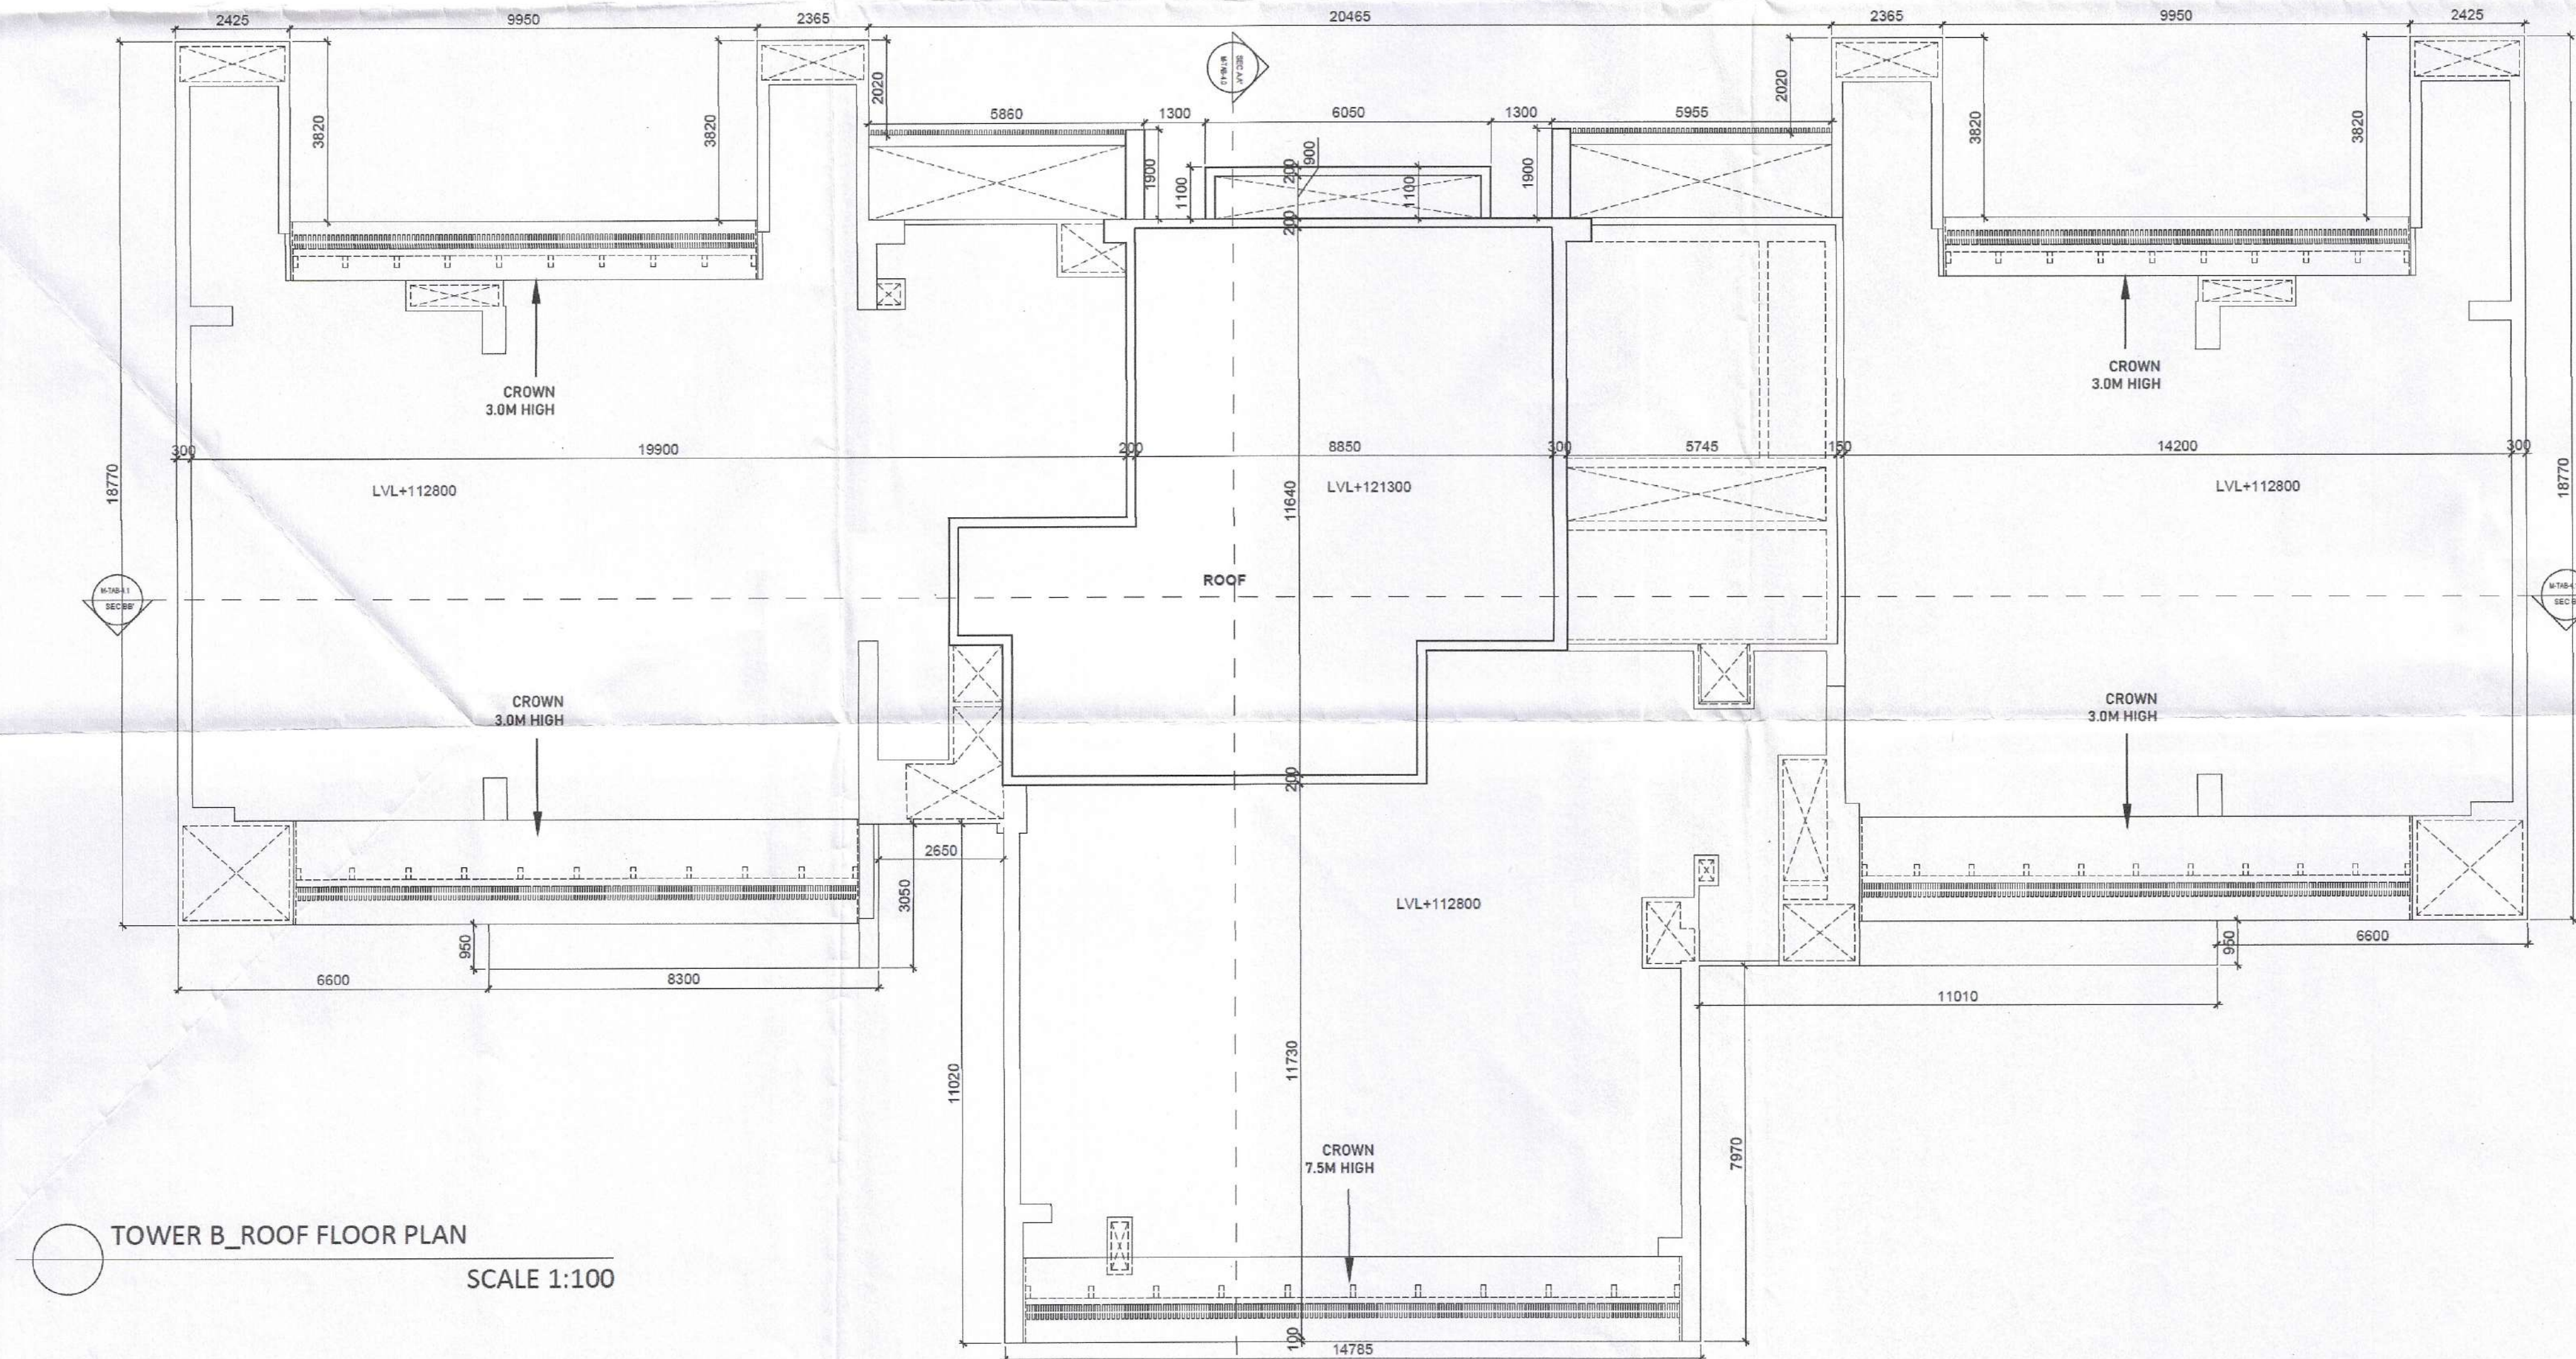

TOWER B_ROOF FLOOR PLAN
SCALE 1:100

TOWER A&B: Door Window Schedule


DOOR/ WINDOW	WIDTH	HEIGHT	SILL	LINTEL
D01	750	2100	300	2400
D02	800	2400	0	2400
D03	750	2100	300	2400
D04	1050	2400	0	2400
D05	750	2100	300	2400
D08	900	2600	0	2600
D09	450	2100	300	2400
D13	910	2100	300	2400
D14	800	2600	0	2600
O	0	0	0	0
FD01	1250	2400	0	2400
FD02	1500	2100	300	2400
FD03	900	2400	0	2400
FD04	750	2100	300	2400
FD05	1250	2400	0	2400
FD06	1250	2600	0	2600
O	0	0	0	0
W01	750	2100	300	2400
W02	600	1200	1200	2400
W03	800	800	1200	2000
W04	600	700	1200	1900
W06	2700	1700	900	2600
W07	600	1400	1200	2600
O	0	0	0	0
DW01	2450	2600	0	2600
DW02	2700	2600	0	2600
DW03	1575	2600	0	2600
DW04	2050	2600	0/1200	2600
DW05	7200	2600	0	2600
DW07	3050	2600	0	2600
DW08	3505	2600	0	2600
DW11	1520	2600	0/1200	2600

NOTES :-

- VRV System is being provided.
- Full DG power back up is being provided.
- Toilets are mechanical ventilated.
- All lifts shall have 100% power back-up.
- All electrical installations shall be as per provision of NBC.
- Fire-fighting/safety provisions will be as per relevant NBC provisions.
- Basement area shall have mechanically ventilated as per relevant code.
- All toilets are ventilated as per Haryana Building Code 2017.
- Building has automatic sprinkler system wherever required by NBC.
- Building will be designed (structures) as per relevant I.S. codes for earthquake resistance.
- Solar panels of required capacity shall be provided on roof top as per hareda/zoning norms.
- All handicap ramps with railing.
- All fire fighting installations shall be as per provision of NBC.
- The rainwater harvesting system shall be provided as per central ground water authority norms.

TOWER B: MUMTY FLOOR NON FAR CALCULATION

S.NO.	LENGTH(M)	WIDTH(M)	NO.	AREA(SQ.M.)
1	6.195	9.120	1	56.522
TOTAL ADDITIONS (A)				56.522

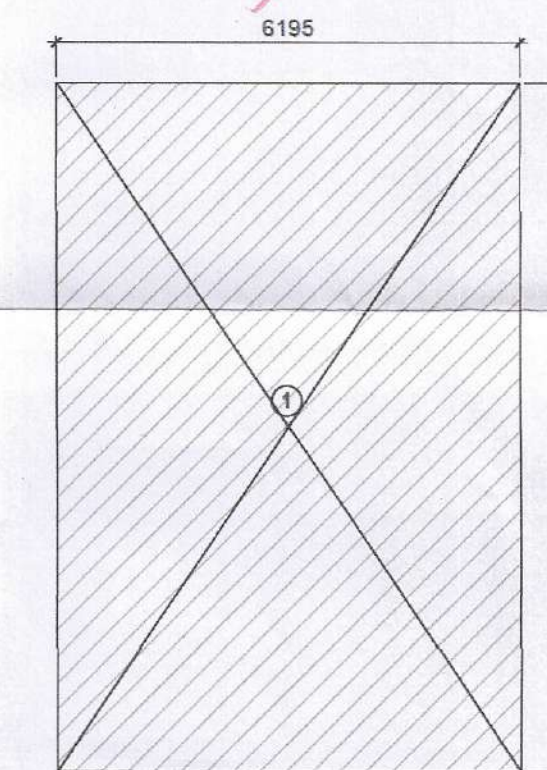

TOWER B_MUMTY FLOOR AREA DIAGRAM
SCALE 1:100

CONCEPT ARCHITECTS:
D P ARCHITECTS

STRUCTURAL CONSULTANTS:
KELKAR DESIGNS PVT. LTD.

MEP CONSULTANTS:
CESPL PVT LTD.


DEVELOPER:
GODREJ PROJECTS DEVELOPMENT LIMITED

ARCHITECT OF RECORD:
ARCHITECTURE COLLECTIVE

**PROPOSED BUILDING PLAN OF
GROUP HOUSING SITE NO. 25
AT SECTOR 43, GURUGRAM**

(Internal) Service of / subject to comments in
in forwarding letter No. 224496-DV/14/12/24

**TOWER B
MUMTY AND ROOF FLOOR PLAN**
Permitting Engineer(HQ)
O/o Chief Engineer-II,
HSVP, Panchkula

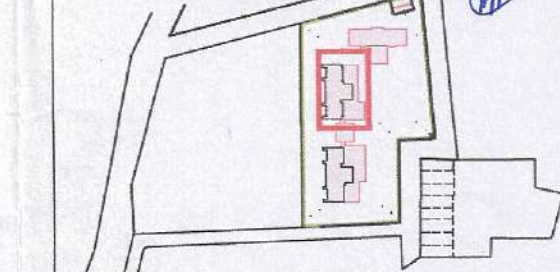

DRG. NO. M-TB-2.11
SCALE: 1:100
DATE:
DEALT: VANSHICA
OWNER'S SIGN: Godrej Projects Development Limited
ARCHITECT SIGN AND STAMP: GAURAV SAMAN
For C.O. [Signature]
Authorised Signatory