




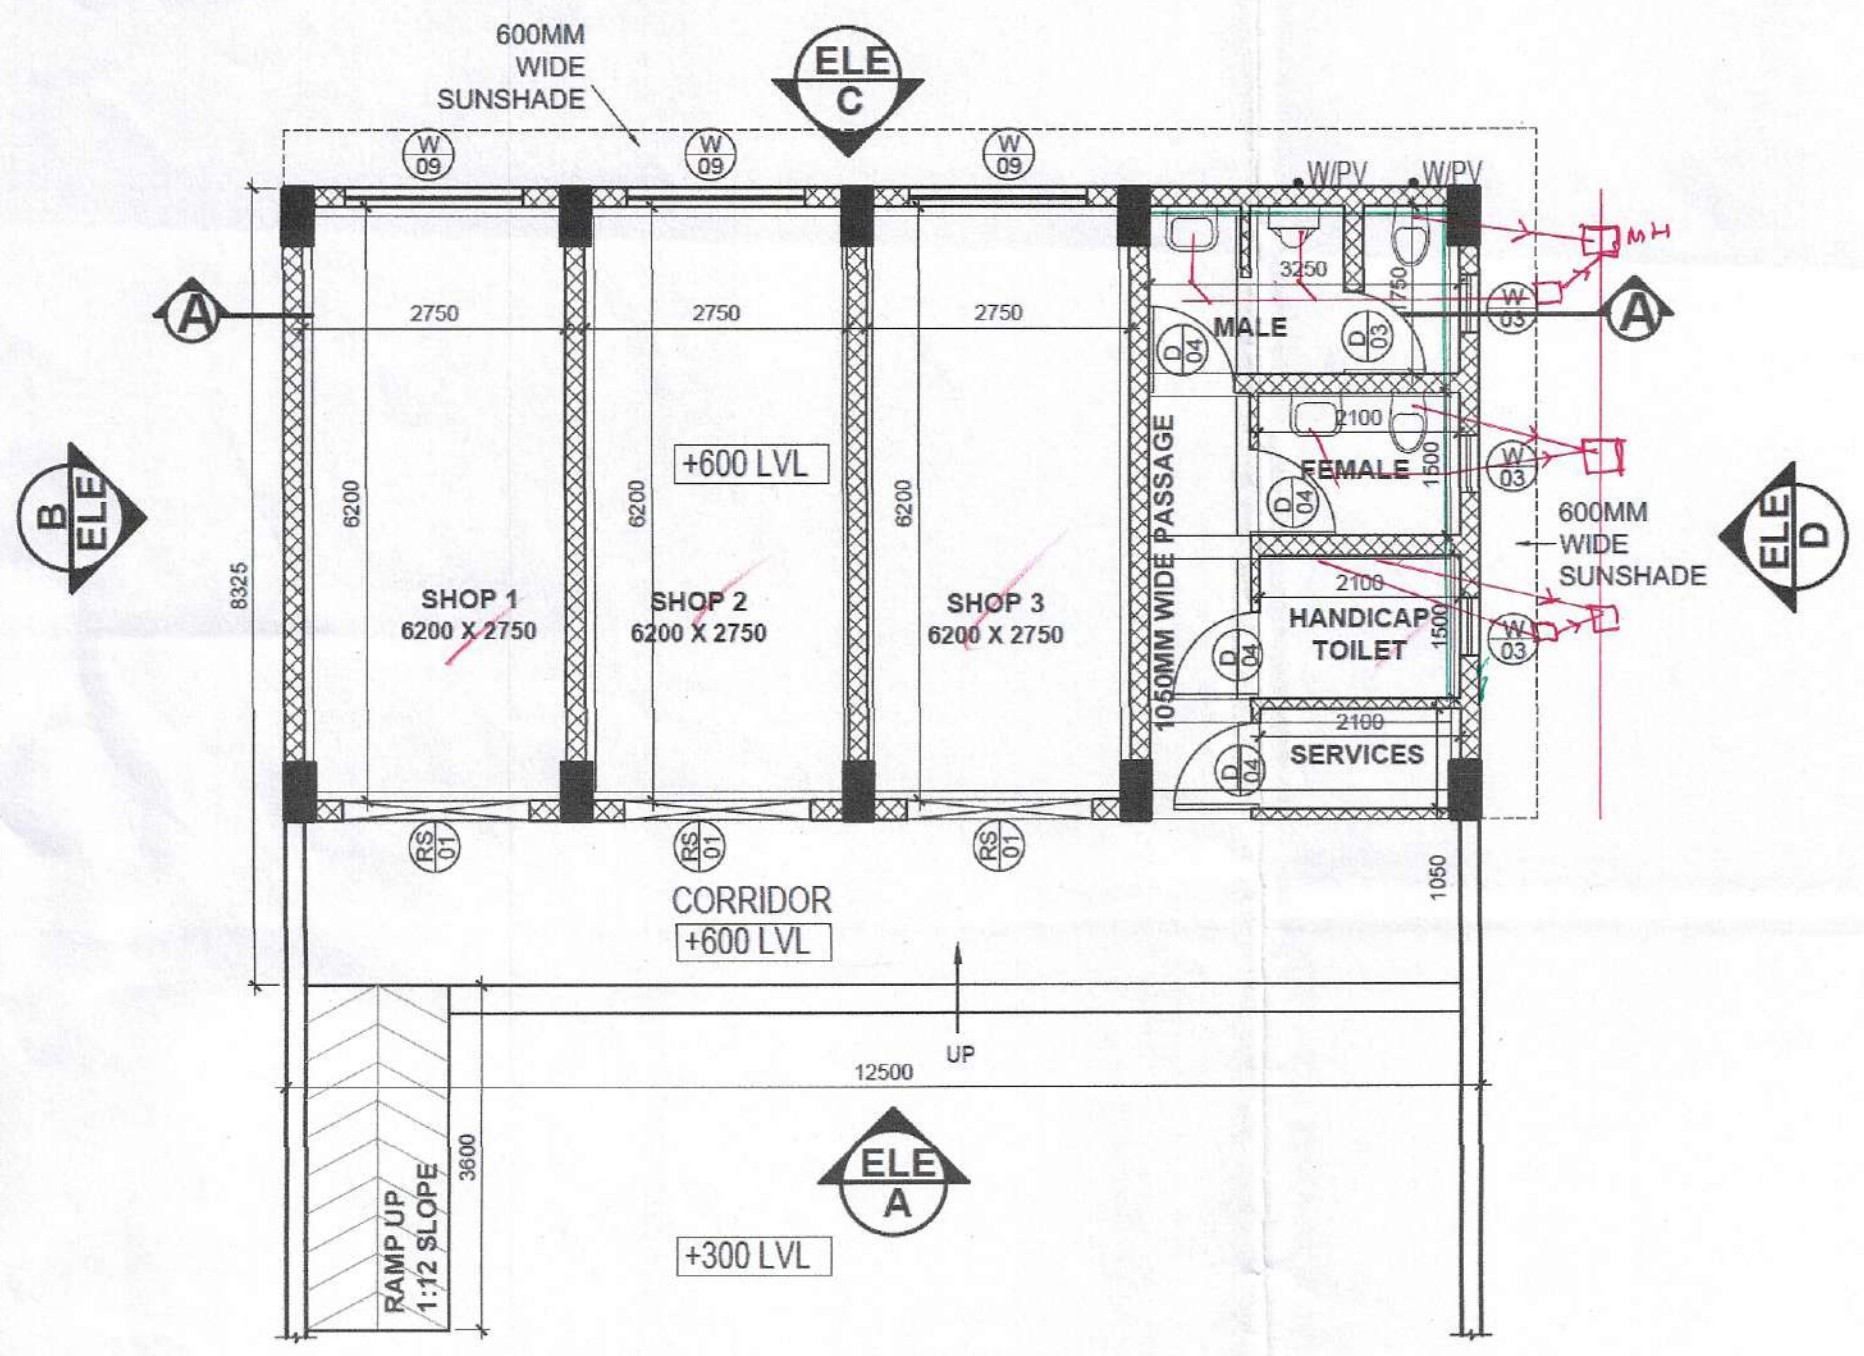

CONVENIENT SHOP_GROUND FLOOR PLAN
SCALE 1:75

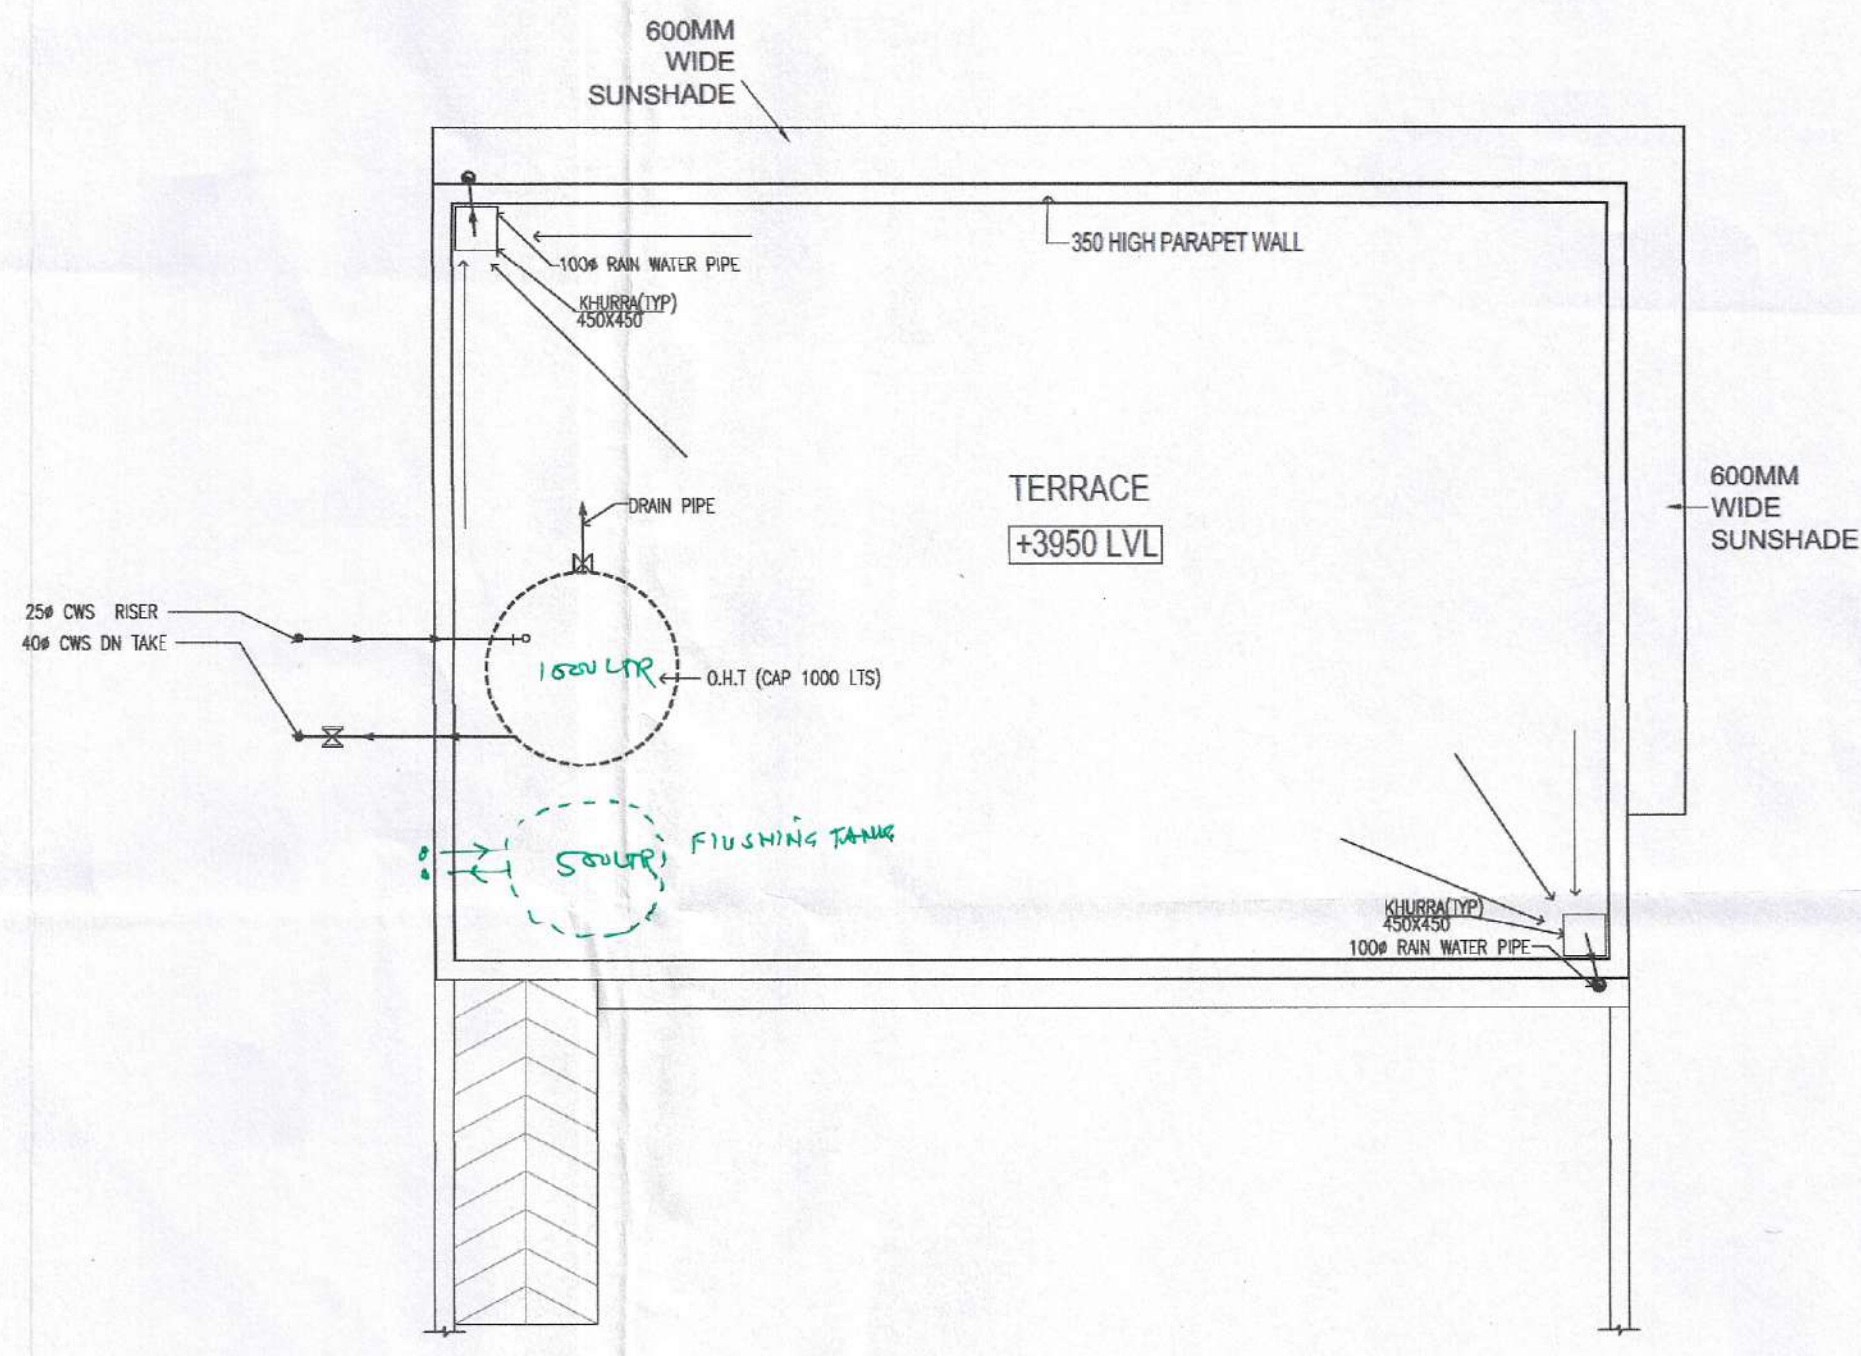


CONVENIENT SHOP_TERRACE FLOOR PLAN
SCALE 1:75

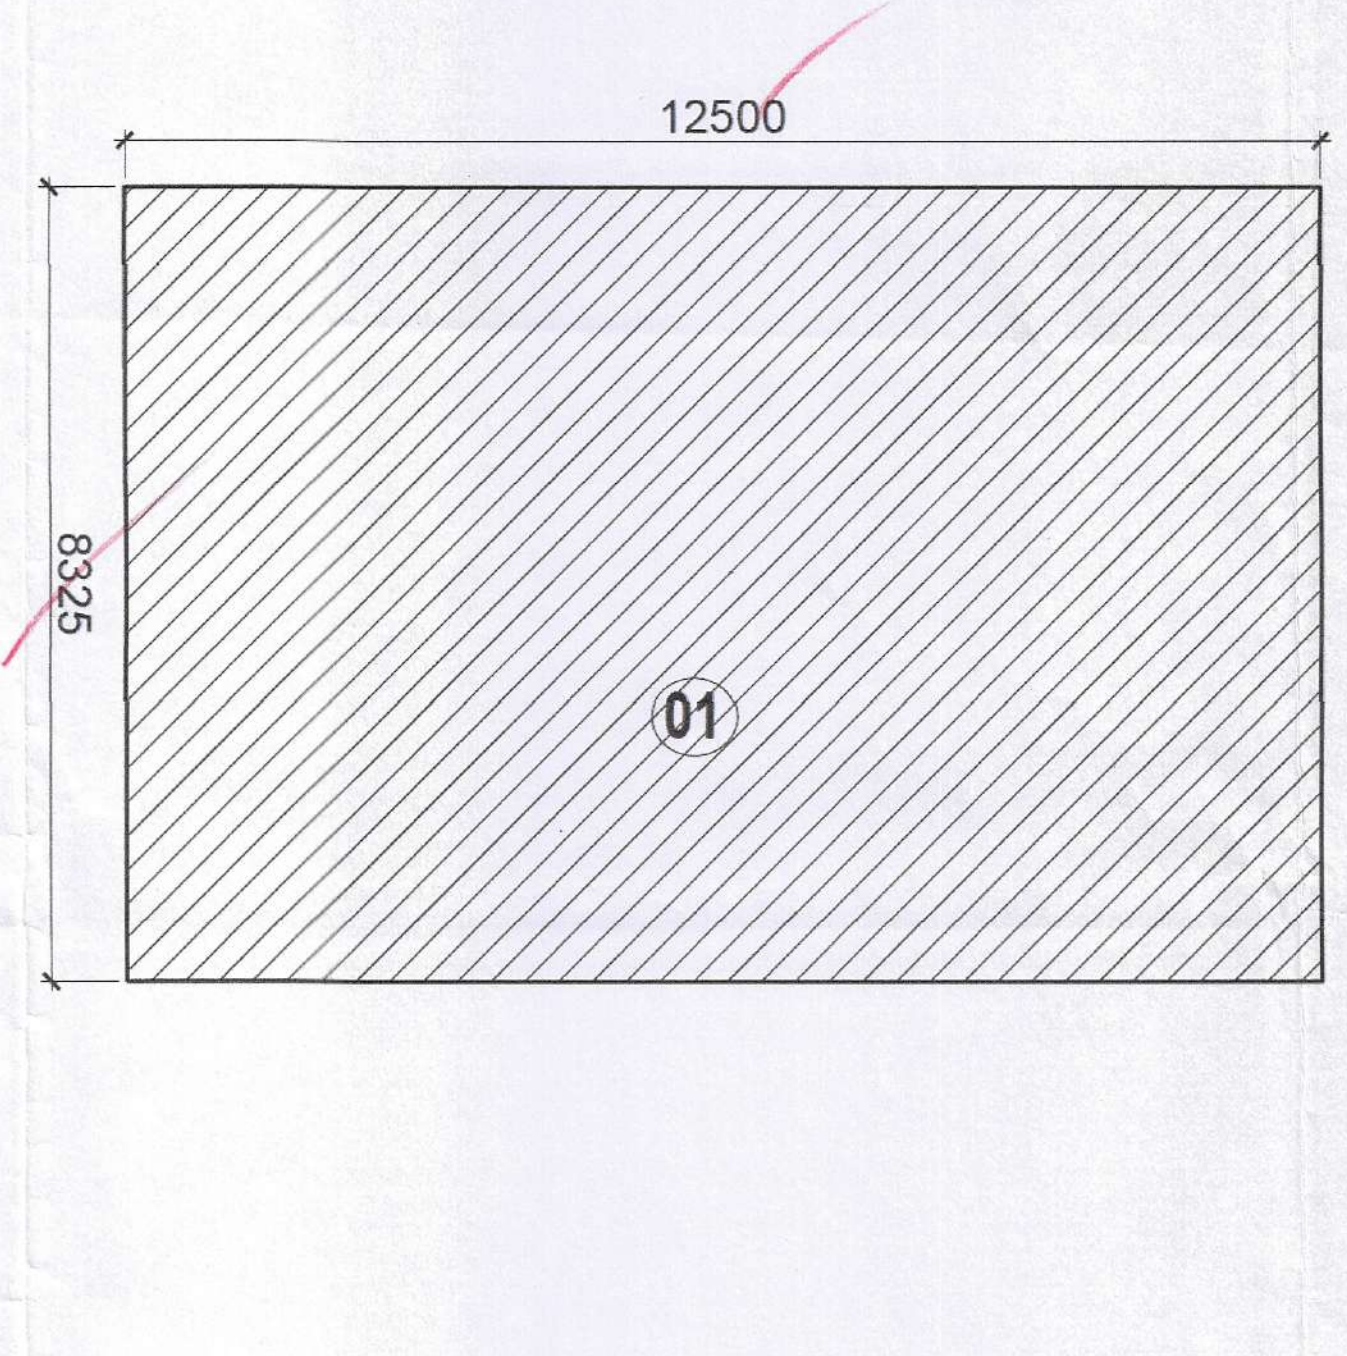


CONVENIENT SHOP_GROUND FLOOR AREA DIAGRAM
SCALE 1:75




CONVENIENT SHOP_SECTION A
SCALE 1:75

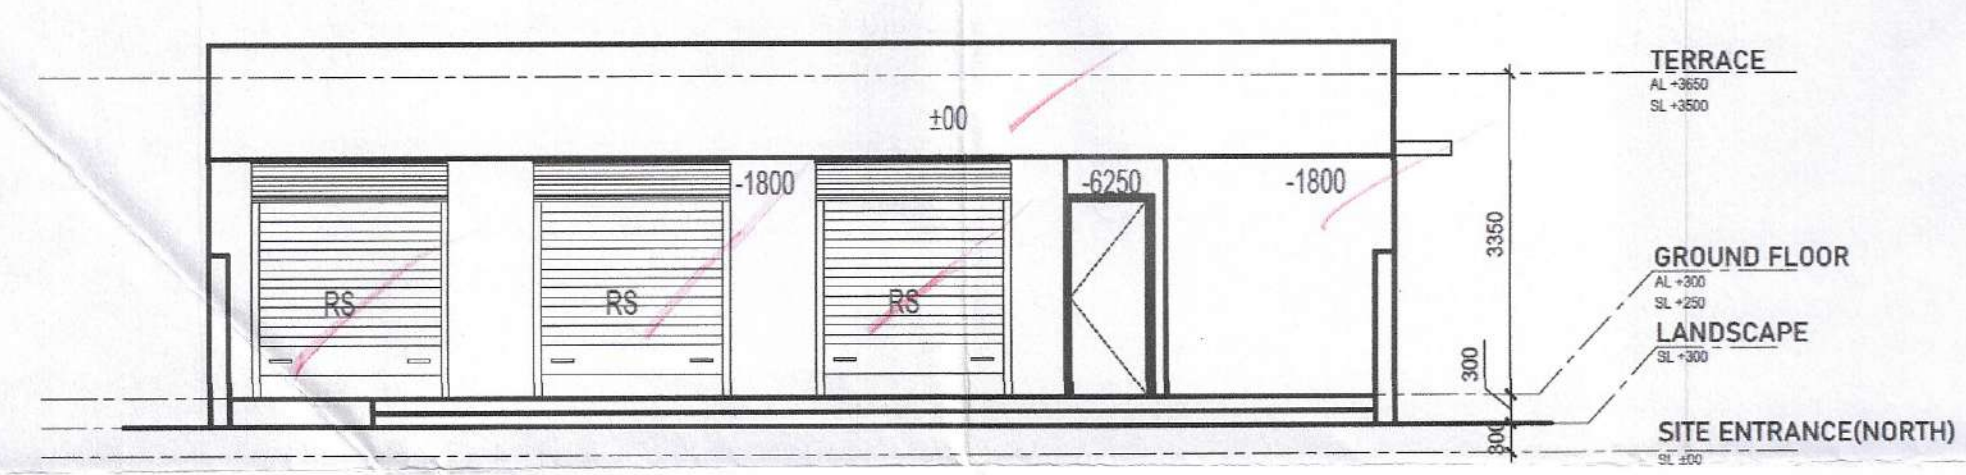


CONVENIENT SHOP_ELEVATION A
SCALE 1:75

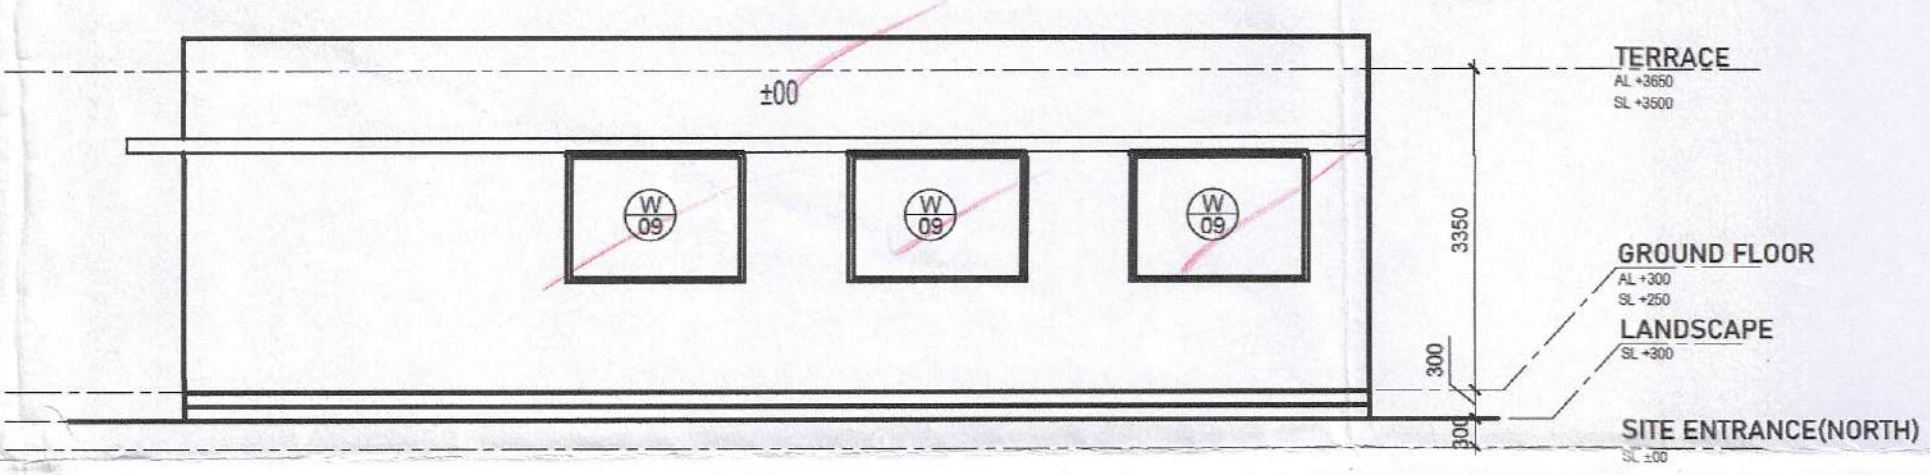

CONVENIENT SHOP_ELEVATION C
SCALE 1:75

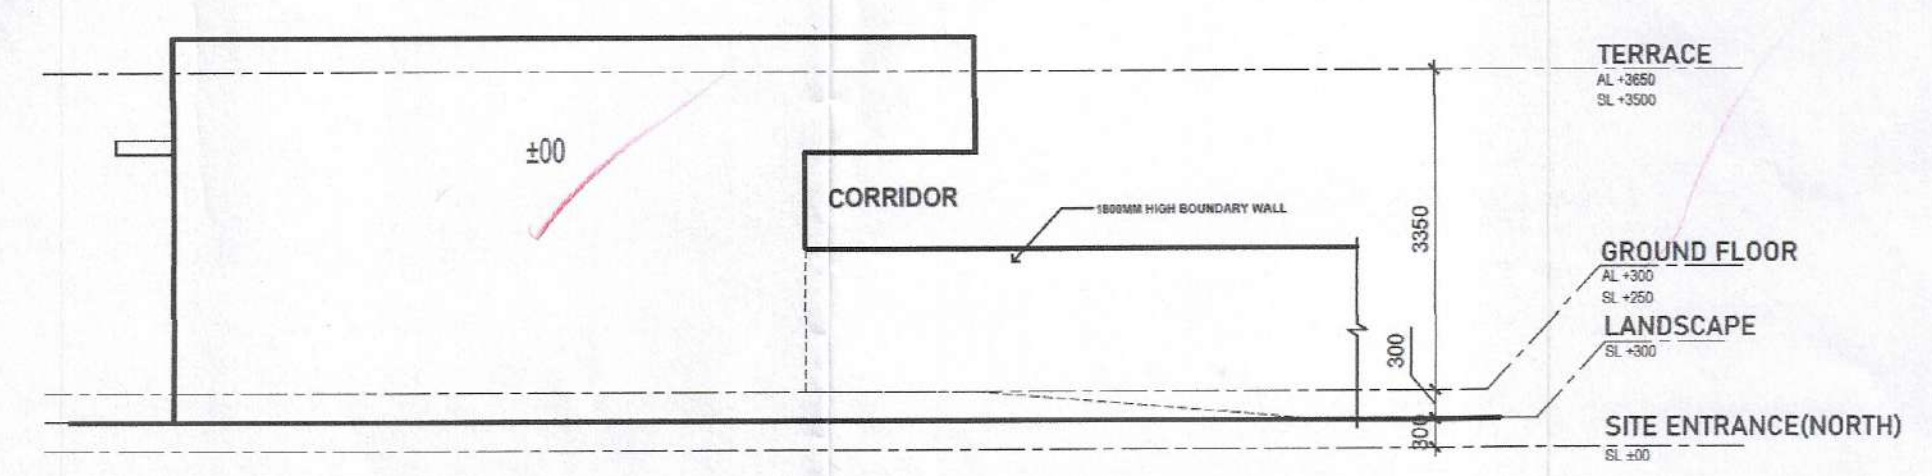

CONVENIENT SHOP_ELEVATION B
SCALE 1:75

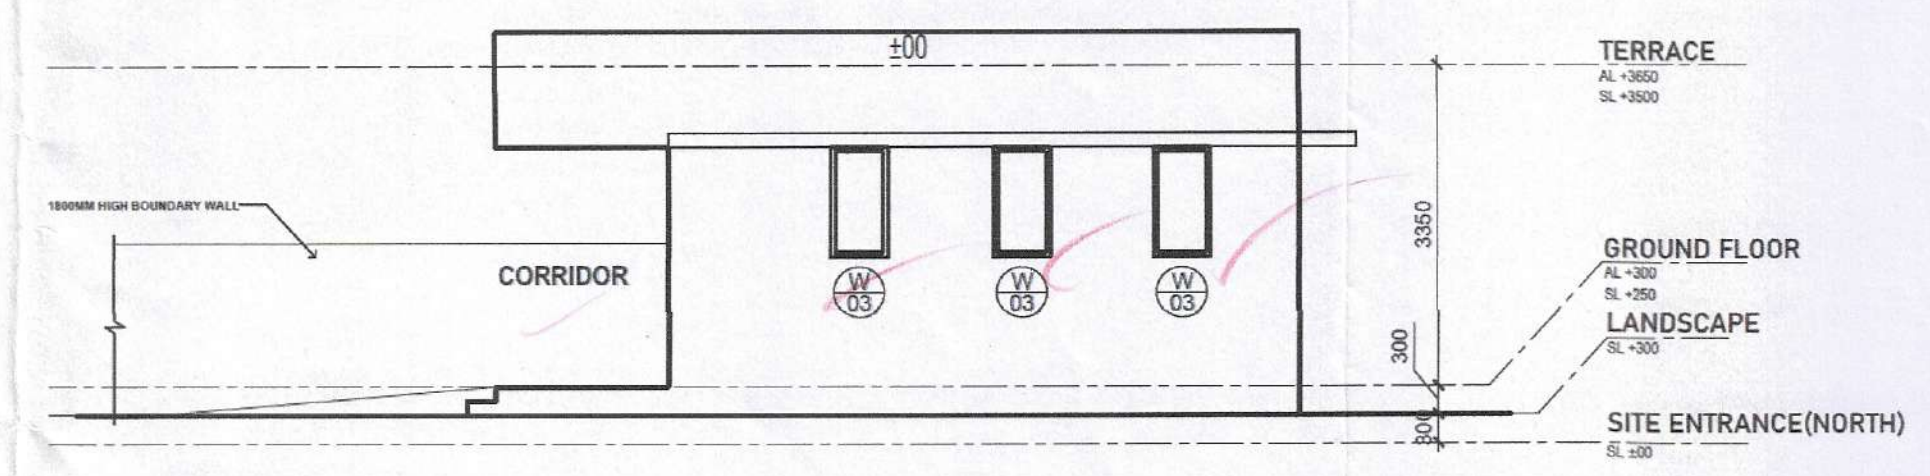

CONVENIENT SHOP_ELEVATION D
SCALE 1:75

SR.NO.	NAME	SIZE	CHL. LVL.	UNTEL. LVL.
1.	D04	900 X 2100	±00	+2100
2.	D03	850 X 2100	±00	+2100
3.	RS	1950 X 2500	±00	+2500
4.	W9	1860 X 1350	+1150	+2500
5.	W3	600 X 1350	+1150	+2500

GROUND FLOOR AREA CALCULATION				
S.NO.	LENGTH(M)	WIDTH(M)	NO.	AREA(SQ.M.)
COVERED AREA				
1	12.500	8.325	1	104.063
TOTAL ADDITIONS (A)				104.063
F.A.R= COVERED AREA (A) - DEDUCTION (B)				104.063
NET GROUND COVERAGE				104.063

DTP (HQ)
Member Secretary
BPAC

STP
Member
BPAC

CTP
Chairman
BPAC

Recommended for Sanction
Senior Town Planner
HUDA, Gurugram
Member BPAC

DDT (T)
MEMBER
BPAC

- NOTES :-
- VRV System is being provided.
 - Full DG power back up is being provided.
 - Toilets are mechanical ventilated.
 - All lifts shall have 100% power back-up.
 - All electrical installations shall be as per provision of NBC.
 - Fire-fighting/safety provisions will be as per relevant NBC provisions.
 - Basement area shall have mechanically ventilated as per relevant code.
 - All toilets are ventilated as per Haryana Building Code 2017.
 - Building has automatic sprinkler system wherever required by NBC.
 - Building will be designed (structures) as per relevant I.S. codes for earthquake resistance.
 - Solar panels of required capacity shall be provided on roof top as per hareda/zoning norms.
 - All handicap ramps with railing.
 - All fire fighting installations shall be as per provision of NBC.
 - The rainwater harvesting system shall be provided as per central ground water authority norms.

CONCEPT ARCHITECTS:
D P ARCHITECTS

STRUCTURAL CONSULTANTS:
KELKAR DESIGNS PVT. LTD.

MEP CONSULTANTS:
CESPL PVT LTD.

DEVELOPER:
GODREJ PROJECTS DEVELOPMENT LIMITED

ARCHITECT OF RECORD:
ARCHITECTURE COLLECTIVE

PROPOSED BUILDING PLAN OF
GROUP HOUSING SITE NO. 25
AT SECTOR 43, GURUGRAM

Checked and found correct for Public Health
CONVENIENT SHOP subject to comments in
in forwarding letter No. 2244/16 ... Dtd. 14/8/24

Permitting Engineer (HQ)
City Chief Engineer, HVI
HSVP, Panchkula.

DRG.NO. M-CS-2.0

SCALE : 1:75

DATE :

DEALT : VANSHICA

For Development Projects Development Limited

Authorised Signatory

GAURAV SANAN

88

For Development Projects Development Limited

Authorised Signatory