


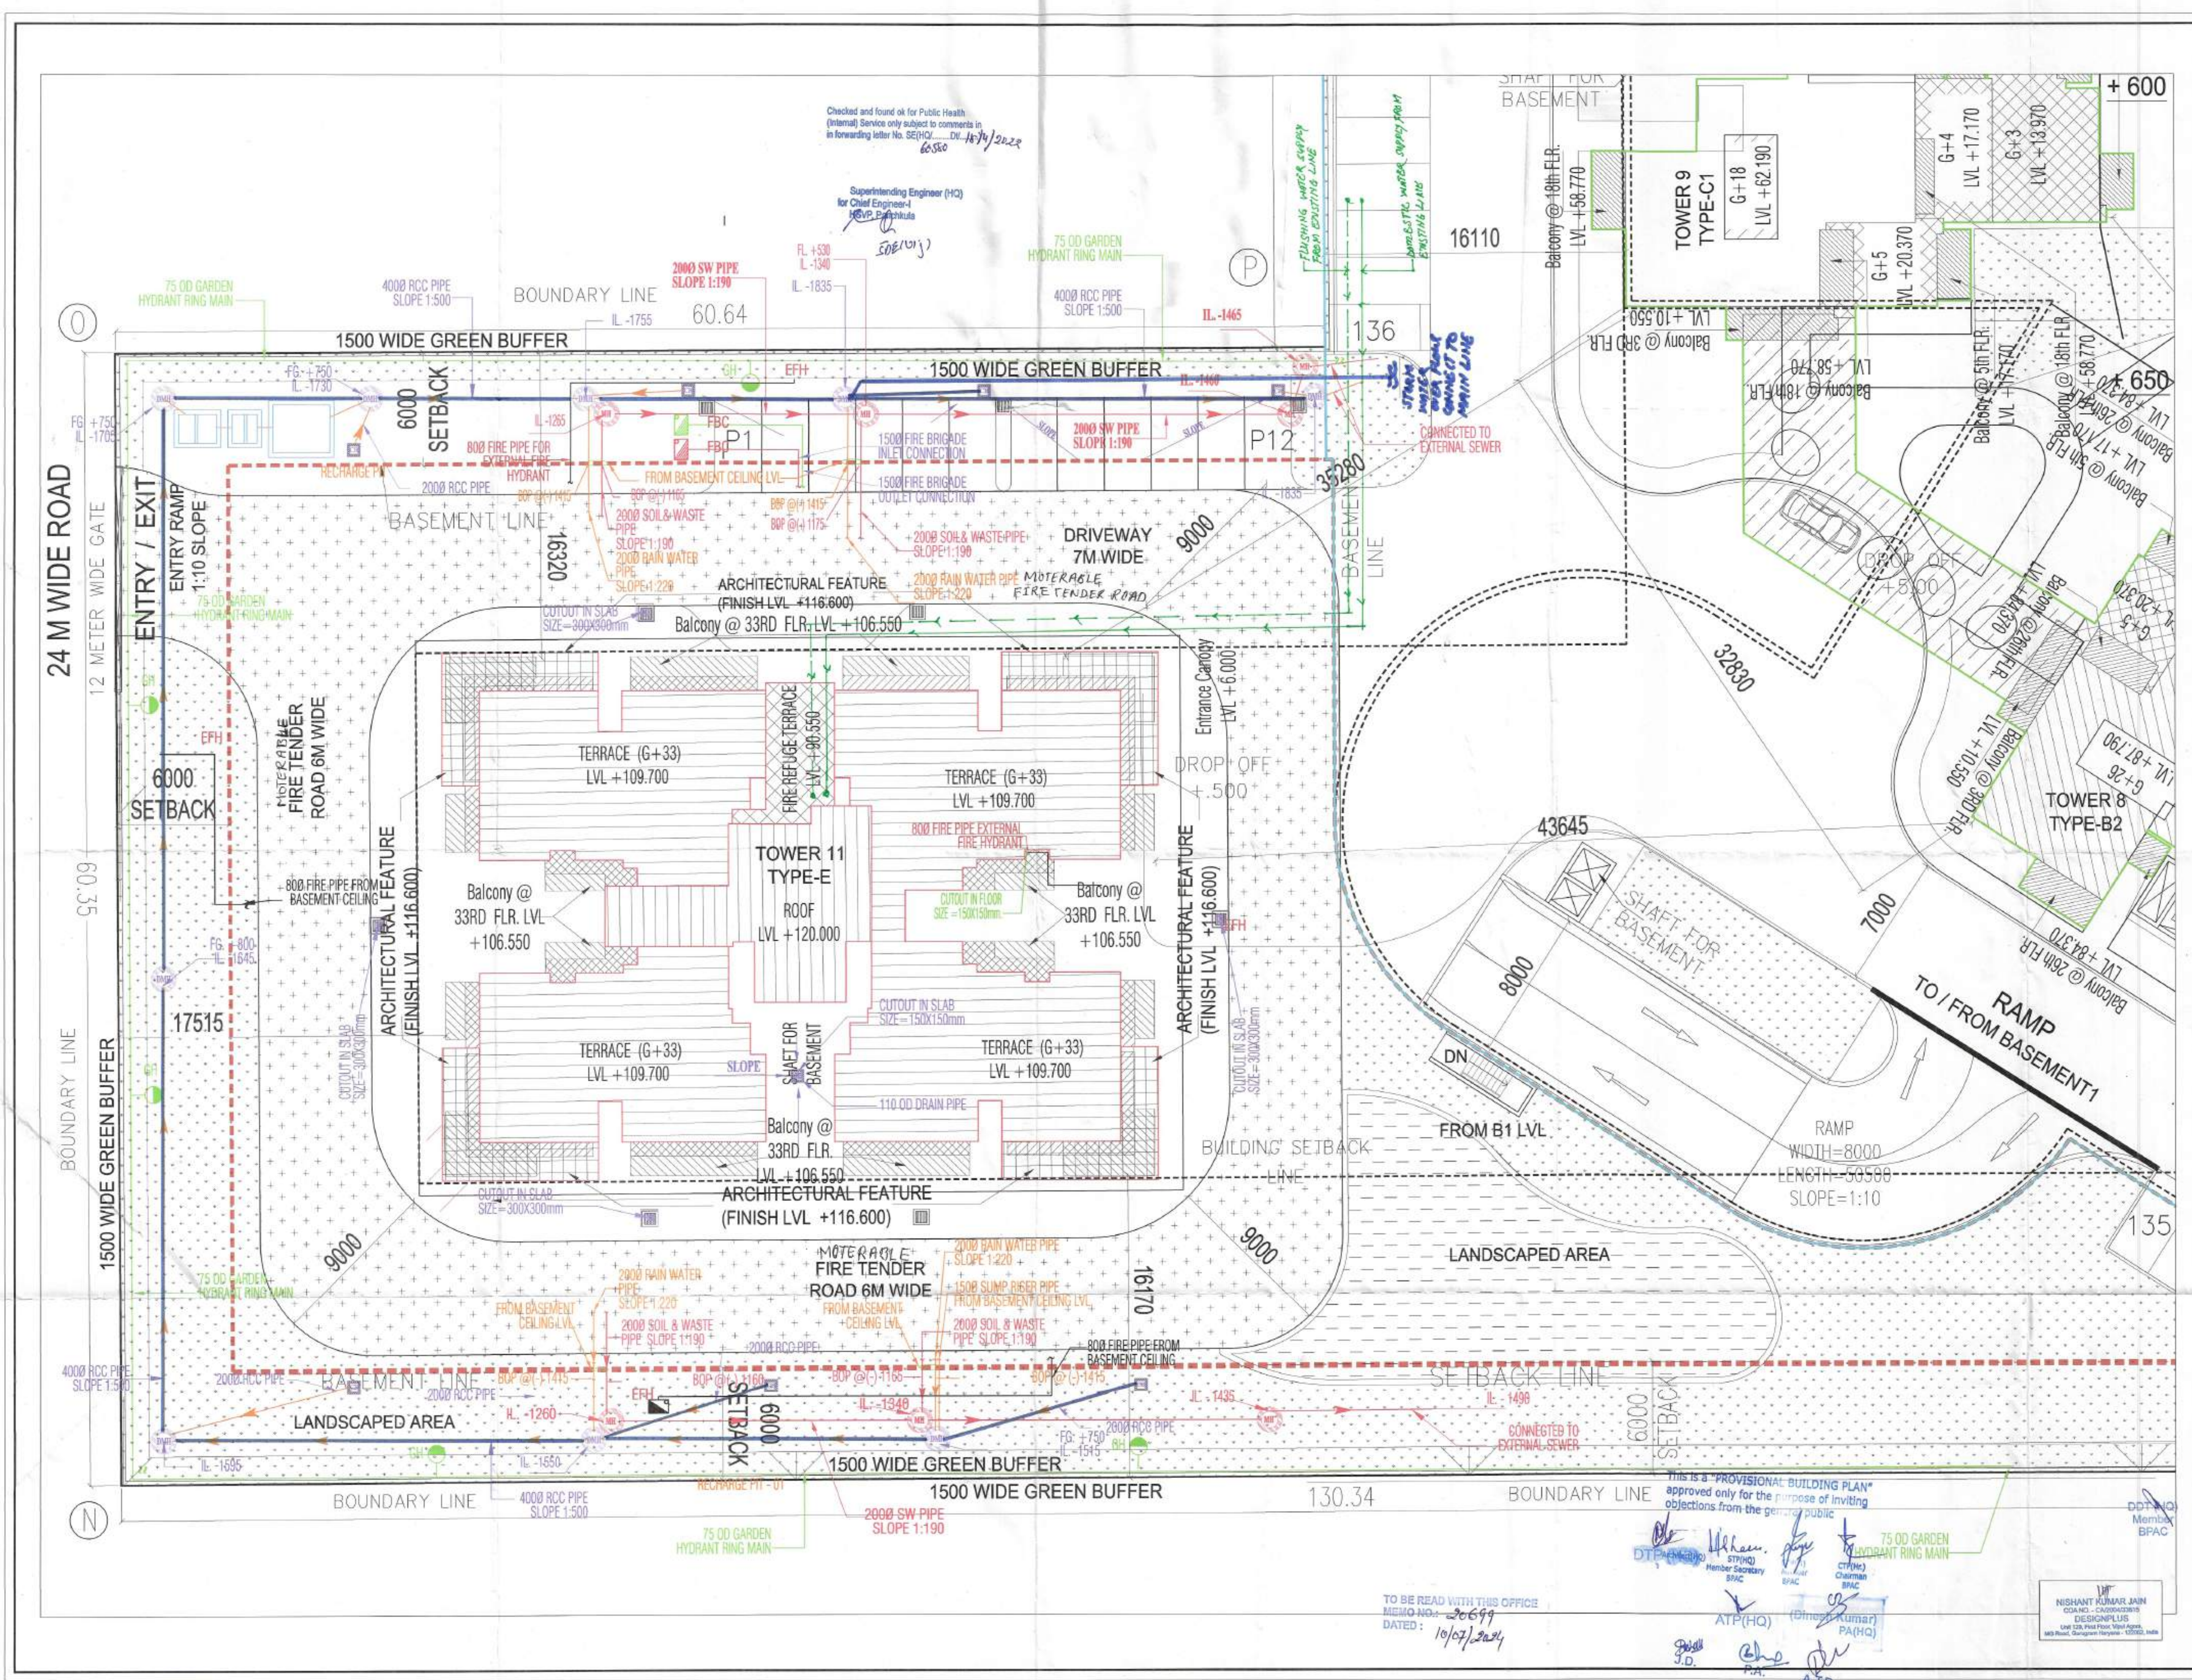

KEY PLAN

OWNER
CONSOLIDATE REALTOR PVT. LTD.

CONSULTANTS
Architect:
DESIGNPLUS ASSOCIATES SERVICES PVT. LTD.
Unit 120, First Floor, Vigna Nagar, M.D. Road, Gurgaon - 122 002, Haryana
Phone: 0122-4145510, Fax: 0122-2411892
Structural Consultant:
MNCPL CONSULTANTS
MNC House
1516, Ring Road, Gurgaon
Phone: 0122-4145510, Fax: 0122-2411892
Planning & Fire Consultant:
C.P. VIDYA & ASSOCIATES
120A, Urban Academy,
South City - 4, Sector 46,
Gurgaon

NOTES:

1. ALL DIMENSIONS ARE IN MM UNLESS OTHERWISE SPECIFIED.
2. ALL DIMENSIONS ARE TO BE READ ONLY AND NOT TO BE MISCARRIED.
3. BUILDING HAS AUTOMATIC FIRE ALARMS AND SMOKE DETECTORS AS PER CODE.
4. BUILDING SHALL BE DESIGNED FOR EARTHQUAKE RESISTANCE AS PER IS 456:2000.
5. ALL TOILETS OR BATH OR W.C. ARE MECHANICALLY VENTILATED.

PROJECT NAME
REVISED BUILDING PLAN OF TOWER - 11 & ADDITIONAL EWS UNITS in Group Housing Colony measuring 13.344 Acres (License No. 53 of 2011, Dated 10.06.2011)
Sector 67, Gurgaon Municipal Urban Complex being developed by Consolidate Realtors Pvt. Ltd.

DRAWING STATUS
SUBMISSION DRAWING

DRAWING TITLE
ICON AT M3M MERLIN (TOWER-11): SITE PLAN

ARCHITECT'S SIGN
NISHANT KUMAR JAIN
10A/101, CHANDANWADI, GURGAON
DESIGNPLUS
Unit 120, First Floor, Vigna Nagar, M.D. Road, Gurgaon - 122 002, Haryana

SCALE
A1, 1:150

DRAWING NUMBER
A-010