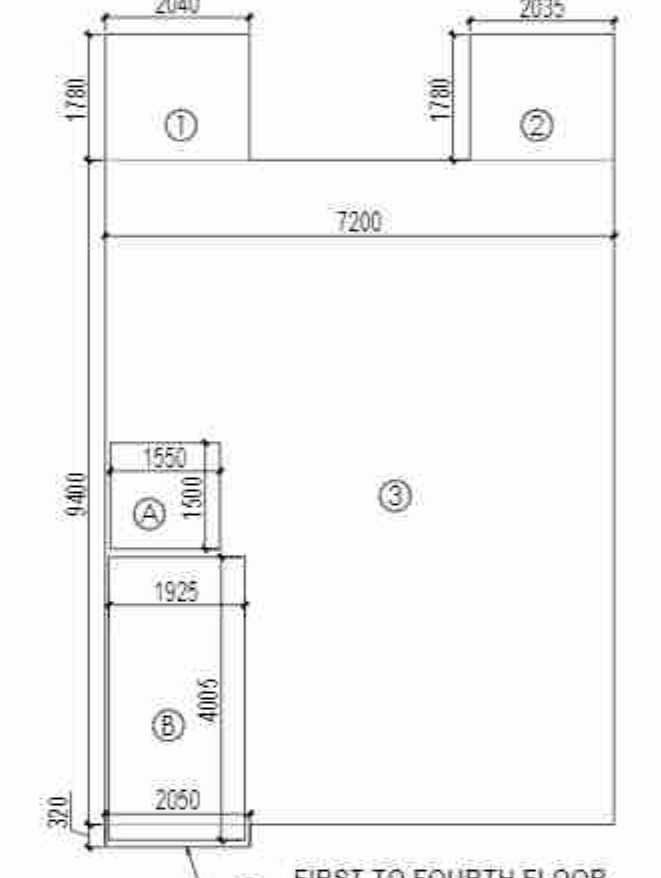
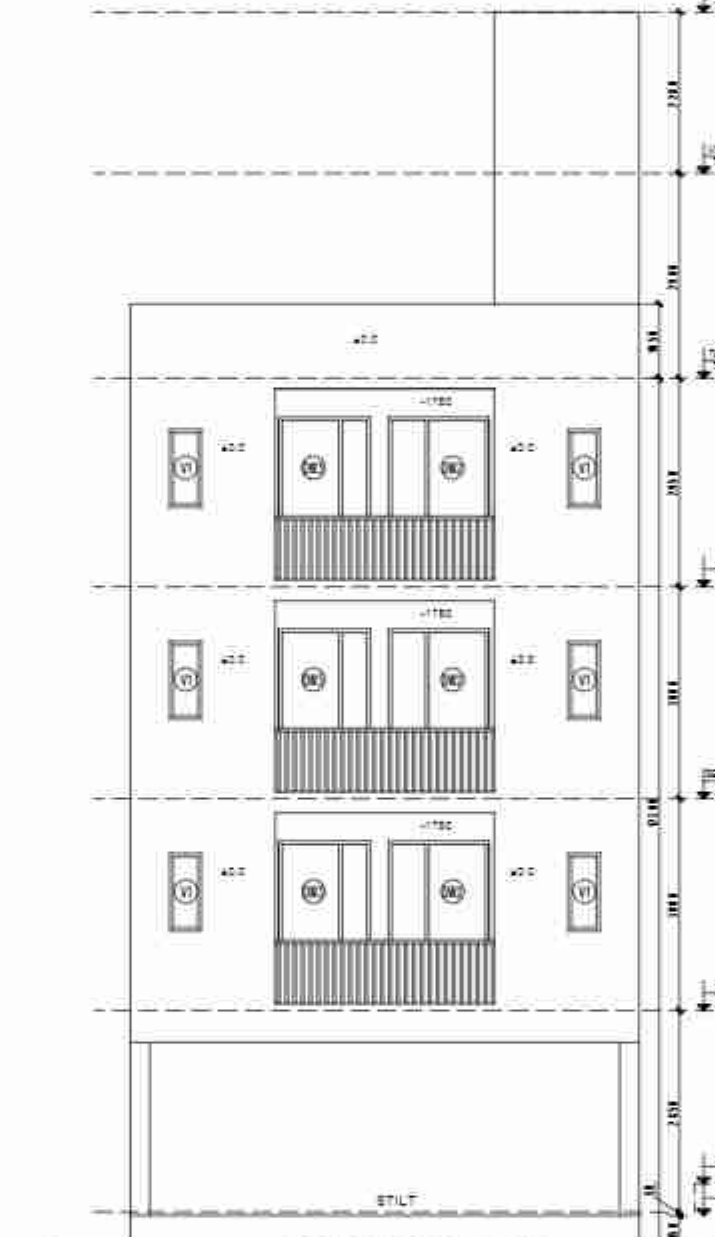
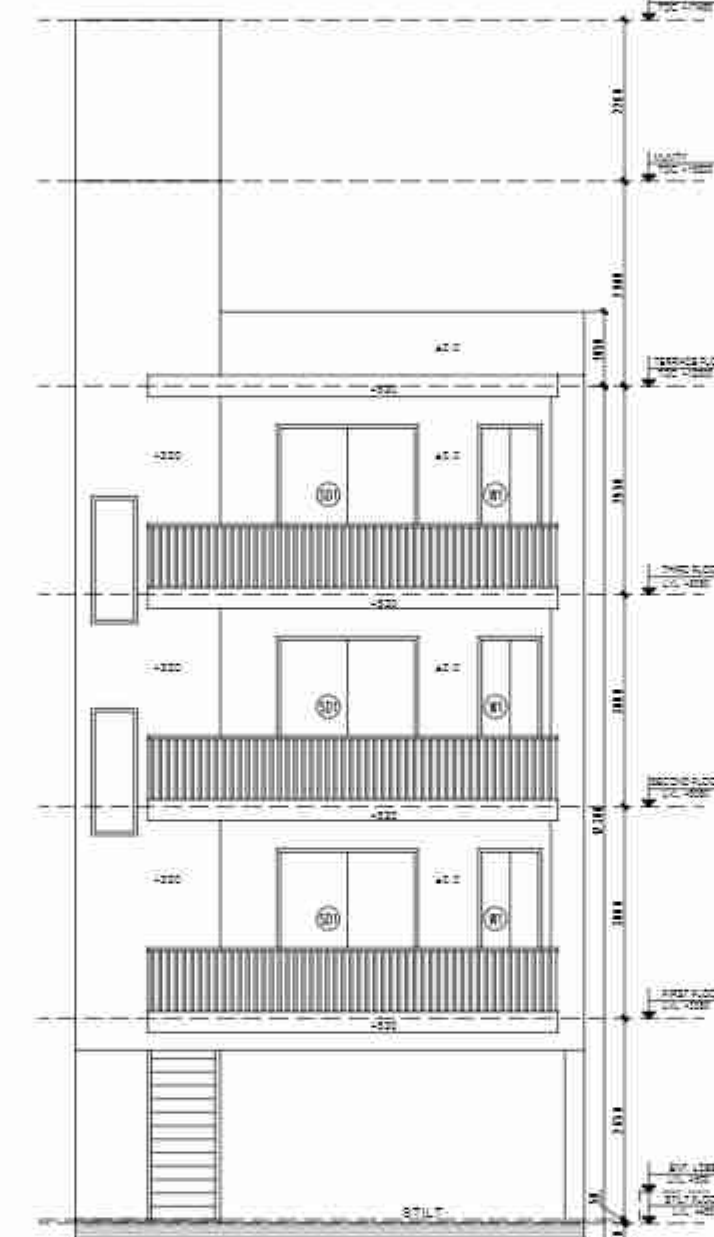
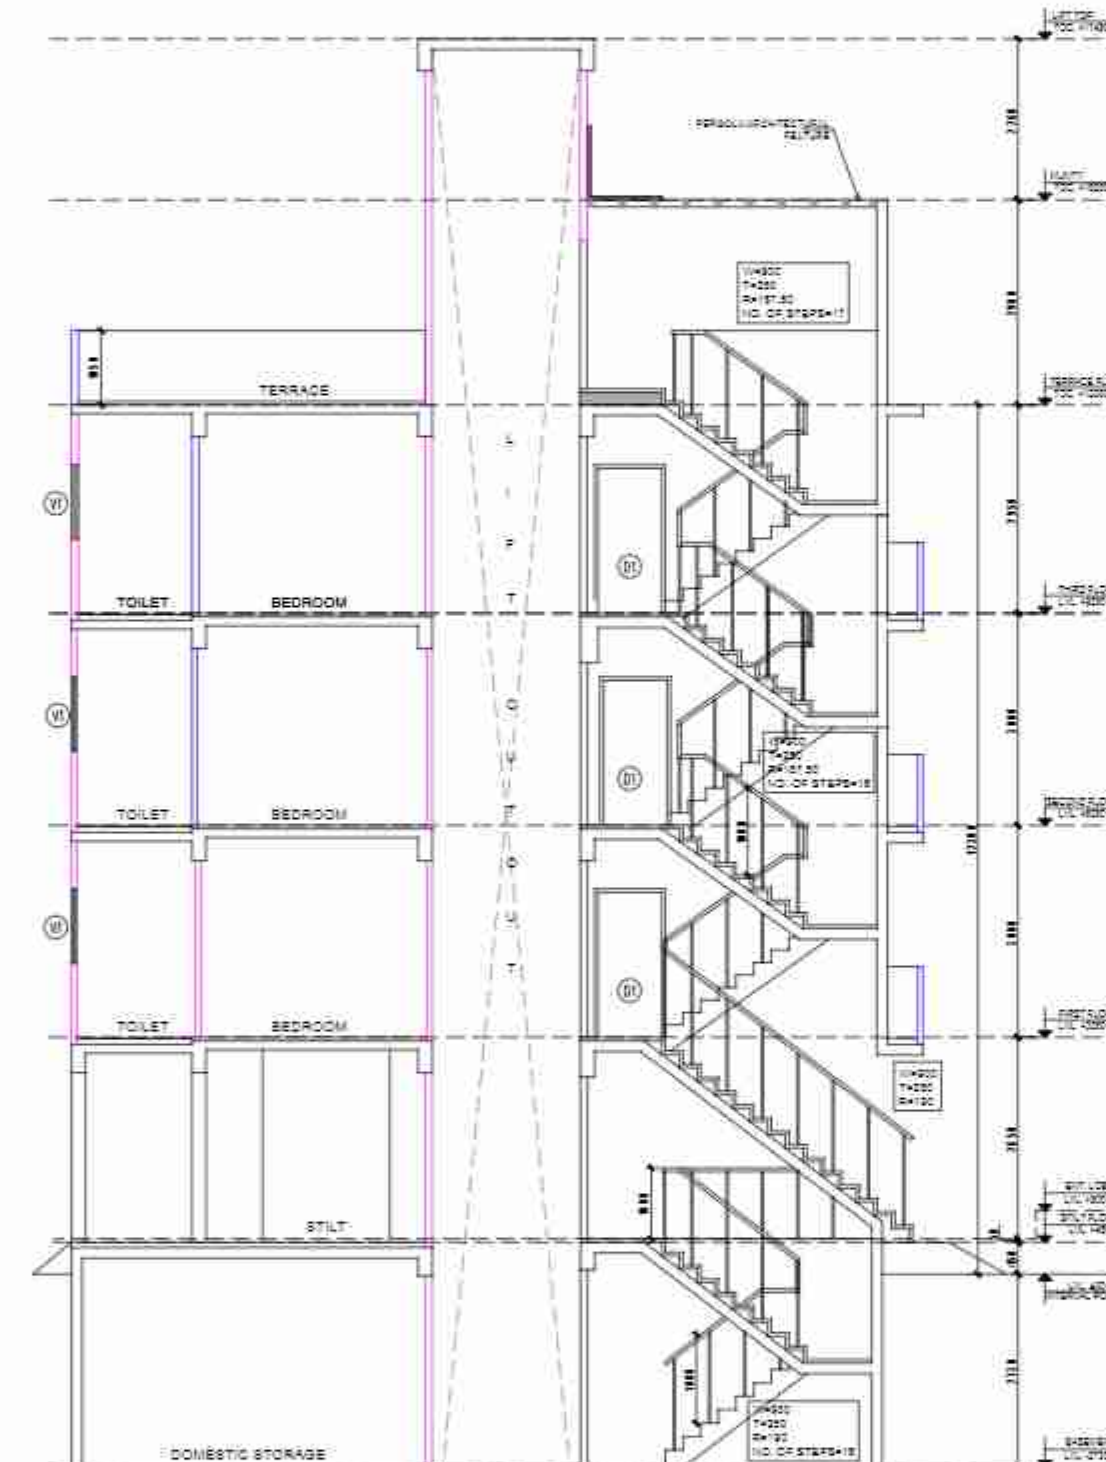
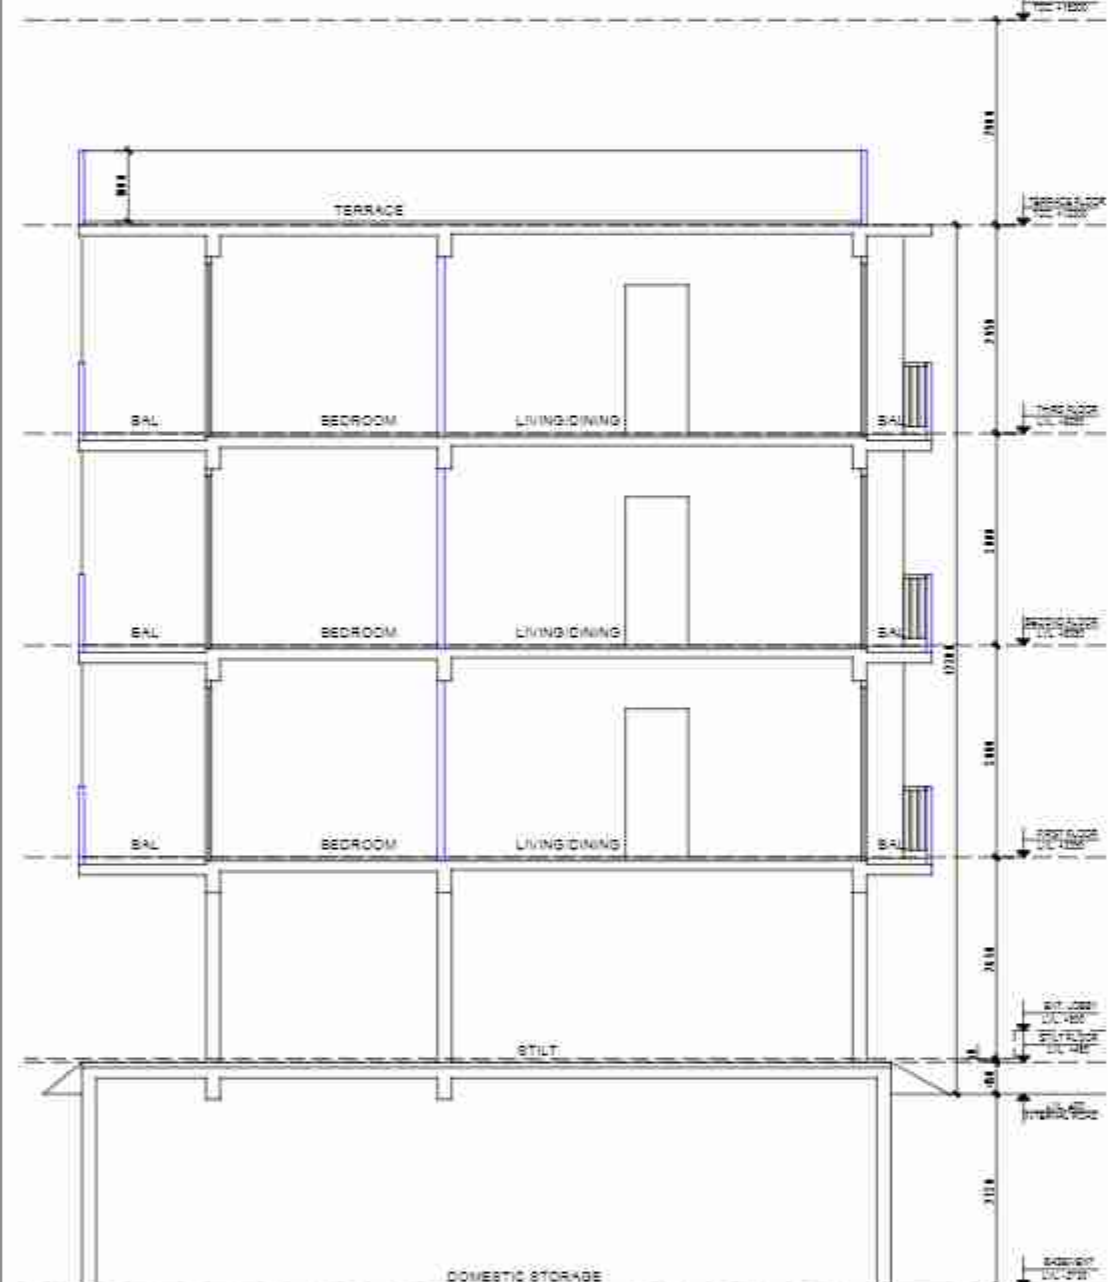
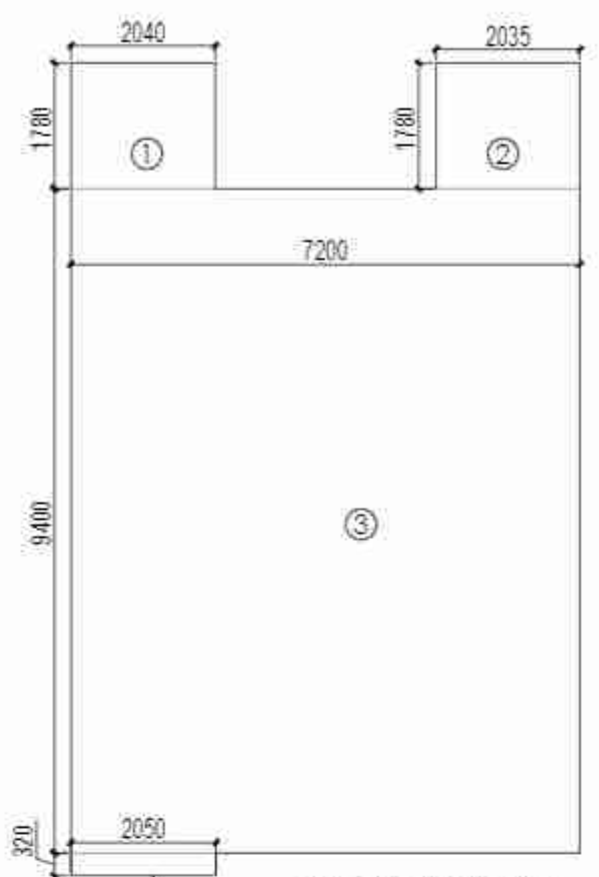
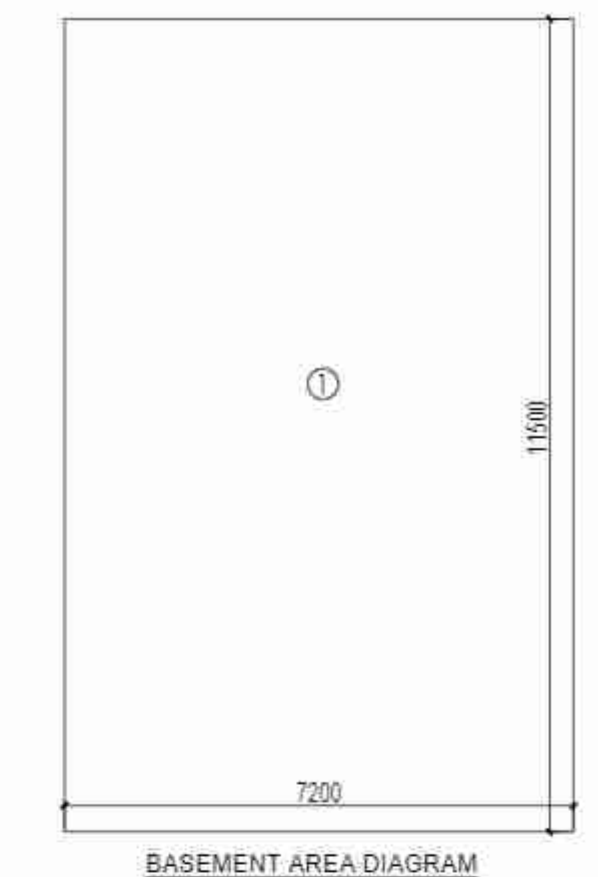
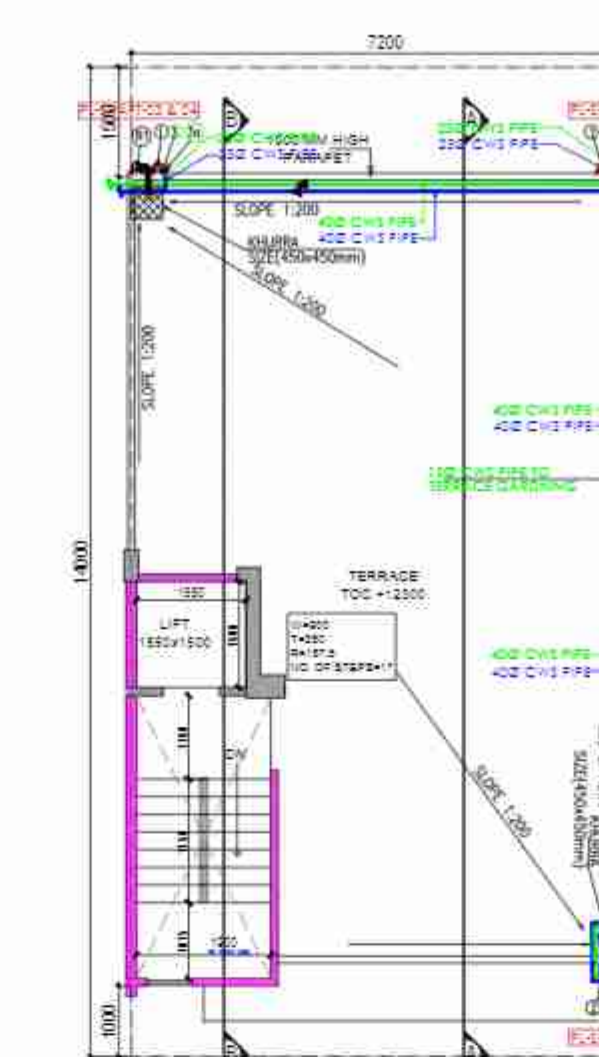
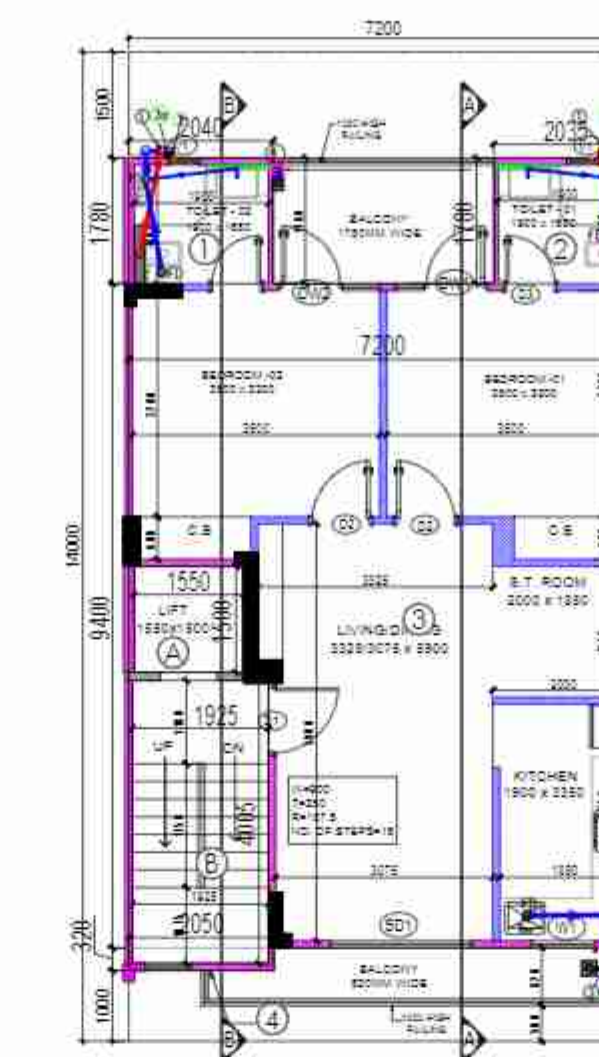
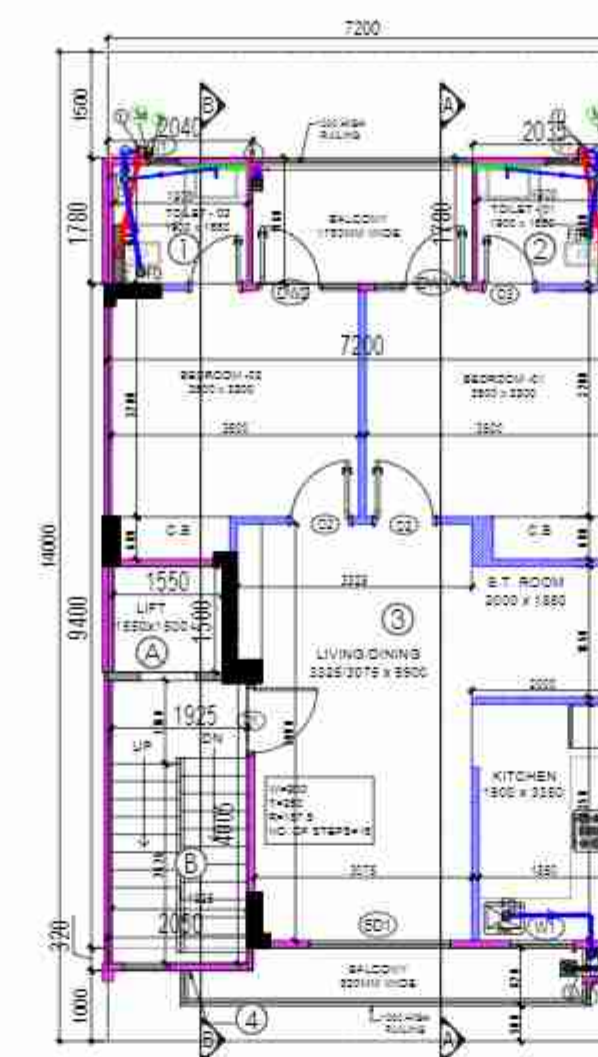
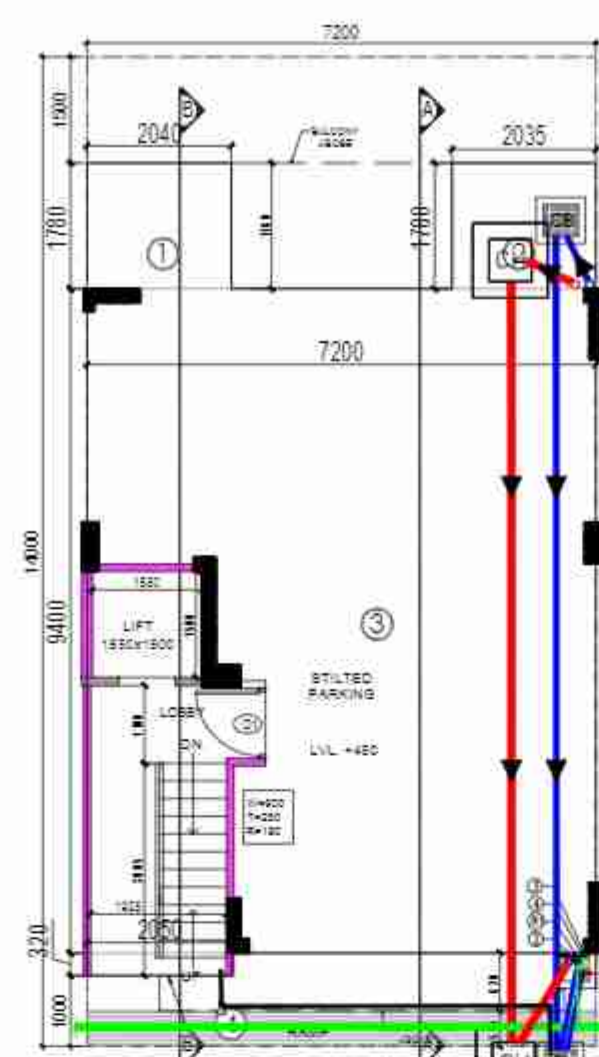
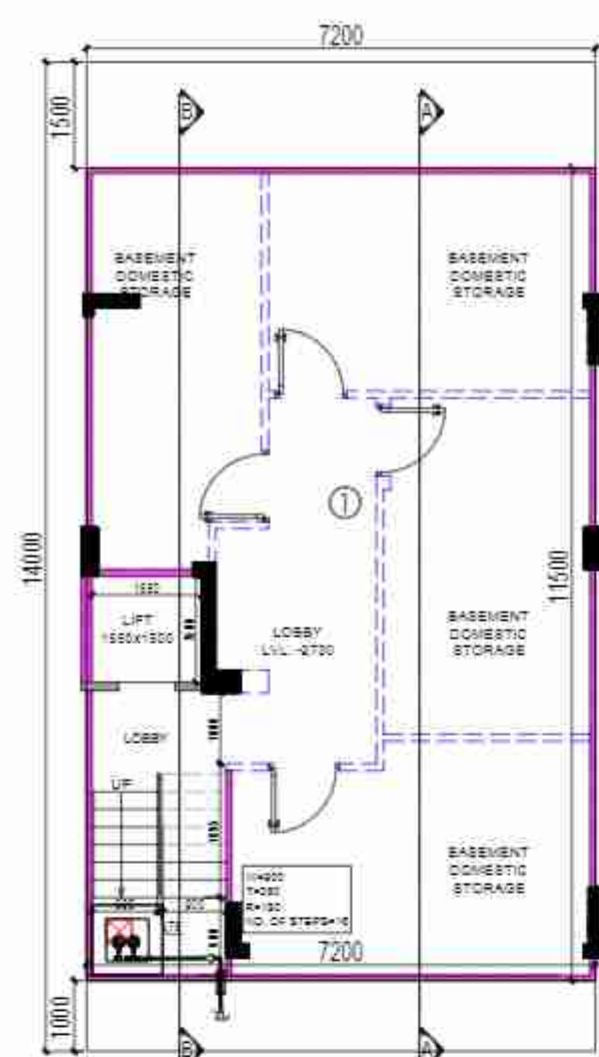
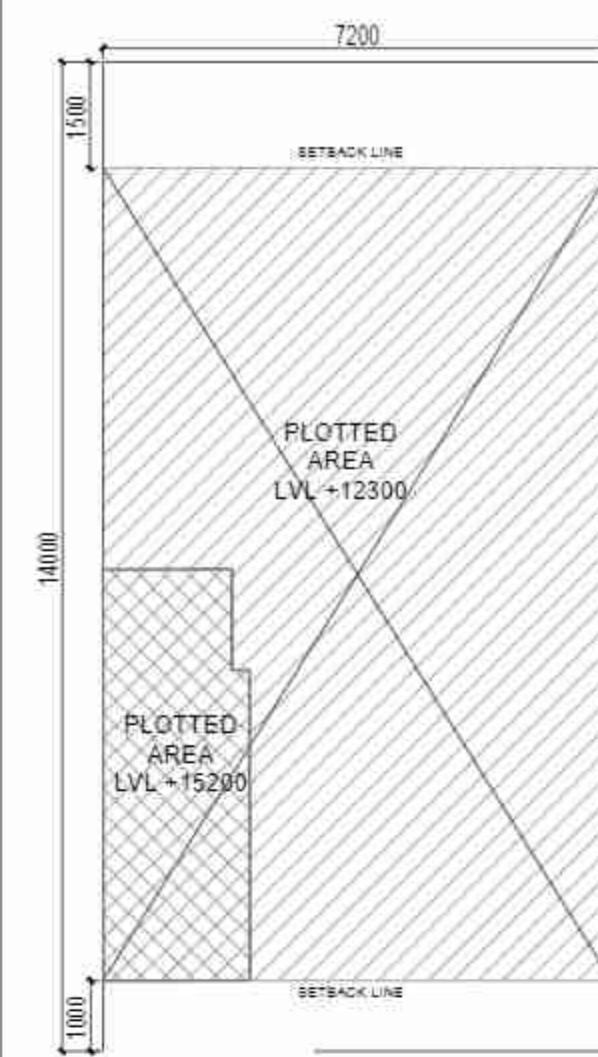


100 MM RCC WALL
100 MM AAC WALL

AREA CALCULATION										
							AREA	UNIT		
TOTAL PLOT AREA (7.20 X 14.00)										
							=	100.80	SQ.	
PERMISSIBLE FAR @ 2										
							=	201.60	SQ.	
PROPOSED FAR @ 1.988										
							=	200.436	SQ.	
PERMISSIBLE GR. COV. @ 75.0%										
							=	75.60	SQ.	
PROPOSED GROUND COVERAGE @ 74.99%										
							=	75.589	SQ.	
AREA OF STILT FLOOR (GR. COVERAGE)										
1	2.040	X	1.780	X	1		=	3.631	SQ.	
2	2.035	X	1.780	X	1		=	3.622	SQ.	
3	7.200	X	9.400	X	1		=	67.680	SQ.	
4	2.050	X	0.320	X	1		=	0.656	SQ.	
TOTAL								75.589	SQ.	
TOTAL GROUND COVERAGE										
							=	75.589	SQ.	
AREA OF STILT FLOOR										
1	1.825	X	1.600	X	1		=	2.920	SQ.	
2	2.075	X	4.220	X	1		=	8.757	SQ.	
TOTAL								11.677	SQ.	
DEDUCTION										
A	1.625	X	4.105	X	1		=	7.902	SQ.	
TOTAL AREA OF STILT FLOOR								=	3.774	SQ.

AREA OF TYPICAL FLOOR (1ST TO 3RD)									
1	2.040	X	1.780	X	1	=	3.631	SQ.M.	
2	2.035	X	1.780	X	1	=	3.622	SQ.M.	
3	7.200	X	9.400	X	1	=	67.680	SQ.M.	
4	2.050	X	0.320	X	1	=	0.656	SQ.M.	
TOTAL								75.589	SQ.M.
DEDUCTION									
A	1.550	X	1.500	X	1	=	2.325	SQ.M.	
B	1.925	X	4.005	X	1	=	7.710	SQ.M.	
TOTAL								10.035	SQ.M.
TOTAL AREA OF TYPICAL FLOOR								=	65.554 SQ.M.
TOTAL FLOOR AREA									
+ (AREA OF TYPICAL FLOOR X 3) + STILT FLOOR AREA								=	200.436 SQ.M.
TOTAL GROUND COVERAGE									
+ STILT FLOOR AREA								=	75.589 SQ.M.
BASEMENT AREA									
A	7.200	X	11.500	X	1	=	82.800	SQ.M.	
TOTAL BASEMENT AREA								=	82.800 SQ.M.
TOTAL BUILT UP AREA									
(BASEMENT AREA + G. COVERAGE AT STILT FLOOR + FLOOR AREA (1ST TO 3RD) + STAIRCASE AREA X 3								=	378.179 SQ.M.

PLUMBING LEGENDS:
(1) 110 OD SOIL PIPE PVC SWR TYPE-B (SOLVENT JOINT)
(2) 110 OD WASTE PIPE PVC SWR TYPE-B (SOLVENT JOINT)
(3) COLD WATER SUPPLY DN TAKE FOR 1ST & 2ND FLR (PVC SCH40)
(4) COLD WATER SUPPLY DN TAKE FOR 3RD & 4TH FLR (PVC SCH40)
(5) 25# WATER SUPPLY RISER PIPE (PVC SCH40)
(6) 75 OD RWP FOR (TERRACE/BALCONY)
(7) PVC SWR TYPE-A TYPE-B UNDER GROUND
COP CLEAN OUT PLUG

DOOR WINDOW SCHEDULE					
TYPE	WIDTH	HEIGHT	SILL LVL	LINTEL LVL	REMARKS
D1	900	2400	± 00	2400	ENTRANCE
D2	900	2400	± 00	2150	BEDROOMS
D3	750	2400	± 00	2150	TOILETS
DW2	900/385	2400/1500	± 00/900	2400	BED ROOM
DW3	900/525	2400/1500	± 00/900	2400	BED ROOM
SD1	2000	2400	± 00	2400	LIVING
W1	900	1200	1200	2400	KITCHEN
V1	450	1100	1050	2150	TOILETS

















PROJECT:
PROPOSED BUILDING PLAN ON PLOT NO.- B-11b, B-12b, B-13b, B-14b, B-16a, B-17a, B-18a & B-19a (08 PLOTS) FOR AFFORDABLE RESIDENTIAL PLOTTED COLONY (UNDER DEEN-DAYAL JAN AWAS YOJNA) OVER AN AREA 57.40 ACRES (LICENCE NO. 32 OF 2021 DATED 03.07.2021 FOR AN AREA MEASURING 52.275 ACRES & LICENCE NO. 102 OF 2022 DATED 27.02.2022 FOR AN AREA MEASURING 5.125 ACRES) IN THE REVENUE ESTATE OF VILLAGE-HAYATPUR, SECTOR 89, GURUGRAM BEING DEVELOPED BY AAWAM RESIDENCY PRIVATE LIMITED & OTHERS IN COLLABORATION WITH ADHIKAANSH REALTORS PRIVATE LIMITED

DRAWING TITLE:
TYPE B - FLOOR PLANS WITH AREA CALCULATION, ELEVATIONS & SECTIONS (LEFT SIDE)

ARCHITECT'S SIGN
Ar. ABHIJIT K. DWIVEDI
CA/2017/96617

AUTHORIZED SIGN

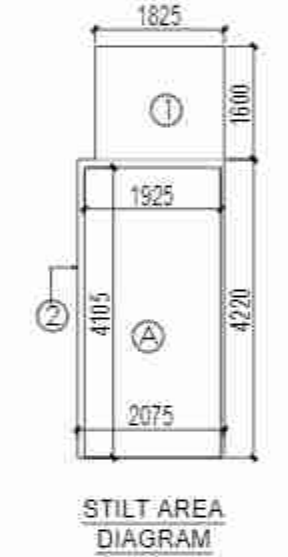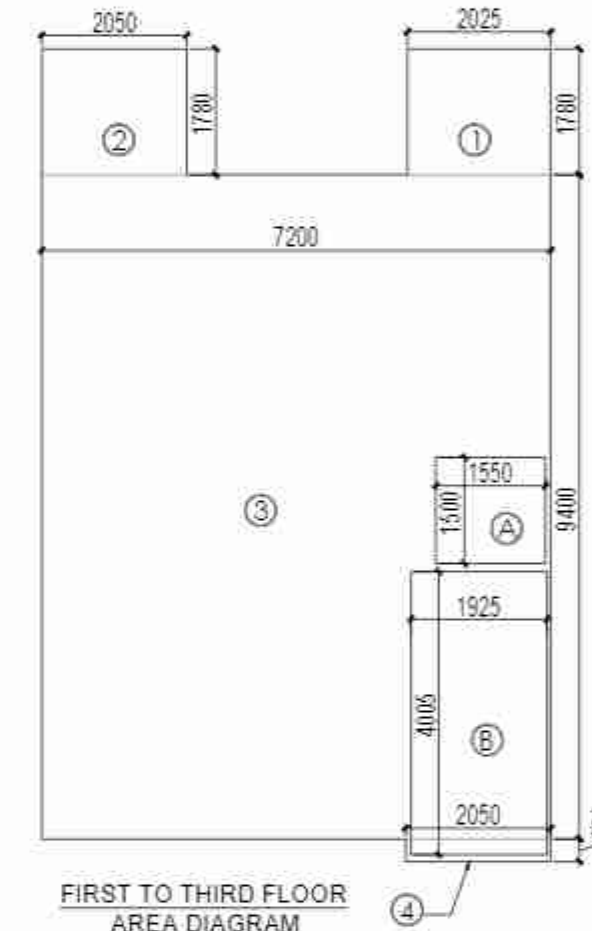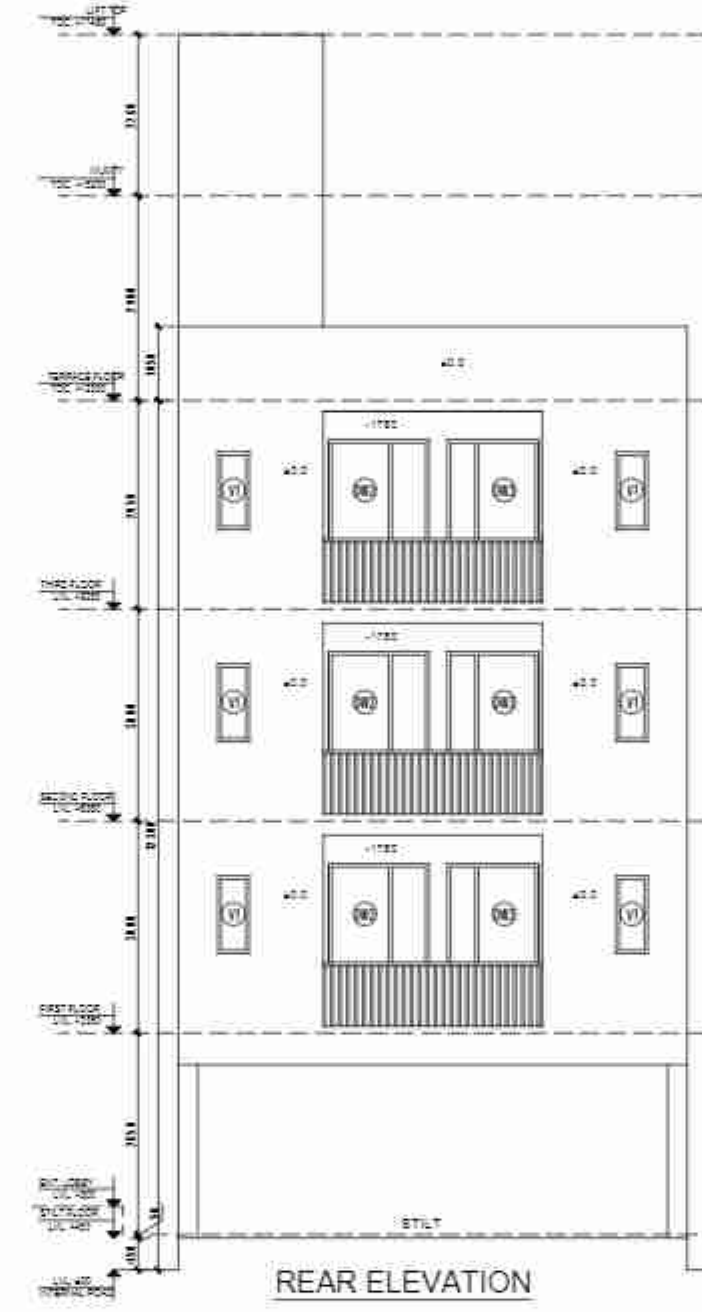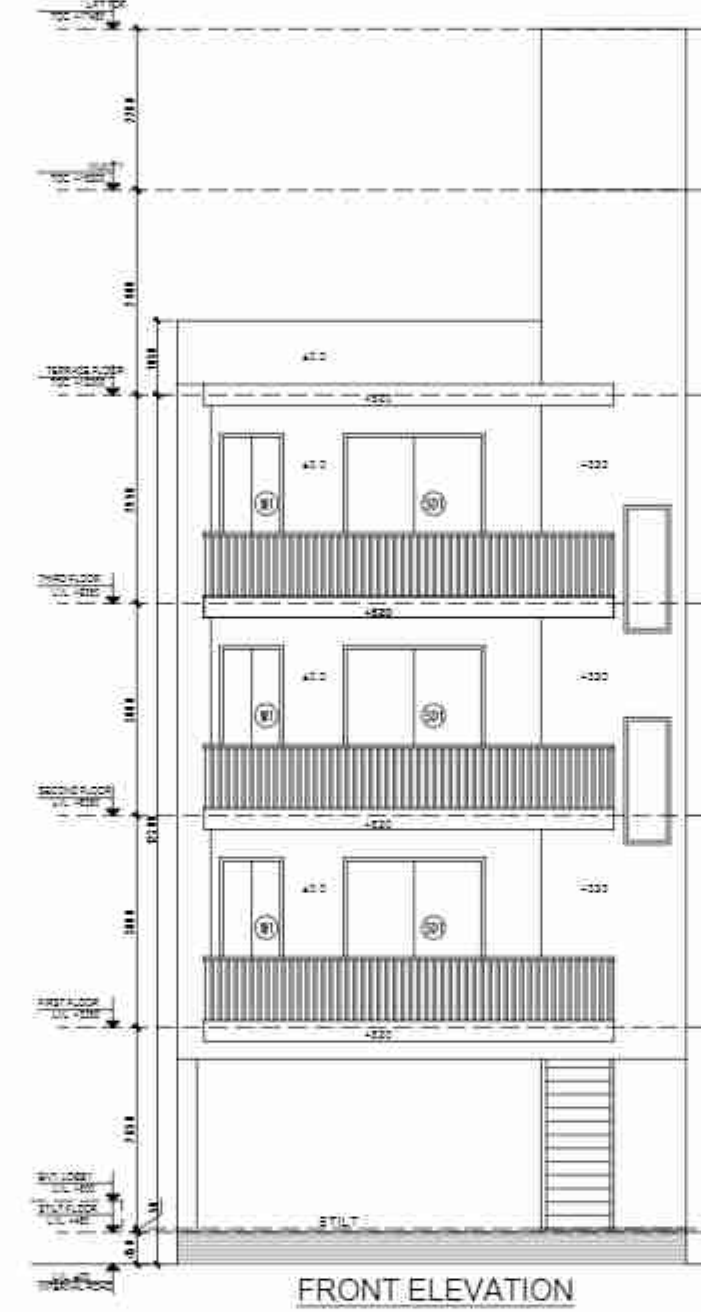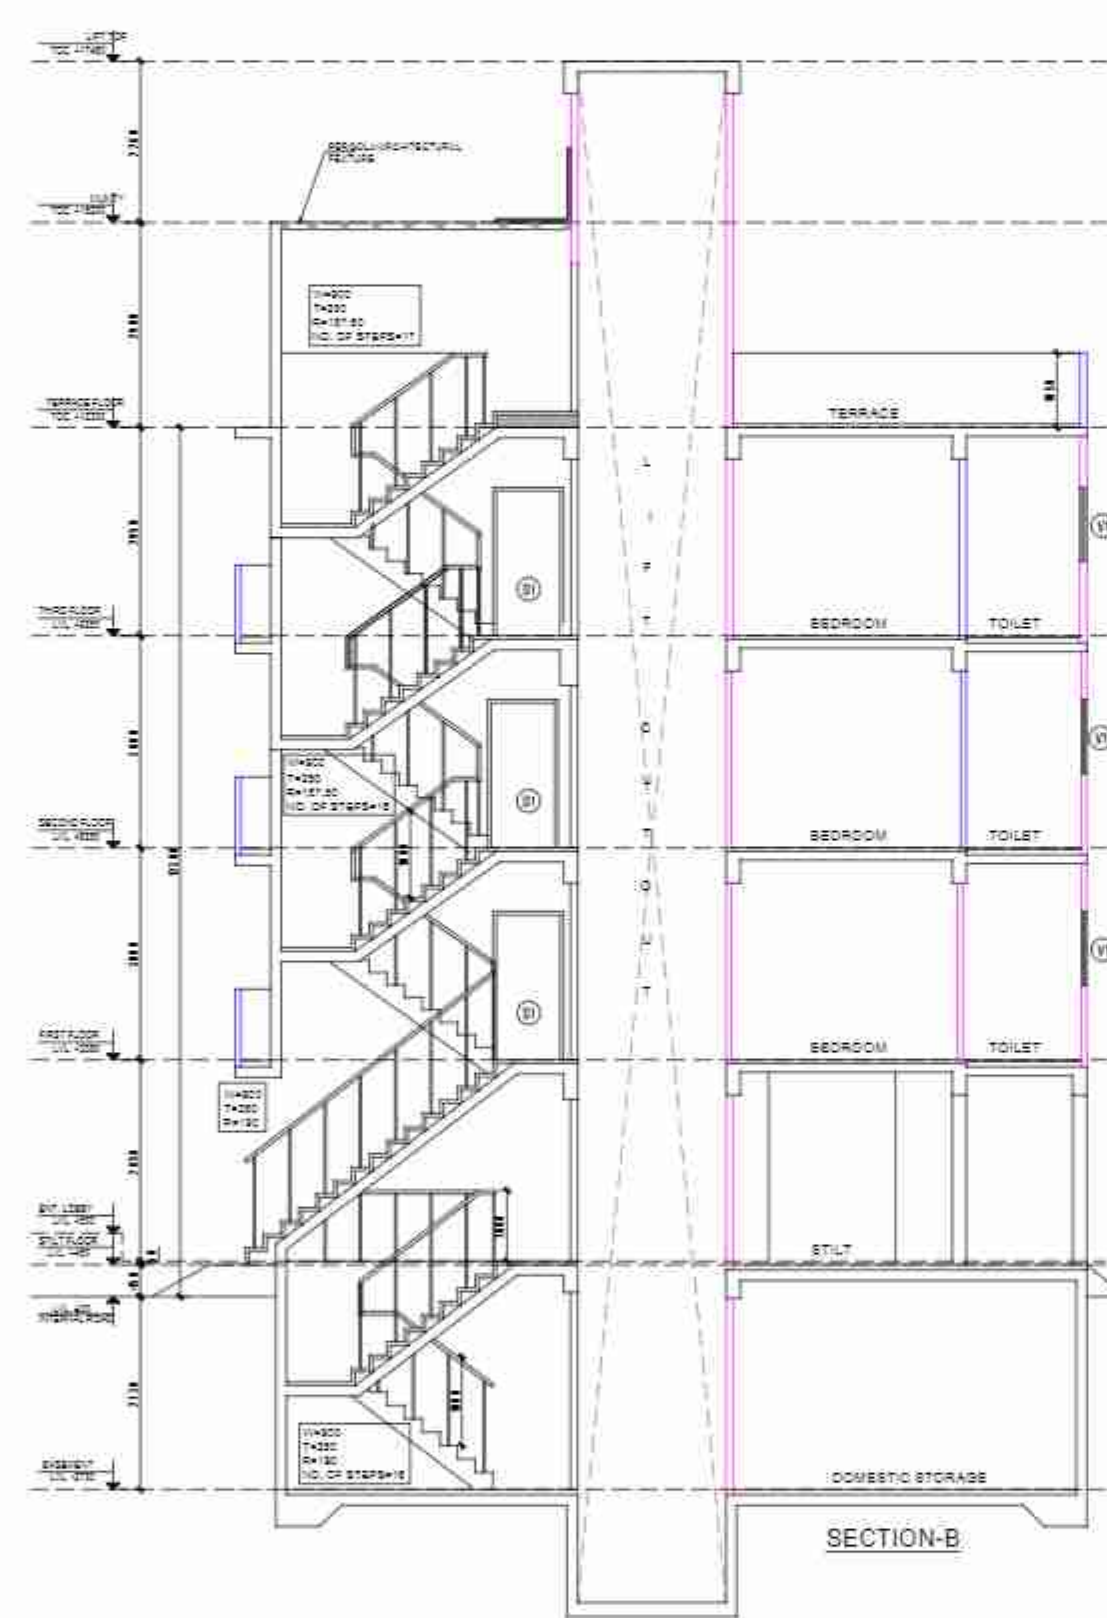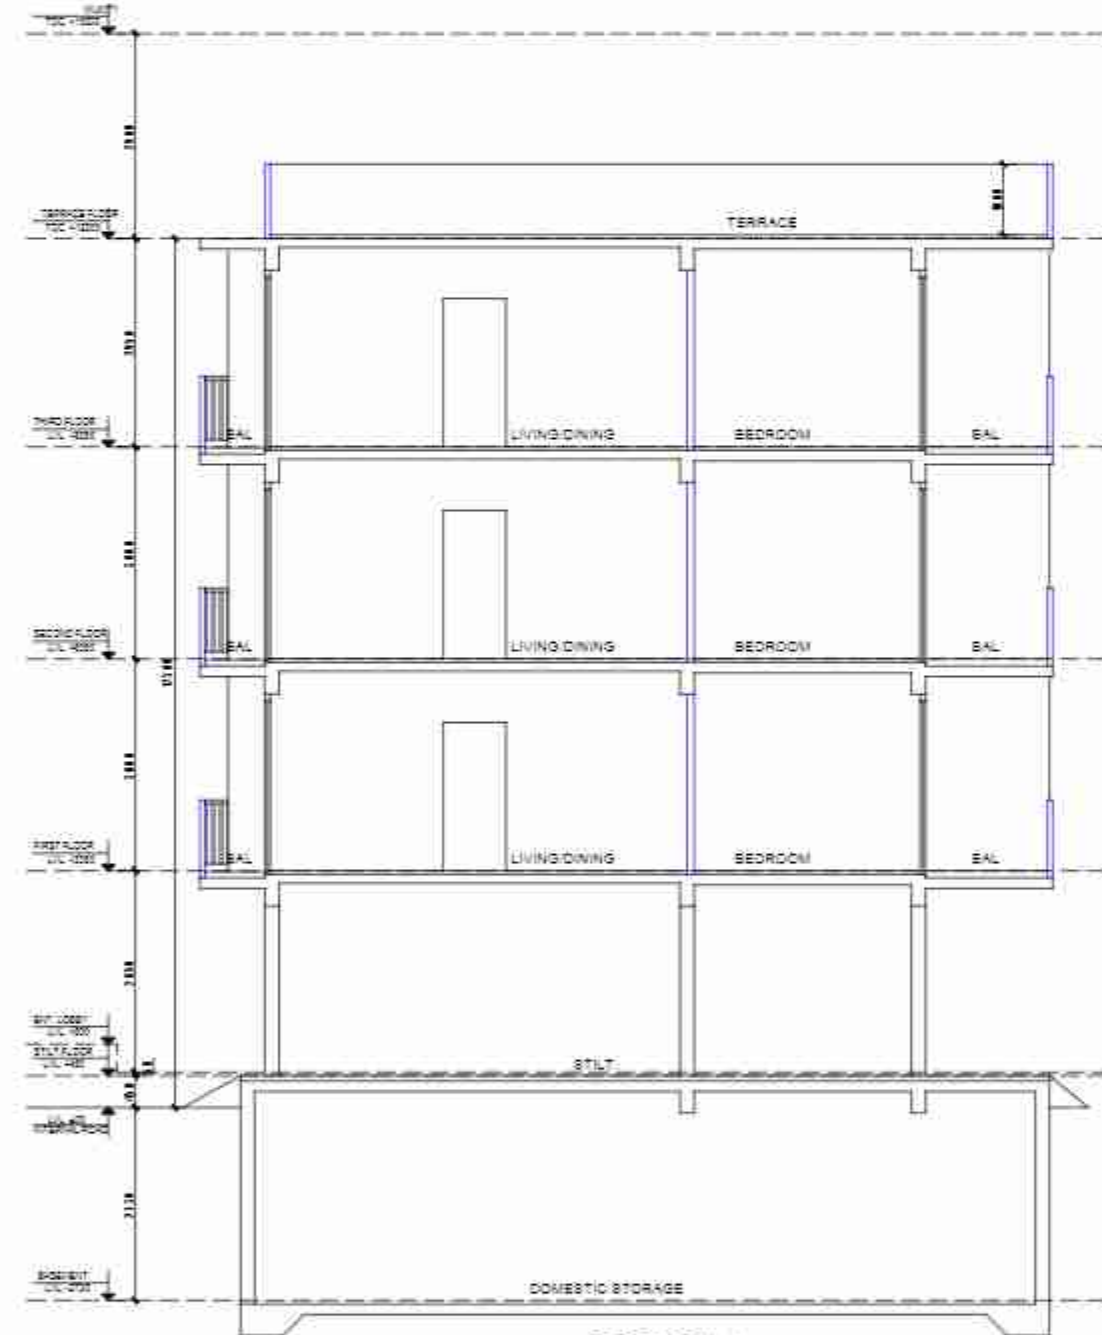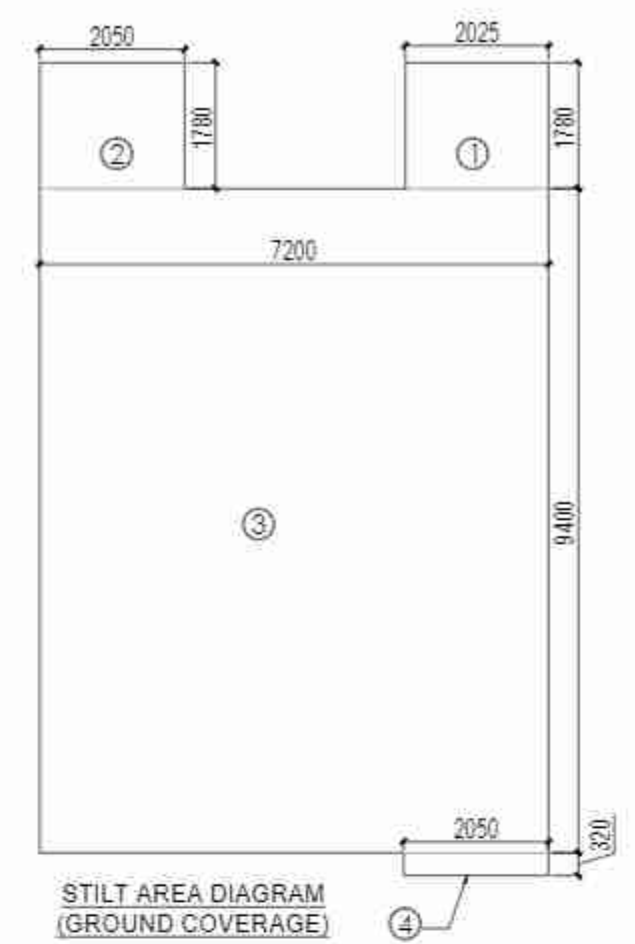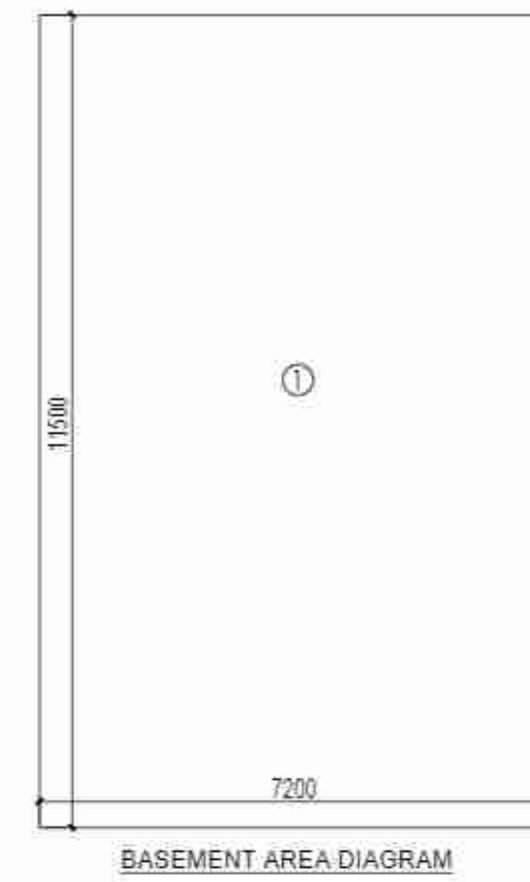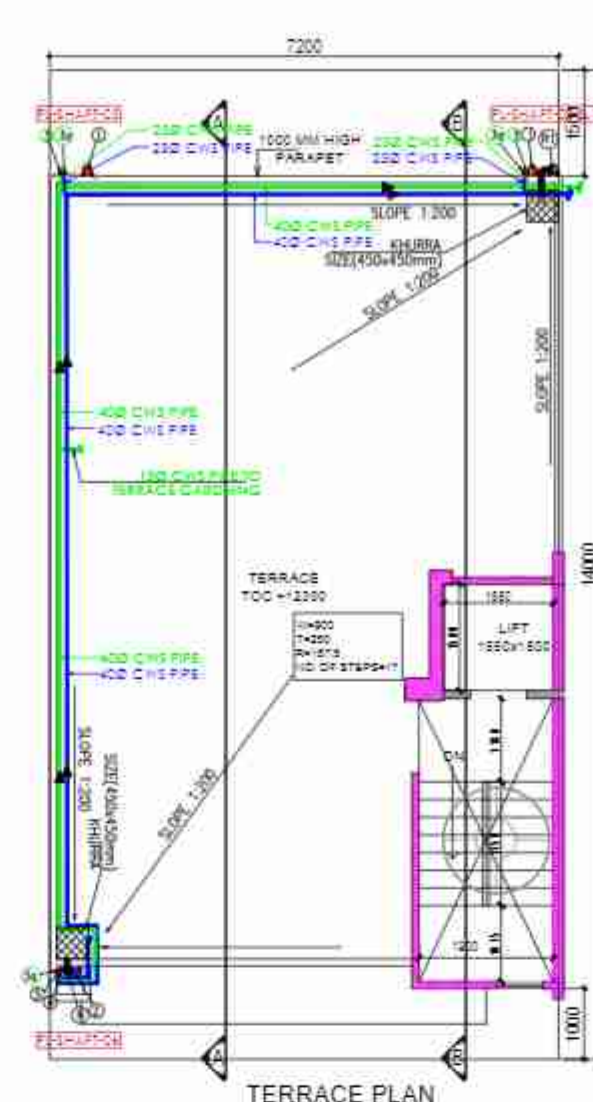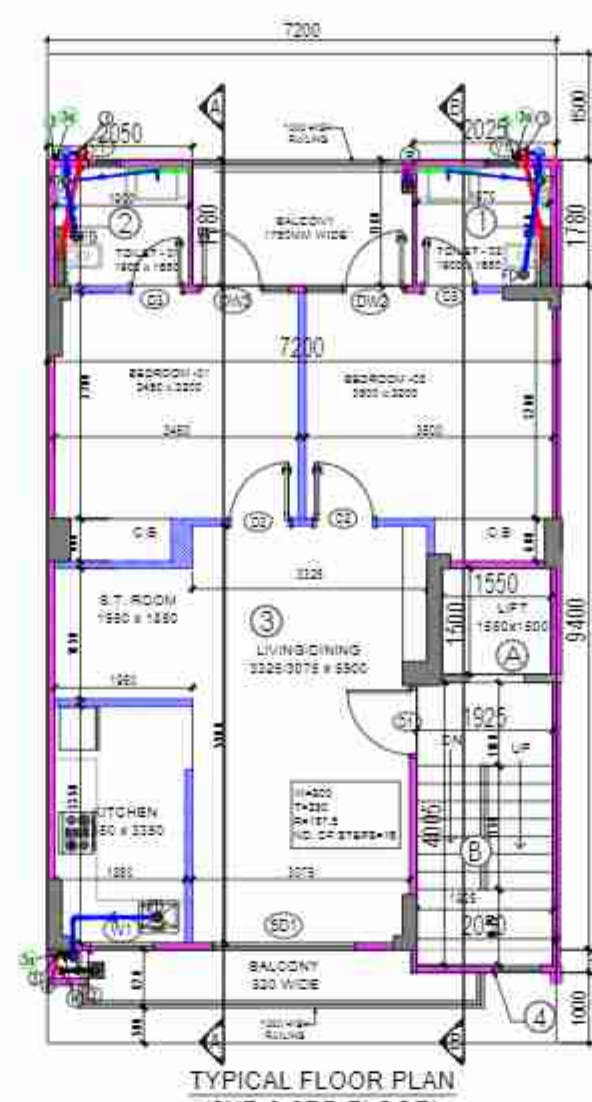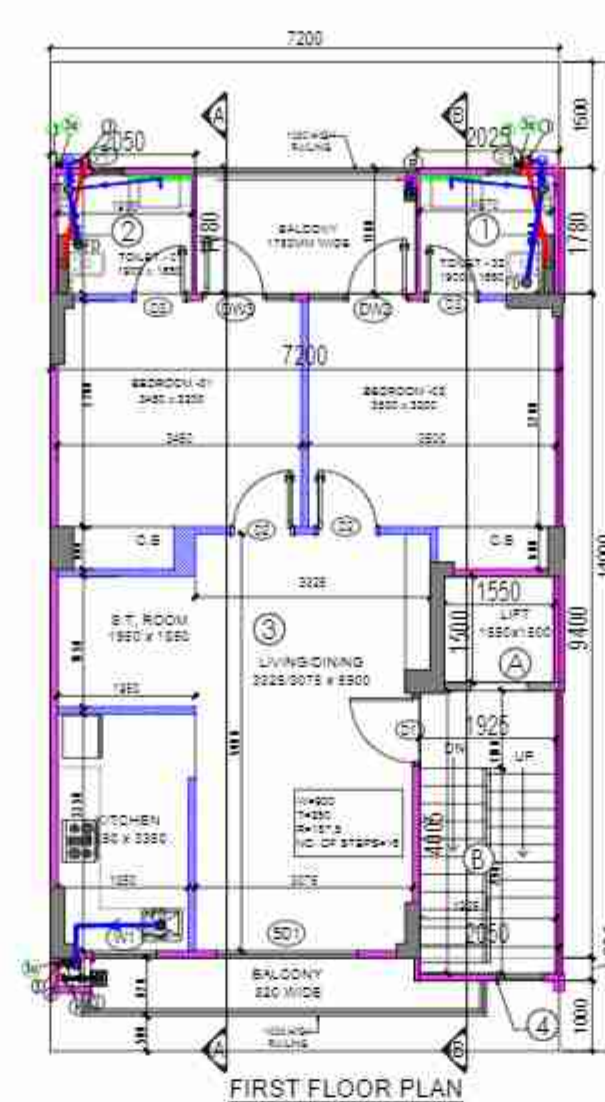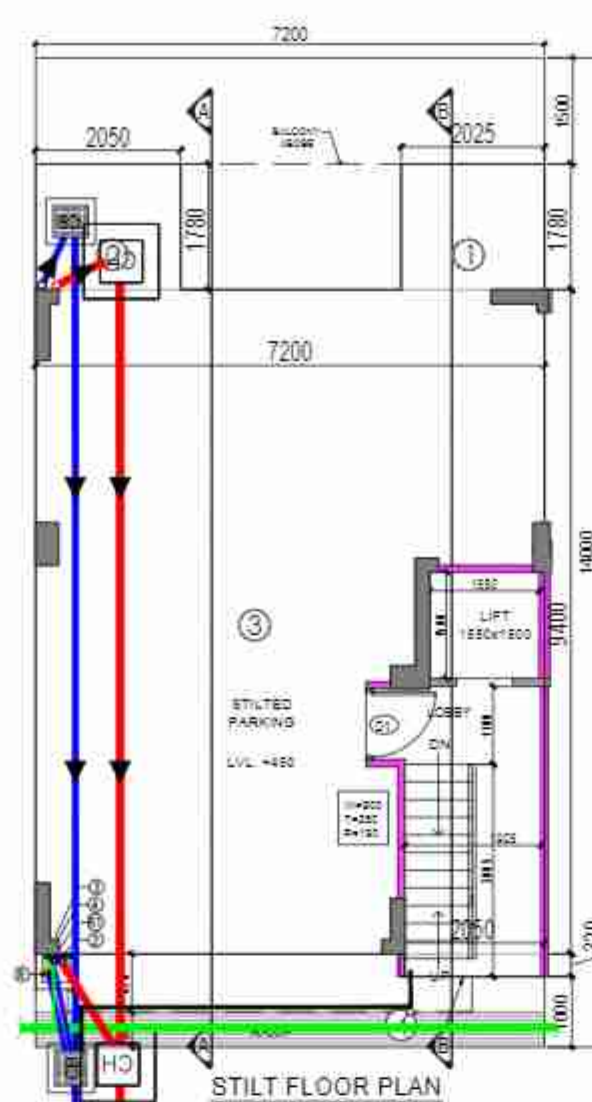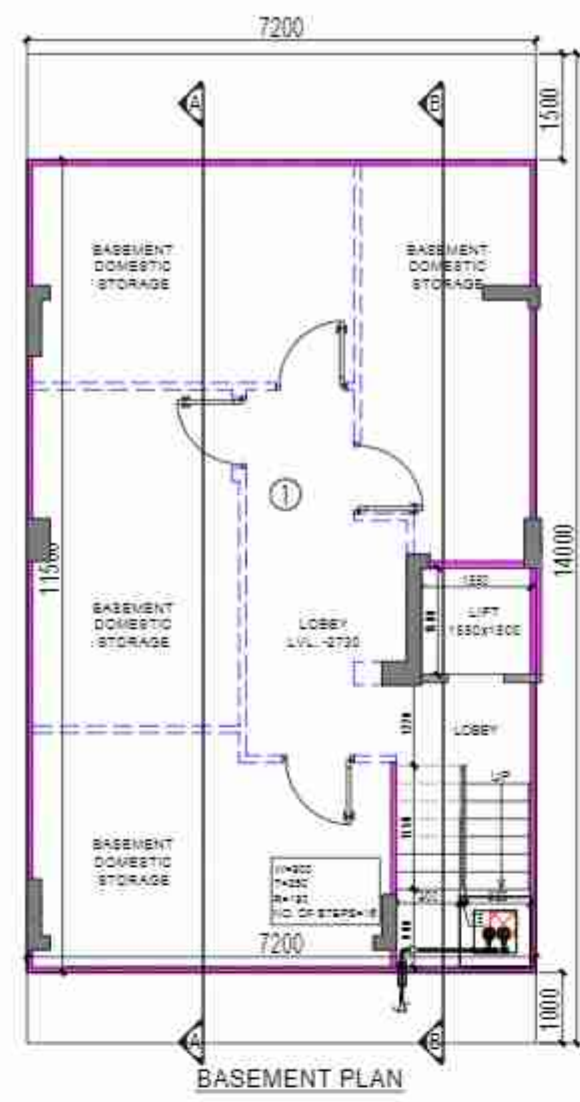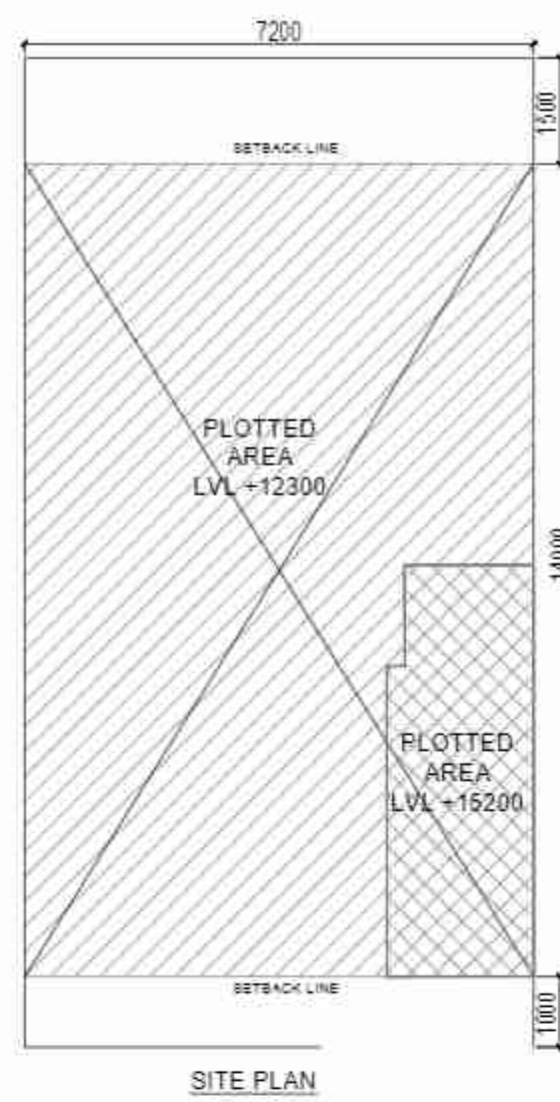

100 MM RCC WALL
100 MM AAC WALL

AREA CALCULATION				AREA	UNIT
TOTAL PLOT AREA (7.20 X 14.00)				100.800	SQ.M.
PERMISSIBLE FAR @ 2				201.600	SQ.M.
PROPOSED FAR @ 1.988				200.439	SQ.M.
PERMISSIBLE GR. COV. @ 75.0%				75.600	SQ.M.
PROPOSED GROUND COVERAGE @ 74.99%				75.590	SQ.M.
AREA OF STILT FLOOR (GR COVERAGE)					
1	2.025	X	1.780	X	1 = 3.605 SQ.M.
2	2.050	X	1.780	X	1 = 3.648 SQ.M.
3	7.200	X	0.430	X	1 = 0.686 SQ.M.
4	2.050	X	0.320	X	1 = 0.656 SQ.M.
TOTAL					75.590 SQ.M.
AREA OF STILT FLOOR					
1	1.525	X	1.800	X	1 = 2.920 SQ.M.
2	2.075	X	4.220	X	1 = 8.737 SQ.M.
TOTAL					11.657 SQ.M.
DEDUCTION					
A	1.925	X	4.105	X	1 = 7.902 SQ.M.
TOTAL AREA OF STILT FLOOR					3.774 SQ.M.

AREA OF TYPICAL FLOOR (1ST TO 3RD)				AREA	UNIT
1	2.025	X	1.780	X	1 = 3.605 SQ.M.
2	2.050	X	1.780	X	1 = 3.648 SQ.M.
3	7.200	X	0.430	X	1 = 0.686 SQ.M.
4	2.050	X	0.320	X	1 = 0.656 SQ.M.
TOTAL					75.590 SQ.M.
DEDUCTION					
A	1.550	X	1.550	X	1 = 2.325 SQ.M.
B	1.925	X	4.005	X	1 = 7.710 SQ.M.
TOTAL					10.035 SQ.M.
TOTAL AREA OF TYPICAL FLOOR					
					65.555 SQ.M.
TOTAL FLOOR AREA					
					200.439 SQ.M.
TOTAL GROUND COVERAGE					
					75.590 SQ.M.
TOTAL BUILT UP AREA					
					378.163 SQ.M.

PLUMBING LEGENDS:
(1) 110 OD SOIL PIPE PVC SWR TYPE-B (SOLVENT JOINT)
(2) 110 OD WASTE PIPE PVC SWR TYPE-B (SOLVENT JOINT)
(3) COLD WATER SUPPLY DN TAKE FOR 1ST & 2ND FLR (PVC SCH.40)
(4) COLD WATER SUPPLY DN TAKE FOR 3RD & 4TH FLR (PVC SCH.40)
(5) COLD WATER SUPPLY RISER PIPE (PVC SCH.40)
(6) 75 OD RWP FOR (TERRACE/BALCONY)
(7) PVC SWR TYPE-A TYPE-B UNDER GROUND
COP CLEAN OUT PLUG

DOOR WINDOW SCHEDULE					
TYPE	WIDTH	HEIGHT	SILL LVL	LINTEL LVL	REMARKS
D1	900	2400	± 00	2400	ENTRANCE
D2	900	2400	± 00	2150	BEDROOMS
D3	750	2400	± 00	2150	TOILETS
DW2	900/525	2400/1500	± 00/900	2400	BED ROOM
DW3	900/570	2400/1500	± 00/900	2400	BED ROOM
SD1	2000	2400	± 00	2400	LIVING
W1	900	1200	1200	2400	KITCHEN
V1	450	1100	1050	2150	TOILETS

















PROJECT:
PROPOSED BUILDING PLAN ON PLOT NO.- B-11a, B-14c & B-19b (3 PLOTS) FOR AFFORDABLE RESIDENTIAL PLOTTED COLONY (UNDER DEEN-DAYAL JAN AWAS YOJNA) OVER AN AREA 57.40 ACRES (LICENCE NO.32 OF 2021 DATED 03.07.2021 FOR AN AREA MEASURING 52.275 ACRES & LICENCE NO. 102 OF 2022 DATED 27.02.2022 FOR AN AREA MEASURING 5.125 ACRES) IN THE REVENUE ESTATE OF VILLAGE-HAYATPUR, SECTOR 89, GURUGRAM BEING DEVELOPD BY AAWAM RESIDENCY PRIVATE LIMITED & OTHERS IN COLLABORATION WITH ADHIKAANSH REALTORS PRIVATE LIMITED

DRAWING TITLE :
TYPE B - FLOOR PLANS WITH AREA CALCULATION, ELEVATIONS & SECTIONS (RIGHT SIDE CORNER)

ARCHITECT'S SIGN

AUTHORIZED SIGN

Ar. ABHINAV DWIVEDI
CA/2017/93517

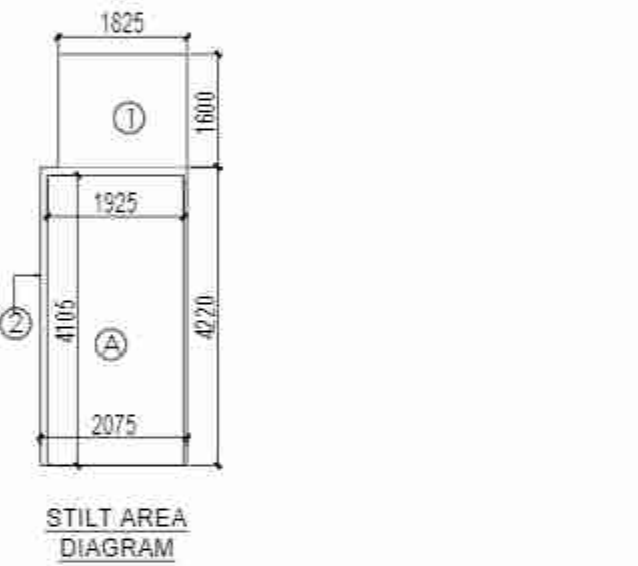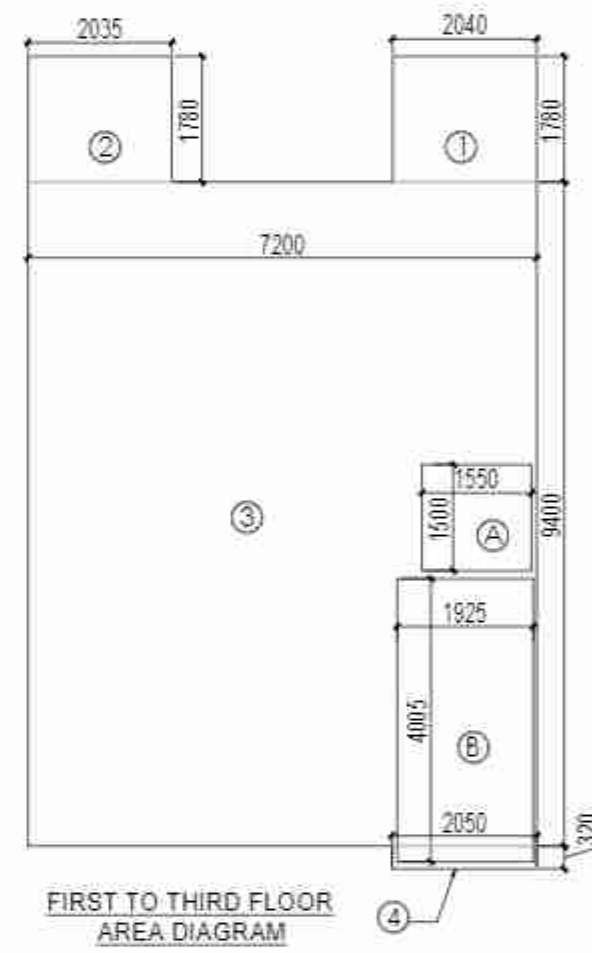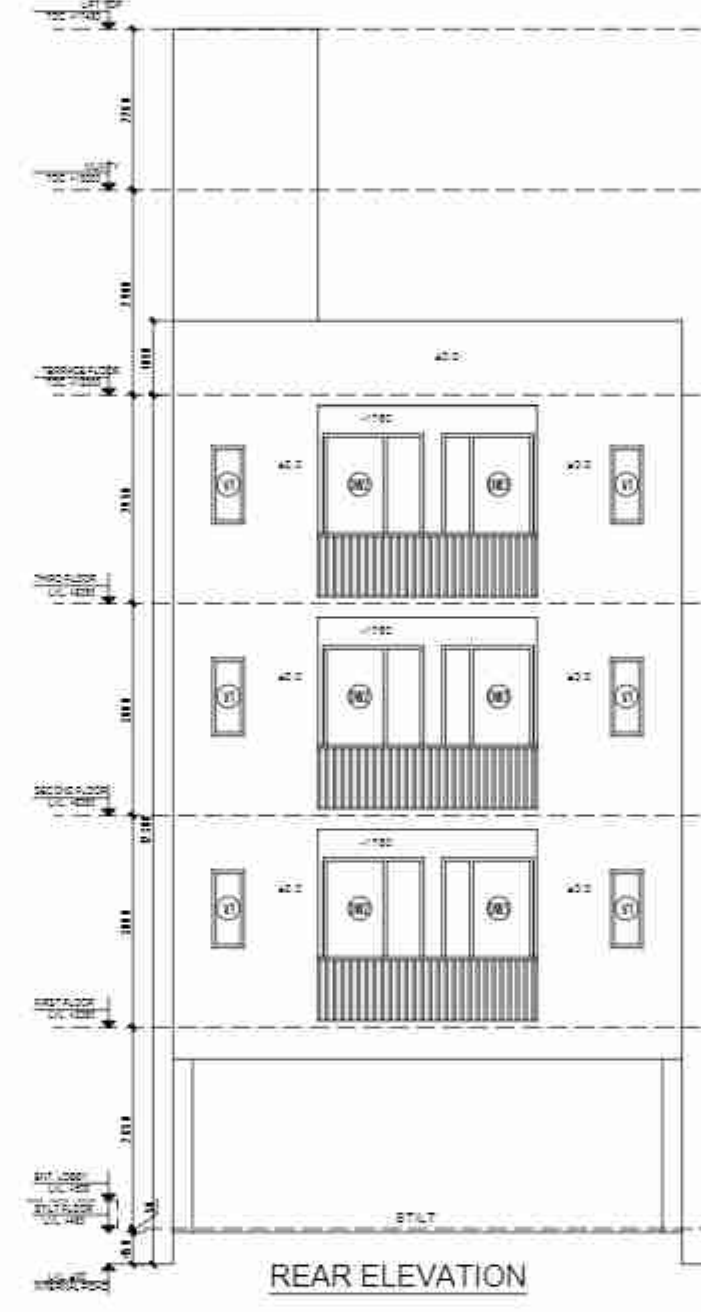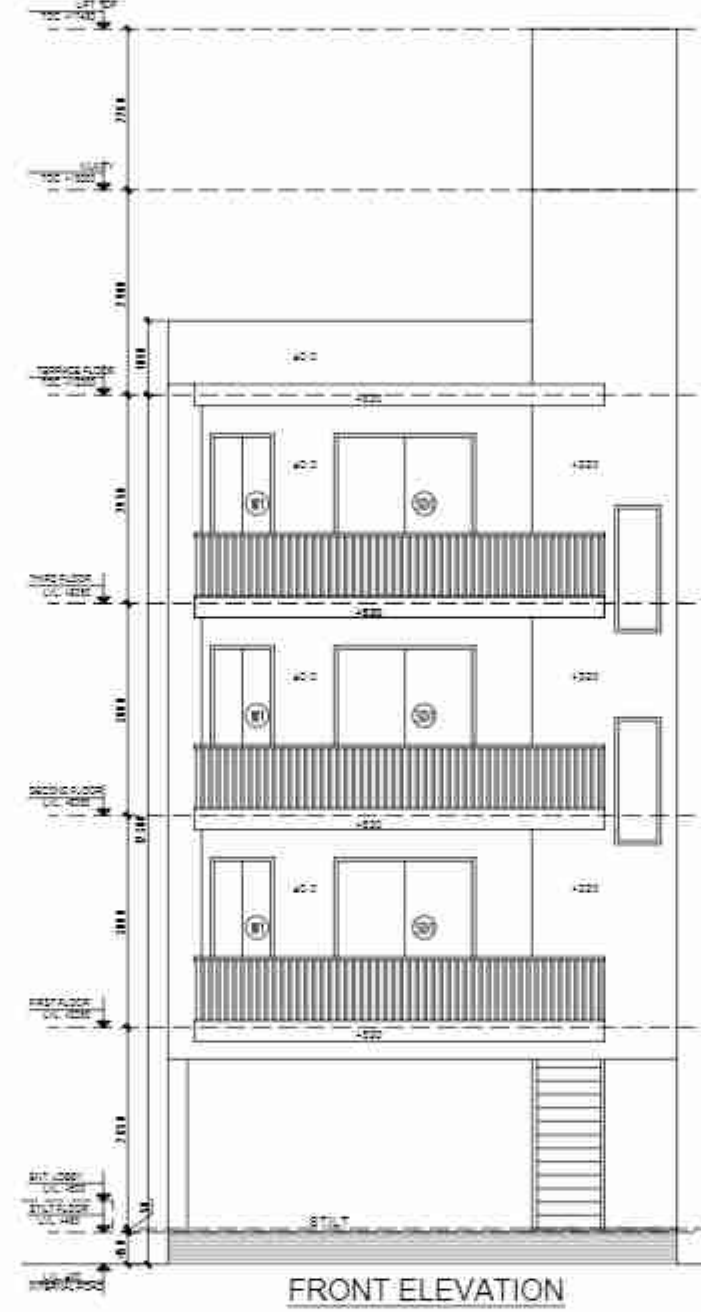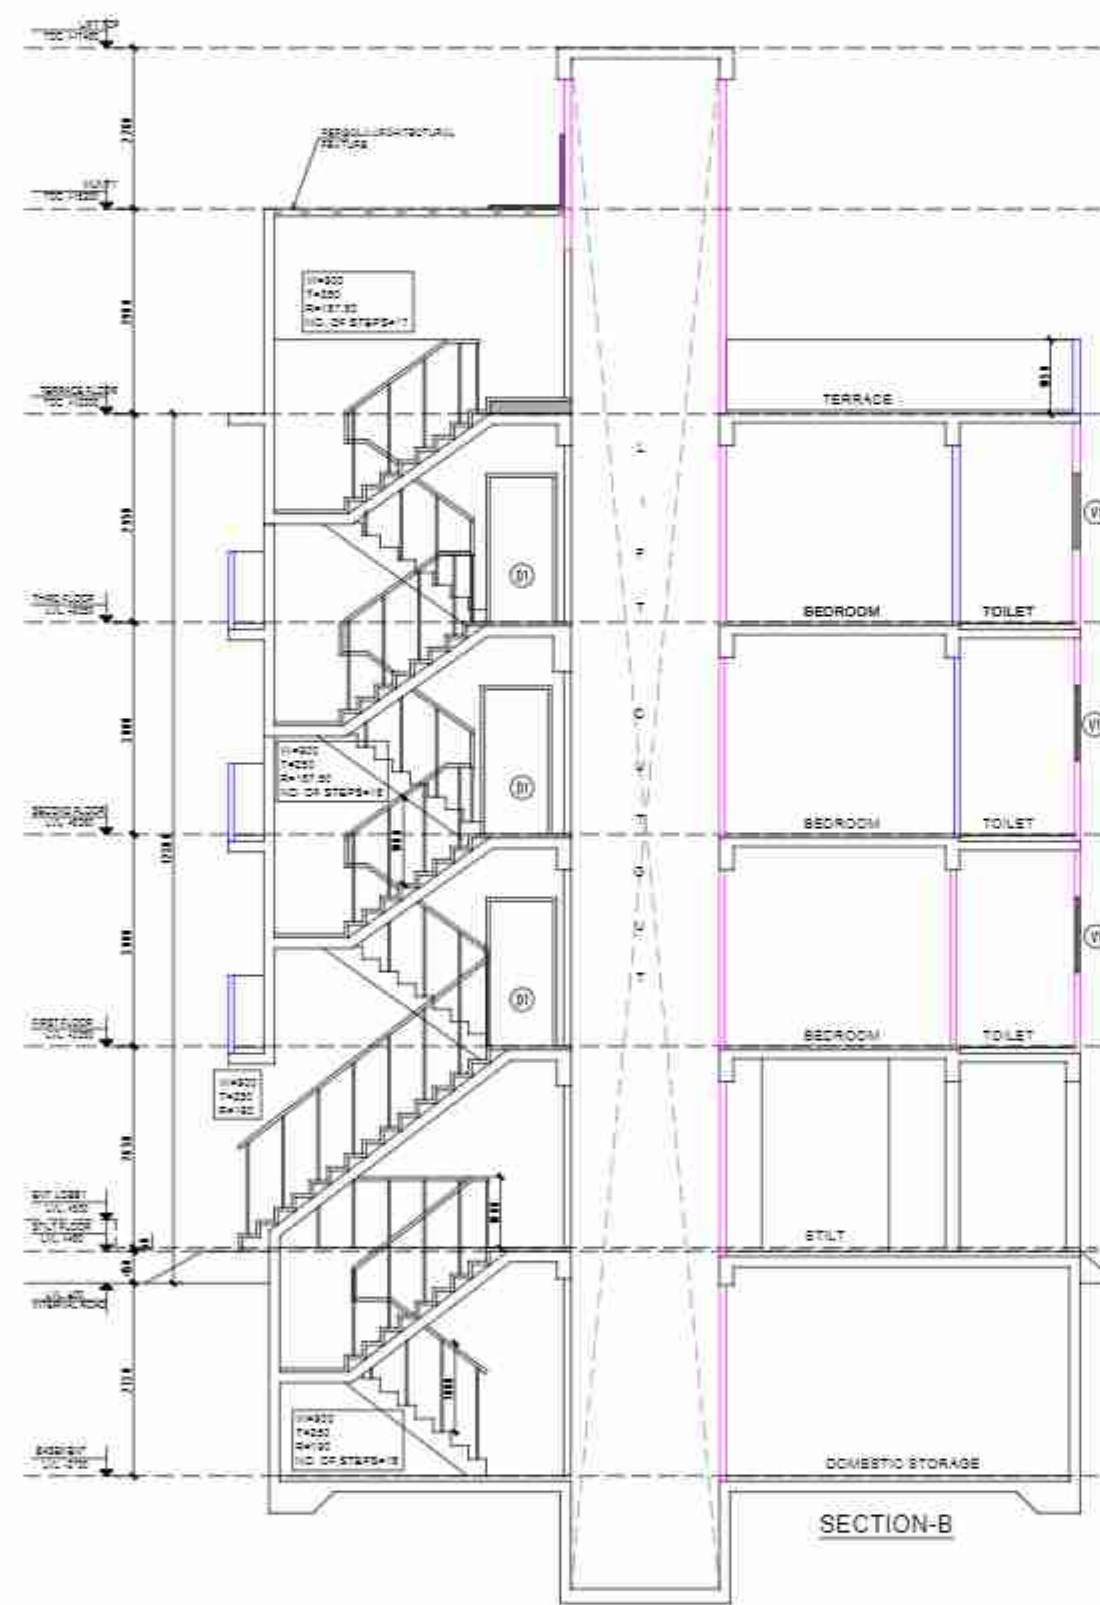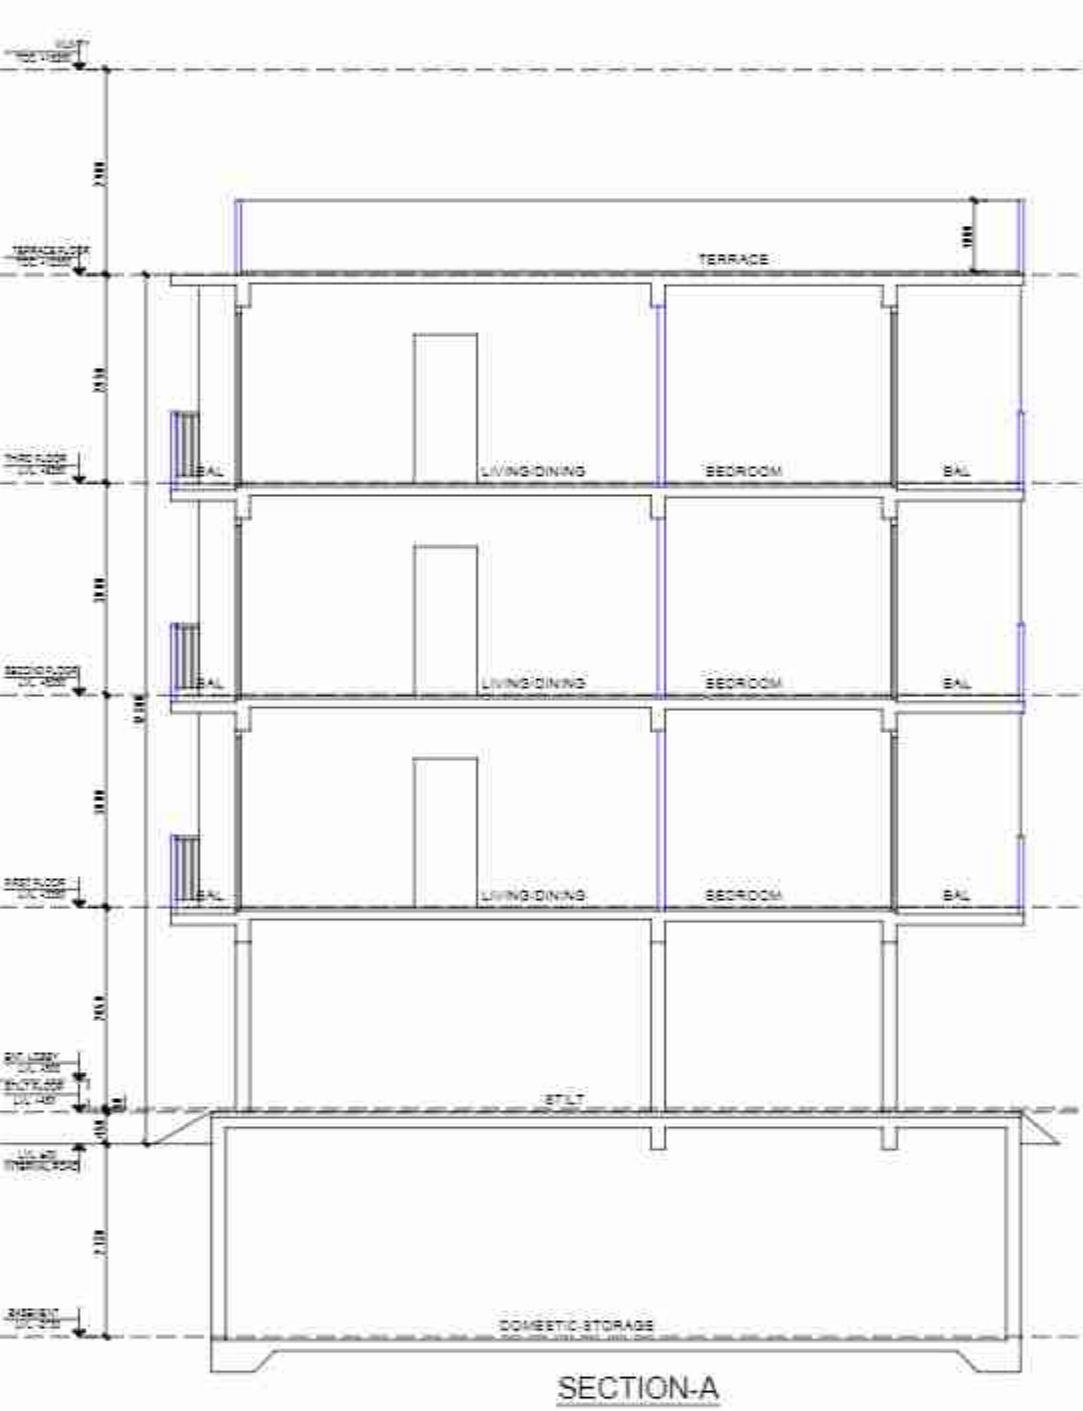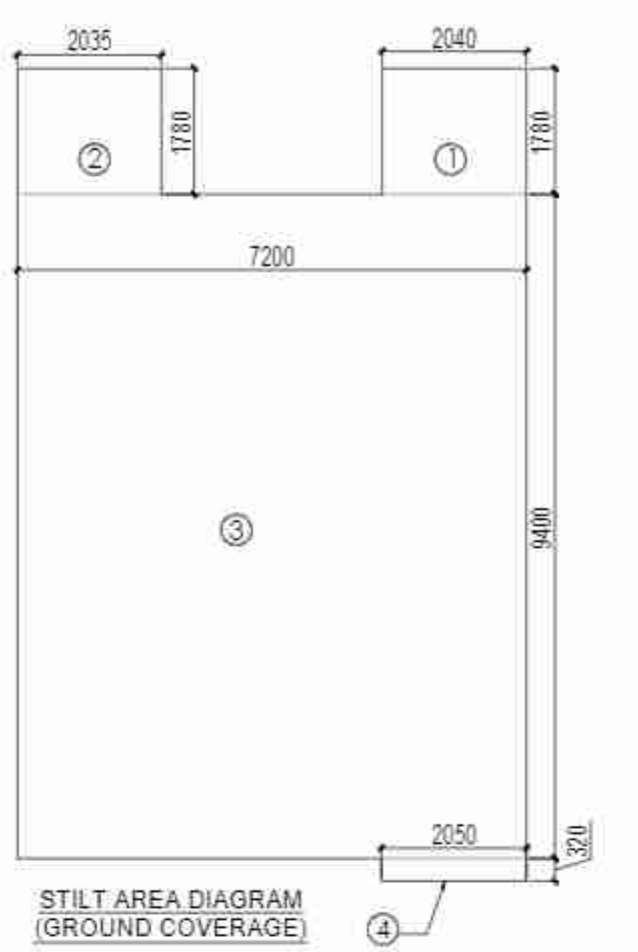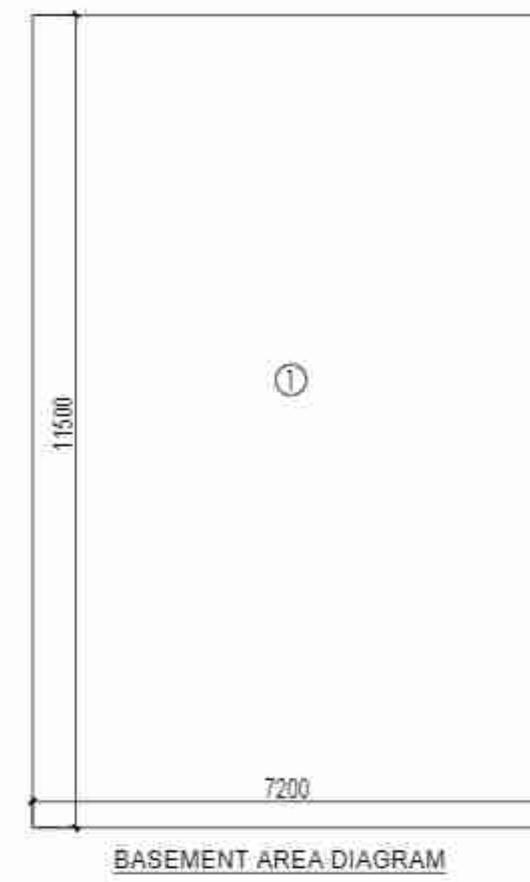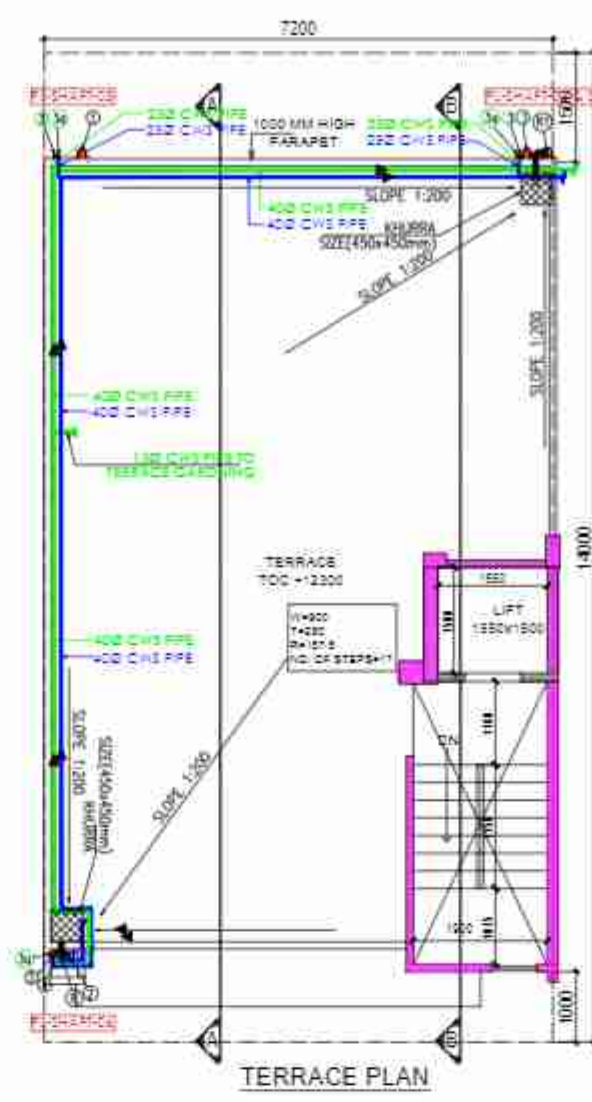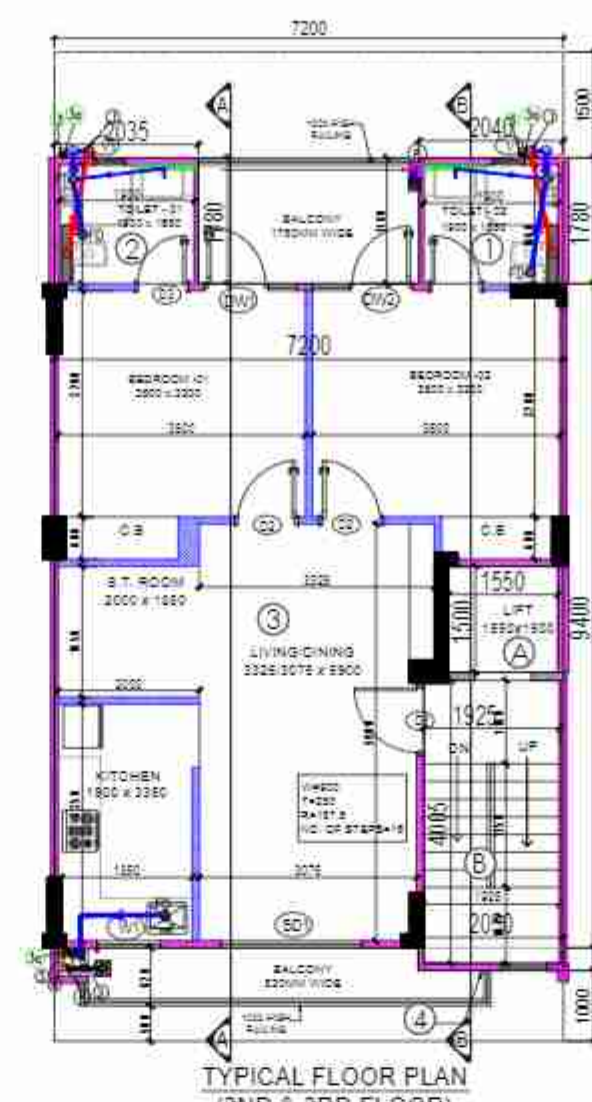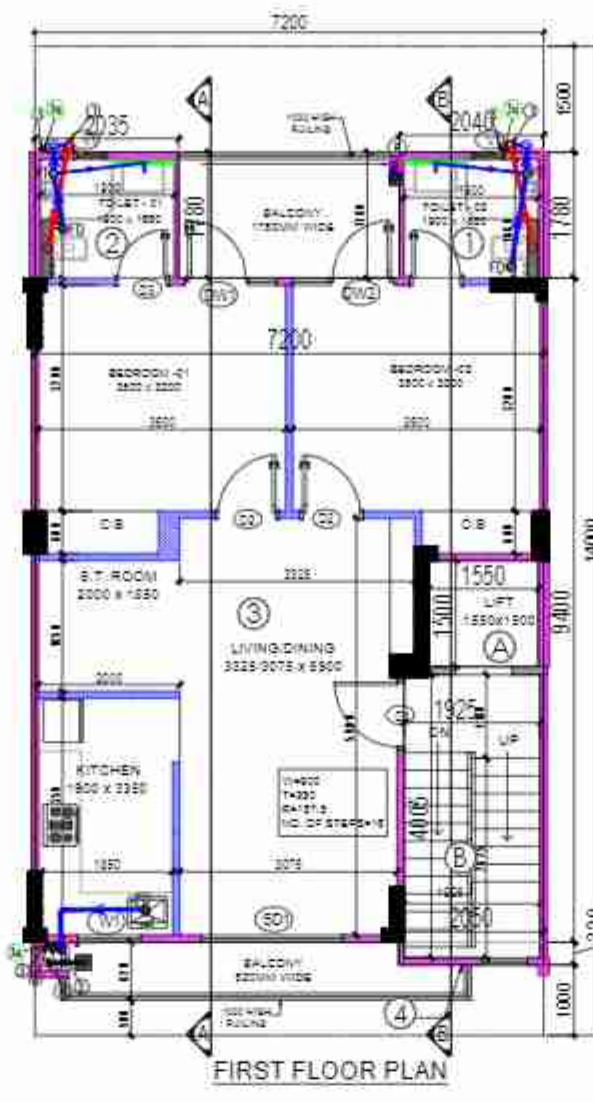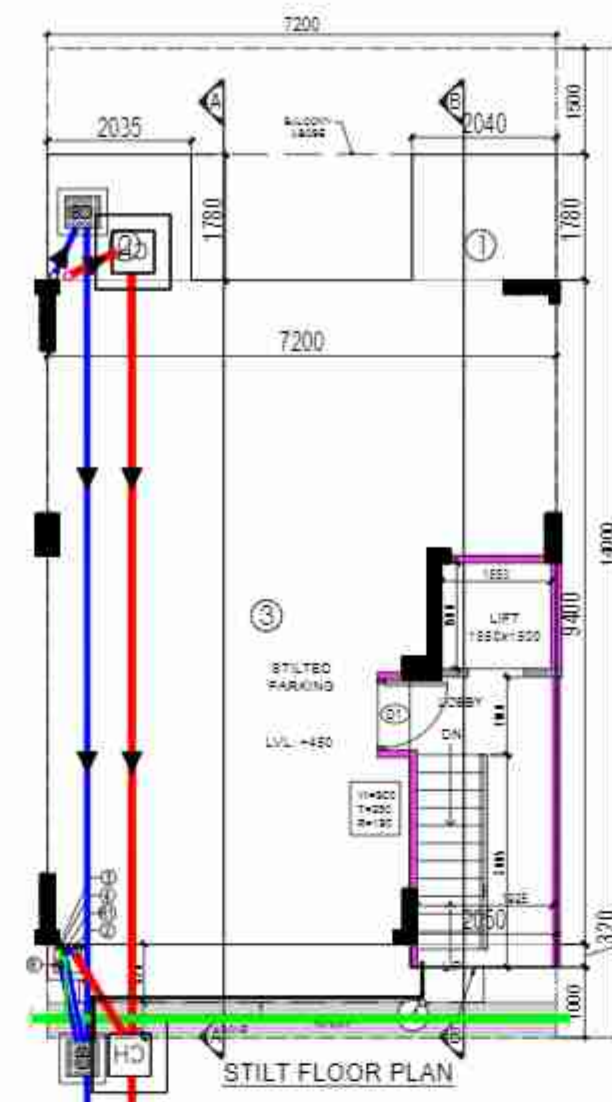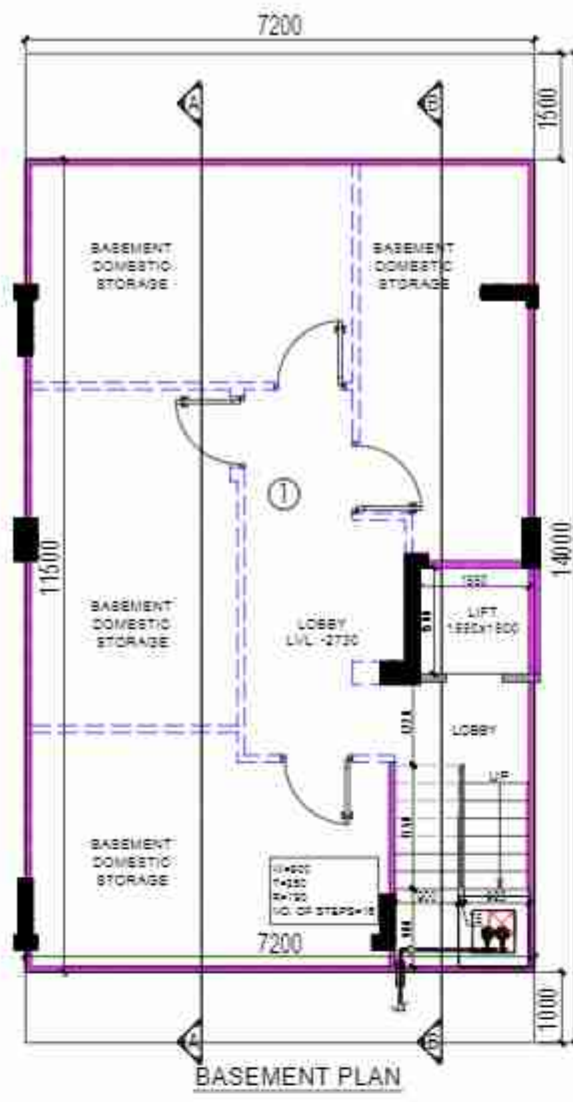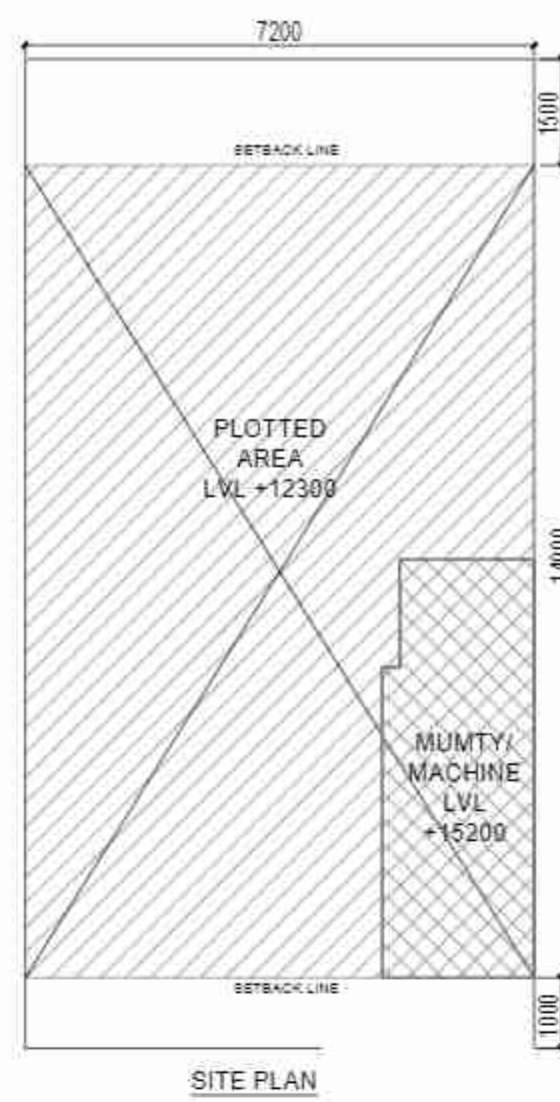

100 MM RCC WALL
100 MM AAC WALL

AREA CALCULATION				AREA	UNIT
TOTAL PLOT AREA (7.20 X 14.00)				100.800	SQ.M.
PERMISSIBLE FAR @ 2				201.600	SQ.M.
PROPOSED FAR @ 1.988				200.436	SQ.M.
PERMISSIBLE GR. COV. @ 75.0%				75.600	SQ.M.
PROPOSED GROUND COVERAGE @ 74.89%				75.589	SQ.M.
AREA OF STILT FLOOR (GR COVERAGE)					
1	2.040	X	1.780	X	1 = 3.631 SQ.M.
2	2.035	X	1.780	X	1 = 3.622 SQ.M.
3	7.200	X	9.400	X	1 = 67.680 SQ.M.
4	2.050	X	0.320	X	1 = 0.656 SQ.M.
TOTAL					75.589 SQ.M.
TOTAL GROUND COVERAGE					
1	1.825	X	1.600	X	1 = 2.920 SQ.M.
2	2.075	X	4.220	X	1 = 8.767 SQ.M.
TOTAL					11.687 SQ.M.
DEDUCTION					
A	1.825	X	4.105	X	1 = 7.502 SQ.M.
TOTAL AREA OF STILT FLOOR					3.774 SQ.M.

AREA OF TYPICAL FLOOR (1ST TO 3RD)					
1	2.040	X	1.780	X	1 = 3.631 SQ.M.
2	2.035	X	1.780	X	1 = 3.622 SQ.M.
3	7.200	X	9.400	X	1 = 67.680 SQ.M.
4	2.050	X	0.320	X	1 = 0.656 SQ.M.
TOTAL					75.589 SQ.M.
DEDUCTION					
A	1.825	X	1.500	X	1 = 2.738 SQ.M.
B	1.925	X	4.005	X	1 = 7.710 SQ.M.
TOTAL					10.448 SQ.M.
TOTAL AREA OF TYPICAL FLOOR					
					65.554 SQ.M.
TOTAL FLOOR AREA					
					200.436 SQ.M.
TOTAL GROUND COVERAGE					
					75.589 SQ.M.
TOTAL BUILT UP AREA					
					378.179 SQ.M.

PLUMBING LEGENDS:
(1) 110 OD SOIL PIPE PVC SWR TYPE-B (SOLVENT JOINT)
(2) 110 OD WASTE PIPE PVC SWR TYPE-B (SOLVENT JOINT)
(3) COLD WATER SUPPLY ON TAKE FOR 1ST & 2ND FLR (PVC SCH40)
(4) COLD WATER SUPPLY ON TAKE FOR 3RD & 4TH FLR (PVC SCH40)
(5) 25mm WATER SUPPLY RISER PIPE (PVC SCH40)
(6) 75 OD RWP FOR (TERRACE/BALCONY)
(7) PVC SWR TYPE-A TYPE-B UNDER GROUND
(8) CLEAN OUT PLUG

DOOR WINDOW SCHEDULE					
TYPE	WIDTH	HEIGHT	SILL LVL	LINTEL LVL	REMARKS
D1	900	2400	± 0	2400	ENTRANCE
D2	900	2400	± 0	2150	BEDROOMS
D3	750	2400	± 0	2150	TOILETS
DW2	900/385	2400/1500	± 00/900	2400	BED ROOM
DW3	900/525	2400/1500	± 00/900	2400	BED ROOM
SD1	2000	2400	± 0	2400	LIVING
W1	900	1200	1200	2400	KITCHEN
V1	450	1100	1050	2150	TOILETS






PROJECT:
PROPOSED BUILDING PLAN ON PLOT NO - B-12a,B-13a,B-14a,B-15b,B-16b,B-17b & B-18b (07 PLOTS) FOR AFFORDABLE RESIDENTIAL PLOTTED COLONY (UNDER DEEN-DAYAL JAN AWAS YOJNA) OVER AN AREA 57.40 ACRES (LICENCE NO.32 OF 2021 DATED 03.07.2021 FOR AN AREA MEASURING 52.275 ACRES & LICENCE NO. 102 OF 2022 DATED 27.02.2022 FOR AN AREA MEASURING 5.125 ACRES) IN THE REVENUE ESTATE OF VILLAGE-HAYATPUR, SECTOR 89, GURUGRAM BEING DEVELOPED BY AAWAM RESIDENCY PRIVATE LIMITED & OTHERS IN COLLABORATION WITH ADHIKAANSH REALTORS PRIVATE LIMITED

DRAWING TITLE :
TYPE B - FLOOR PLANS WITH AREA CALCULATION, ELEVATIONS & SECTIONS (RIGHT SIDE)


ARCHITECT'S SIGN
Ar. ABHISHEK DWIVEDI
CA/2017/03517

AUTHORIZED SIGN

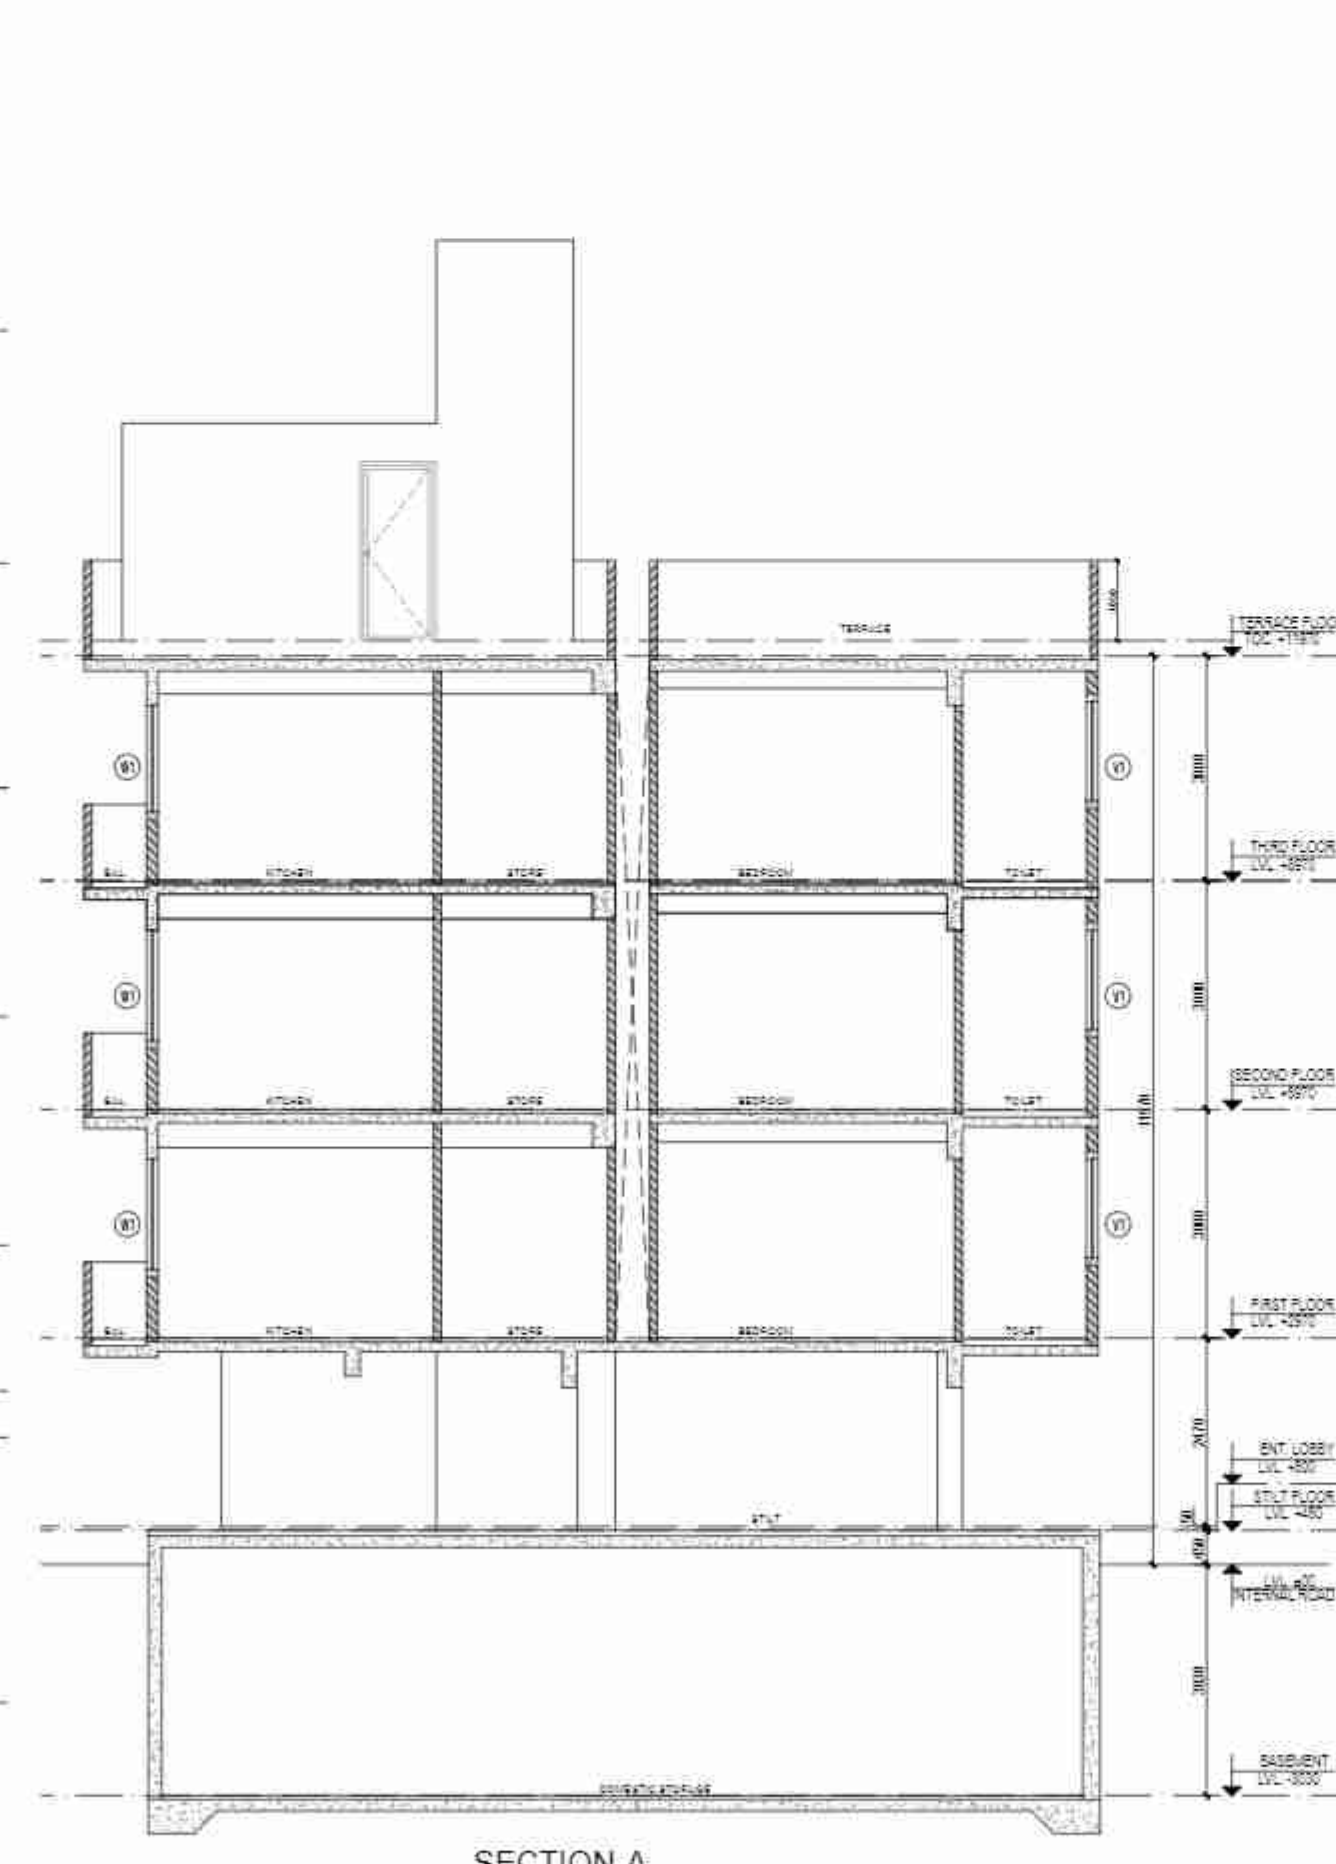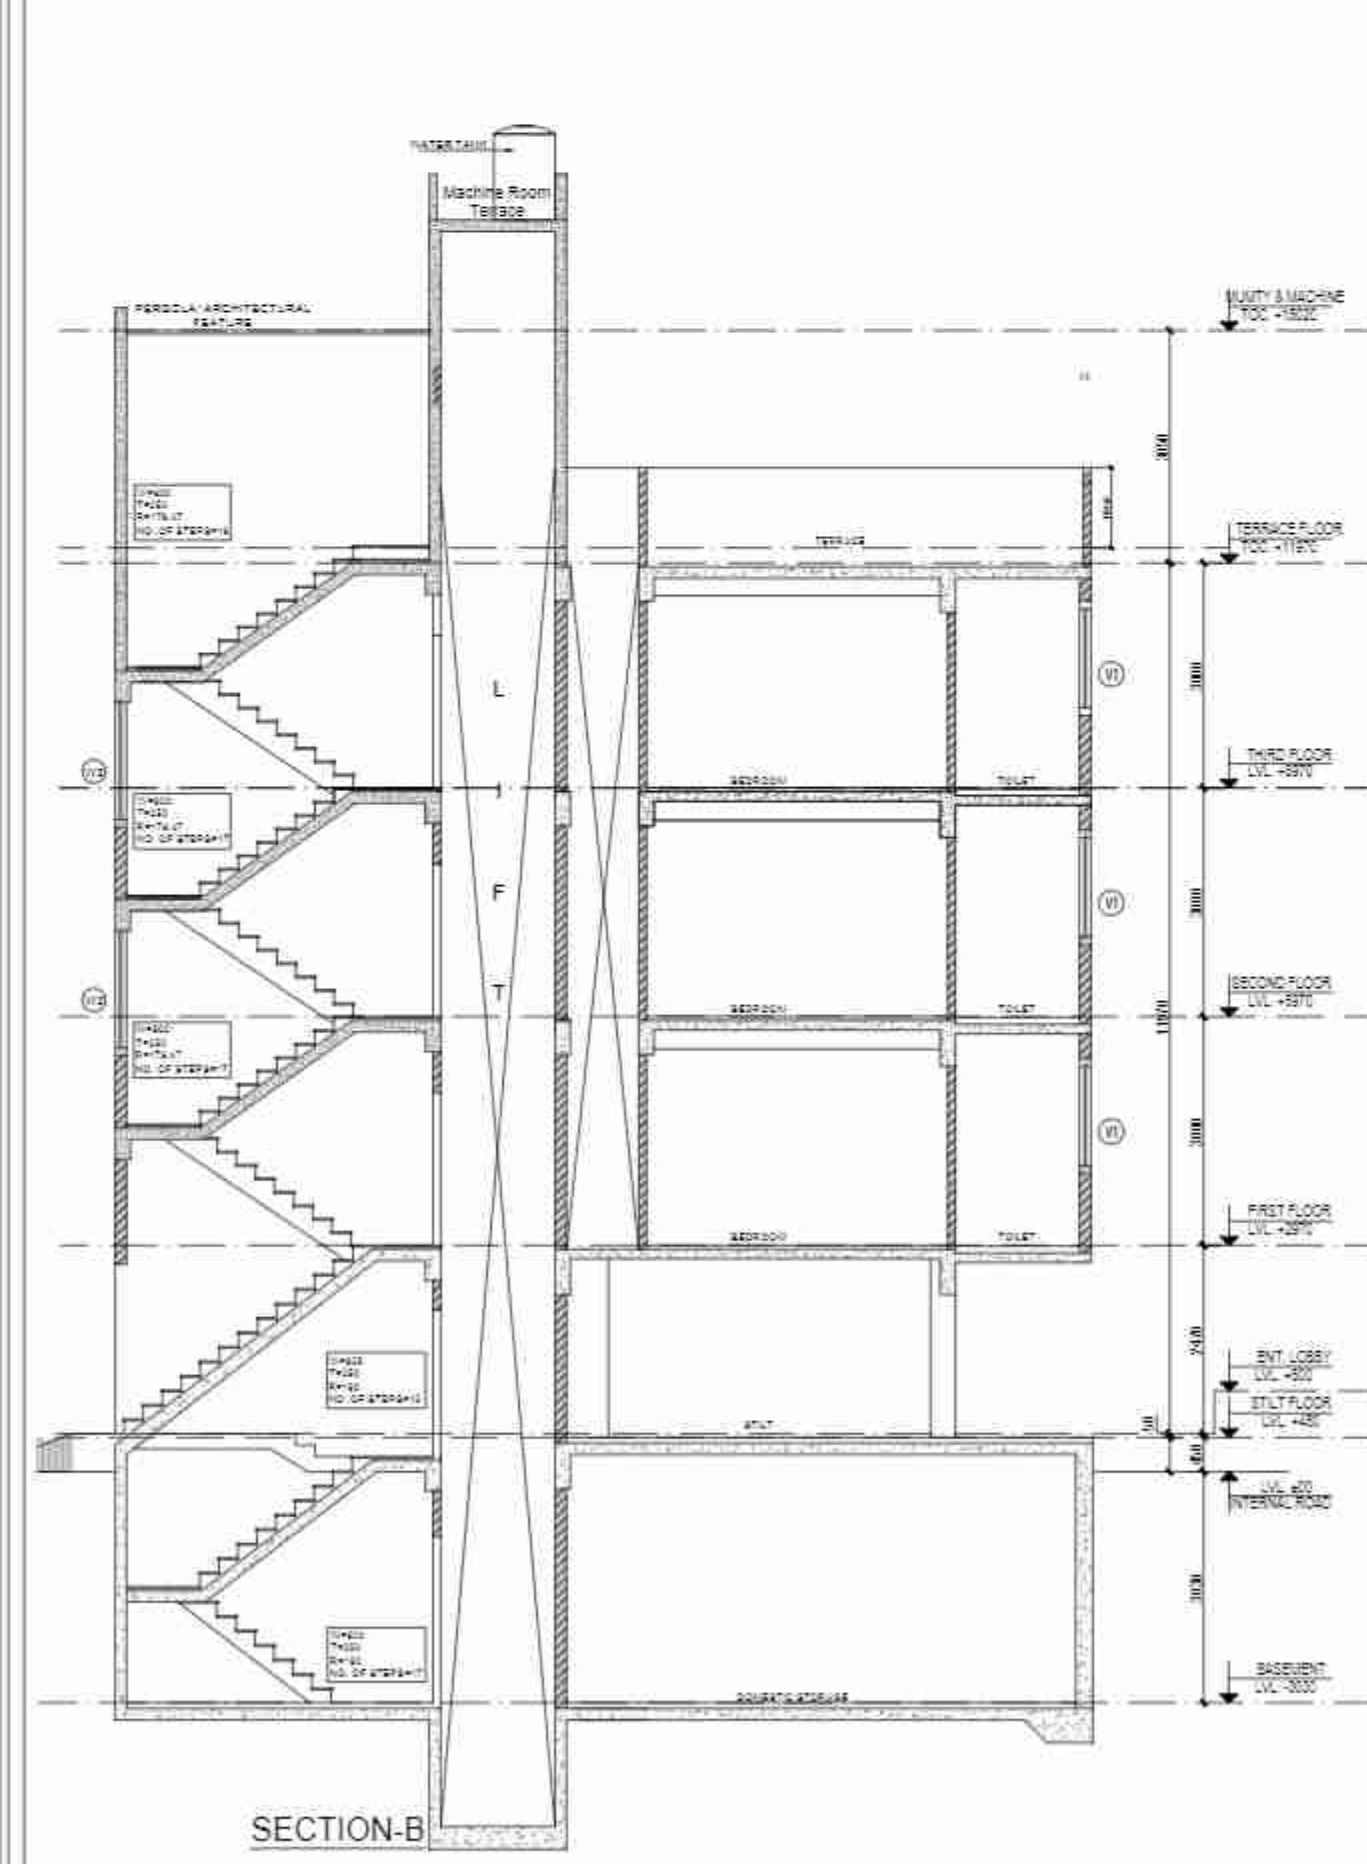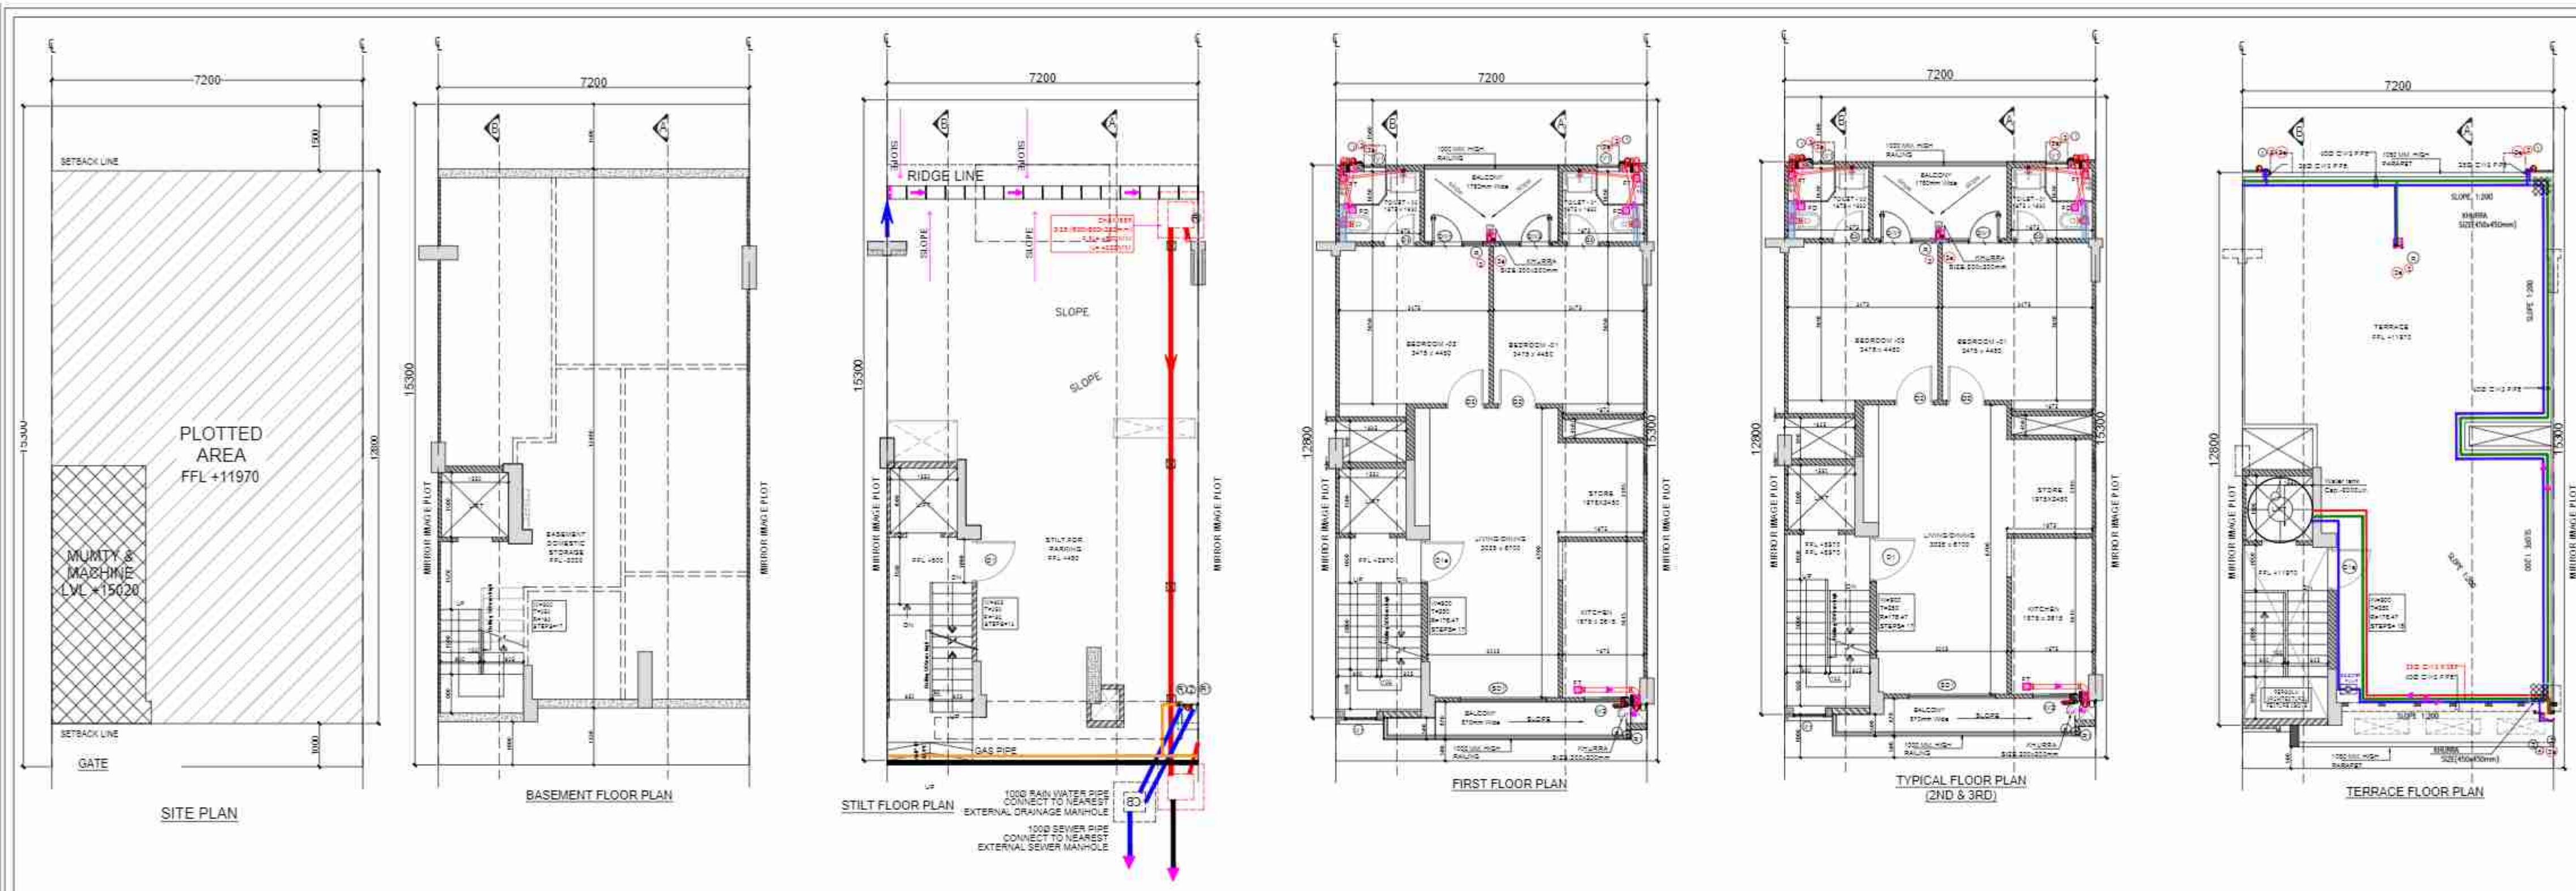

LEGEND
15mm Blockwork for Outer Walls
100mm Blockwork for Internal Walls

DOOR WINDOW SCHEDULE					
TYPE	WIDTH	HEIGHT	SILL LVL	LINTEL LVL	REMARKS
D1 Frames	1050	2350	± 00	2350	ENTRANCE
D18 Frames	1000	2350	± 00	2350	ENTRANCE
D2 Frames	900	2350	± 00	2350	BEDROOMS
D3 Frames	750	2350	± 00	2350	TOILETS
D5 Frames	1000	2350	± 00	2350	BEDROOMS
D6 Frames	2000	2350	± 00	2350	BEDROOMS
DW1 Glass	750-1200	Beam bottom	± 00	Beam bottom	BEDROOMS
DW2 Glass	750-1150	Beam bottom	± 00	Beam bottom	BEDROOMS
DW3 Glass	750-1125	Beam bottom	± 00	Beam bottom	BEDROOMS
W1 Glass	750	Beam bottom	Beam bottom	Beam bottom	STAIRCASE
W2 Glass	850	1450	900	2350/Beam bottom	KITCHEN
W3 Glass	500	1350	1000	2350	TOILETS

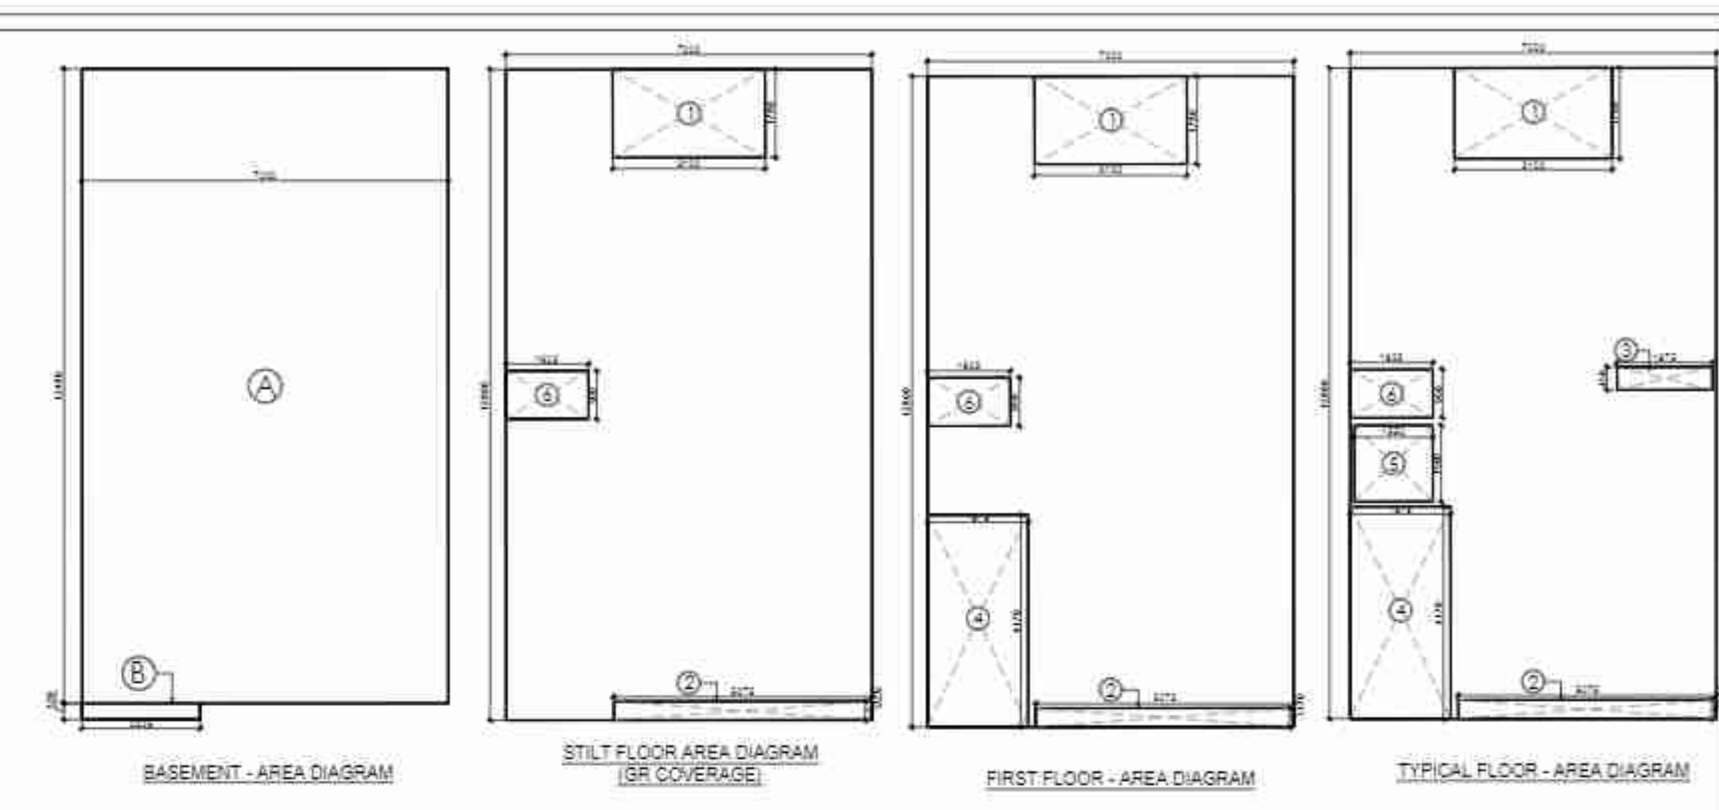

AREA CALCULATION					
				AREA	UNIT
TOTAL PLOT AREA (7.2X15.3)				110.160	SQ.M.
PERMISSIBLE FAR @ 2.64				290.822	SQ.M.
PROPOSED FAR @ 1.982				218.328	SQ.M.
PERMISSIBLE GR. COV. @ 75%				82.620	SQ.M.
PROPOSED GROUND COVERAGE @ 74.98%				82.602	SQ.M.
AREA OF STILT FLOOR/ GROUND COVERAGE					
A	7.200	X	12.800	X	1 = 92.160 SQ.M.
TOTAL				92.160	SQ.M.
DEDUCTION					
1	1.780	X	3.100	X	1 = 5.518 SQ.M.
2	0.370	X	5.075	X	1 = 1.878 SQ.M.
6	1.625	X	0.950	X	1 = 1.544 SQ.M.
TOTAL				8.939	SQ.M.
TOTAL AREA OF STILT FLOOR/ GROUND COVERAGE (A)				82.602	SQ.M.
AREA OF FIRST FLOOR					
A	7.200	X	12.800	X	1 = 92.160 SQ.M.
TOTAL				92.160	SQ.M.
DEDUCTION					
1	1.780	X	3.100	X	1 = 5.518 SQ.M.
2	0.370	X	5.075	X	1 = 1.878 SQ.M.
4	1.975	X	4.170	X	1 = 8.236 SQ.M.
6	1.625	X	0.950	X	1 = 1.544 SQ.M.
TOTAL				17.466	SQ.M.
TOTAL AREA OF FIRST FLOOR (B)				74.694	SQ.M.
AREA OF TYPICAL FLOOR (2ND & 3RD)					
A	7.200	X	12.800	X	1 = 92.160 SQ.M.
TOTAL				92.160	SQ.M.
DEDUCTION					
1	1.780	X	3.100	X	1 = 5.518 SQ.M.
2	0.370	X	5.075	X	1 = 1.878 SQ.M.
3	1.875	X	0.450	X	1 = 0.844 SQ.M.
4	1.975	X	4.170	X	1 = 8.236 SQ.M.
5	1.550	X	1.500	X	1 = 2.325 SQ.M.
6	1.625	X	0.950	X	1 = 1.544 SQ.M.
TOTAL				20.343	SQ.M.
TOTAL AREA OF TYPICAL FLOOR (C)				71.817	SQ.M.
TOTAL FLOOR AREA (D)					
= (1ST FLOOR + 2ND FLOOR + 3RD FLOOR)				218.328	SQ.M.
BASEMENT AREA					
A	7.200	X	12.480	X	1 = 89.856 SQ.M.
B	0.320	X	2.325	X	1 = 0.744 SQ.M.
TOTAL BASEMENT AREA (E)				90.600	SQ.M.
MUMTY/ MACHINE ROOM AREA					
B	2.175	X	1.850	X	1 = 4.024 SQ.M.
TOTAL MUMTY/ MACHINE ROOM AREA (F)				4.024	SQ.M.
STAIRCASE AREA					
4	1.975	X	4.170	X	4 = 32.943 SQ.M.
TOTAL STAIRCASE AREA (G)				32.943	SQ.M.
TOTAL BUILT-UP AREA (A+D+E+F+G)				428.496	SQ.M.

PLUMBING LEGENDS:

- (1) 110 OD SOIL PIPE PVC SWR TYPE-B (SOLVENT JOINT)
- (2) 110 OD WASTE PIPE PVC SWR TYPE-B (SOLVENT JOINT)
- (3) COLD WATER SUPPLY ON TAKE FOR 1ST & 2ND FLP. (PVC SCH-40)
- (4) COLD WATER SUPPLY ON TAKE FOR 3RD & 4TH FLP. (PVC SCH-40)
- (5) 250 WATER SUPPLY RISE PIPE (PVC SCH-40)
- (6) 75 OD R/W FOR (EALCONVY) TERRACE
- (7) PVC SWR TYPE-A UNDER GROUND
- (8) 110 OD R/W FOR TERRACE
- (9) PVC SWR TYPE-A, TYPE-B UNDER GROUND
- (10) CLEAN OUT PLUG


MUMTY/MACHINE ROOM

KEY PLAN

PROJECT:
PROPOSED BUILDING PLAN ON PLOT NO.- C-2.4.6 FOR RESIDENTIAL PLOTTED COLONY UNDER DEEN DAYAL JAN AWAS YOJNA OVER AN AREA MEASURING 57.40ACRES (LICENSE NO. 32 OF 2021, DATED 03.07.2021 FOR AN AREA MEASURING 52.275 ACRES & LICENSE NO. 102 OF 2022 DATED 27.02.2022 FOR AN AREA MEASURING 5.125 ACRES) IN THE REVENUE ESTATE OF VILLAGE HAYATPUR, SECTOR-89, GURUGRAM BEING DEVELOPED BY AAWAM RESIDENCY PRIVATE LIMITED & OTHERS IN COLLABORATION WITH ADHIKAANSH PRIVATE LIMITED.

DRAWING TITLE:
FLOOR PLANS WITH AREA CALCULATION, ELEVATIONS AND SECTIONS
TYPE- C (Left)

ARCHITECT'S SIGN **AUTHORIZED SIGN**

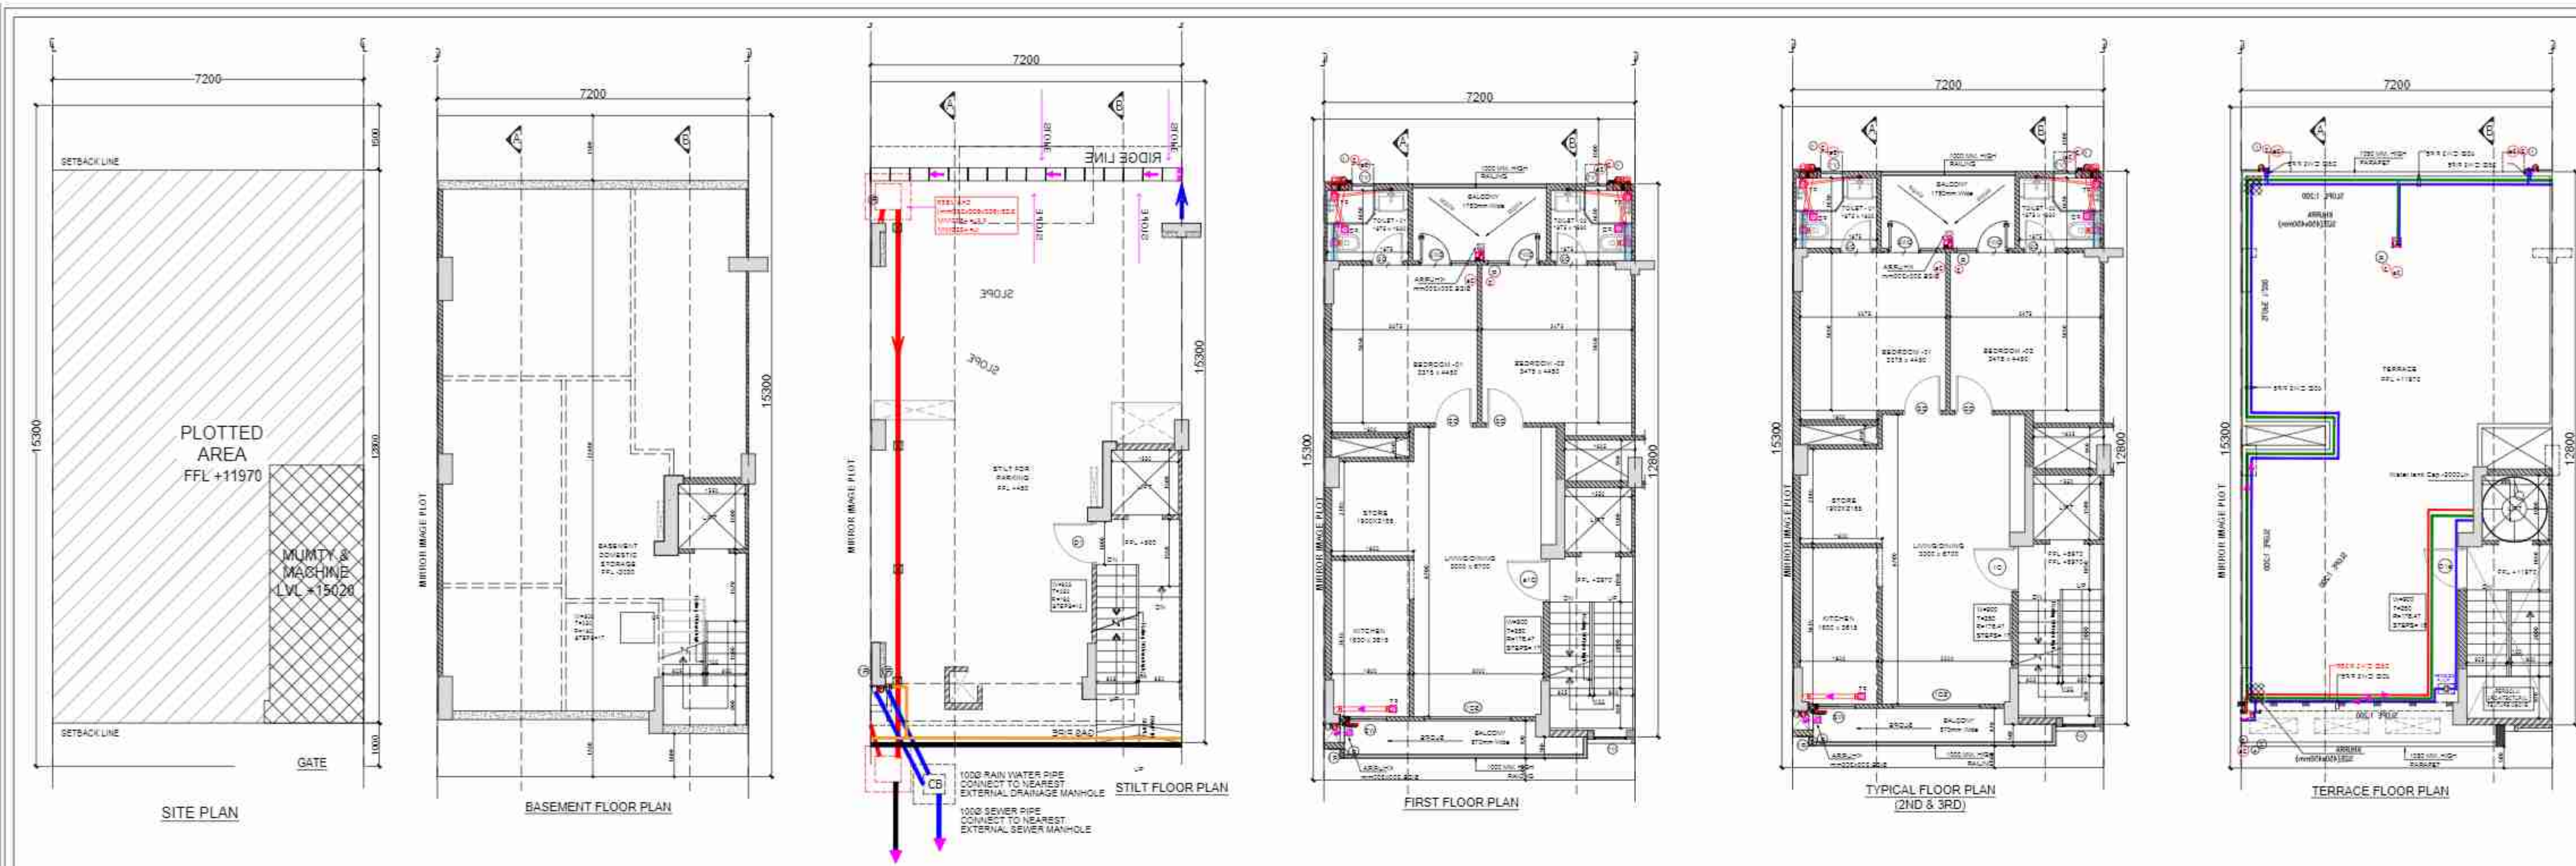

AREA CALCULATION				AREA	UNIT
TOTAL PLOT AREA (7.2X15.3)				110.160	SQ.M.
PERMISSIBLE FAR @ 2.64				290.822	SQ.M.
PROPOSED FAR @ 1.982				218.328	SQ.M.
PERMISSIBLE GR. COV. @ 75%				82.620	SQ.M.
PROPOSED GROUND COVERAGE @ 74.98%				82.602	SQ.M.

AREA OF STILT FLOOR/ GROUND COVERAGE				AREA	UNIT
A	7.200	X	12.800	92.160	SQ.M.
TOTAL				92.160	SQ.M.
DEDUCTION					
1	1.780	X	3.100	5.518	SQ.M.
2	0.370	X	5.075	1.878	SQ.M.
6	1.625	X	0.950	1.544	SQ.M.
TOTAL				8.939	SQ.M.
TOTAL AREA OF STILT FLOOR/ GROUND COVERAGE (A)				82.602	SQ.M.

AREA OF FIRST FLOOR				AREA	UNIT
A	7.200	X	12.800	92.160	SQ.M.
TOTAL				92.160	SQ.M.
DEDUCTION					
1	1.780	X	3.100	5.518	SQ.M.
2	0.370	X	5.075	1.878	SQ.M.
4	1.975	X	4.170	8.236	SQ.M.
6	1.625	X	0.950	1.544	SQ.M.
TOTAL				17.466	SQ.M.
TOTAL AREA OF FIRST FLOOR (B)				74.694	SQ.M.




AREA OF TYPICAL FLOOR (2ND & 3RD)				AREA	UNIT
A	7.200	X	12.800	92.160	SQ.M.
TOTAL				92.160	SQ.M.
DEDUCTION					
1	1.780	X	3.100	5.518	SQ.M.
2	0.370	X	5.075	1.878	SQ.M.
3	1.875	X	0.450	0.844	SQ.M.
4	1.975	X	4.170	8.236	SQ.M.
5	1.550	X	1.500	2.325	SQ.M.
6	1.625	X	0.950	1.544	SQ.M.
TOTAL				20.343	SQ.M.
TOTAL AREA OF TYPICAL FLOOR (C)				71.817	SQ.M.

TOTAL FLOOR AREA (D)				AREA	UNIT
= (1ST FLOOR + 2ND FLOOR + 3RD FLOOR)				218.328	SQ.M.

BASEMENT AREA				AREA	UNIT
A	7.200	X	12.480	89.856	SQ.M.
B	0.320	X	2.325	0.744	SQ.M.
TOTAL BASEMENT AREA (E)				90.600	SQ.M.
MUMTY/ MACHINE ROOM AREA				AREA	UNIT
B	2.175	X	1.850	4.024	SQ.M.
TOTAL MUMTY/ MACHINE ROOM AREA (F)				4.024	SQ.M.

STAIRCASE AREA				AREA	UNIT
4	1.975	X	4.170	8.243	SQ.M.
TOTAL STAIRCASE AREA (G)				32.943	SQ.M.
TOTAL BUILT-UP AREA (A+E+F+G)				428.496	SQ.M.

PLUMBING LEGEND:	
1	110 OD SOIL PIPE PVC SWR TYPE-B (SOLVENT JOINT)
2	110 OD WASTE PIPE PVC SWR TYPE-B (SOLVENT JOINT)
3	COLD WATER SUPPLY ON TAKE FOR 1ST & 2ND FLP. (PVC SCH 40)
4	COLD WATER SUPPLY ON TAKE FOR 3RD & 4TH FLP. (PVC SCH 40)
5	250 WASTE SUPPLY RISE PIPE (PVC SCH 40)
6	75 OD R/W FOR (EALCONV) TERRACE
7	PVC SWR TYPE-A, TYPE-B UNDER GROUND
8	110 OD R/W FOR TERRACE
9	PVC SWR TYPE-A, TYPE-B UNDER GROUND
10	COP CLEAN OUT PLUG

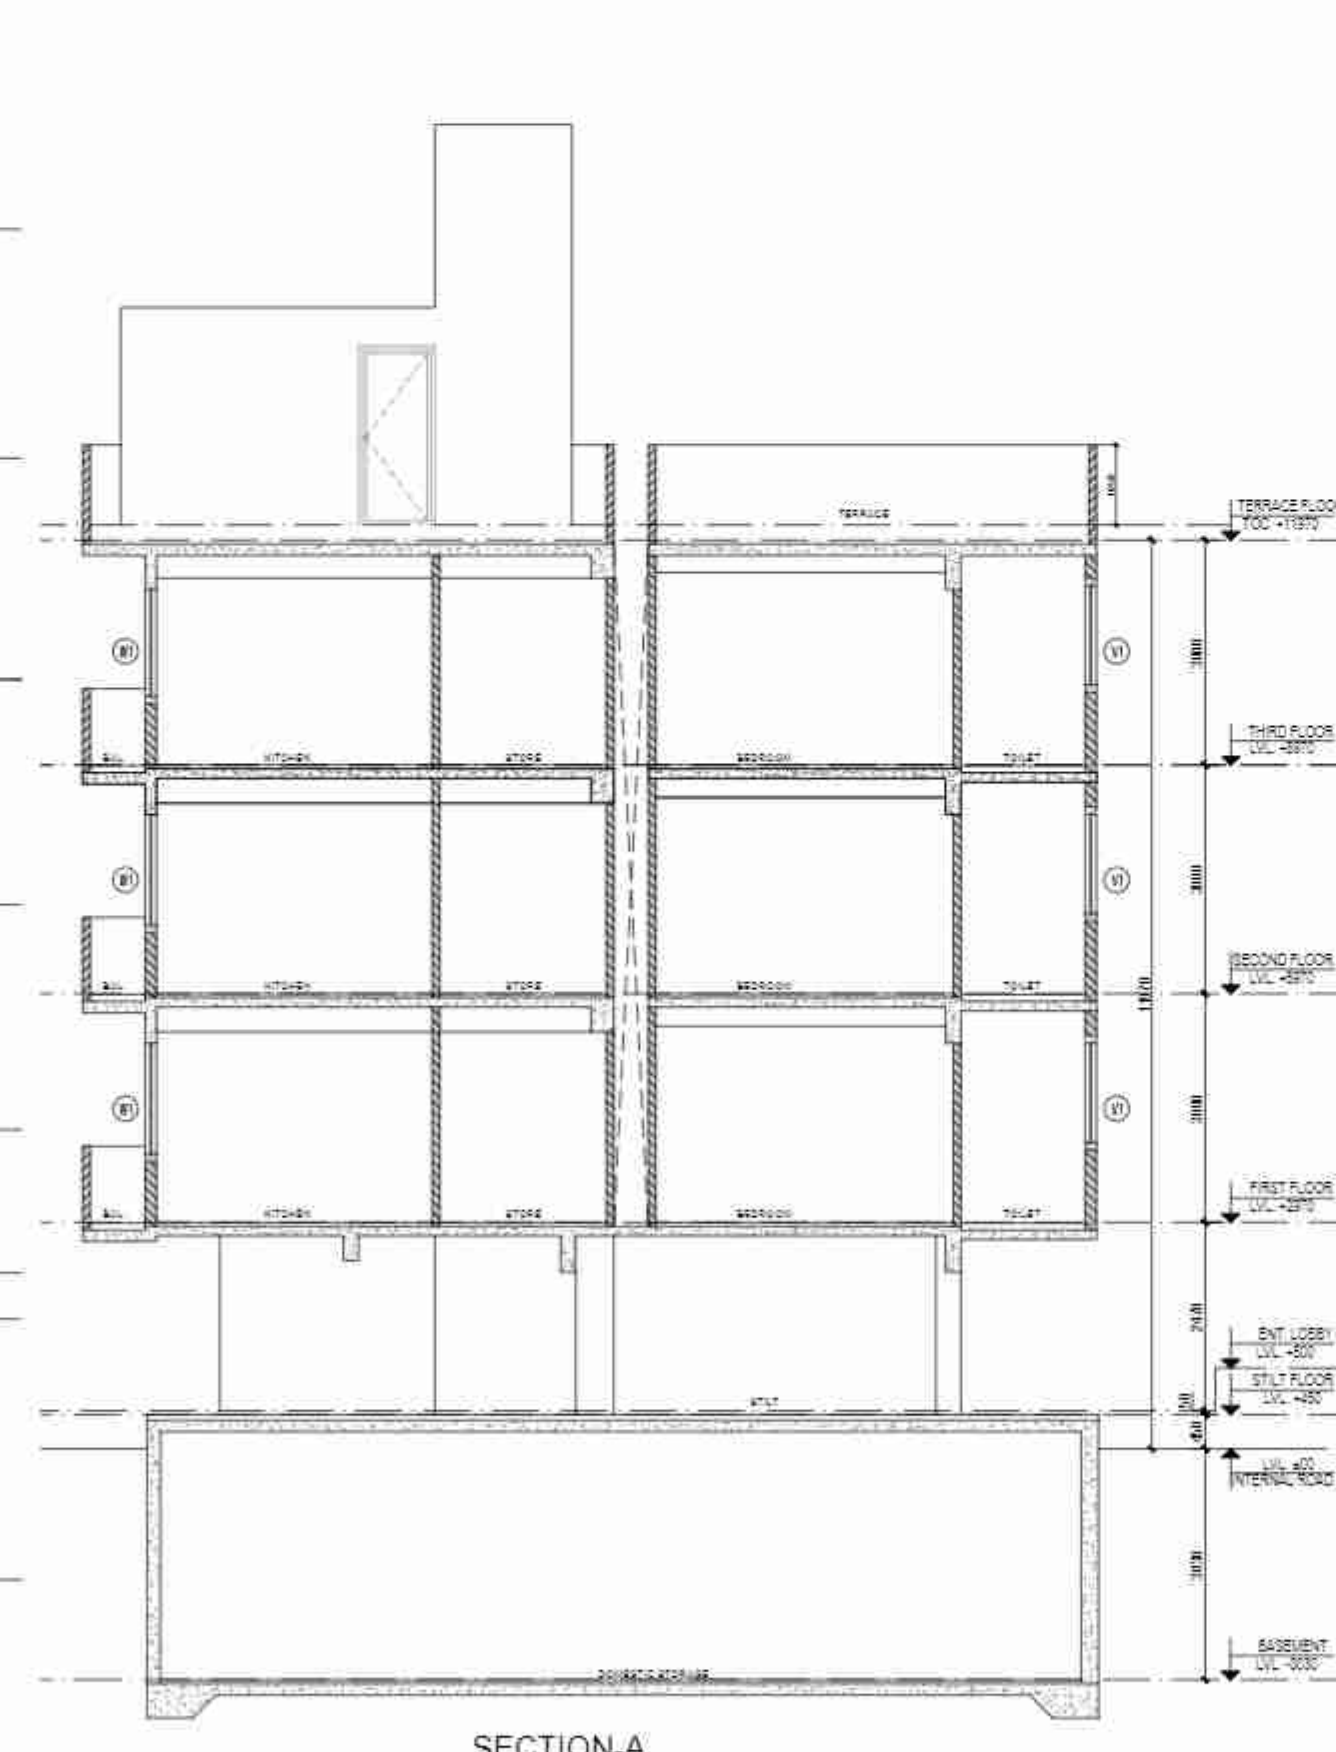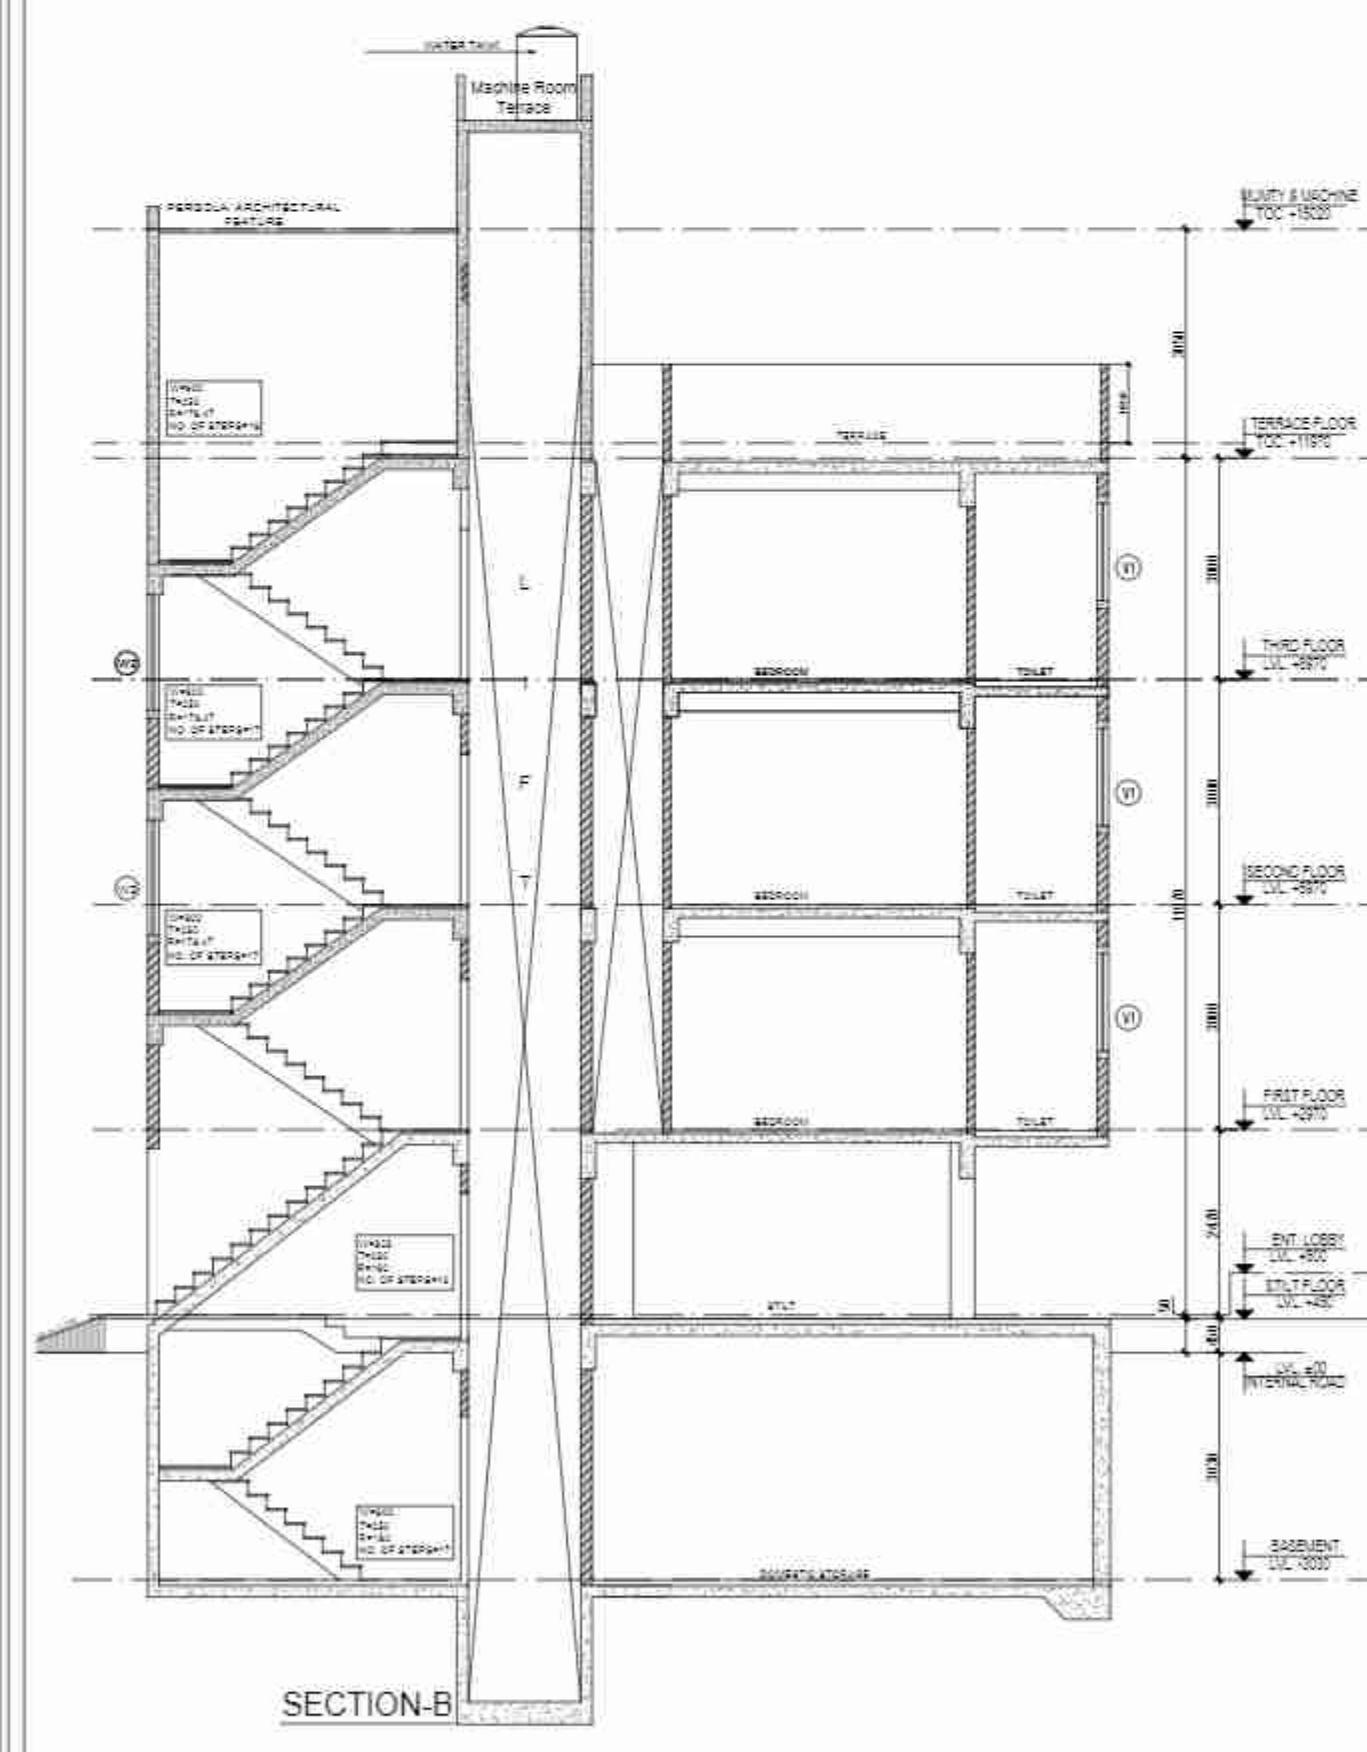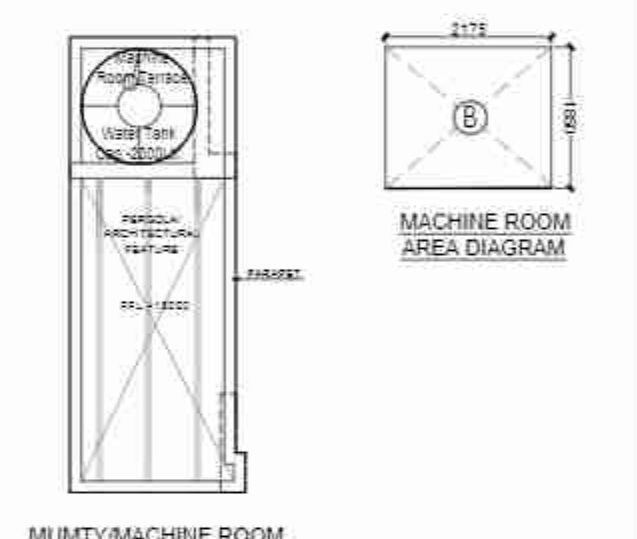

LEGEND	
150mm	Blockwork for Outer Walls
100mm	Blockwork for Internal Walls




DOOR WINDOW SCHEDULE					
TYPE	WIDTH	HEIGHT	SILL LVL	LINTEL LVL	REMARKS
D1	1050	2350	± 00	2350	ENTRANCE
D1A	1000	2350	± 00	2350	ENTRANCE
D2	900	2350	± 00	2350	BEDROOMS
D3	750	2350	± 00	2350	TOILETS
D4	1000	2350	± 00	2350	BASEMENT
D5	2000	2350	± 00	2350	LIVING
DW1	750-1200	Beam bottom	± 00	Beam bottom	BEDROOMS
DW2	750-1150	Beam bottom	± 00	Beam bottom	BEDROOMS
DW3	750-1125	Beam bottom	± 00	Beam bottom	BEDROOMS
W1	750	Beam bottom	Beam bottom	Beam bottom	STAIRCASE
W2	850	1450	900	2350/Beam bottom	KITCHEN
W3	500	1350	1000	2350	TOILETS

PROJECT:
PROPOSED BUILDING PLAN ON PLOT NO - C-1, C-7 FOR RESIDENTIAL PLOTTED COLONY UNDER DEEN DAYAL JAN AWAS YOJNA OVER AN AREA MEASURING 57.40ACRES (LICENSE NO. 32 OF 2021, DATED 03.07.2021 FOR AN AREA MEASURING 52.275 ACRES & LICENSE NO. 102 OF 2022 DATED 27.02.2022 FOR AN AREA MEASURING 5.125 ACRES) IN THE REVENUE ESTATE OF VILLAGE HAYATPUR, SECTOR-89, GURUGRAM BEING DEVELOPED BY AAWAM RESIDENCY PRIVATE LIMITED & OTHERS IN COLLABORATION WITH ADHIKAANSH PRIVATE LIMITED.


DRAWING TITLE
FLOOR PLANS WITH AREA CALCULATION, ELEVATIONS AND SECTIONS
TYPE- C (Right Corner)

ARCHITECT'S SIGN
AUTHORIZED SIGN

ADHIKAANSH PRIVATE LIMITED
GURUGRAM

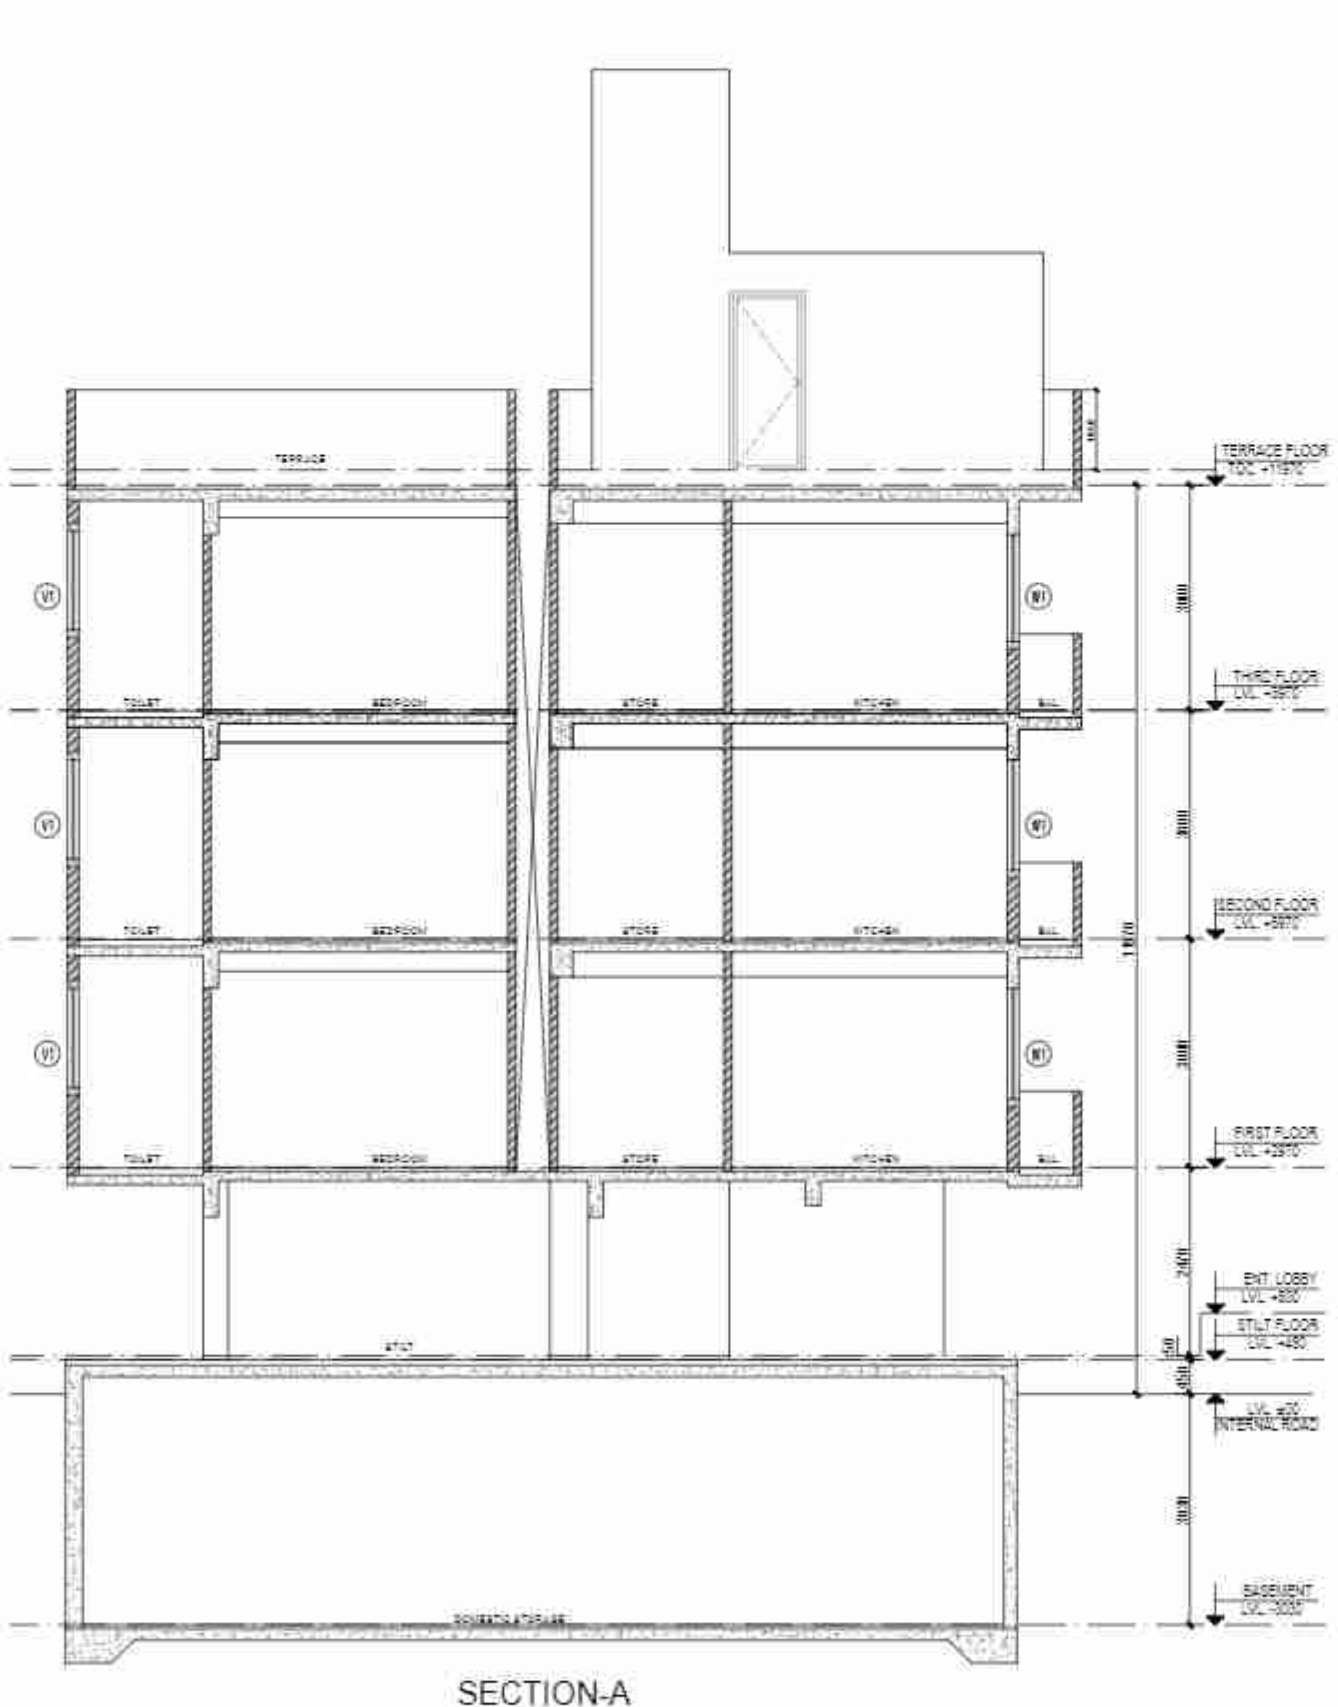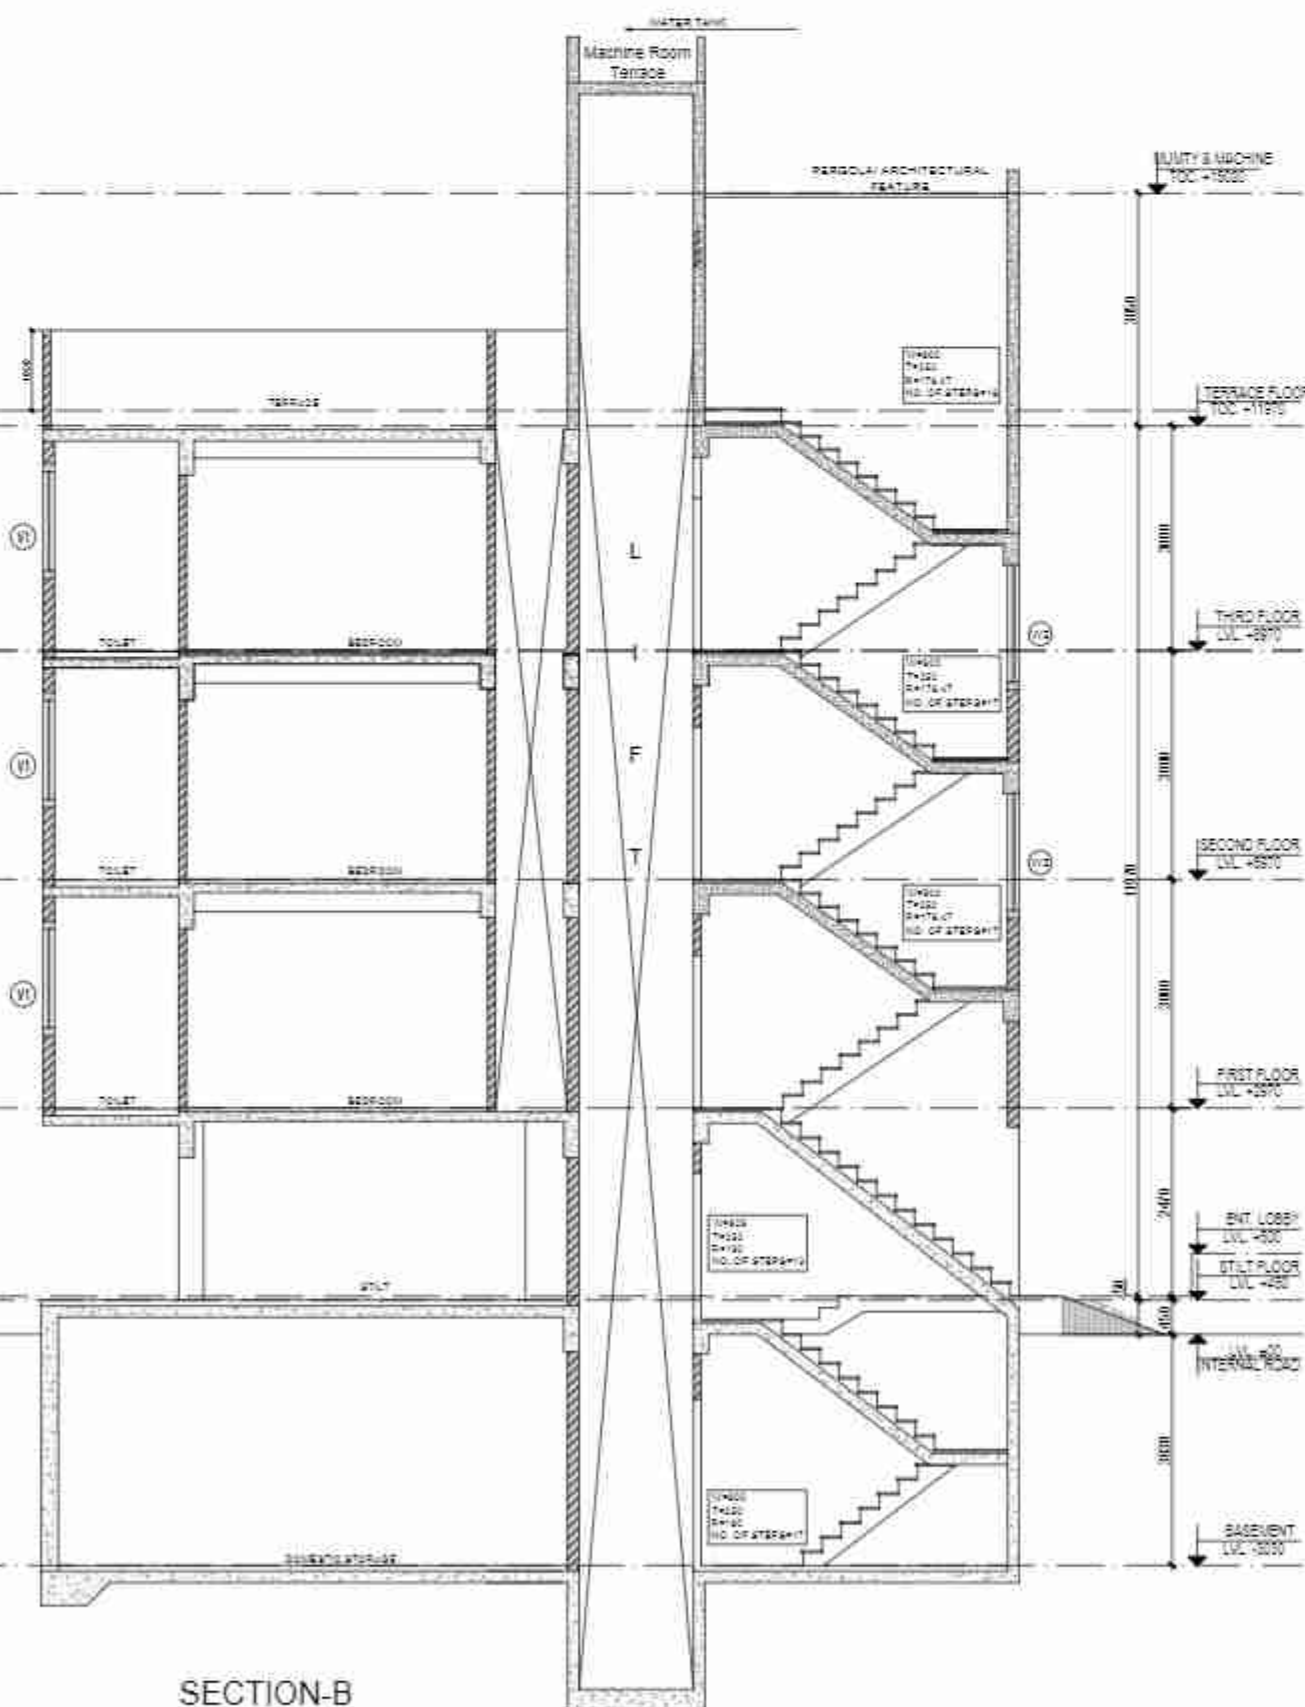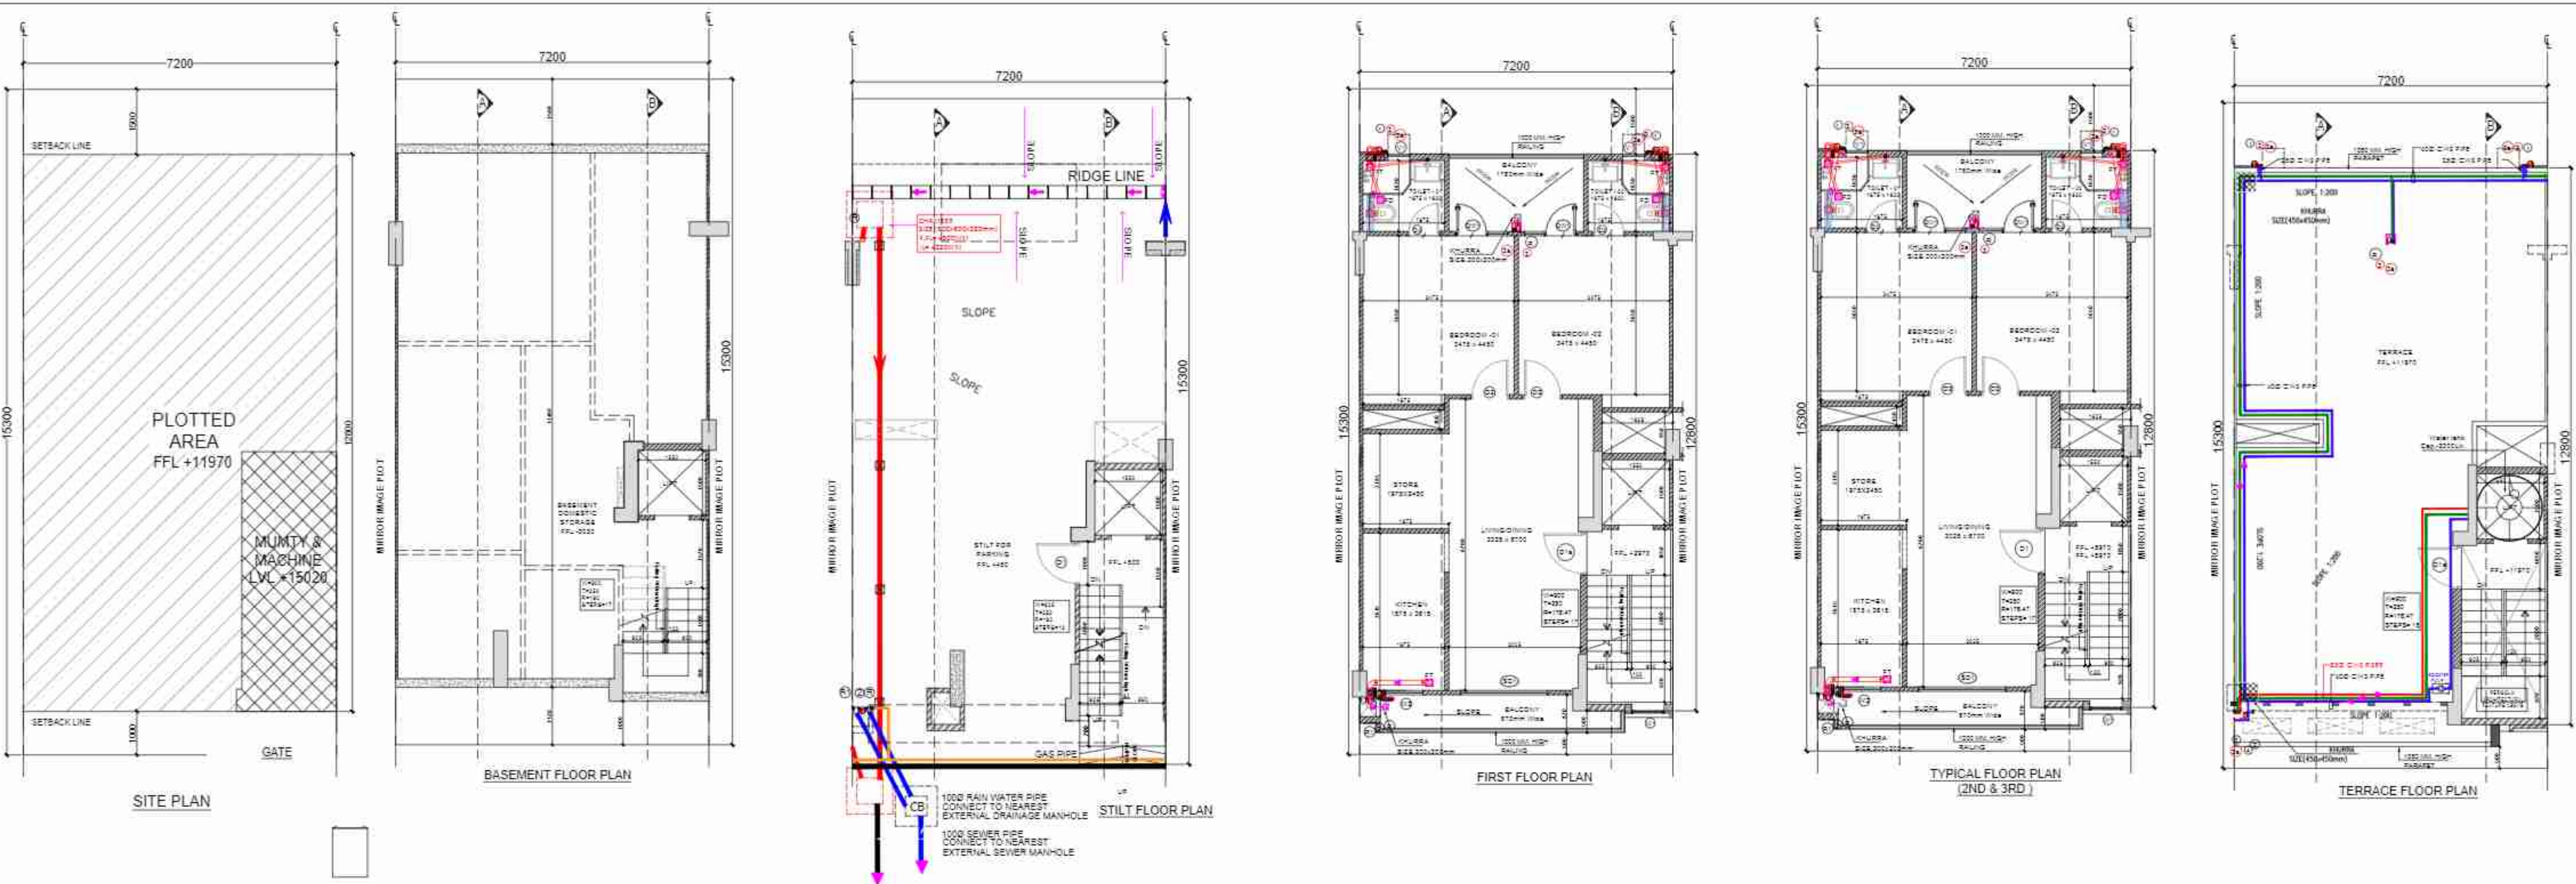

DOOR WINDOW SCHEDULE					
TYPE	WIDTH	HEIGHT	SILL LVL	LINTEL LVL	REMARKS
D1	1050	2350	± 00	2350	ENTRANCE
D1A	1000	2350	± 00	2350	ENTRANCE
D2	900	2350	± 00	2350	BEDROOMS
D3	750	2350	± 00	2350	TOILETS
D4	1000	2350	± 00	2350	BASEMENT
D5	2000	2350	± 00	2350	LIVING
D1V1	750-1200	Beam bottom	± 00	Beam bottom	BEDROOMS
D1V2	750-1150	Beam bottom	± 00	Beam bottom	BEDROOMS
D1V3	750-1125	Beam bottom	± 00	Beam bottom	BEDROOMS
V1	750	Beam bottom	Beam bottom	Beam bottom	STAIRCASE
V2	850	1450	900	2350/Beam bottom	KITCHEN
V3	500	1350	1000	2350	TOILETS

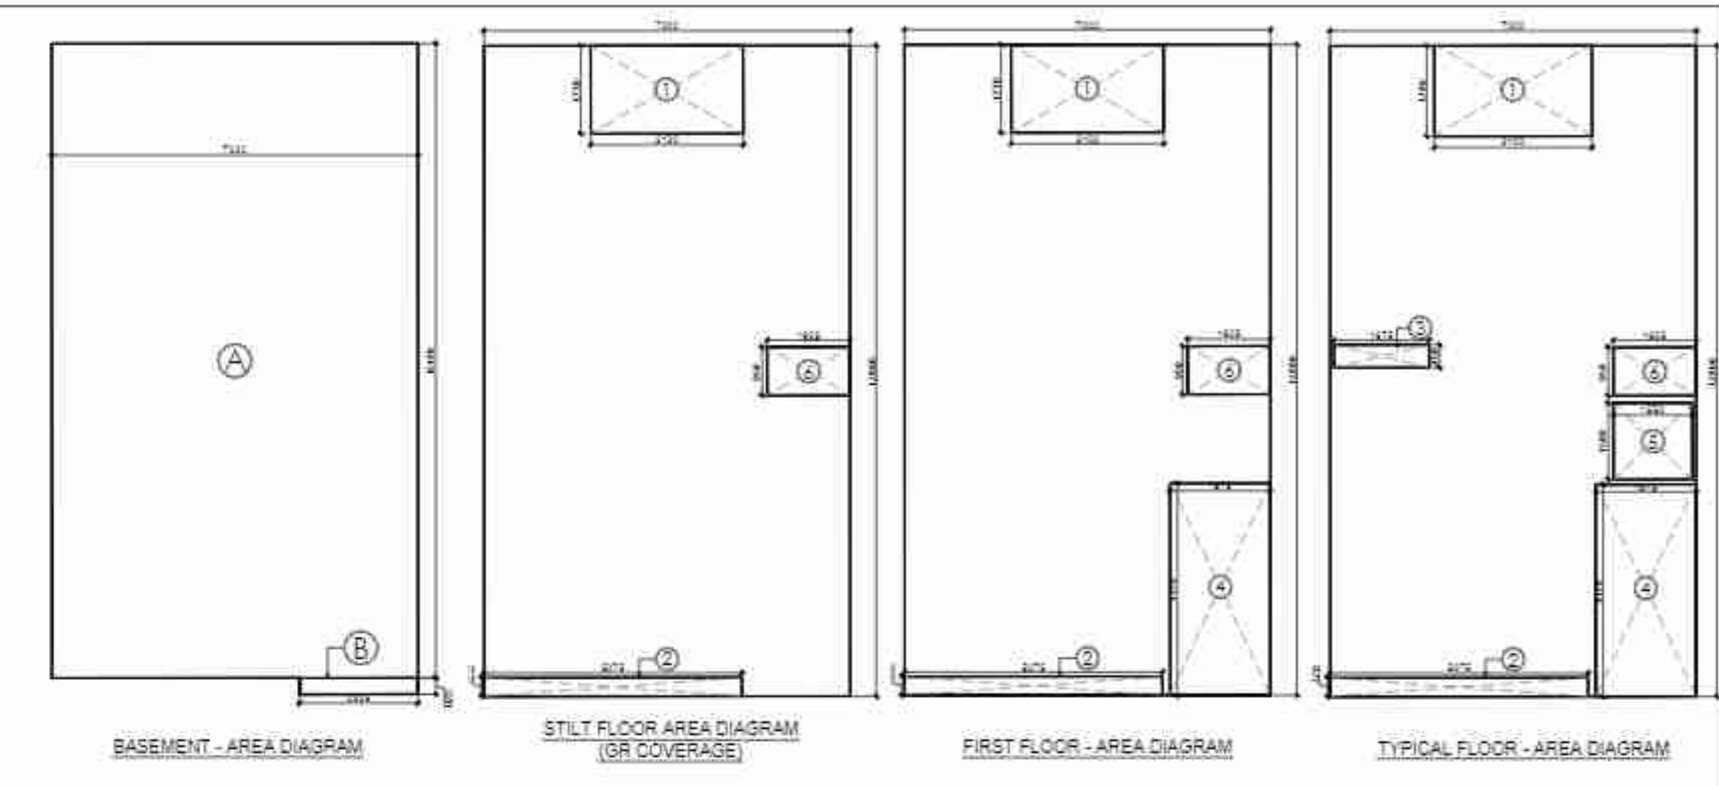

AREA CALCULATION				AREA	UNIT
TOTAL PLOT AREA (7.2X15.3)				110.160	SQ.M.
PERMISSIBLE FAR @ 2.64				290.822	SQ.M.
PROPOSED FAR @ 1.982				218.328	SQ.M.
PERMISSIBLE GR. COV. @ 75%				82.620	SQ.M.
PROPOSED GROUND COVERAGE @ 74.98%				82.602	SQ.M.

AREA OF STILT FLOOR/ GROUND COVERAGE					
A	7.200	X	12.800	X	1
TOTAL					92.160
DEDUCTION					
1	1.780	X	3.100	X	1
2	0.370	X	5.075	X	1
6	1.625	X	0.950	X	1
TOTAL					6.939
TOTAL AREA OF STILT FLOOR/ GROUND COVERAGE (A)					82.602

AREA OF FIRST FLOOR					
A	7.200	X	12.800	X	1
TOTAL					92.160
DEDUCTION					
1	1.780	X	3.100	X	1
2	0.370	X	5.075	X	1
4	1.975	X	4.170	X	1
6	1.625	X	0.950	X	1
TOTAL					17.466
TOTAL AREA OF FIRST FLOOR (B)					74.694

AREA OF TYPICAL FLOOR (2ND & 3RD)					
A	7.200	X	12.800	X	1
TOTAL					92.160
DEDUCTION					
1	1.780	X	3.100	X	1
2	0.370	X	5.075	X	1
3	1.875	X	0.450	X	1
4	1.975	X	4.170	X	1
5	1.550	X	1.500	X	1
6	1.625	X	0.950	X	1
TOTAL					20.343
TOTAL AREA OF TYPICAL FLOOR (C)					71.817



TOTAL FLOOR AREA (D)					
= (1ST FLOOR + 2ND FLOOR + 3RD FLOOR)					218.328

BASEMENT AREA					
A	7.200	X	12.480	X	1
B	0.320	X	2.325	X	1
TOTAL BASEMENT AREA (E)					90.600

MUMTY/ MACHINE ROOM AREA					
B	2.175	X	1.850	X	1
TOTAL MUMTY/ MACHINE ROOM AREA (F)					4.024

STAIRCASE AREA					
4	1.975	X	4.170	X	4
TOTAL STAIRCASE AREA (G)					32.943
TOTAL BUILT-UP AREA (A+D+E+F+G)					428.496













PLUMBING LEGEND:	
1	110 OD SOIL PIPE (PVC SWR TYPE-B) (SOLVENT JOINT)
2	110 OD WASTE PIPE (PVC SWR TYPE-B) (SOLVENT JOINT)
3	COLD WATER SUPPLY ON TAKE FOR 1ST & 2ND FLOOR (PVC SCH-40)
4	COLD WATER SUPPLY ON TAKE FOR 3RD & 4TH FLOOR (PVC SCH-40)
5	250 WATER SUPPLY RISE PIPE (PVC SCH-40)
6	75 OD R/W FOR (EALCONV) TERRACE
7	PVC SWR TYPE-A TYPES UNDER GROUND
8	110 OD R/W FOR TERRACE
9	PVC SWR TYPE-A TYPES UNDER GROUND
10	COP CLEAN OUT PLUG

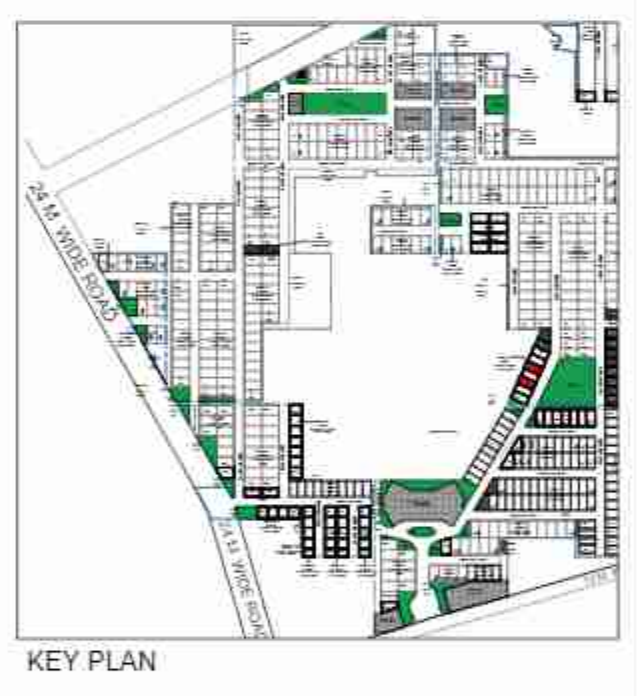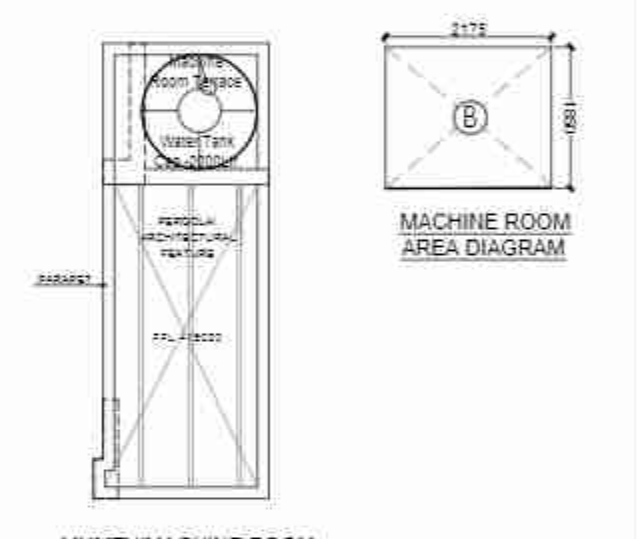

PROJECT:
PROPOSED BUILDING PLAN ON PLOT NO - C-3, C-5 FOR RESIDENTIAL PLOTTED COLONY UNDER DEEN DAYAL JAN AWAS YOJNA OVER AN AREA MEASURING 57.40ACRES (LICENSE NO. 32 OF 2021, DATED 03.07.2021 FOR AN AREA MEASURING 52.275 ACRES & LICENSE NO. 102 OF 2022 DATED 27.02.2022 FOR AN AREA MEASURING 5.125 ACRES) IN THE REVENUE ESTATE OF VILLAGE HAYATPUR, SECTOR-89, GURUGRAM BEING DEVELOPED BY AAWAM RESIDENCY PRIVATE LIMITED & OTHERS IN COLLABORATION WITH ADHIKAANSH PRIVATE LIMITED.

DRAWING TITLE:
FLOOR PLANS WITH AREA CALCULATION, ELEVATIONS AND SECTIONS
TYPE - C (Right)

ARCHITECT'S SIGN
AUTHORIZED SIGN

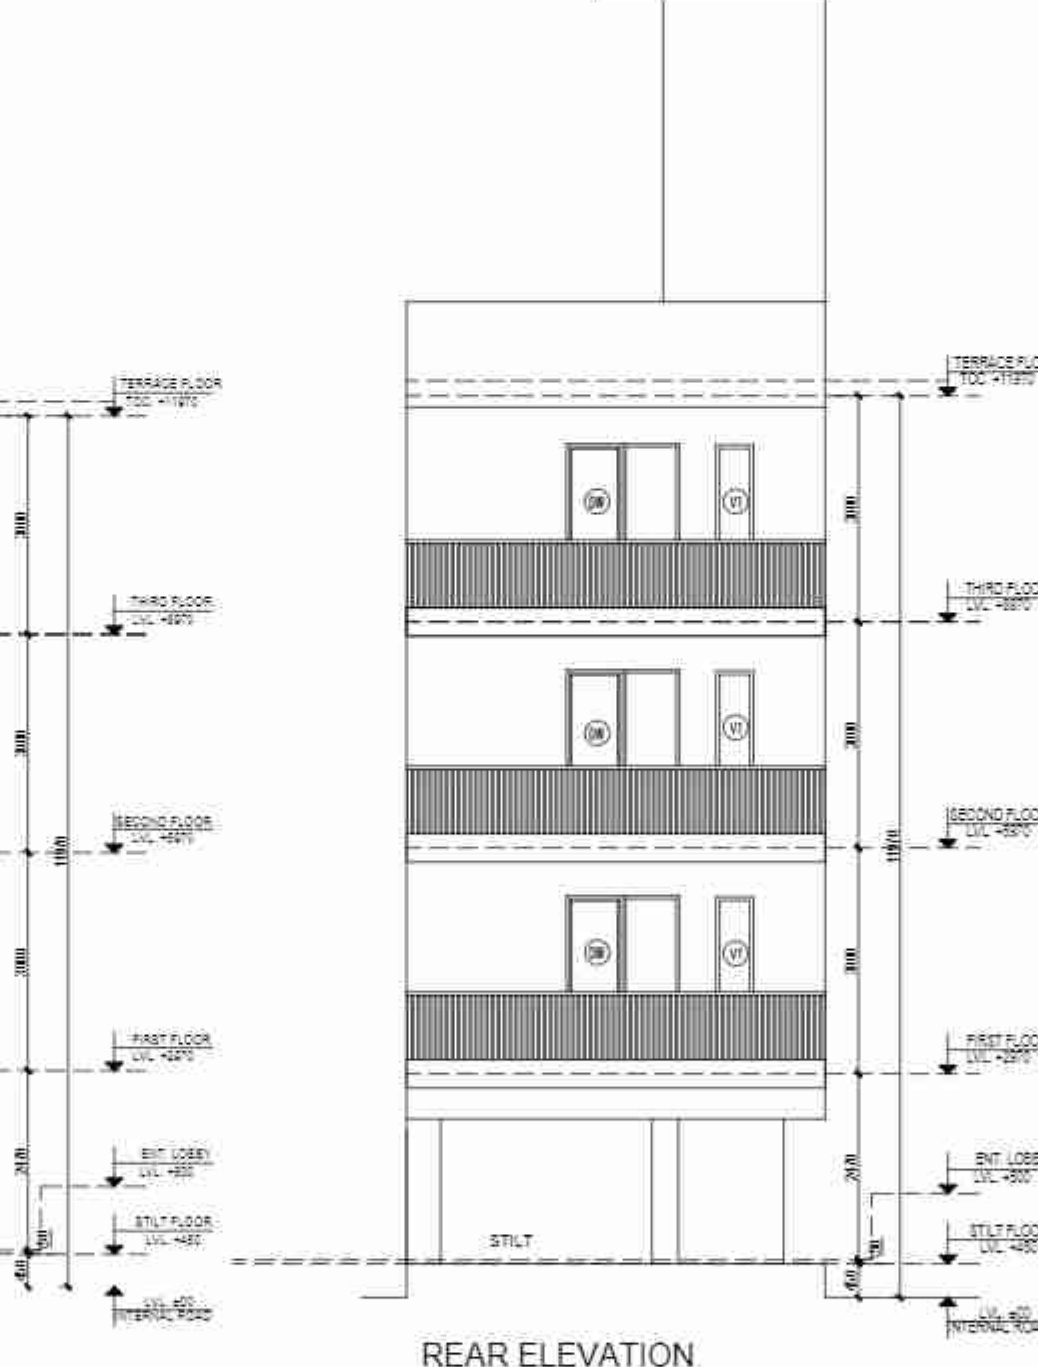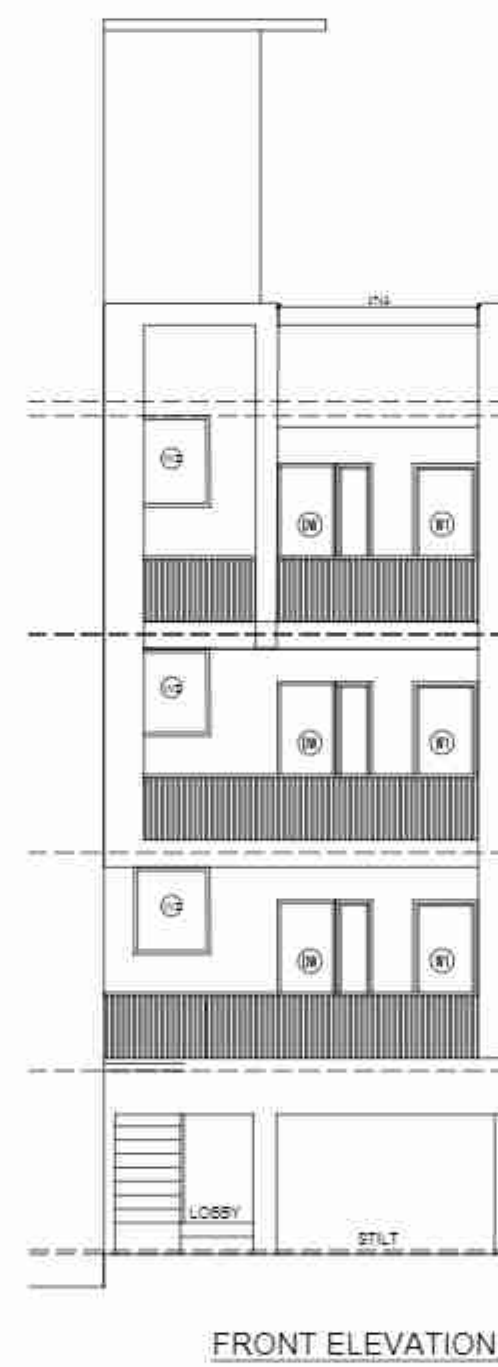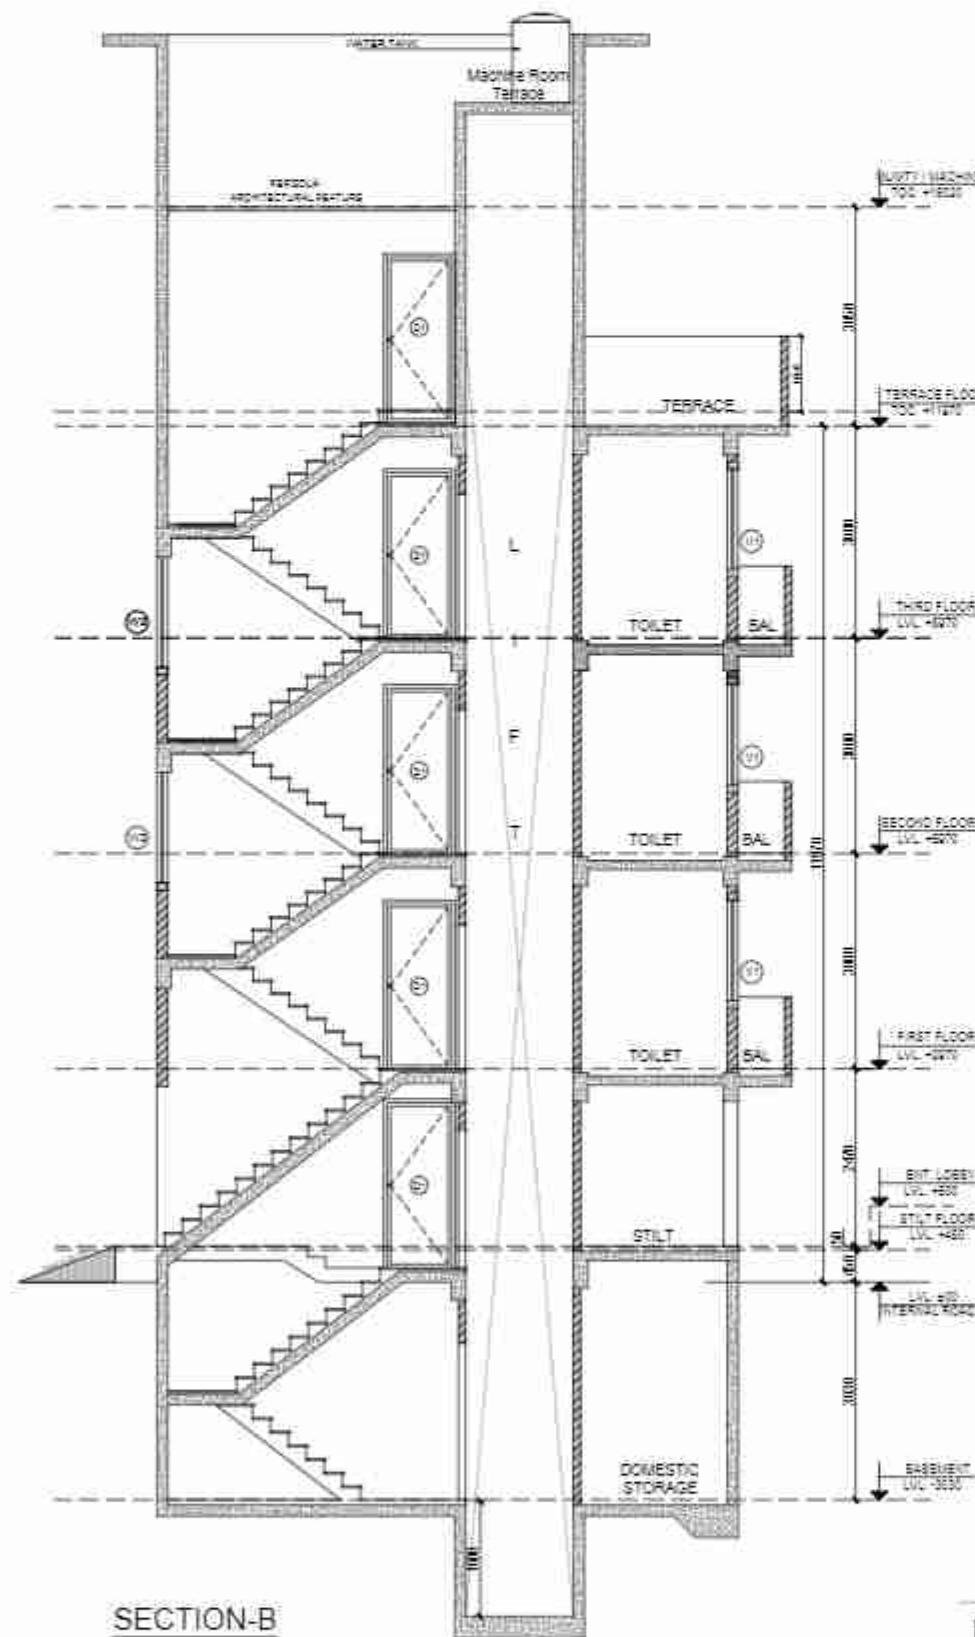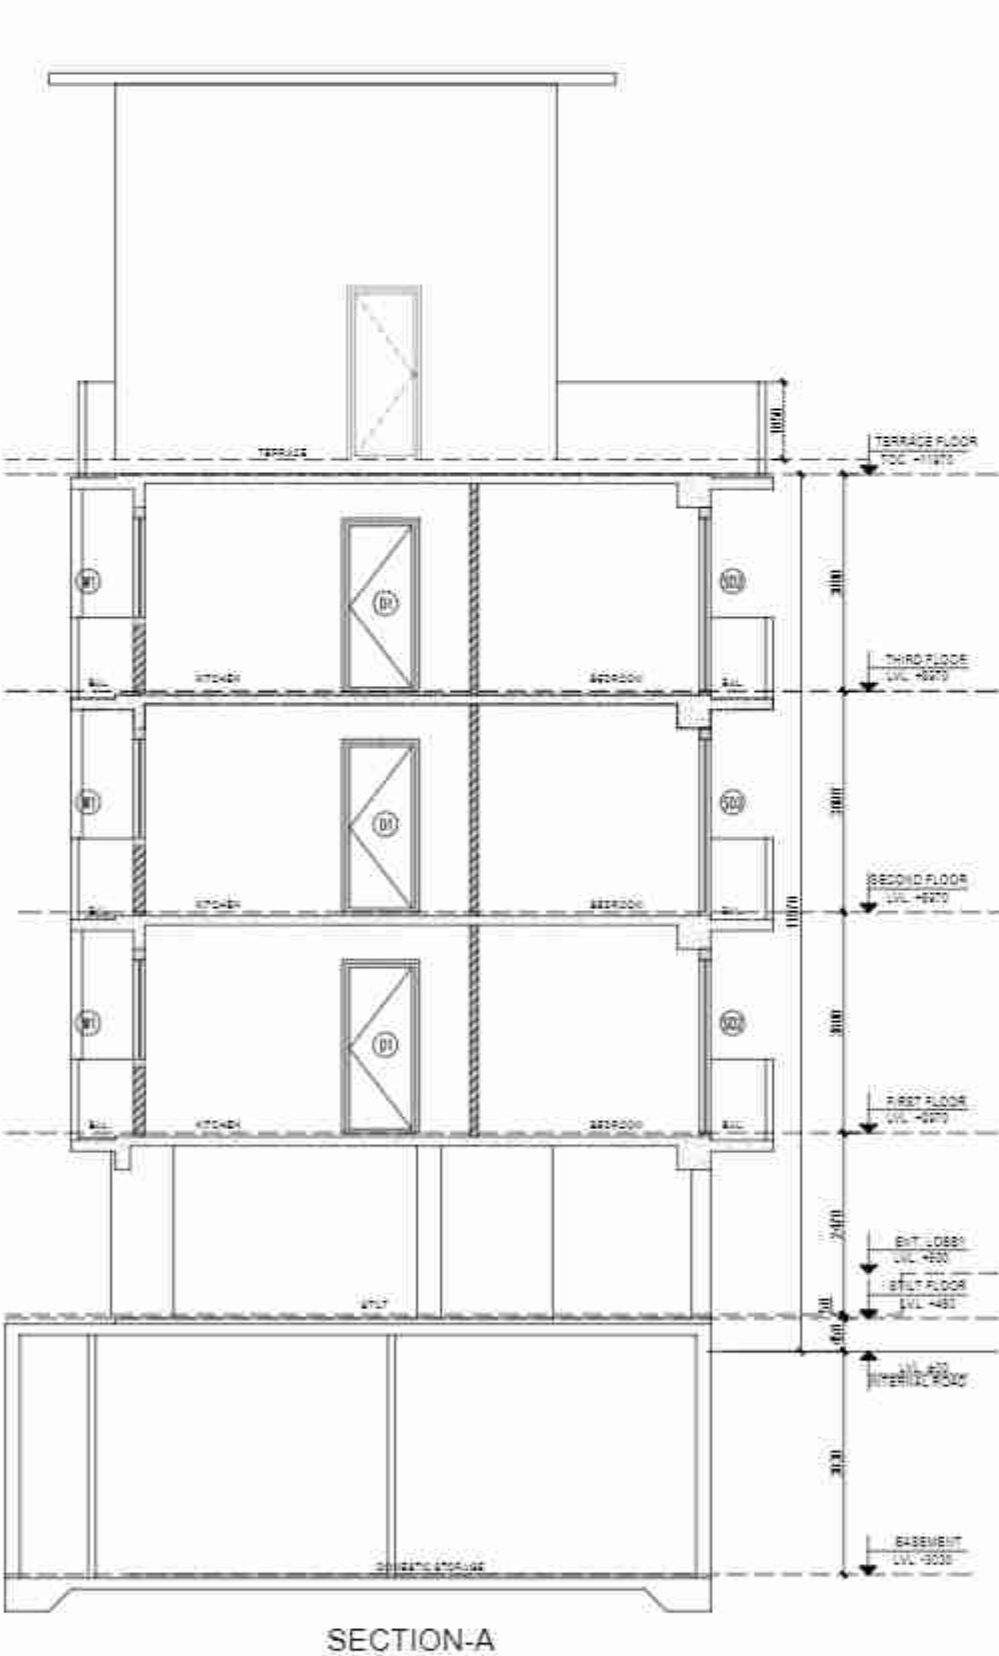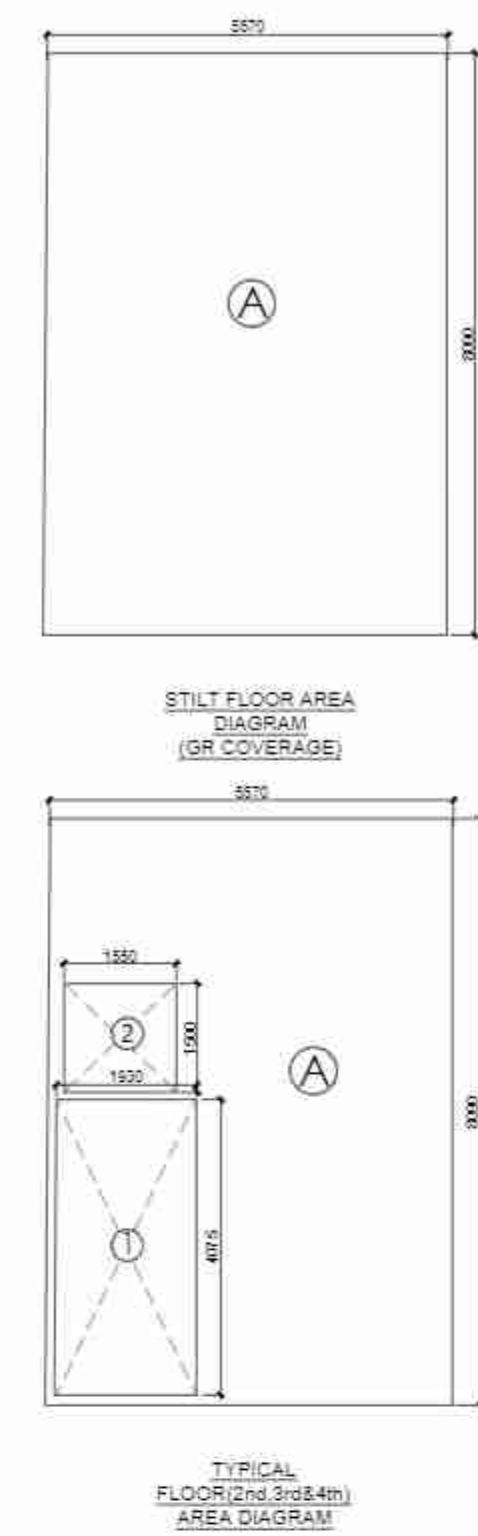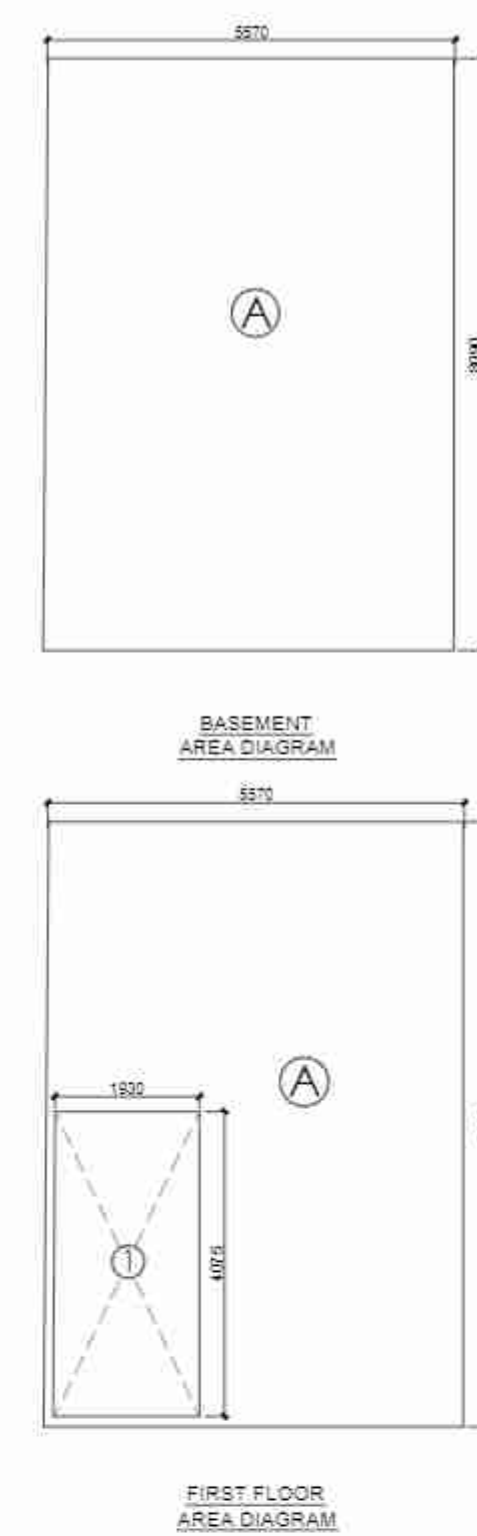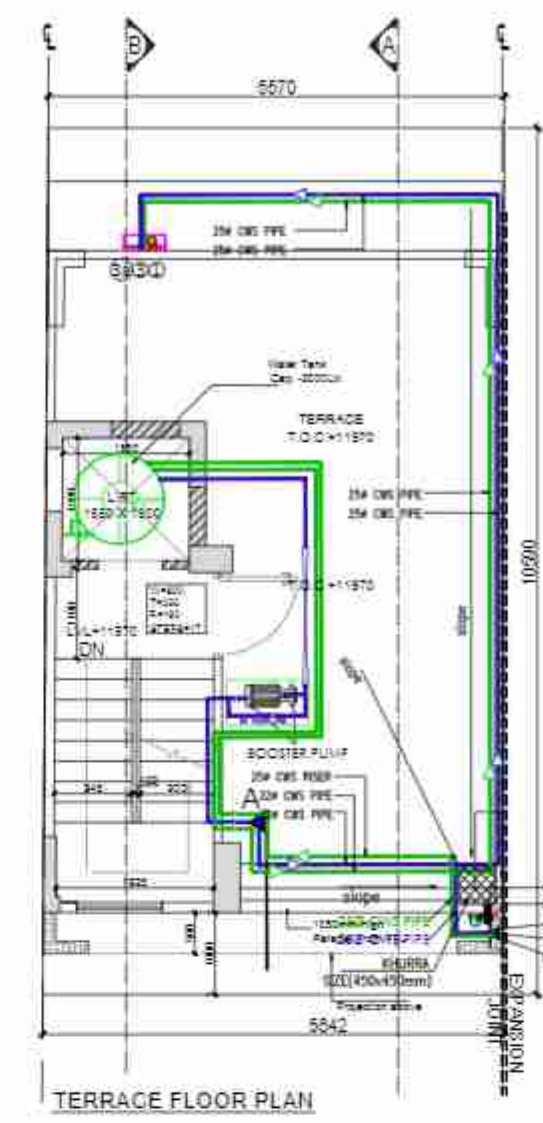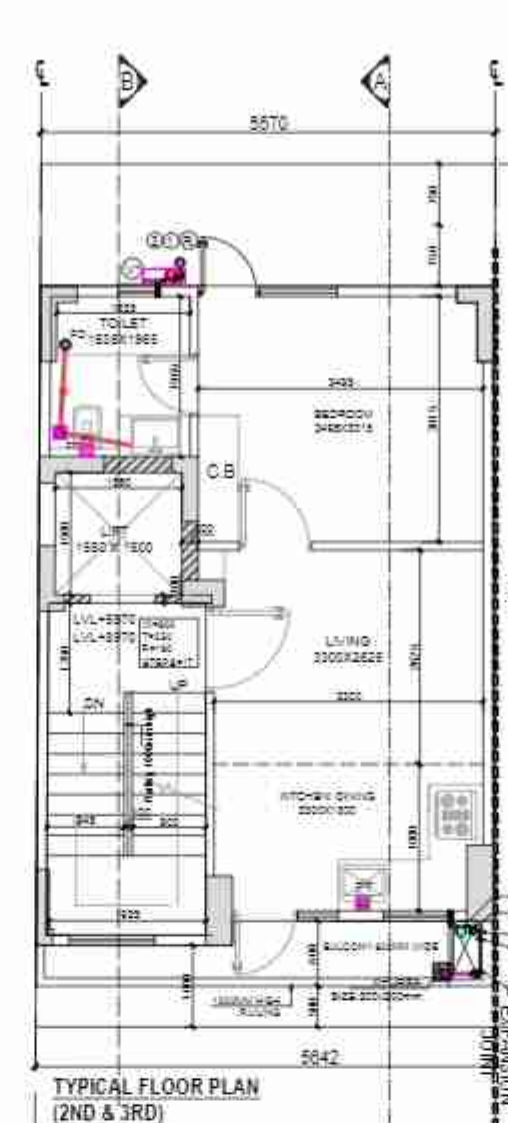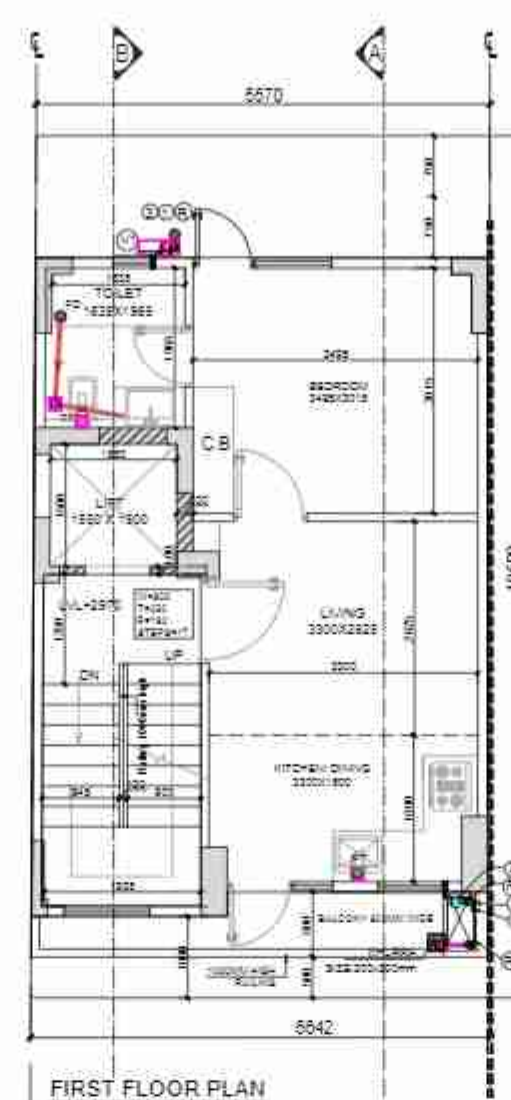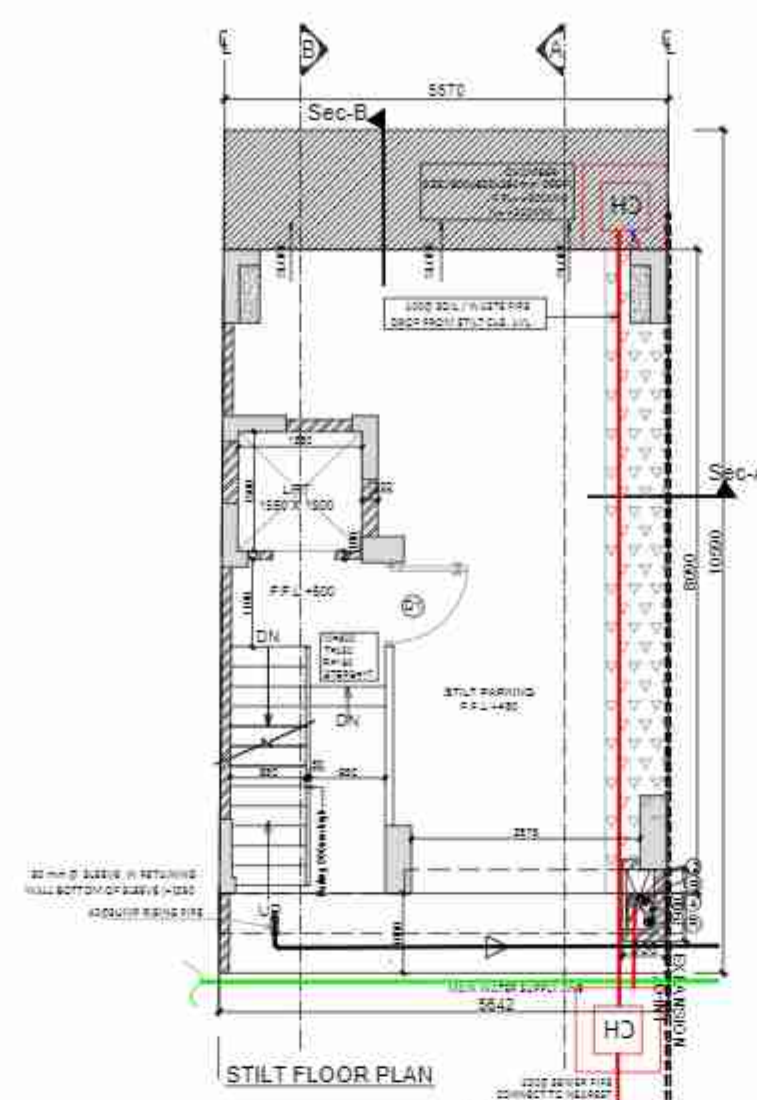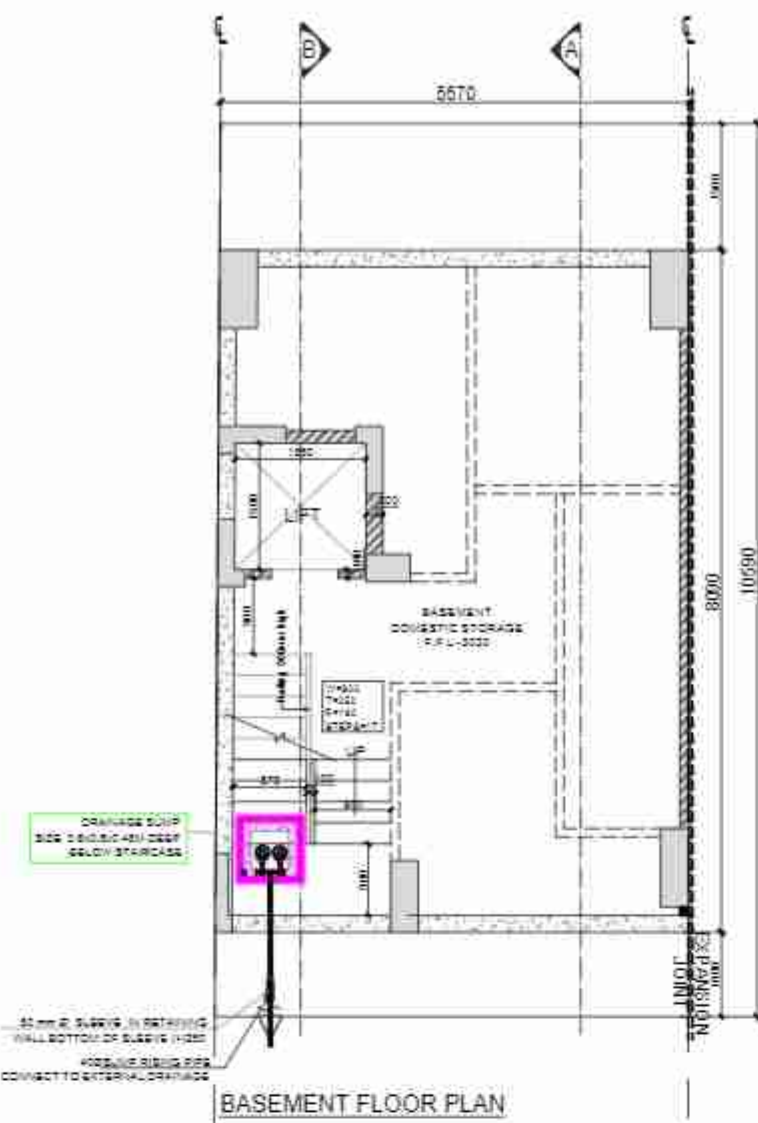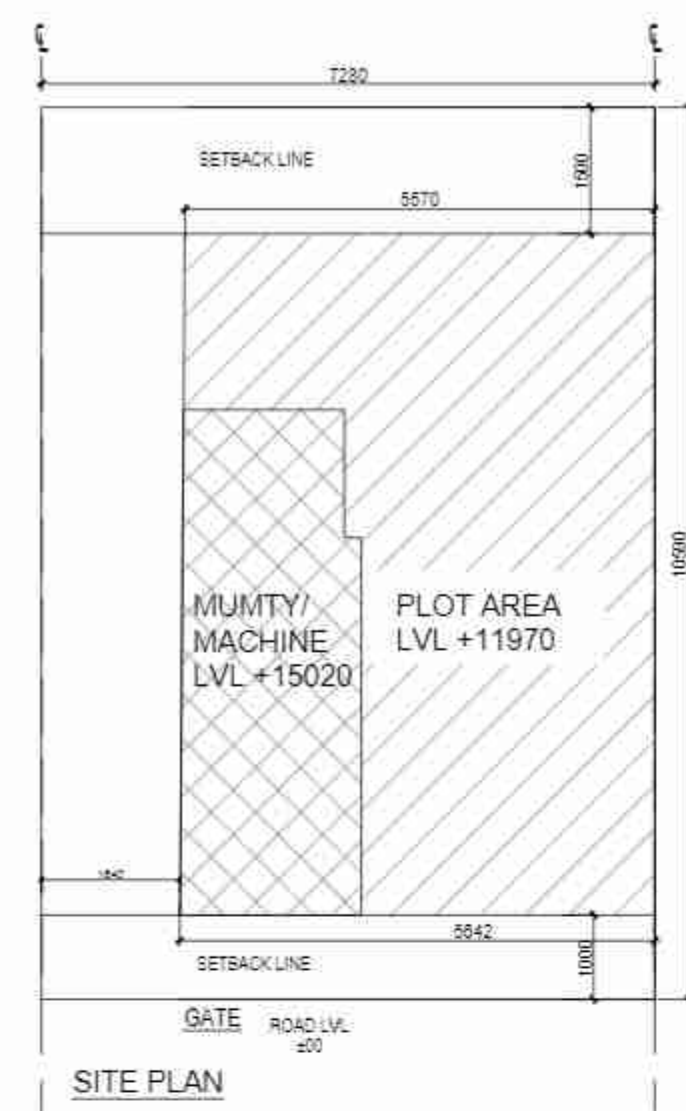

PLUMBING LEGENDS:	
①	110 OD SOIL PIPE
②	110 OD WASTE PIPE
③	COLD WATER SUPPLY DN TAKE
③a	COLD WATER SUPPLY DN TAKE BY HYDRO-PNEUMATIC SYSTEM
④	25Ø WATER SUPPLY RISER PIPE
R1	75 OD RWP FOR (BALCONY)
(R)	110 OD RWP FOR (TERRACE)
COP	CLEAN OUT PLUG

DOOR WINDOW SCHEDULE					
TYPE	WIDTH	HEIGHT	SILL LVL	LINTEL LVL	REMARKS
D1	1050	2350	± 00	2350	ENTRANCE
D2	900	2350	± 00	2350	BEDROOMS
D3	750	2350	± 00	2350	TOILETS
D4	1000	2350	± 00	2350	BASEMENT
DW1	750-1500	2350	± 00	2350	BEDROOM
DW2	750-1300	2350	± 00	2350	LIVING
W1	800	1350	1000	2350	KITCHEN
W2	1050	Beam Bottom	T.O.C of Respective Floor	Beam Bottom	STAIRCASE
W3	500	1350	1000	2350	TOILETS

AREA CALCULATION					
				AREA	UNIT
TOTAL PLOT AREA				=	77.090 SQ.M.
PERMISSIBLE FAR @ 2.64				=	203.518 SQ.M.
PROPOSED FAR @ 1.387				=	106.943 SQ.M.
PERMISSIBLE GR. COV. @ 75%				=	57.818 SQ.M.
PROPOSED GROUND COVERAGE @ 58.45%				=	45.061 SQ.M.
AREA OF STILT FLOOR/ GROUND COVERAGE					
A	5.570	X	8.090	X	1
				=	45.061 SQ.M.
TOTAL				=	45.061 SQ.M.
TOTAL AREA OF STILT FLOOR/ GROUND COVERAGE (A)				=	45.061 SQ.M.
AREA OF FIRST FLOOR					
A	5.570	X	8.090	X	1
				=	45.061 SQ.M.
TOTAL				=	45.061 SQ.M.
DEDUCTION					
1	1.930	X	4.075	X	1
				=	7.865 SQ.M.
TOTAL				=	7.864 SQ.M.
TOTAL AREA OF FIRST FLOOR (B)				=	37.198 SQ.M.
AREA OF TYPICAL FLOOR (2ND & 3RD)					
A	5.570	X	8.090	X	1
				=	45.061 SQ.M.
TOTAL				=	45.061 SQ.M.
DEDUCTION					
1	1.930	X	4.075	X	1
				=	7.865 SQ.M.
2	1.550	X	1.500	X	1
				=	2.325 SQ.M.
TOTAL				=	10.189 SQ.M.
TOTAL AREA OF TYPICAL FLOOR				=	34.873 SQ.M.
TOTAL FLOOR AREA (C)				=	
= (1ST FLOOR + 2ND FLOOR + 3RD FLOOR) (D)				=	106.943 SQ.M.
BASEMENT AREA					
A	5.570	X	8.090	X	1
				=	45.061 SQ.M.
TOTAL BASEMENT AREA (E)				=	45.061 SQ.M.
MUMTY/ MACHINE ROOM AREA					
A	2.080	X	1.800	X	1
				=	3.744 SQ.M.
TOTAL MUMTY/ MACHINE ROOM AREA (F)				=	3.744 SQ.M.
STAIRCASE AREA					
1	1.930	X	4.075	X	1
				=	7.865 SQ.M.
TOTAL STAIRCASE AREA (G)				=	31.459 SQ.M.
TOTAL BUILT-UP AREA (A+D+E+F+G)				=	232.268 SQ.M.















LEGEND	
	150mm. Blockwork for Outer wall
	100mm. Blockwork for Internal wall

PROJECT:
PROPOSED BUILDING PLAN ON PLOT NO.- E1-1 FOR RESIDENTIAL PLOTTED COLONY UNDER DEEN DAYAL JAN AWAS YOJNA OVER AN AREA MEASURING 57.40 ACRES (LICENSE NO. 32 OF 2021, DATED 03.07.2021 FOR AN AREA MEASURING 52.275 ACRES & LICENSE NO. 102 OF 2022 DATED 27.02.2022 FOR AN AREA MEASURING 5.125 ACRES) IN THE REVENUE ESTATE OF VILLAGE HAYATPUR, SECTOR-89, GURUGRAM BEING DEVELOPED BY AAWAM RESIDENCY PRIVATE LIMITED & OTHERS IN COLLABORATION WITH ADHIKAANSH PRIVATE LIMITED.


DRAWING TITLE:
FLOOR PLANS WITH AREA CALCULATION, ELEVATIONS AND SECTIONS
TYPE- E1-1 (Left Corner)

DRAWING NUMBER	
M3/MQ/SEC-89/TE1-SN-01	
DATE	AUTHORIZED SIGN


ARCHITECT'S SIGN

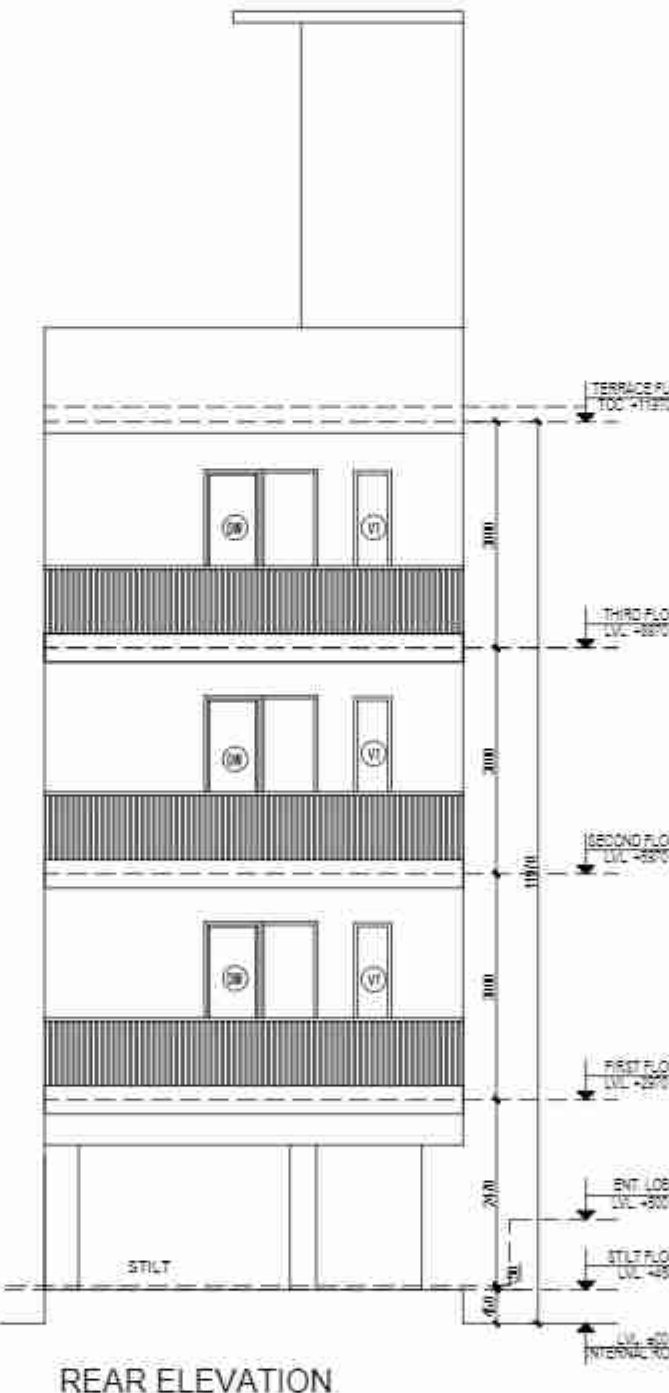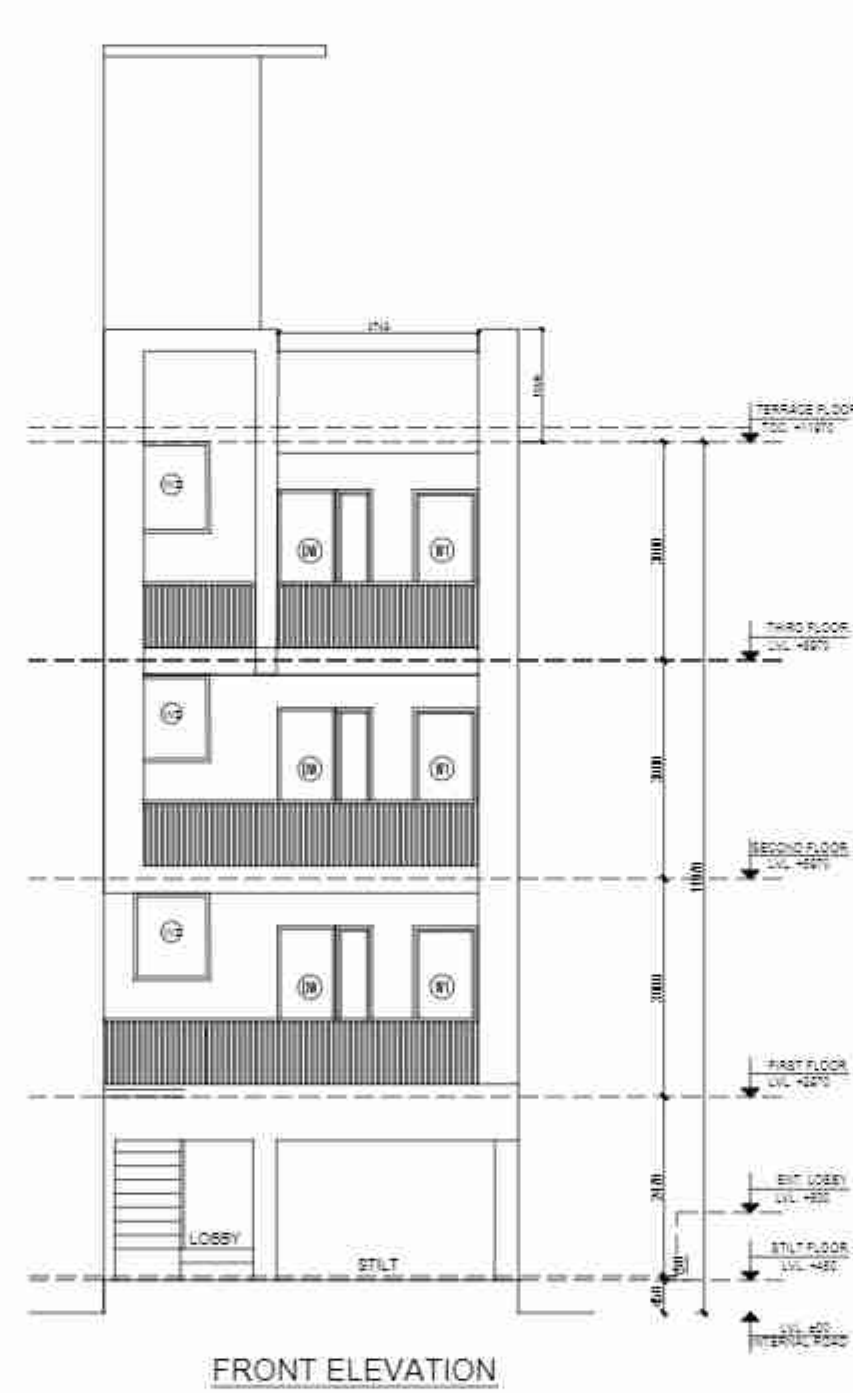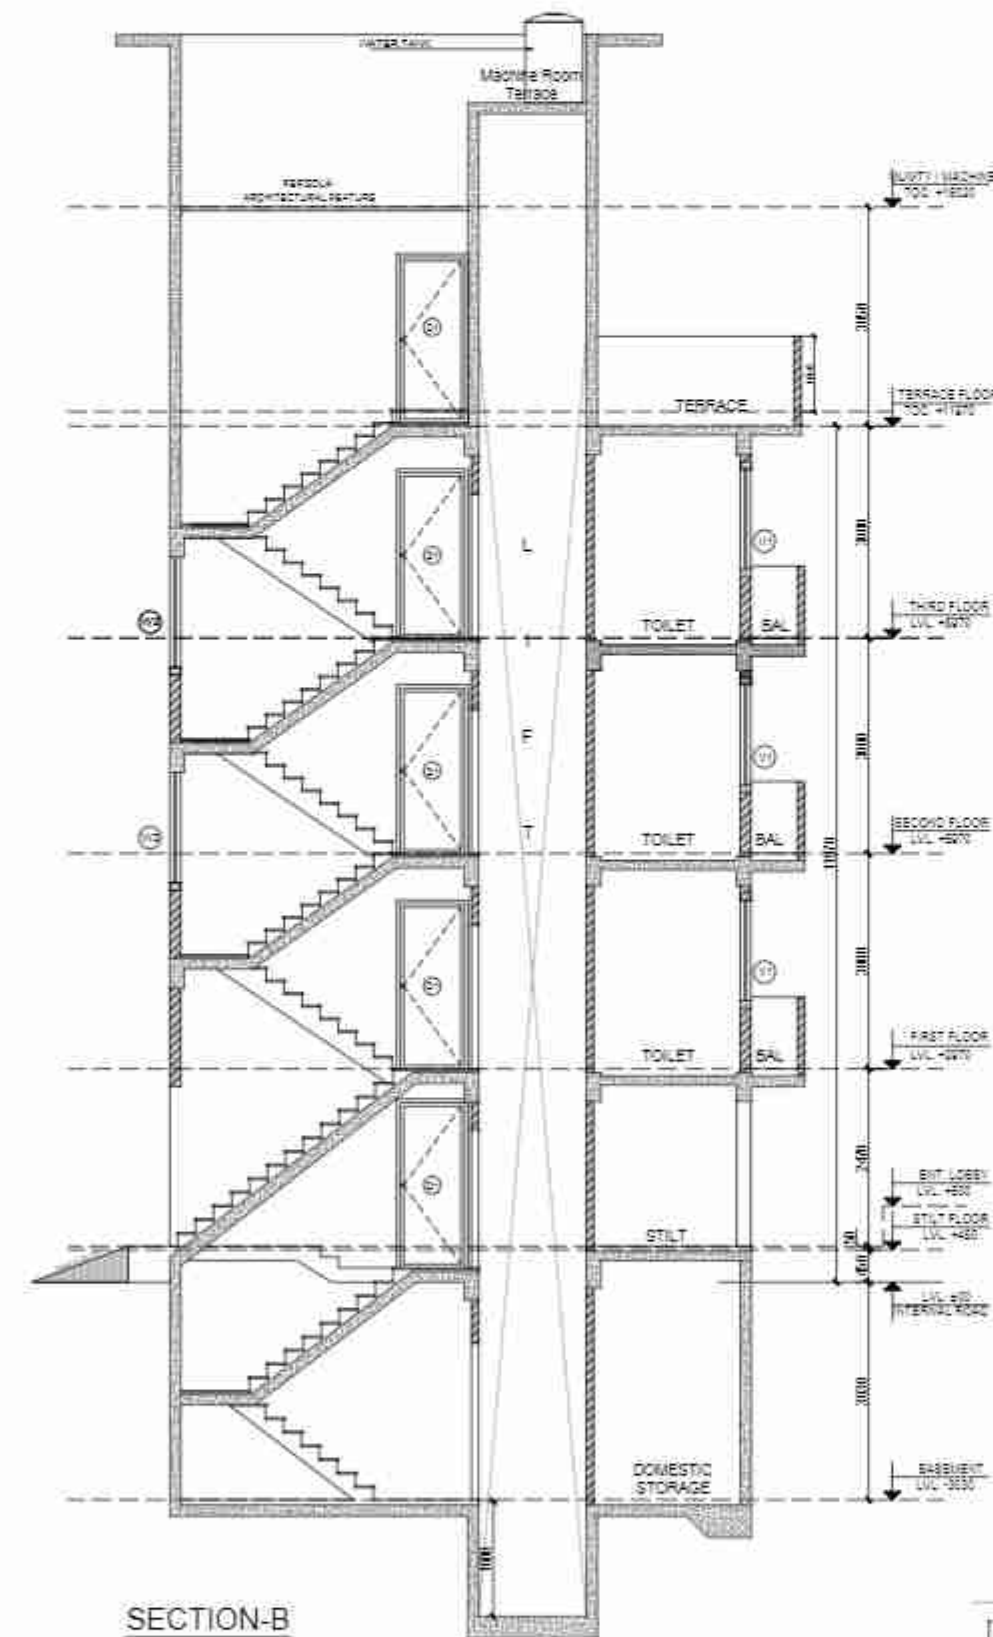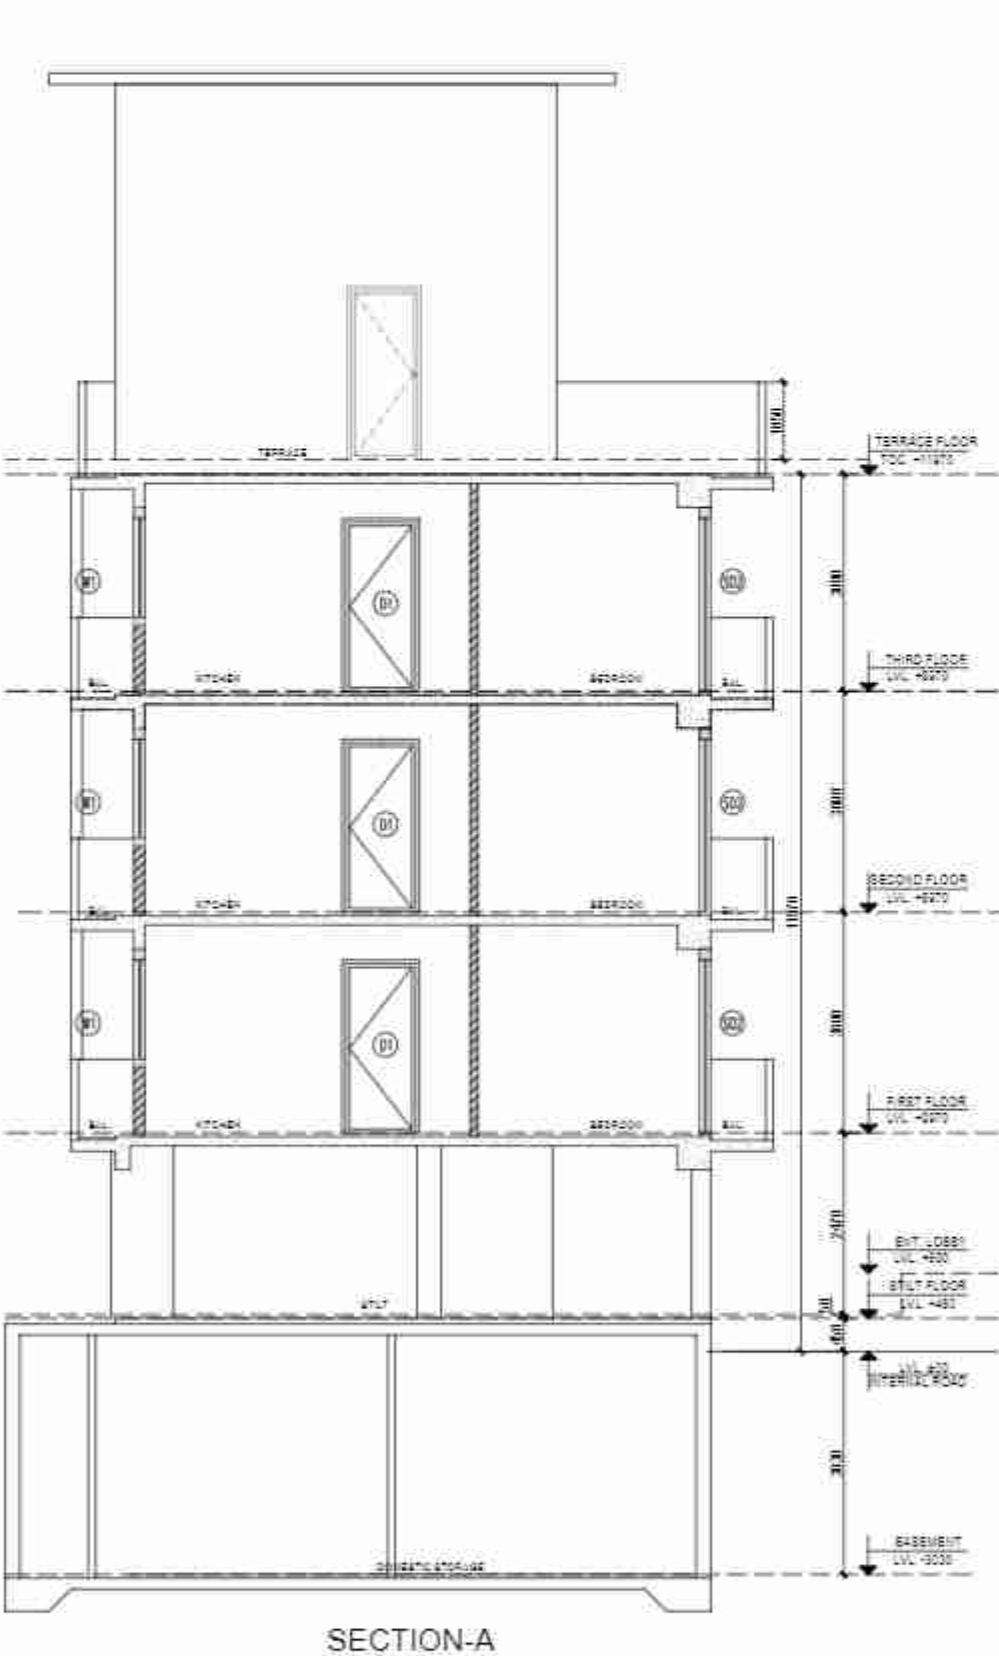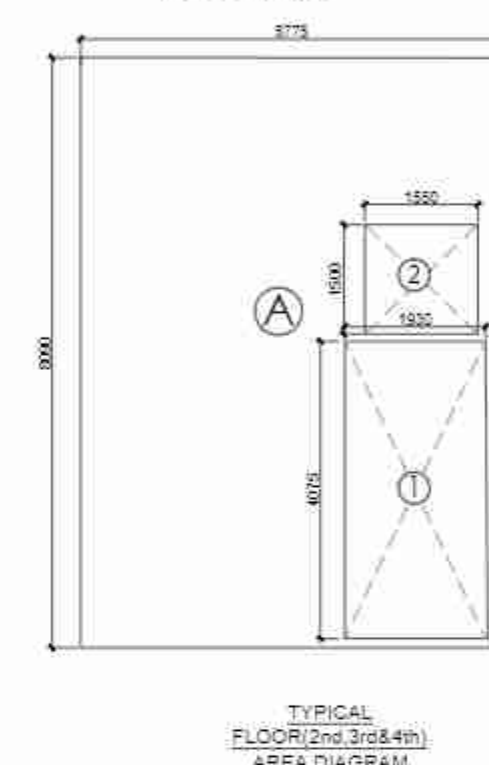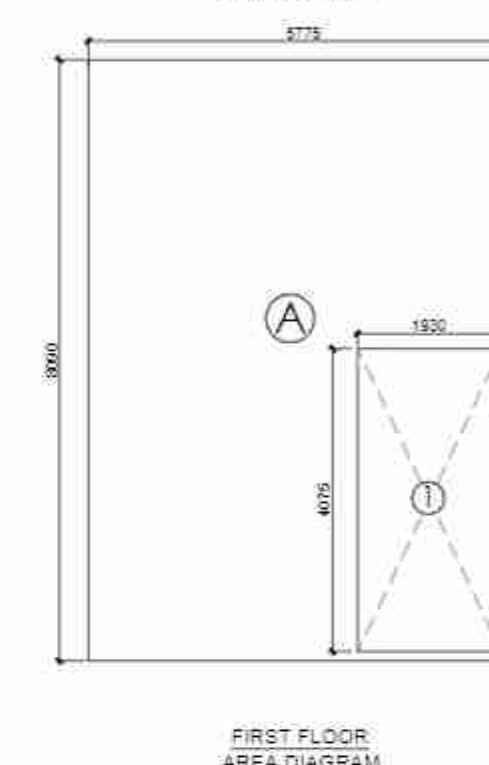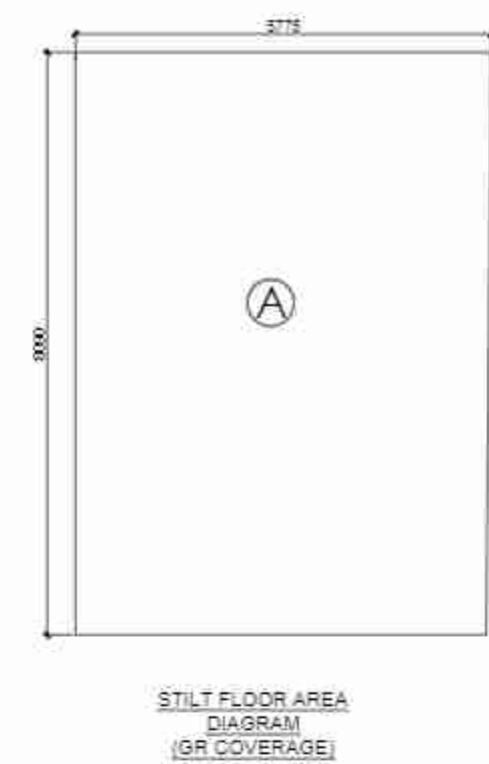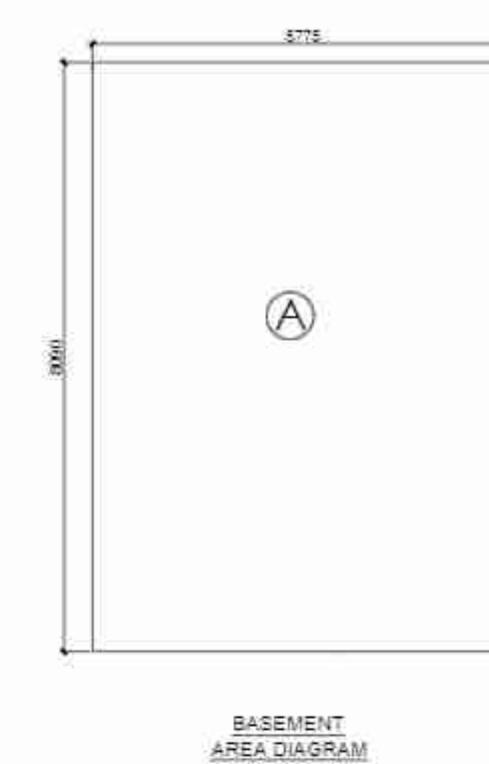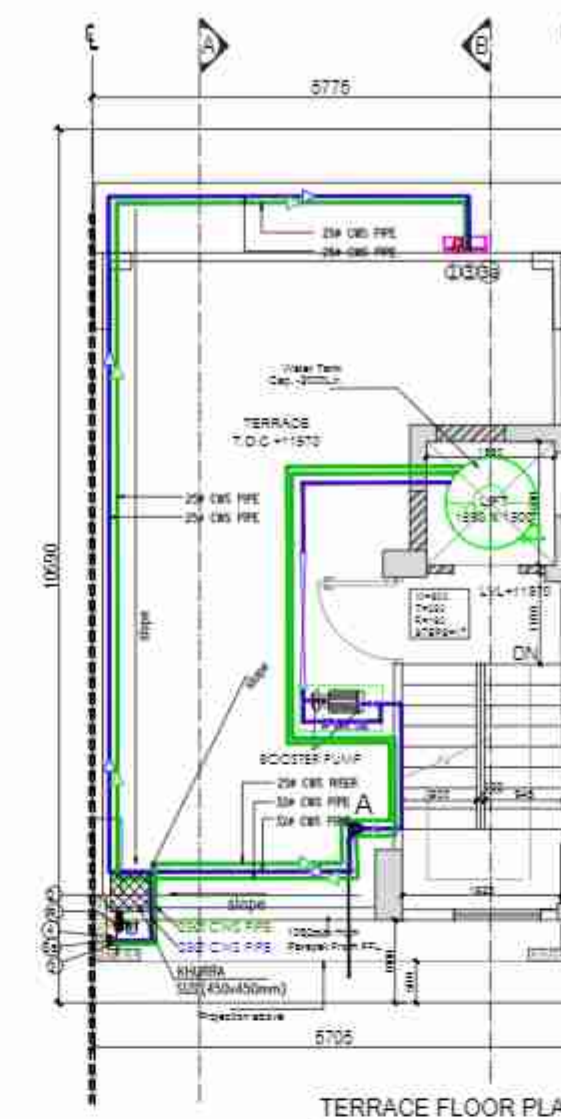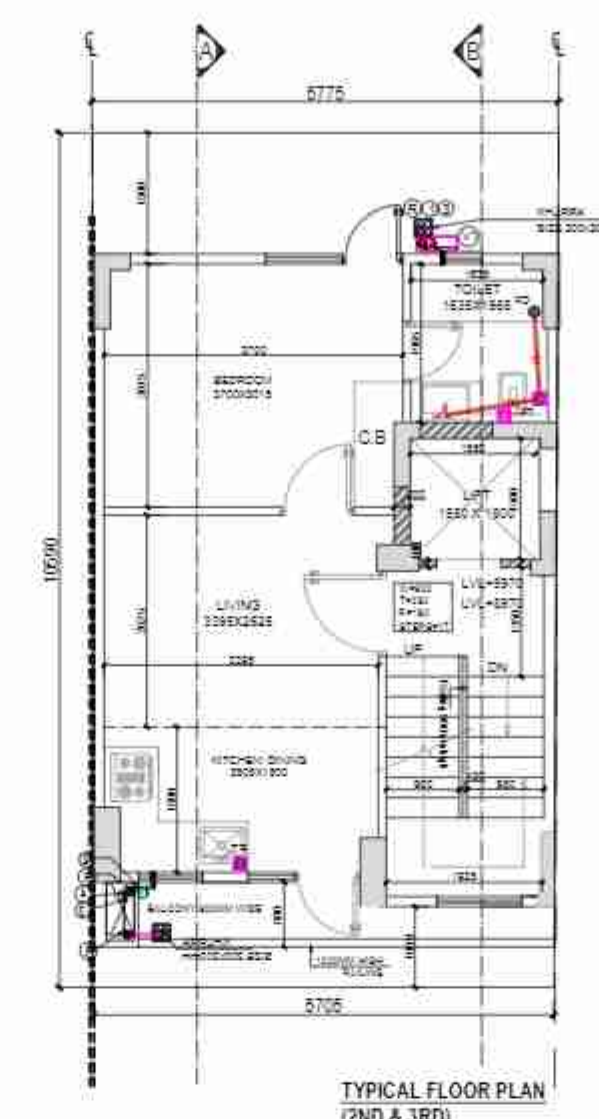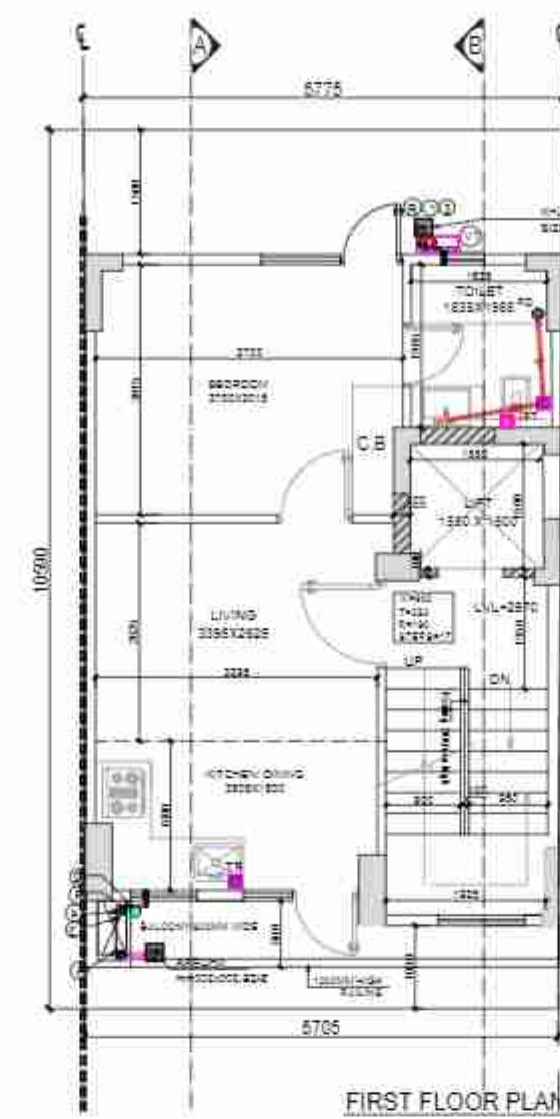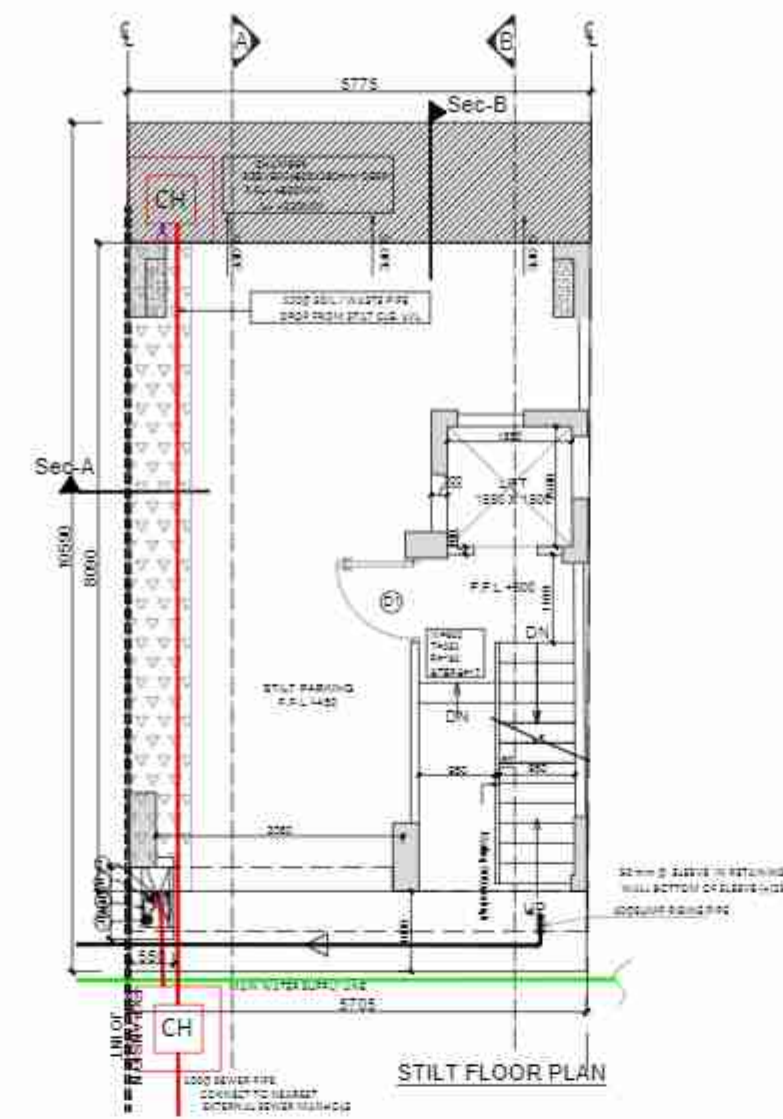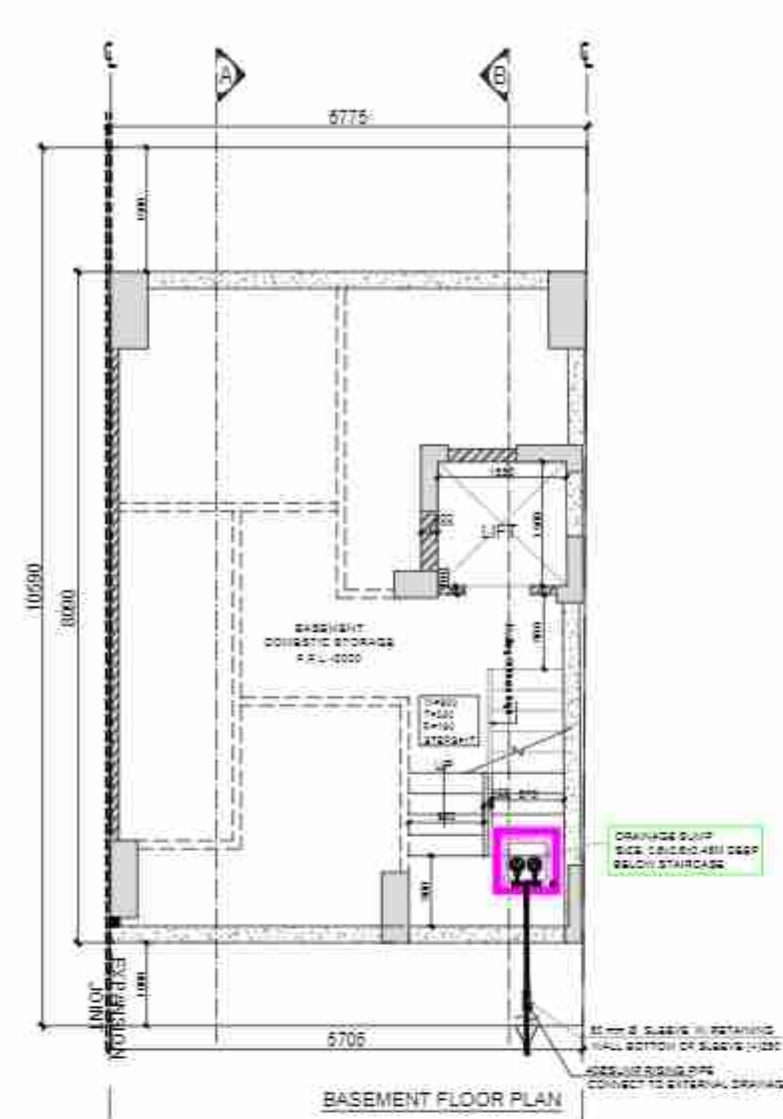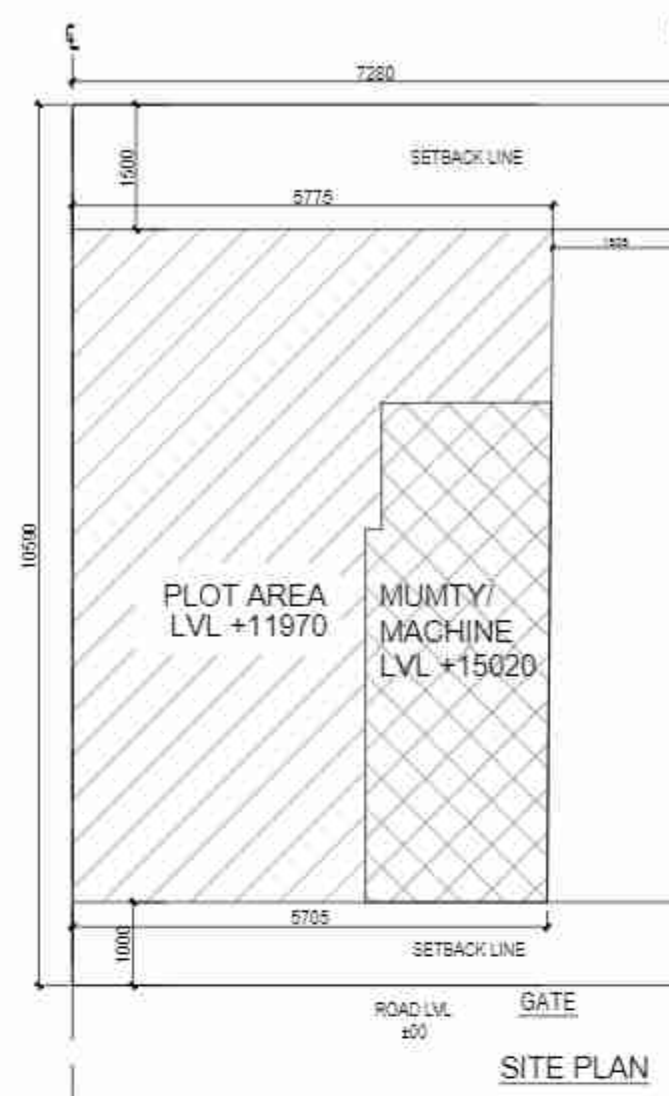

DOOR WINDOW SCHEDULE					
TYPE	WIDTH	HEIGHT	SILL LVL	LINTEL LVL	REMARKS
D1	1050	2350	± 00	2350	ENTRANCE
D2	900	2350	± 00	2350	BEDROOMS
D3	750	2350	± 00	2350	TOILETS
D4	1000	2350	± 00	2350	BASEMENT
DW1	750-1500	2350	± 00	2350	BEDROOM
DW2	750-1300	2350	± 00	2350	LIVING
W1	800	1350	1000	2350	KITCHEN
W2	1050	Beam Bottom	T.O.C of Respective Floor	Beam Bottom	STAIRCASE
V1	500	1350	1000	2350	TOILETS

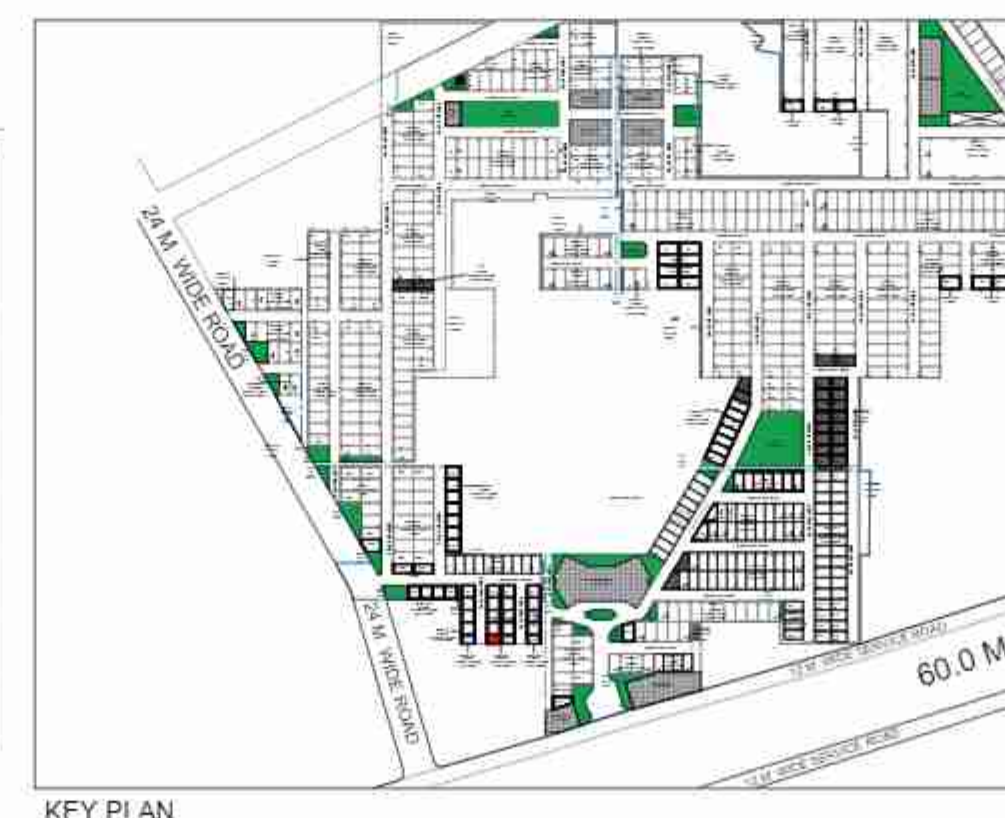

AREA CALCULATION					
				AREA	UNIT
TOTAL PLOT AREA				=	77.090 SQ.M.
PERMISSIBLE FAR @ 2.84				=	203.518 SQ.M.
PROPOSED FAR @ 1.387				=	106.943 SQ.M.
PERMISSIBLE GR. COV. @ 75%				=	57.818 SQ.M.
PROPOSED GROUND COVERAGE @ 58.45%				=	45.061 SQ.M.
AREA OF STILT FLOOR/ GROUND COVERAGE					
A	5.570	X	8.090	X	1 = 45.061 SQ.M.
				TOTAL	= 45.061 SQ.M.
TOTAL AREA OF STILT FLOOR/ GROUND COVERAGE (A)				=	45.061 SQ.M.
AREA OF FIRST FLOOR					
A	5.570	X	8.090	X	1 = 45.061 SQ.M.
				TOTAL	= 45.061 SQ.M.
DEDUCTION					
1	1.930	X	4.075	X	1 = 7.865 SQ.M.
				TOTAL	= 7.864 SQ.M.
TOTAL AREA OF FIRST FLOOR (B)				=	37.198 SQ.M.
AREA OF TYPICAL FLOOR (2ND & 3RD)					
A	5.570	X	8.090	X	1 = 45.061 SQ.M.
				TOTAL	= 45.061 SQ.M.
DEDUCTION					
1	1.930	X	4.075	X	1 = 7.865 SQ.M.
2	1.560	X	1.500	X	1 = 2.325 SQ.M.
				TOTAL	= 10.189 SQ.M.
TOTAL AREA OF TYPICAL FLOOR				=	34.873 SQ.M.
TOTAL FLOOR AREA (C)				=	106.943 SQ.M.
= (1ST FLOOR + 2ND FLOOR + 3RD FLOOR) (D)				=	106.943 SQ.M.
BASEMENT AREA					
A	5.570	X	8.090	X	1 = 45.061 SQ.M.
TOTAL BASEMENT AREA (E)				=	45.061 SQ.M.
MUMTY/ MACHINE ROOM AREA					
A	2.080	X	1.800	X	1 = 3.744 SQ.M.
TOTAL MUMTY/ MACHINE ROOM AREA (F)				=	3.744 SQ.M.
STAIRCASE AREA					
1	1.930	X	4.075	X	1 = 7.865 SQ.M.
TOTAL STAIRCASE AREA (G)				=	31.459 SQ.M.
TOTAL BUILT-UP AREA (A+D+E+F+G)				=	232.268 SQ.M.

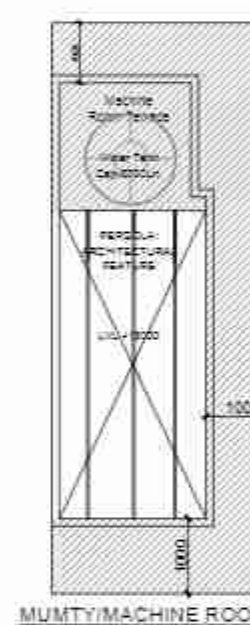

LEGEND	
	150mm. Blockwork for Outer wall
	100mm. Blockwork for Internal wall

PROJECT:
PROPOSED BUILDING PLAN ON PLOT NO. - E1-2 FOR RESIDENTIAL PLOTTED COLONY UNDER DEEN DAYAL JAN AWAS YOJNA) OVER AN AREA MEASURING 57.40ACRES (LICENSE NO. 32 OF 2021, DATED 03.07.2021 FOR AN AREA MEASURING 52.275 ACRES & LICENSE NO. 102 OF 2022 DATED 27.02.2022 FOR AN AREA MEASURING 5.125 ACRES) IN THE REVENUE ESTATE OF VILLAGE HAYATPUR, SECTOR-89, GURUGRAM BEING DEVELOPED BY AAWAM RESIDENCY PRIVATE LIMITED & OTHERS IN COLLABORATION WITH ADHIKAANSH PRIVATE LIMITED.

DRAWING TITLE
FLOOR PLANS WITH AREA CALCULATION, ELEVATIONS AND SECTIONS
TYPE- E1-2 (Right Corner)









DRAWING NUMBER

MUM/DP/SEC-89/TE1-SN-01

ARCHITECT'S SIGN

AUTHORIZED SIGN

APR 2024
DR. KIRAN K. SHARMA
CONSULTANT

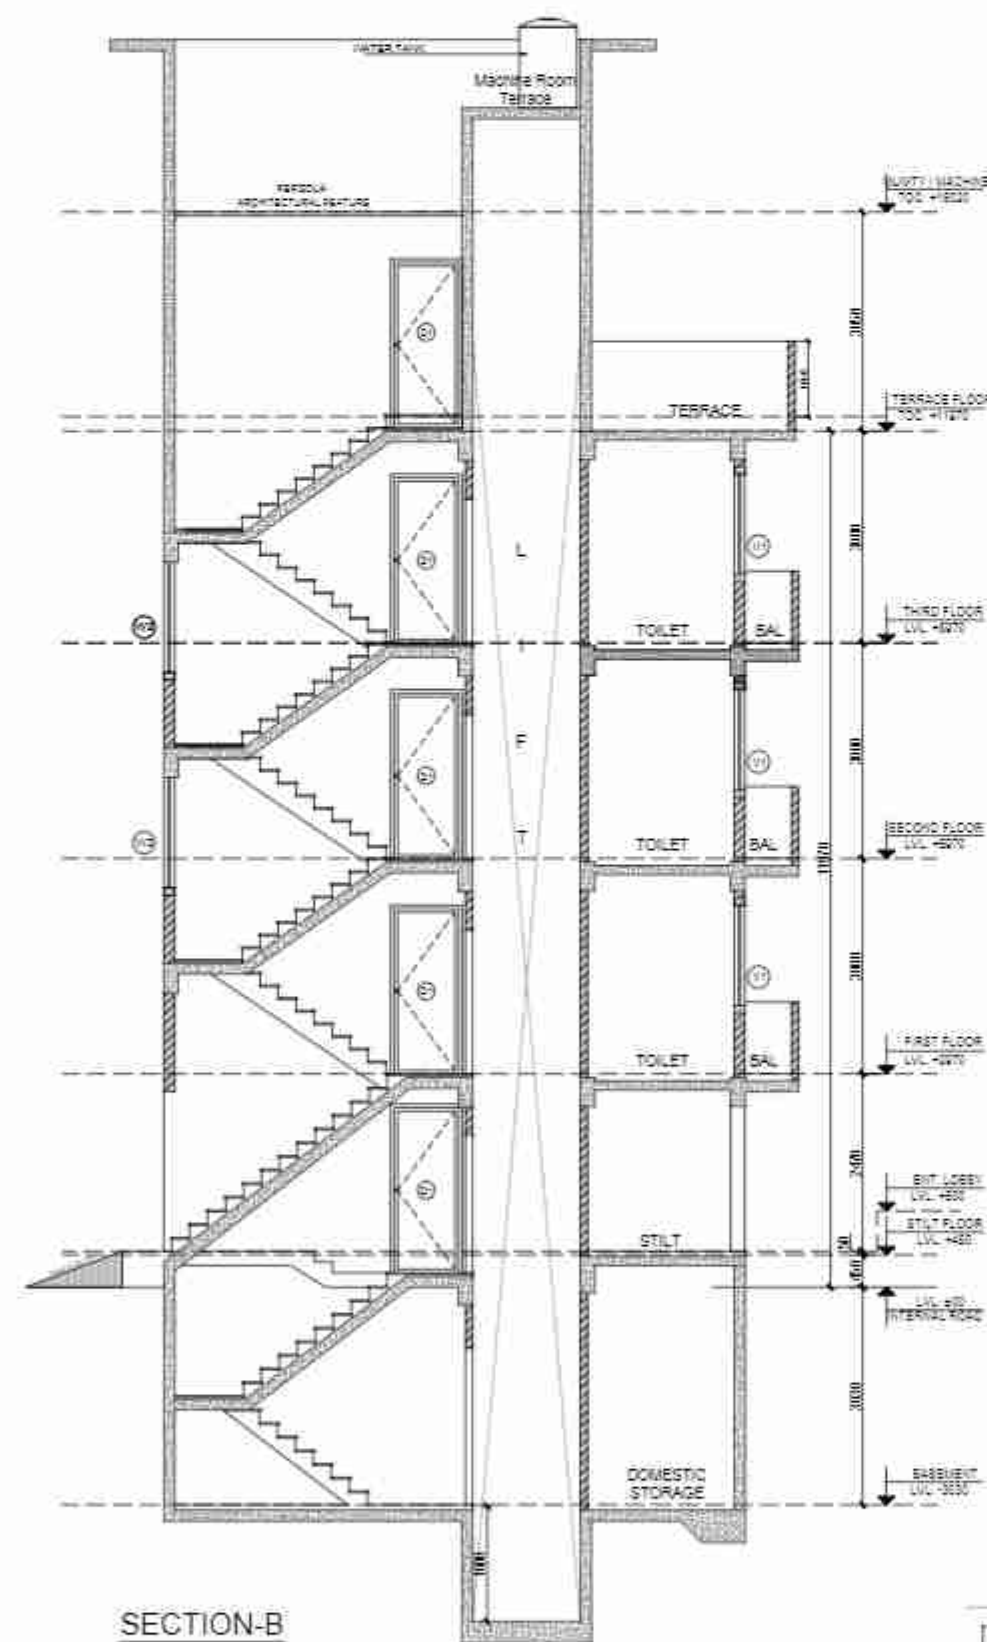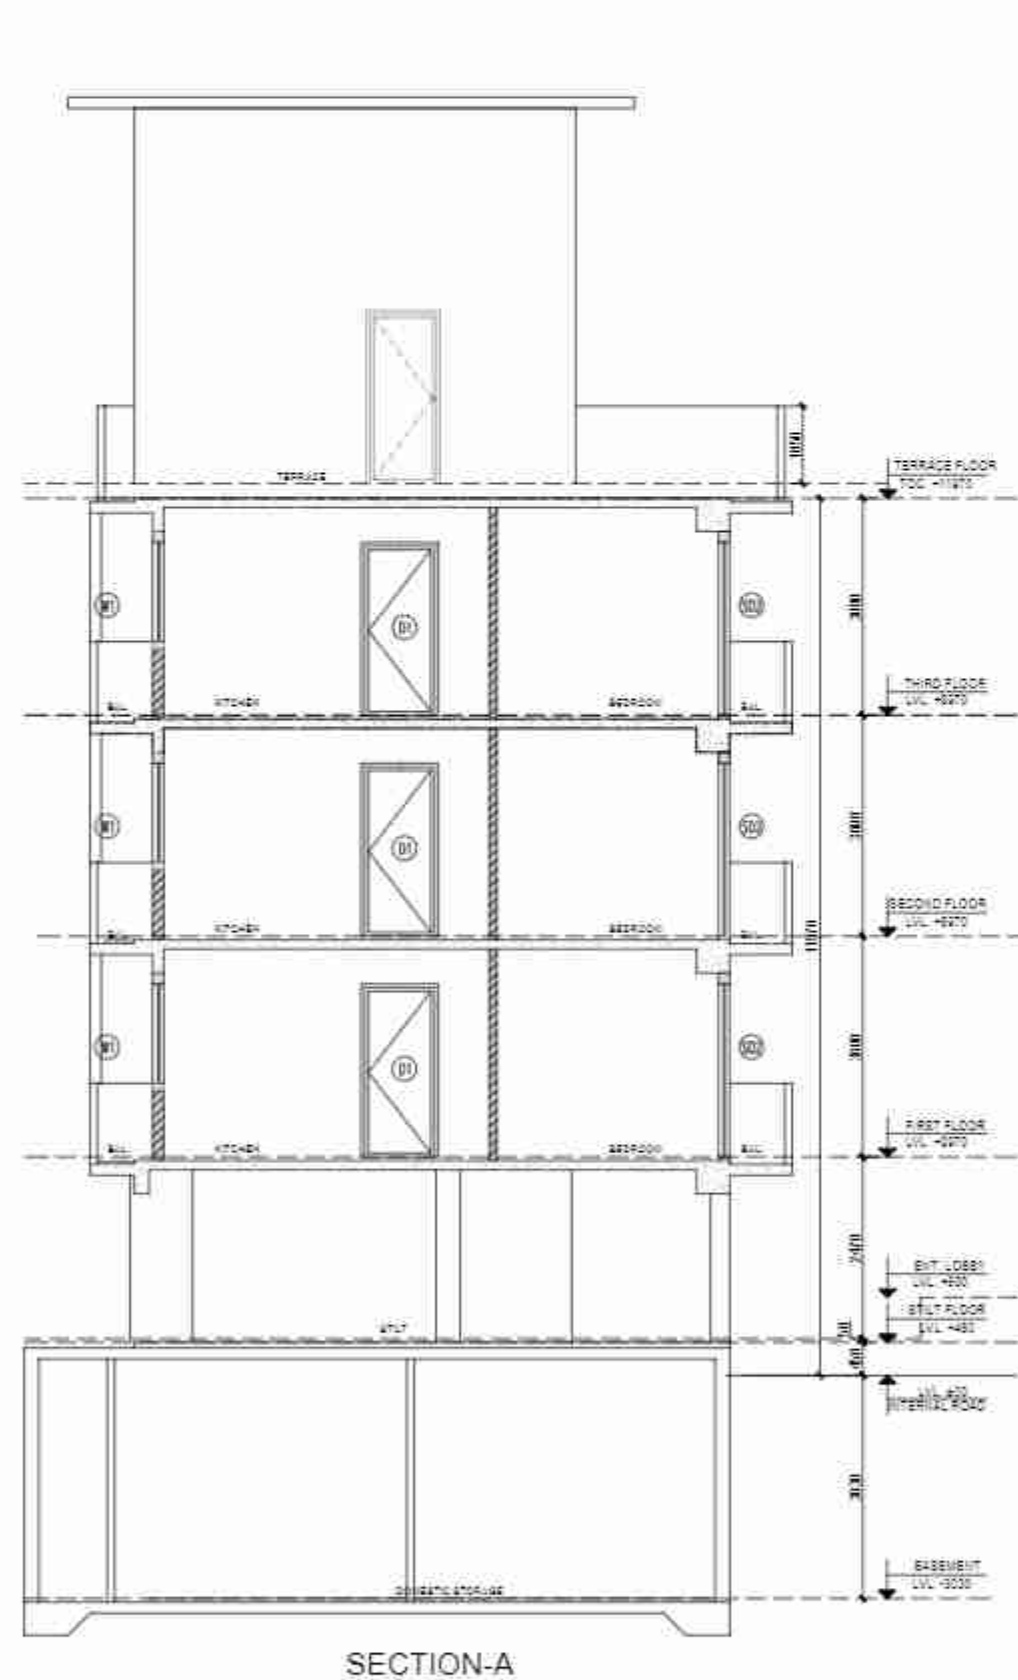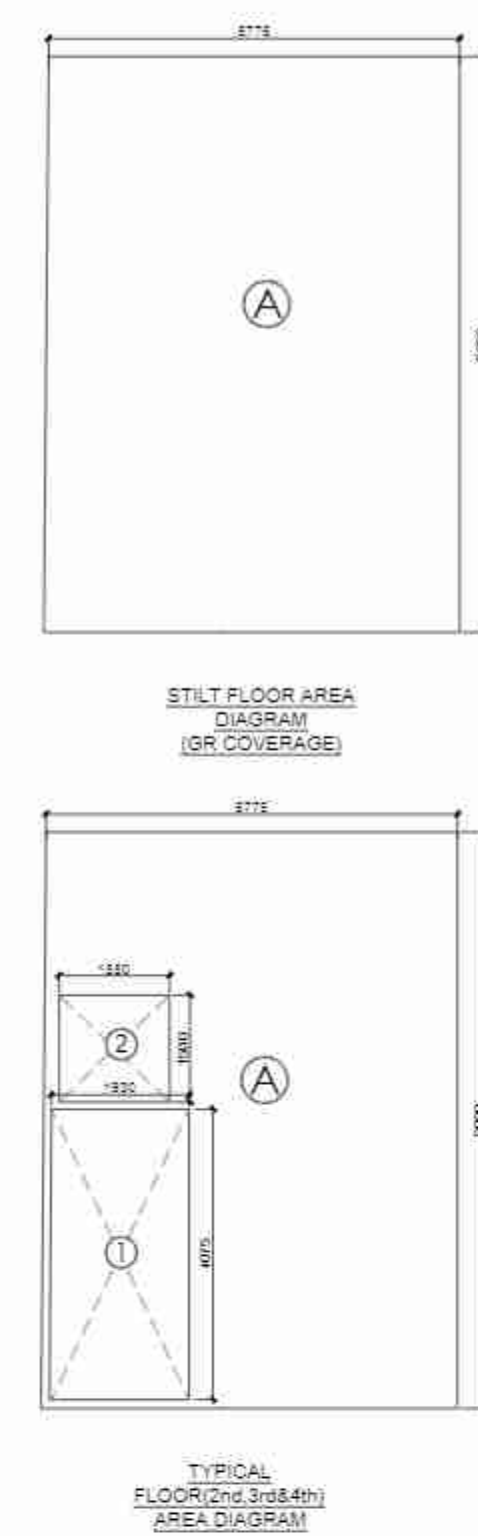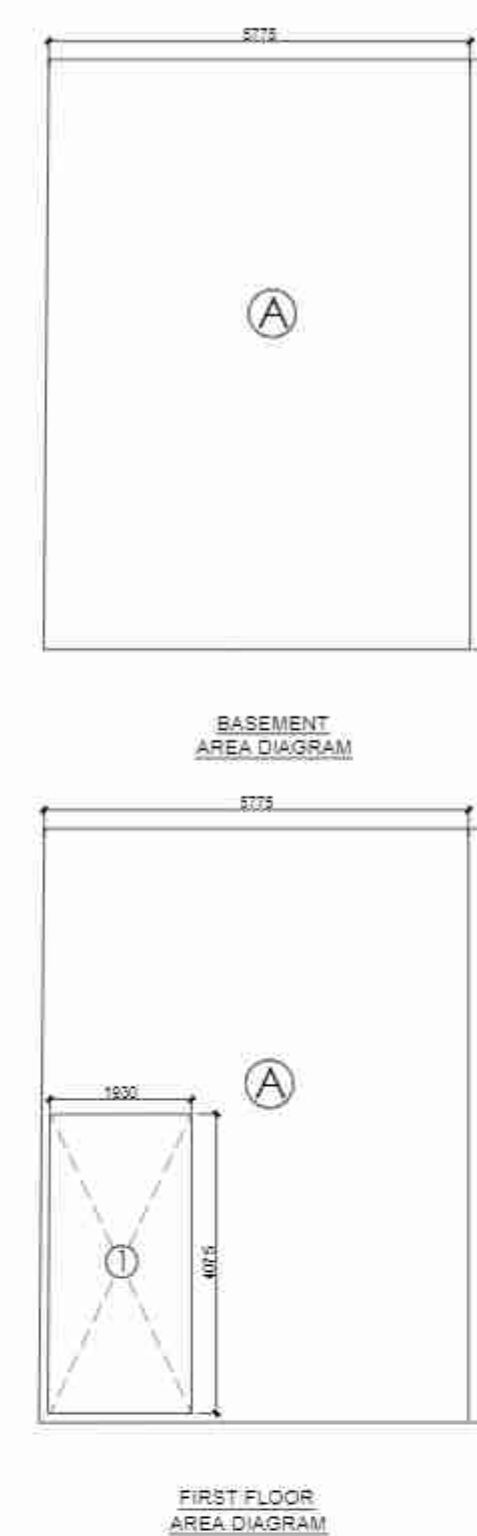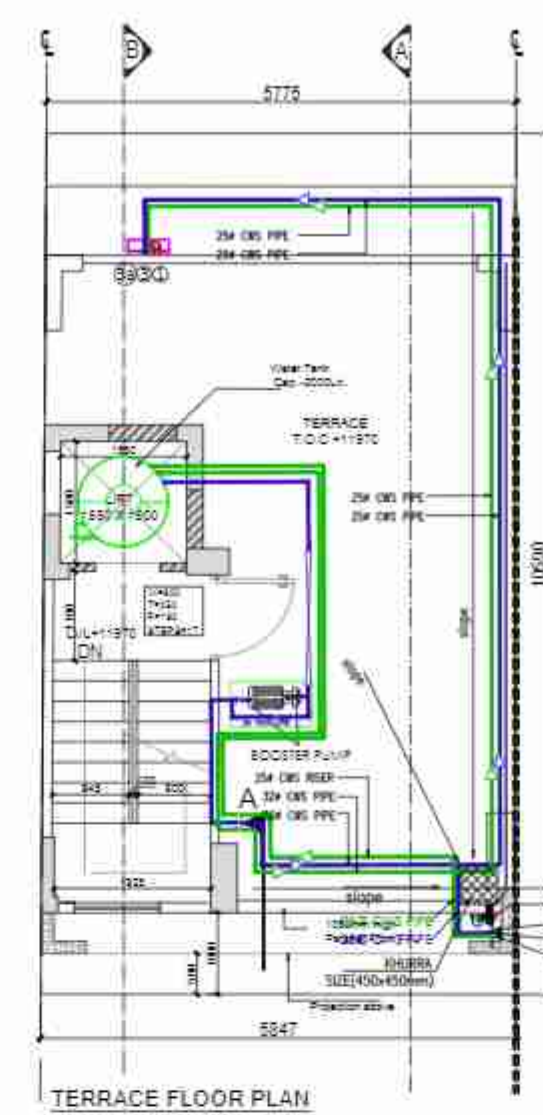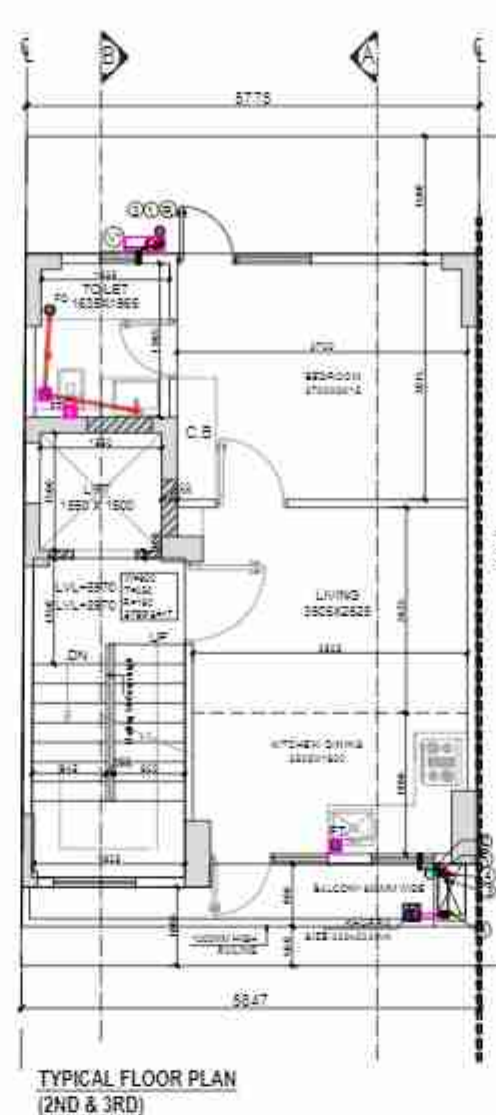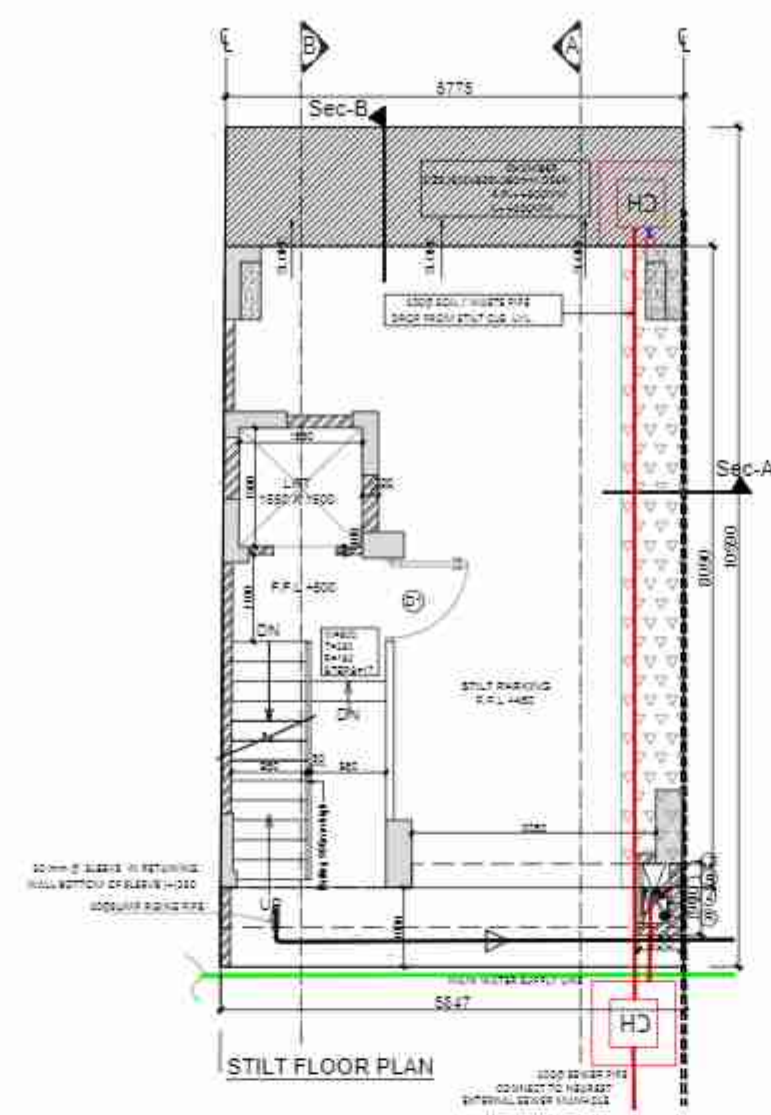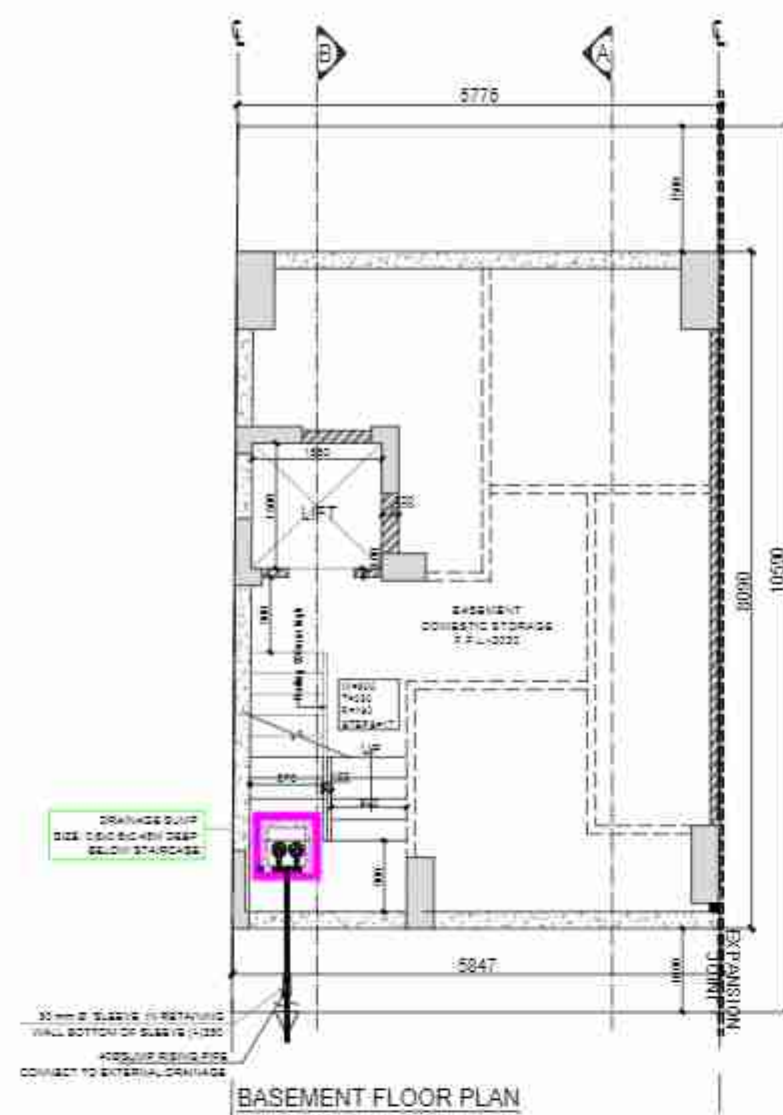

PLUMBING LEGENDS:	
①	110 OD SOIL PIPE
②	110 OD WASTE PIPE
③	COLD WATER SUPPLY DN TAKE
3a	COLD WATER SUPPLY DN TAKE BY HYDRO-PNEUMATIC SYSTEM
④	25Ø WATER SUPPLY RISER PIPE
R1	75 OD RWP FOR (BALCONY)
R	110 OD RWP FOR (TERRACE)
COP	CLEAN OUT PLUG

DOOR WINDOW SCHEDULE					
TYPE	WIDTH	HEIGHT	SILL LVL	LINTEL LVL	REMARKS
D1 Sliding Door	1050	2350	± 00	2350	ENTRANCE
D2 Sliding Door	900	2350	± 00	2350	BEDROOMS
D3 Sliding Door	750	2350	± 00	2350	TOILETS
D4 Sliding Door	1000	2350	± 00	2350	BASEMENT
D5 Sliding Door - Sliding	750-1500	2350	± 00	2350	BEDROOM
D6 Sliding Door - Sliding	750-1300	2350	± 00	2350	LIVING
W1 Sliding Window	800	1350	1000 of Respective Floor	1000	KITCHEN
W2 Sliding Window	1050	Beam Bottom	1000 of Respective Floor	Beam Bottom	STAIRCASE
W3 Sliding Window	500	1350	1000	2350	TOILETS

AREA CALCULATION						
						AREA UNIT
TOTAL PLOT AREA					=	77.090 SQ.M
PERMISSIBLE FAR @ 2.64					=	203.518 SQ.M
PROPOSED FAR @ 1.387					=	106.943 SQ.M
PERMISSIBLE GR. COV. @ 75%					=	57.818 SQ.M
PROPOSED GROUND COVERAGE @ 58.45%					=	45.061 SQ.M

AREA OF STILT FLOOR/ GROUND COVERAGE							
A	5.570	X	8.090	X	1	=	45.061 SQ.M
					TOTAL	=	45.061 SQ.M
TOTAL AREA OF STILT FLOOR/ GROUND COVERAGE (A)						=	45.061 SQ.M

AREA OF FIRST FLOOR							
A	5.570	X	8.090	X	1	=	45.061 S.Q.M.
					TOTAL	=	45.061 S.Q.M.
DEDUCTION							
1	1.930	X	4.075	X	1	=	7.865 S.Q.M.
					TOTAL	=	7.864 S.Q.M.
TOTAL AREA OF FIRST FLOOR (B)						=	37.198 S.Q.M.

AREA OF TYPICAL FLOOR (2ND & 3RD)							
A	5.570	X	8.090	X	1	=	45.061 SQ.M
					TOTAL	=	45.061 SQ.M
DEDUCTION							
1	1.930	X	4.075	X	1	=	7.865 SQ.M
2	1.550	X	1.500	X	1	=	2.325 SQ.M
					TOTAL	=	10.189 SQ.M

TOTAL AREA OF TYPICAL FLOOR				=	34.873	SQ.M.
TOTAL FLOOR AREA (C)						
= (1ST FLOOR + 2ND FLOOR + 3RD FLOOR) (D)				=	106.943	SQ.M.

BASEMENT AREA							
A	5.570	X	8.090	X	1	=	45.061 SQ.M.
TOTAL BASEMENT AREA (E)						=	45.061 SQ.M.

MUMTY/ MACHINE ROOM AREA									
A	2.080	X	1.800	X	1	=	3.744	SQ.M	
TOTAL MUMTY/ MACHINE ROOM AREA (F)						=	3.744	SQ.M	

STAIRCASE AREA							
1	1.930	X	4.075	X	1	=	7.865 SQ.M
TOTAL STAIRCASE AREA (G)						=	31.459 SQ.M
TOTAL BUILT-UP AREA (A+D+E+F+G)						=	232.268 SQ.M

LEGEND	
	150mm. Blockwork for Outer wall
	100mm. Blockwork for Internal wall

PROJECT:
PROPOSED BUILDING PLAN ON PLOT NO. E-1-3
FOR RESIDENTIAL PLOTTED COLONY UNDER
DEEN DAYAL JAN AWAS YOUNA) OVER AN AREA
MEASURING 57.40ACRES (LICENSE NO. 32 OF
2021, DATED 03.07.2021 FOR AN AREA
MEASURING 52.275 ACRES & LICENSE NO. 102
OF 2022 DATED 07.02.2022 FOR AN AREA
MEASURING 5.125 ACRES) IN THE REVENUE
ESTATE OF VILLAGE HAYATPUR
SECTOR-89, GURUGRAM BEING DEVELOPED BY
AAWM RESIDENCY PRIVATE LIMITED &
OTHERS IN COLLABORATION WITH
ADHIKAANSH PRIVATE LIMITED.

DRAWING TITLE:
FLOOR PLANS WITH AREA CALCULATION,
ELEVATIONS AND SECTIONS
TYPE- E1-3 (Left Corner)

DRAWING NUMBER:

M3M/DE/SEC-SD/TE1-SM-01

1. *Journal of Management Education* 25(1): 1-10

ARCHITECT'S SIGN

100

[Signature]

ALICE B. DUNN
DANIEL DUNN

1	2	3	100
---	---	---	---	---	---	---	---	---	----	----	-----
