



PHE LEGENDS:

1000mm x 1000mm DRAIN CHANNEL
FLOOR DRAIN
1000mm PARKING DRAIN PIPE (TYP)
RISER LINE
FLOW DIRECTION
FLOOR DRAIN AT BASEMENT FLOOR LEVEL
1000 DRAIN PIPE FROM BASEMENT TO 1st FLOOR LEVEL
DRAINAGE PUMP PUMP OUTLET PIPE
SEWERAGE PUMP PUMP OUTLET PIPE FROM BASEMENT 4 TO G LEVEL

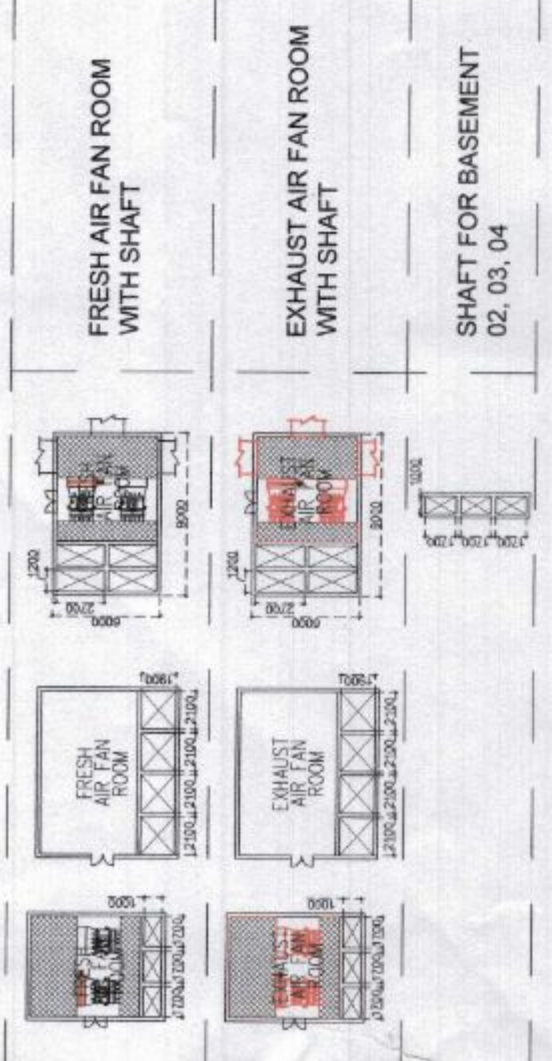

ALSO TYPICAL COMMENTS:
1. PROVIDE SHAFT FOR SEWAGE PREVENTION FROM LG-GR TYPICAL.
2. PROVIDE SHAFT FOR SEWAGE PREVENTION FROM LG-GR TYPICAL.
3. UPDATE THE ZONE AREA AS FOLLOWED

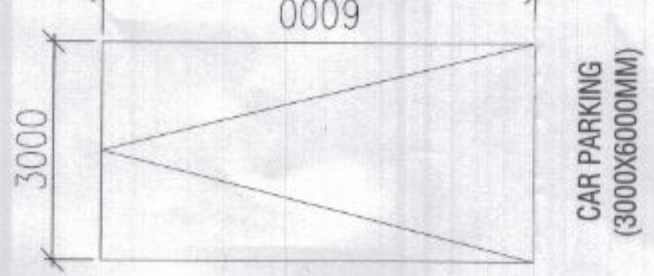

CAR PARKING (3000x0009mm)

DOOR SCHEDULE


DOOR NAME	SIZE	INTEL. V.A.	NO. OF DOORS
D01	1000x2100	1000	2 NOS.
D02	1000x2100	1000	2 NOS.
D03	1000x2100	1000	2 NOS.
D04	1000x2100	1000	2 NOS.
D05	1000x2100	1000	2 NOS.
D06	1000x2100	1000	2 NOS.
D07	1000x2100	1000	2 NOS.
D08	1000x2100	1000	2 NOS.
D09	1000x2100	1000	2 NOS.
D10	1000x2100	1000	2 NOS.

BASEMENT PLAN -02
LVL.- 13.550
NO OF CAR PARKING = 579

TOTAL BASEMENT AREA= 49014 SQM.
FHC REQUIRED=49014/1000= 50 NOS.
FHC PROVIDED= 62 NOS.

WATER SUPPLY LEGENDS:

1500 FLUSHING WATER SUPPLY (FOR TOWER A-B-C & D)
1500 DOMESTIC WATER SUPPLY (FOR TOWER A-B-C & D)
1500 FLUSHING WATER SUPPLY (FOR TOWER E-F & G)
1500 DOMESTIC WATER SUPPLY (FOR TOWER E-F & G)
DOMESTIC WATER SUPPLY RISER PIPE
FLUSHING WATER SUPPLY RISER PIPE

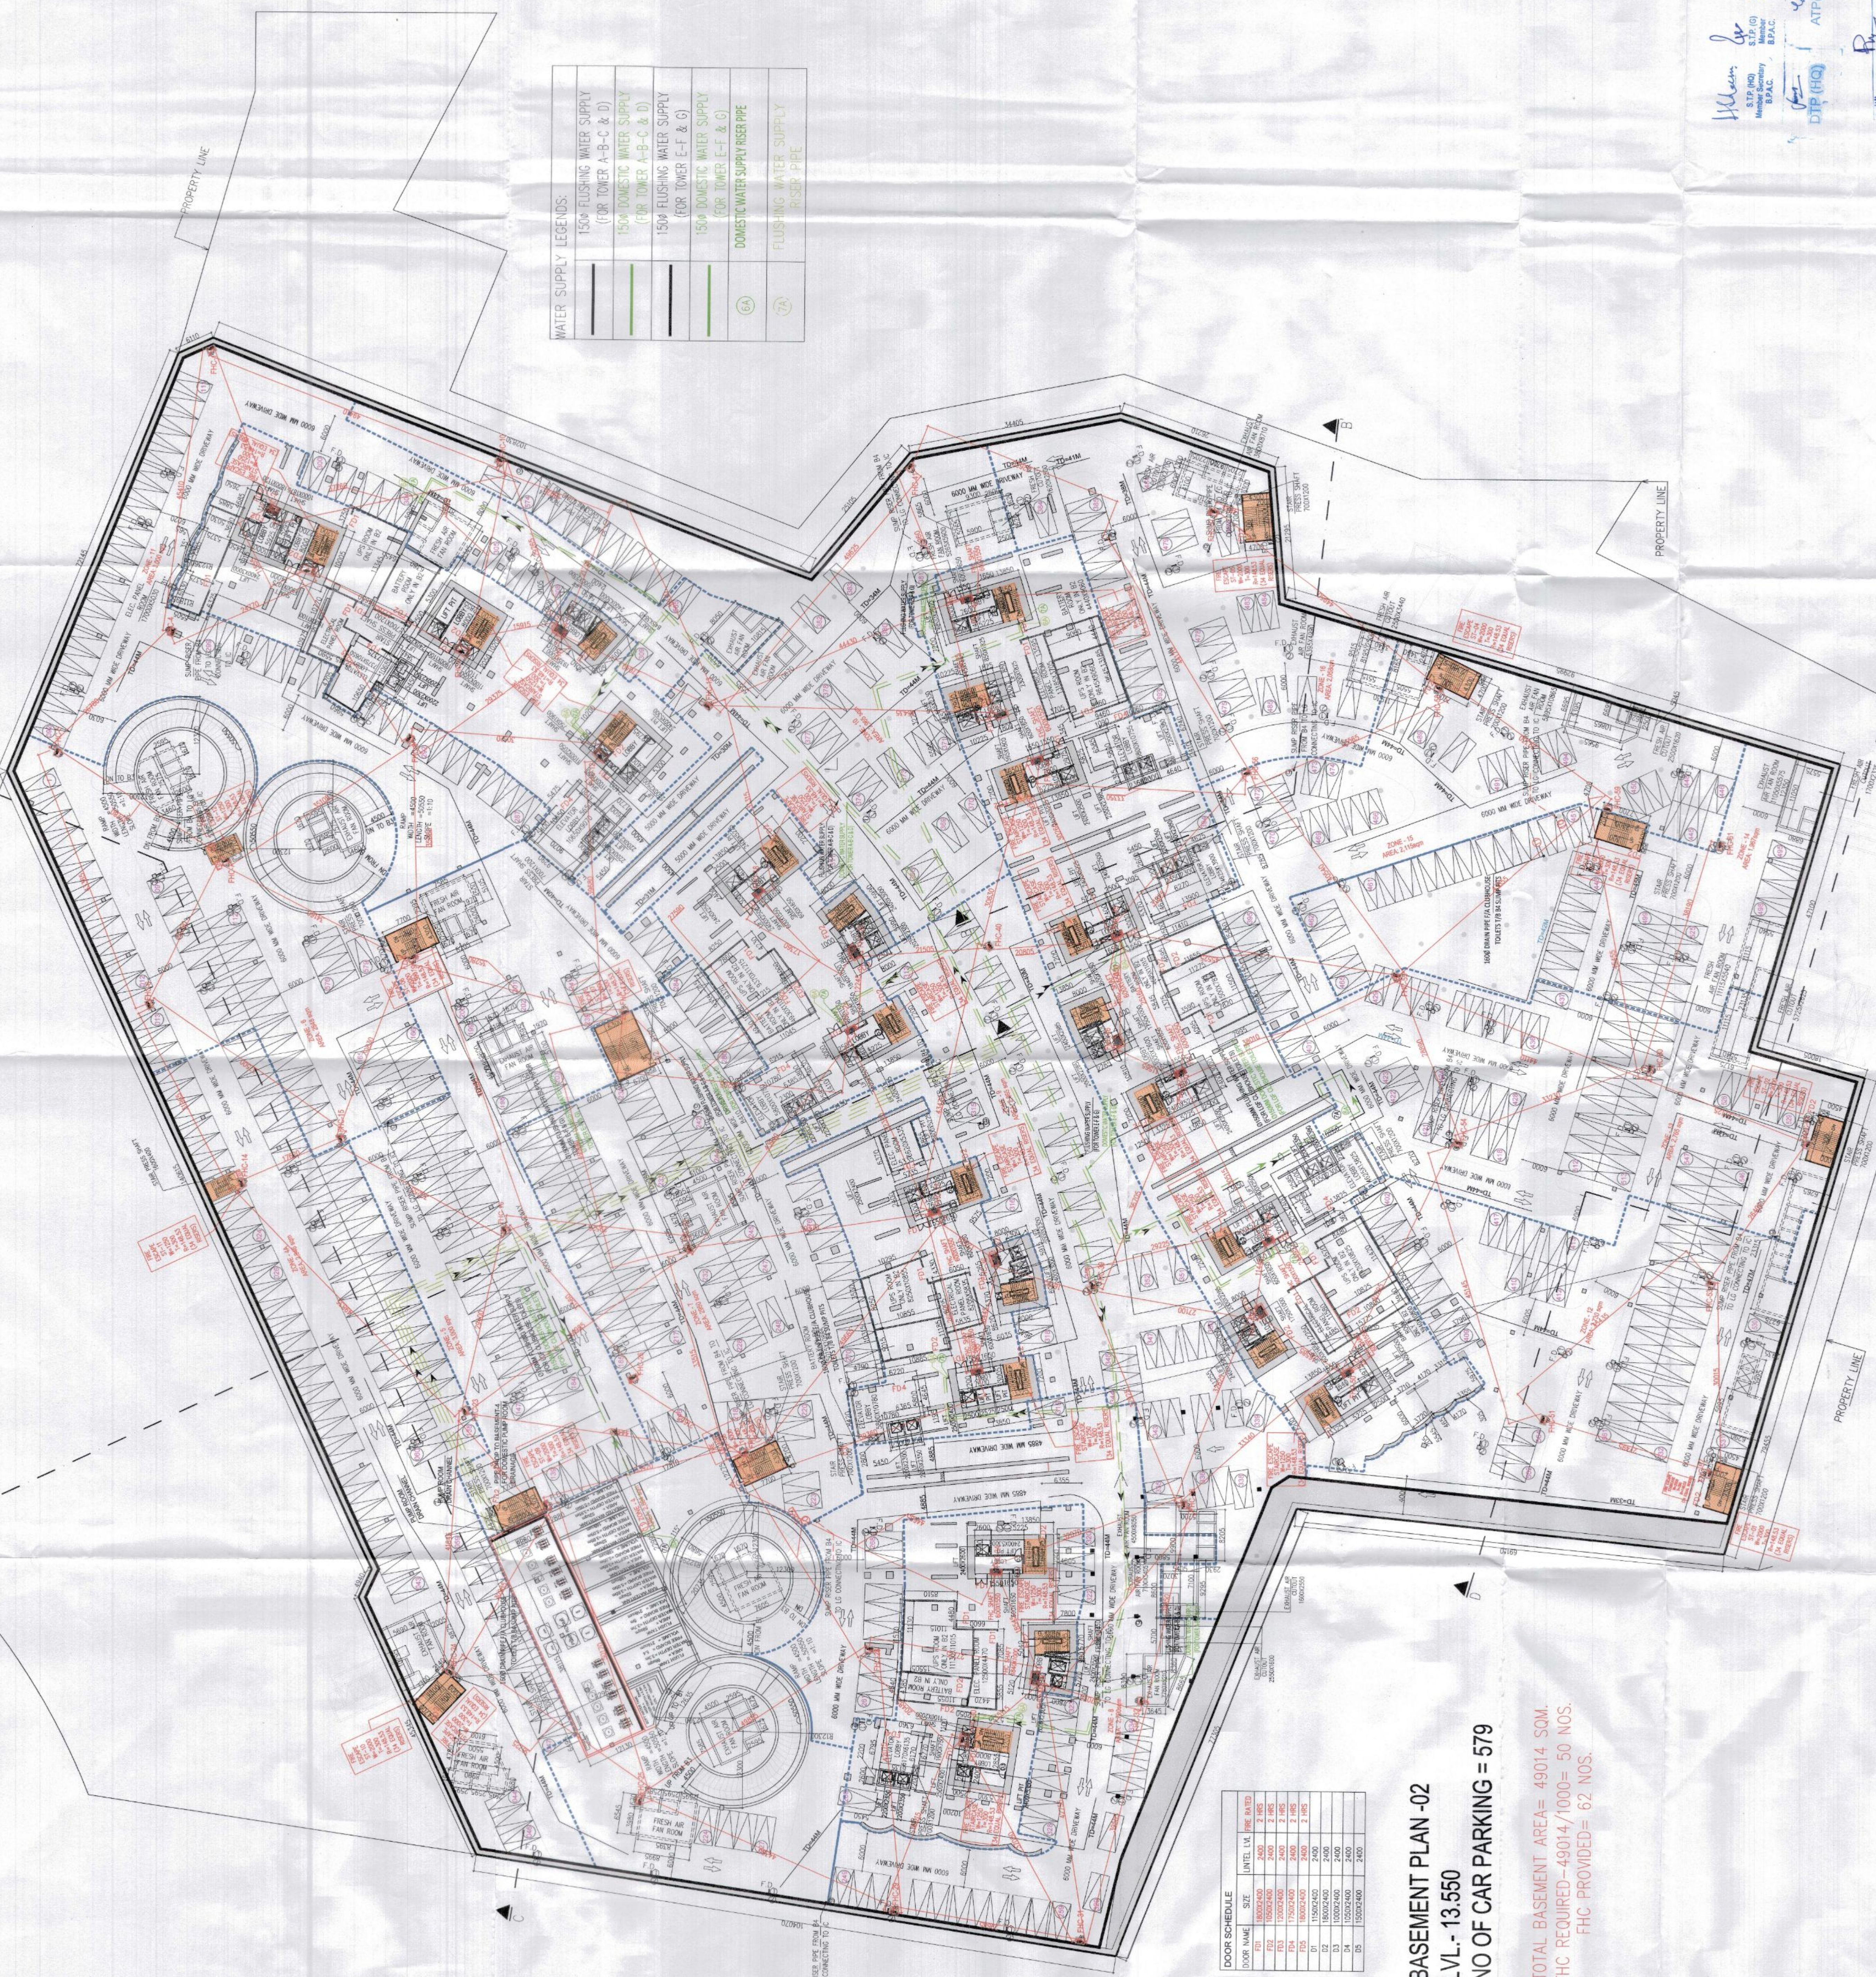

NOTES:-

1. BUILDING WILL BE DESIGNED (STRUCTURES) AS PER RELEVANT IS CODES FOR EARTH QUAKE RESISTANCE.
2. BUILDING HAS AUTOMATIC SPRINKLER SYSTEM ON ALL FLOORS.
3. BUILDING IS ARTIFICIALLY LIGHTENED MECHANICALLY VENTILATED & CENTRALLY AIR CONDITIONED WITH POWER BACKUP.

PROJECT
REVISED BUILDING PLANS OF GROUP HOUSING SCHEME 'THE DAHLIAS' IN ZONE-10 FALLING IN GROUP HOUSING COLONY AREA MEASURING 476 60/15 ACRES NAMELY DLF-5 (FORMERLY KNOWN AS DLF CITY PHASE-V) GURUGRAM BEING DEVELOPED BY DLF LIMITED.

PROJECT ARCHITECT
RSP DESIGN CONSULTANTS
UNIT 103, BESTECH BUSINESS TOWER
GURUGRAM, HARYANA 122018, INDIA

OWNER:
DLF LIMITED
THE SHOPPING MALL, DLF
OUTRAB ENCLAVE (PHASE-I)
GURGAON, HARYANA 122002

ASSOCIATES ARCHITECT
G & G ASSOCIATES
Plot No.428, Sector-37C, Near GAV
International School,
PH-8860131417
Gurgaon-122006

ARCHITECT'S SEAL
& SIGNATURE

OWNER'S SEAL
& SIGNATURE

Scale : 1:400

Drawing No:-

BS-02

FLOOR PLAN BASEMENT-2

DLF5