

1. BUILDING WILL BE DESIGNED (STRUCTURES) AS PER RELEVANT IS CODES FOR EARTH QUAKE RESISTANCE.
2. BUILDING HAS AUTOMATIC SPRINKLER SYSTEM ON ALL FLOORS.
3. THE BUILDING IS FULLY VENTILATED & CENTRALLY AIR BACKUP.

NOTES :-
1. BUILDING WILL BE DESIGNED (STRUCTURES) AS PER RELEVANT IS CODES FOR EARTH QUAKE RESISTANCE.
2. BUILDING HAS AUTOMATIC SPRINKLER SYSTEM ON ALL FLOORS.
3. THE BUILDING IS FULLY VENTILATED & CENTRALLY AIR BACKUP.

ITEM	DESCRIPTION	UNIT	QTY	AMOUNT
1	1000 S.S. & WASTE CHUTE PIPE	M	1000	1000.00
2	1000 S.S. & WASTE CHUTE PIPE	M	1000	1000.00
3	1000 S.S. & WASTE CHUTE PIPE	M	1000	1000.00
4	1000 S.S. & WASTE CHUTE PIPE	M	1000	1000.00
5	1000 S.S. & WASTE CHUTE PIPE	M	1000	1000.00
6	1000 S.S. & WASTE CHUTE PIPE	M	1000	1000.00
7	1000 S.S. & WASTE CHUTE PIPE	M	1000	1000.00
8	1000 S.S. & WASTE CHUTE PIPE	M	1000	1000.00
9	1000 S.S. & WASTE CHUTE PIPE	M	1000	1000.00
10	1000 S.S. & WASTE CHUTE PIPE	M	1000	1000.00

ITEM	DESCRIPTION	UNIT	QTY	AMOUNT
1	1000 S.S. & WASTE CHUTE PIPE	M	1000	1000.00
2	1000 S.S. & WASTE CHUTE PIPE	M	1000	1000.00
3	1000 S.S. & WASTE CHUTE PIPE	M	1000	1000.00
4	1000 S.S. & WASTE CHUTE PIPE	M	1000	1000.00
5	1000 S.S. & WASTE CHUTE PIPE	M	1000	1000.00
6	1000 S.S. & WASTE CHUTE PIPE	M	1000	1000.00
7	1000 S.S. & WASTE CHUTE PIPE	M	1000	1000.00
8	1000 S.S. & WASTE CHUTE PIPE	M	1000	1000.00
9	1000 S.S. & WASTE CHUTE PIPE	M	1000	1000.00
10	1000 S.S. & WASTE CHUTE PIPE	M	1000	1000.00

PROJECT ARCHITECT
RSP DESIGN CONSULTANTS
UNIT-103, BESTECH BUSINESS TOWER
GURUGRAM, HARYANA 122018, INDIA

OWNER:
DLF LIMITED
THE SHOPPING MALL DLF
QUTAB ENCLAVE (PHASE-I)
GURGAON, HARYANA 122002

ASSOCIATES ARCHITECT
G & G ASSOCIATES
Plot No.428, Sector-37C, Near GAY
International School,
PH-8860131417
Gurgaon-122006

ARCHITECT'S SEAL
& SIGNATURE

OWNER'S SEAL
& SIGNATURE

DATE: 10/07/2024
SCALE: 1:100



DRAWING TITLE:
FLOOR PLAN & AREA CALCULATION OF
28TH FLOOR
TOWER-4 & 5 (TOWER-D)

DATE: 10/07/2024
SCALE: 1:100

ITEM	DESCRIPTION	UNIT	QTY	AMOUNT
1	1000 S.S. & WASTE CHUTE PIPE	M	1000	1000.00
2	1000 S.S. & WASTE CHUTE PIPE	M	1000	1000.00
3	1000 S.S. & WASTE CHUTE PIPE	M	1000	1000.00
4	1000 S.S. & WASTE CHUTE PIPE	M	1000	1000.00
5	1000 S.S. & WASTE CHUTE PIPE	M	1000	1000.00
6	1000 S.S. & WASTE CHUTE PIPE	M	1000	1000.00
7	1000 S.S. & WASTE CHUTE PIPE	M	1000	1000.00
8	1000 S.S. & WASTE CHUTE PIPE	M	1000	1000.00
9	1000 S.S. & WASTE CHUTE PIPE	M	1000	1000.00
10	1000 S.S. & WASTE CHUTE PIPE	M	1000	1000.00

ITEM	DESCRIPTION	UNIT	QTY	AMOUNT
1	1000 S.S. & WASTE CHUTE PIPE	M	1000	1000.00
2	1000 S.S. & WASTE CHUTE PIPE	M	1000	1000.00
3	1000 S.S. & WASTE CHUTE PIPE	M	1000	1000.00
4	1000 S.S. & WASTE CHUTE PIPE	M	1000	1000.00
5	1000 S.S. & WASTE CHUTE PIPE	M	1000	1000.00
6	1000 S.S. & WASTE CHUTE PIPE	M	1000	1000.00
7	1000 S.S. & WASTE CHUTE PIPE	M	1000	1000.00
8	1000 S.S. & WASTE CHUTE PIPE	M	1000	1000.00
9	1000 S.S. & WASTE CHUTE PIPE	M	1000	1000.00
10	1000 S.S. & WASTE CHUTE PIPE	M	1000	1000.00

ITEM	DESCRIPTION	UNIT	QTY	AMOUNT
1	1000 S.S. & WASTE CHUTE PIPE	M	1000	1000.00
2	1000 S.S. & WASTE CHUTE PIPE	M	1000	1000.00
3	1000 S.S. & WASTE CHUTE PIPE	M	1000	1000.00
4	1000 S.S. & WASTE CHUTE PIPE	M	1000	1000.00
5	1000 S.S. & WASTE CHUTE PIPE	M	1000	1000.00
6	1000 S.S. & WASTE CHUTE PIPE	M	1000	1000.00
7	1000 S.S. & WASTE CHUTE PIPE	M	1000	1000.00
8	1000 S.S. & WASTE CHUTE PIPE	M	1000	1000.00
9	1000 S.S. & WASTE CHUTE PIPE	M	1000	1000.00
10	1000 S.S. & WASTE CHUTE PIPE	M	1000	1000.00

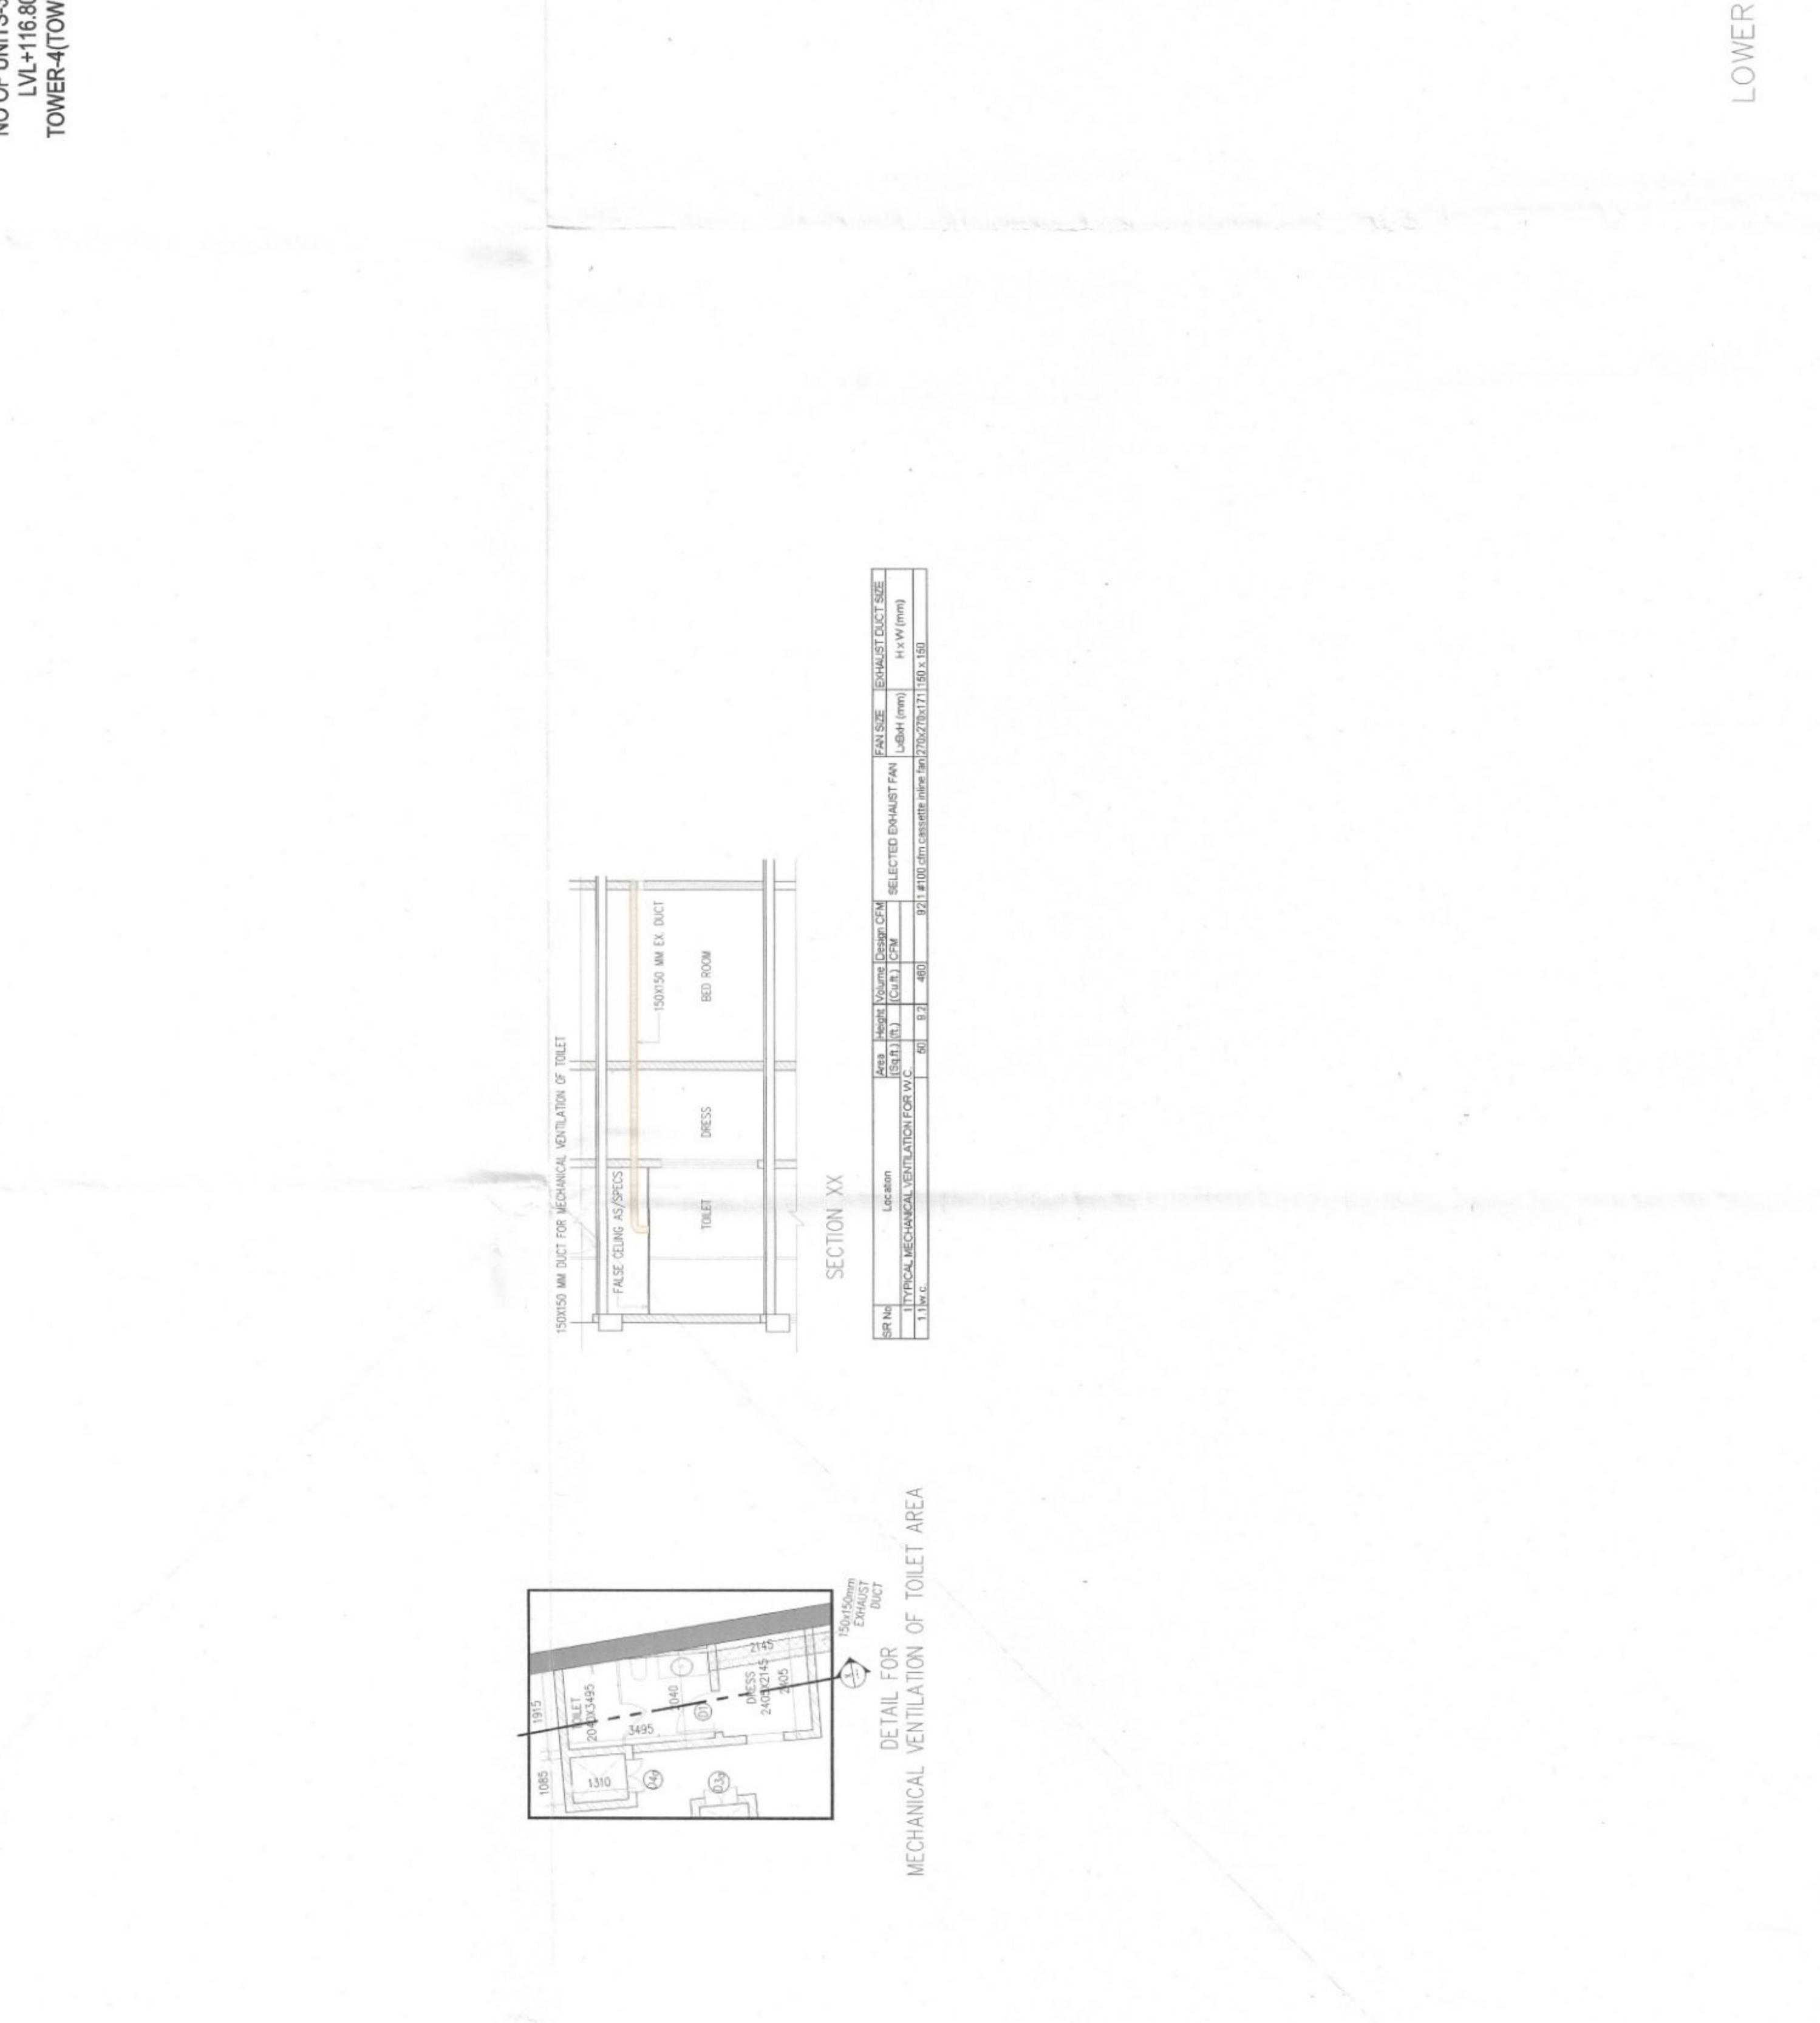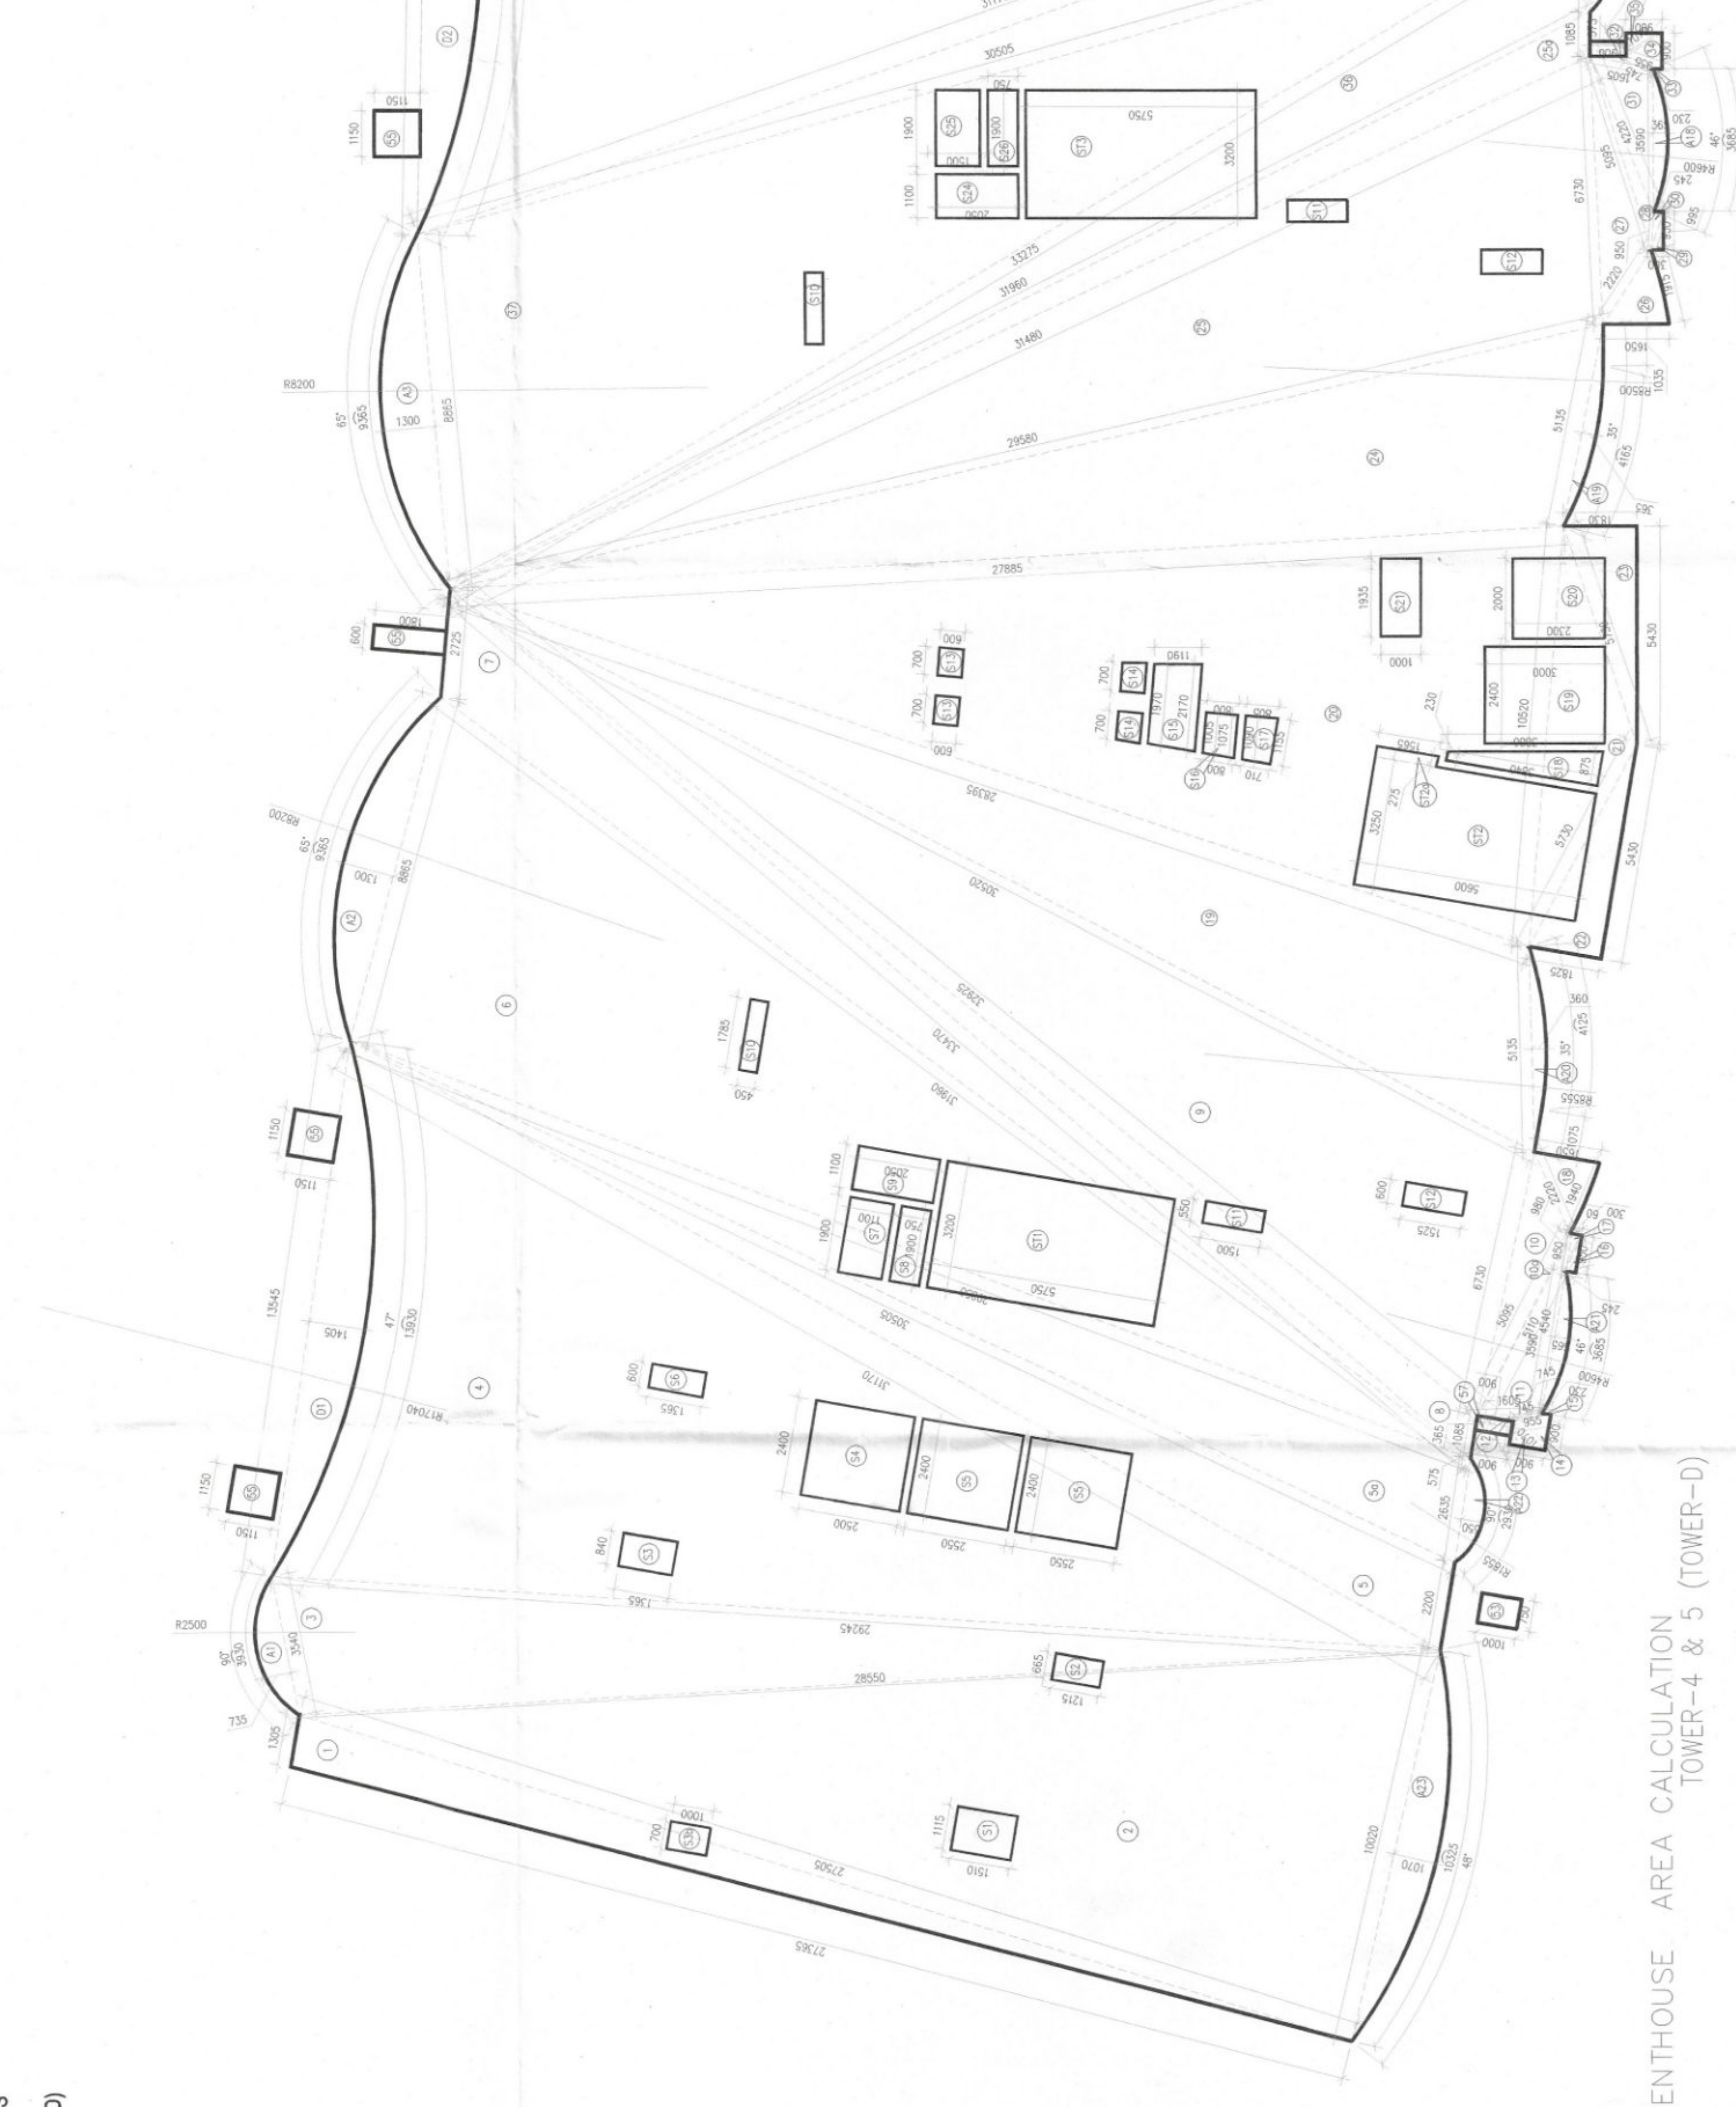

NOTE: THE TOWER NUMBER IN THE
BRACKET IS THE PREVIOUS TOWER NUMBER.

LOWER PENTHOUSE AREA CALCULATION
TOWER-4 & 5 (TOWER-D)

DWF5