


PLUMBING LEGEND:-
--- 400 MM Ø STORM WATER LINE
--- 200 MM Ø SEWER LINE
--- DOMESTIC WATER SUPPLY LINE
--- PLUMBING WATER SUPPLY LINE

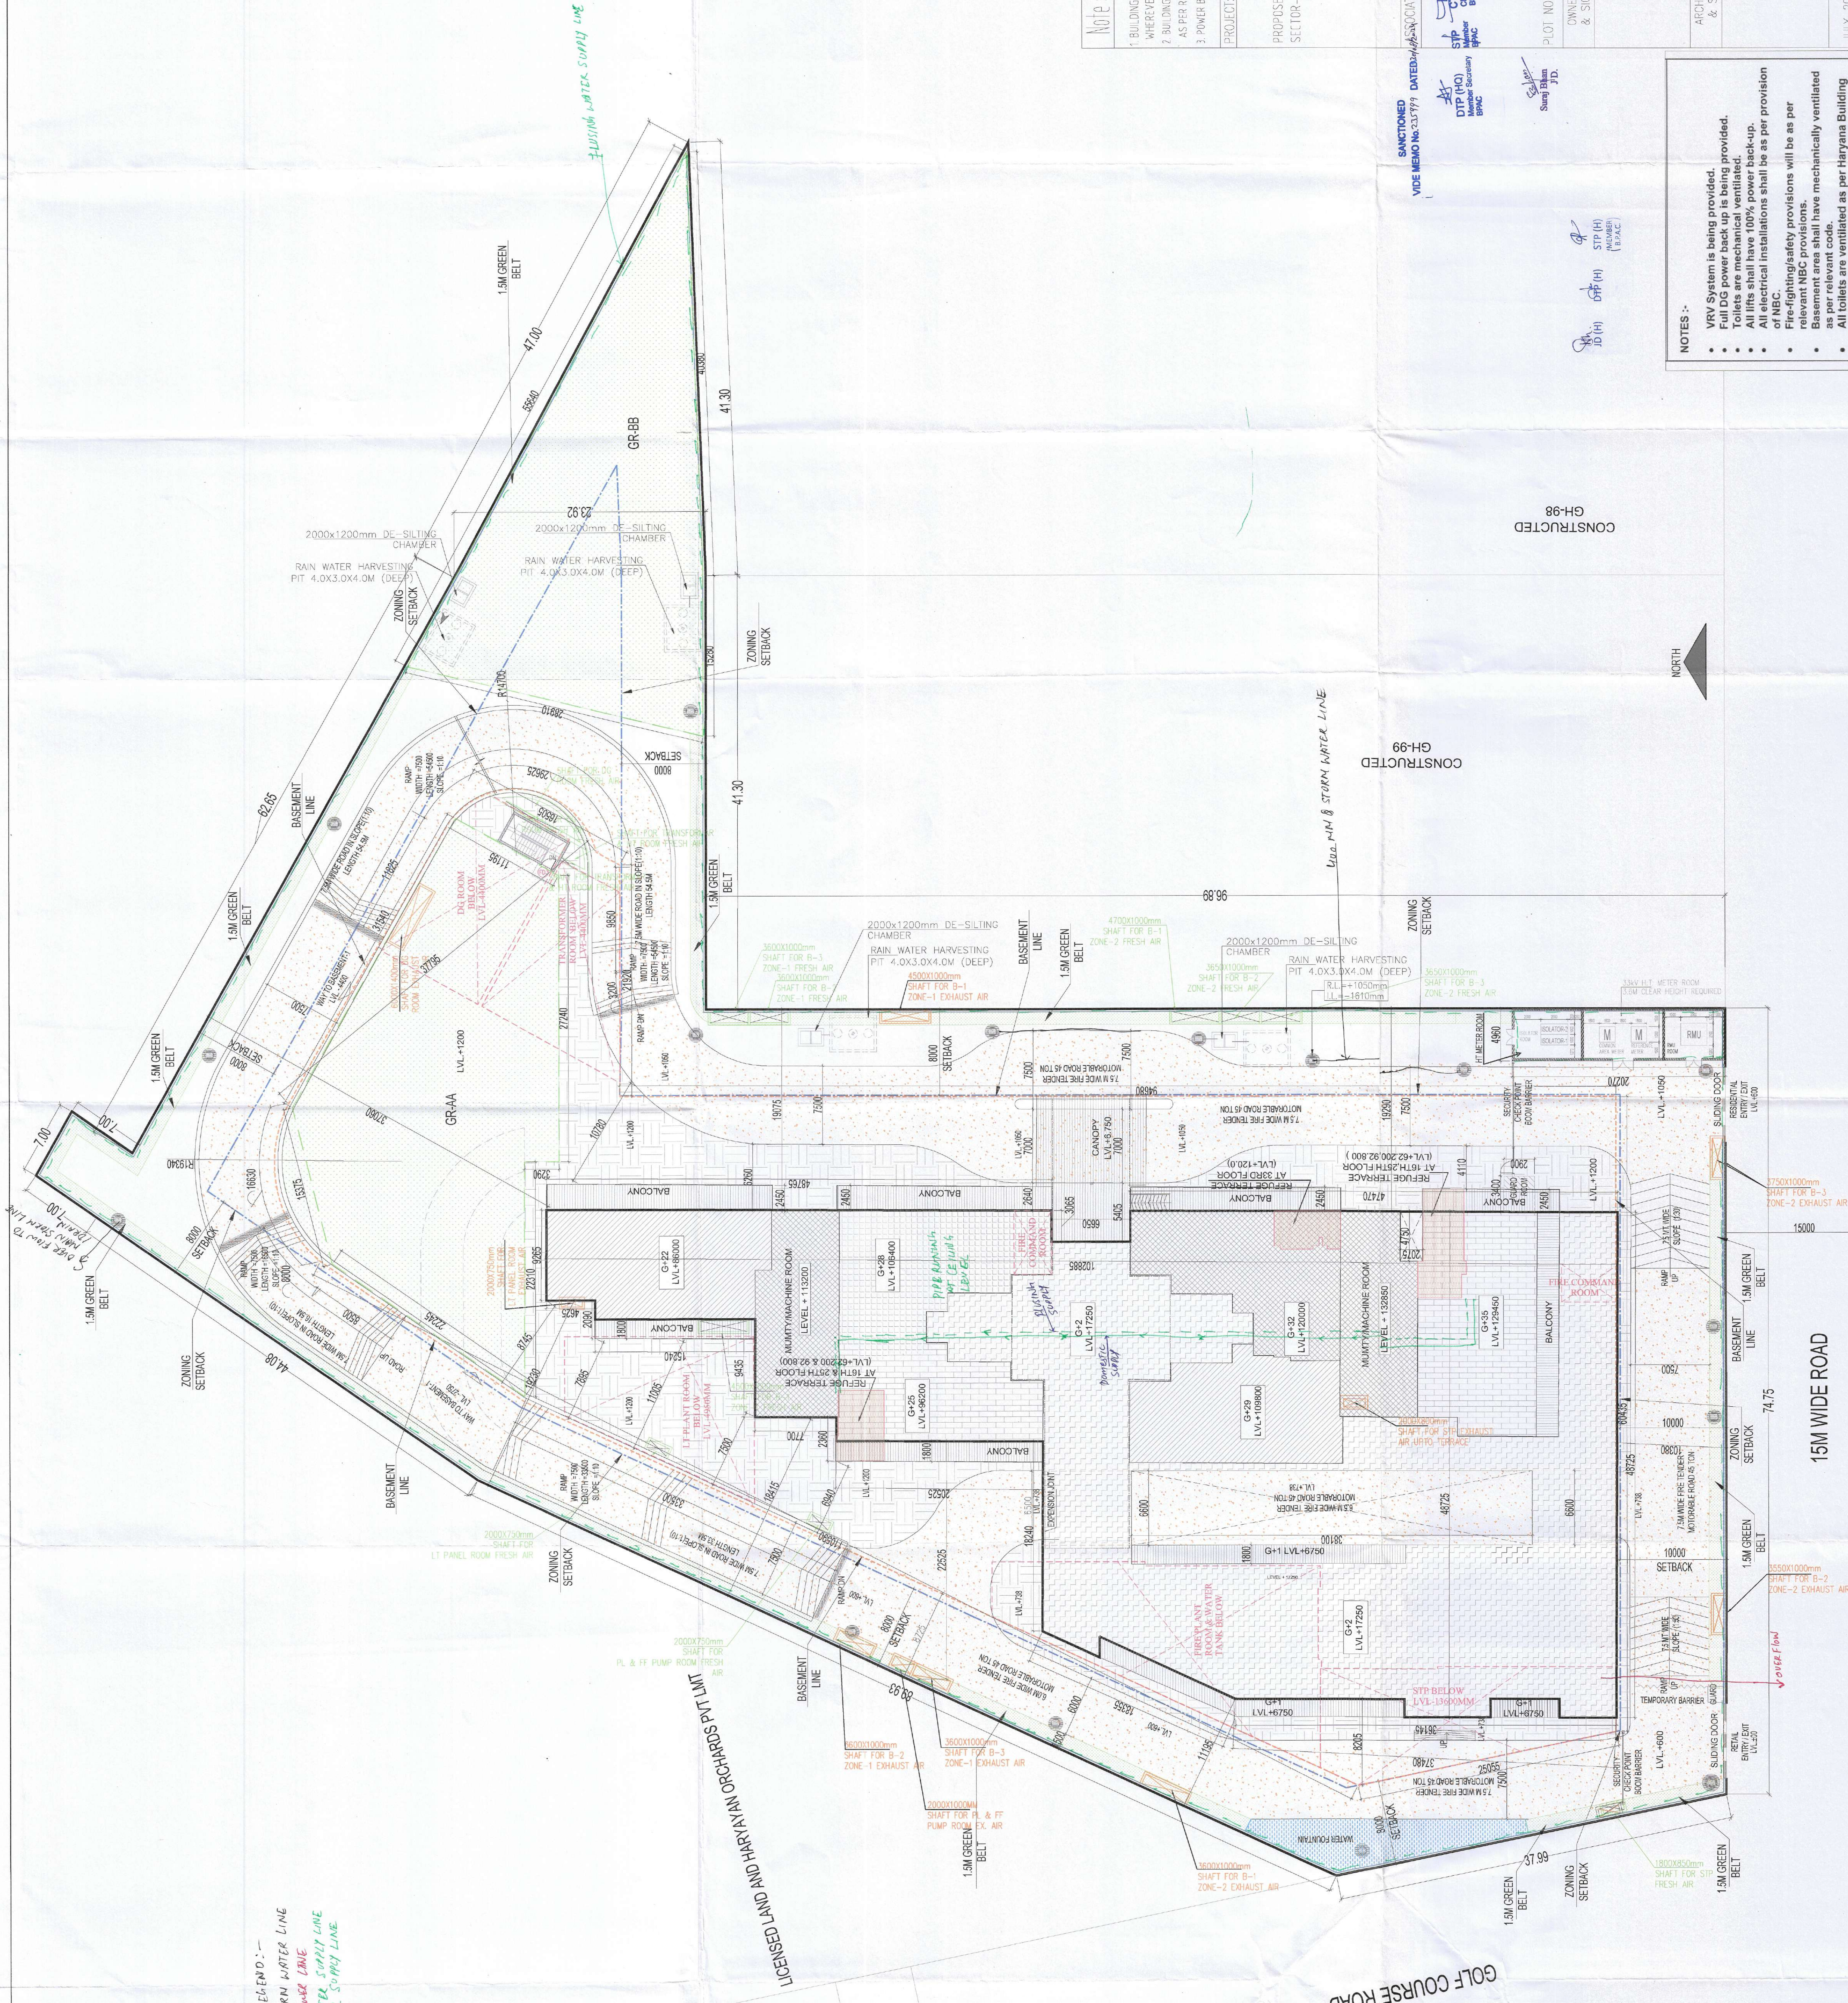

Notes:-

- VRV System is being provided.
- Full DG power back up is being provided.
- Toilets are mechanical ventilated.
- All lifts shall have 100% power back-up.
- All electrical installations shall be as per provision of NBC.
- Fire-fighting/safety provisions will be as per relevant NBC provisions.
- Basement area shall have mechanically ventilated as per relevant code.
- All toilets are ventilated as per Haryana Building Code.
- Building has automatic sprinkler system wherever required by NBC.
- Building will be designed (structures) as per relevant I.S. codes for earthquake resistance.
- Solar panels of required capacity shall be provided on roof top as per hazard zoning norms.
- All fire fighting installations shall be as per provision of NBC.
- The rainwater harvesting system shall be provided as per central ground water authority norms.

Sanctioned
Vide Memo No. 23/1991 DATED 24/05/2019

Architects
DTP (H)
S.P. Chatterjee
Member
BPMC

Associates
PLOT NO-408 SEC-37C GURGAON (PH-956794794)

Owner's Seal & Signature
For Wonder City Builders Ltd.
Authorized Signatory

Architect's Seal & Signature
Ar. Rajender Kumar
CACH 265971

Scale
1:100

Member
BPMC

Drawing Title:-
SITE PLAN
SERVICES PLAN

Drawing No:-
ST-02

GH-95
SECTOR 54

SECTOR 53

METRO STATION
53-54

GOLF COURSE ROAD

15M WIDE ROAD

GH-98
CONSTRUCTED

GH-99
CONSTRUCTED