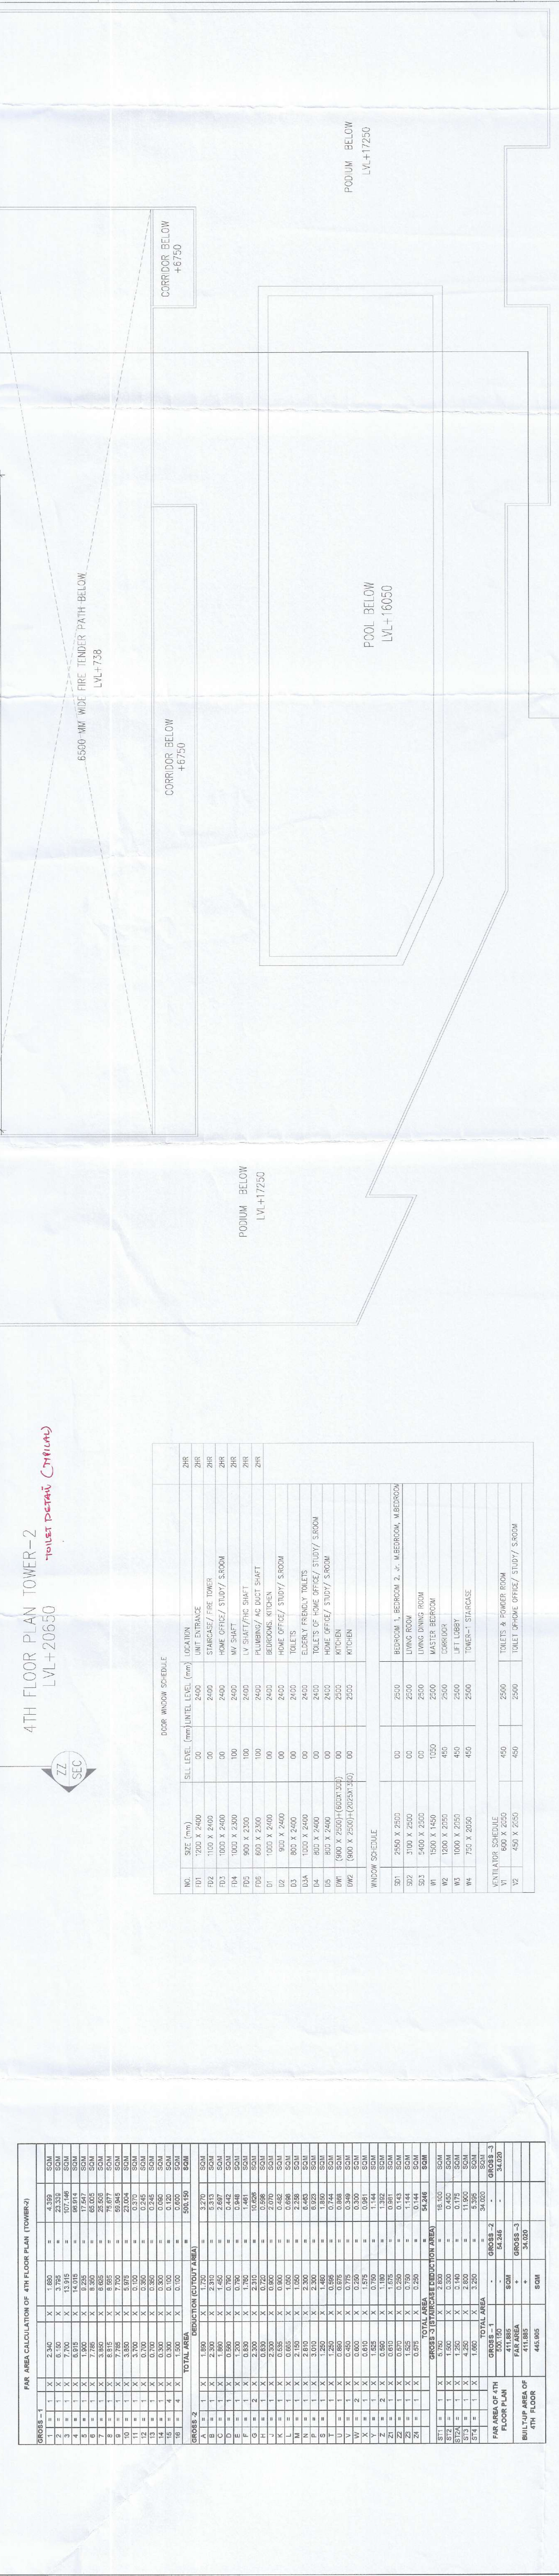
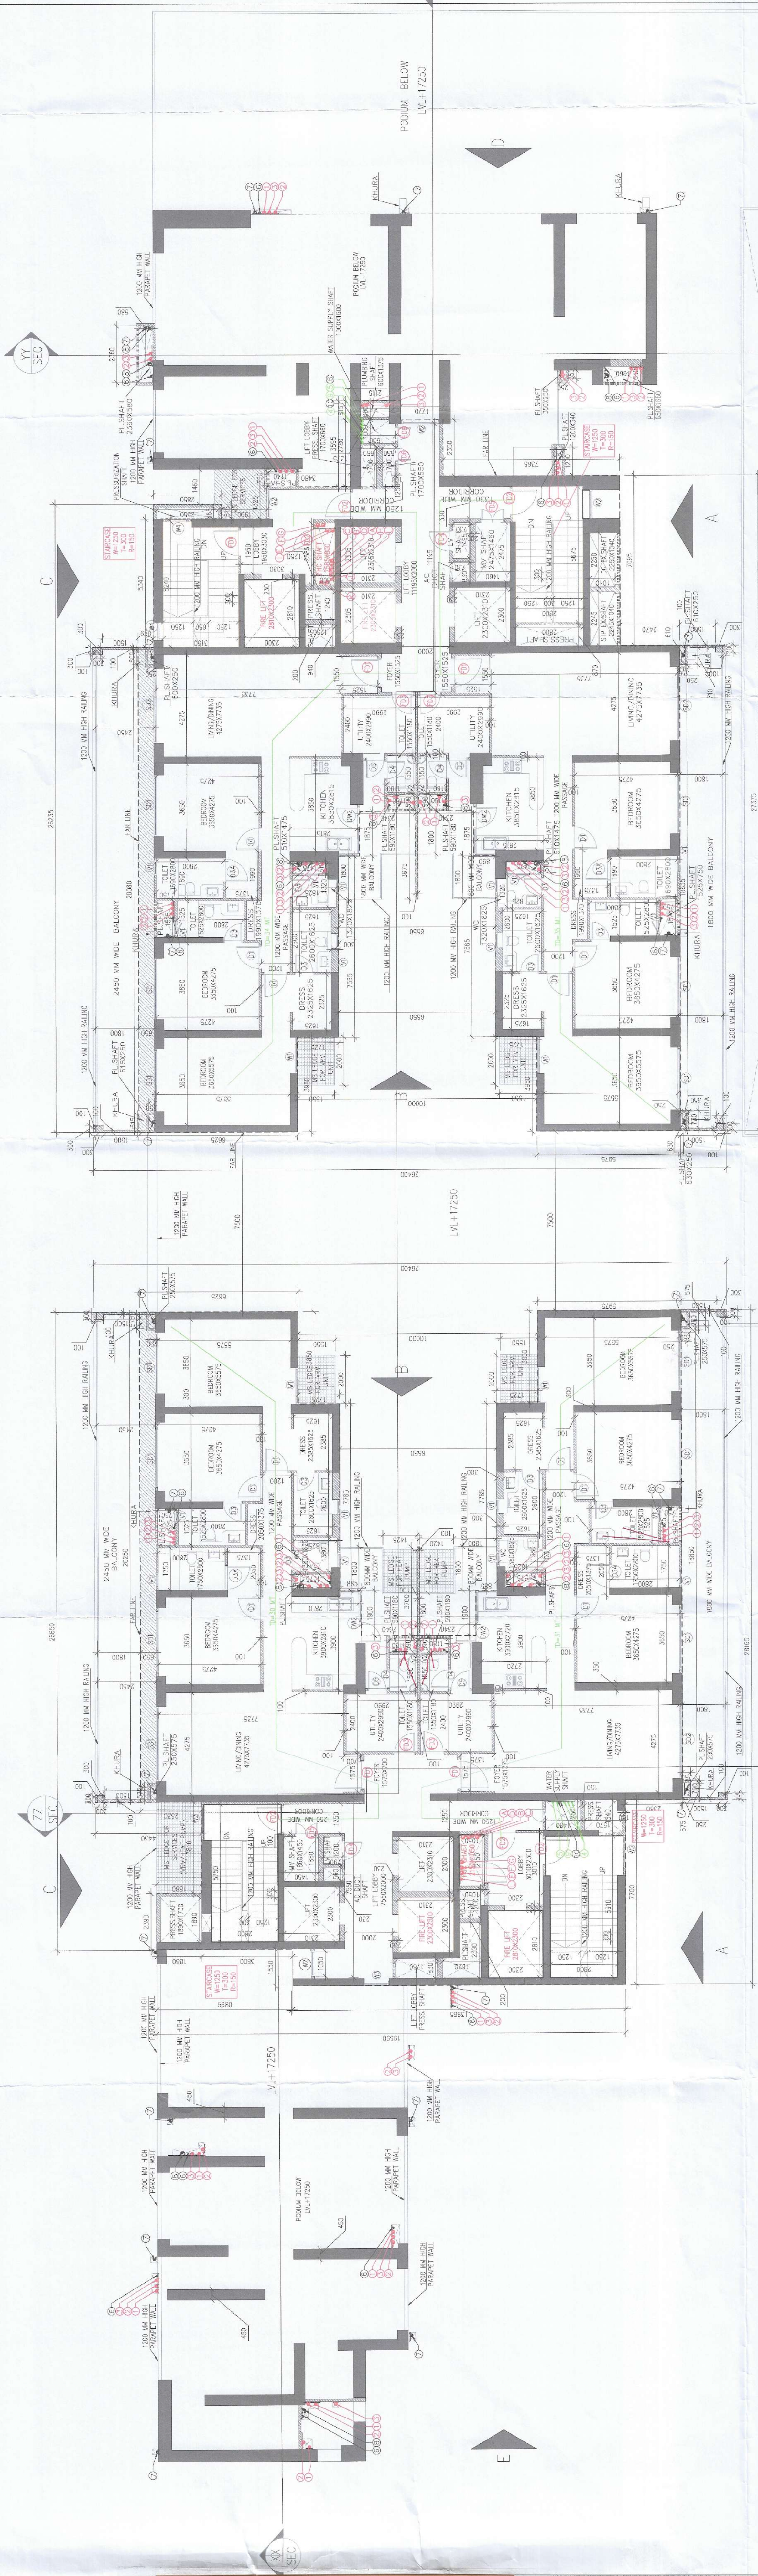
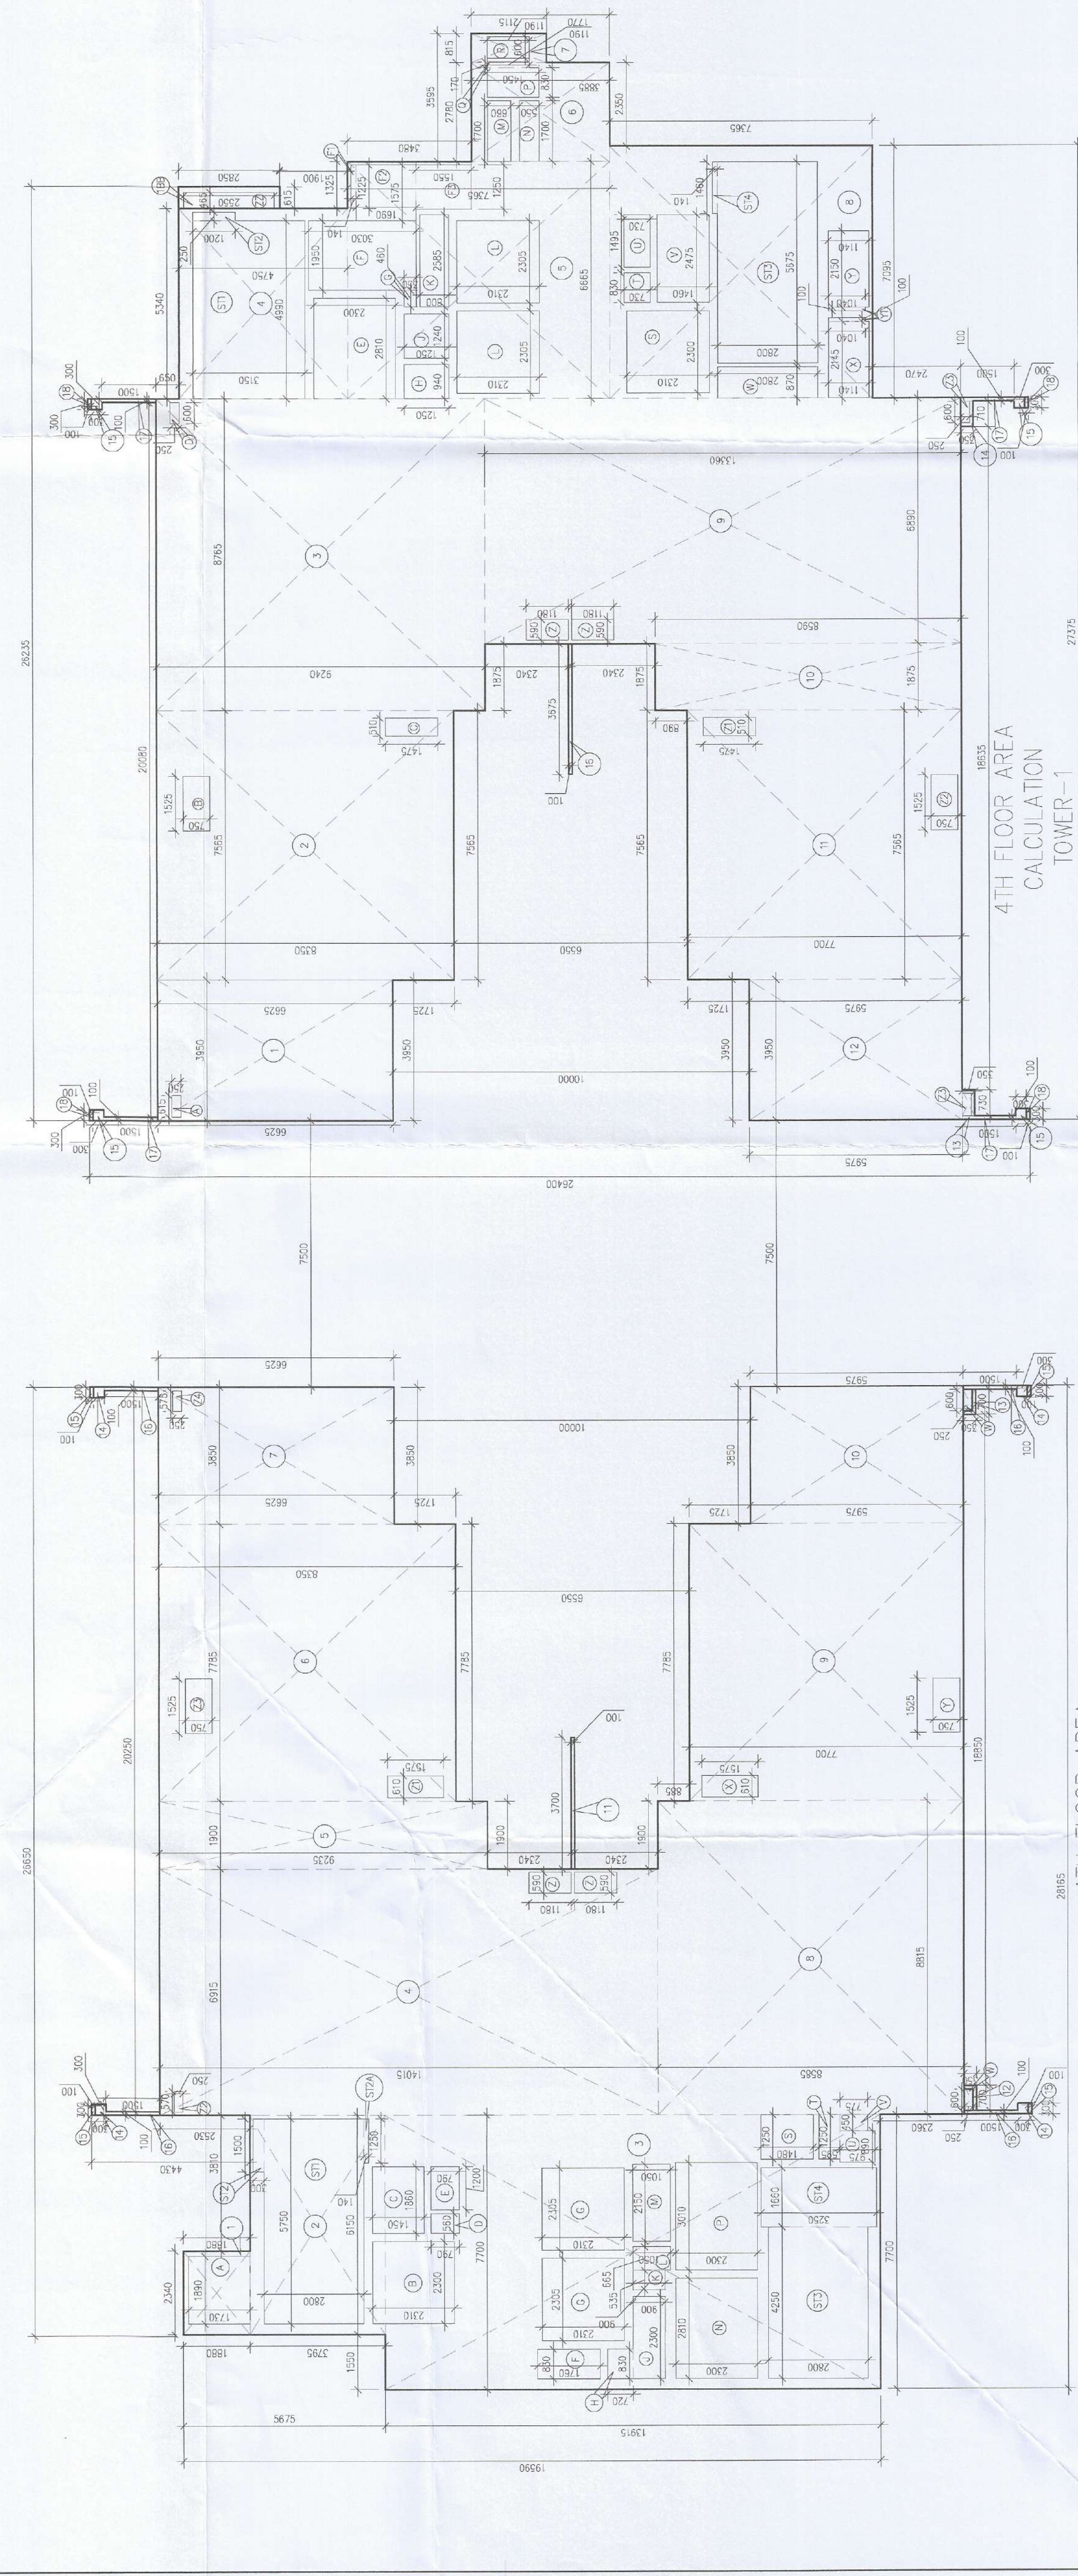


FLUIDS LEAKING:	5.0502
1. 110.00 KETICAL SOL. PPE	1
2. 110.00 KETICAL WASTE PPE	2
3. 110.00 ANTIPOISON PPE	3
4. DOMESTIC WATER SUPPLY DOWN PPE	4
5. DOMESTIC WATER SUPPLY UPPE BROUGHT	5
6. FRESH WATER SUPPLY DOWN PPE	6
7. 100.00 BALCONY DRAIN PPE	7
8. 100.00 C/RN WATER PPE	8
9. DOMESTIC WATER SUPPLY UPPE PPE	9
10. FRESH WATER SUPPLY DOWN PPE	10
11. FLOOR SPA	11
12. FLOOR SPA	12
13. ACCESS DOOR	13
14. KIMBERLY DIS BALCONY DRAIN	14

[illegible]

SANCTIONED
 WIDE MEMO NO. 23.7799 DATED 24/11/2024
 ASSOCIATE ARCHITECTS
 1) P. SRIPRIYA (B.E.A.C.)
 STIP(H)
 Member
 Ministry
 EPIC
 CHAIRMAN
 BRAC
 DTP (HO)
 STP
 CYP
 CHAIRMAN
 BRAC
 SRI
 SRI
 SUNG
 / TD.
 G G ASSOCIATES
 PLOT NO-408 SDC-37C CURAUM (PH-9845794794)
 OWNER'S SEAL
 & SIGNATURE

For Wonder City Buildcon Ltd.

ARCHITECT'S SEAL & SIGNATURE

Superintending Engineer(HQ)
O/o Chief Engineer-I/I,
HSVP, Panchkula.

JULY - 2024	Scale : 1:1000	DDP (T) MEMBER
-------------	----------------	-------------------

Drawing Title:—	4TH FLOOR PLAN & AREA DIAGRAM	Drawing No:—	T-09
-----------------	----------------------------------	--------------	------