

[illegible]

NOTES :	
• New system is being provided.	
• Fall protection is being provided.	
• Toilets are mechanical ventilated.	
• All lifts shall have 100% power back-up.	
• All fire fighting installations shall be as per provision of NBC.	
• Fire-fighting agency provisions will be as per NBC.	
• Basement area shall have mechanically ventilated as per relevant code.	
• All air shall be ventilated as per Mysuru Building Code 2017.	
• Building has automatic sprinkler system wherever relevant (structures) as per relevant I. codes for earthquake resistance.	
• All fire fighting installations shall be provided on roof top of each building.	
• All handrails comply with railing.	
• All fire fighting installations shall be as per NBC.	
• The rainwater harvesting system shall be provided as per central ground water authority norms.	

PROJECT: PROPOSED BUILDING PLAN OF G.H. SITE NO.100 IN SECTOR-54 (GURUGRAM)

ASSOCIATE ARCHITECTS

STP (H)
'MEMBER'
(B.P.A.C.)



GG ASSOCIATES

LOT NO-408 SEC-37C GURGAON (PH-9560794794)

STP
Member
BPMC

[Signature]
Chairman
BPMC

Wonder City Buildcon Ltd.



[Signature]
Authorized Signatory

ARCHITECT'S SEAL
& SIGNATURE

Ar. Raghinder Kumar
CA/2012/55971

JULY-2024	Scale : DDT (T) MEMBER BPAC	Drawing No. :-
		Drawing Title :-

GROUND FLOOR PLAN LV+750 (COMMERCIAL)	T-01
---	------

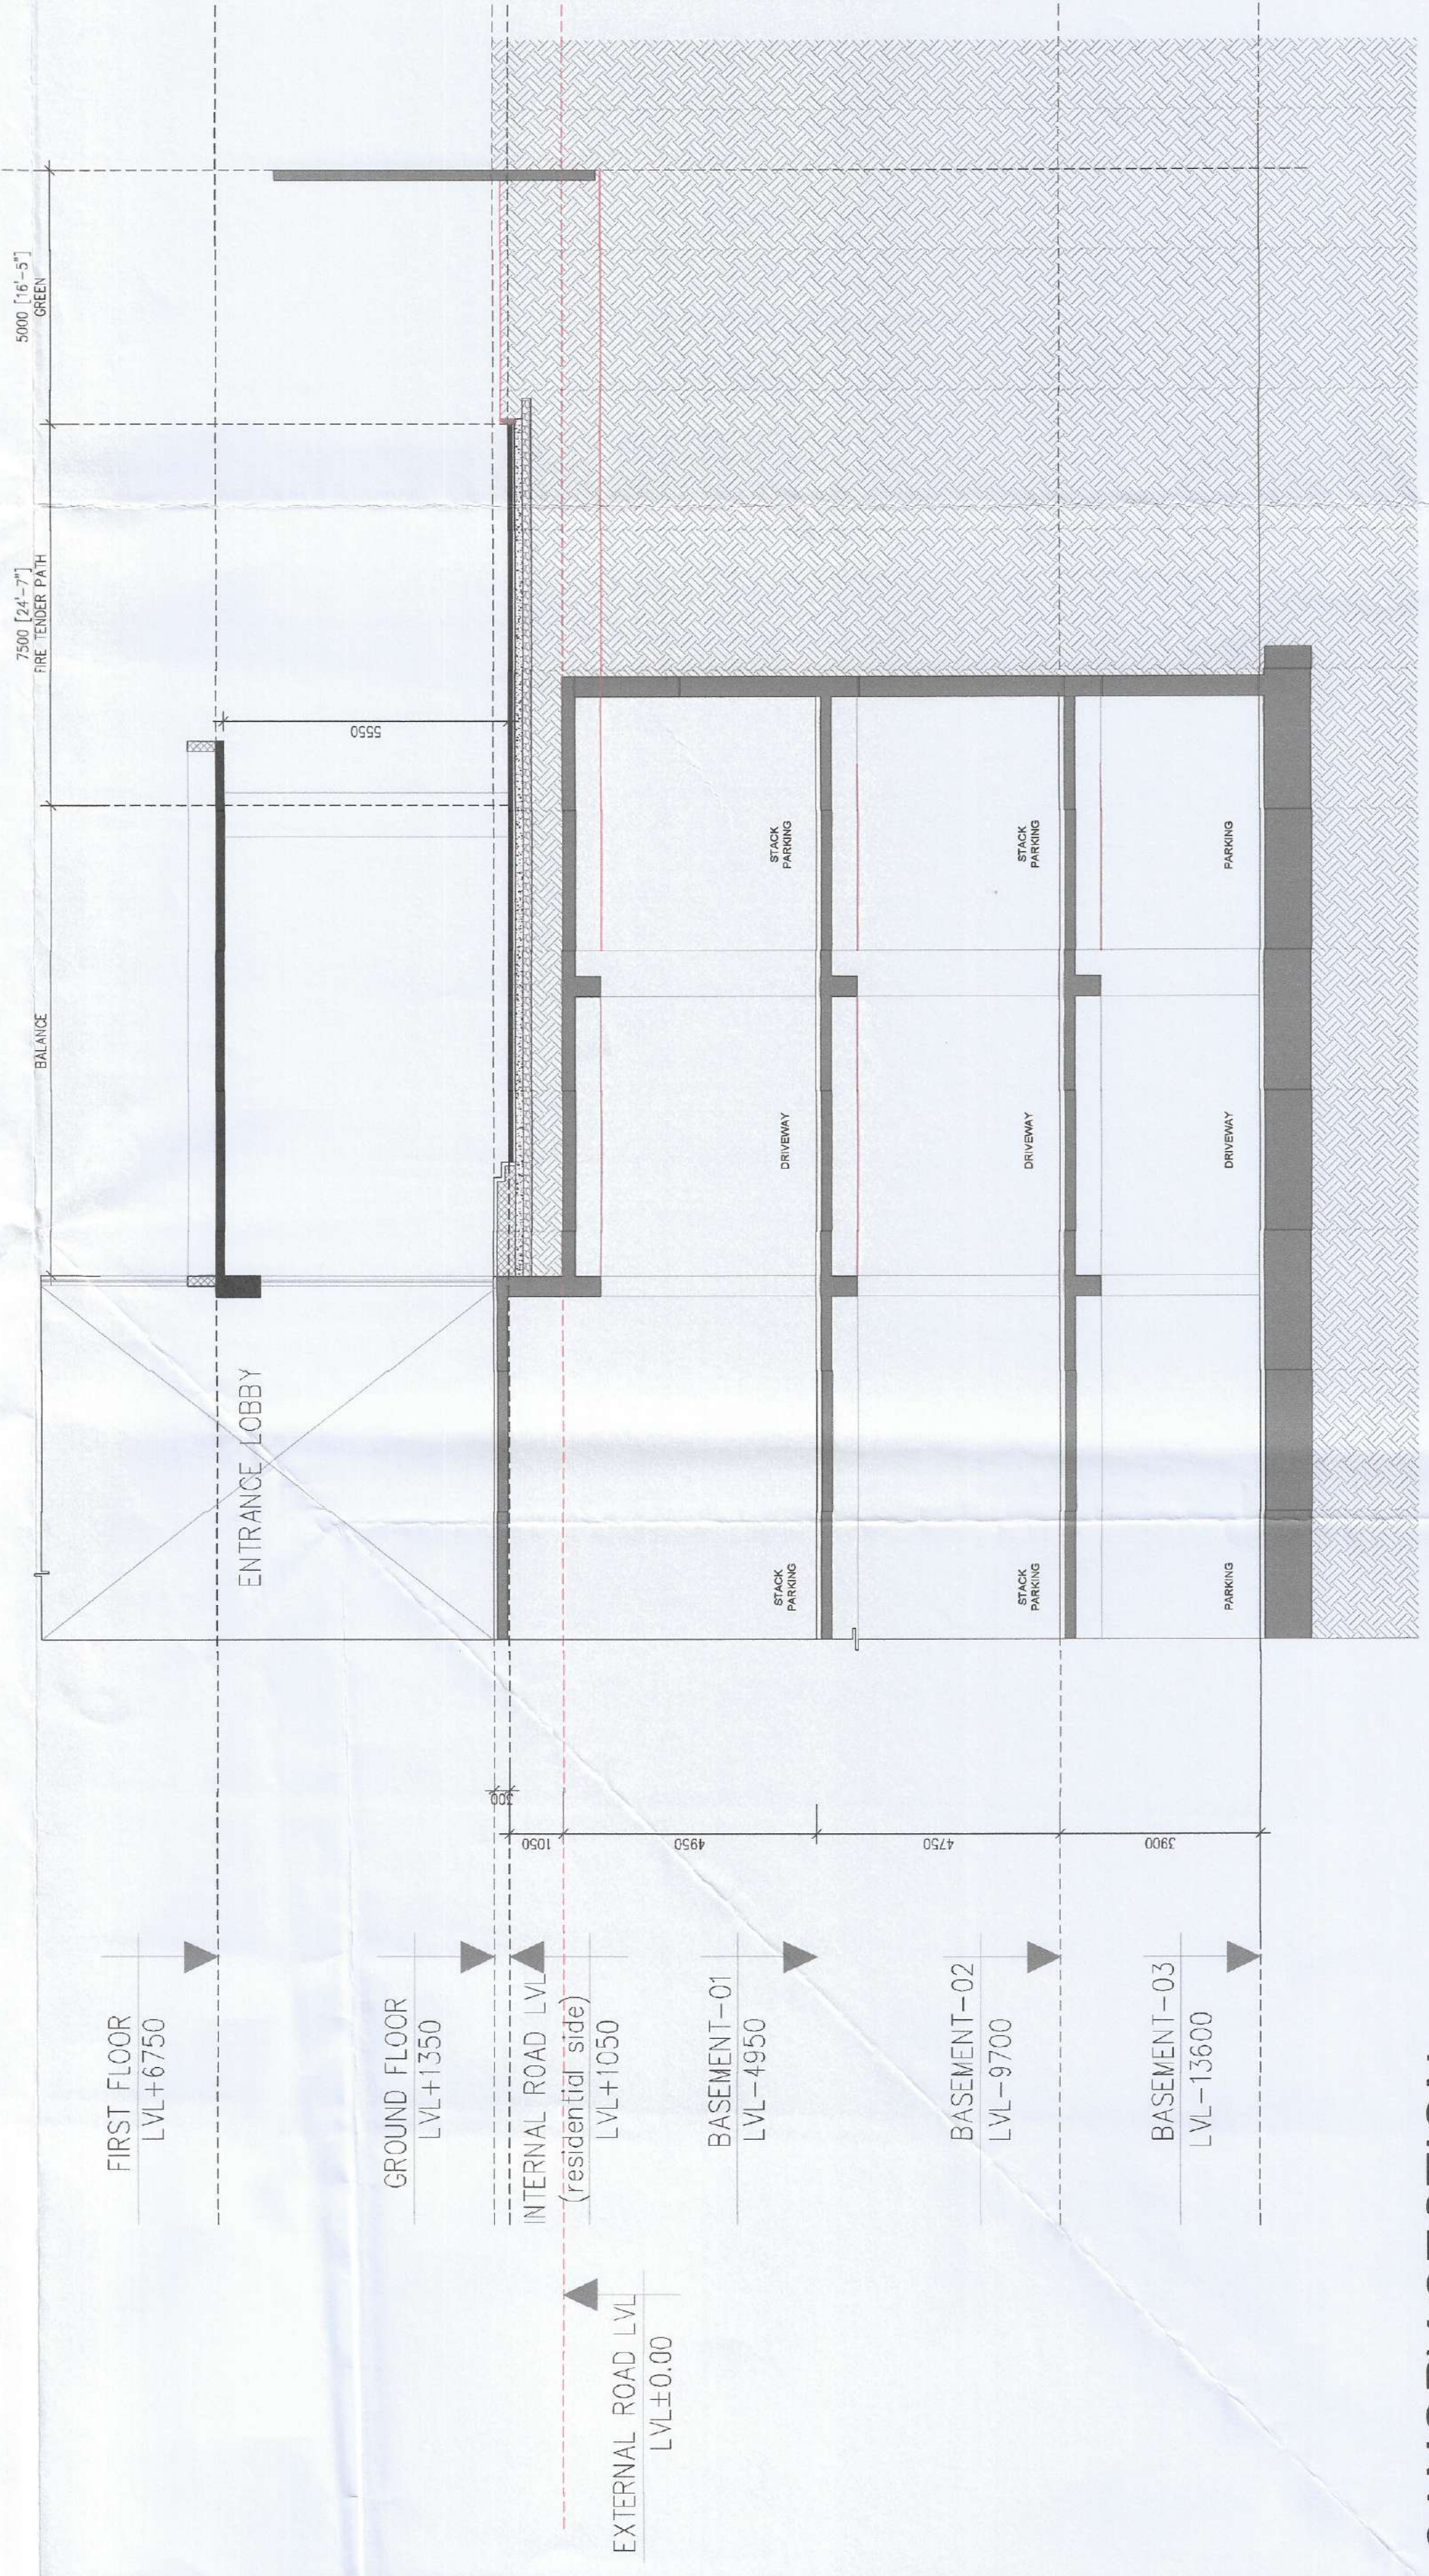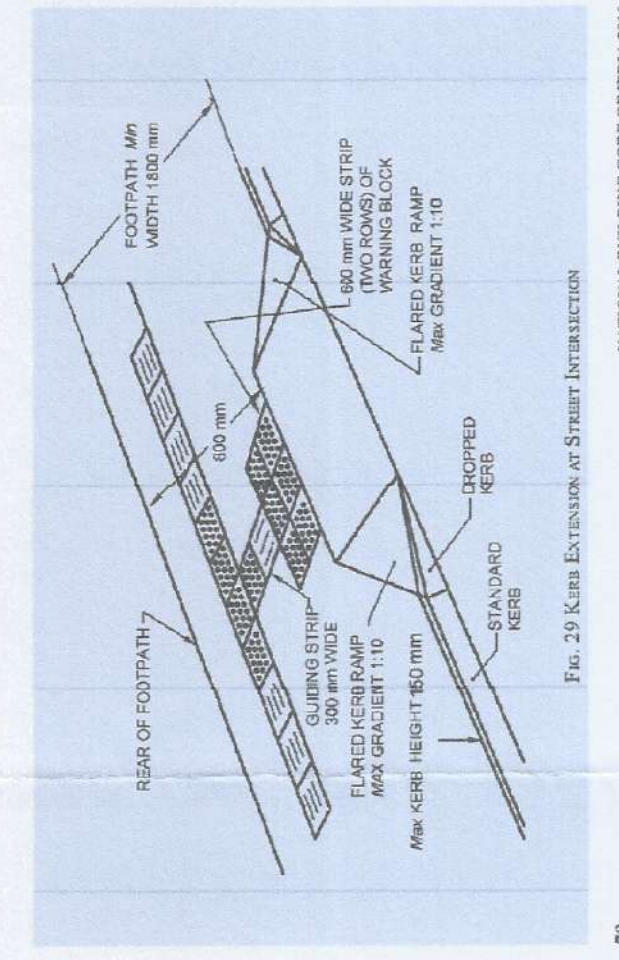

CANOPY SECTION